


PLAN NOTES:
1 REMOVE EXISTING PAN COIL UNIT. PROVIDE NEW 5 TON HEATING UNIT WITH CONDENSATE PAN ON ROOF. PROVIDE NEW HEATING WASTE COIL. PROVIDE OUTSIDE AIR THROUGH ROOF. PROVIDE AIR COOLED CONDENSING UNIT ON ROOF.
2 PROVIDE NEW DX COOLING COIL WITH CONDENSATE PAN ON EXISTING AIR HANDLING UNIT. PROVIDE 40 TON AIR COOLED CONDENSING UNIT WITH CONDENSATE PAN ON ROOF. PROVIDE 4" CONCRETE PAD. PROVIDE NEW DISTRIBUTION DUCTWORK.

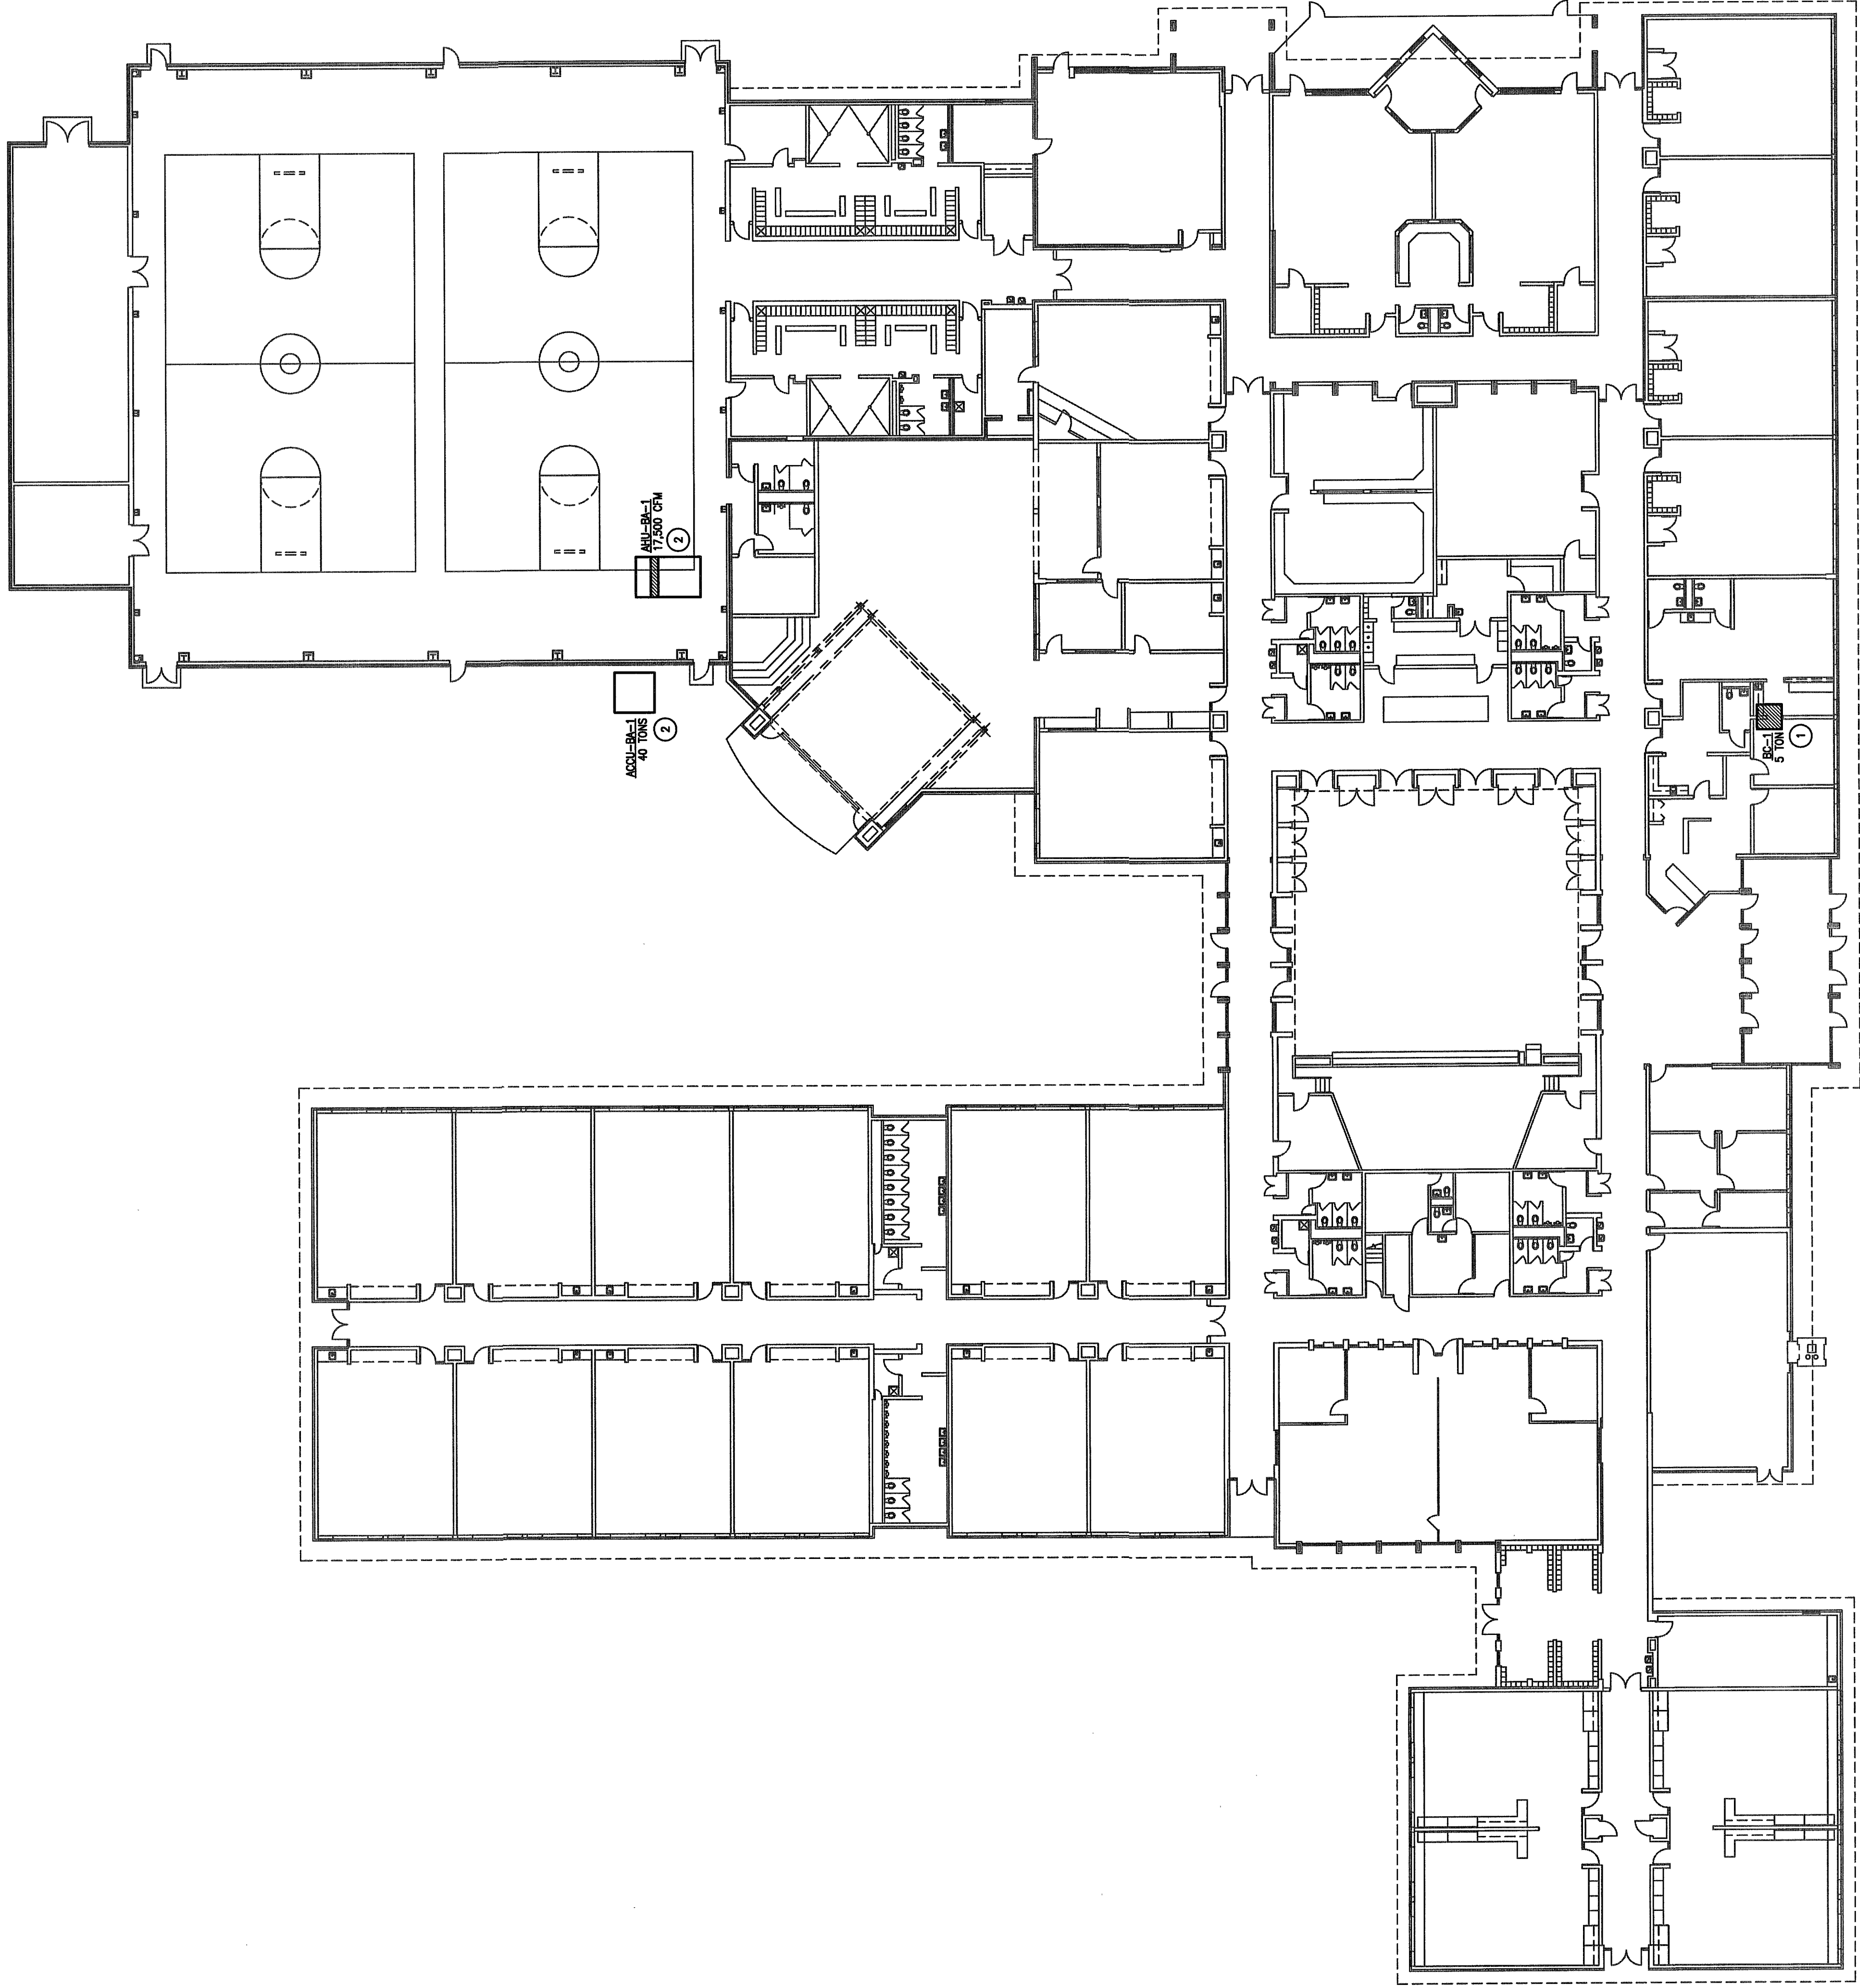

 NORTH
MECHANICAL PLAN
1/16" = 1'-0"

Seal

MECHANICAL RENOVATIONS
to the
BAILEY ELEMENTARY SCHOOL
Chesteron, Indiana

Honeywell
The Precedent
9355 Delegates Row
Indianapolis, IN 46240

Revision	
Project No.	HN09001
Date	4-21-09
Scale	1/16"=1'-0"
Drawn By	MSF
Checked By	CC
Sheet Title	

MECH PLAN

Sheet No.

M1.1

89-M-01