



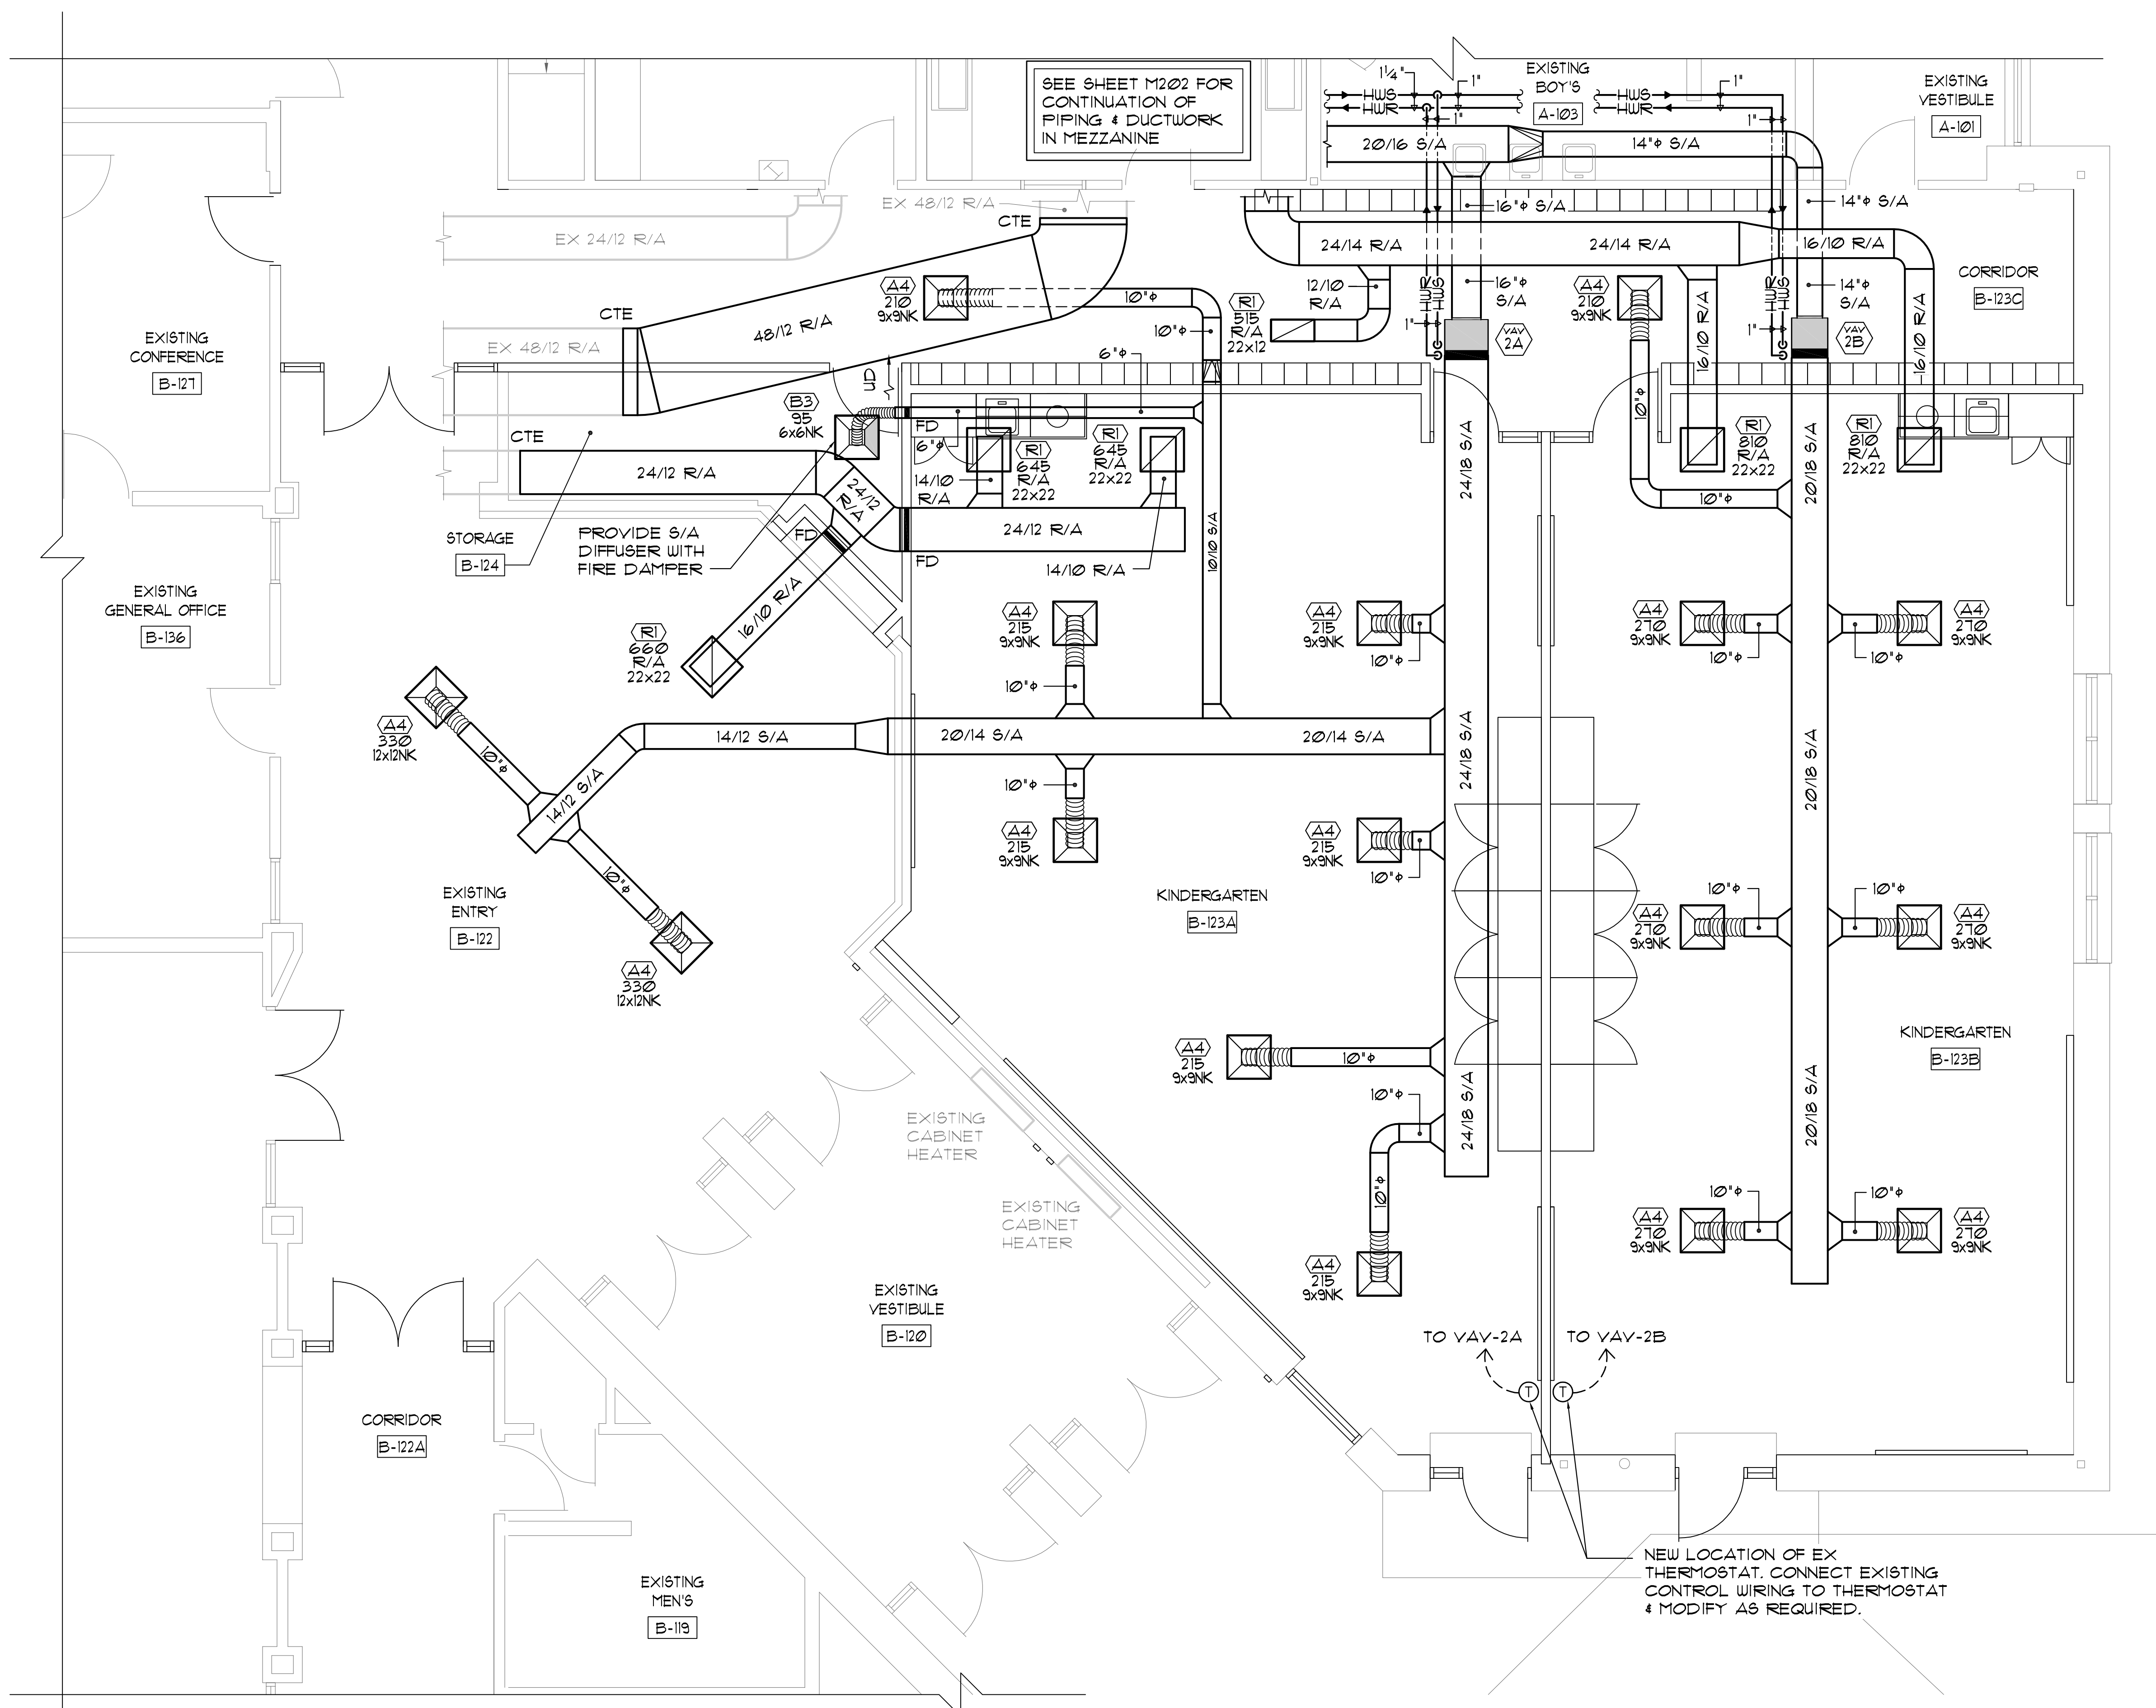



SEE SHEET M202 FOR CONTINUATION OF PIPING & DUCTWORK IN MEZZANINE

NEW LOCATION OF EX THERMOSTAT. CONNECT EXISTING CONTROL WIRING TO THERMOSTAT & MODIFY AS REQUIRED.

1 MECHANICAL FLOOR PLAN
1/4" = 1'-0"

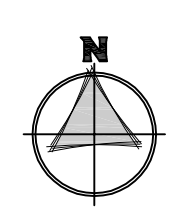

KEY PLAN
NOT TO SCALE

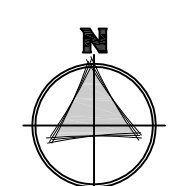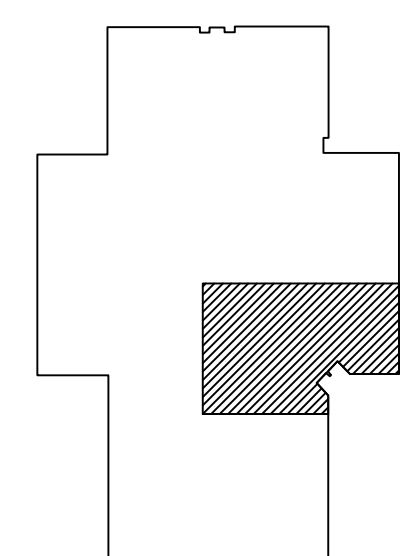

STRUCTURAL CONSULTANT:
Larson Engineering, Inc.
1505 E. 10th Street, Suite 100
Westfield, Indiana 46084-1000
(P) 630.251.0841
(F) 630.251.0842

MEP CONSULTANT:
Miles Engineering Group
6711 W. Newburg Dr. #A
Westfield, Indiana 46084
(P) 765.343.6000
(F) 765.343.6003

DUNELAND SCHOOL CORPORATION

2015

JACKSON ELEMENTARY SCHOOL RENOVATIONS

811 N. 400 E., VALPARAISO, IN 46383

PROJECT NUMBER: E-008	REVISION:
PROJECT MANAGER: SJS	1
DRAWN BY:	2
ISSUED FOR BIDDING: AUGUST 2015	
MECHANICAL FLOOR PLAN	

DUNELAND SCHOOL CORPORATION
Westfield, Indiana

M201