


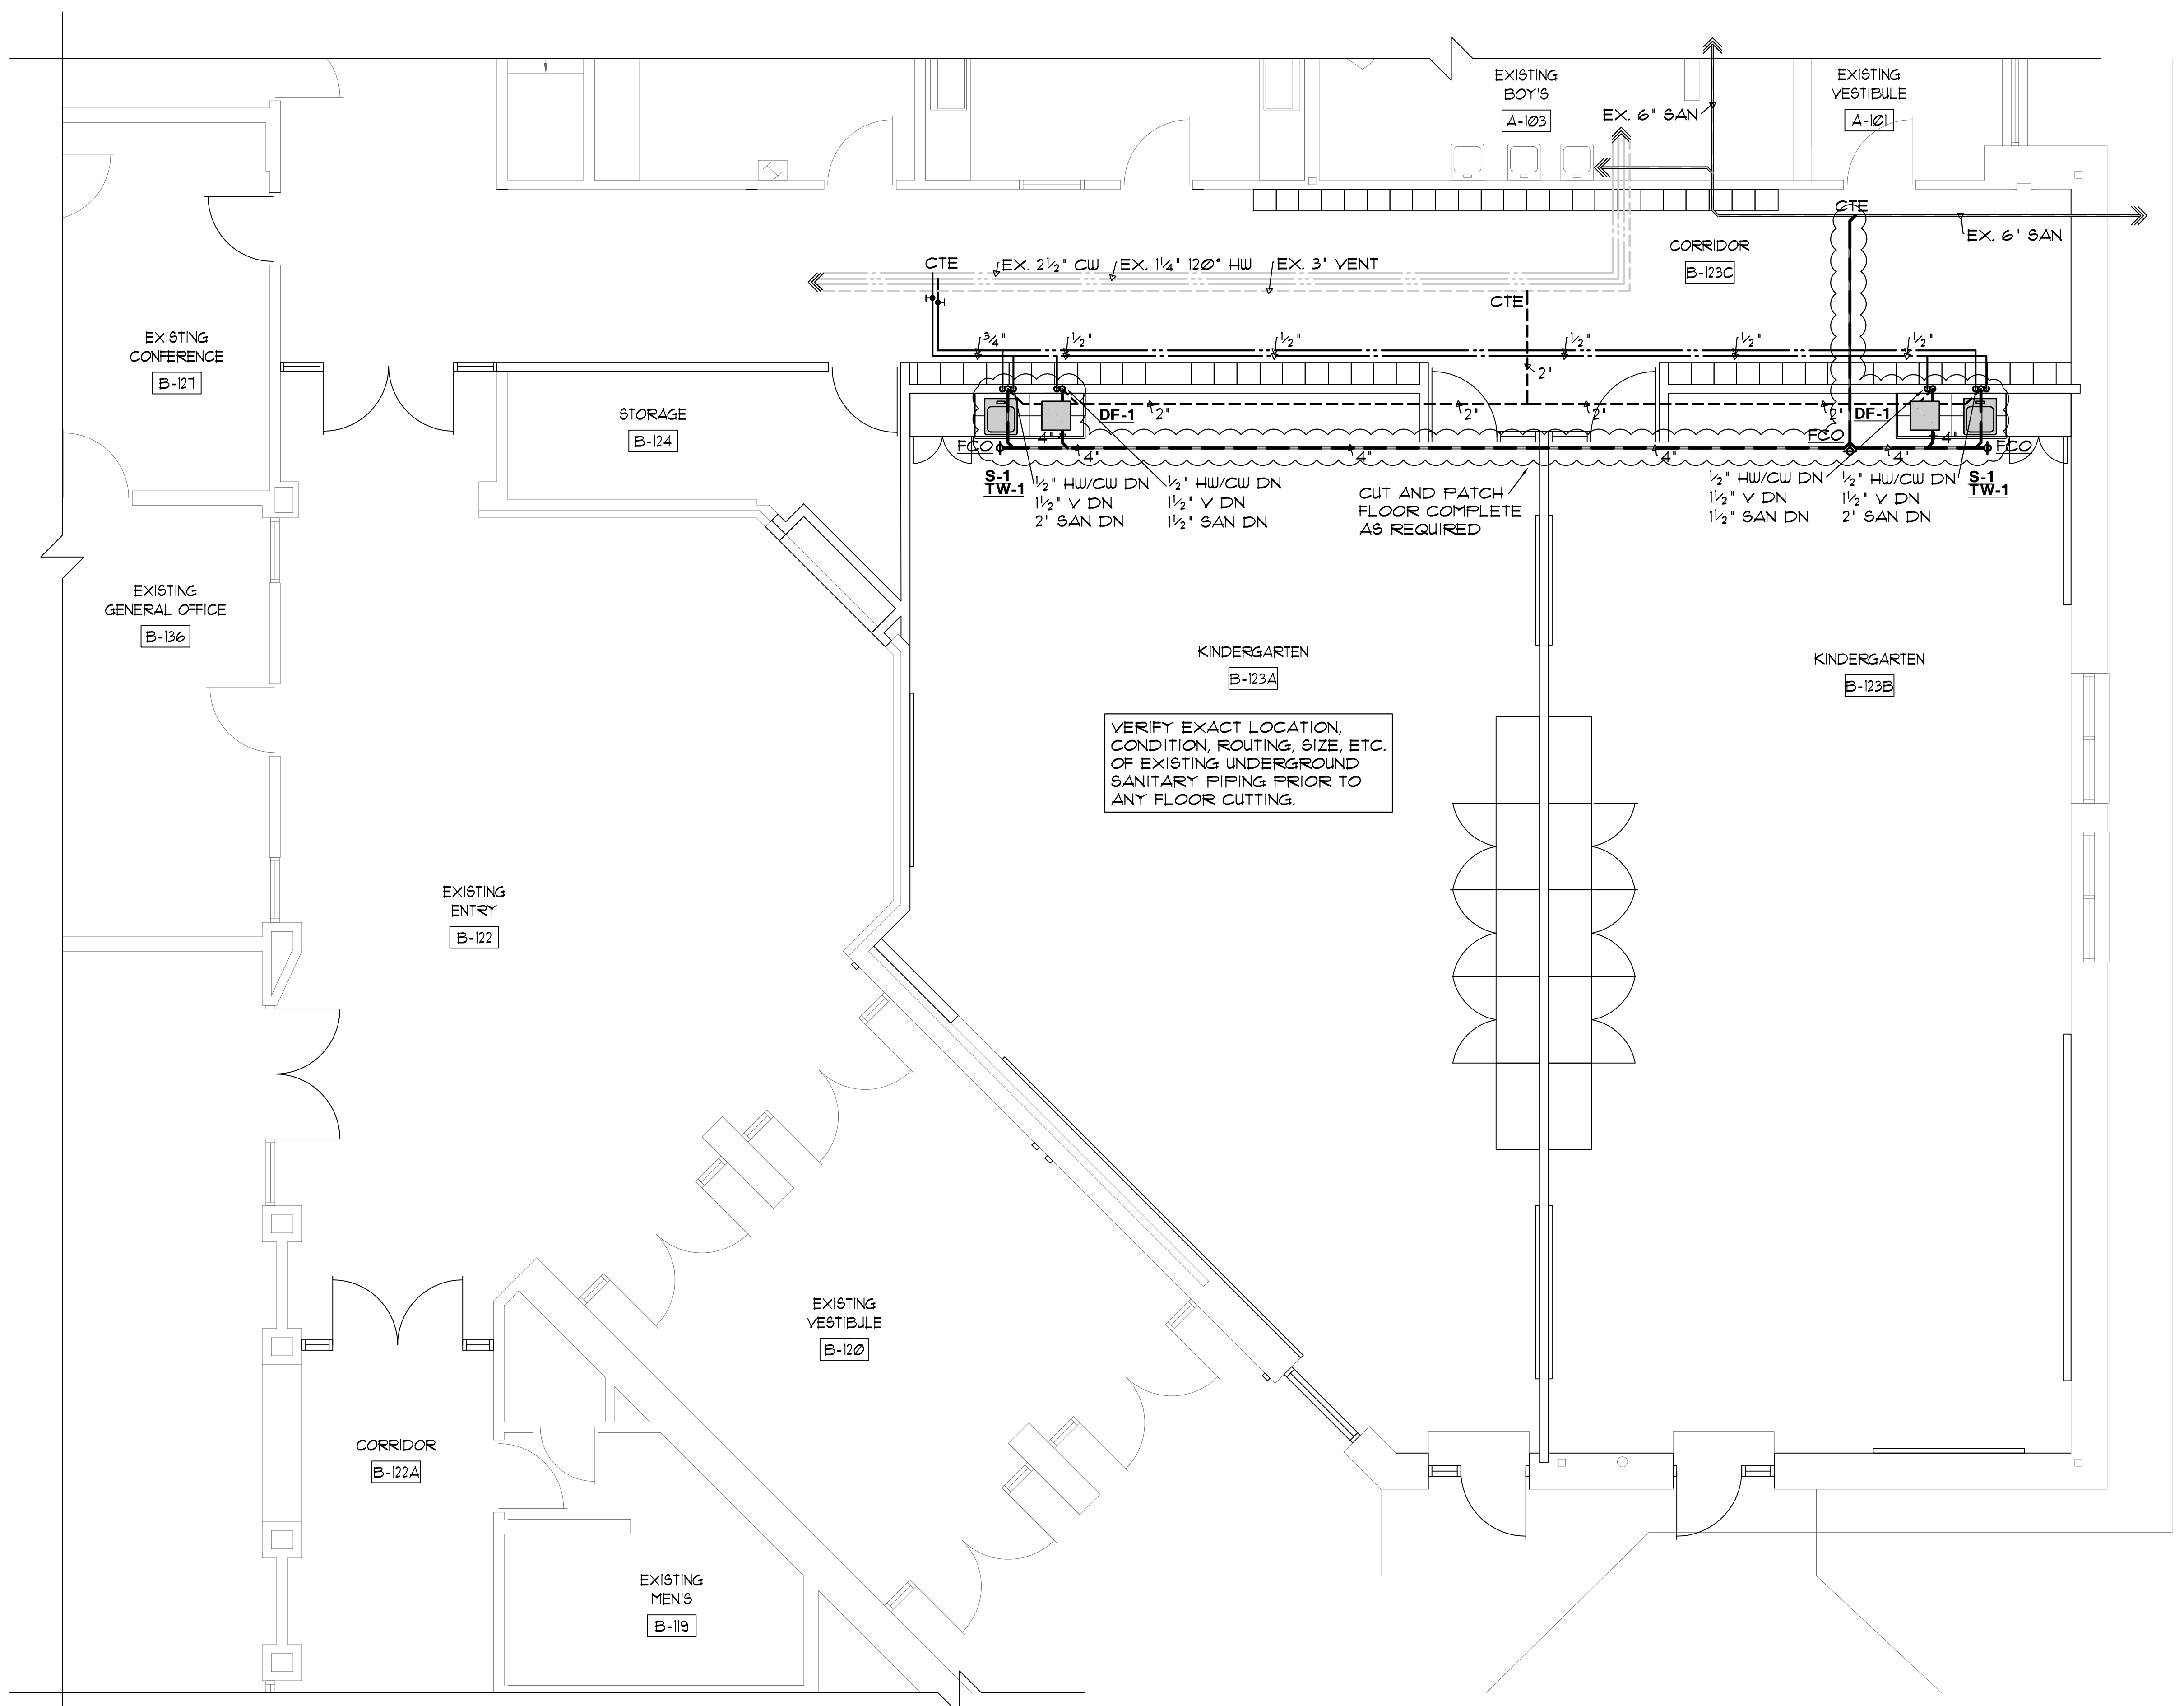
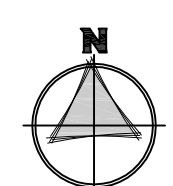


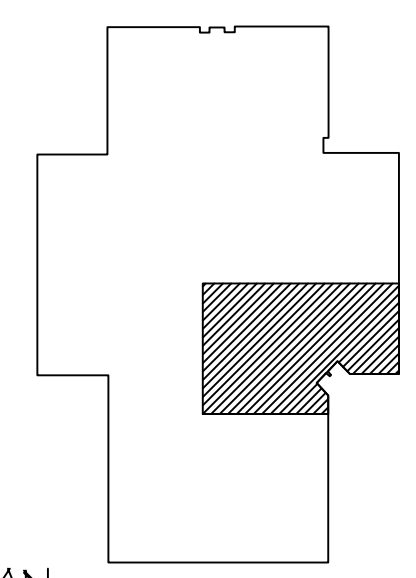

1 PLUMBING FLOOR PLAN
1/4" = 1'-0"

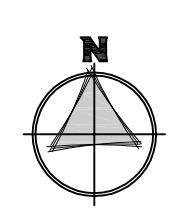

KEY PLAN
NOT TO SCALE

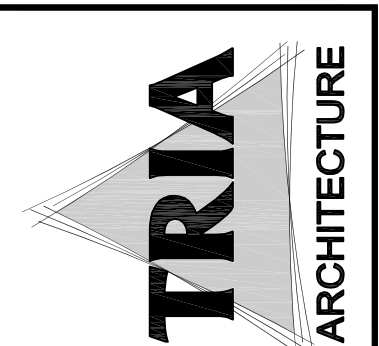

STRUCTURAL CONSULTANT:
Larson Engineering, Inc.
1500 E. 10th Street, Suite 100
Westfield, Indiana 46084-1000
(P) 630.251.0041
(F) 630.251.0042

MEP CONSULTANT:
Miles Engineering Group
6711 W. Newburg Dr. #A
Westfield, Indiana 46084
(P) 733.513.6000
(F) 733.513.6003

DUNELAND SCHOOL CORPORATION
2015
JACKSON ELEMENTARY SCHOOL RENOVATIONS
811 N. 400 E., VALPARAISO, IN 46383

PROJECT NUMBER:	E-008
PROJECT MANAGER:	SJS
DRAWN BY:	
DATE:	
ISSUED FOR BIDDING:	04/02/05
PLUMBING FLOOR PLAN	

