





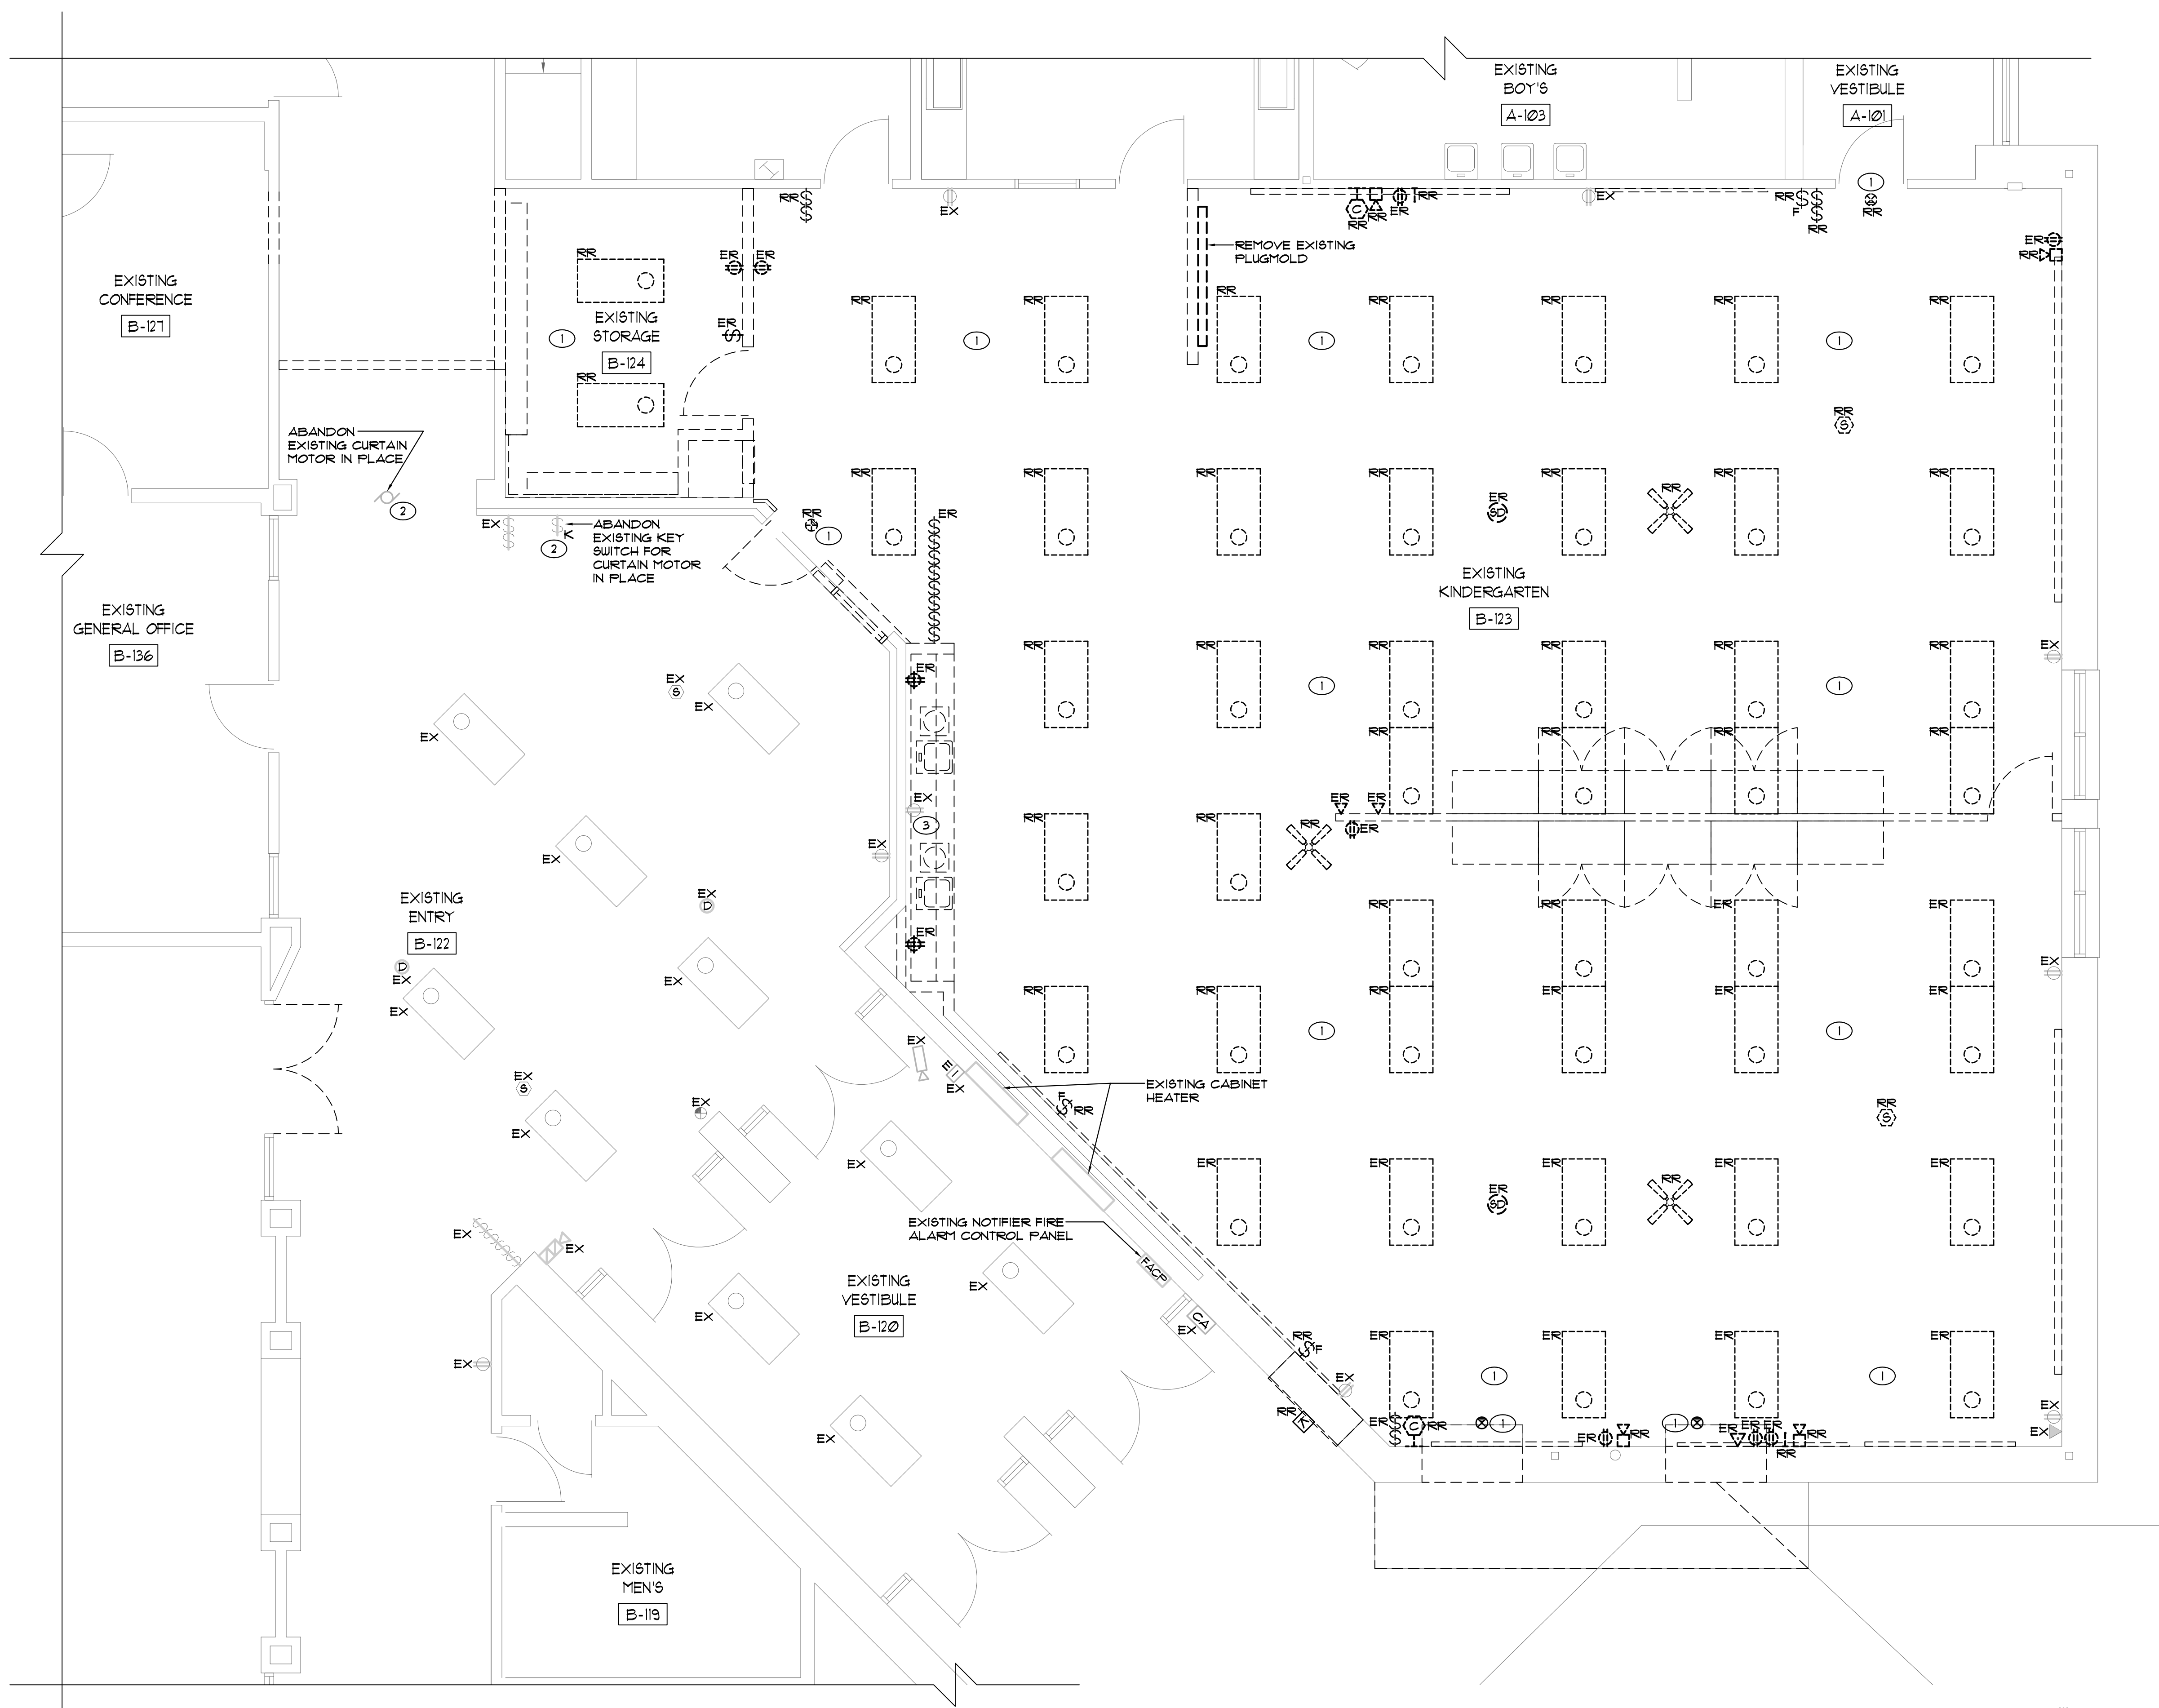


- SHEET NOTES**
1. DISCONNECT AND REMOVE EXISTING LIGHTING TO BE RELOCATED, LABELED "RR". RETAIN ALL ASSOCIATED WIRING, CONDUIT, ETC. FOR USE WITH RELOCATED LIGHT FIXTURES IN NEW LOCATIONS. SEE ELECTRICAL LIGHTING PLAN FOR NEW LIGHTING LOCATIONS.
  2. REMOVE EXISTING WIRING AND ACCESSIBLE CONDUIT BACK TO SOURCE.
  3. ELECTRICAL CONTRACTOR SHALL ADJUST THE BOX AND COVER FOR ELECTRICAL DEVICE TO AS THIN A PROFILE AS NECESSARY TO ACCOMMODATE THE REMOVE OF CASEWORK.

1 ELECTRICAL EXISTING PLAN  
1/4" = 1' - 0"

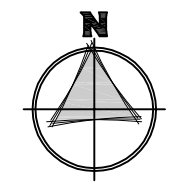

KEY PLAN  
NOT TO SCALE

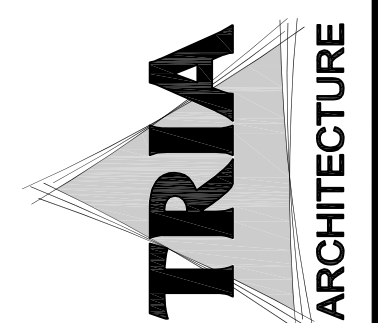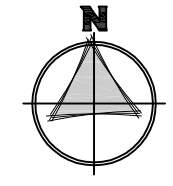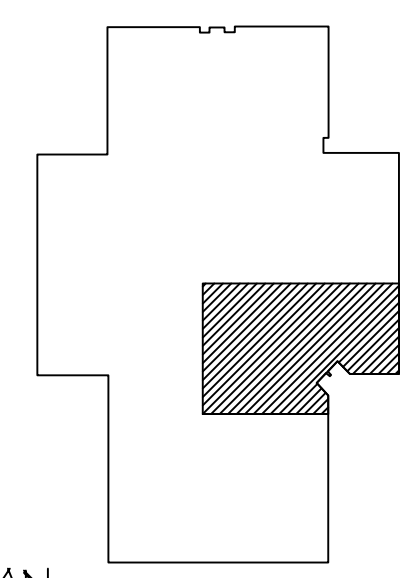


**Larson Engineering, Inc.**  
185 E. 10th Street, Suite 100  
Westerville, OH 43081-1000  
(614) 885-1000  
FAX (614) 885-1001

**Millies Engineering Group**  
6711 W. 12th Street, Suite 100  
Westerville, OH 43081-1000  
(614) 885-1000  
FAX (614) 885-1001

**DUNELAND SCHOOL CORPORATION**  
**2015**  
**JACKSON ELEMENTARY SCHOOL RENOVATIONS**  
**811 N. 400 E., VALPARAISO, IN 46383**

|                               |           |
|-------------------------------|-----------|
| PROJECT NUMBER: E-008         | REVISION: |
| PROJECT MANAGER: SCS          | 1         |
| DRAWN BY:                     | 2         |
| USED FOR BIDDING: AUGUST 2015 | 3         |
| ELECTRICAL EXISTING PLAN      |           |

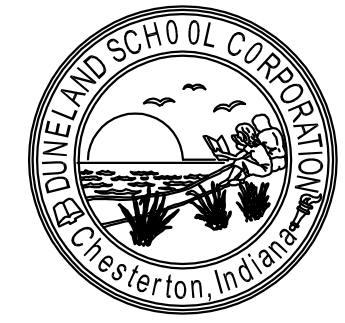

E101