

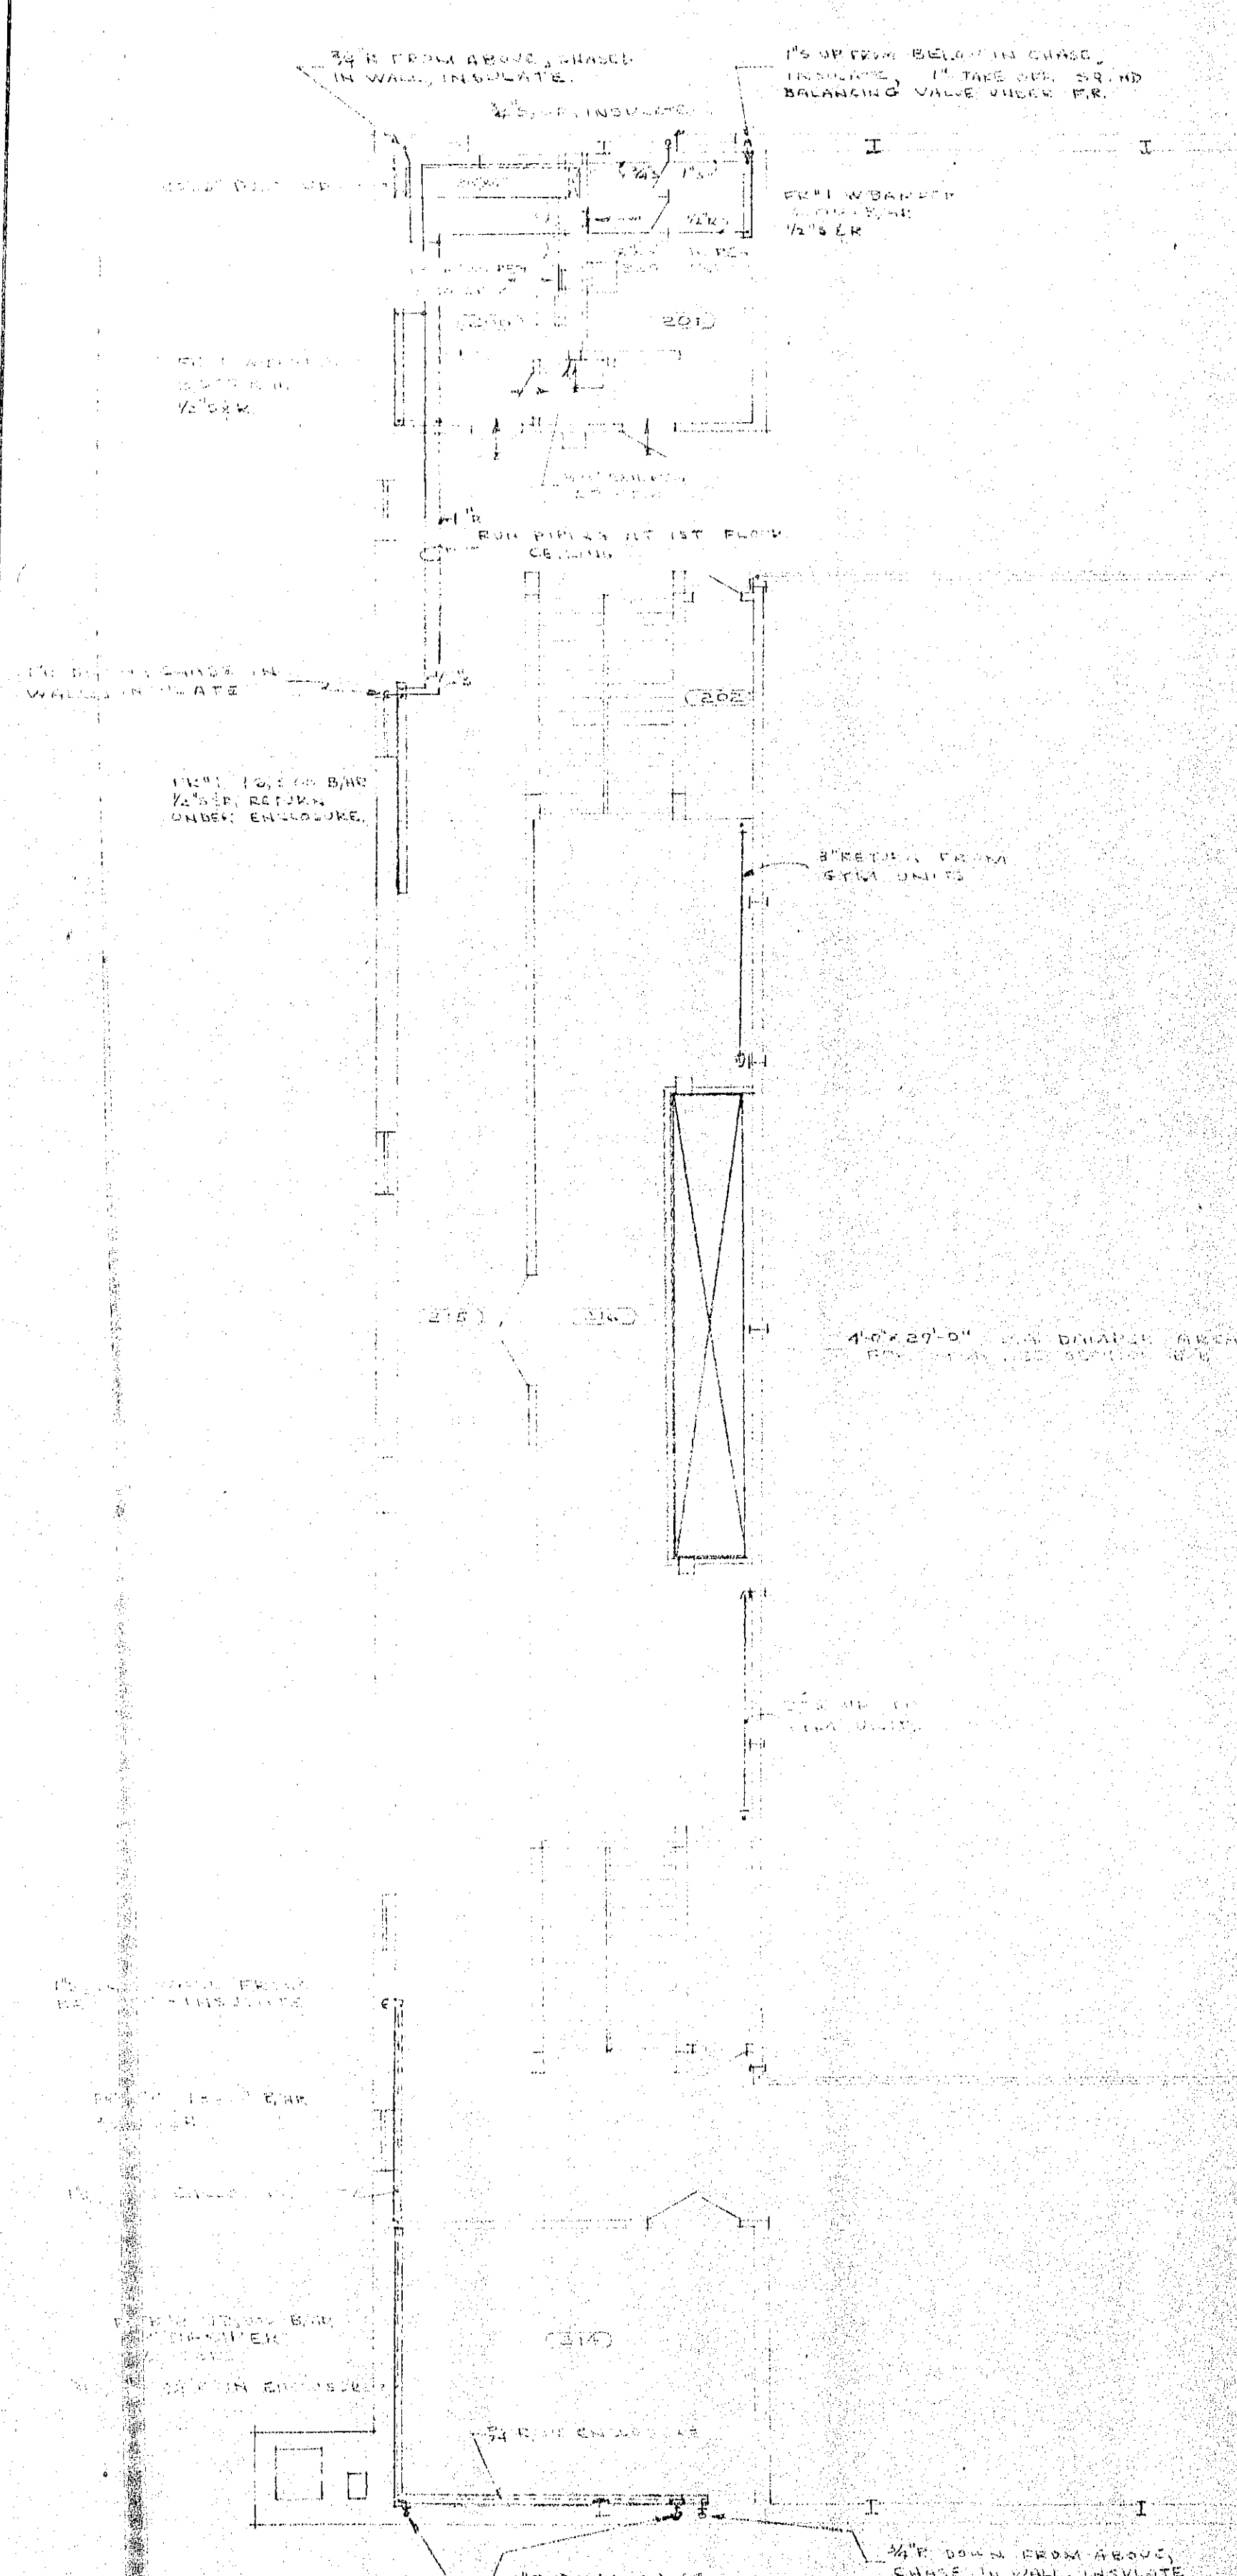
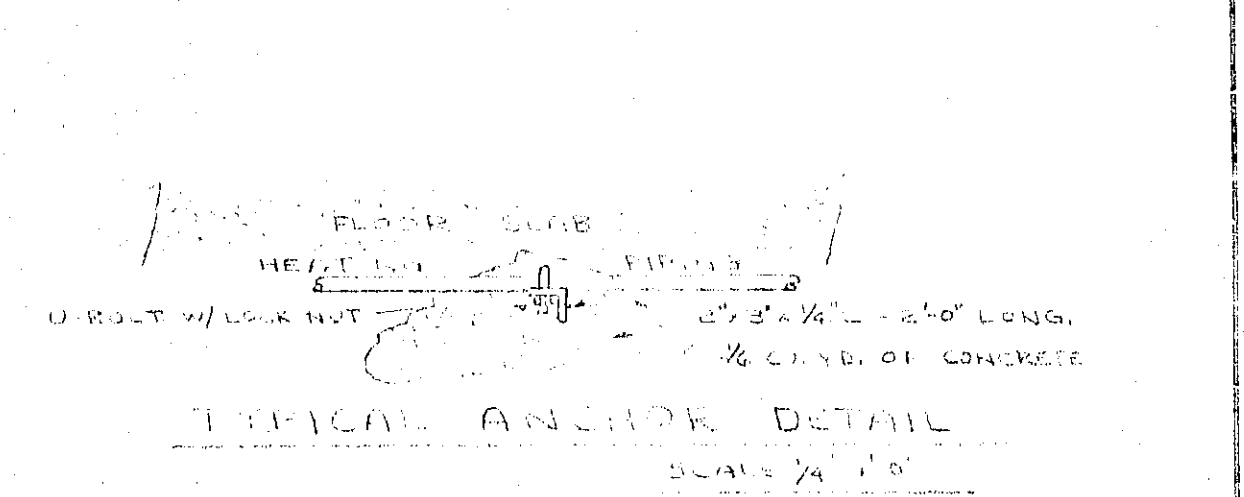
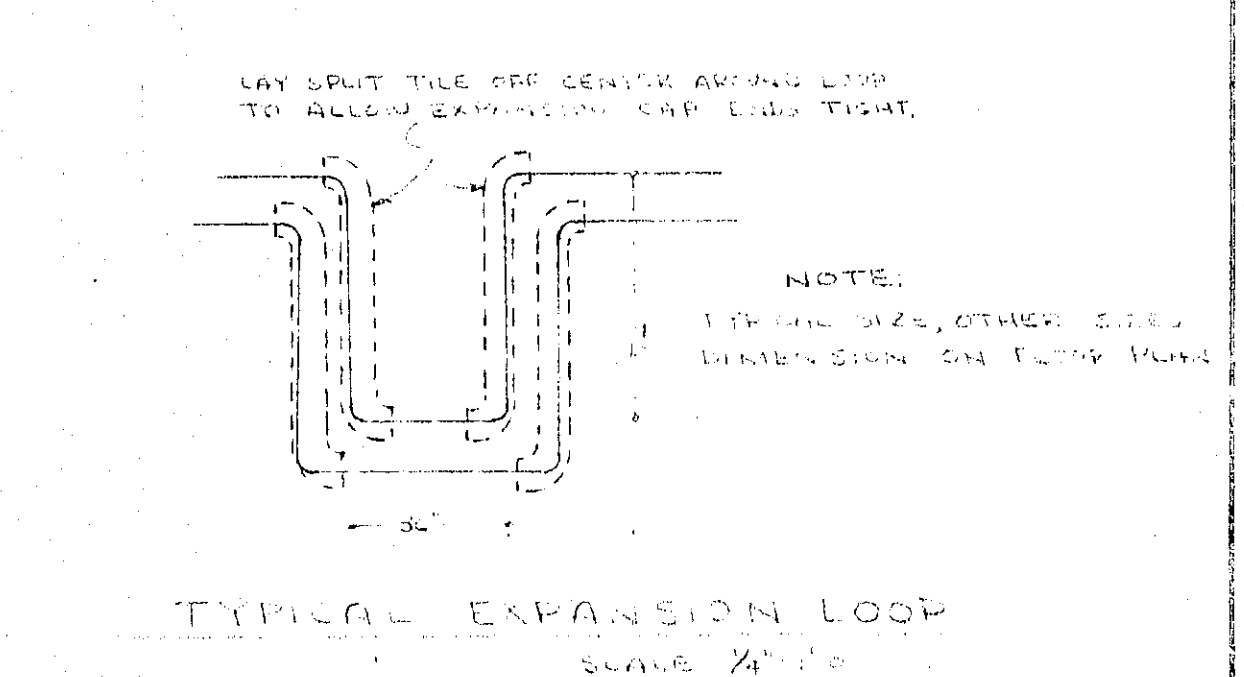
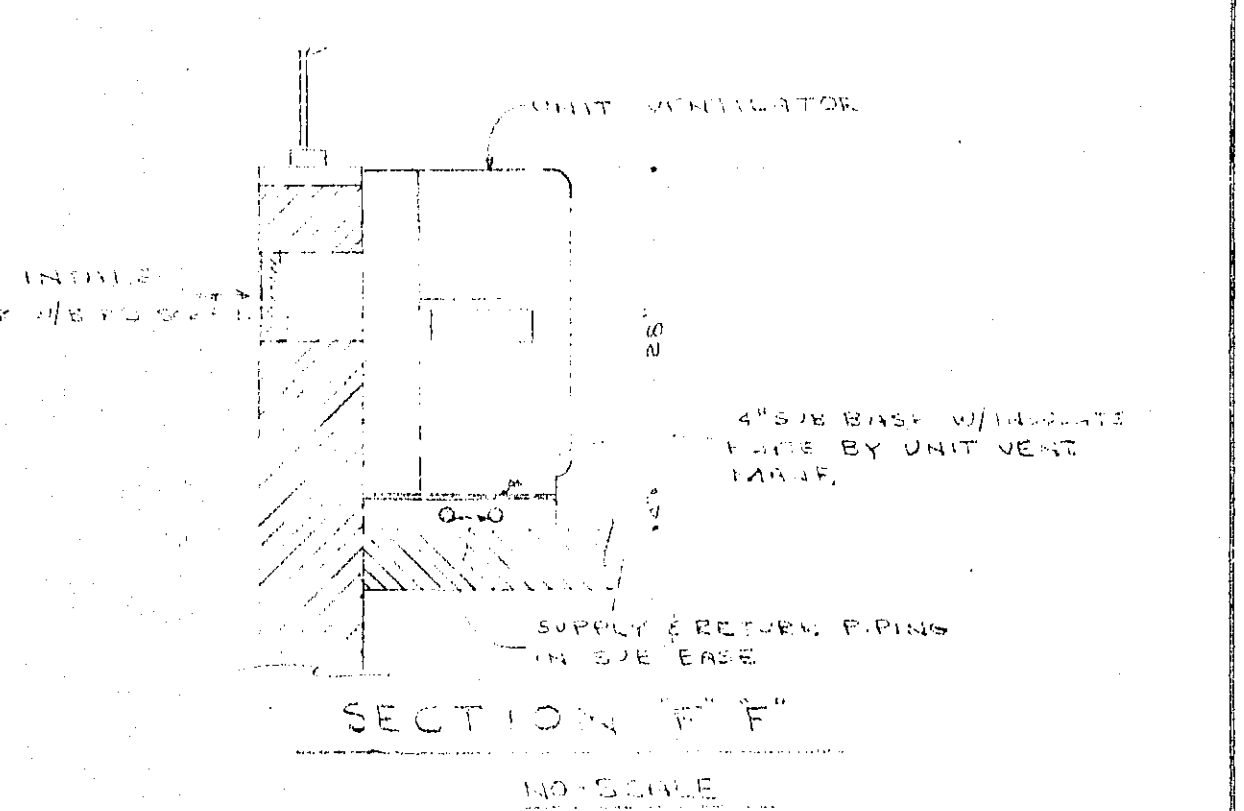


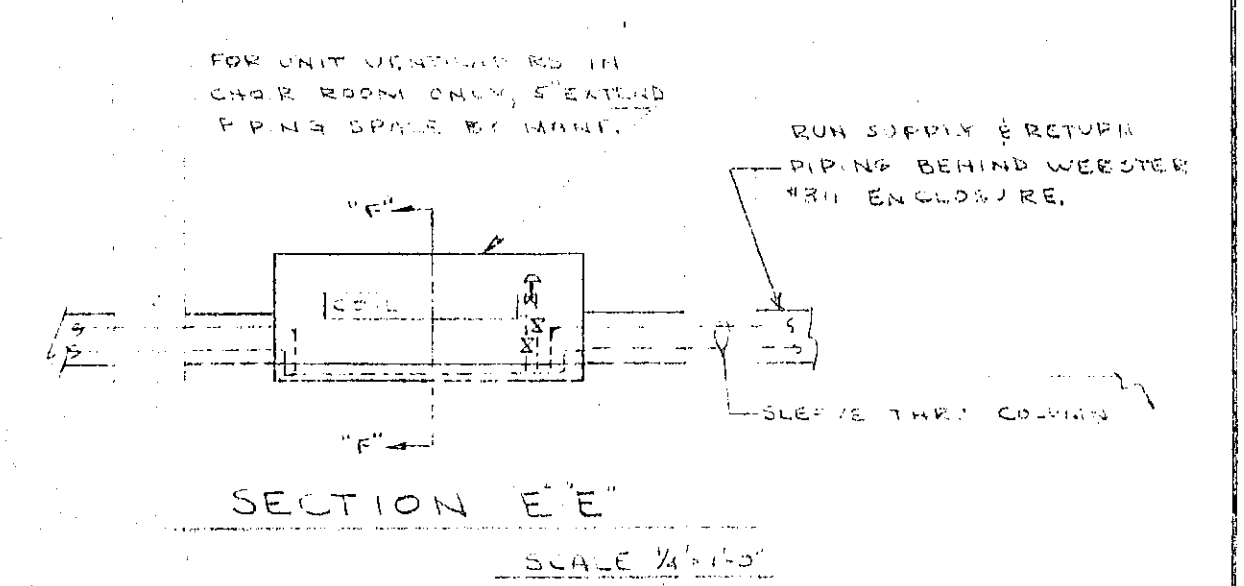

MEZZANINE FLOOR
HEATING & VENTILATING PLAN
SCALE 1/8" = 1'-0"

2" SUPPLY UP FROM BELOW, 2" SUPPLY BRANCH AT 1ST FLOOR CEILING, 1 1/2" H-1 UP (INSULATE PIPING IN CHASE)

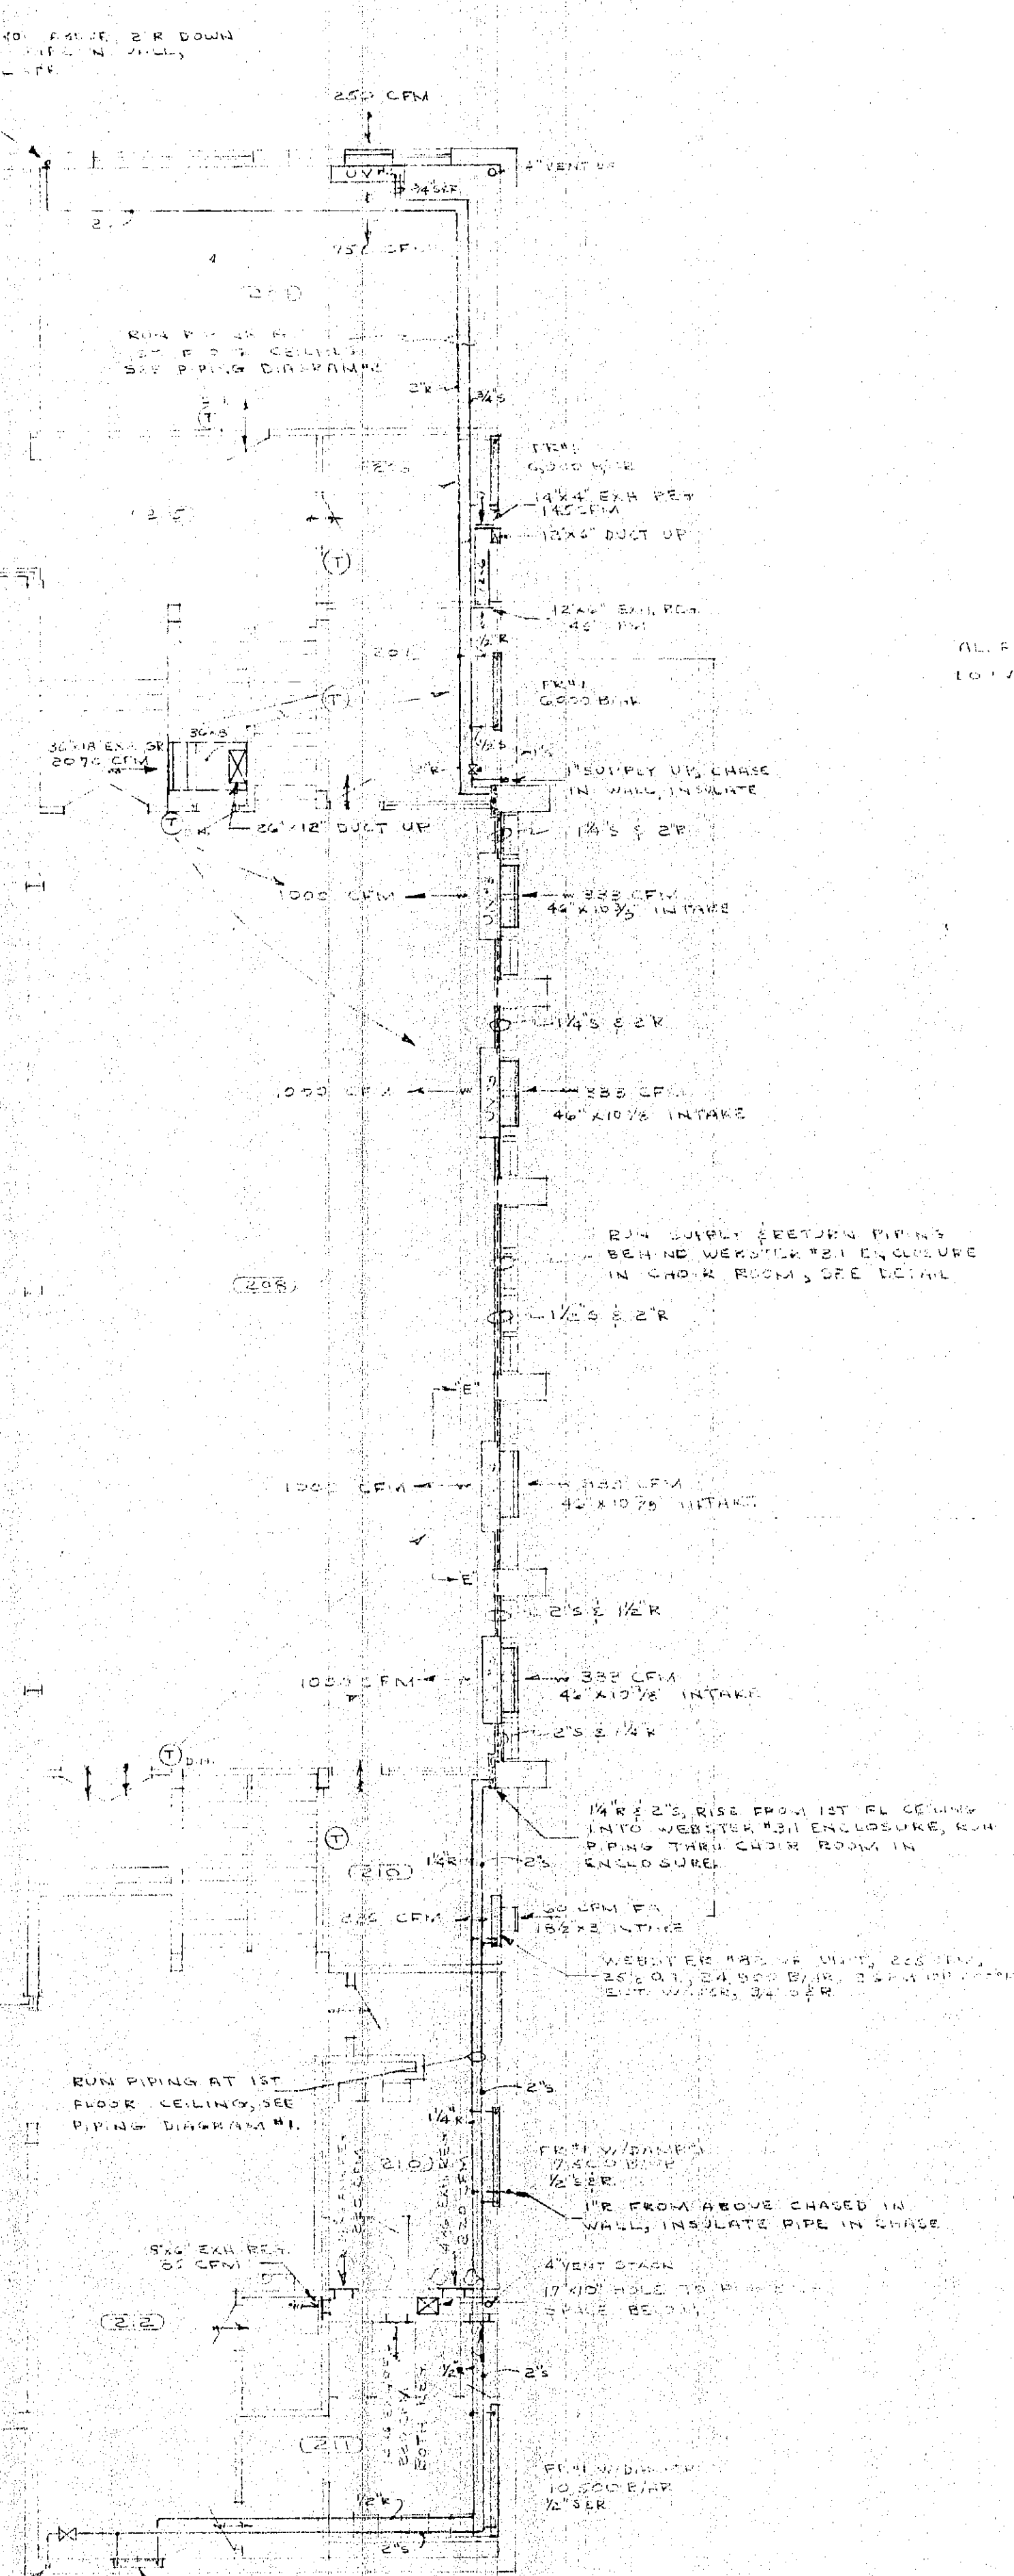

DATE NOV. 10, 1959 CERTIFIED BY DOUGLAS F. NALLY REGISTERED NO. 1999 STATE OF INDIANA	HEATING - SECOND FLOOR PLAN (S.H. MO) PHYSICIAN EDUCATIONAL BUILDING WEST VIRGINIA UNIVERSITY MORGANTOWN, W. VA. SCHUTT-NALLY, ASSOCIATES ARCHITECTS AND ENGINEERS 510 JEFFERSON ST. GARY, IND.
---	--

REYNOLDS W. PARKER, ENGINEER
1000 W. 10TH STREET
MORGANTOWN, W. VA.