


LIGHTING PANEL BOARD NO. 1			
N90-32-3L		225A. MAINS	
		120/208 VOLT 1 PHASE 3 WIRE	
1	2 INCANDESCENT FIXTURES	2	2 INCANDESCENT FIXTURES
3	DITTO	4	DITTO
5	DITTO	6	DITTO
7	DITTO	8	DITTO
9	DITTO	10	DITTO
11	DITTO	12	DITTO
13	3 INCANDESCENT LTR. STAGE	14	3. FLOOR RECEP.TS.
15	2 INCANDESCENT LTR. STAGE BEAR	16	8 RECEP.TS. & 1 PROGRAM BELL
17	2 INCANDESCENT LTR. STAGE BEAR	18	2 FLOOR RECEP.TS.
19	8 RECEP.TS. & 1 1/8 HP ATR. MOTOR	20	2 FLOOR 2 WALL RECEP.TS.
21	10 TRC LTR. HALLWAY ENTRANCEWAY	22	1 RECEP.TABLE
23	3 CLO. LOCKS-MULTI PURPOSE ROOM	24	1 1/4 HP - BACK ROOM HOIST
25	1 1/4 HP EXHAUST FAN	26	9 INCAND. LTR. STORAGE ROOMS
27	3 RECEP.TS. STORAGE ROOMS	28	2 INCAND. LTR. - STAGE. ROOMS
29	6 INCAND. LTR. - UNITILES WORKSHOP	30	6 RECEP.TS - STORAGE. WAREHOUSE & POLYMER
31	SPACE	32	SPACE


LIGHTING PANELBOARD NO.2			
NQO-24-4L		100A. MAINS	120/208 VOLT, 3 PHASE, 4 WIRE
1	8 FLOOR FIX. C.R.#6	2	16 FLOOR FIXTURES C.R.#4
3	8 FLOOR. FIXTURES C.R.#6	4	8 FLOOR FIX. C.R.#6
5	12 FLOOR. FIXTURES C.R.#7	6	8 FLOOR FIX. C.R.#6
7	8 FLOOR FIX. C.R.#7	8	12 FLOOR FIXTURES C.R.#5
9	8 WALK-IE-HR. MOTOR GIRLS SHOWER	10	3 RECEPTS. #2-1/2 HP HTR. MOTORS
11	8 INCLITS. FL. MOTOR BOYS SHOWER	12	SPACE
13	5 RECEPTS. #1-1/2 HP HTR. MOTORE C.R.#4	14	7 HALL #1 ENTER. WAY LITS.
15	4 RECEPTS. #1-1/2 HP HTR. MOTORE C.R.#5	16	SPACE
17	4 RECEPTS. #1-1/2 HP HTR. MOTORE C.R.#6	18	SPACE
19	3 RECEPTS. #1-1/2 HP HTR. MOTORE C.R.#7	20	SPACE
21	SPACE	22	SPACE
23	SPACE	24	SPACE

LIGHTING PANEL BOARD No.3 - KITCHEN			
NQO-32-4L	225A MAINS	120/208VOLT, 3 PHASE, 4 WIRE.	
1	8 INC. LTR. SKULLERY, REFR. STOPAGE	2	1 1/2 HP CONVEYOR OF DISH WASHER
3	1 REFR. OPERATOR & FREEZER	4	1 RECEPT.
5	1 RECEPT.	6	3/4 HP DISPOSAL-208V, 1 Ø (USA)
7	4 RECEPT.	8	3 INC. FIXTURES
9	2 INC. FIXTURES & 1 1/2 HP MOTOR	10	3 INC. FIXTURES
11	1 CLOCK & 1 BELL	12	3 INC. FIXTURES
13	3/4 HP DISH WASHER, 208V, 1 Ø (USA)	14	3 INC. FIXTURES
15	1 1/2 HP DISH WASHER, 208V, 1 Ø (USA)	16	1 1/2 HP DISH WASHER, 208V, 1 Ø (USA)
17	1 1/2 HP DISH WASHER, 208V, 1 Ø (USA)	18	1 1/2 HP DISH WASHER, 208V, 1 Ø (USA)
19	1 1/2 HP DISH WASHER, 208V, 1 Ø (USA)	20	1 1/2 HP DISH WASHER, 208V, 1 Ø (USA)
21	1 1/2 HP DISH WASHER, 208V, 1 Ø (USA)	22	1 1/2 HP DISH WASHER, 208V, 1 Ø (USA)
23	2 INC. LIGHTS	24	2 INC. LIGHTS
25	1 RECEPT. - FEEZLER	26	1 RECEPT. - FEEZLER
27	SPARE	28	SPARE
29	SPARE	30	SPARE
31	SPARE	32	SPARE
ALL MOTORS TO HAVE STARTERS AS REQUIRED.			

ALL MOTORS TO HAVE STARTERS AS REQUIRED.

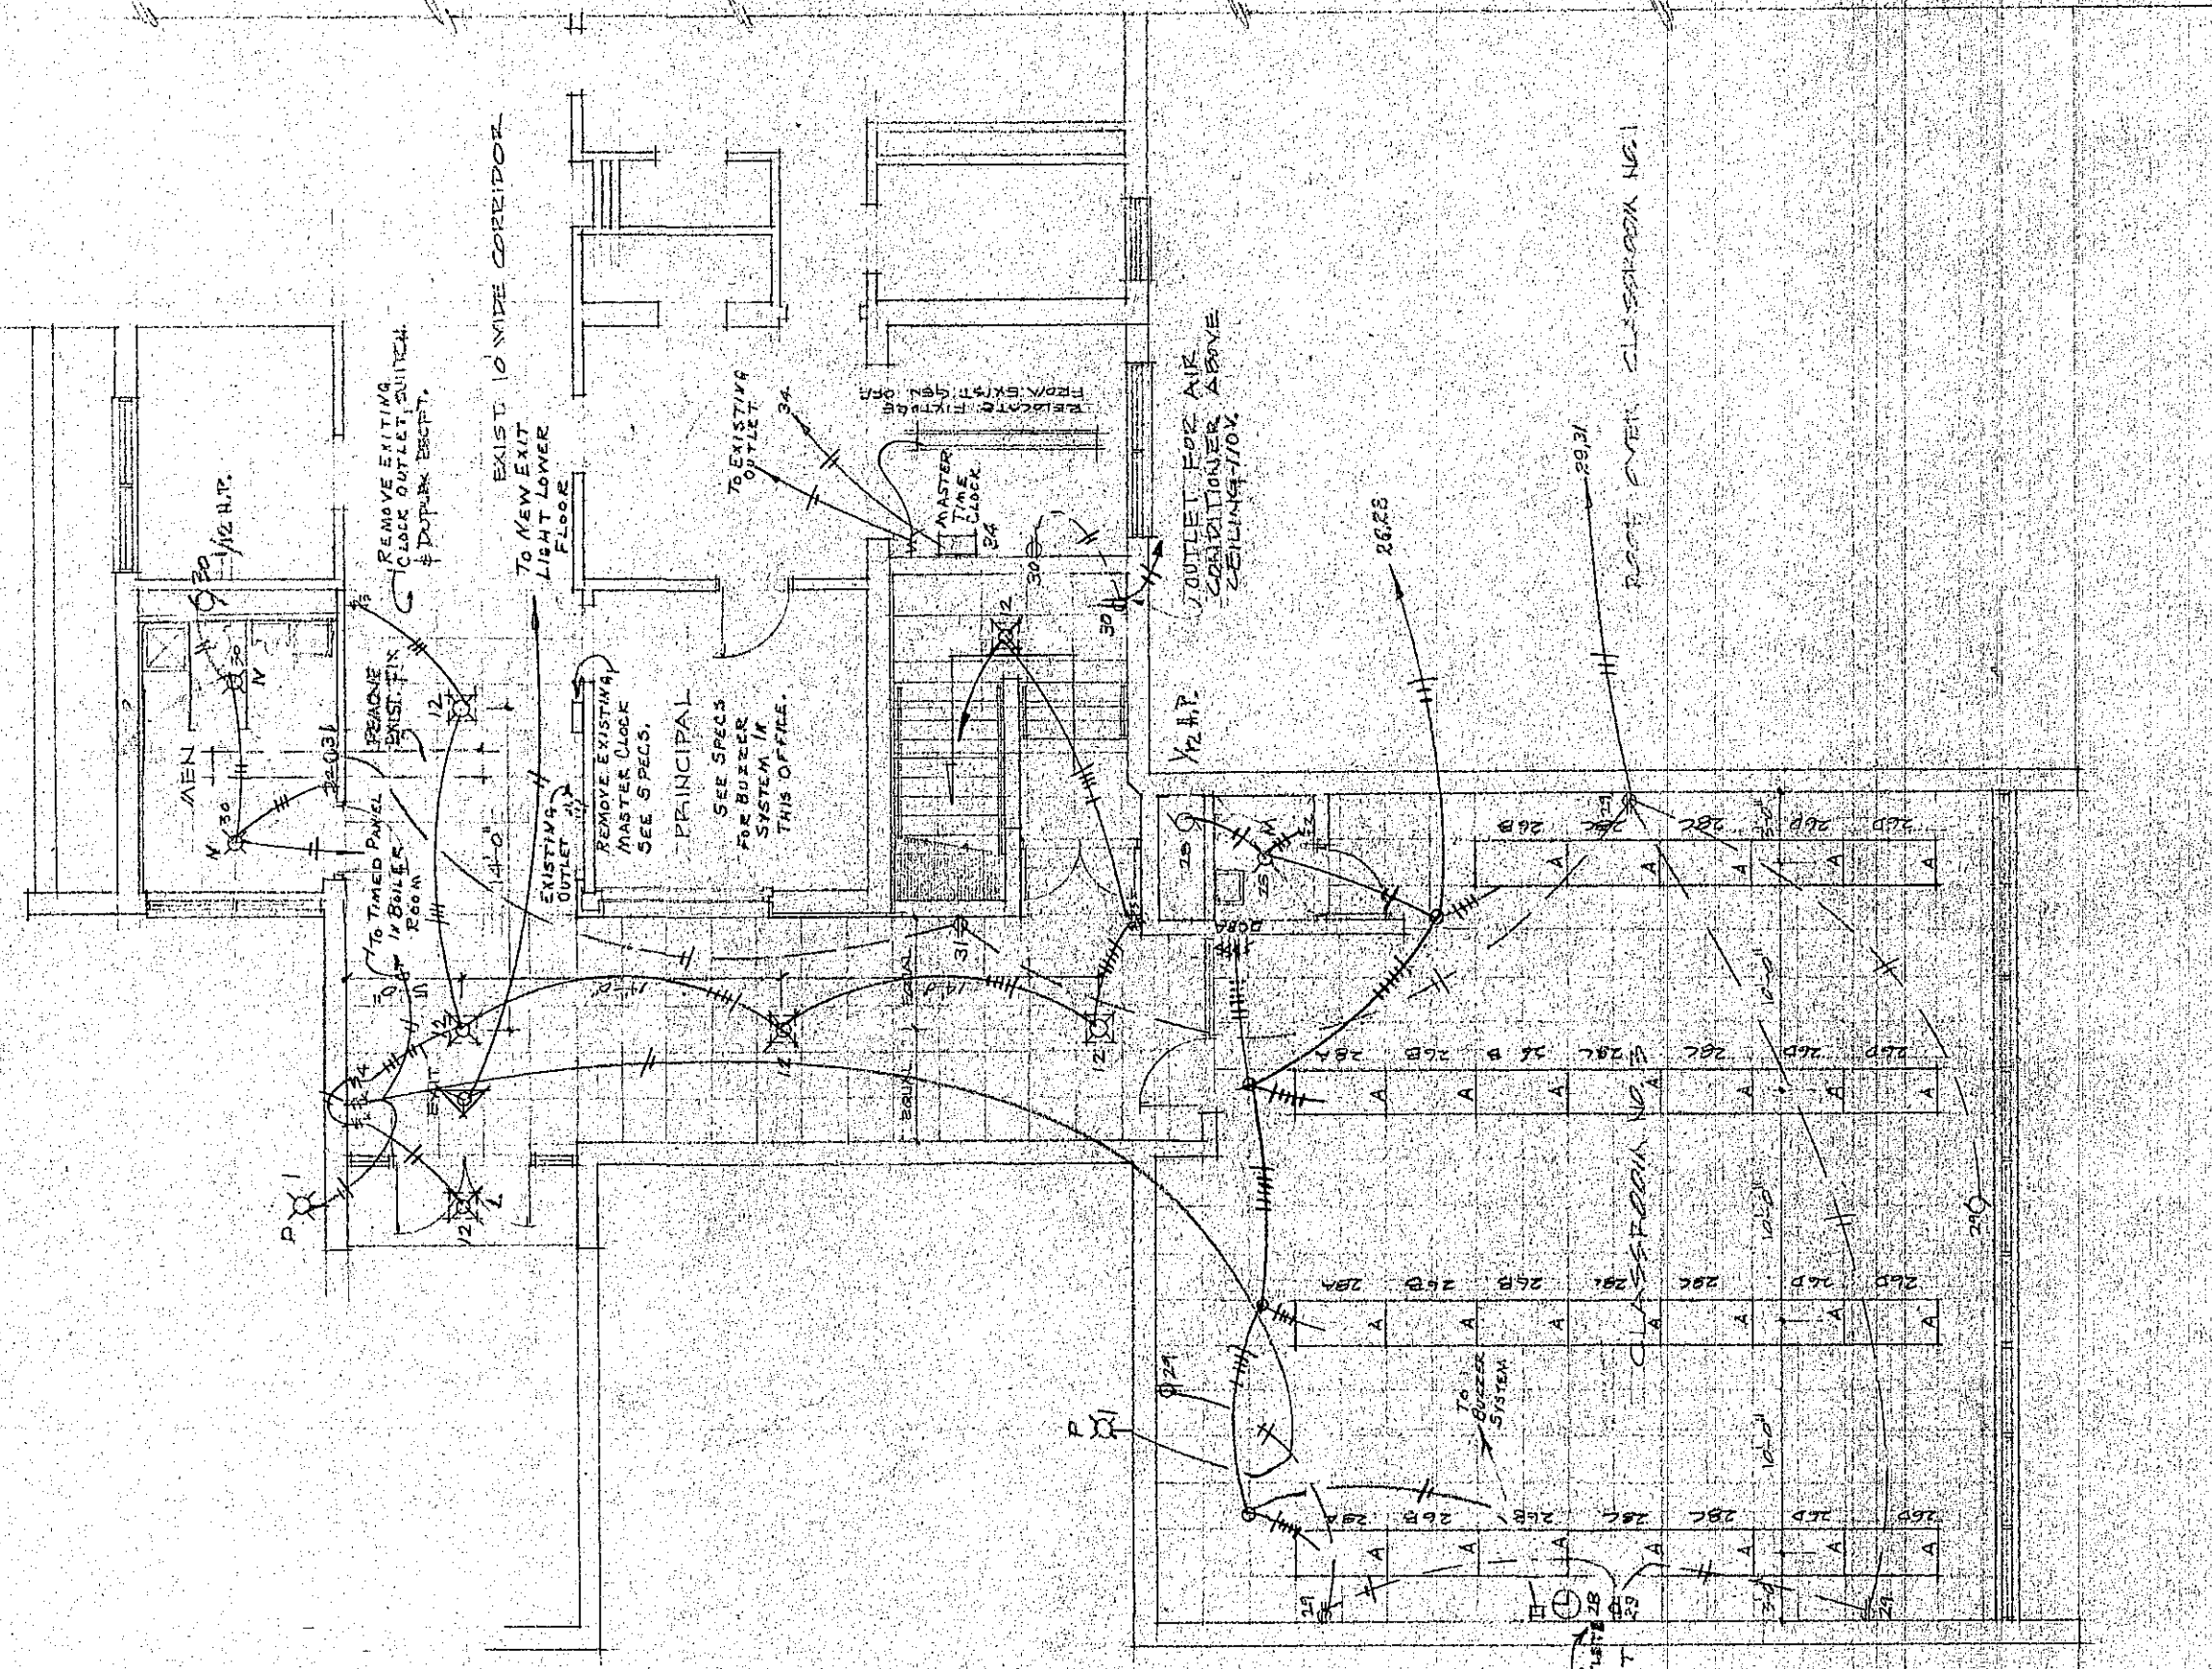

EAST CLASSROOMS-UPPER LEVEL ELECTRICAL PLAN
SCALE: 3/8"=1'-0"

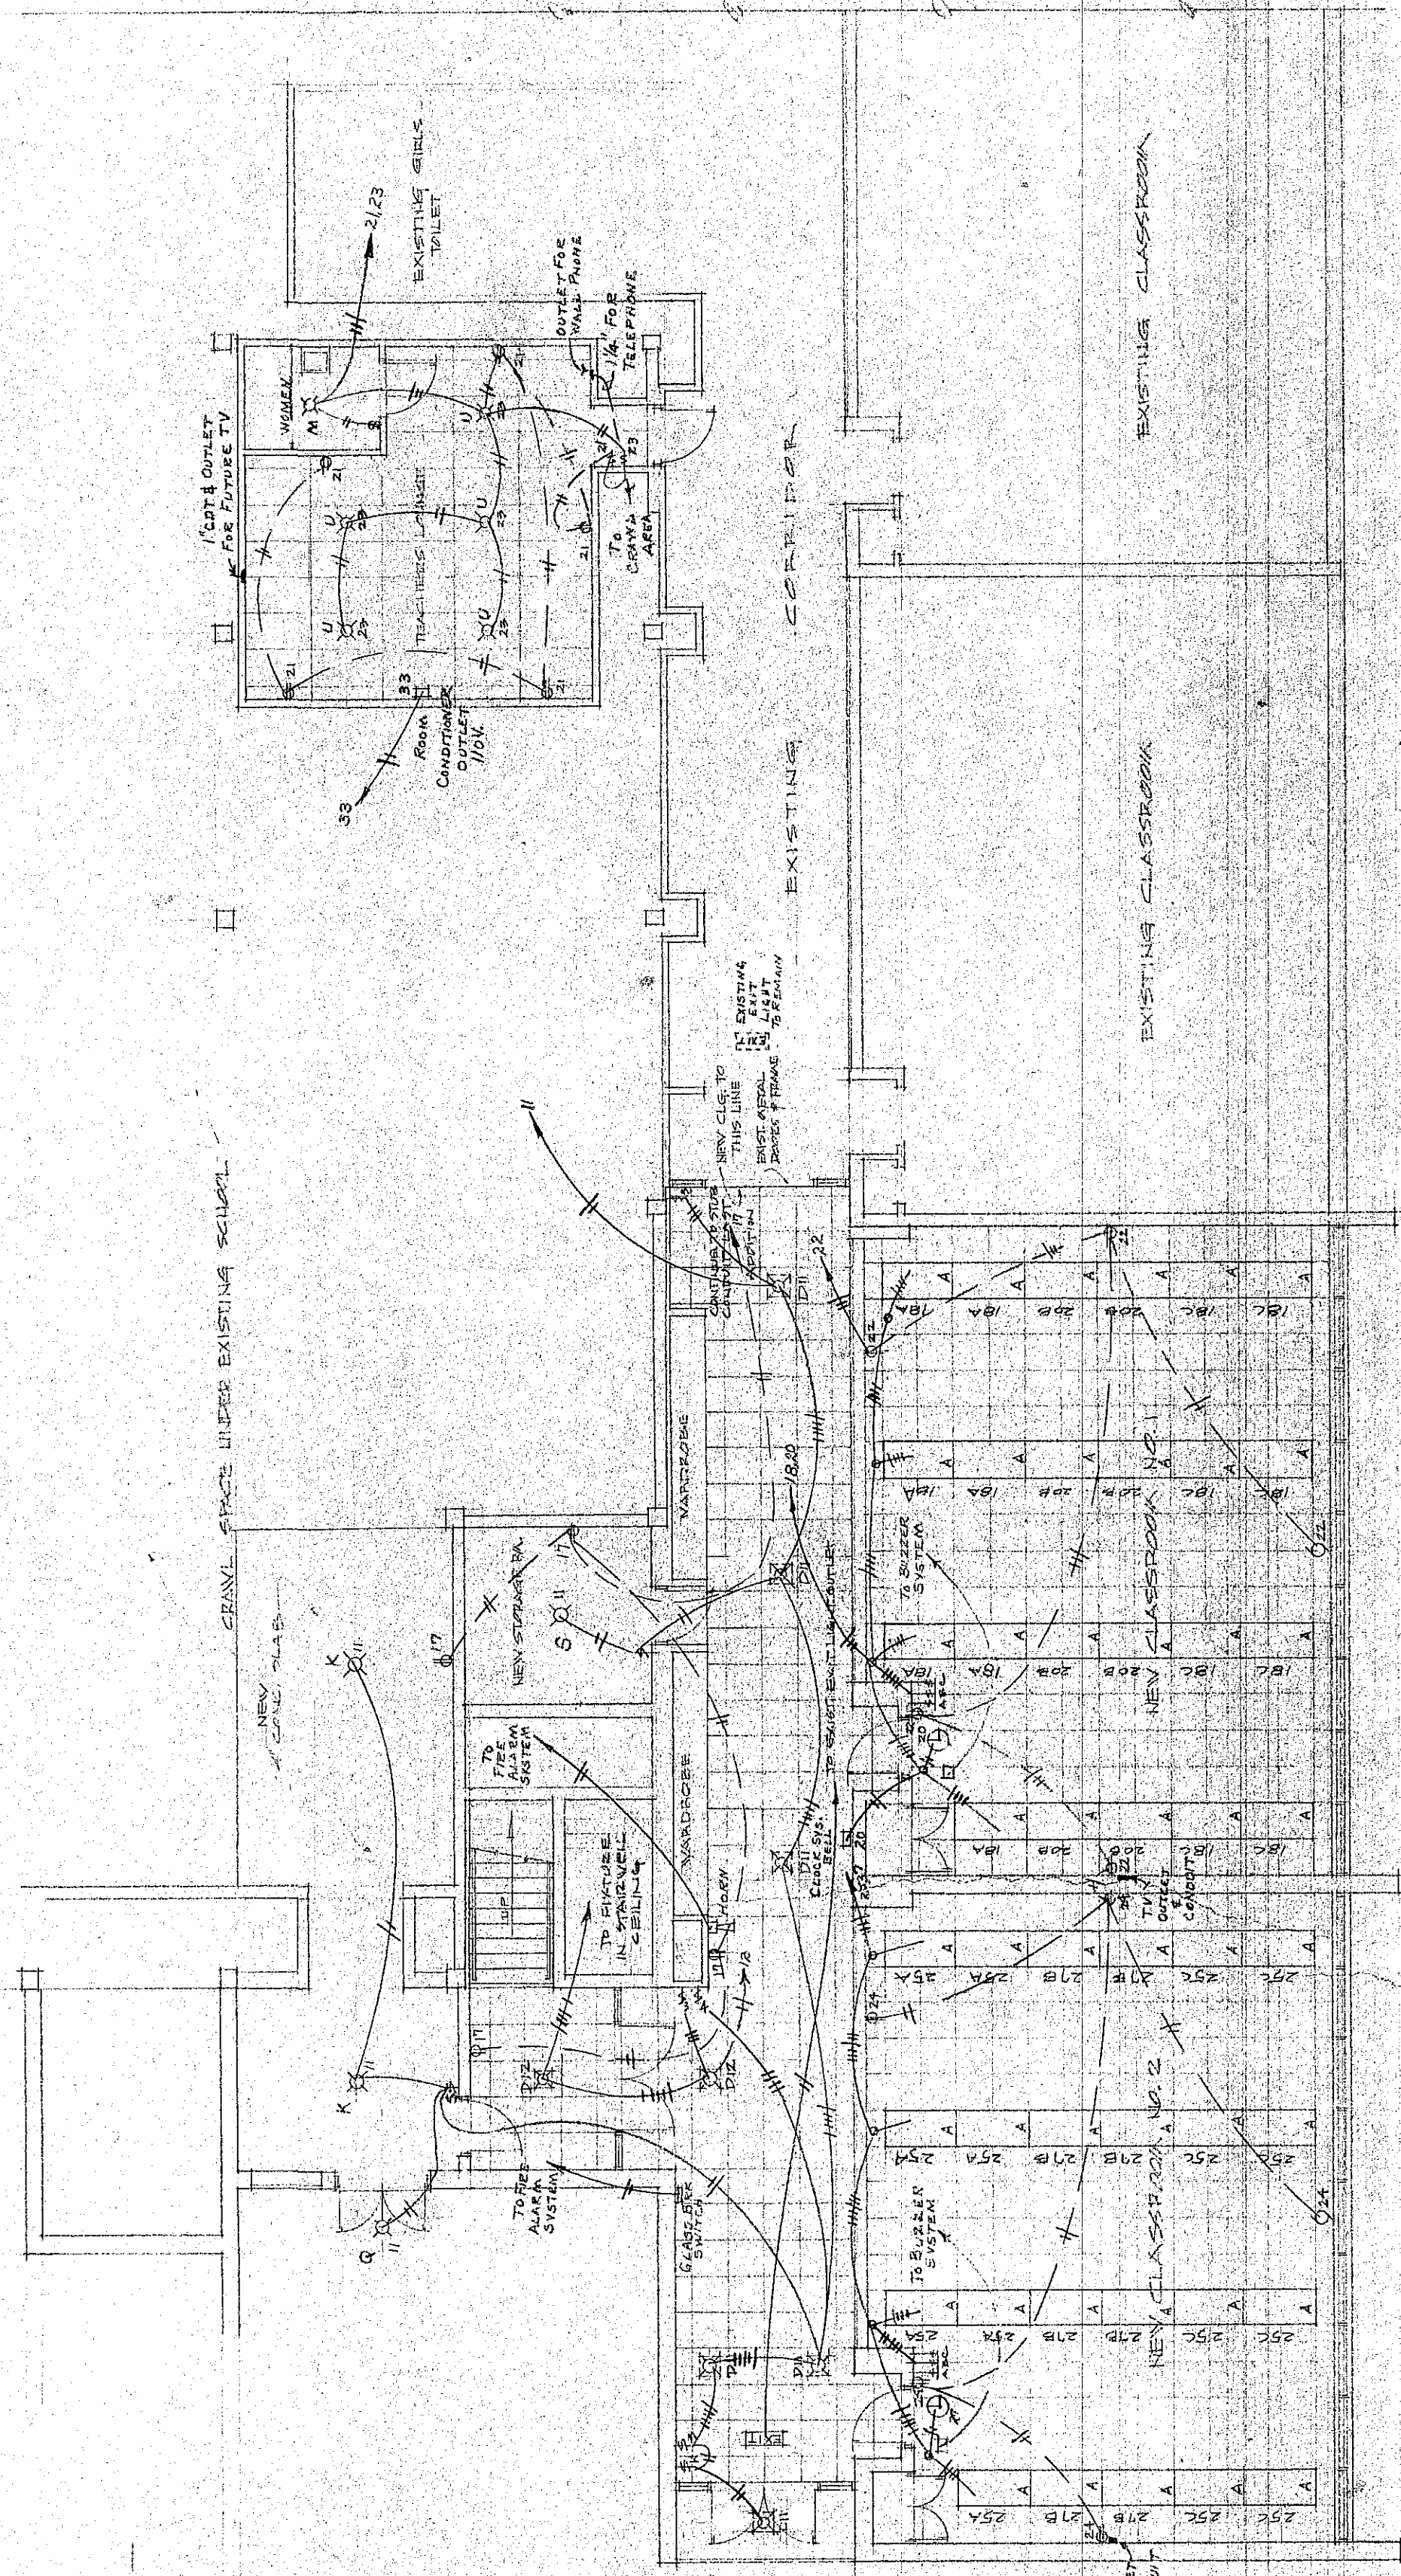

EAST CLASSROOMS-LOWER LEVEL ELECTRICAL PLAN
SCALE: 3/8"=1'-0"