



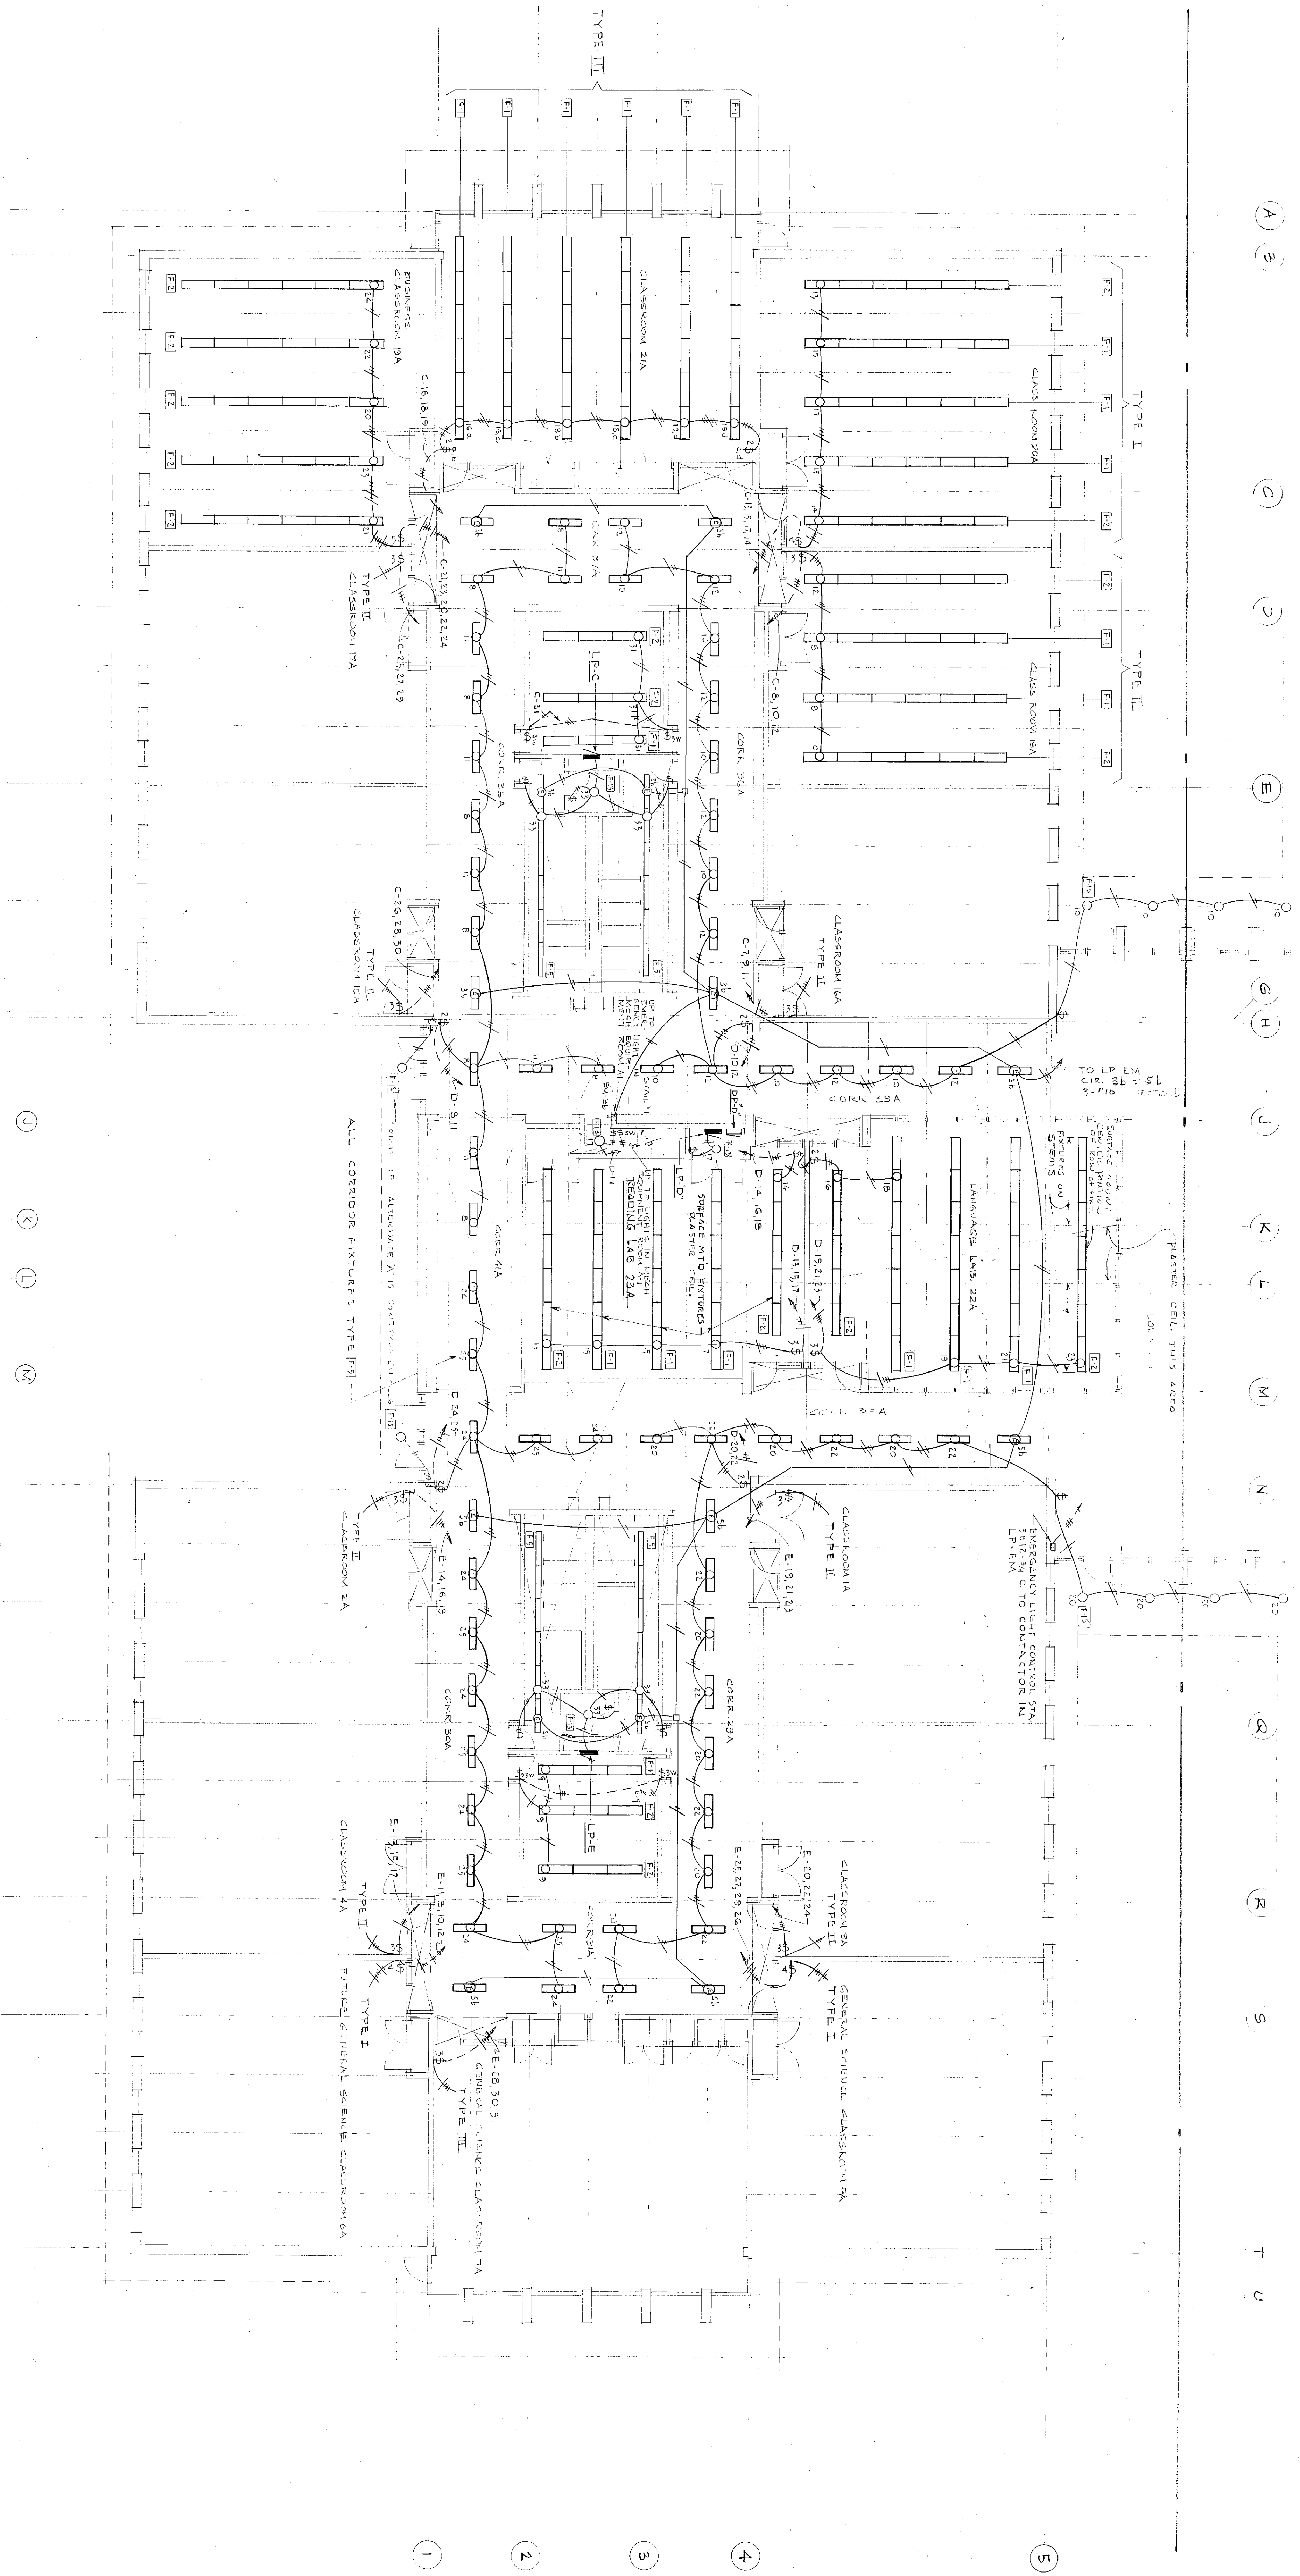

PENTHOUSE MECHANICAL EQUIPMENT ROOM PLAN
UNIT A - (EAST)
SCALE 1/8" = 1'-0"

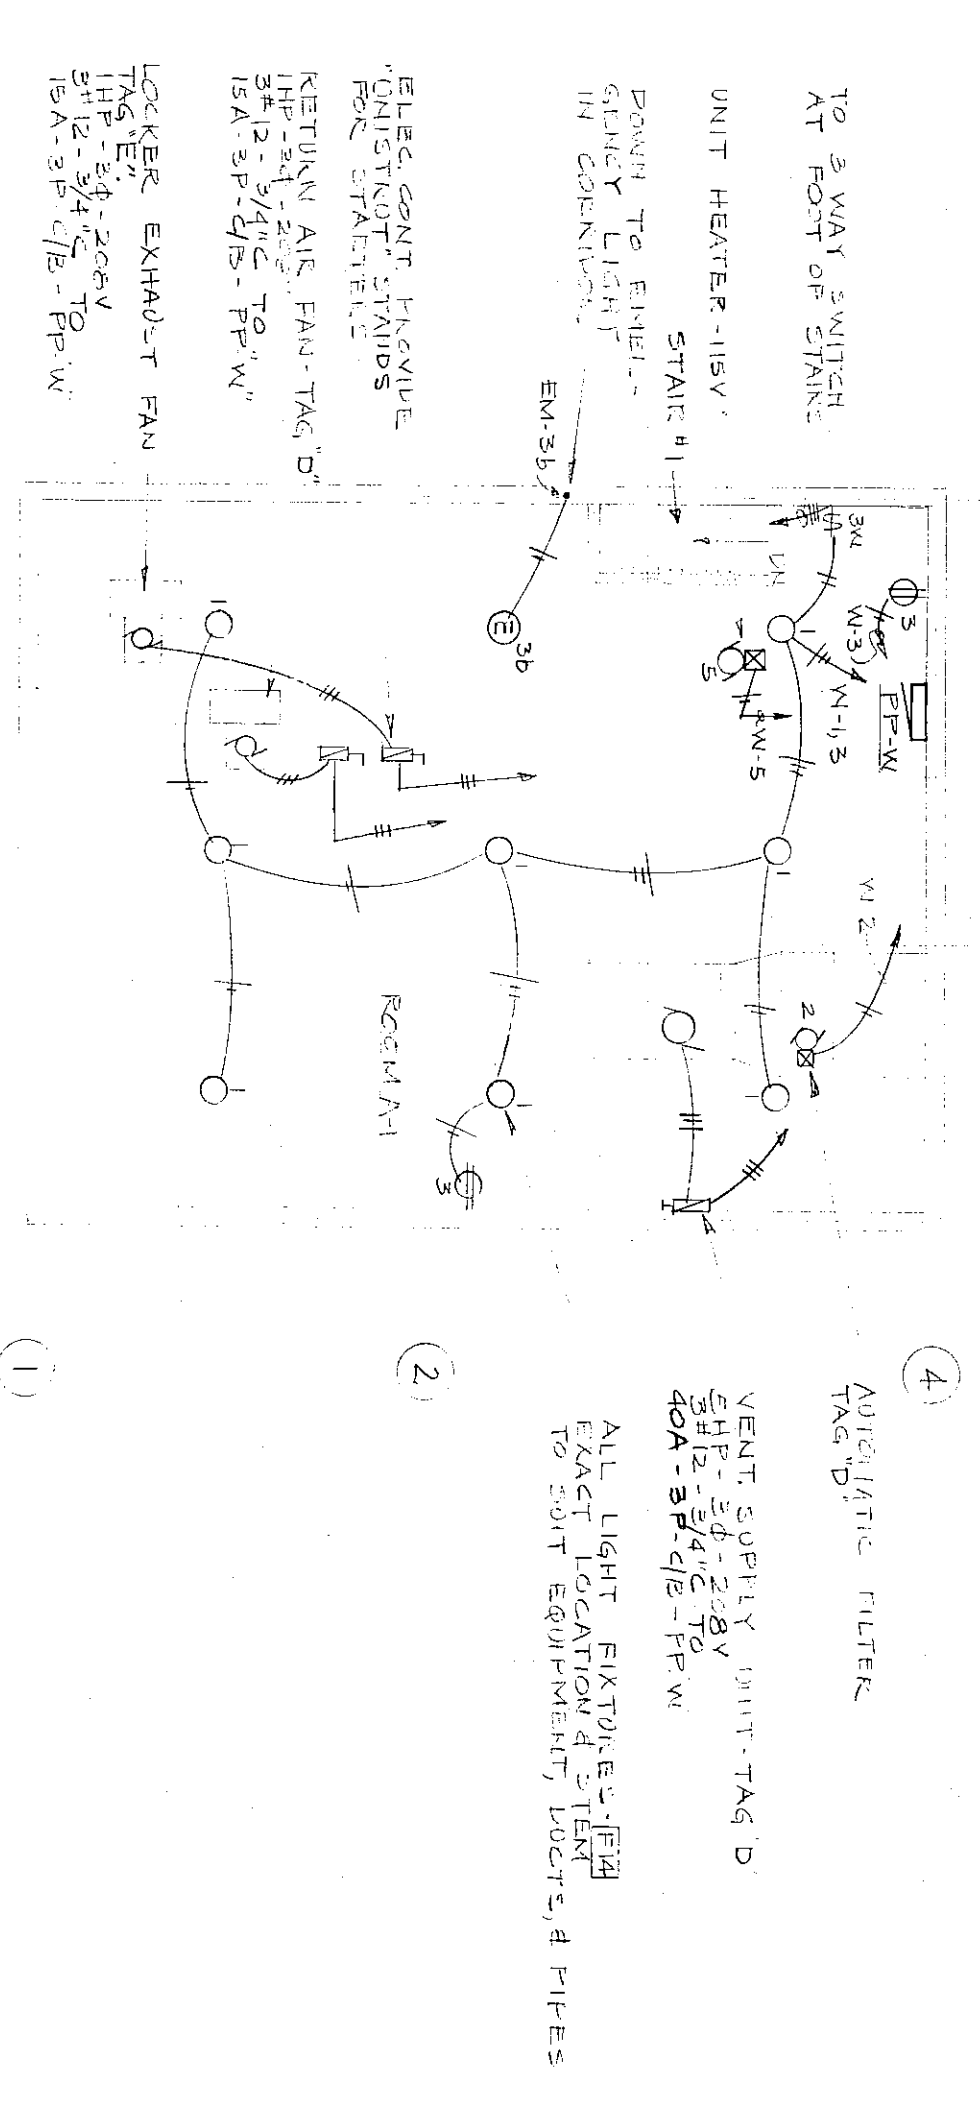

FLOOR PLAN - UNIT A
SCALE 1/8" = 1'-0"

ELECTRICAL

DATE: 6-21-65
PROJECT NO: 2169-3
DRAWN BY: SCHARRES & ASSOCIATES
CHECKED BY: SCHARRES & ASSOCIATES
NOTED BY: SCHARRES & ASSOCIATES
NOTED BY: SCHARRES & ASSOCIATES

ARCHITECTS
SCHARRES & ASSOCIATES
109 WEST JEFFERSON AVENUE
CHICAGO, ILLINOIS 60604
PHONE: 312-427-9300

LIGHTING PLAN
UNIT A -
EAST MECH-
ANICAL EQUIP-
MENT ROOM
PLAN.

WESTCHESTER
TOWNSHIP
JUNIOR HIGH
SCHOOL
FIFTH STREET
CHESTER, INDIANA
FOR THE
WESTCHESTER TOWNSHIP
SCHOOL BUILDING CORP.

NO.	REVISION	DATE
1	AS SHOWN	6/21/65
2	REVISION	6/21/65

NO.	REVISION	DATE
1	AS SHOWN	6/21/65
2	REVISION	6/21/65

