


TO LIVING ROOM
SEE SHEET E-11
SECTION 1

ROLL 1/4" SCALE PLAN
SEE SHEET E-11

SEE SHEET E-11 FOR
EQUIPMENT WIRING
LIGHTS IN JACO BY EQUIP
CONTRACTOR SEE SHEET E-11

FLOOR PLAN UNIT E
SCALE 1/4" = 1'-0"

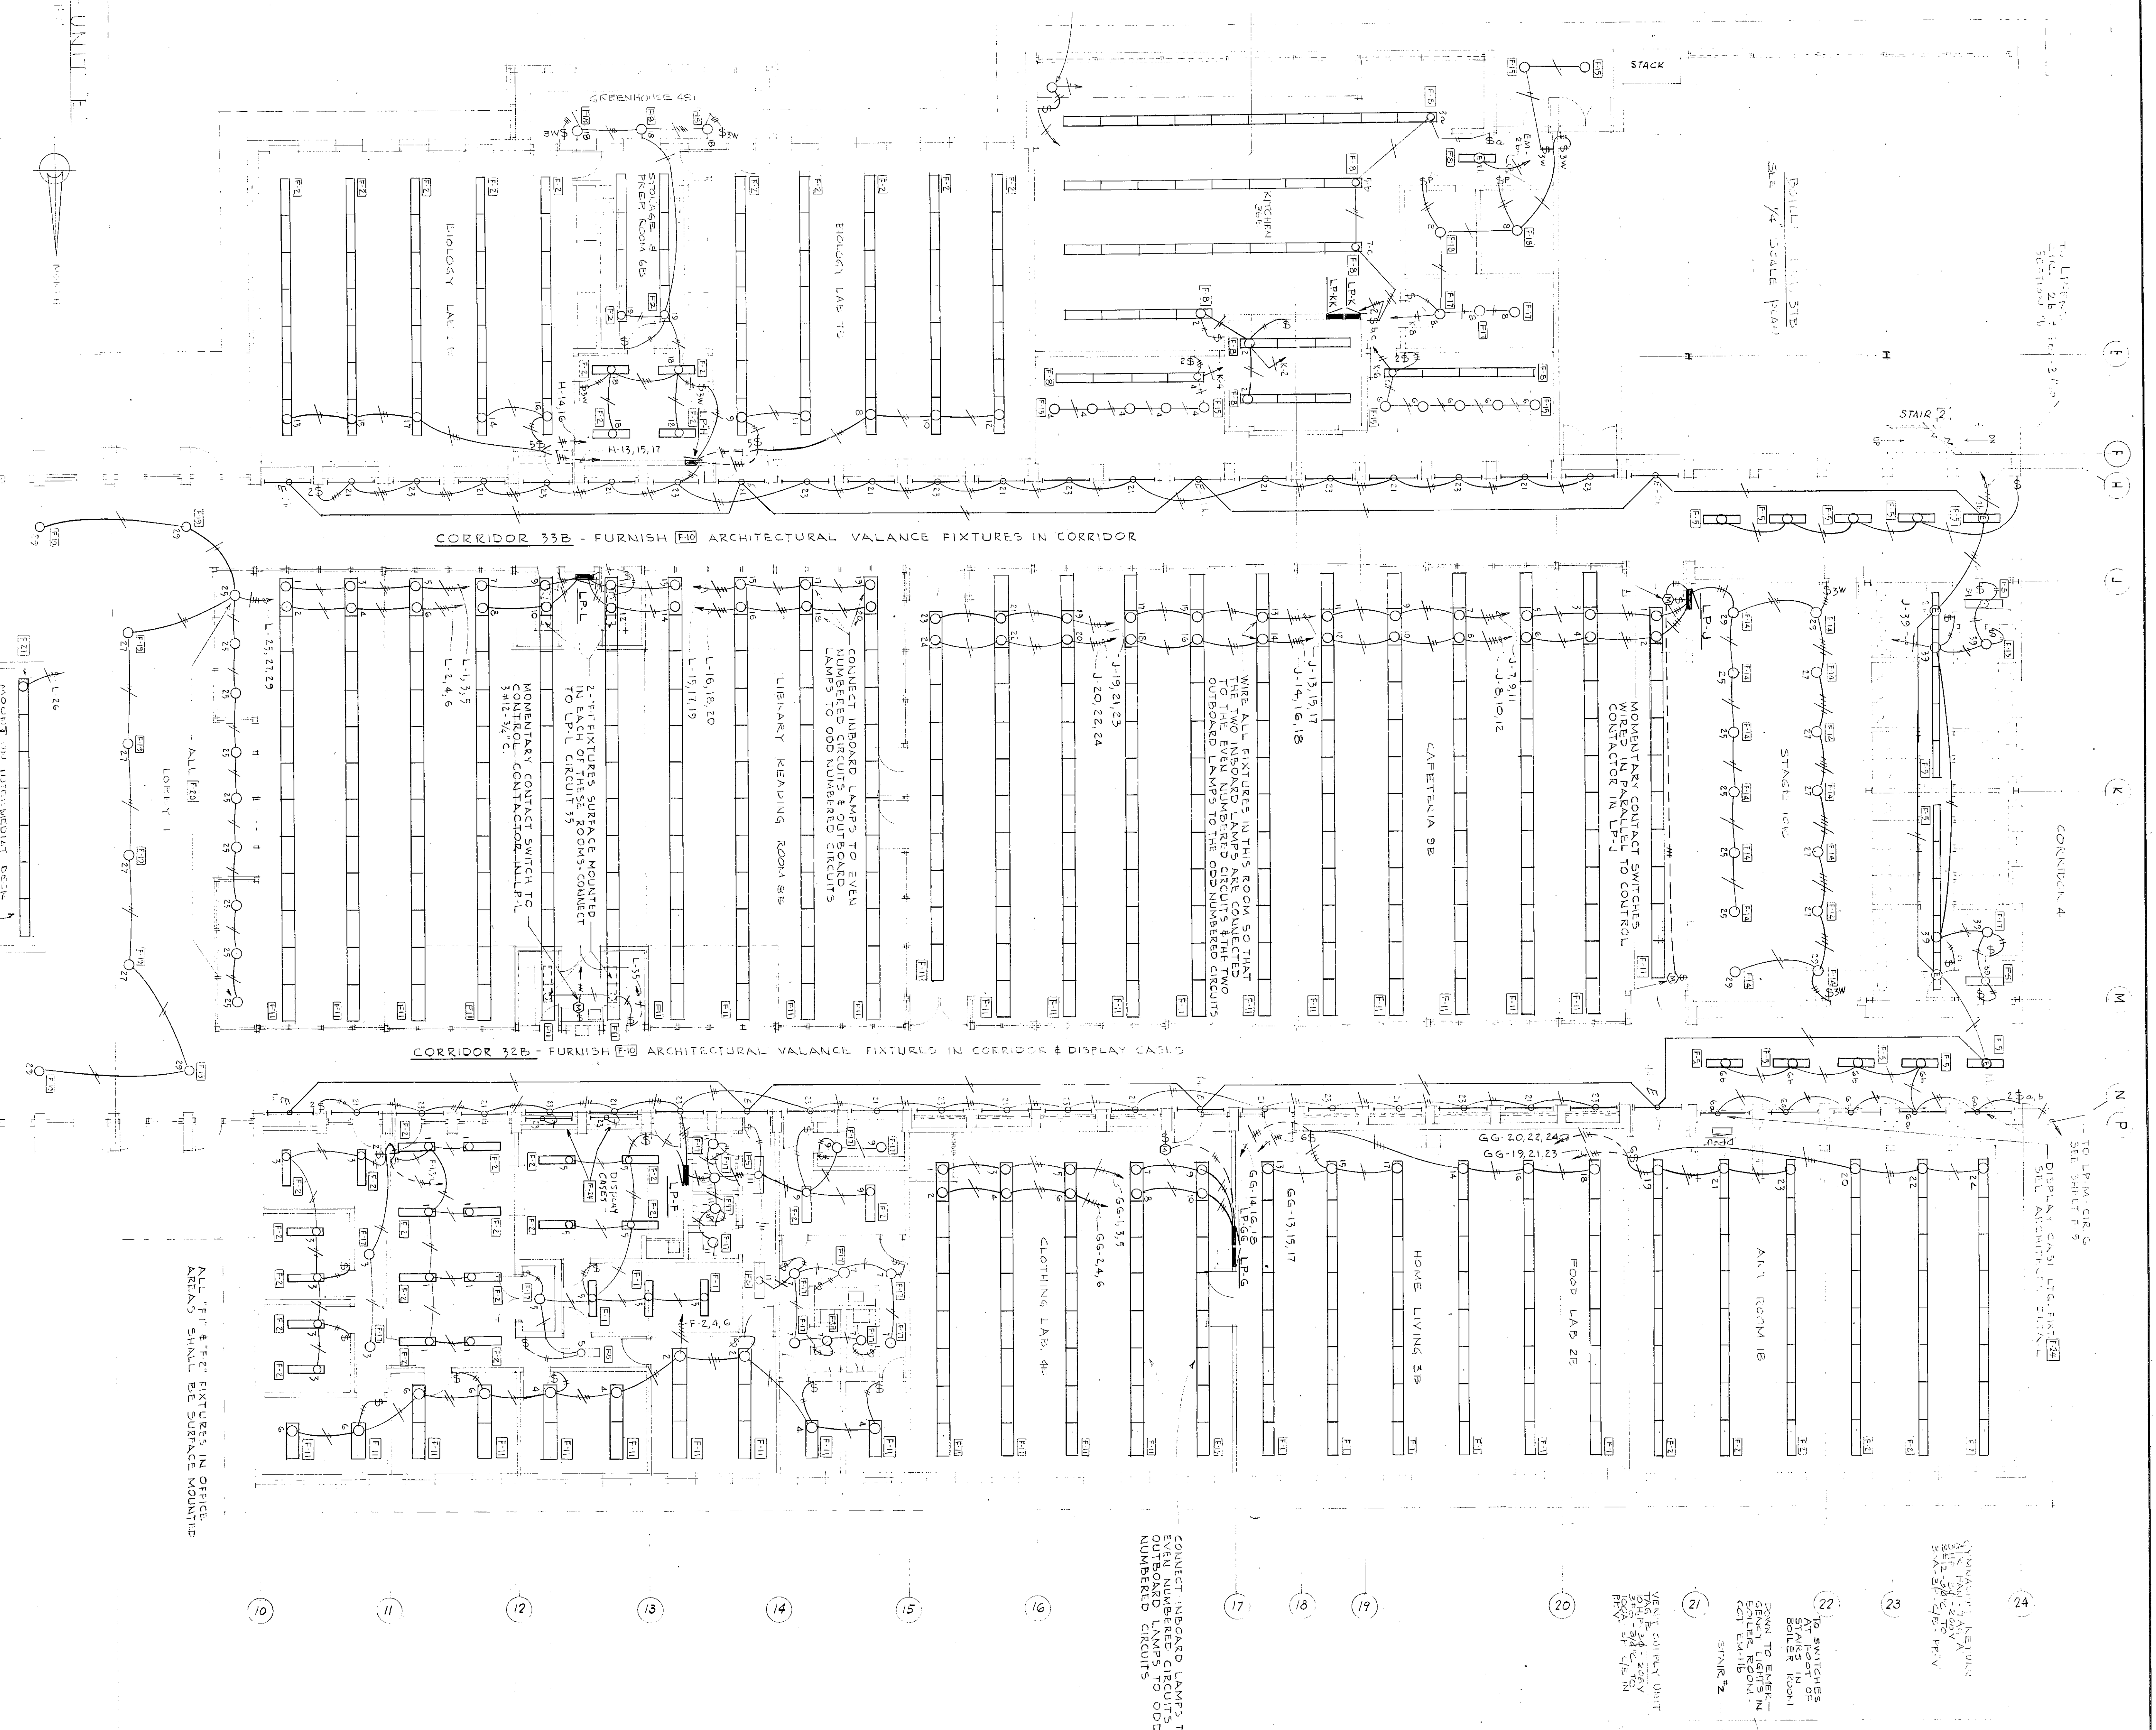


TO LIVING ROOM
SEE SHEET E-11
SECTION 1

CONNECT INBOARD LAMP TO
EVEN NUMBERED CIRCUITS &
OUTBOARD LAMP TO ODD
NUMBERED CIRCUITS

ALL "T" & "F" FIXTURES IN OFFICE
AREAS SHALL BE SURFACE MOUNTED

PENTHOUSE MECHANICAL EQUIPMENT ROOM PLAN
WEST
SCALE 1/8" = 1'-0"

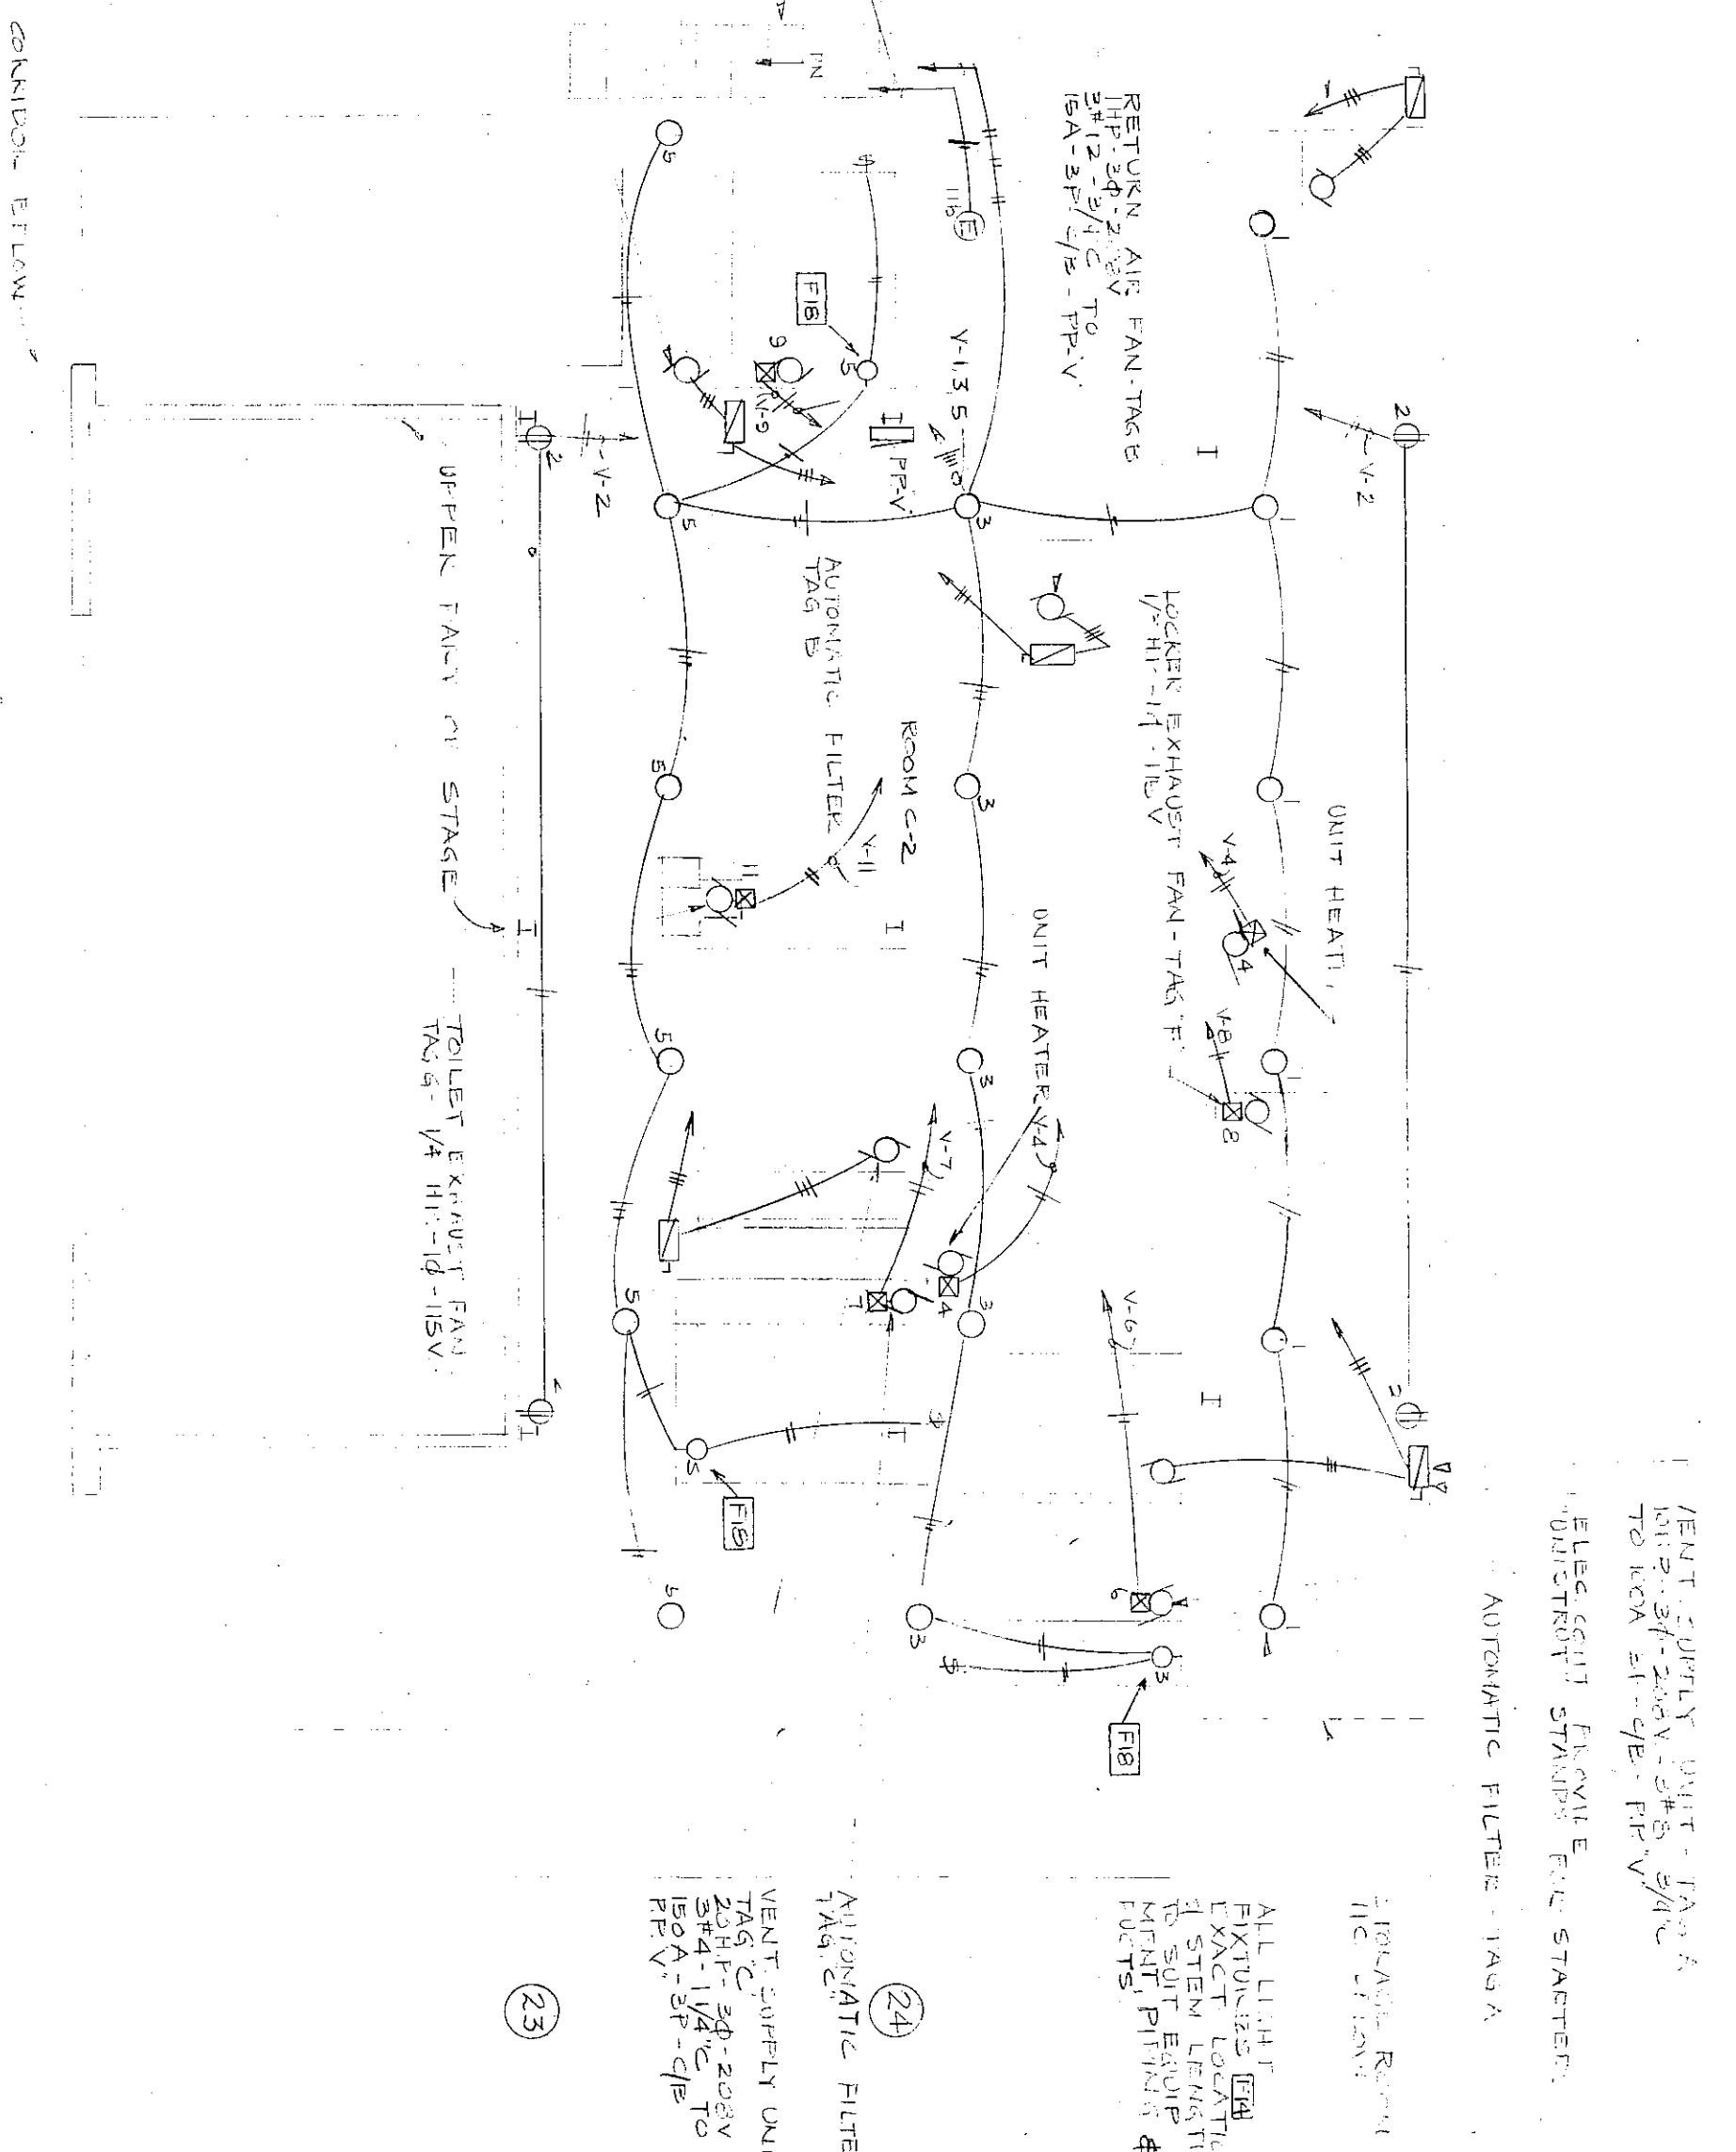

VENT SUPPLY DUCT
TO BOILER ROOM
SEE SHEET E-11
SECTION 1

VENT SUPPLY DUCT
TO BOILER ROOM
SEE SHEET E-11
SECTION 1

SCHARRS & ASSOCIATES
CONSULTING ENGINEERS
RIVERSIDE PLAZA
CHICAGO, ILLINOIS

WESTCHESTER TOWNSHIP JUNIOR HIGH SCHOOL FIFTH STREET CHESTER, INDIANA FOR THE WESTCHESTER TOWNSHIP SCHOOL BUILDING CORP.		LIGHTING PLAN UNIT B, MECH. ANICAL EQUIP MENT ROOM PLAN.		ELECTRICAL PROJECT NO. 621245 DRAWN BY: J. W. WILKINS CHECKED BY: J. W. WILKINS DATE: 10/1/54 BY: J. W. WILKINS		THE PERKINS ARCHITECTS 100 WEST JACKSON ROAD CHICAGO, ILLINOIS 4 PHONE: 312-427-9800		NO. 1000 DATE: 10/1/54 BY: J. W. WILKINS CHECKED BY: J. W. WILKINS DATE: 10/1/54 BY: J. W. WILKINS	
---	--	--	--	--	--	---	--	---	--