



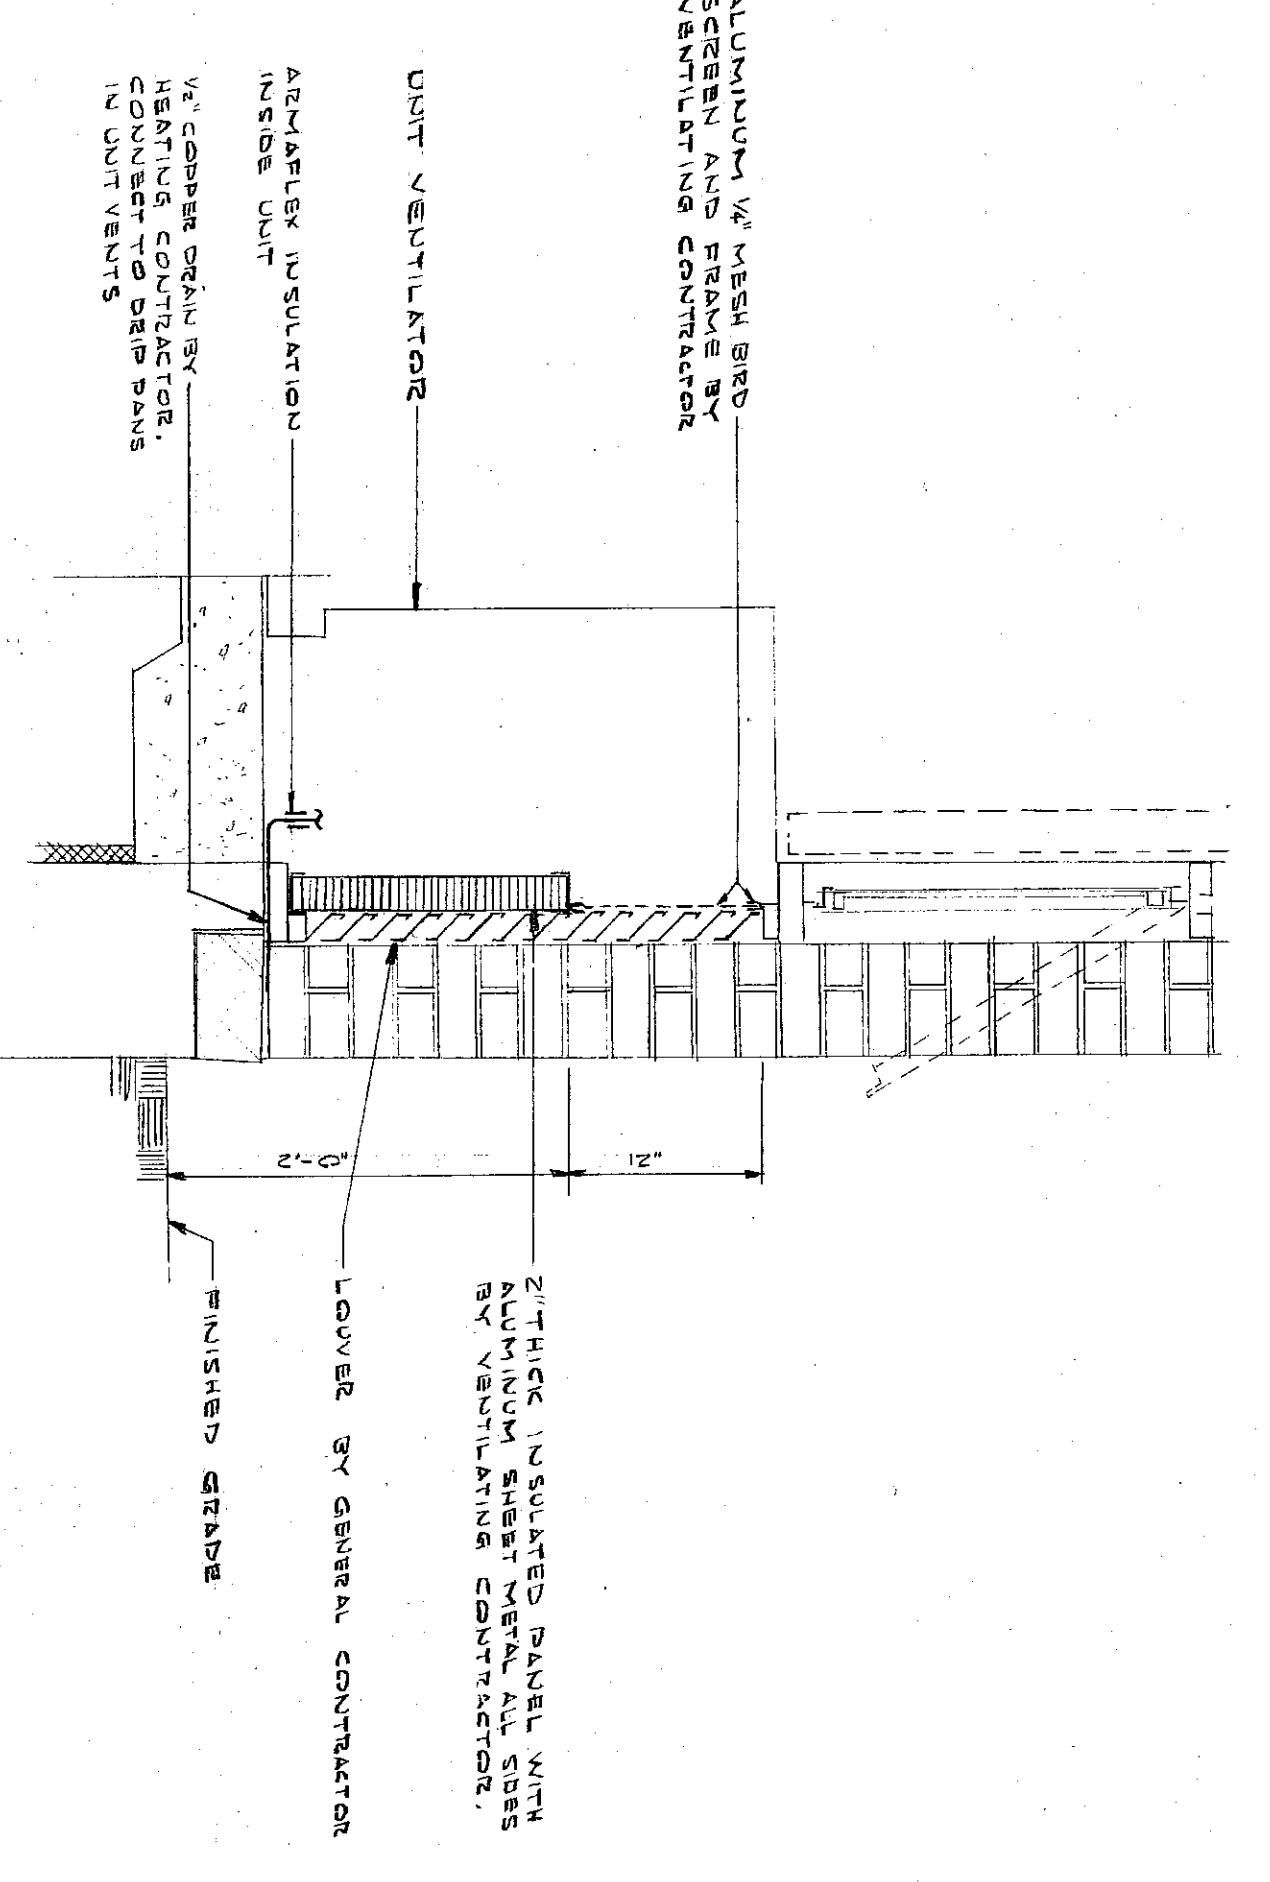


B-M-I
B-M-I
B-M-I


FLOOR PLAN - UNIT - A

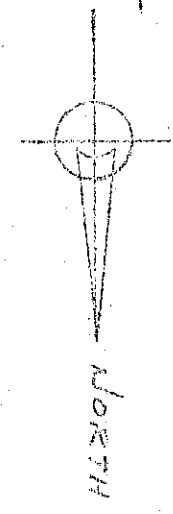

SECTION B
TYPICAL SECTION THRU
UNIT VENTILATOR WALL
SCALE 1/4" = 1'-0"

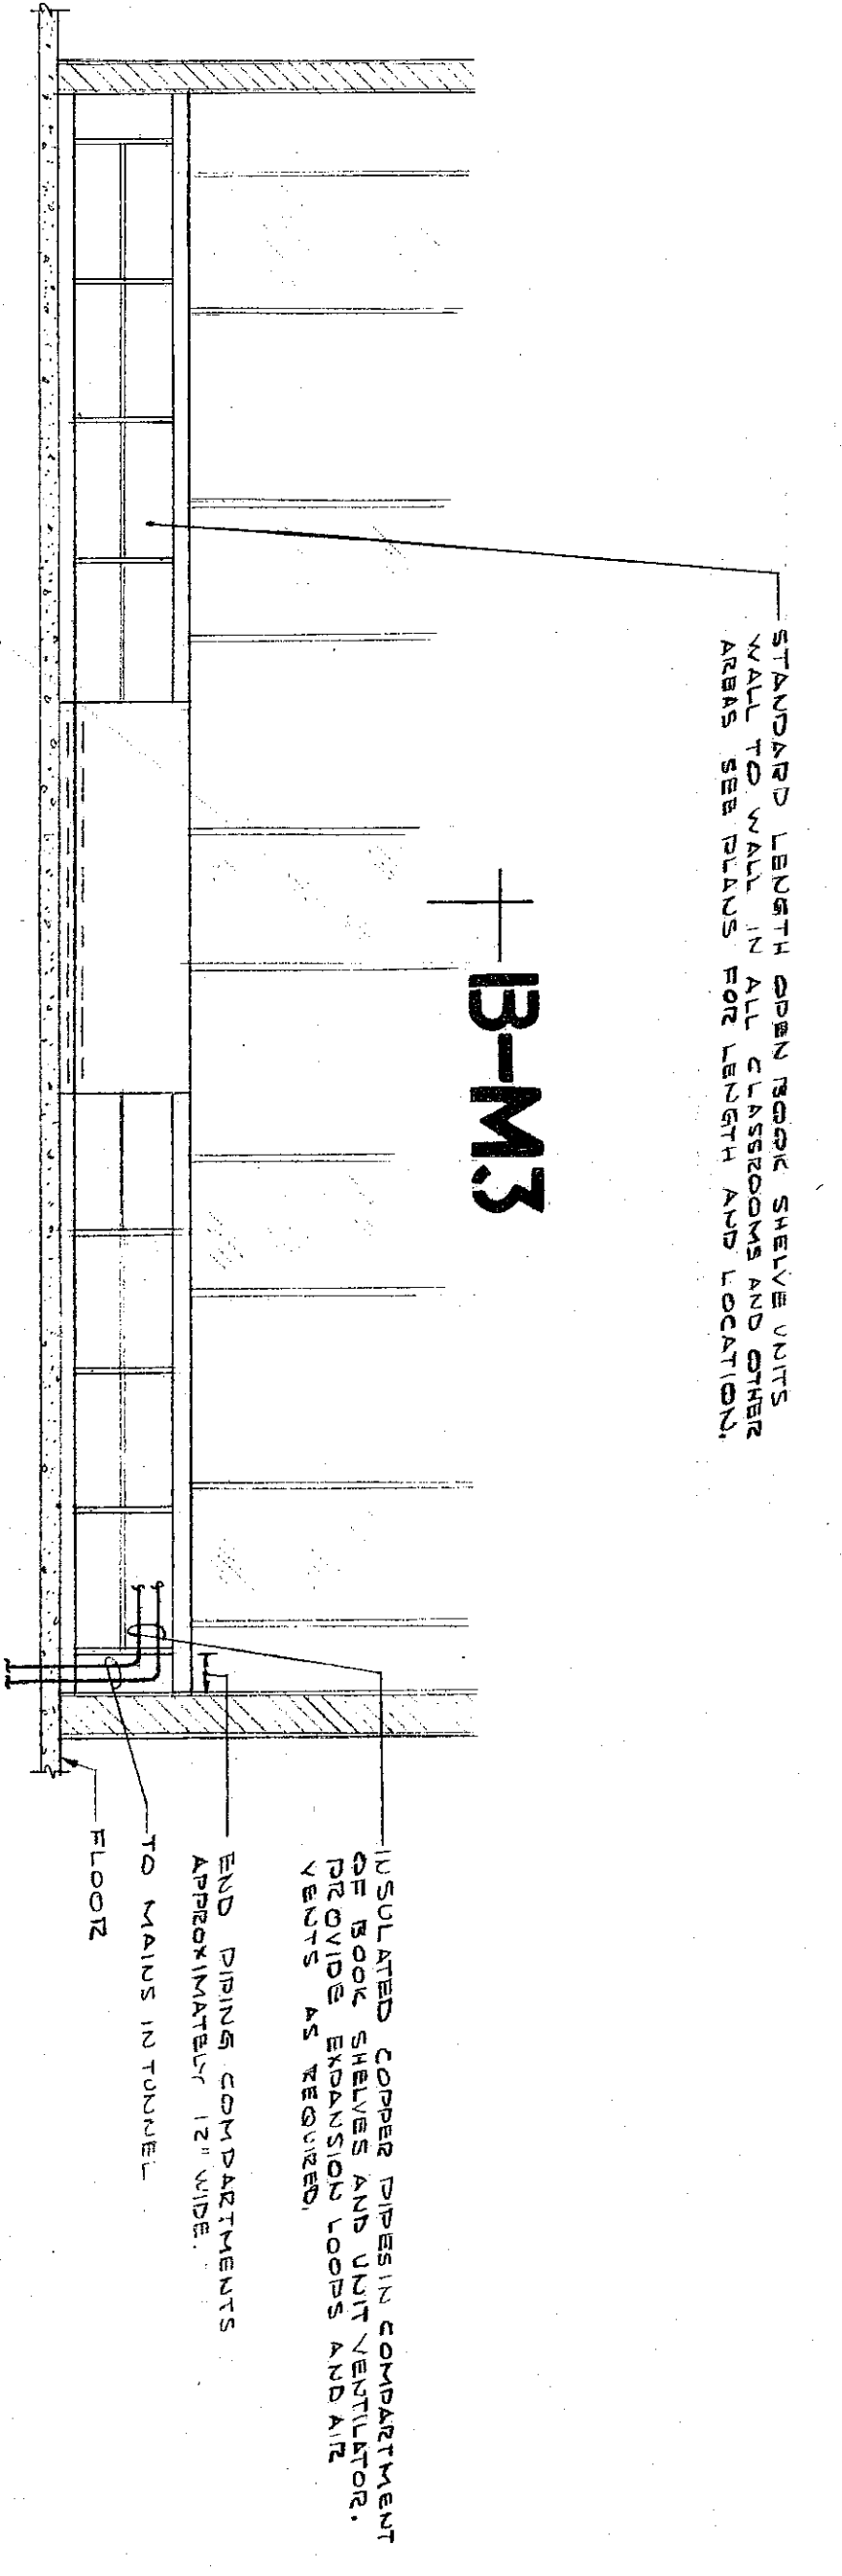

SECTION A
TYPICAL SECTION OF ALL CLASSROOM
UNIT VENTILATORS AND CABINETS
SCALE 3/4" = 1'-0"

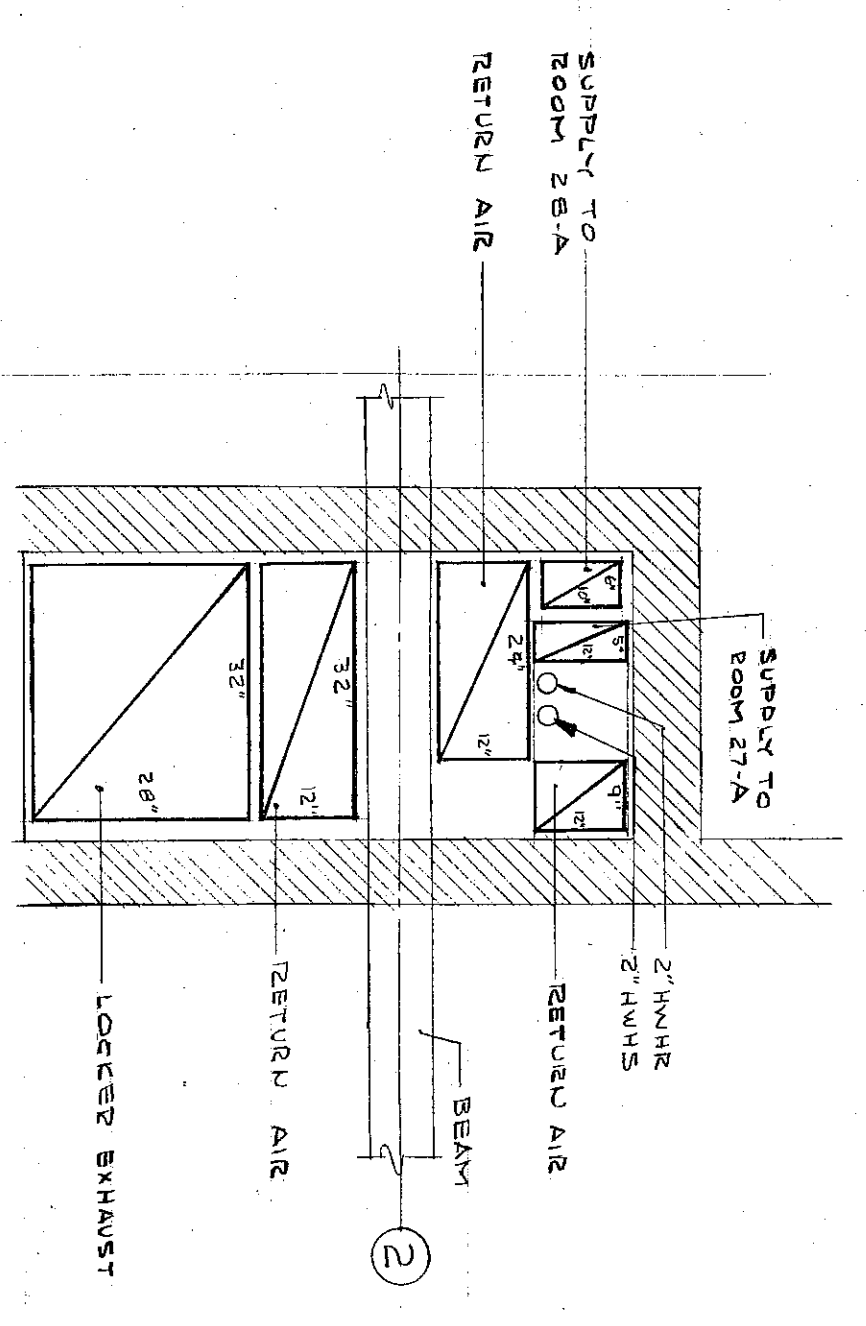

DETAIL A
SCALE 3/4" = 1'-0"

SCHARRES & ASSOCIATES
CONSULTING ENGINEERS
RIVERSIDE PLAZA CHICAGO, ILLINOIS

THE
Perkins
Erwin
ARCHITECTS
300 WEST JACKSON
CHICAGO, ILLINOIS 60604
PHONE 312-427-3300

PROJECT NO. 21700-2
DRAWN BY: E. W. SCHARRES
CHECKED BY: J. SCHARRES
DATE: 10/1/68

M3

MECHANICAL

FLOOR PLAN
UNIT "A"

WESTCHESTER TOWNSHIP JUNIOR HIGH SCHOOL
FIFTH STREET
CHESTER, INDIANA
FOR THE
WESTCHESTER TOWNSHIP
SCHOOL BUILDING CORP.

NO.	REVISION	DATE
1	GENERAL	10/1/68
2	PLUMBING	10/1/68

NO.	REVISION	DATE
1	GENERAL	10/1/68
2	PLUMBING	10/1/68