


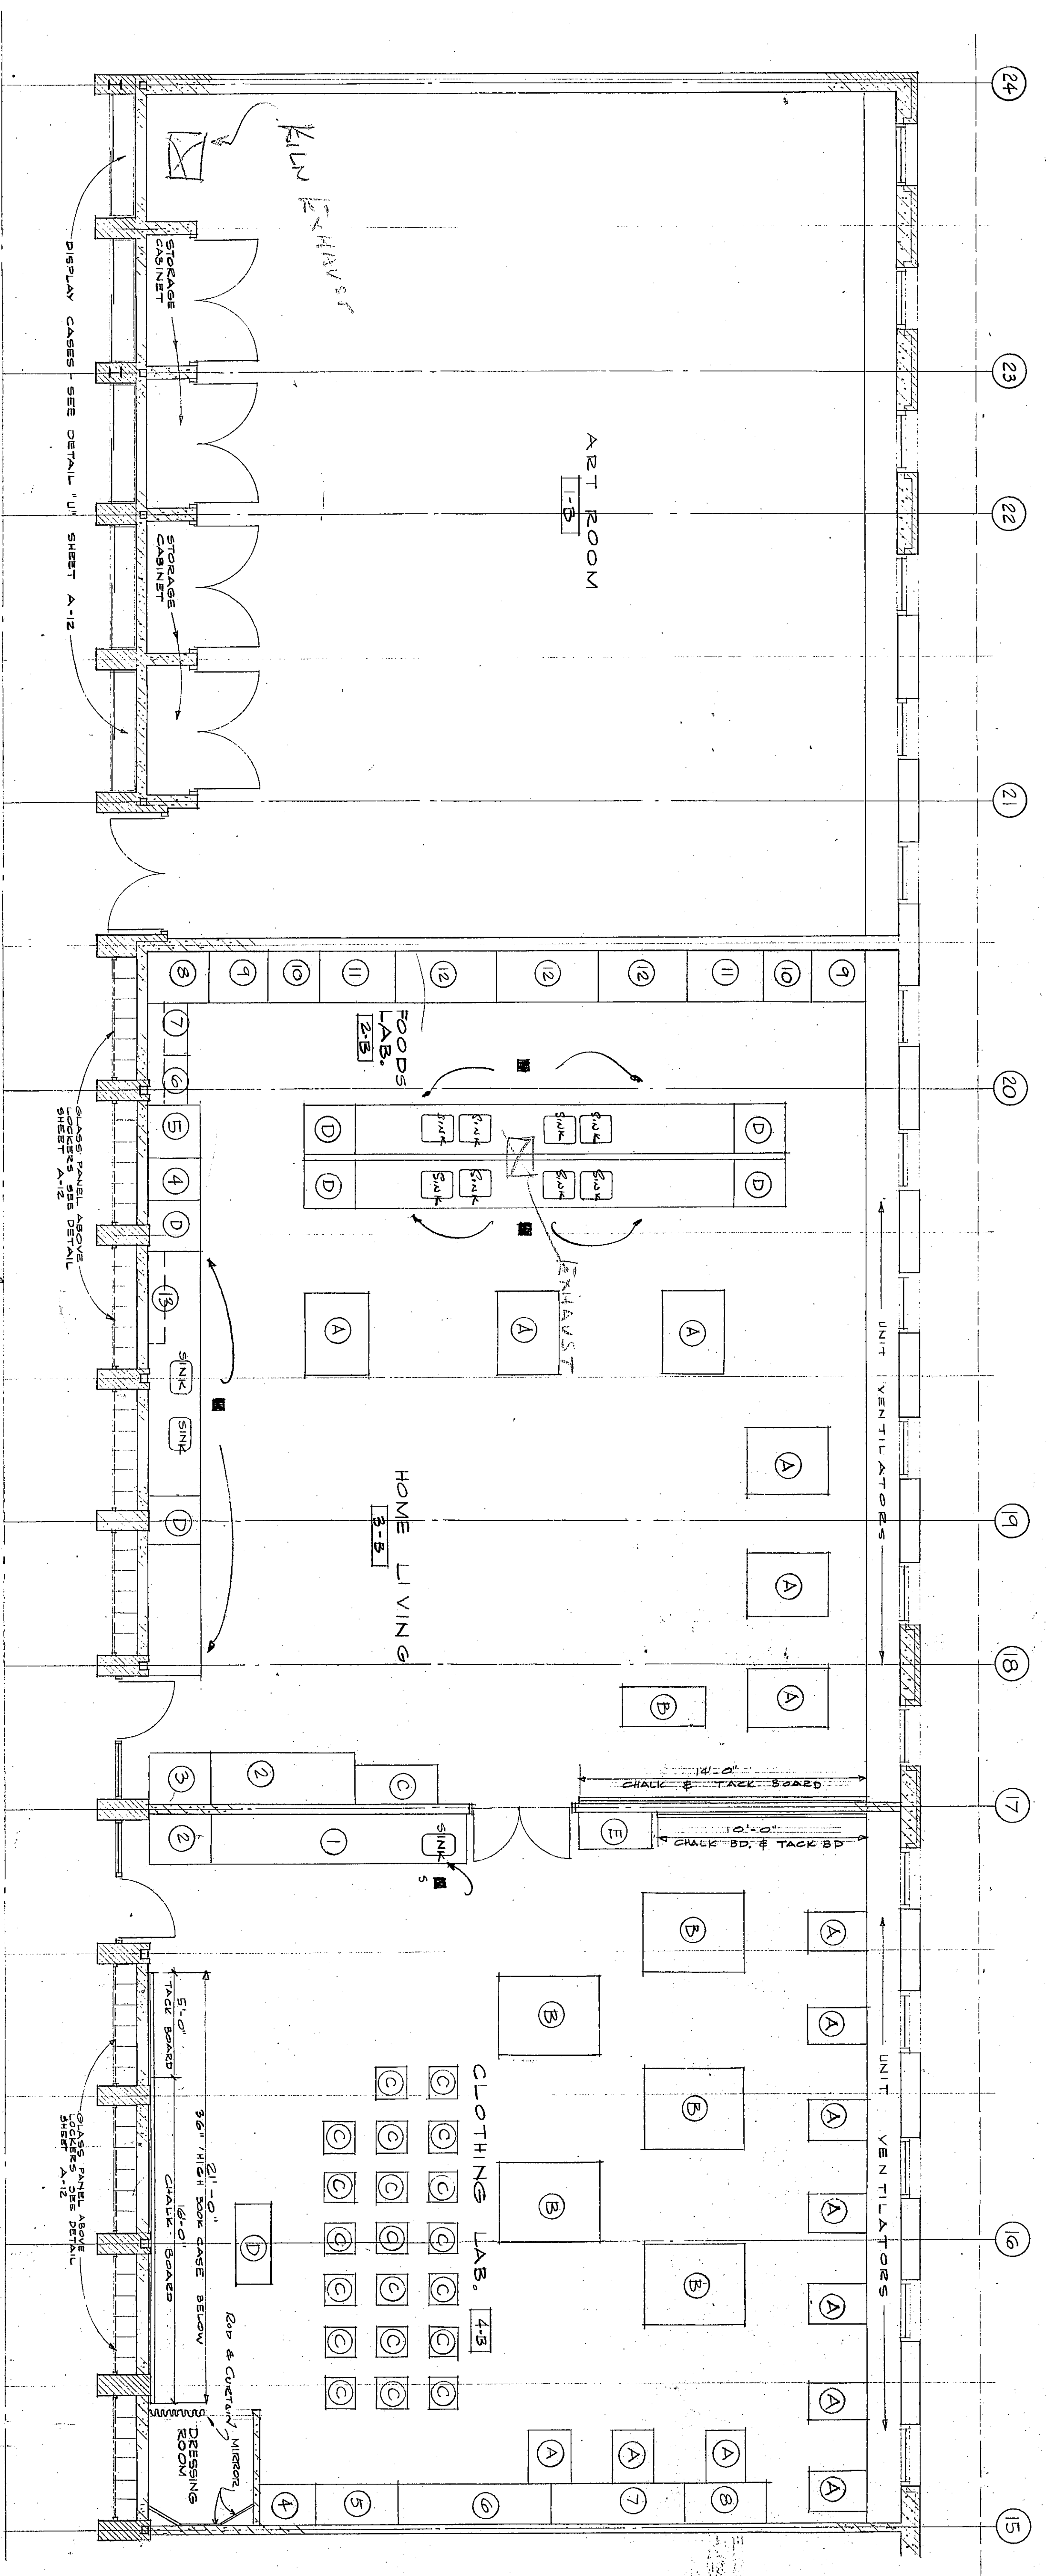

FLOOR PLAN ART ROOM 1-B

FLOOR PLAN FOODS LAB 2-B & HOME LIVING 3-B

FLOOR PLAN CLOTHING LAB 4-B

- LEGEND
- 1. FILE DRAWER
 - 2. BOOK BIN
 - 3. TEACHERS WARDROBE
 - 4. SEWING OVER TABLE W/ WHEELS
 - 5. SEWING MACHINE
 - 6. AUTOMATIC WASHER
 - 7. AUTOMATIC DRYER
 - 8. GENERAL STORAGE
 - 9. FOOD STALL STORAGE
 - 10. FOOD STORAGE
 - 11. GENERAL STORAGE
 - 12. WALL CABINETS
 - 13. TABLE & CHAIRS
 - 14. MOBILE DEMONSTRATION
 - 15. ELECTRIC PANNO

- LEGEND
- 1. TOTE TRAYS
 - 2. TEACHERS WARDROBE
 - 3. PRESSING ROOM STORAGE
 - 4. SEWING BOARD STORAGE
 - 5. WARDROBE (3)
 - 6. FILE CABINET (2)
 - 7. GEN. STORAGE
 - 8. SEWING MACHINE
 - 9. CHAIR W/ ONE ARM (20)
 - 10. TEACHERS DESK W/ BUILT-IN SEWING MACH. (SINGLE END)
 - 11. MOBILE DEN. TABLE W/ MIRROR

GENERAL NOTE

1. ■ INDICATES EQUIPMENT IN BASE B/D.

2. ● INDICATES EQUIPMENT AS SHOWN IN THIS SHEET. NOTE: NO EQUIP. AS SHOWN IN THIS SHEET.

3. ALL OTHER EQUIP. LISTED IN THIS SHEET AS PURCHASED BY OWNER.

NO.	OWNER'S DESCRIPTION	QTY.	DATE
1	OFFICE	50	4/4
2	OFFICE	50	4/4
3	OFFICE	50	4/4
4	OFFICE	50	4/4
5	OFFICE	50	4/4
6	OFFICE	50	4/4
7	OFFICE	50	4/4
8	OFFICE	50	4/4
9	OFFICE	50	4/4
10	OFFICE	50	4/4
11	OFFICE	50	4/4

NO.	REMARKS	TIME	BY	DATE
1				
2				
3				
4				
5				
6				
7				
8				
9				
10				

WESTCHESTER TOWNSHIP JUNIOR HIGH SCHOOL

FIFTH STREET
CHESTER, INDIANA

FOR THE
WESTCHESTER TOWNSHIP
SCHOOL BUILDING COM.

THE PERKINS ARCHITECTS

100 WEST JACKSON BLVD.
CHICAGO, ILL. 60604
PHONE 312-427-9200

EQUIPMENT

DATE: 6-21-66
PROJECT NO: 20691-B
CHECKED BY: J. PERKINS
DRAWN BY: J. PERKINS
APP. NO. 03

