


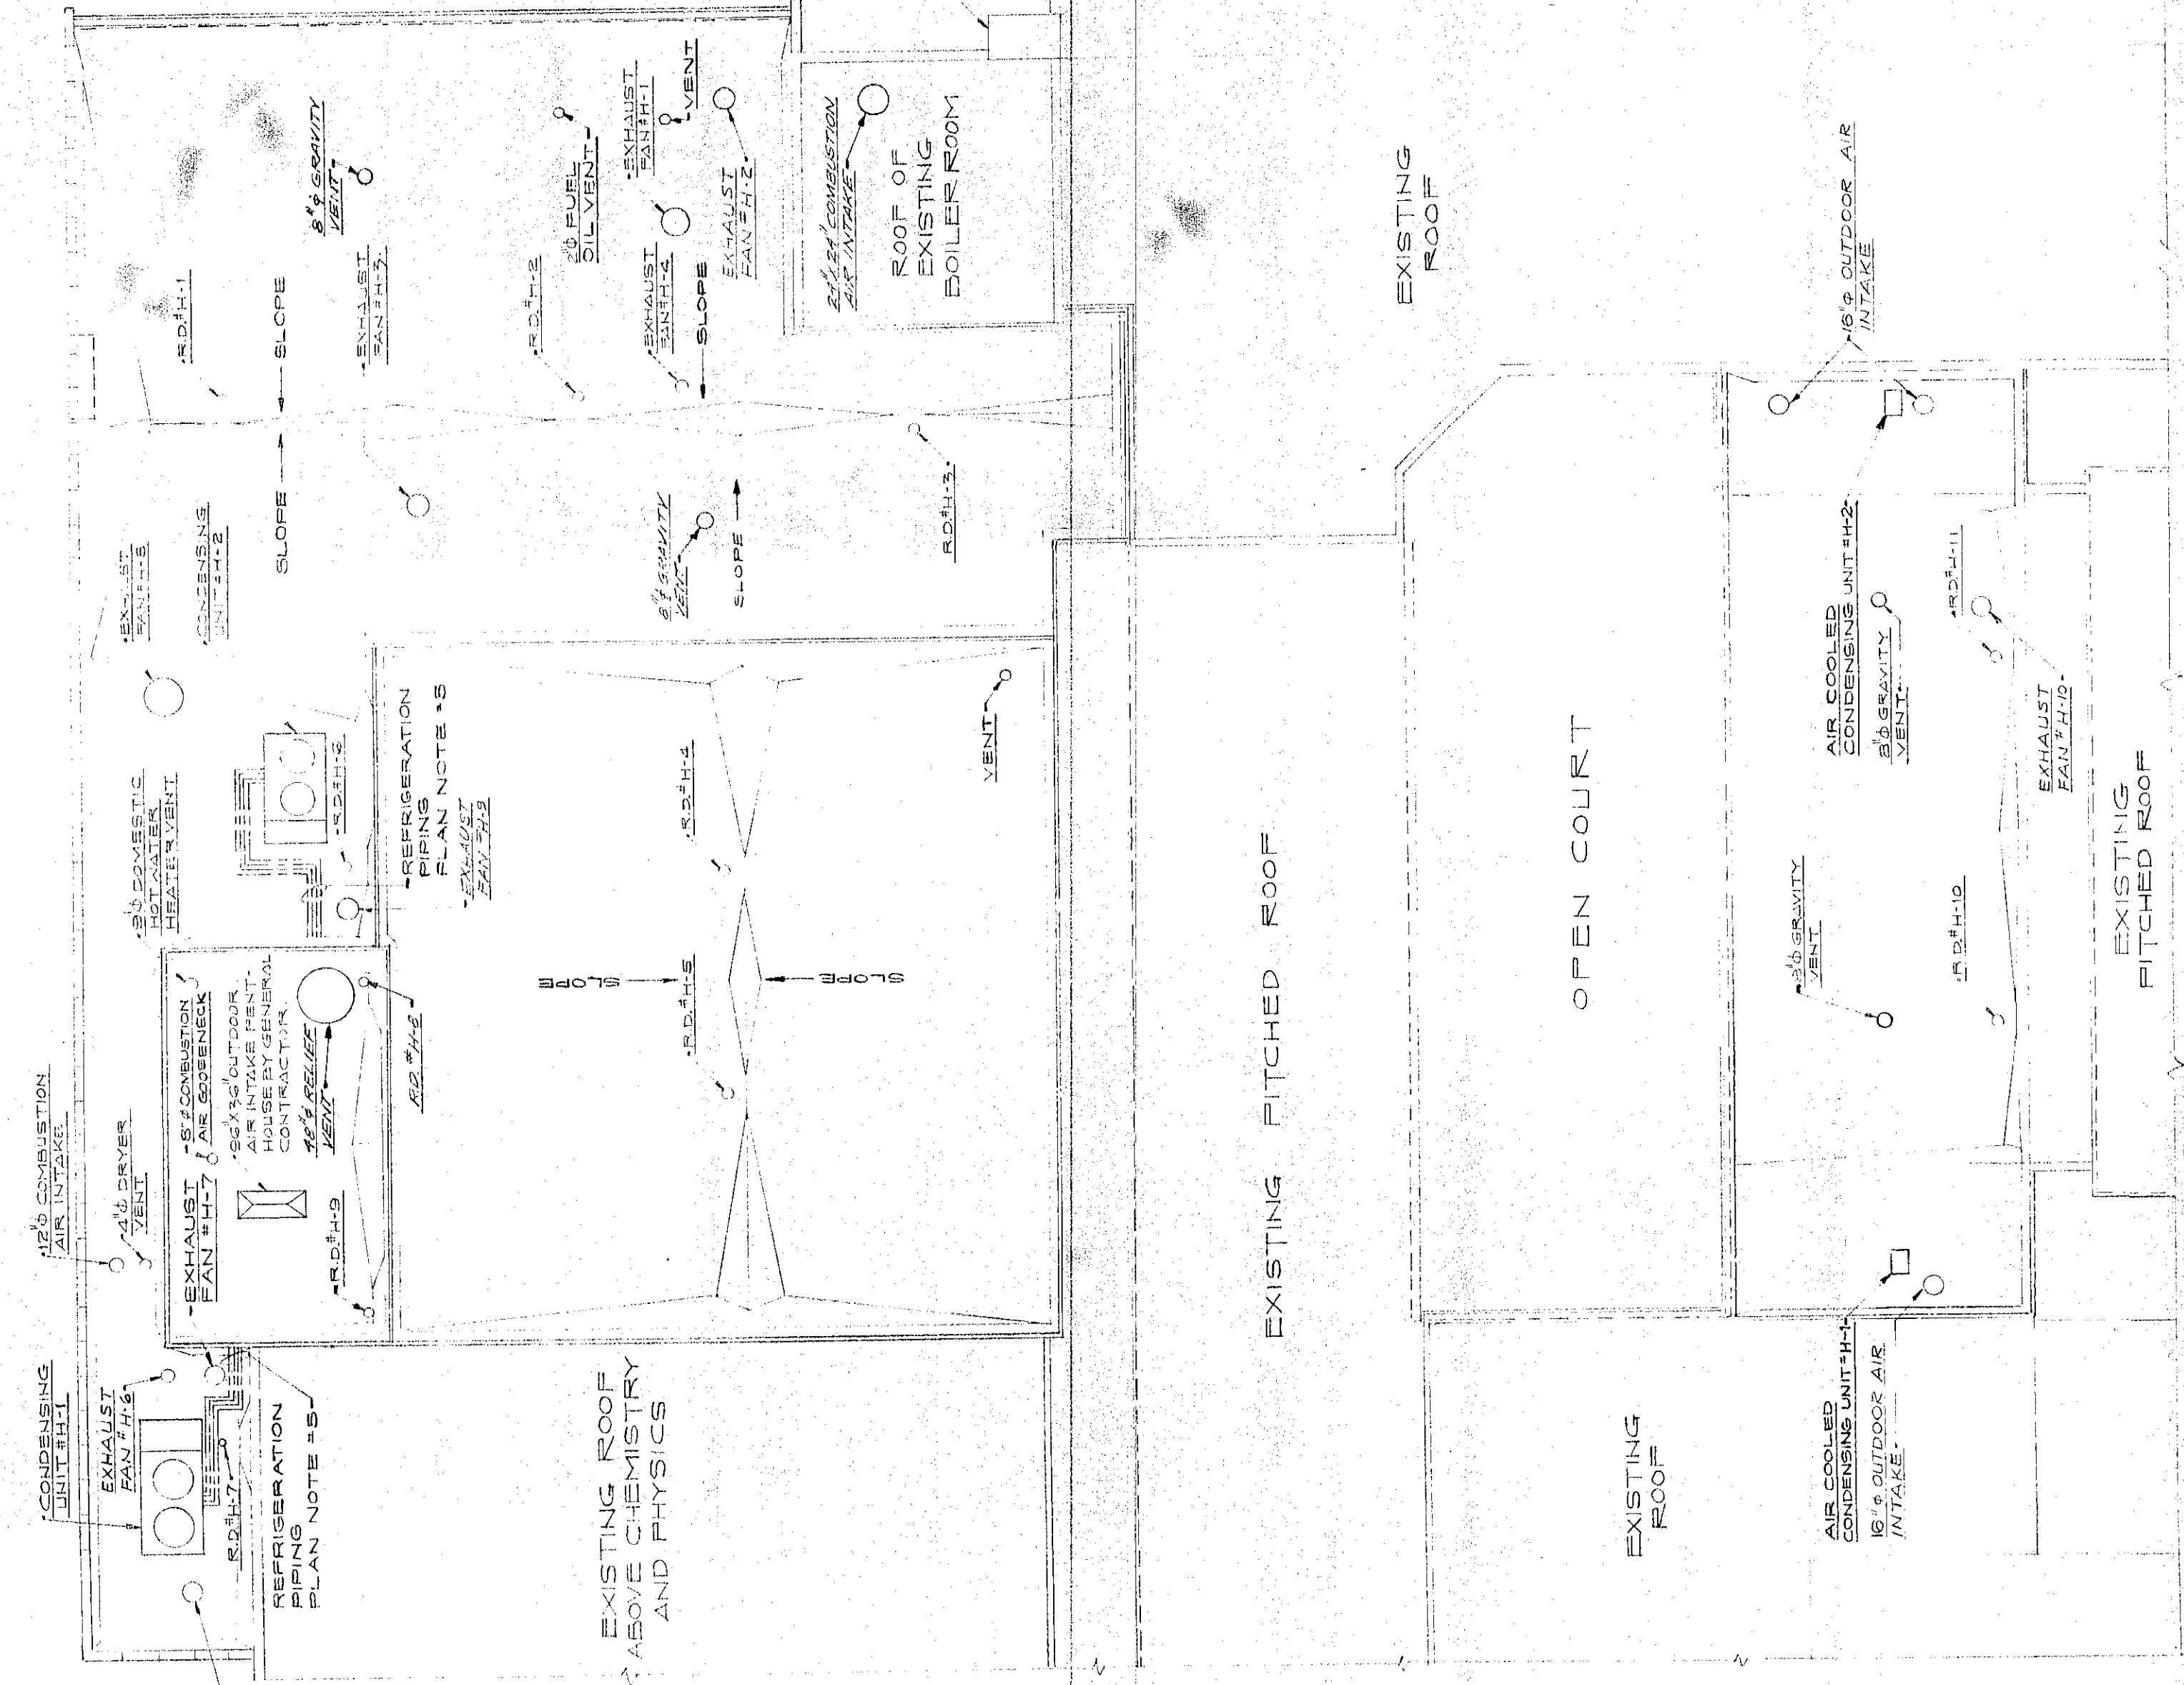

ROOF PLAN
SCALE: 1/8" = 1'-0"

EXHAUST FAN SCHEDULE									
NO.	AREA	EXHAUST FAN	TYPE	HP	CFM	SP. FT.	HP	ELECTRICAL	POWER
H-1	EXIST. BOILER ROOM	10" DIA.	1/2"	1/2"	1000	1/2"	1/2"	1/2"	1/2"
H-2	EXIST. BOILER ROOM	10" DIA.	1/2"	1/2"	1000	1/2"	1/2"	1/2"	1/2"
H-3	EXIST. BOILER ROOM	10" DIA.	1/2"	1/2"	1000	1/2"	1/2"	1/2"	1/2"
H-4	EXIST. BOILER ROOM	10" DIA.	1/2"	1/2"	1000	1/2"	1/2"	1/2"	1/2"
H-5	EXIST. BOILER ROOM	10" DIA.	1/2"	1/2"	1000	1/2"	1/2"	1/2"	1/2"
H-6	EXIST. BOILER ROOM	10" DIA.	1/2"	1/2"	1000	1/2"	1/2"	1/2"	1/2"
H-7	EXIST. BOILER ROOM	10" DIA.	1/2"	1/2"	1000	1/2"	1/2"	1/2"	1/2"
H-8	EXIST. BOILER ROOM	10" DIA.	1/2"	1/2"	1000	1/2"	1/2"	1/2"	1/2"
H-9	EXIST. BOILER ROOM	10" DIA.	1/2"	1/2"	1000	1/2"	1/2"	1/2"	1/2"
H-10	EXIST. BOILER ROOM	10" DIA.	1/2"	1/2"	1000	1/2"	1/2"	1/2"	1/2"

- NOTES:
1. MOTOR DATA: 120 VOLT, 1 PHASE, 60 CYCLE.
 2. INSTALL FAN ON CURB FURNISHED BY THE GENERAL CONTRACTOR (SEE SPECIFICATIONS).
 3. EXHAUST FAN SHALL BE INSTALLED BY THE MECHANICAL CONTRACTOR (SEE SPECIFICATIONS).

ROOF DRAIN SCHEDULE			
NO.	AREA	TYPE	SIZE
R-1	EXIST. BOILER ROOM	1/2"	1/2"
R-2	EXIST. BOILER ROOM	1/2"	1/2"
R-3	EXIST. BOILER ROOM	1/2"	1/2"
R-4	EXIST. BOILER ROOM	1/2"	1/2"
R-5	EXIST. BOILER ROOM	1/2"	1/2"
R-6	EXIST. BOILER ROOM	1/2"	1/2"
R-7	EXIST. BOILER ROOM	1/2"	1/2"
R-8	EXIST. BOILER ROOM	1/2"	1/2"
R-9	EXIST. BOILER ROOM	1/2"	1/2"
R-10	EXIST. BOILER ROOM	1/2"	1/2"

ROOF PLAN NOTES

1. ALL DRAIN NOT OTHERWISE NOTED ARE 1/2" ALUMINUM DRAIN.
2. ALL DRAIN NOTED ON THIS PLAN SHALL BE 1/2" UNDER DIVISION #10 UNLESS OTHERWISE NOTED.
3. DRAIN SHALL BE INSTALLED BY THE MECHANICAL CONTRACTOR (SEE SPECIFICATIONS).
4. 1/2" ROOF DRAIN SHALL BE INSTALLED WITHOUT CONSIDERATION OF ROOF DRAINAGE.
5. REPERATION DRAIN SHALL BE INSTALLED WITHOUT CONSIDERATION OF ROOF DRAINAGE.
6. PROVIDE DRAINAGE FOR ALL ROOF DRAINAGE, AS RECOMMENDED BY THE MECHANICAL CONTRACTOR.

- SITE PLAN NOTES
1. ALL WORK SHOWN ON THIS PLAN SHALL BE 1/2" UNDER DIVISION #10 UNLESS OTHERWISE NOTED.
 2. EXHAUSTION OF DRAINAGE SHALL BE INSTALLED BY THE MECHANICAL CONTRACTOR (SEE SPECIFICATIONS).
 3. DRAINAGE SHALL BE INSTALLED BY THE MECHANICAL CONTRACTOR (SEE SPECIFICATIONS).
 4. DRAINAGE SHALL BE INSTALLED BY THE MECHANICAL CONTRACTOR (SEE SPECIFICATIONS).
 5. DRAINAGE SHALL BE INSTALLED BY THE MECHANICAL CONTRACTOR (SEE SPECIFICATIONS).
 6. DRAINAGE SHALL BE INSTALLED BY THE MECHANICAL CONTRACTOR (SEE SPECIFICATIONS).
 7. DRAINAGE SHALL BE INSTALLED BY THE MECHANICAL CONTRACTOR (SEE SPECIFICATIONS).
 8. DRAINAGE SHALL BE INSTALLED BY THE MECHANICAL CONTRACTOR (SEE SPECIFICATIONS).
 9. DRAINAGE SHALL BE INSTALLED BY THE MECHANICAL CONTRACTOR (SEE SPECIFICATIONS).
 10. DRAINAGE SHALL BE INSTALLED BY THE MECHANICAL CONTRACTOR (SEE SPECIFICATIONS).

MECHANICAL SITE PLAN
SCALE: 1/8" = 1'-0"

