




PLAN NOTES
 1. ALL NEW WORK SHOWN ON THIS SHEET IS NEW UNLESS OTHERWISE NOTED.
 2. EXISTING WORK IS SHOWN ON THE PREVIOUS SHEET.
 3. ALL NEW WORK SHALL BE IN ACCORDANCE WITH THE LATEST EDITIONS OF THE NATIONAL PLUMBING AND MECHANICAL CODES.
 4. ALL NEW WORK SHALL BE IN ACCORDANCE WITH THE LATEST EDITIONS OF THE NATIONAL ELECTRICAL CODE.
 5. ALL NEW WORK SHALL BE IN ACCORDANCE WITH THE LATEST EDITIONS OF THE NATIONAL FIRE PROTECTION ASSOCIATION'S STANDARDS.
 6. ALL NEW WORK SHALL BE IN ACCORDANCE WITH THE LATEST EDITIONS OF THE AMERICAN SOCIETY OF MECHANICAL ENGINEERS' STANDARDS.
 7. ALL NEW WORK SHALL BE IN ACCORDANCE WITH THE LATEST EDITIONS OF THE AMERICAN SOCIETY OF CIVIL ENGINEERS' STANDARDS.
 8. ALL NEW WORK SHALL BE IN ACCORDANCE WITH THE LATEST EDITIONS OF THE AMERICAN SOCIETY OF MECHANICAL ENGINEERS' STANDARDS.
 9. ALL NEW WORK SHALL BE IN ACCORDANCE WITH THE LATEST EDITIONS OF THE AMERICAN SOCIETY OF CIVIL ENGINEERS' STANDARDS.
 10. ALL NEW WORK SHALL BE IN ACCORDANCE WITH THE LATEST EDITIONS OF THE AMERICAN SOCIETY OF MECHANICAL ENGINEERS' STANDARDS.

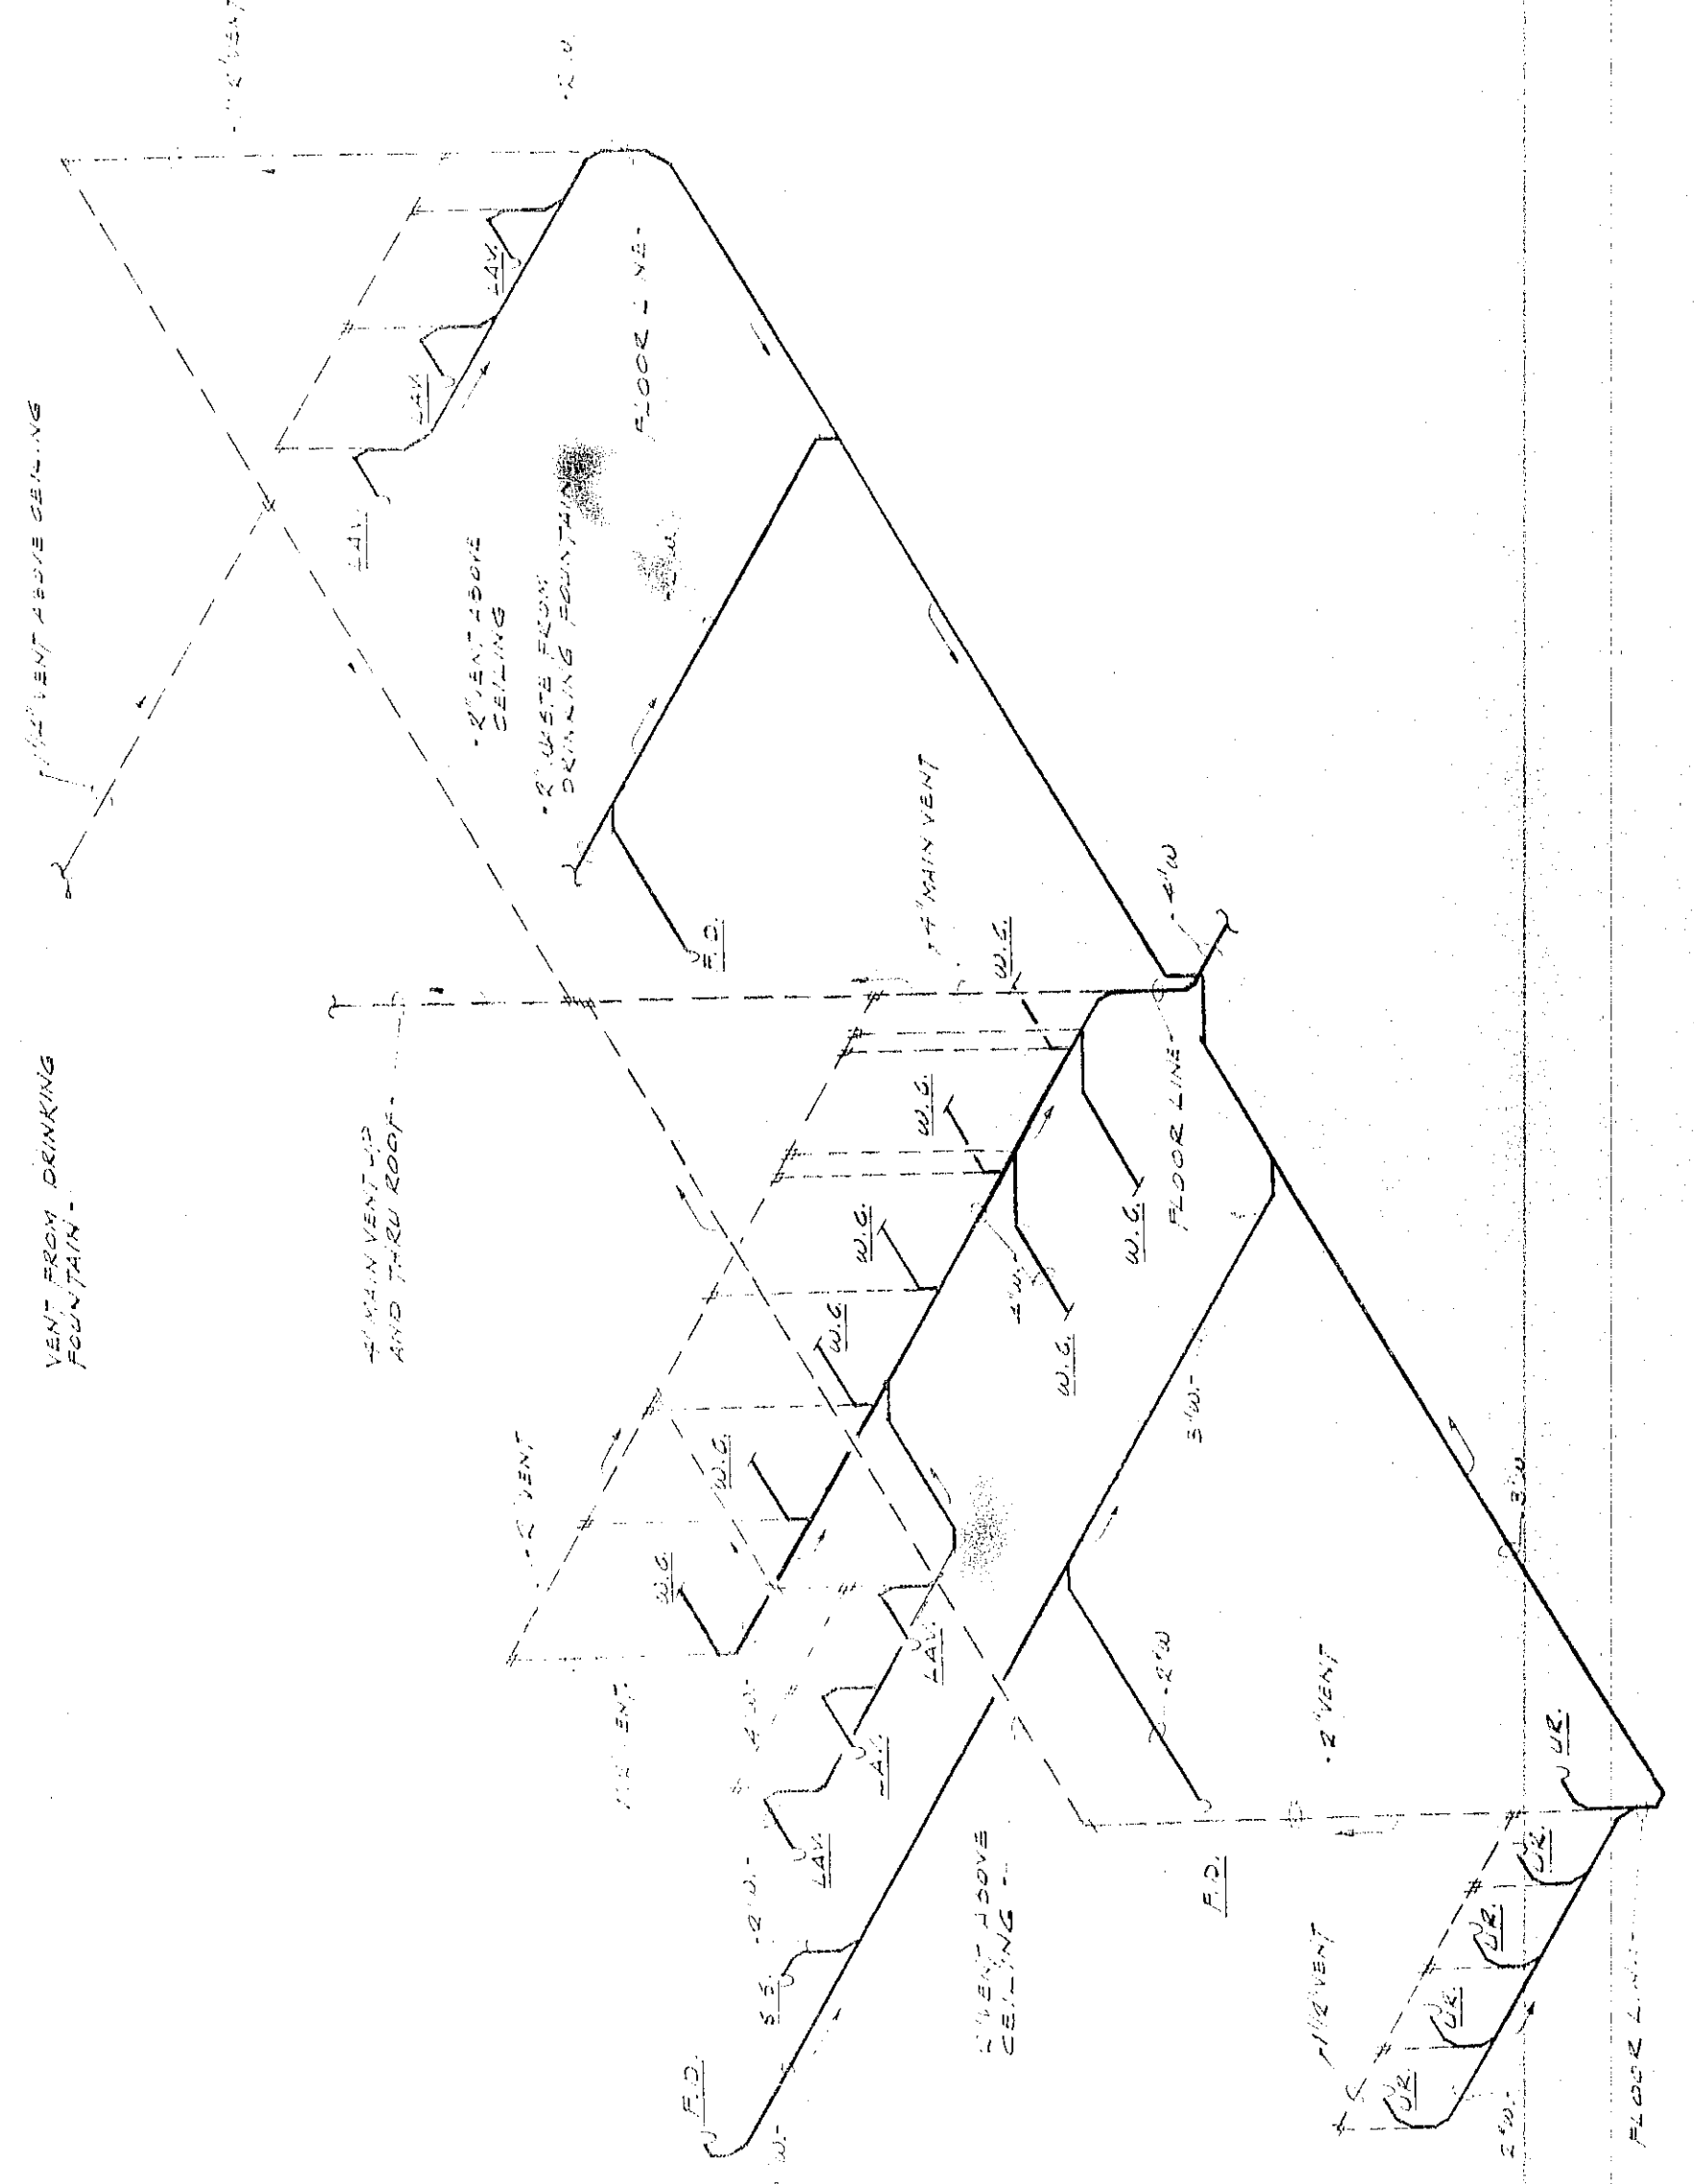


ISOMETRIC FOR GIRLS AND BOYS RESTROOMS
 NO SCALE

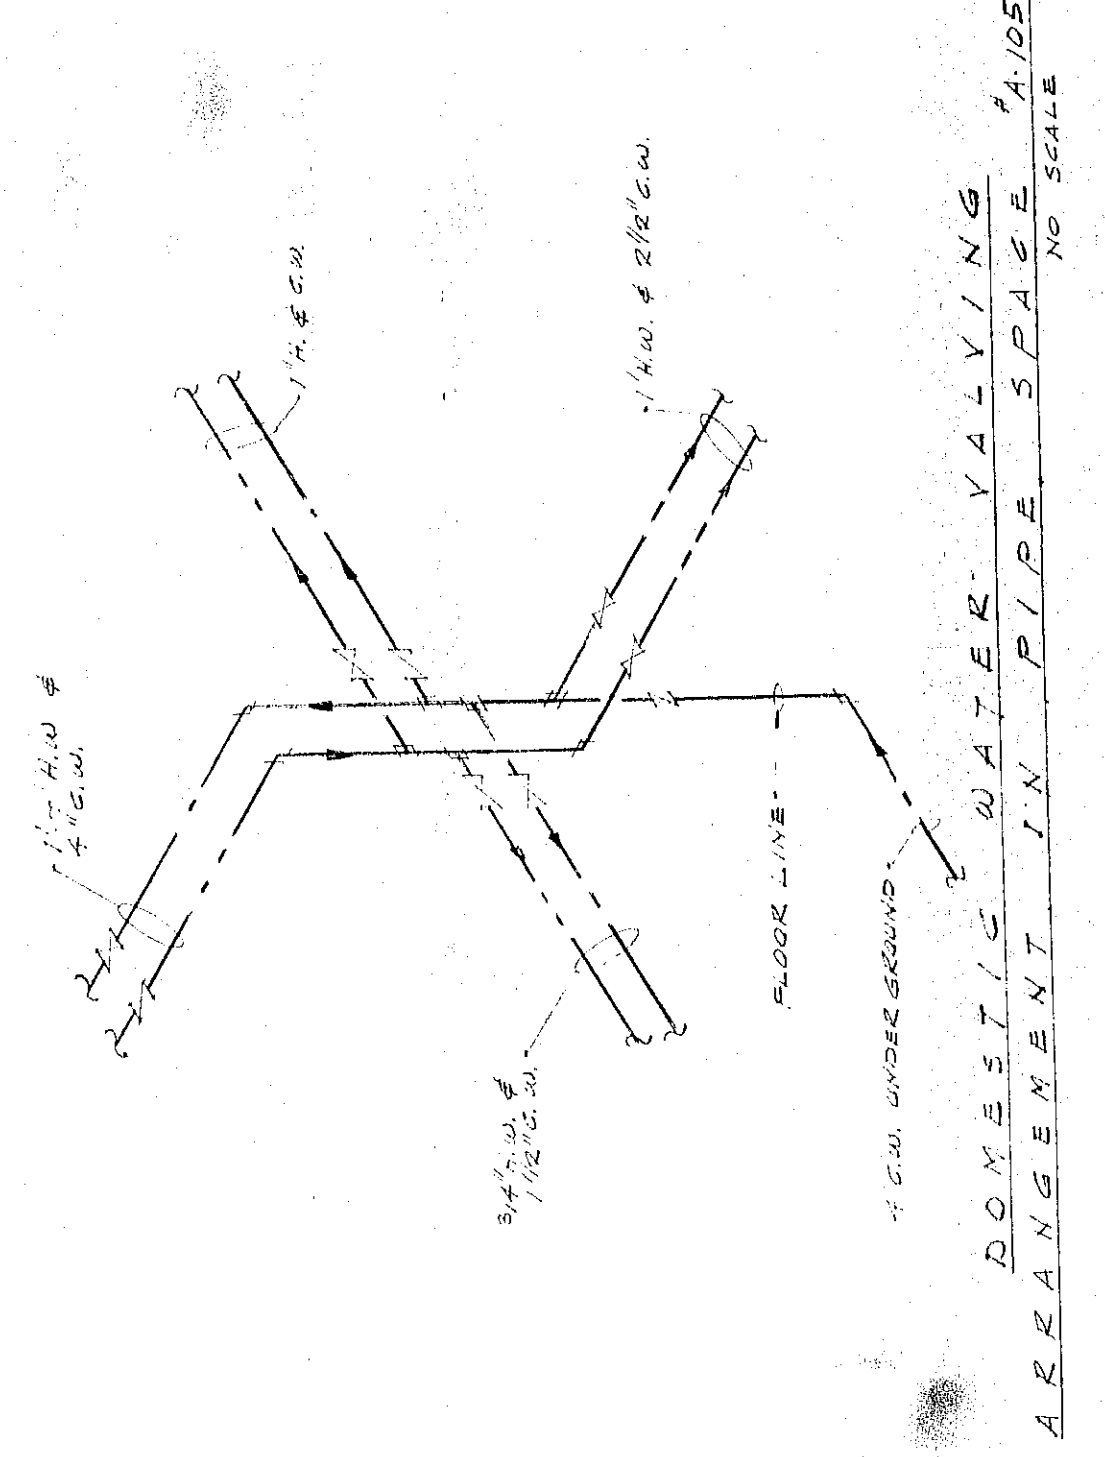


ARRANGEMENT IN PIPE SPACE
 NO SCALE

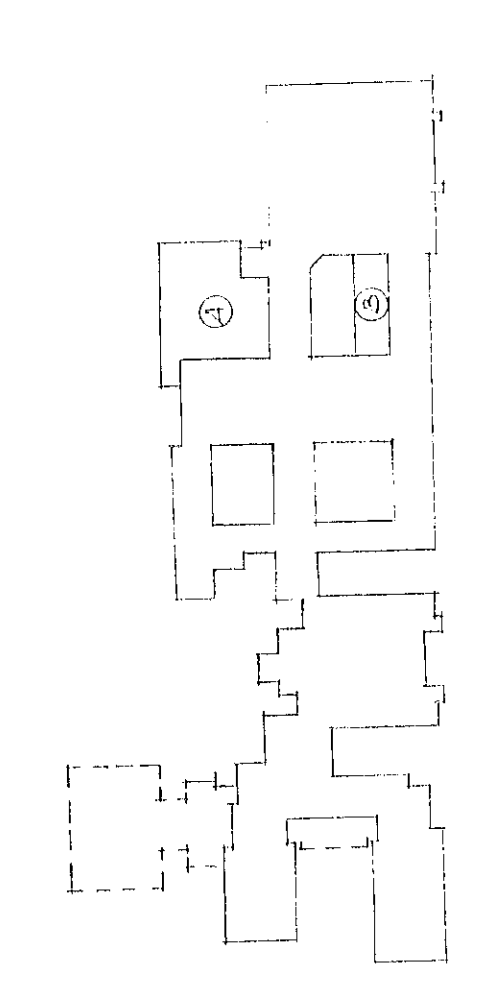

KEY PLAN
 NO SCALE

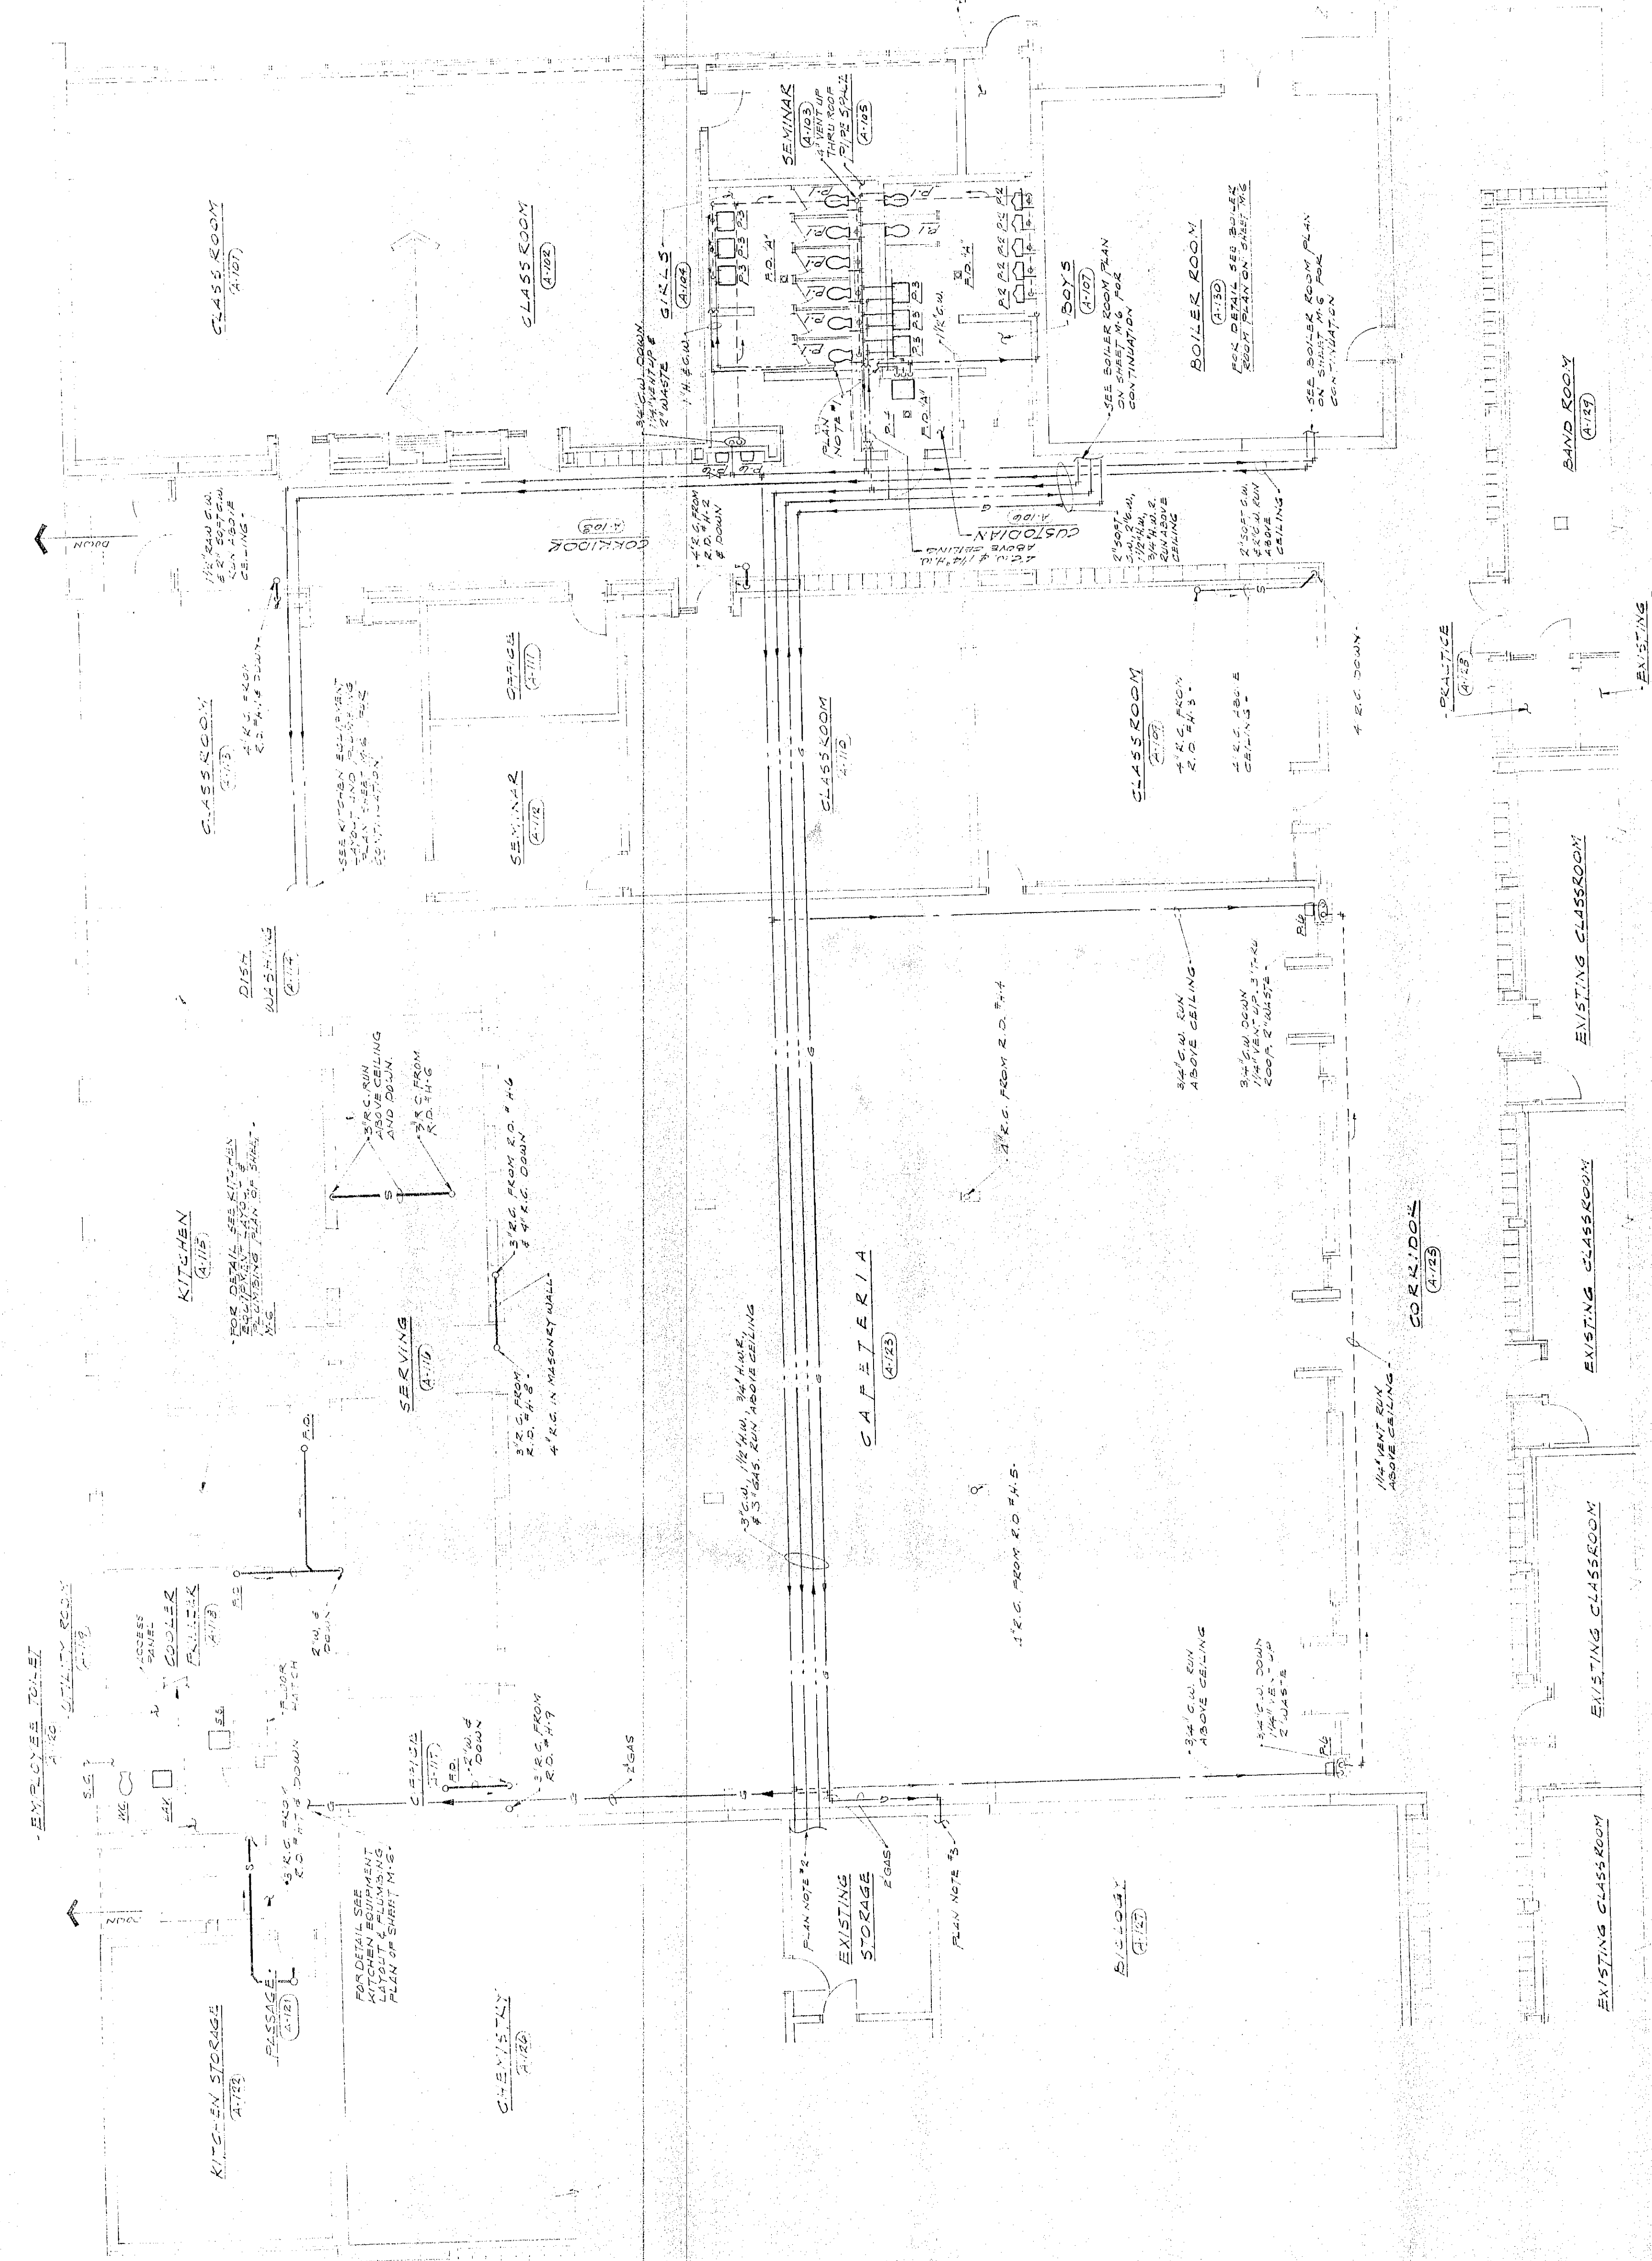

UNIT A PLUMBING FIRST FLOOR PLAN
 SCALE 1/8" = 1'-0"

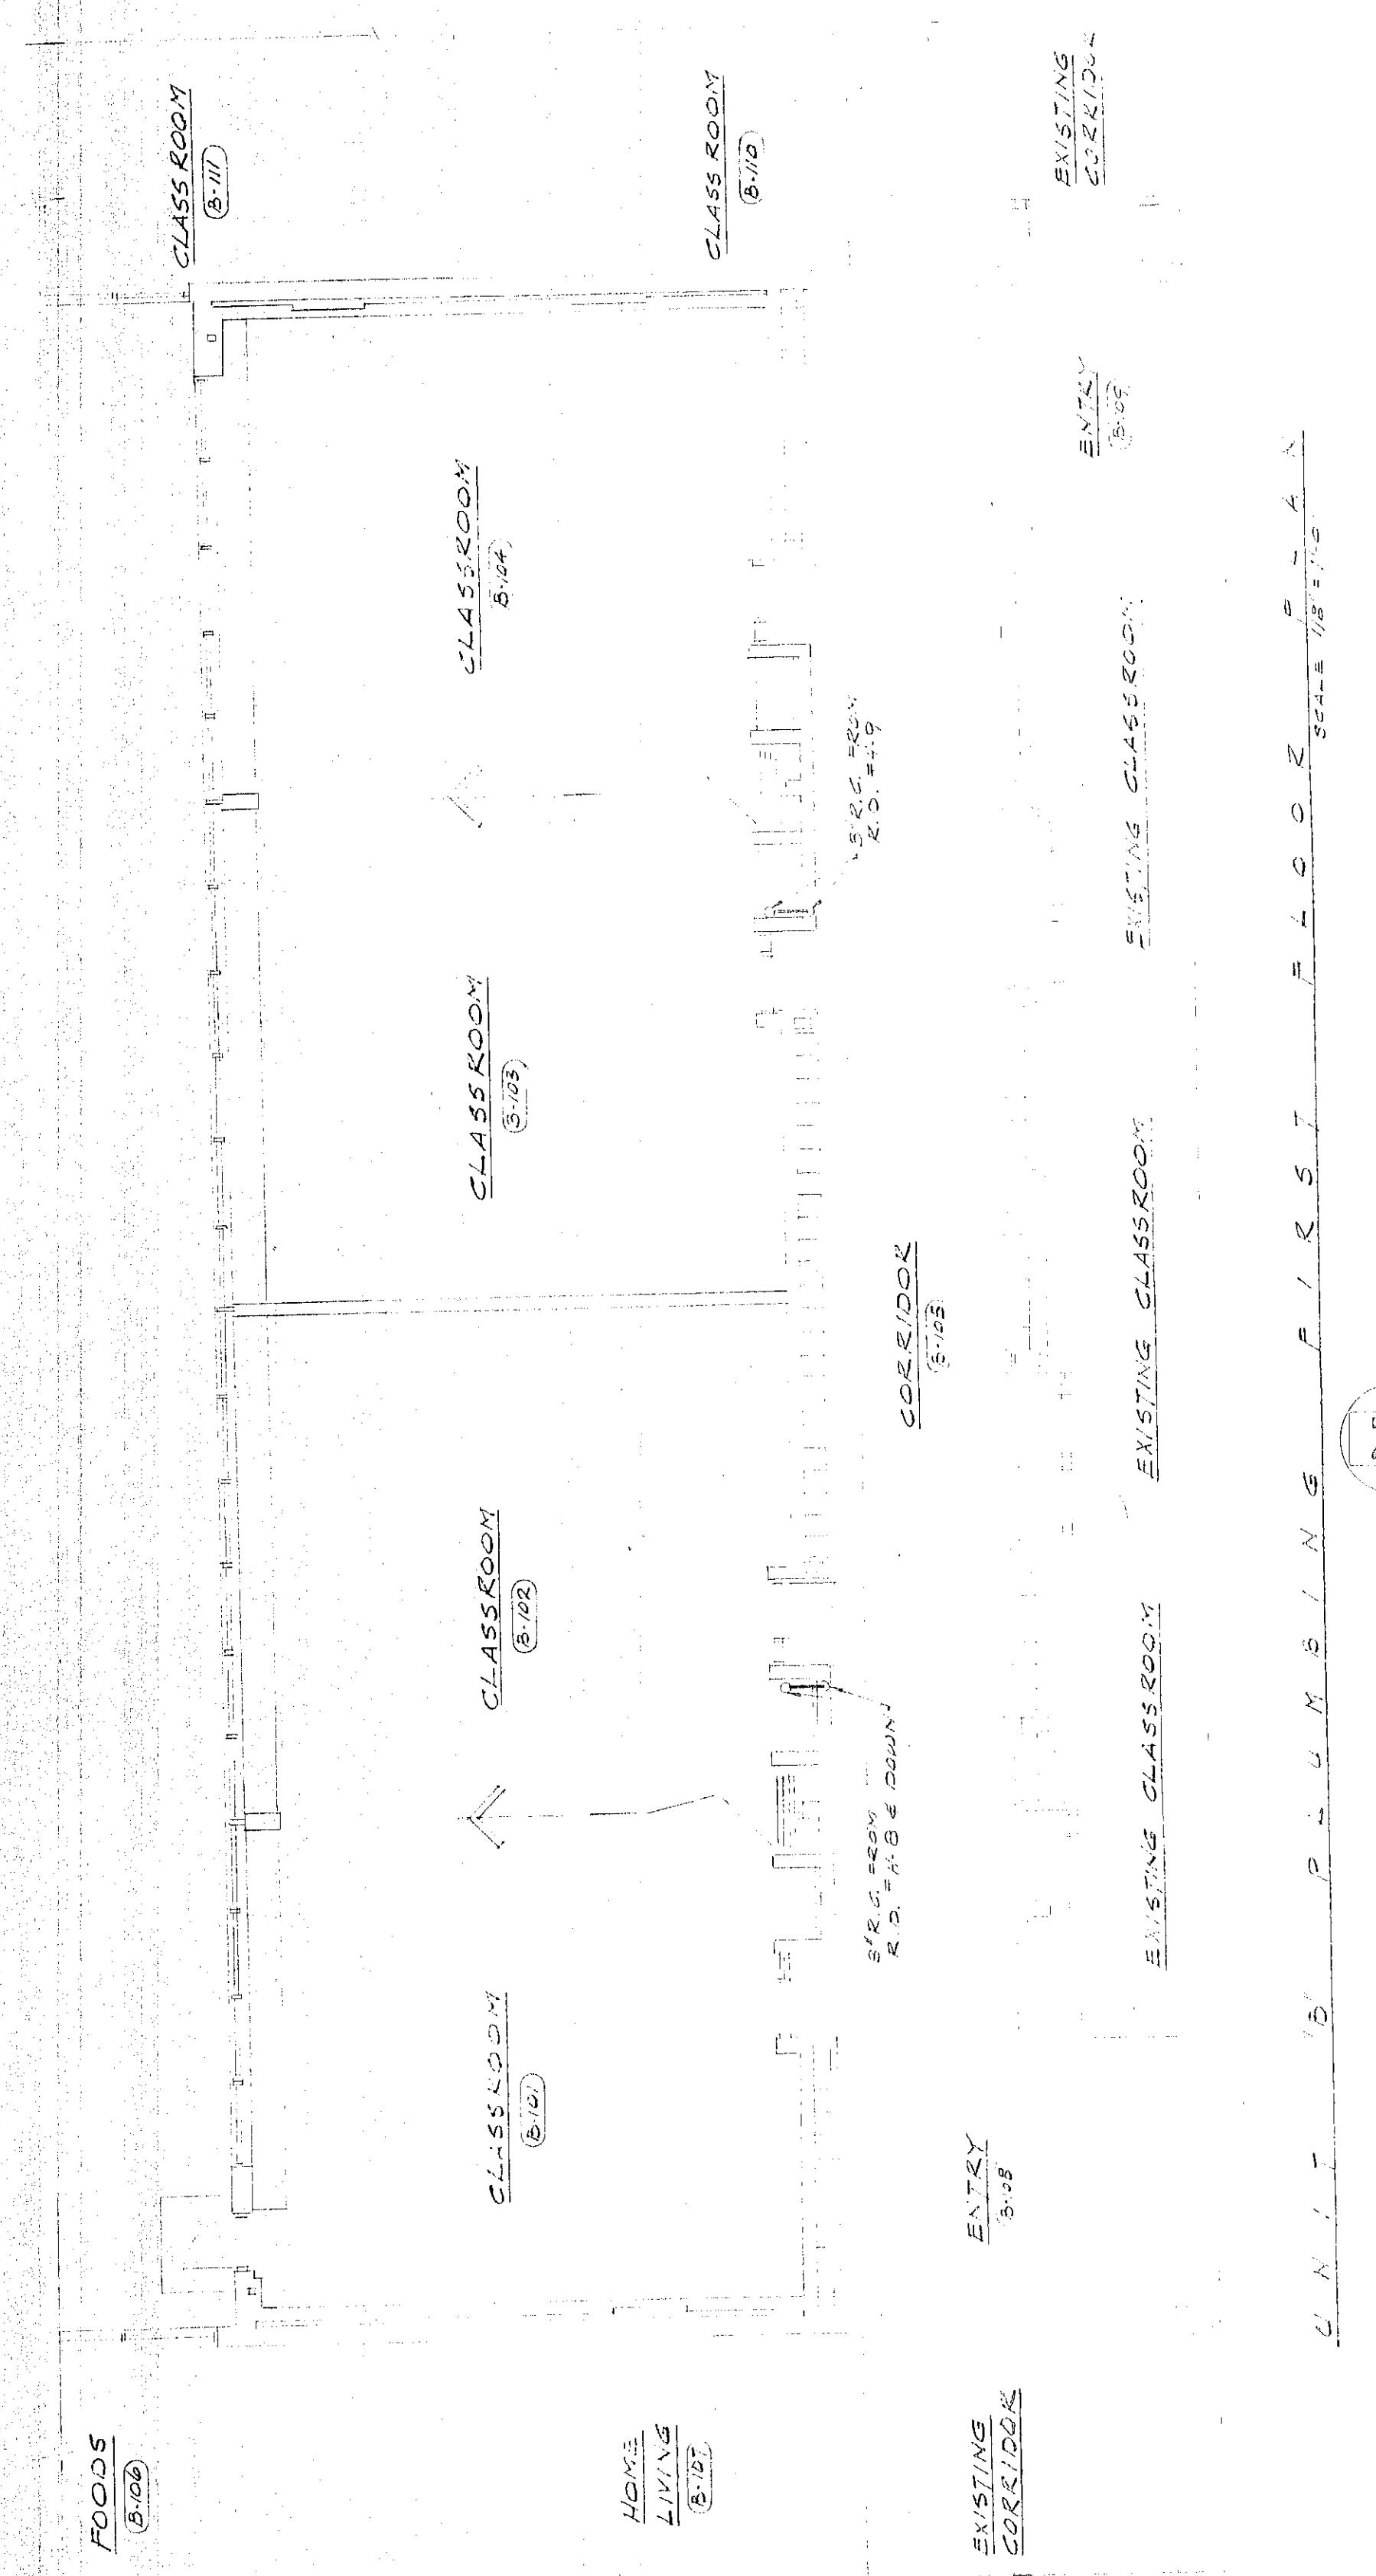

UNIT B PLUMBING FIRST FLOOR PLAN
 SCALE 1/8" = 1'-0"