
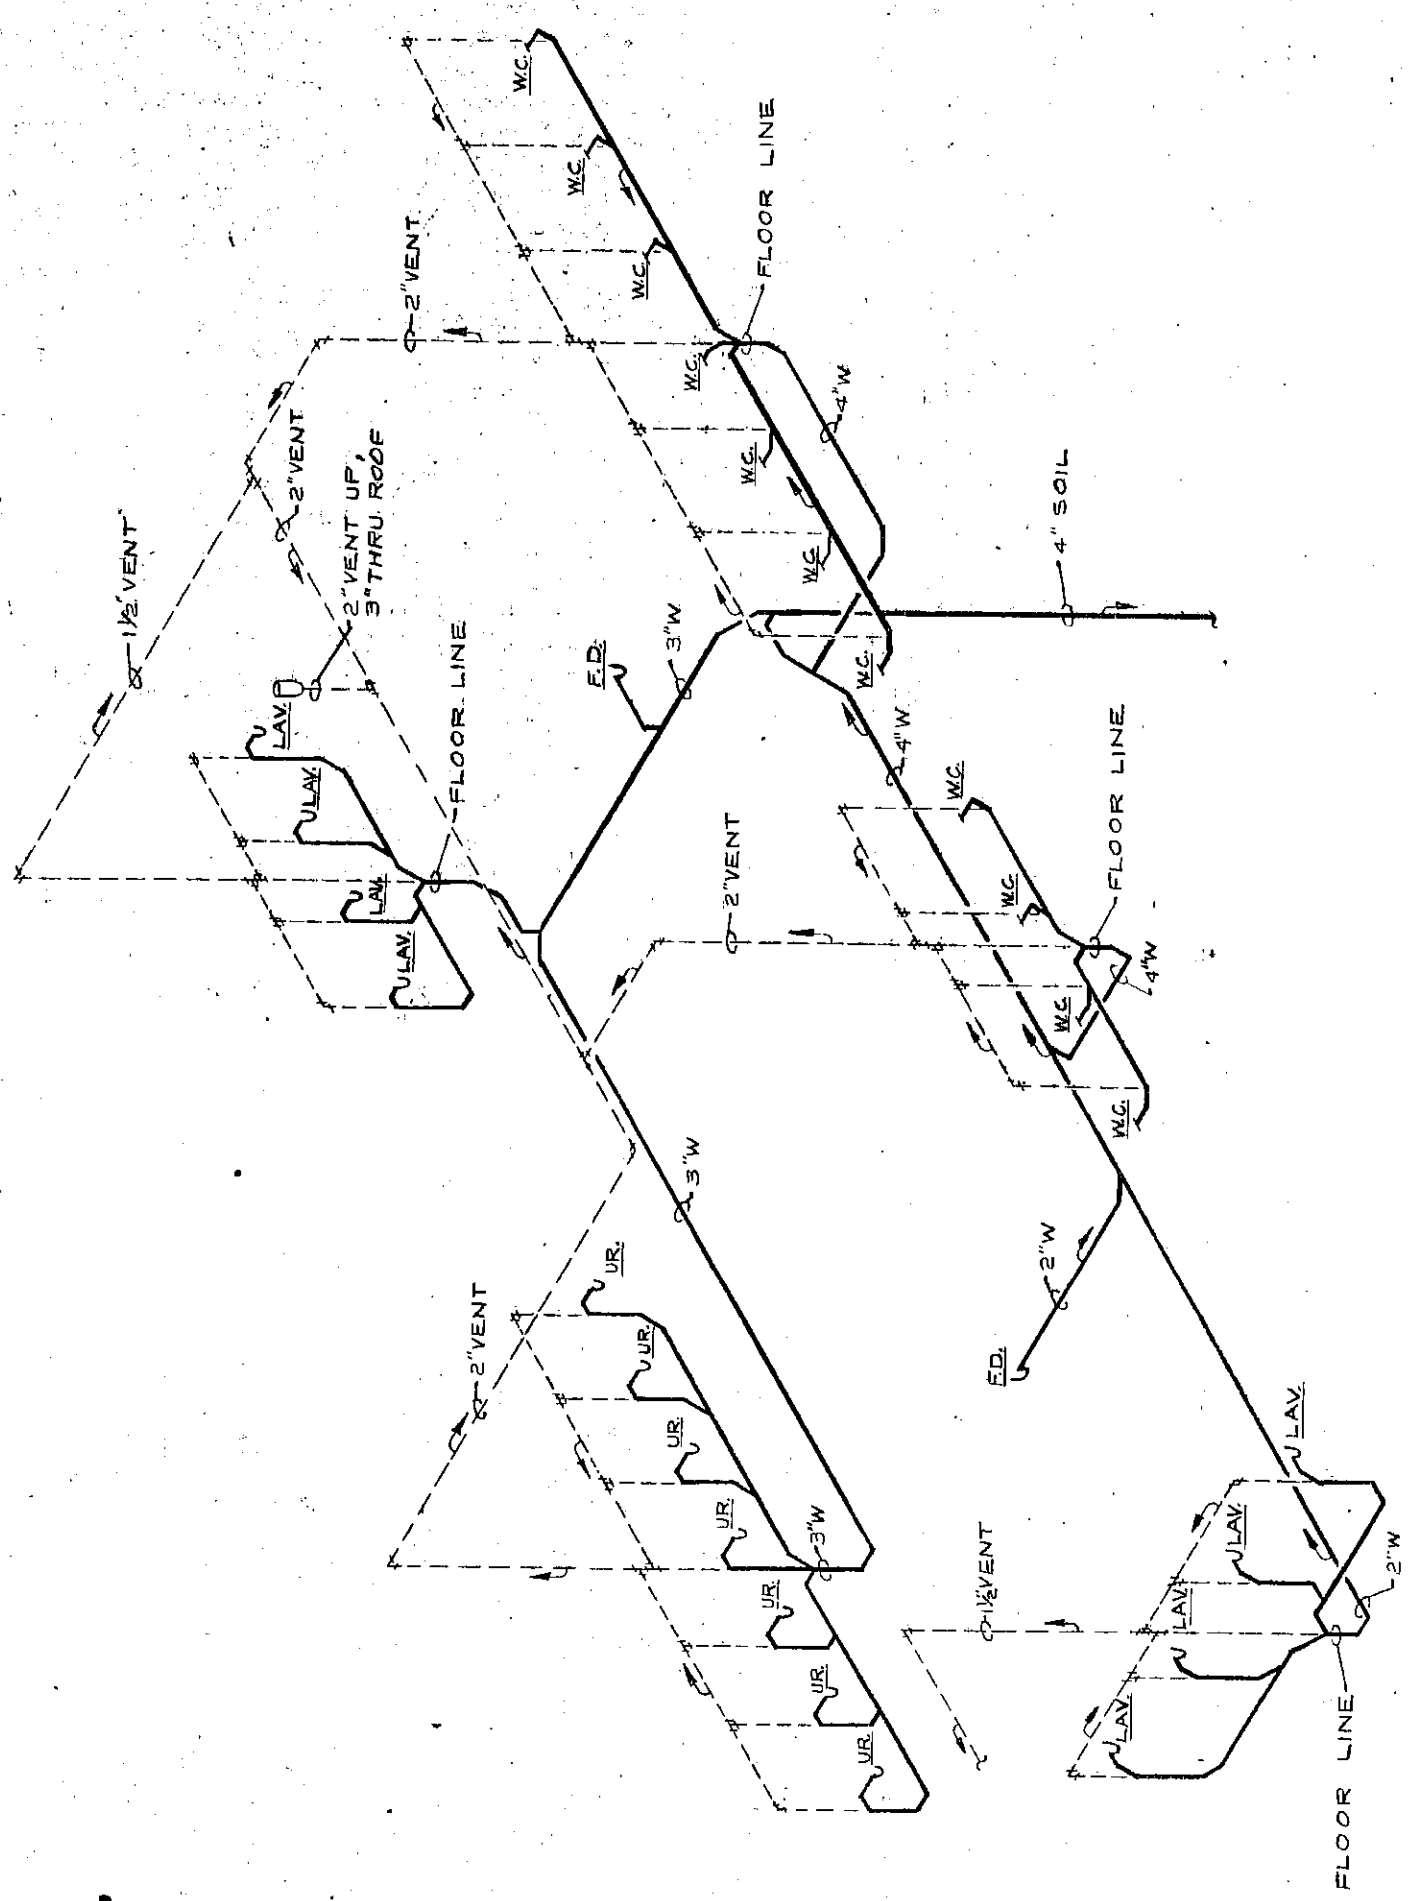
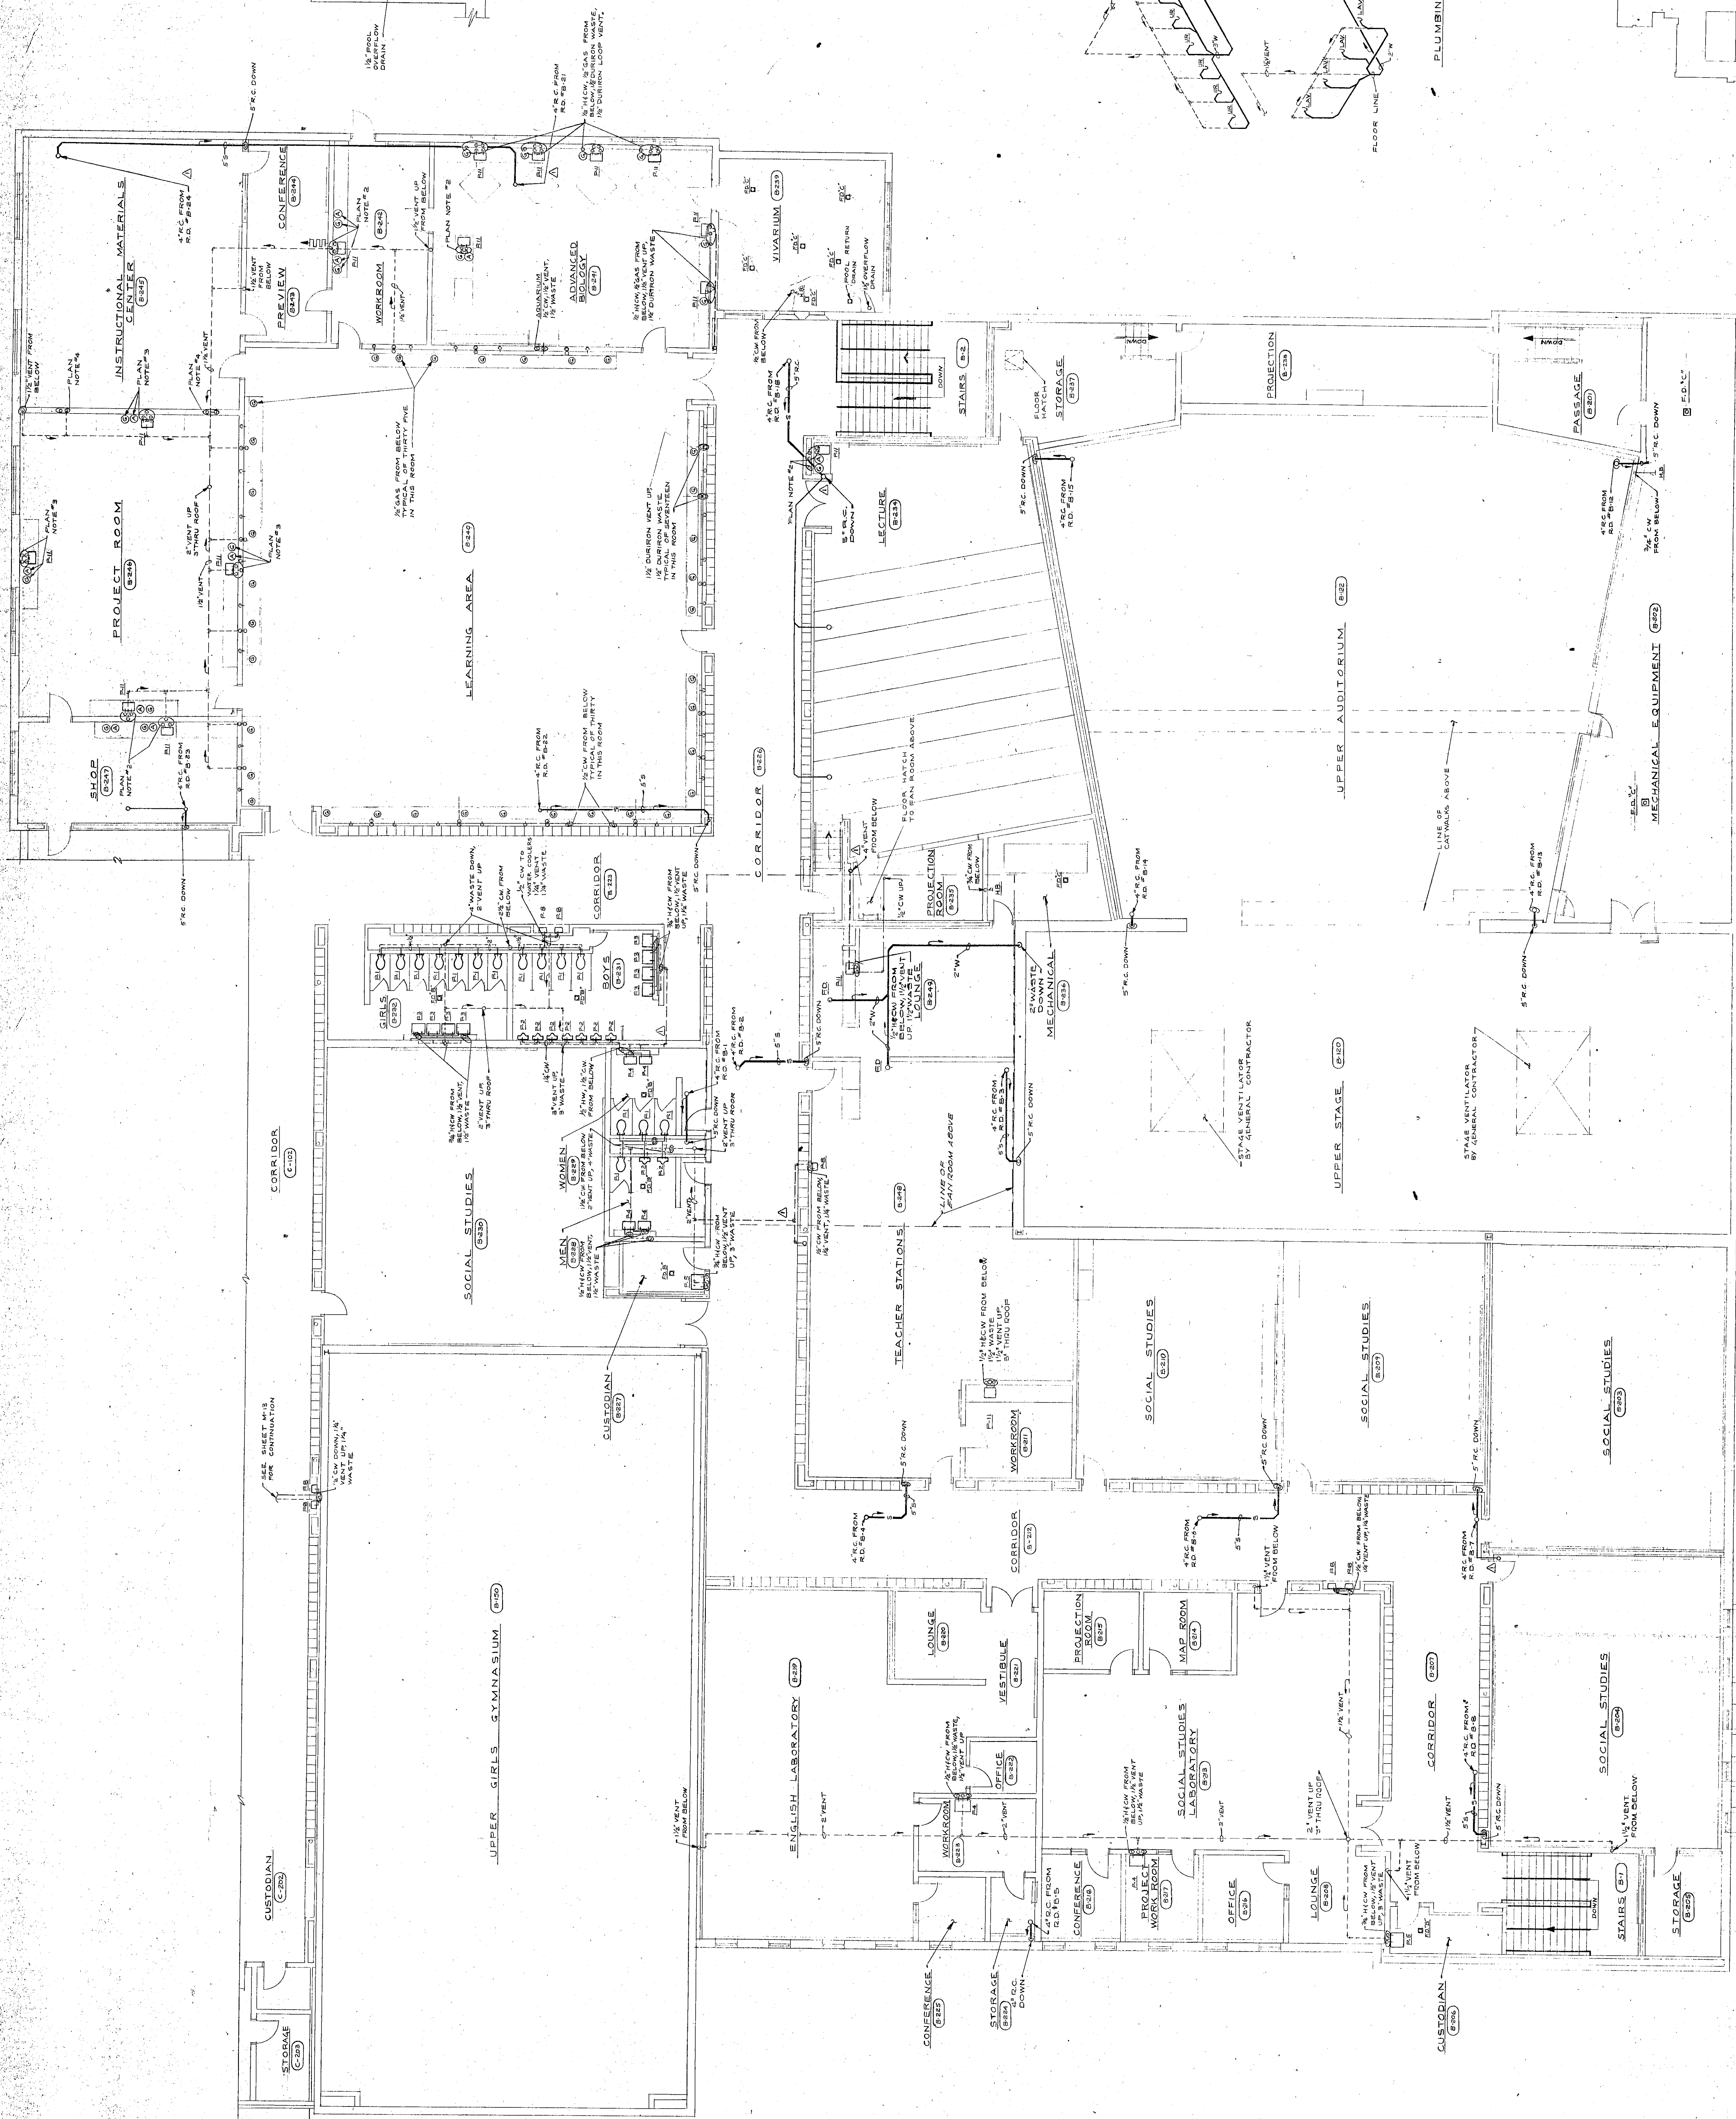


[illegible]

PLUMBING ISOMETRIC OF ROOMS B-231, B-232

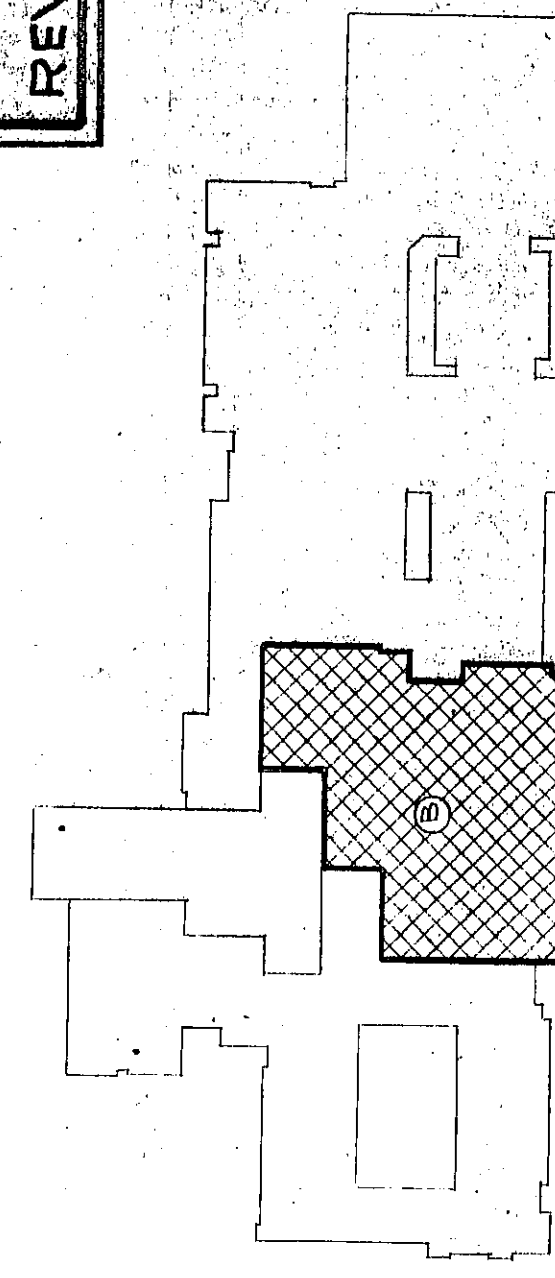

SECOND FLOOR KEY PLAN

UNIT B PLUMBING SECOND FLOOR PLAN
SCALE 1/8" = 1'-0"

EVERETT I. BROWN COMPANY -- ARCHITECTS & ENGINEERS
 3500 BRADBURY AVENUE -- PARK FLETCHER
 INDIANAPOLIS INDIANA
 SHEET M-8 OF 33
 ADDITION TO CHESTERTON HIGH SCHOOL