



LOCKER ROOM C-134

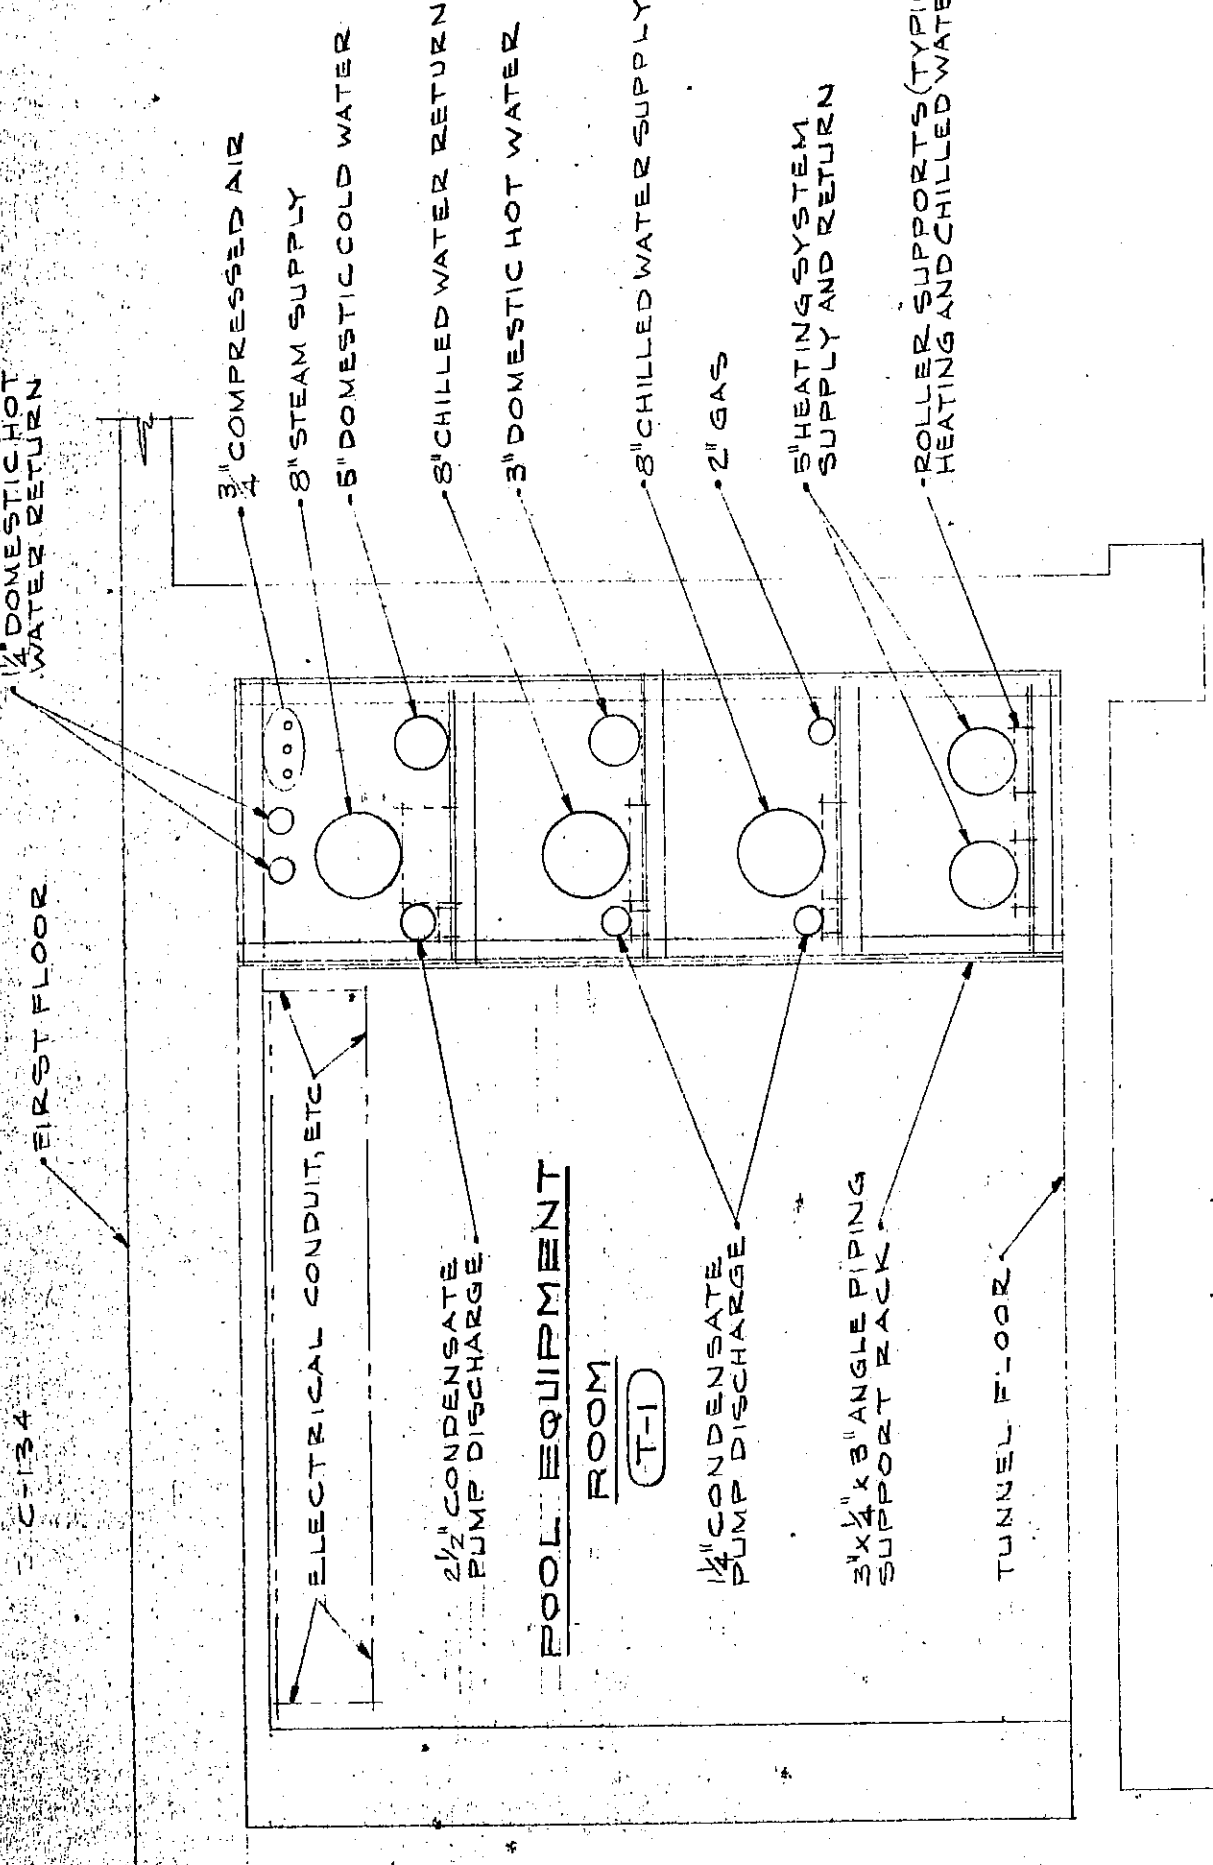


SECTION A-A SCALE 1/8" = 1'-0"


SECTION B-B SCALE 1/8" = 1'-0"

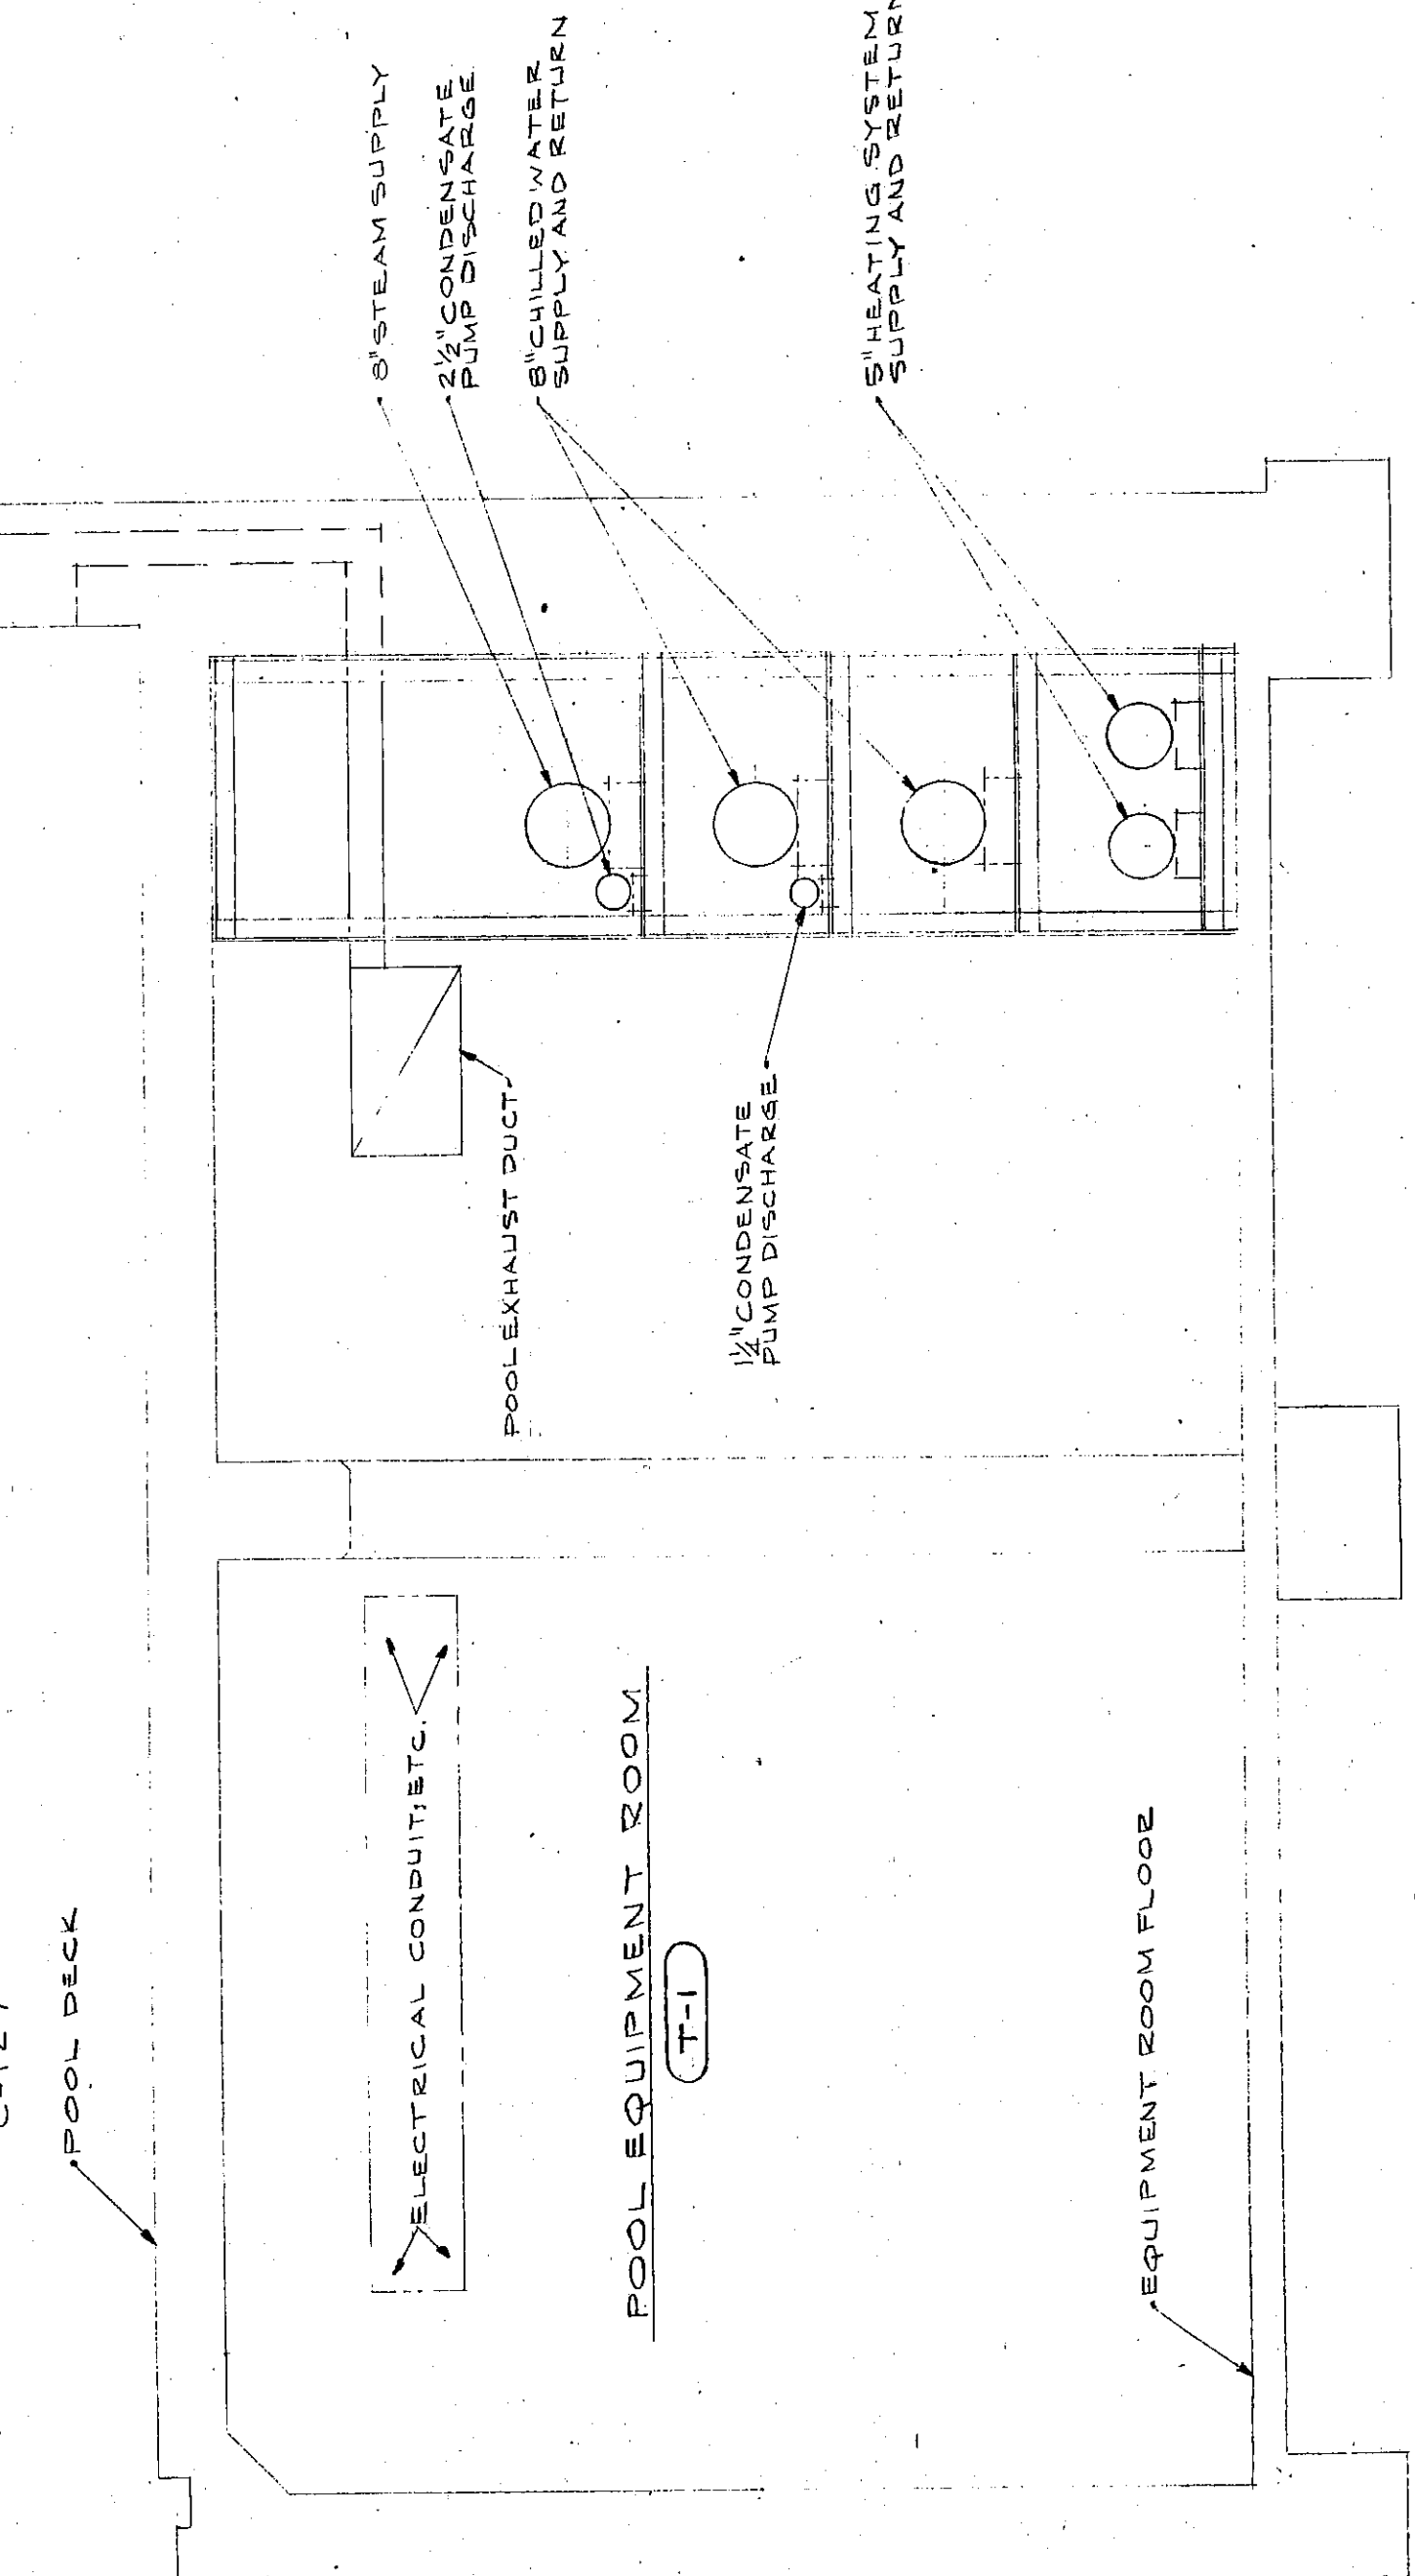


SECTION C-C SCALE 1/8" = 1'-0"

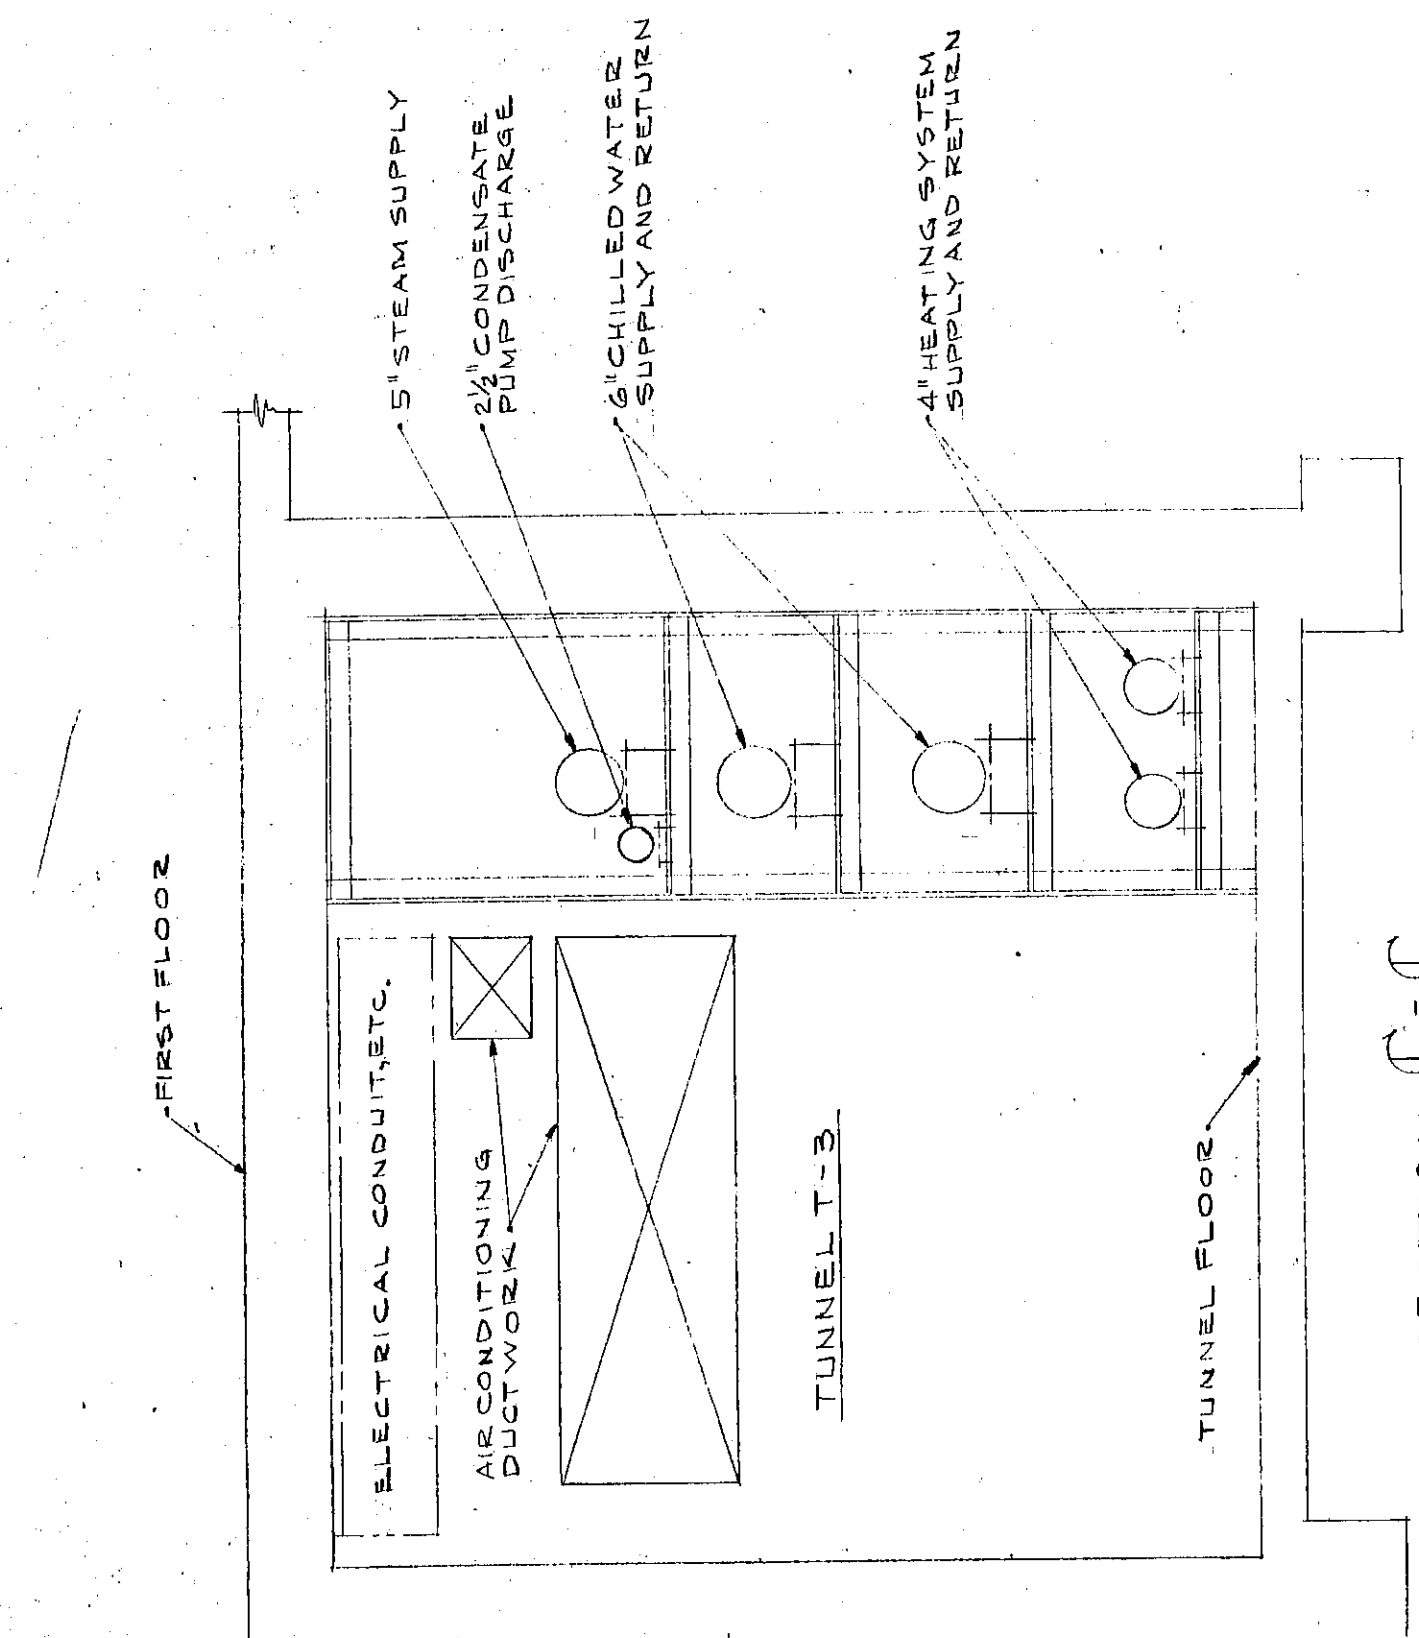


SECTION D-D SCALE 1/8" = 1'-0"

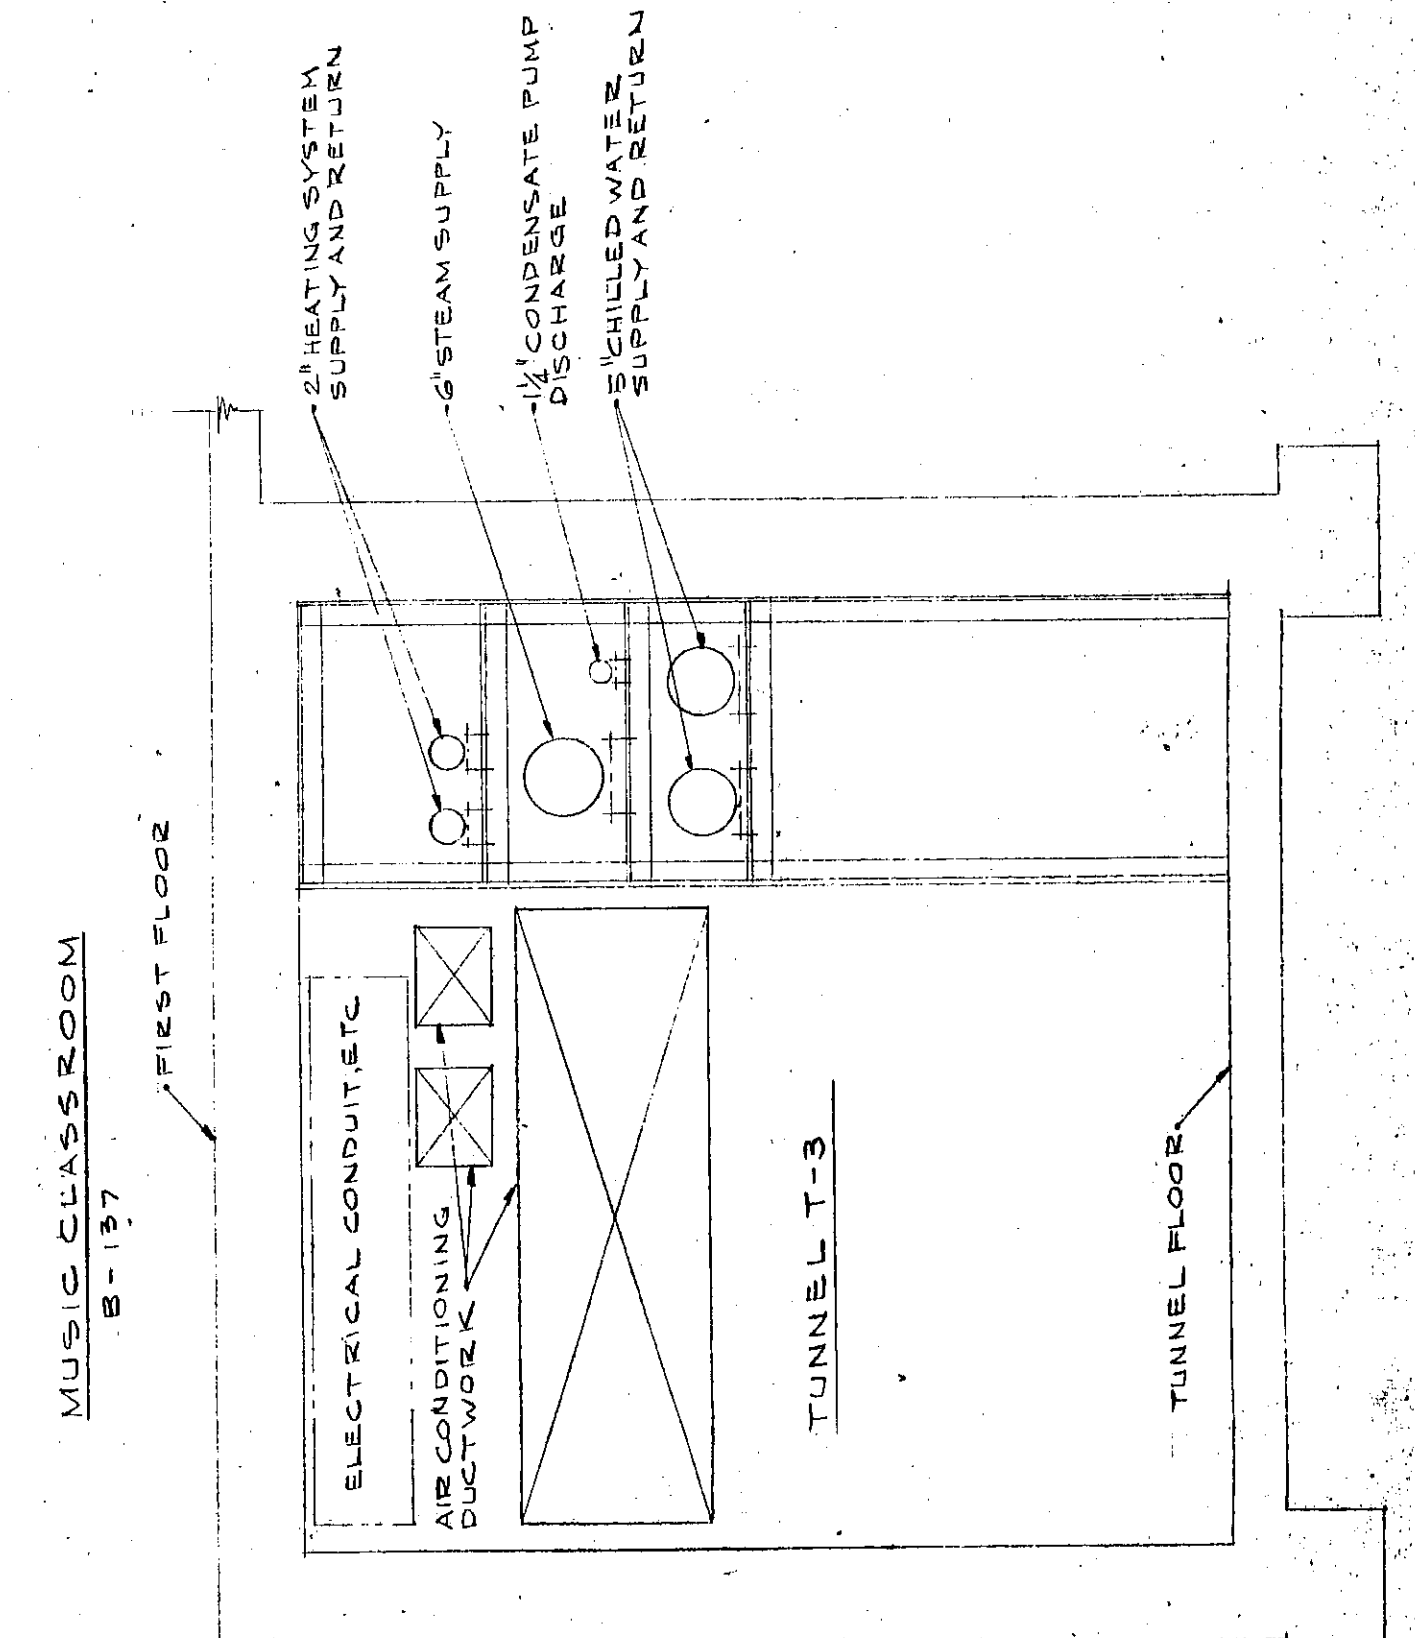

SECTION E-E SCALE 1/8" = 1'-0"

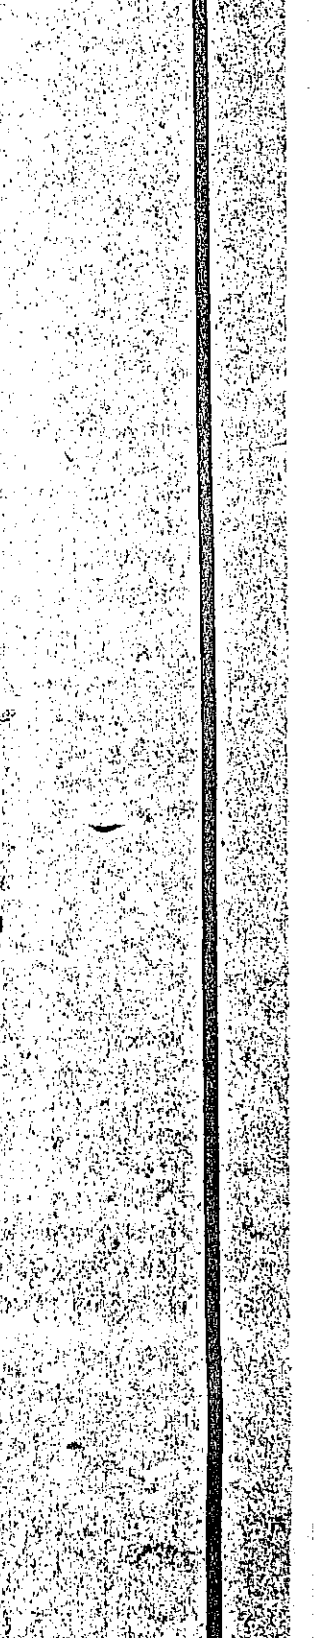

- PLAN NOTES**
1. ALL PIPING SHALL BE ALL ALUMINUM CONSTRUCTION.
 2. ALL PIPING UNDER FLOOR SLAB IN UNOCCUPIED AREAS SHALL BE RUN IN TUNNELS.
 3. ALL PIPING RUN IN TUNNELS SHALL BE RUN AS CLOSE TO THE WALL AS POSSIBLE TO ALLOW MAXIMUM ACCESS.
 4. SEE SPECIFICATIONS FOR STANDARD DETAILS.
 5. PIPING SUPPORT BACKS SHALL BE LOCATED EVERY 10 FEET.
 6. ALL ALUMINUM GUIDES LOCATIONS, EXPANSION JOINTS, ETC., SHALL BE SHOWN ON THIS PLAN.
 7. PROVIDE AIRTIGHT, WATERPROOF BULKHEAD.

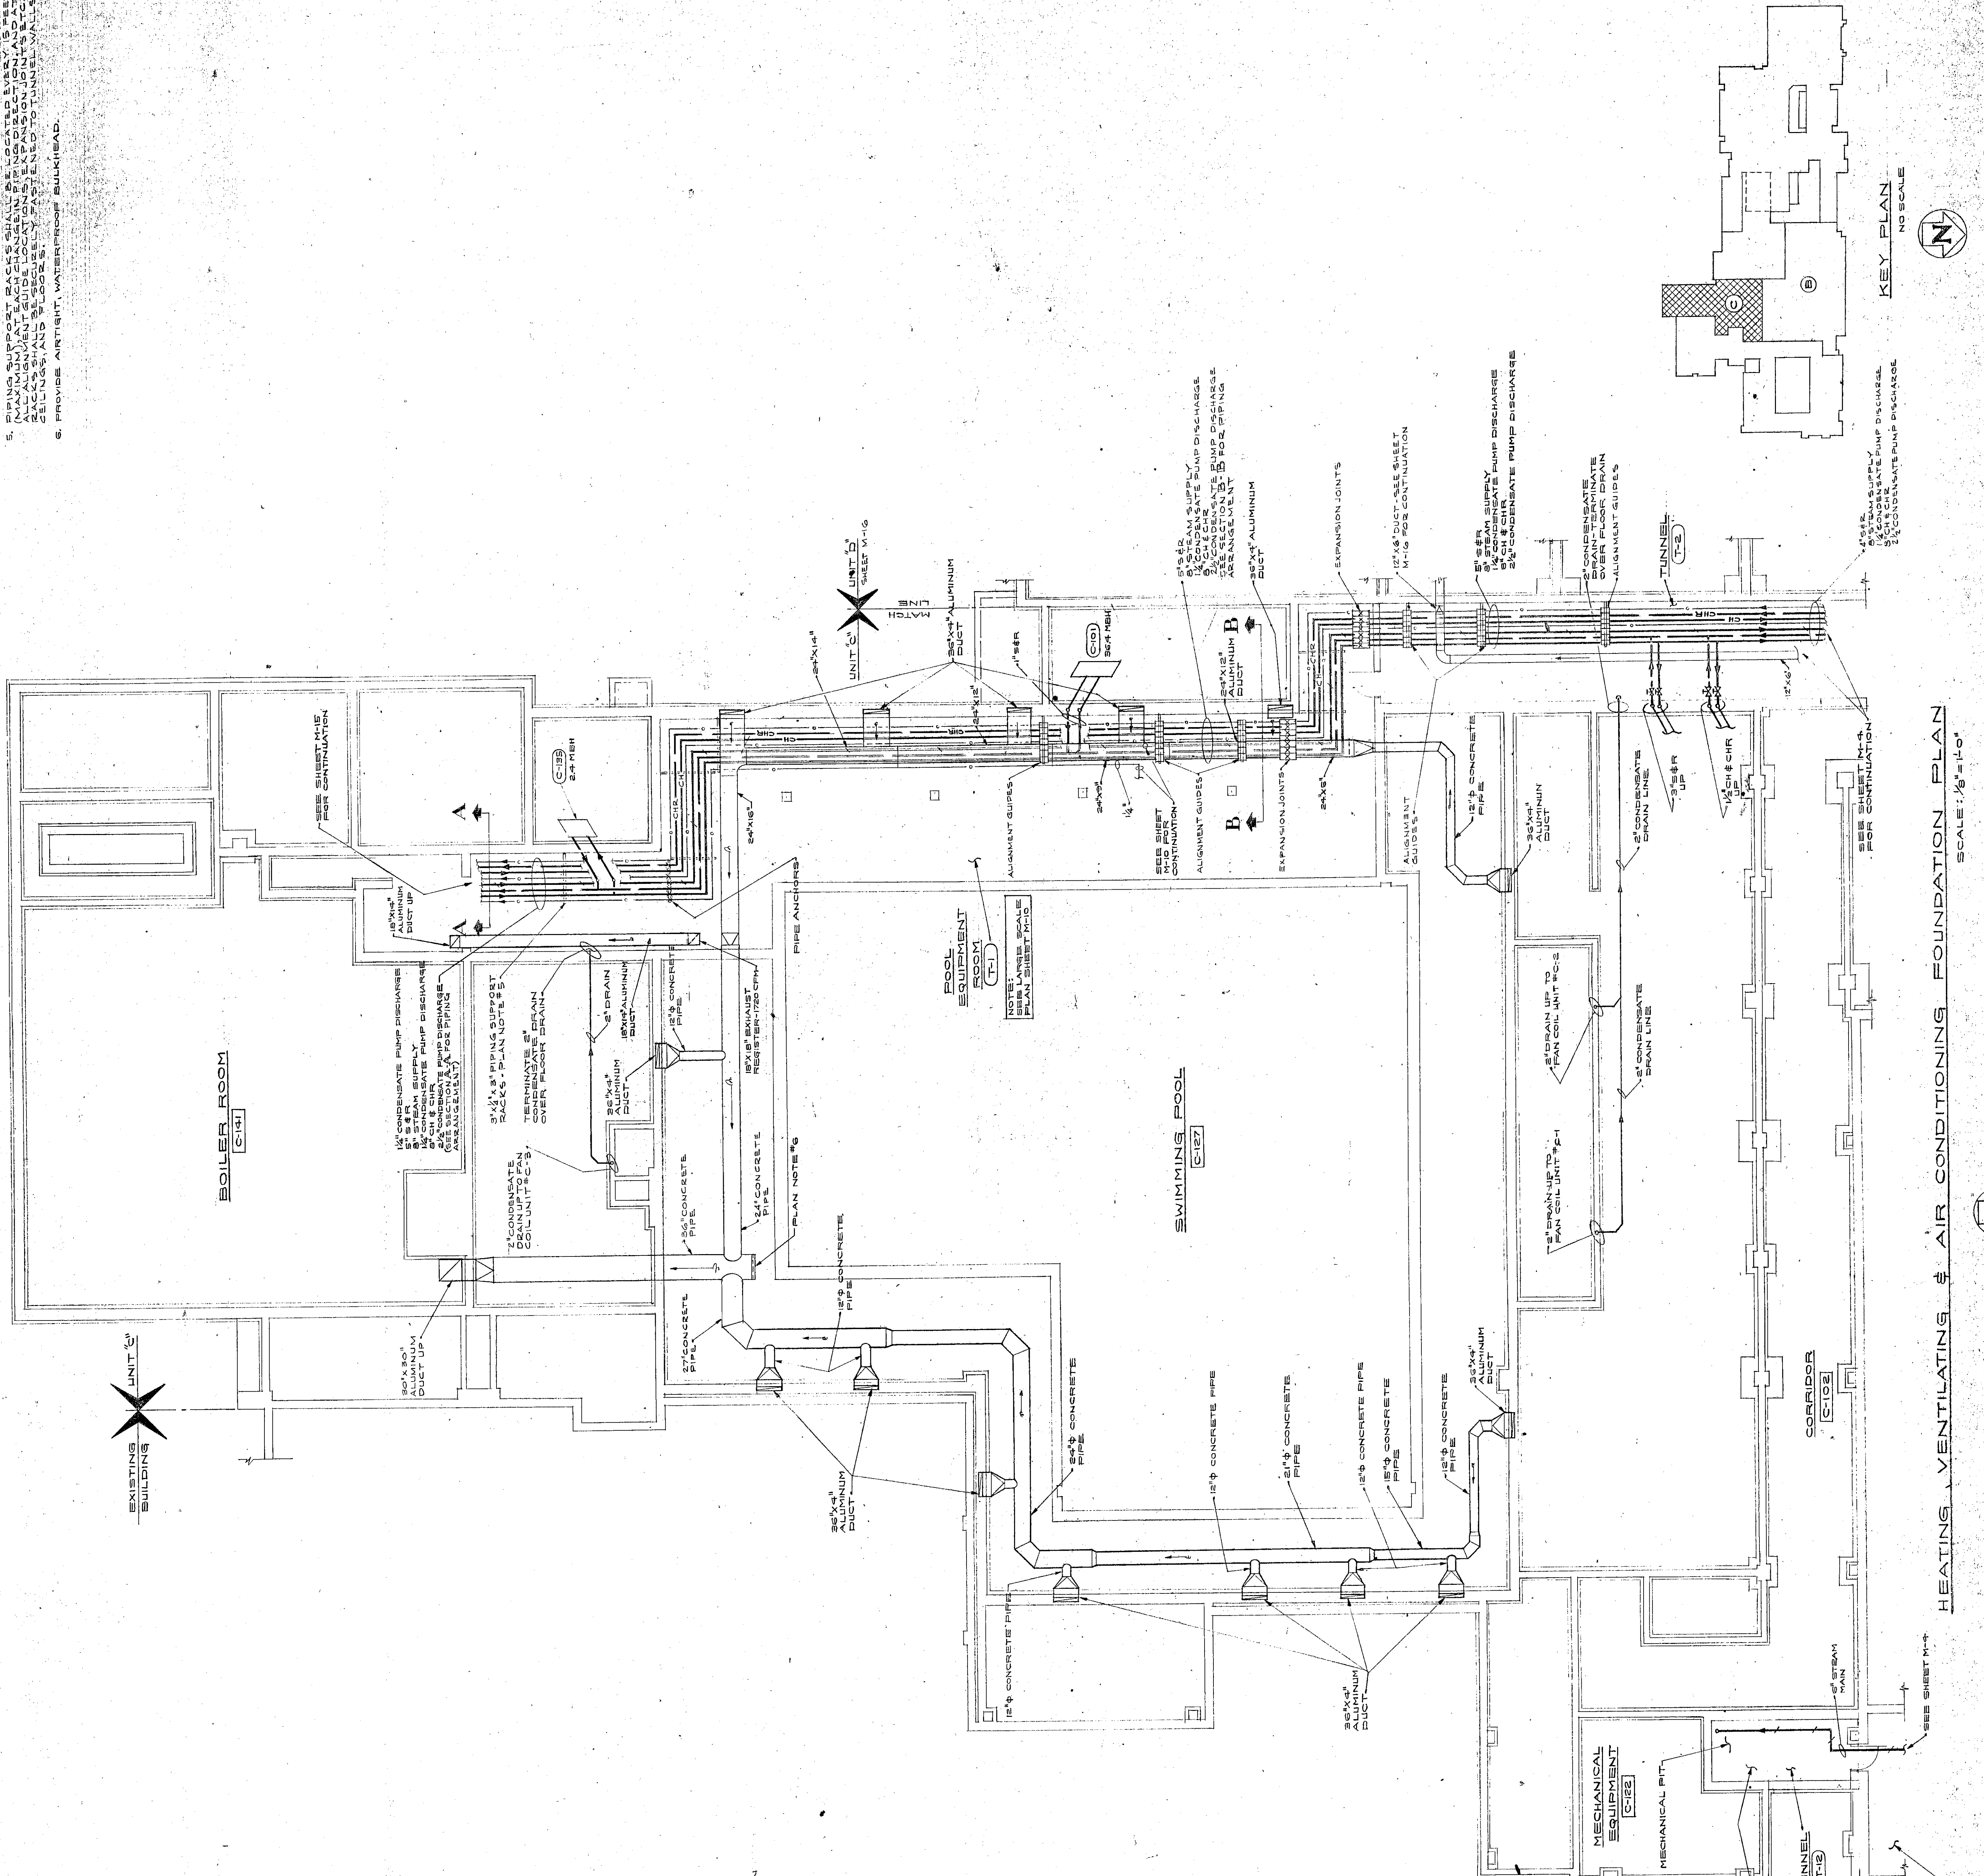

HEATING, VENTILATING & AIR CONDITIONING FOUNDATION PLAN SCALE 1/8" = 1'-0"

