



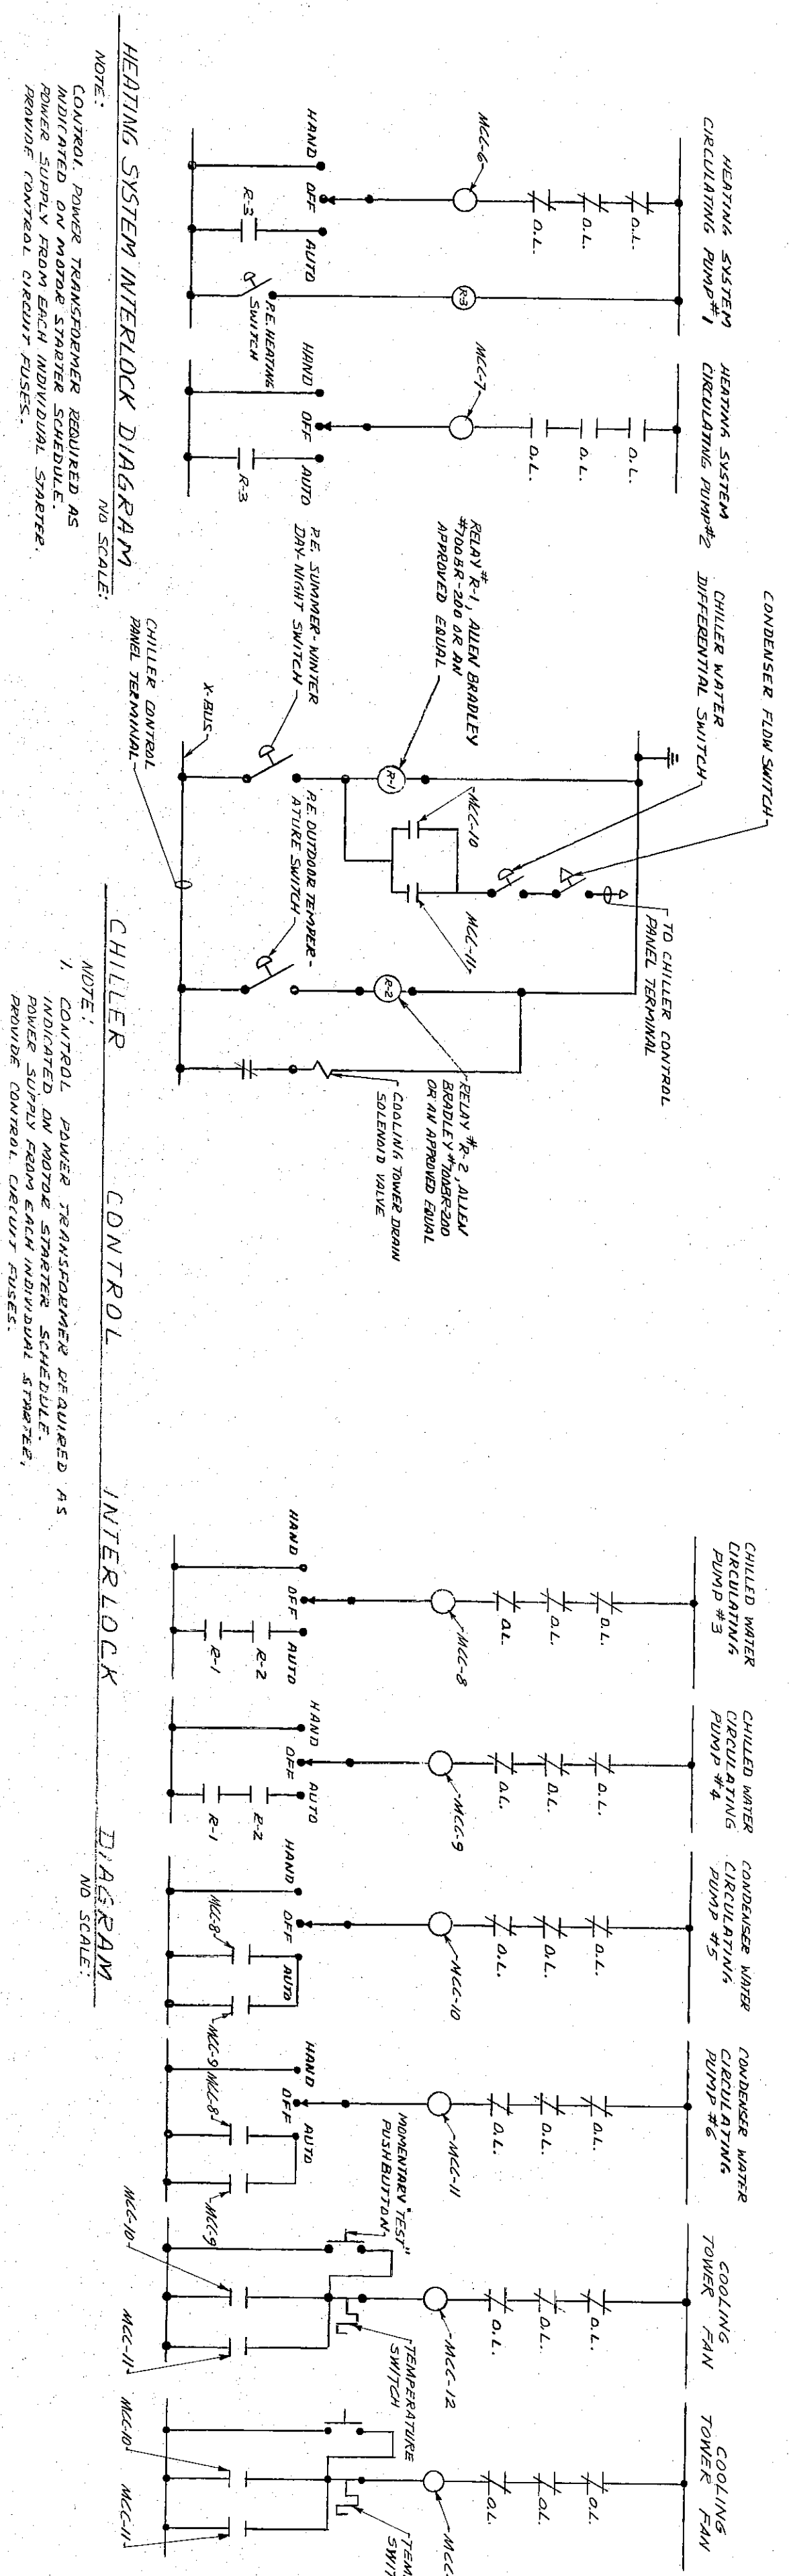

P A N E L									
WAVELENGTH	SURFACE	MATERIAL	THICKNESS	INDEX OF REFRACTION	WAVELENGTH	WAVELENGTH		REMARKS	
						IN AIR	IN WATER		
10000	✓	2534	✓	✓	10000	10000	10000	THE ABOVE WAVELENGTHS WERE OBTAINED FROM THE SPECTRUM OF A MERCURY DISCHARGE	
10000	✓	2534	✓	✓	10000	10000	10000		
10000	✓	2534	✓	✓	10000	10000	10000		
10000	✓	2534	✓	✓	10000	10000	10000		
10000	✓	2534	✓	✓	10000	10000	10000	THE ABOVE WAVELENGTHS WERE OBTAINED FROM THE SPECTRUM OF A MERCURY DISCHARGE	
10000	✓	2534	✓	✓	10000	10000	10000		
10000	✓	2534	✓	✓	10000	10000	10000		
10000	✓	2534	✓	✓	10000	10000	10000		
10000	✓	2534	✓	✓	10000	10000	10000	THE ABOVE WAVELENGTHS WERE OBTAINED FROM THE SPECTRUM OF A MERCURY DISCHARGE	
10000	✓	2534	✓	✓	10000	10000	10000		
10000	✓	2534	✓	✓	10000	10000	10000		
10000	✓	2534	✓	✓	10000	10000	10000		

PLAN NOTES

1. SEE SHEET E-1 FOR ELECTRICAL SITE PLAN.
2. SEE SHEET E-2 FOR SYMBOLS, DETAILS, SCHEDULES AND GENERAL NOTES.
3. SEE SHEET E-2 FOR POWER RISER DIAGRAM.
4. SEE SHEET M-200-500 EMULSIST PAW SCHEDULE AND POWER CIRCUITS.
5. ALL ELECTRICAL WORK SHOWN IS NEW AND BY THE ELECTRICAL CONTRACTOR UNLESS OTHERWISE NOTED.

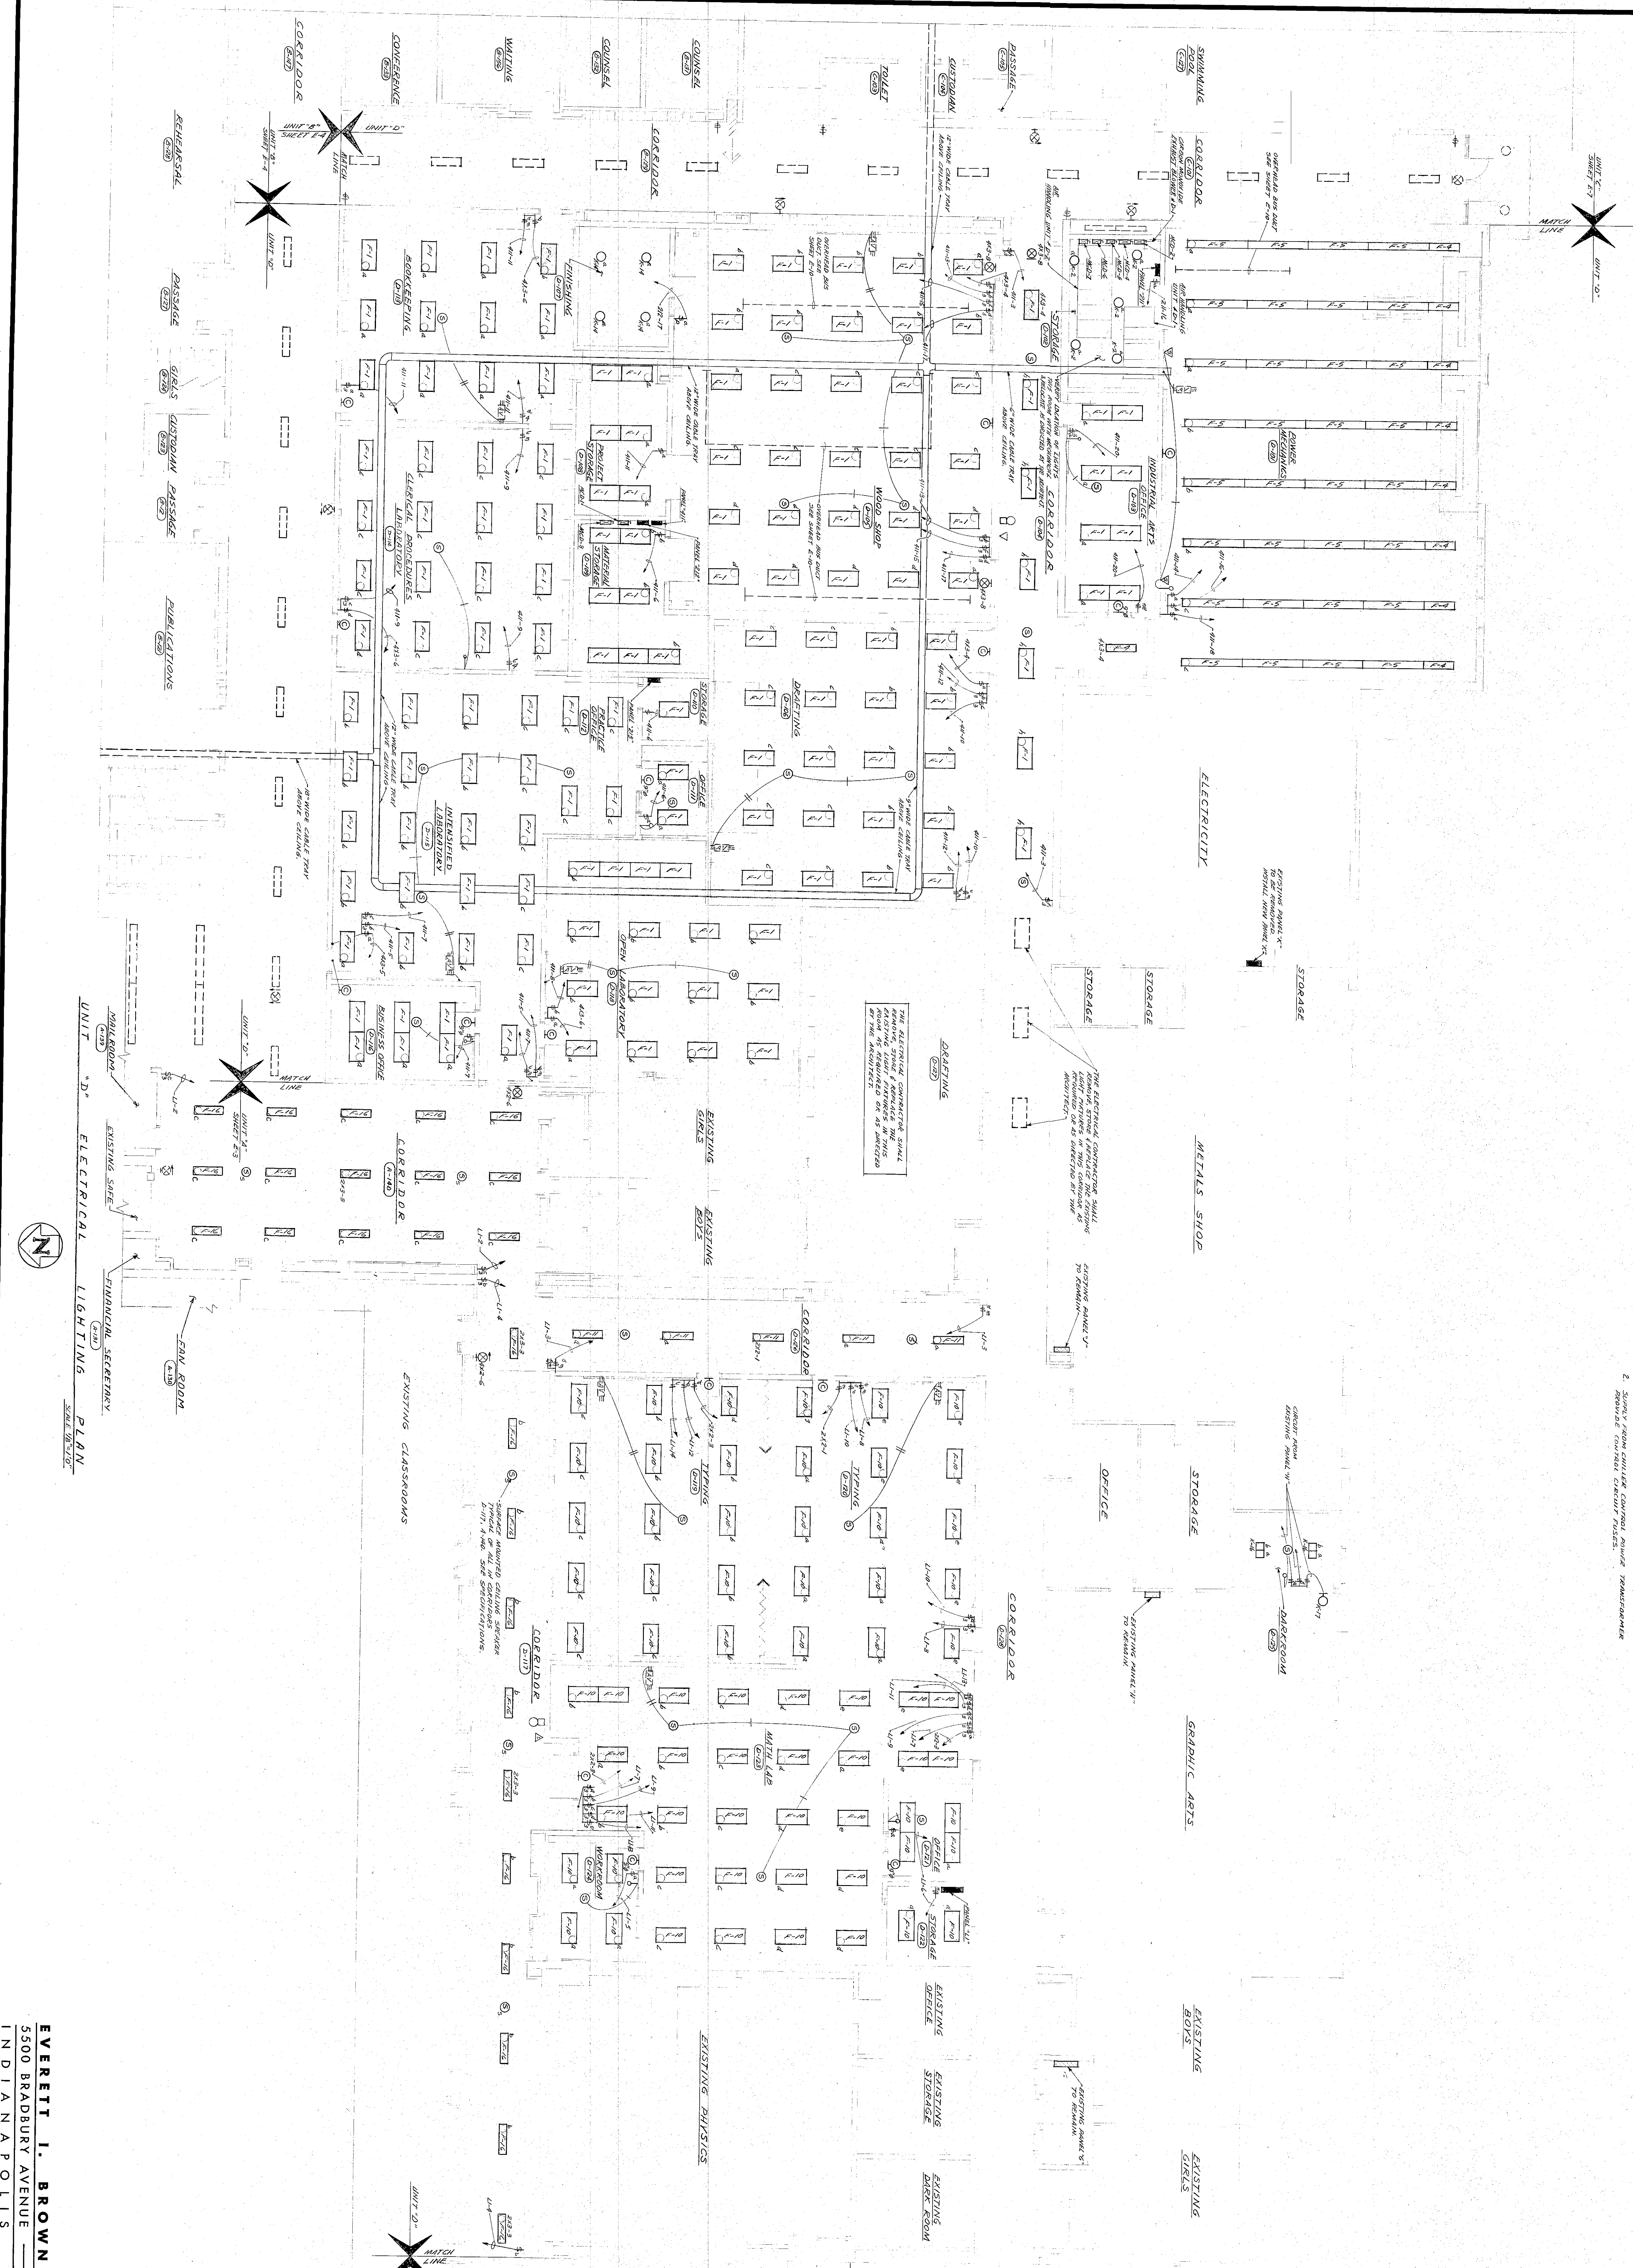

AL LIGHTING PLAN

SCALE 1/8" = 1'-0"



EVERETT I. BROWN COMPANY -- ARCHITECTS & ENGINEERS
3500 BRADBURY AVENUE — PARK FLETCHER
INDIANAPOLIS, INDIANA SHEET E-9 OF 20