


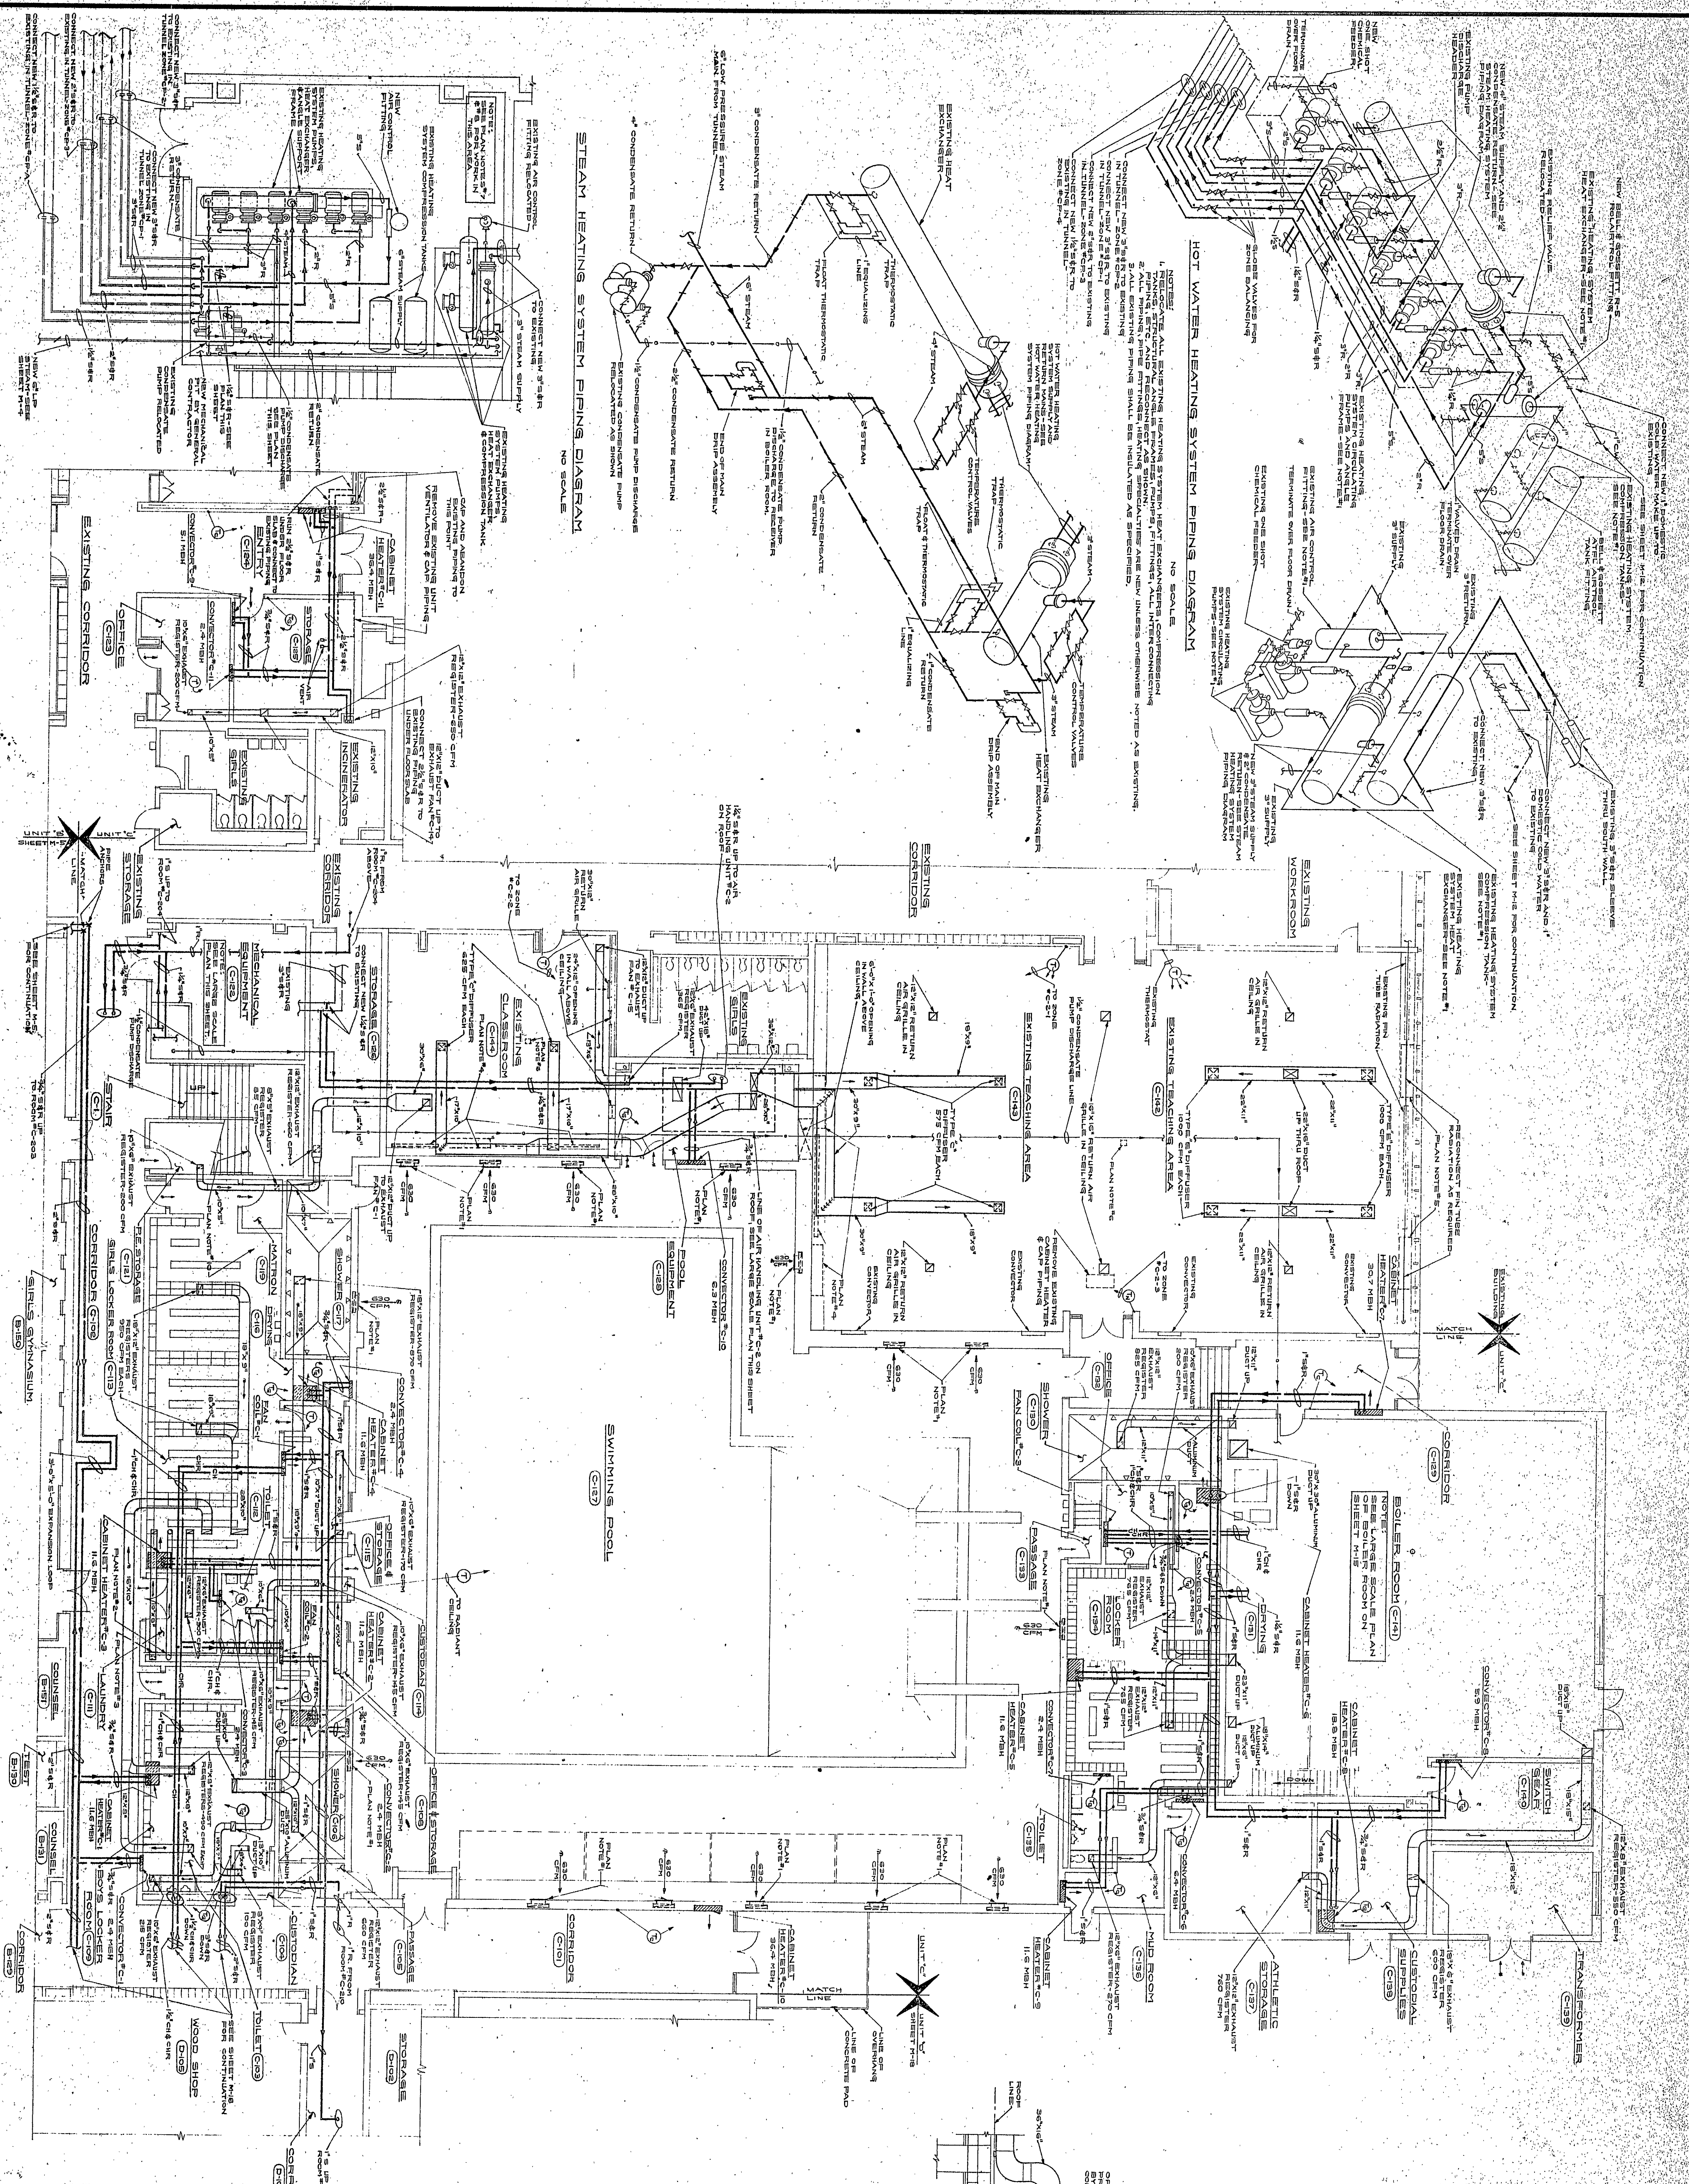

MECHANICAL EQUIPMENT LAYOUT
SCALE: 1/8" = 1'-0"

STEAM HEATING SYSTEM PIPING DIAGRAM
NO SCALE


HOT WATER HEATING SYSTEM PIPING DIAGRAM
NO SCALE

UNIT & HEATING VENTILATING & AIR CONDITIONING FIRST FLOOR PLAN
SCALE: 1/8" = 1'-0"

PLAN NOTES

1. EXISTING EXHAUST REGISTER AND DUCT DOWN TO BASEMENT FROM VENTILATING UNIT IN WALLS TO BE REMOVED.
2. EXISTING EXHAUST REGISTER AND DUCT DOWN TO BASEMENT FROM VENTILATING UNIT IN WALLS TO BE REMOVED.
3. EXISTING EXHAUST REGISTER AND DUCT DOWN TO BASEMENT FROM VENTILATING UNIT IN WALLS TO BE REMOVED.
4. EXISTING EXHAUST REGISTER AND DUCT DOWN TO BASEMENT FROM VENTILATING UNIT IN WALLS TO BE REMOVED.
5. EXISTING EXHAUST REGISTER AND DUCT DOWN TO BASEMENT FROM VENTILATING UNIT IN WALLS TO BE REMOVED.
6. EXISTING EXHAUST REGISTER AND DUCT DOWN TO BASEMENT FROM VENTILATING UNIT IN WALLS TO BE REMOVED.
7. EXISTING EXHAUST REGISTER AND DUCT DOWN TO BASEMENT FROM VENTILATING UNIT IN WALLS TO BE REMOVED.
8. EXISTING EXHAUST REGISTER AND DUCT DOWN TO BASEMENT FROM VENTILATING UNIT IN WALLS TO BE REMOVED.
9. EXISTING EXHAUST REGISTER AND DUCT DOWN TO BASEMENT FROM VENTILATING UNIT IN WALLS TO BE REMOVED.
10. EXISTING EXHAUST REGISTER AND DUCT DOWN TO BASEMENT FROM VENTILATING UNIT IN WALLS TO BE REMOVED.

SECTION A-A
NO SCALE

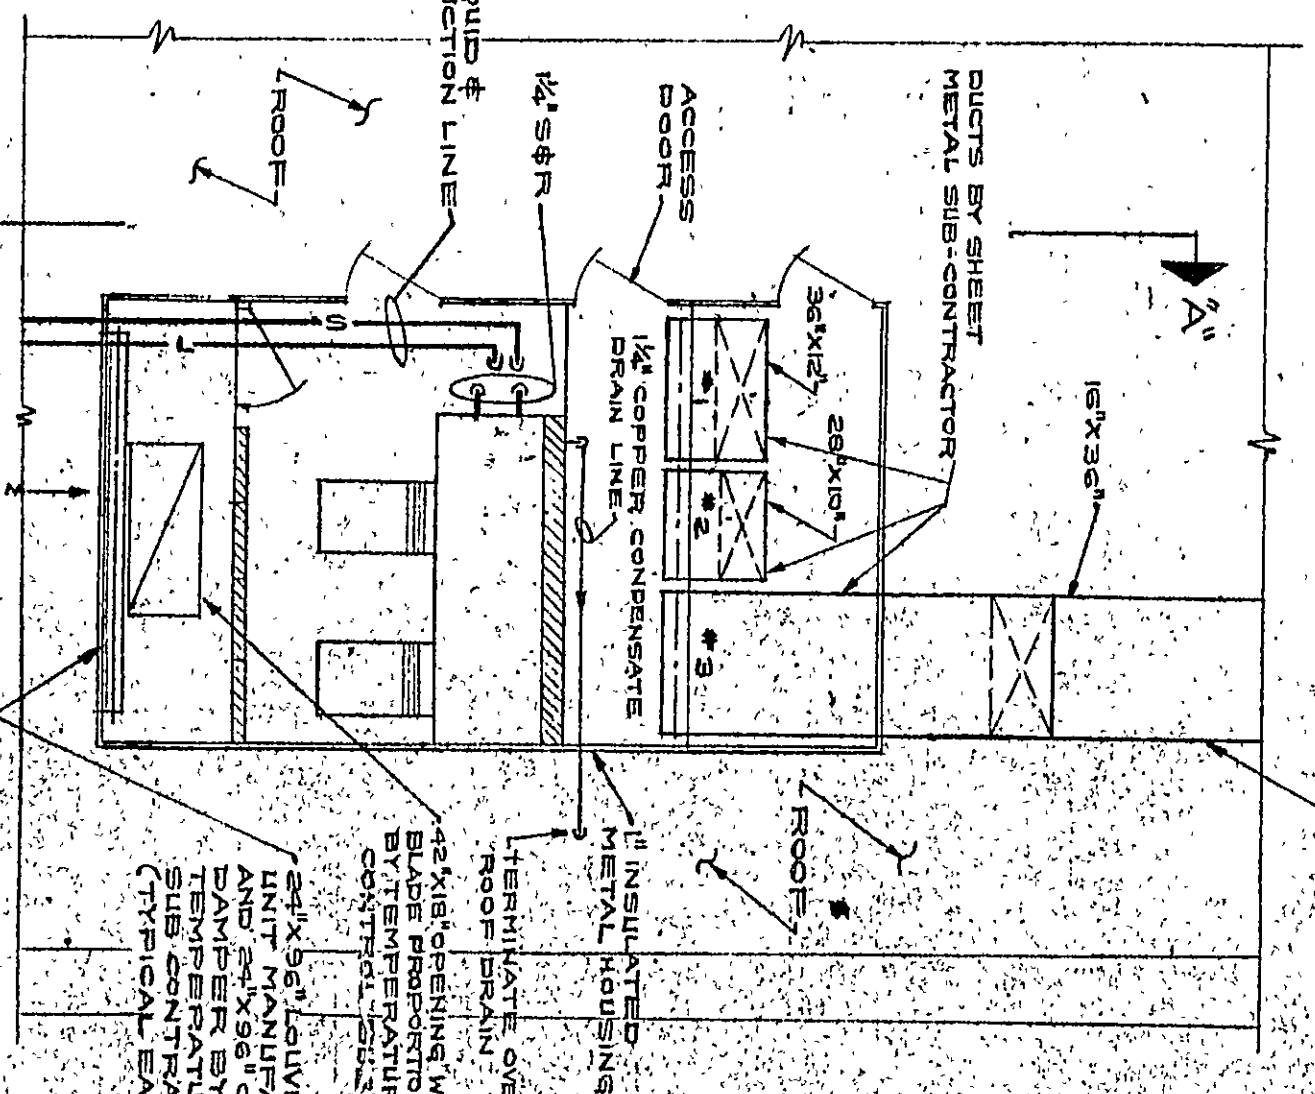

PLAN OF AIR HANDLING UNIT ON ROOF
NO SCALE

ZONE HANDLING SCHEDULE

ZONE	AREA	LOAD	UNIT	TYPE	SIZE
1	CLAS	2,000	1	16" X 24"	16" X 24"
2	CLAS	2,000	1	16" X 24"	16" X 24"
3	CLAS	2,000	1	16" X 24"	16" X 24"

KEY PLAN
NO SCALE

