



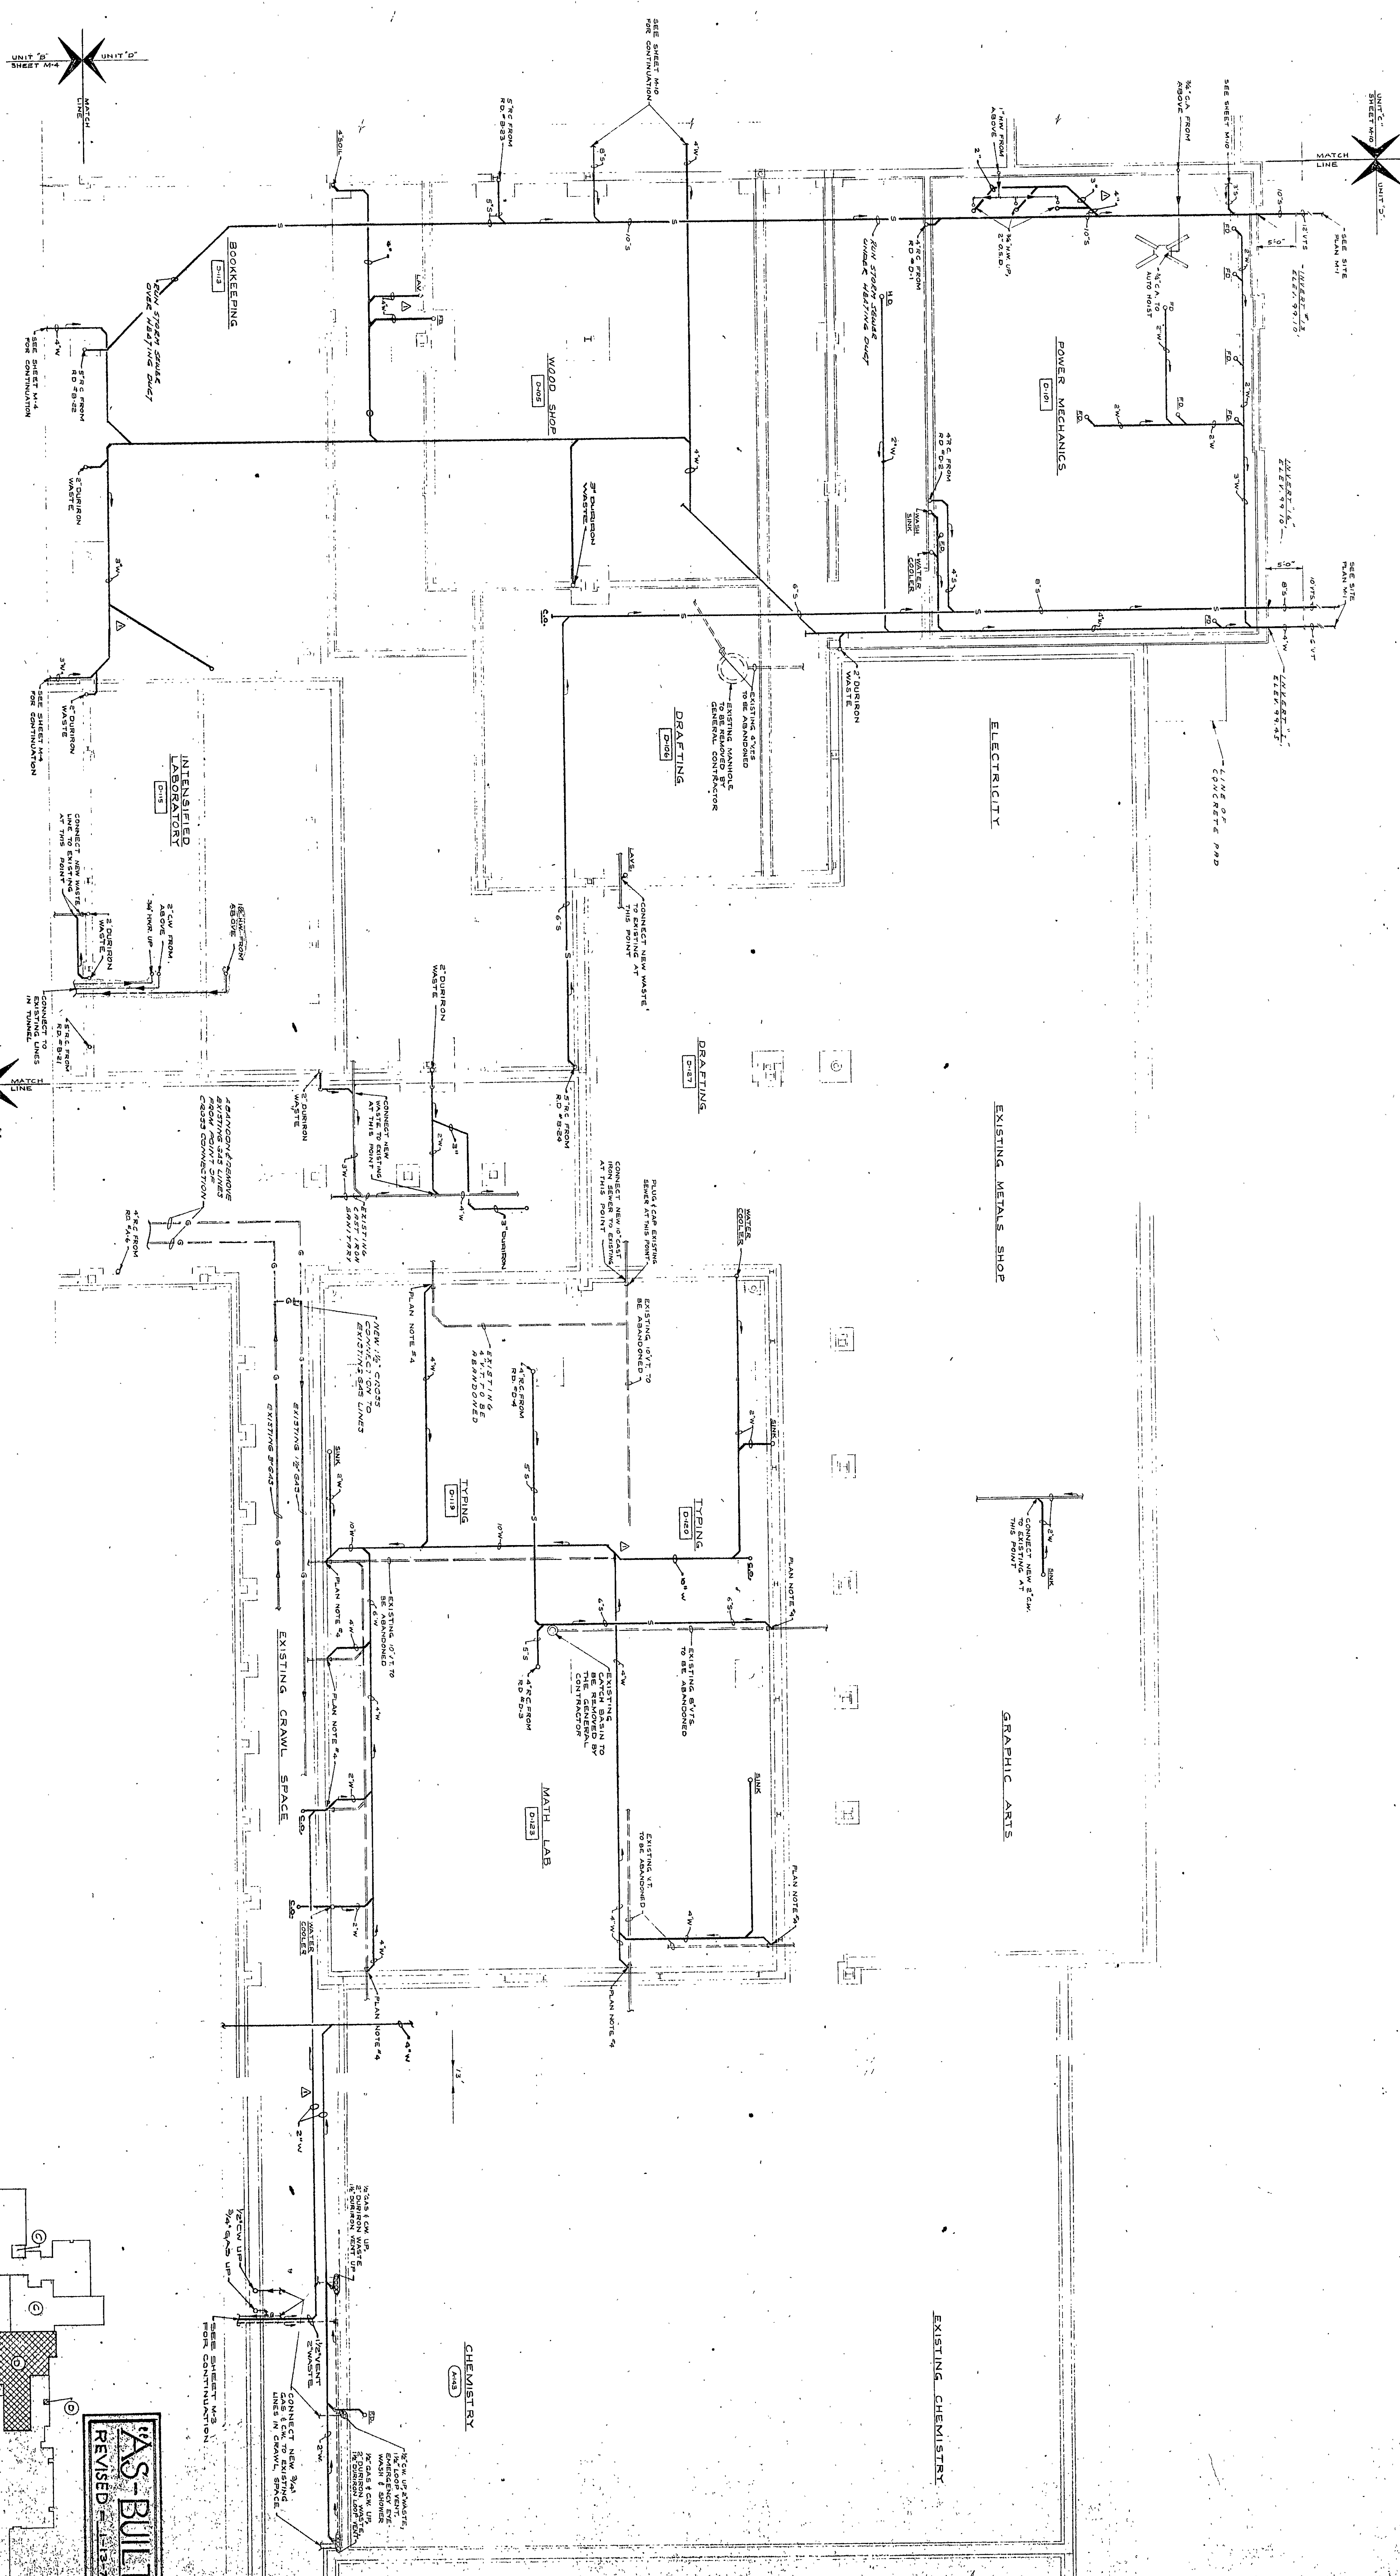

UNIT 'D' PLUMBING FOUNDATION PLAN
SCALE 1/8" = 1'-0"

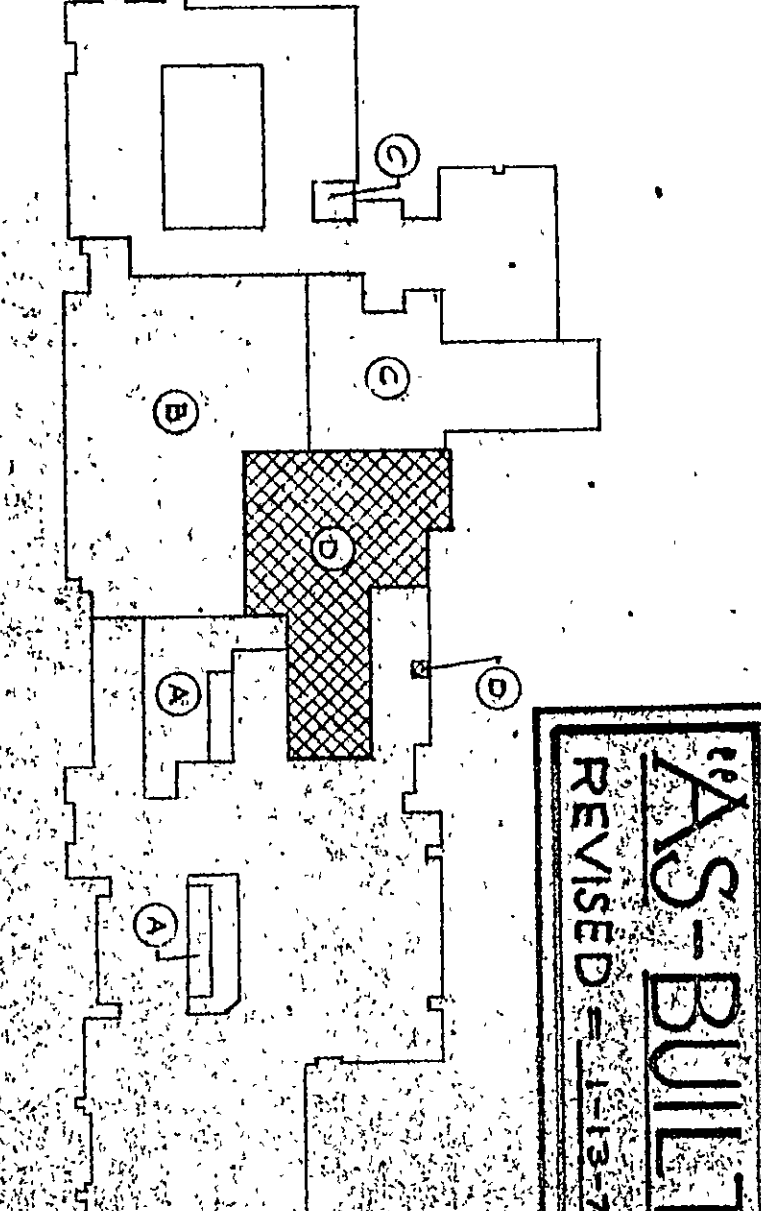

REVISION NUMBER SHEET 169-76
EVERETT - I. BROWN COMPANY - ARCHITECTS & ENGINEERS
5500 BRADLEY AVENUE - PARKFLETCHER
INDIANAPOLIS - INDIANA
SHEET W-17 OF 33
ADDITION TO CHESTERION HIGH SCHOOL

PLAN NOTES
1. ALL NEW WORK SHALL BE SHOWN WITH A DASH-dot-dot LINE.
2. ALL EXISTING WORK SHALL BE SHOWN WITH A DASH-dot LINE.
3. ALL EXISTING WORK SHALL BE SHOWN WITH A DASH-dot LINE.
4. ALL EXISTING WORK SHALL BE SHOWN WITH A DASH-dot LINE.
5. ALL EXISTING WORK SHALL BE SHOWN WITH A DASH-dot LINE.