


NOTE:
ALL WIRE TO BE
CONDUIT RATED
FOR 600 VOLTS
SIGNATURE TYPE
SIGNATURE TYPE
SIGNATURE TYPE

PROPERTY LINE

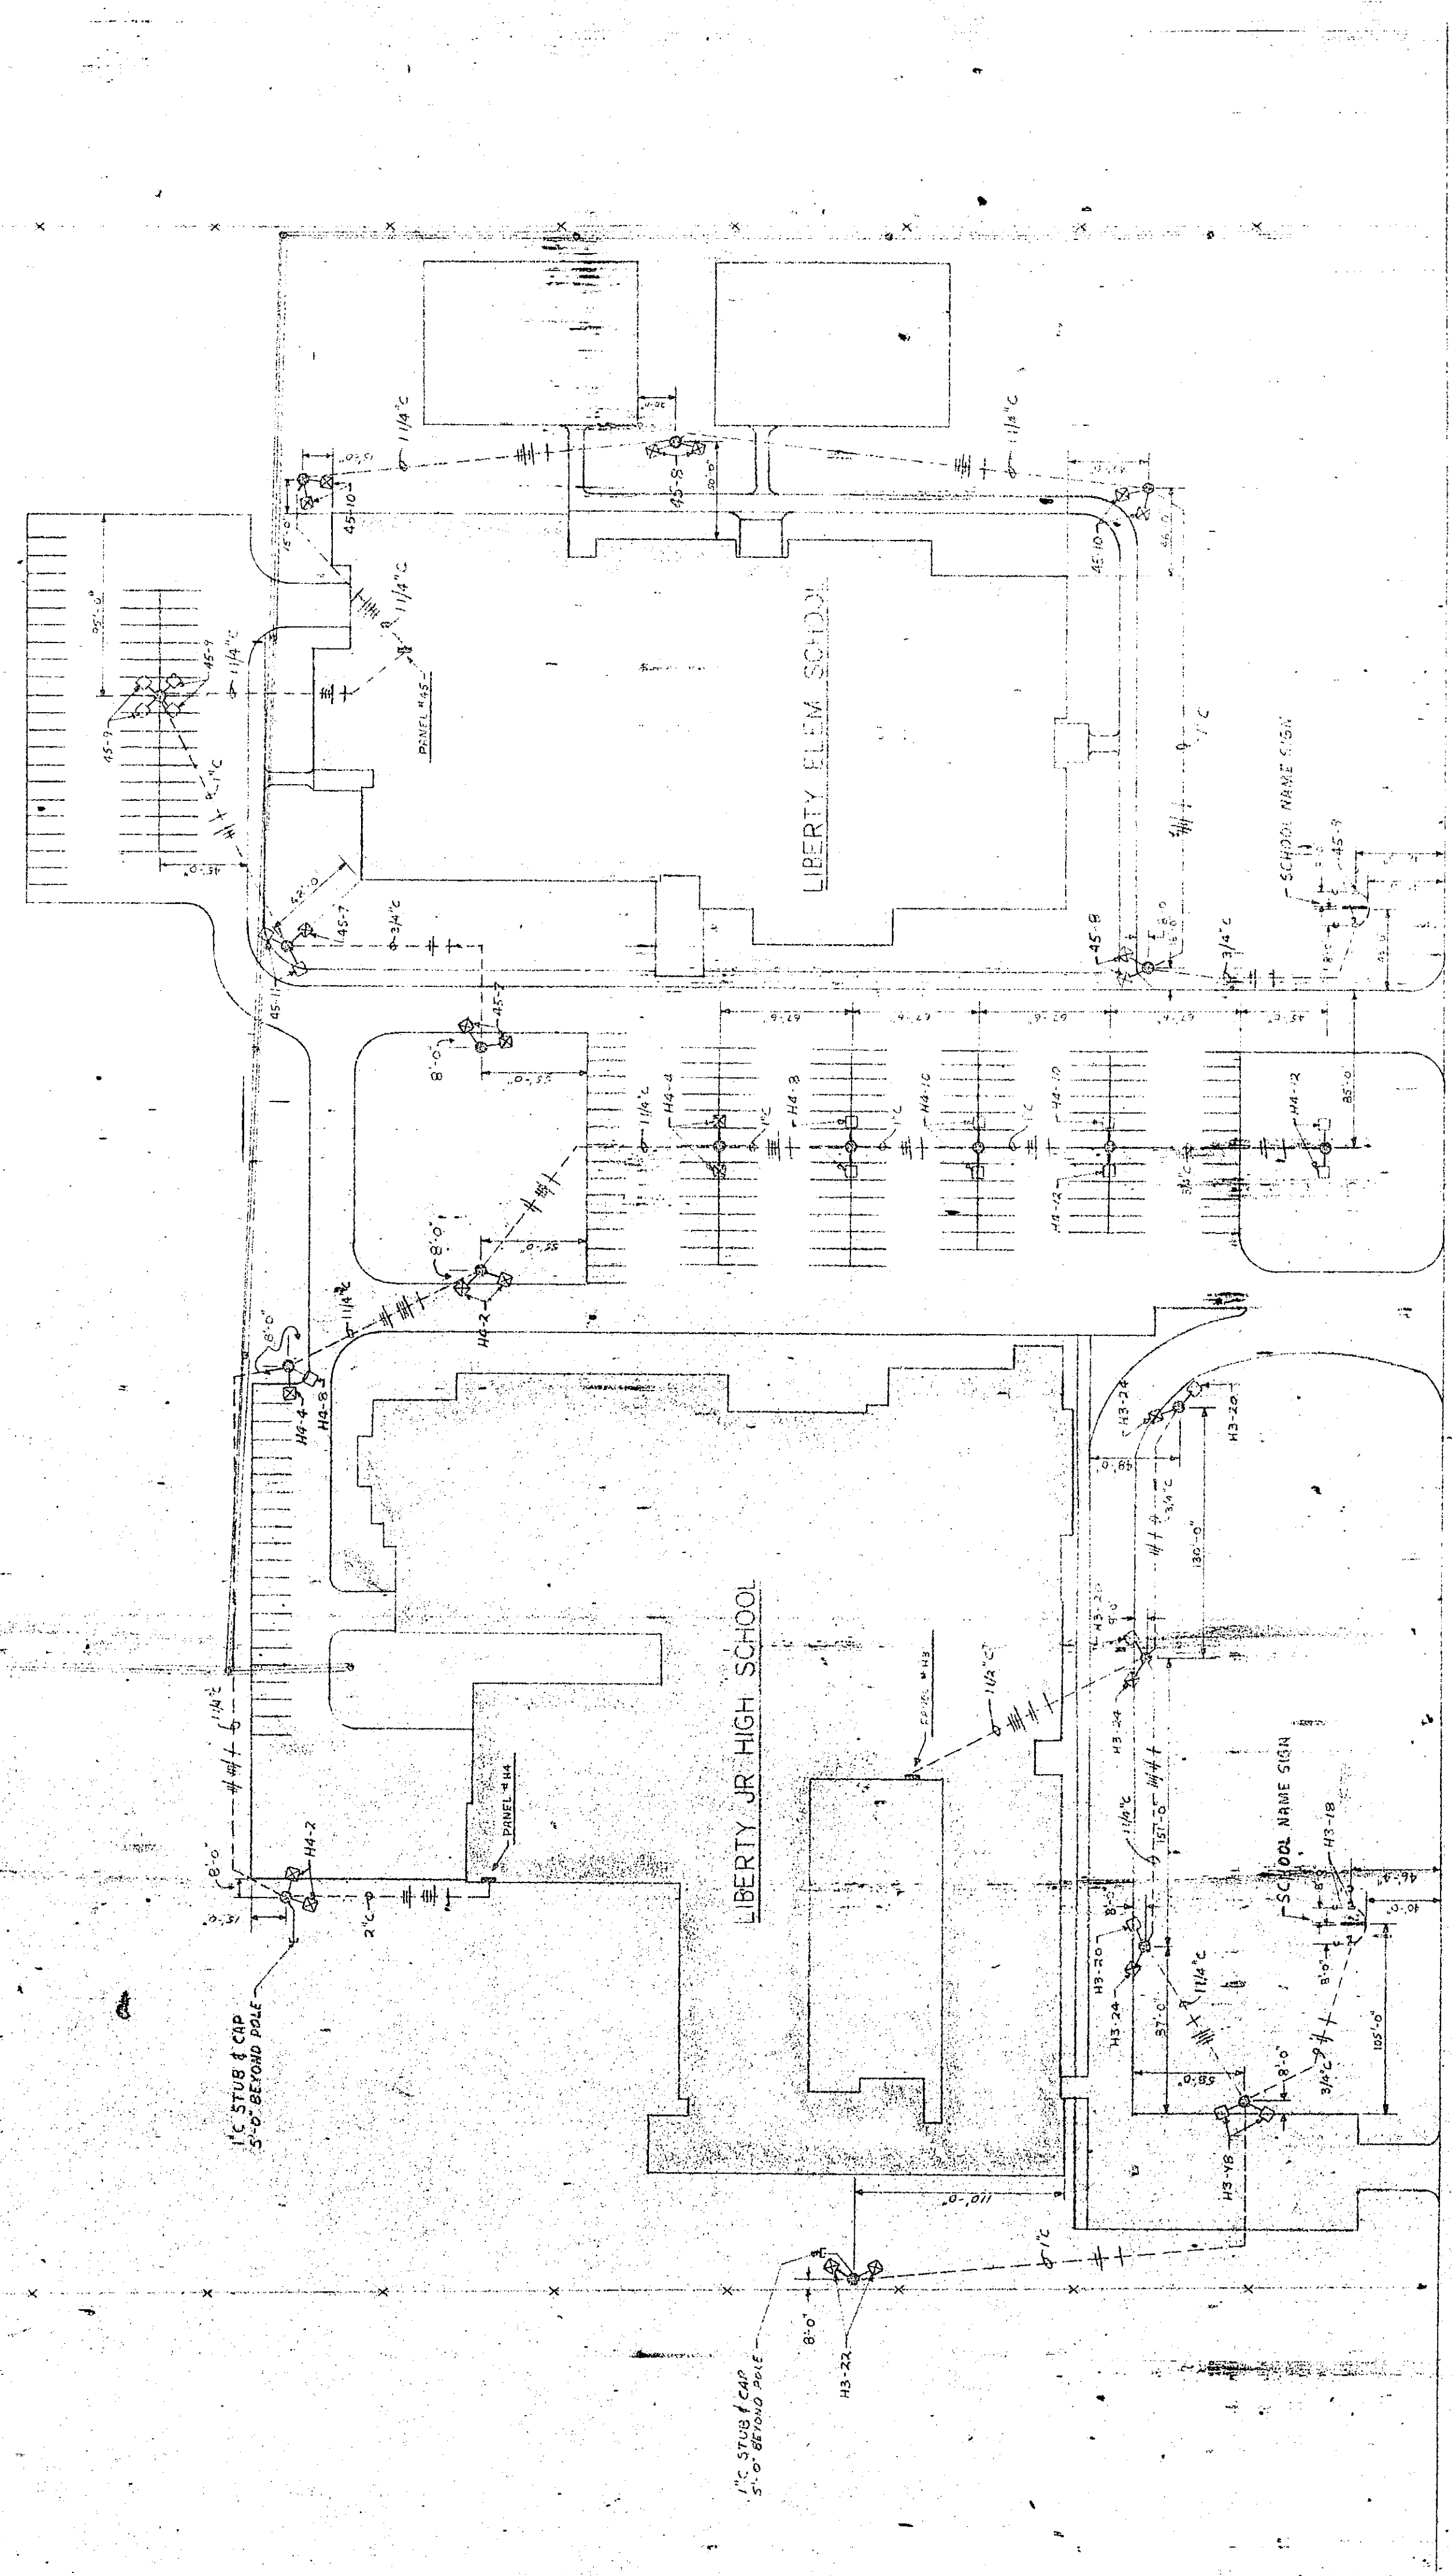

ELECTRICAL SITE PLAN

OUTSIDE LIGHTING	
SCALE: 1"=50'-0"	DRAWN BY: JFE
DATE: 2/16/71	REVISIONS:
LIBERTY JR. & LIBERTY ELEM. SCHOOLS	
DRAWING NUMBER: E-1	

1/16/71

537 5W7