


GENERAL NOTES

- 4-1 ALL CONTRACTORS SHALL VERIFY ALL EXISTING FLOOR ELEVATIONS AND DIMENSIONS OF EXISTING BUILDING RELATED TO NEW WORK.
- 4-2 ALL CONTRACTORS SHALL CHECK ALL PLANS, SPECIFICATIONS, AND ETC. FOR EXTENT OF REMODELING WORK.
- 4-3 ALL ITEMS OF EQUIPMENT OR MATERIALS NOT MARKED OR INDICATED AS EXISTING ARE NEW AND SHALL BE FURNISHED BY THE APPROPRIATE CONTRACTOR.

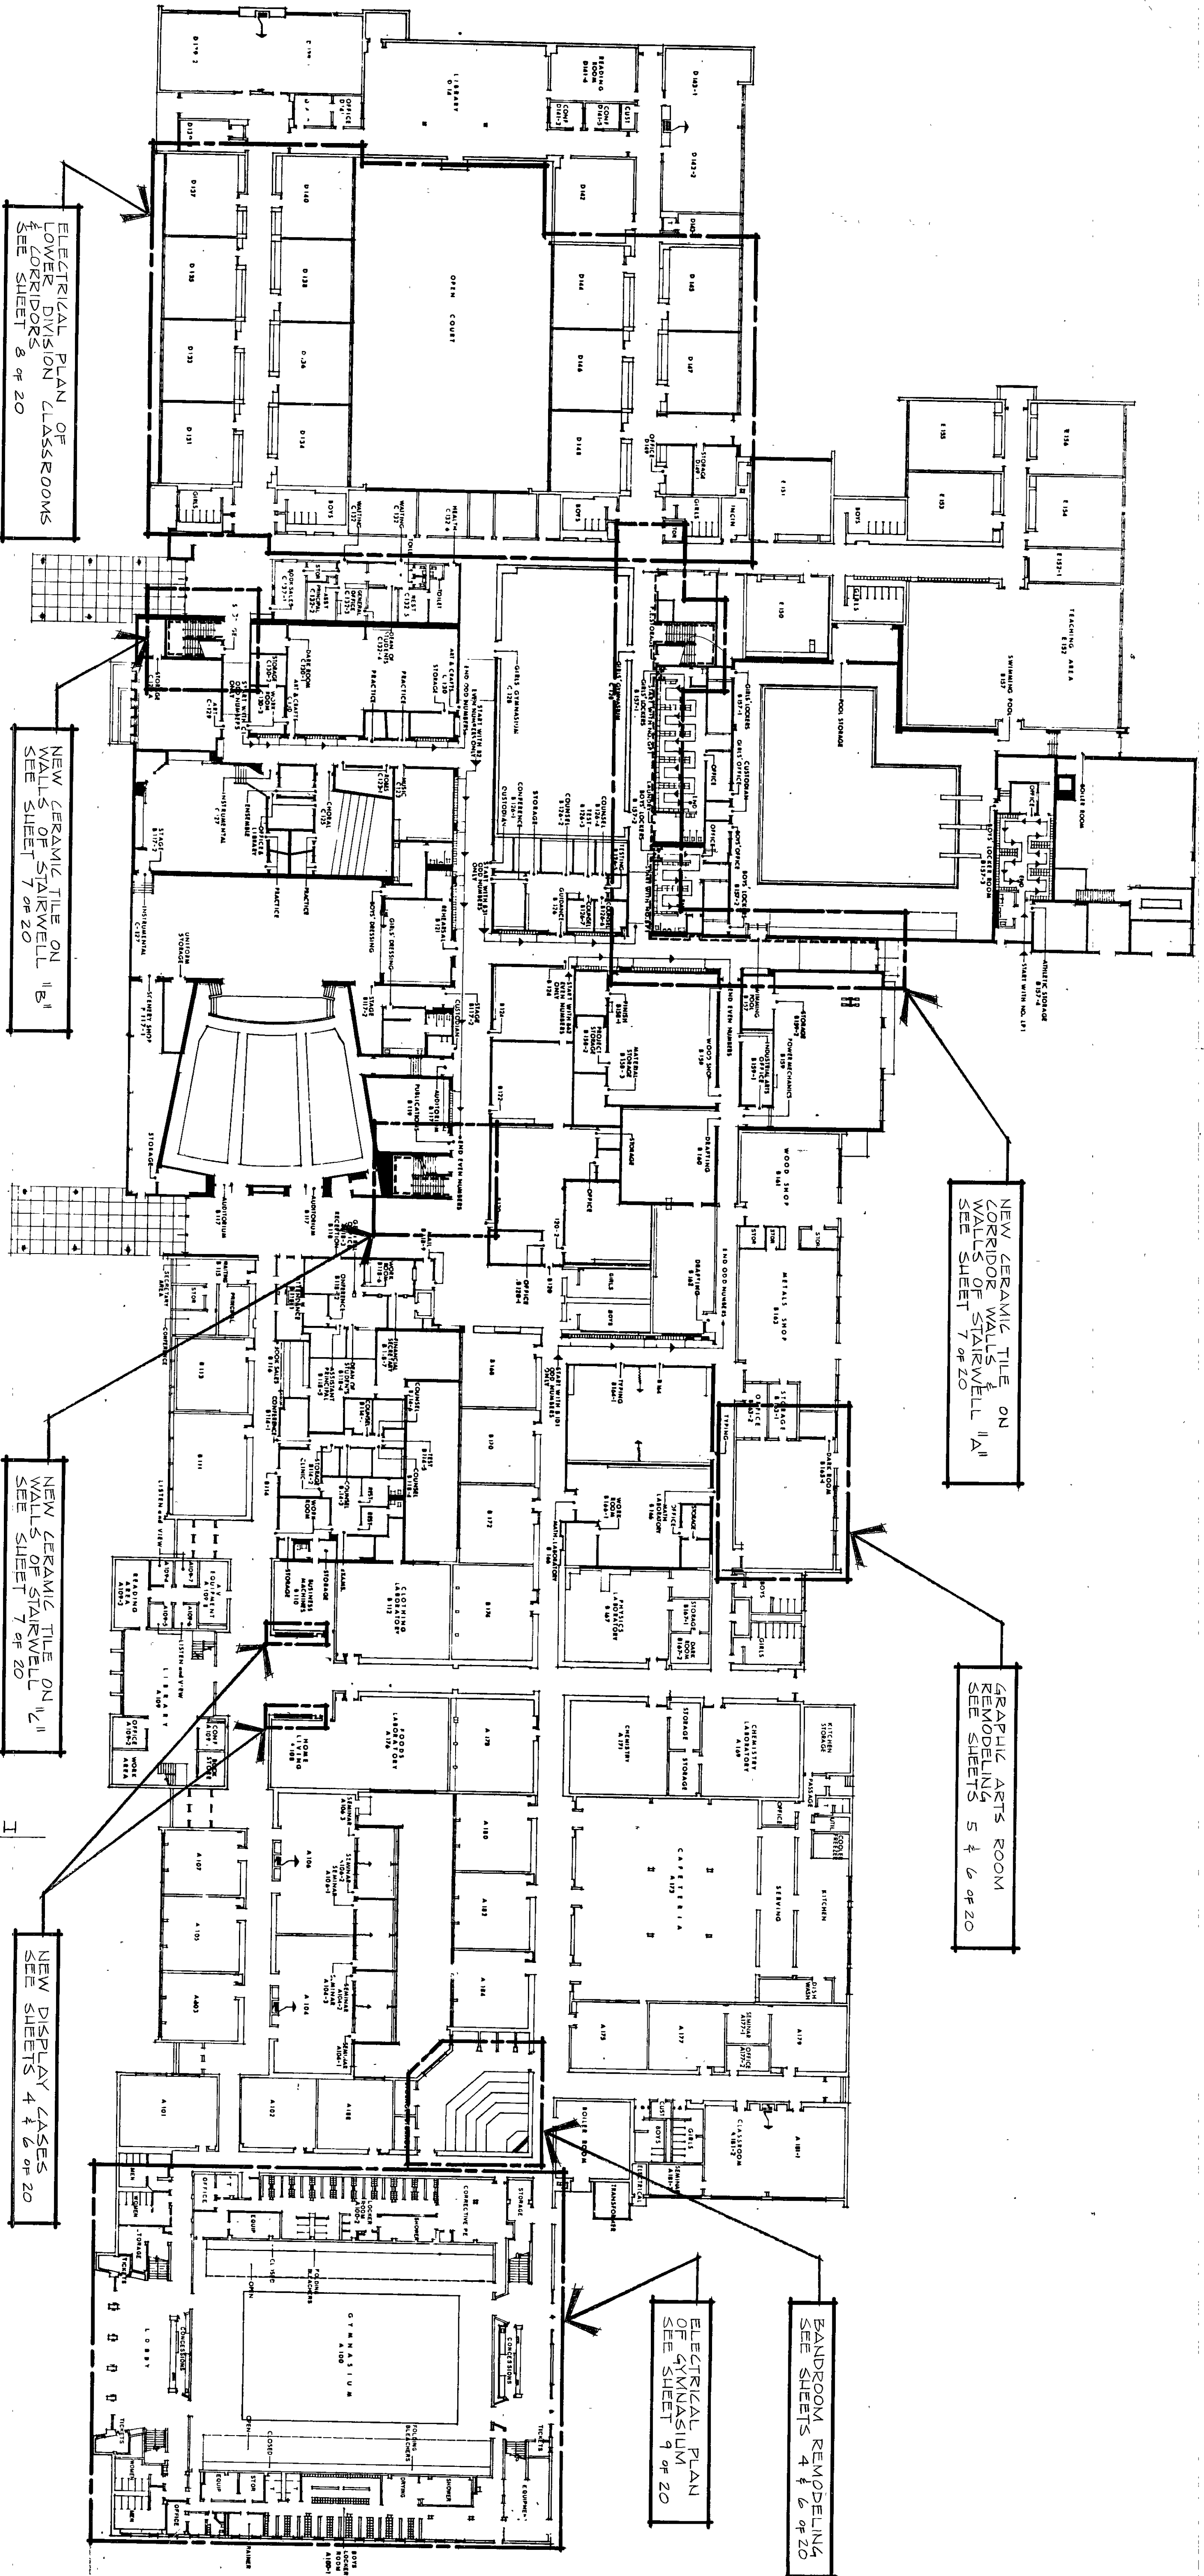

ELECTRICAL PLAN OF LOWER DIVISION CLASSROOMS & CORRIDORS SEE SHEET 8 OF 20

NEW CERAMIC TILE ON WALLS OF STAIRWELL "B" SEE SHEET 7 OF 20

NEW CERAMIC TILE ON CORRIDOR WALLS & WALLS OF STAIRWELL "A" SEE SHEET 7 OF 20

GRAPHIC ARTS ROOM REMODELING SEE SHEETS 5 & 6 OF 20


BANDROOM REMODELING SEE SHEETS 4 & 6 OF 20

ELECTRICAL PLAN OF GYMNASIUM SEE SHEET 9 OF 20

NEW DISPLAY CASES SEE SHEETS 4 & 6 OF 20

CHESTERTON SENIOR HIGH SCHOOL
FIRST FLOOR PLAN
SCALE: 1/8" = 1'-0"

KEY PLAN

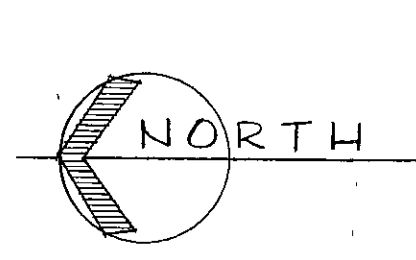

MATERIAL INDICATIONS

- CONCRETE
- LIGHTWEIGHT BLOCK
- WOOD BLOCKING
- FINISH WOOD
- METAL PANEL
- STEEL
- ELEVATION
- DETAIL
- SECTION

VERETT · I. BROWN COMPANY
ARCHITECTS
ENGINEERS
WEST BRADBURY AVENUE · PARK FLETCHER · INDIANAPOLIS, INDIANA · 46241

LANEIOUS REMODEL
TERTON SENIOR HIGH SCHOOL

ROBERT STANLEY HILL
REGISTERED
No. 1449
STATE OF INDIANA
ARCHITECT

PROJECT
2575
DATE
APRIL 12, 1976
REVISED

NO. 1