



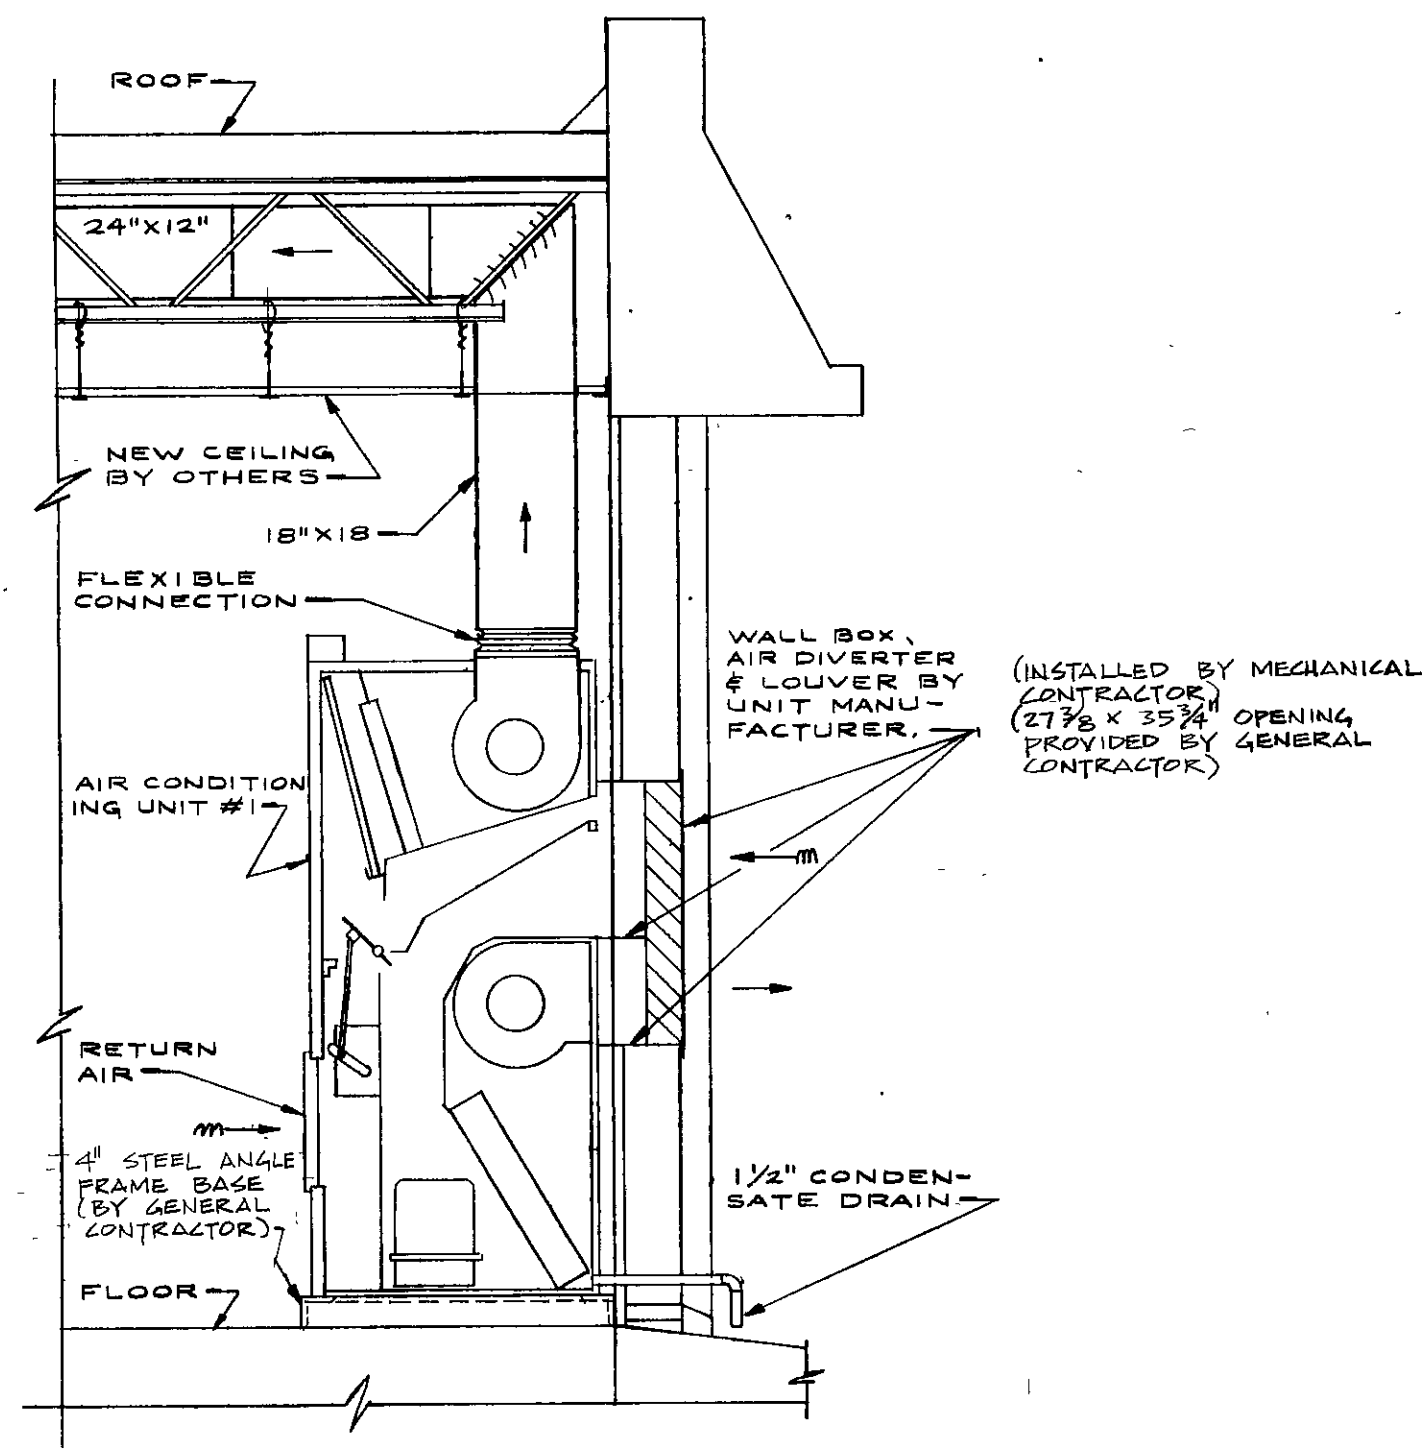


SECTION "A-A"
SCALE: 1/8" = 1'-0"

MECHANICAL PLAN NOTES


- M-1 See Sheet 16 for general notes and legends.
- M-2 Air Conditioning Unit #1 - EDPAC Model SA-6 vertical unit air conditioner, cooling only. 1800 cfm, 20% minimum outdoor air capacity 64.2 MBH, compressor 6 HP, blower 3/4 condenser/exhaust blower 3/4 HP. All motors shall be 200 volt, 3 phase, 60 hertz.
- M-3 All rectangular ducts shall be lined with 1" fiberglass.
- M-4 ALL MECHANICAL WORK ON THIS SHEET SHALL BE BID IN CONTRACT # 7

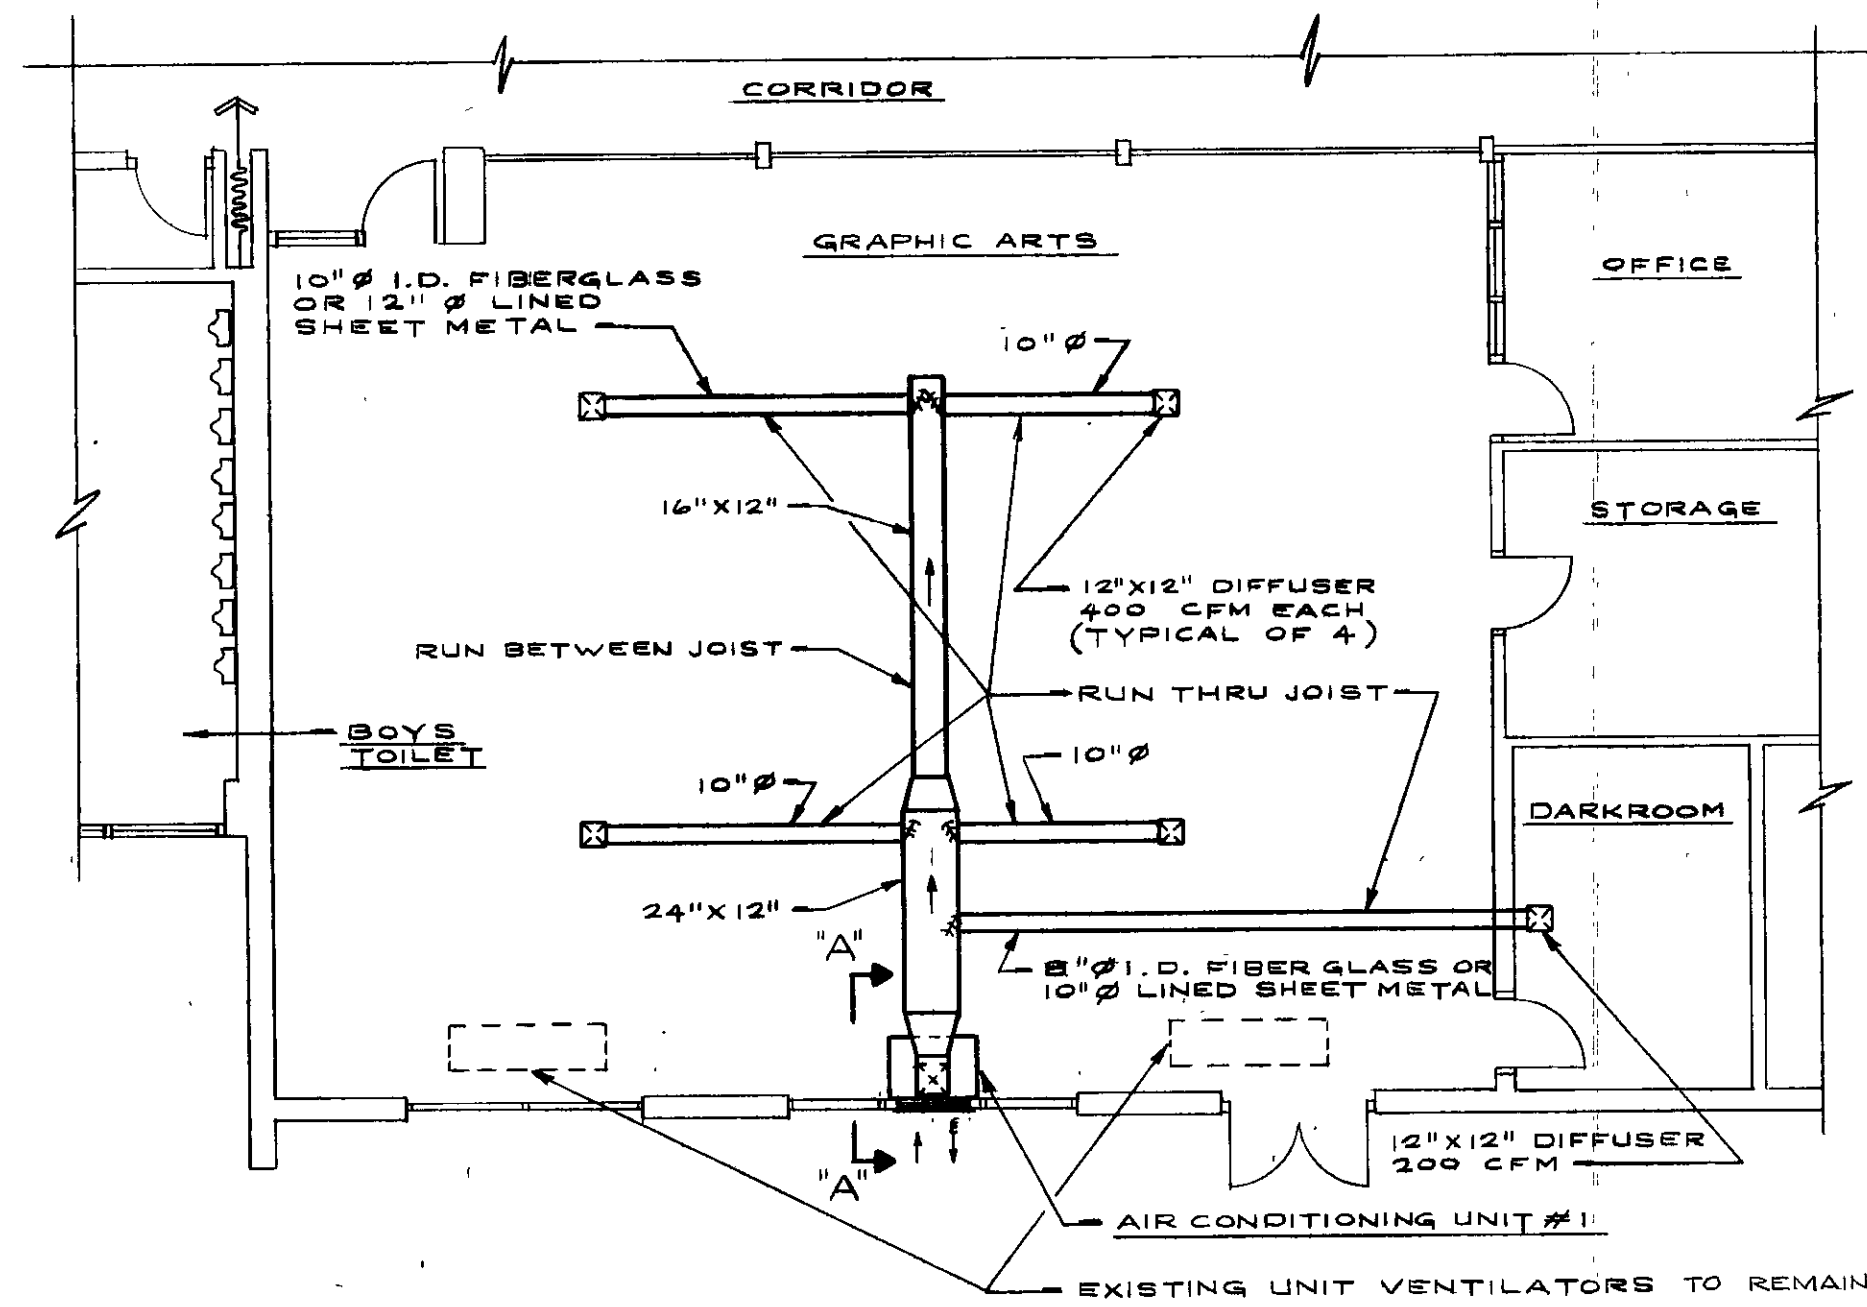


AIR CONDITIONING PLAN OF OF GRAPHIC ARTS ROOM
SCALE: 1/8" = 1'-0"

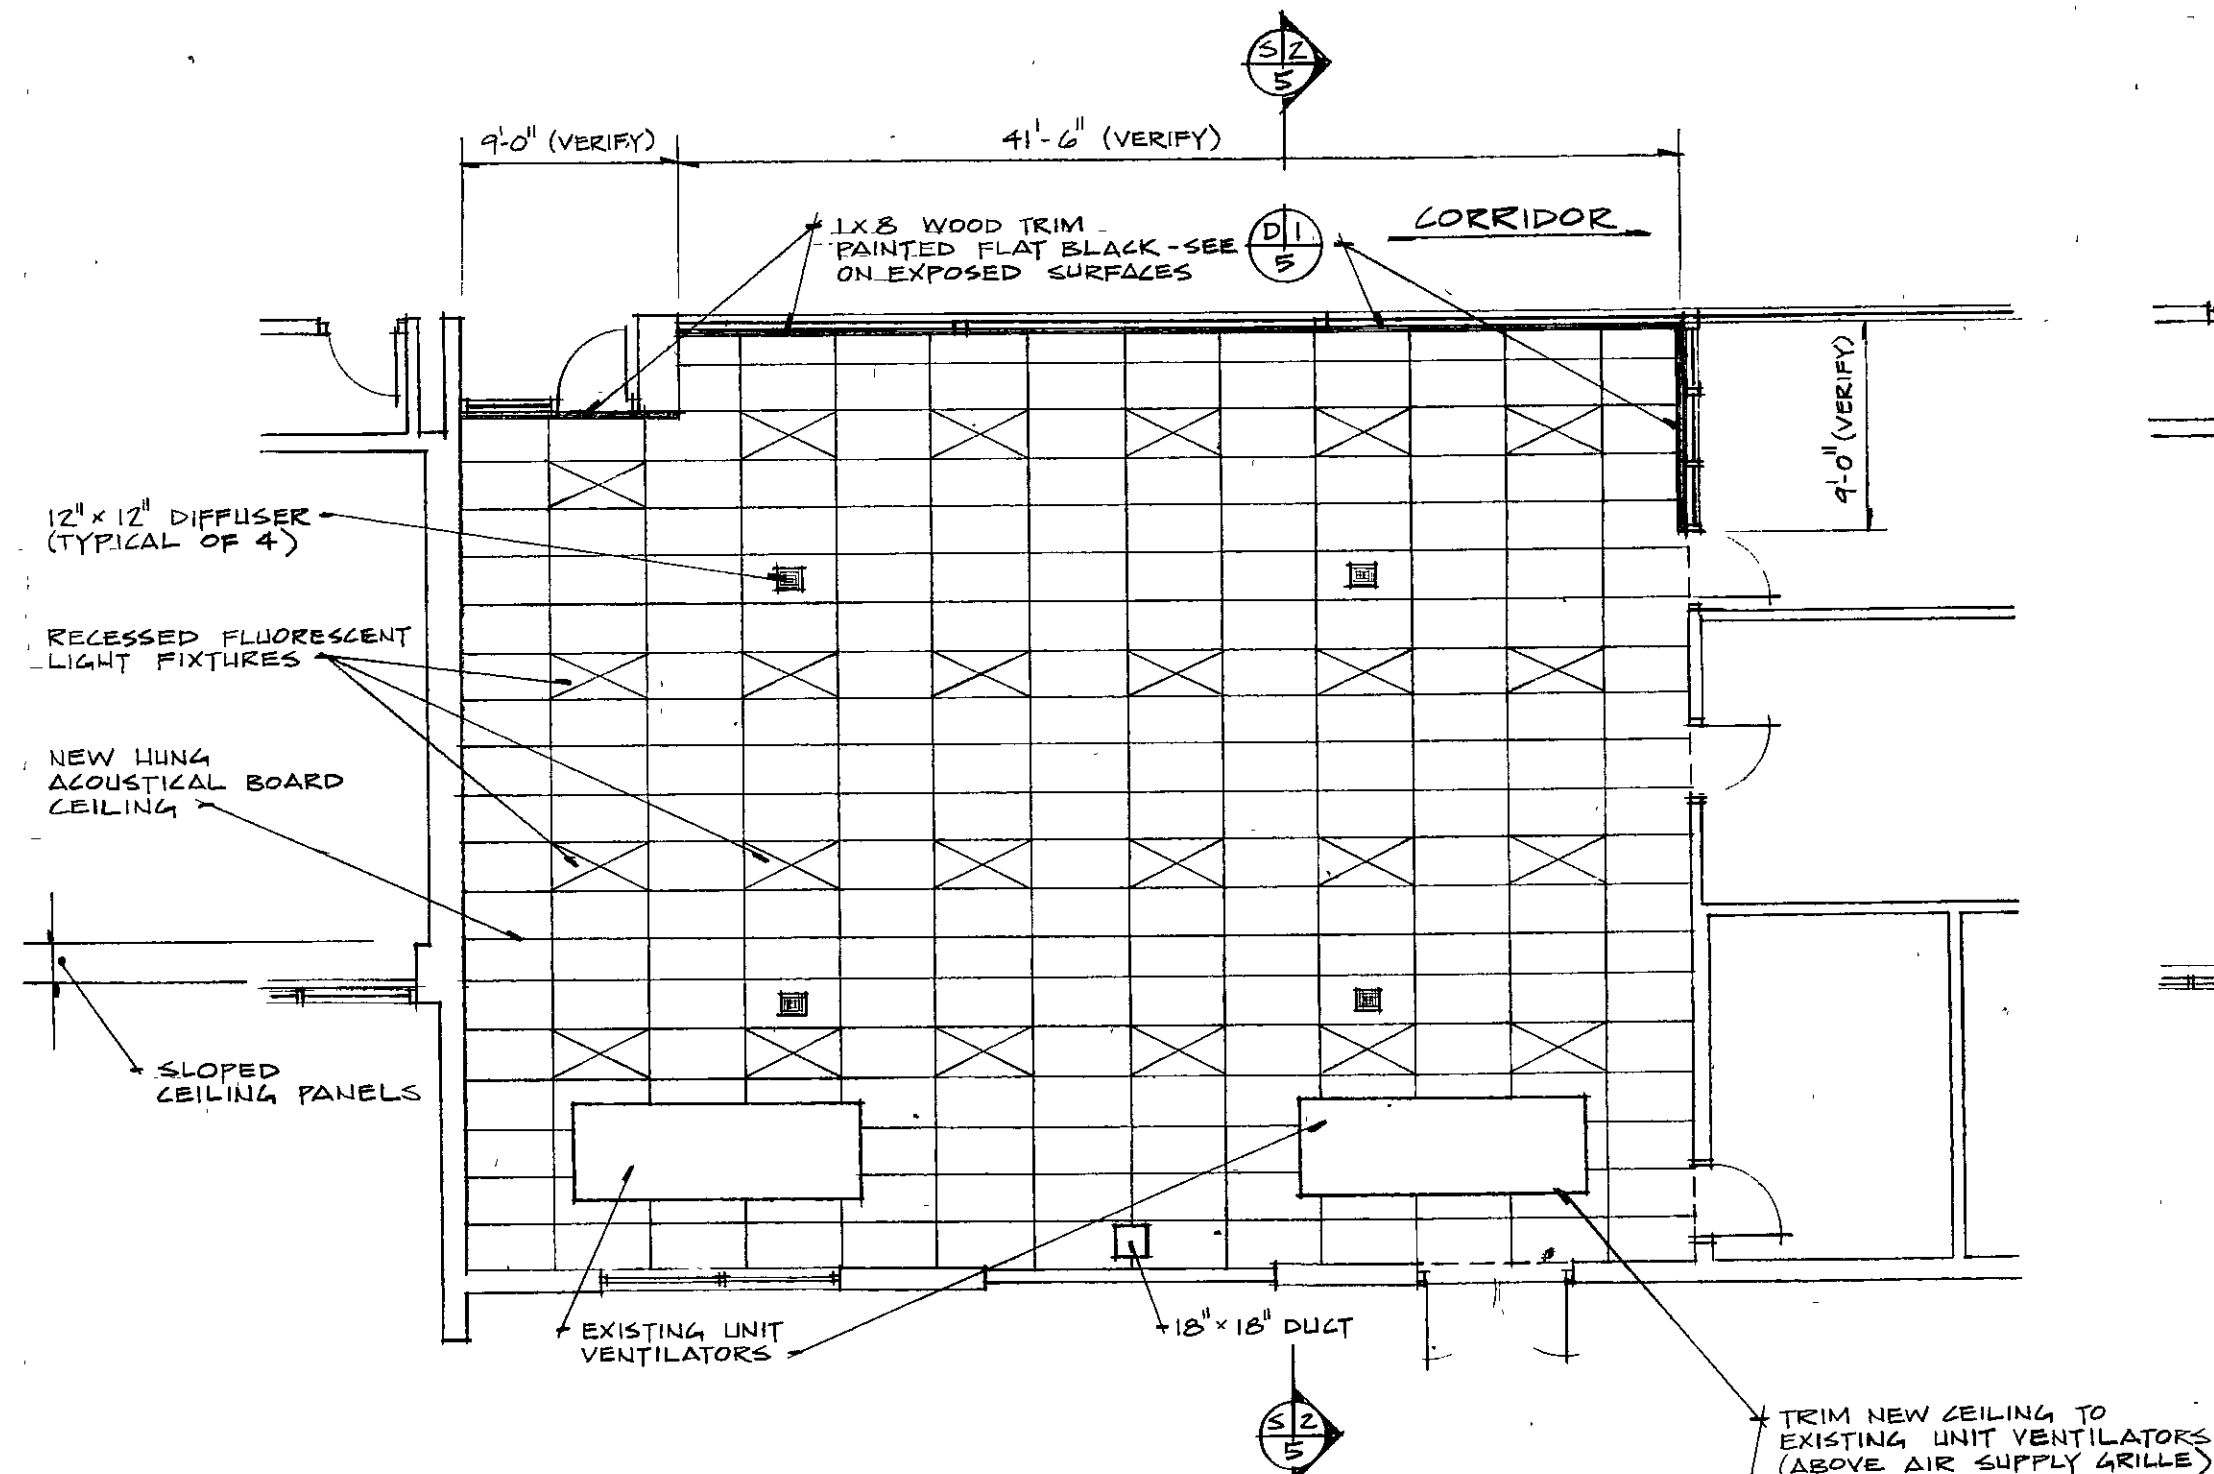


REFLECTED CEILING PLAN
SCALE: 1/8" = 1'-0"

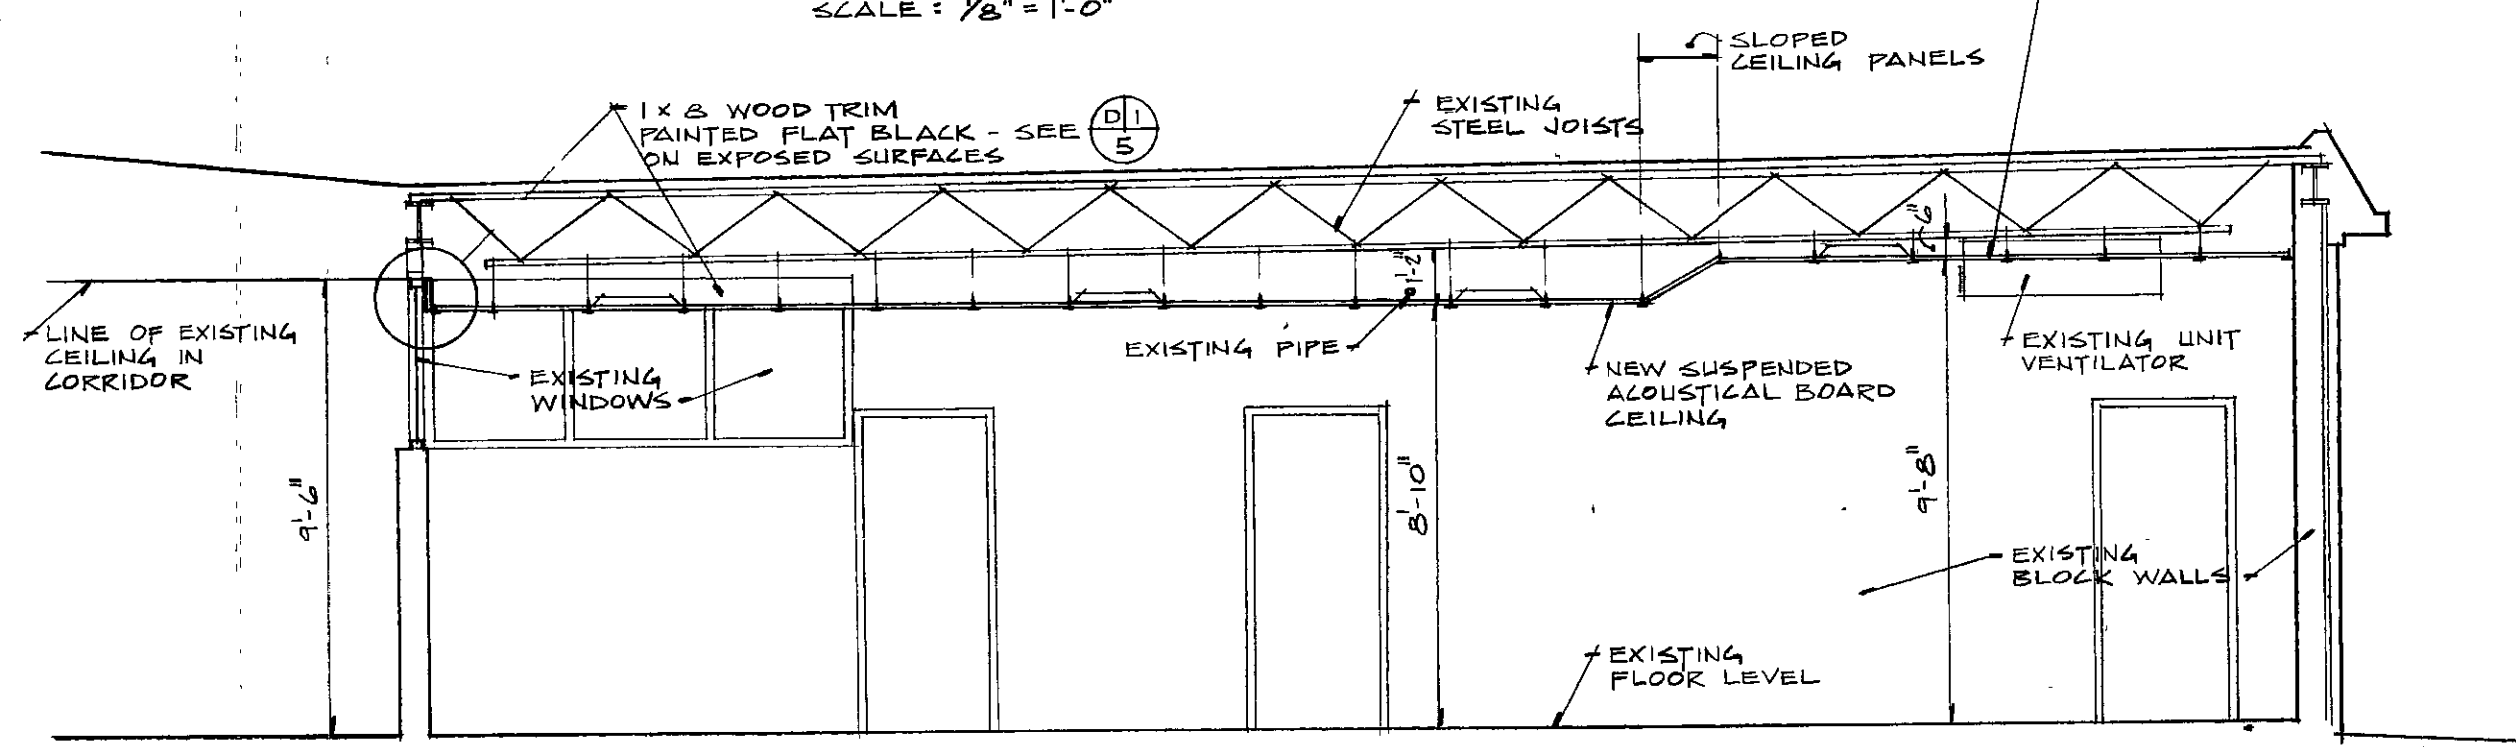


SECTION S2
SCALE: 1/4" = 1'-0"

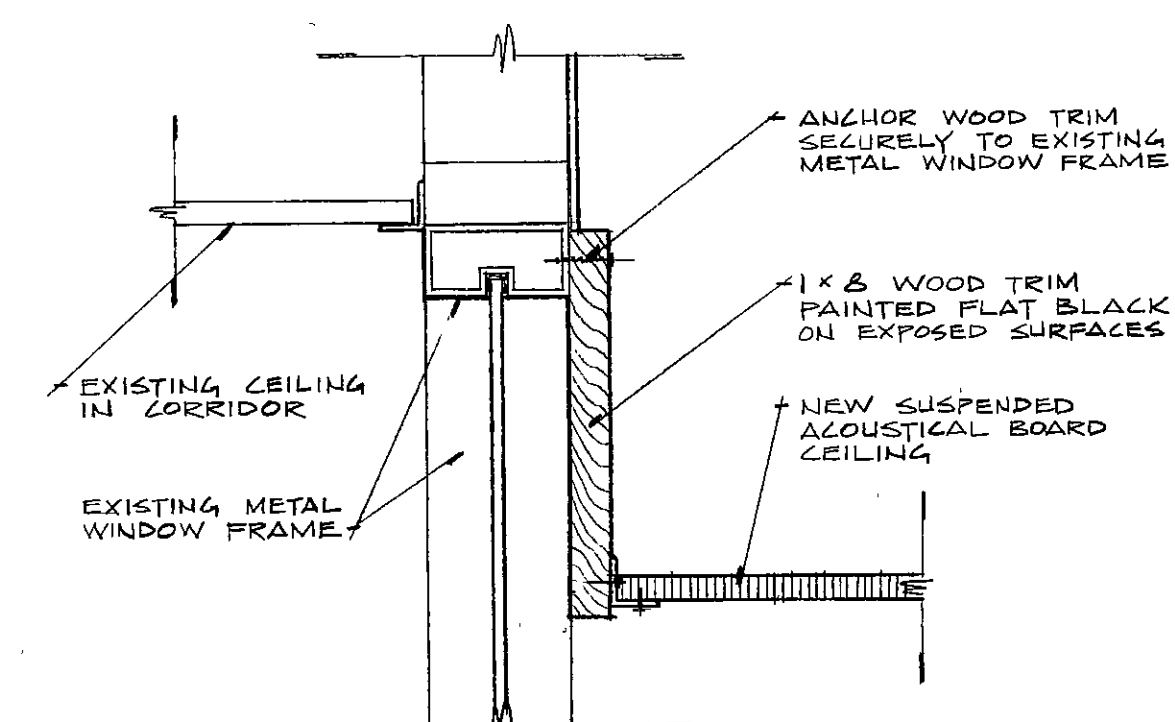


DETAIL D1
SCALE: 3" = 1'-0"

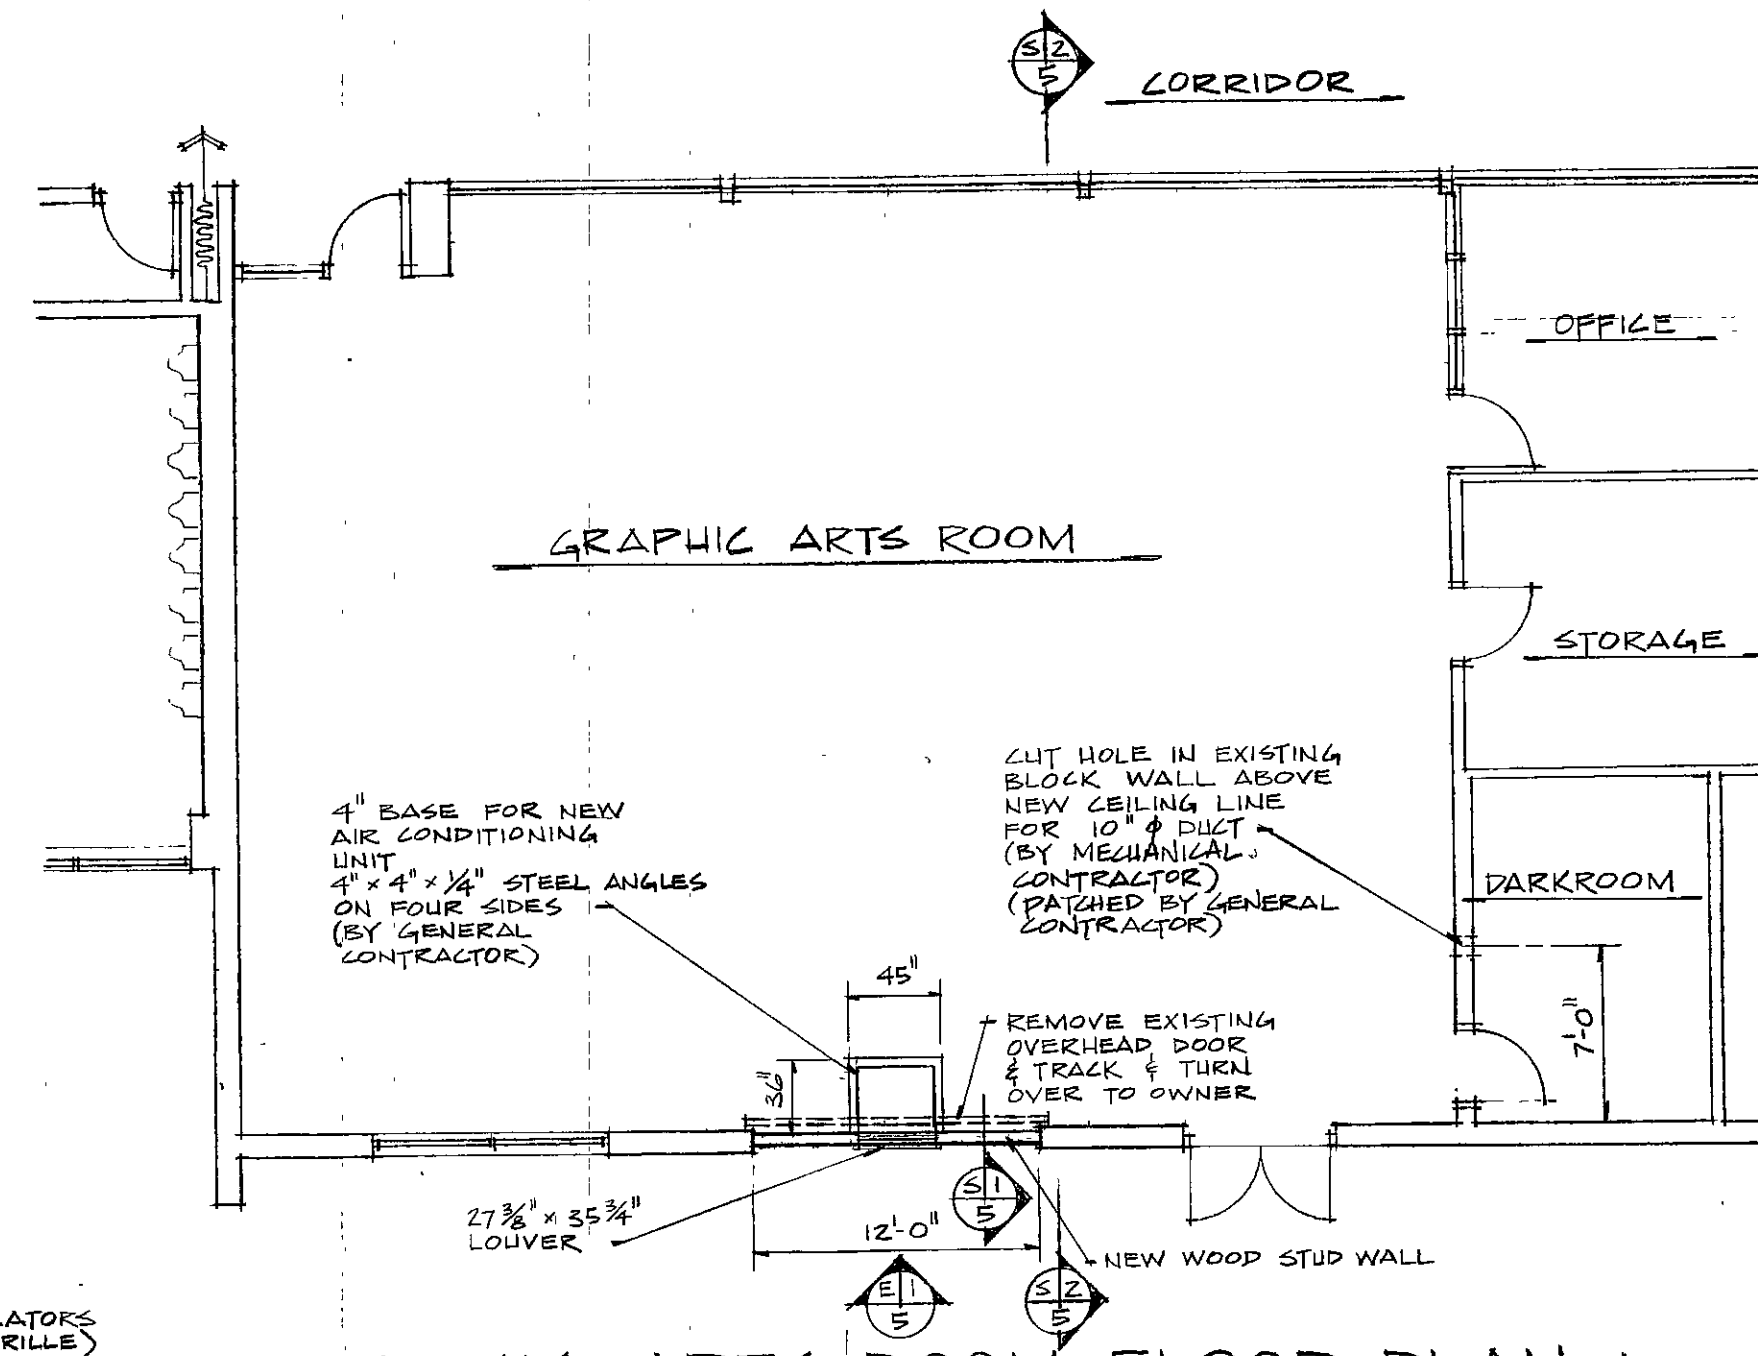

GRAPHIC ARTS ROOM FLOOR PLAN
SCALE: 1/8" = 1'-0"

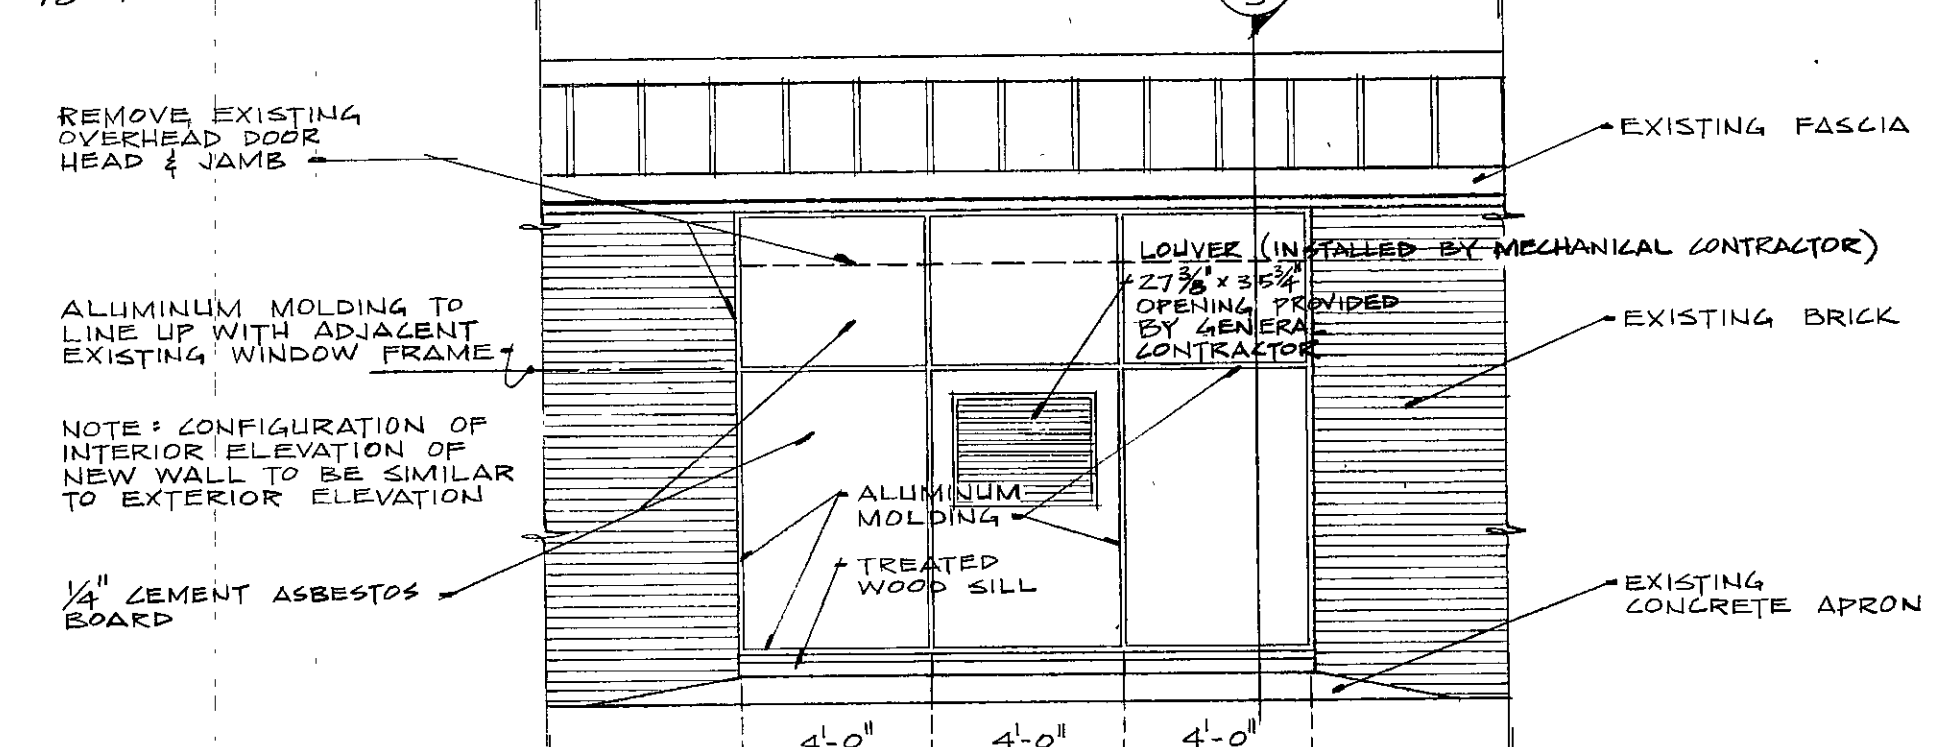

ELEVATION E1
SCALE: 1/4" = 1'-0"

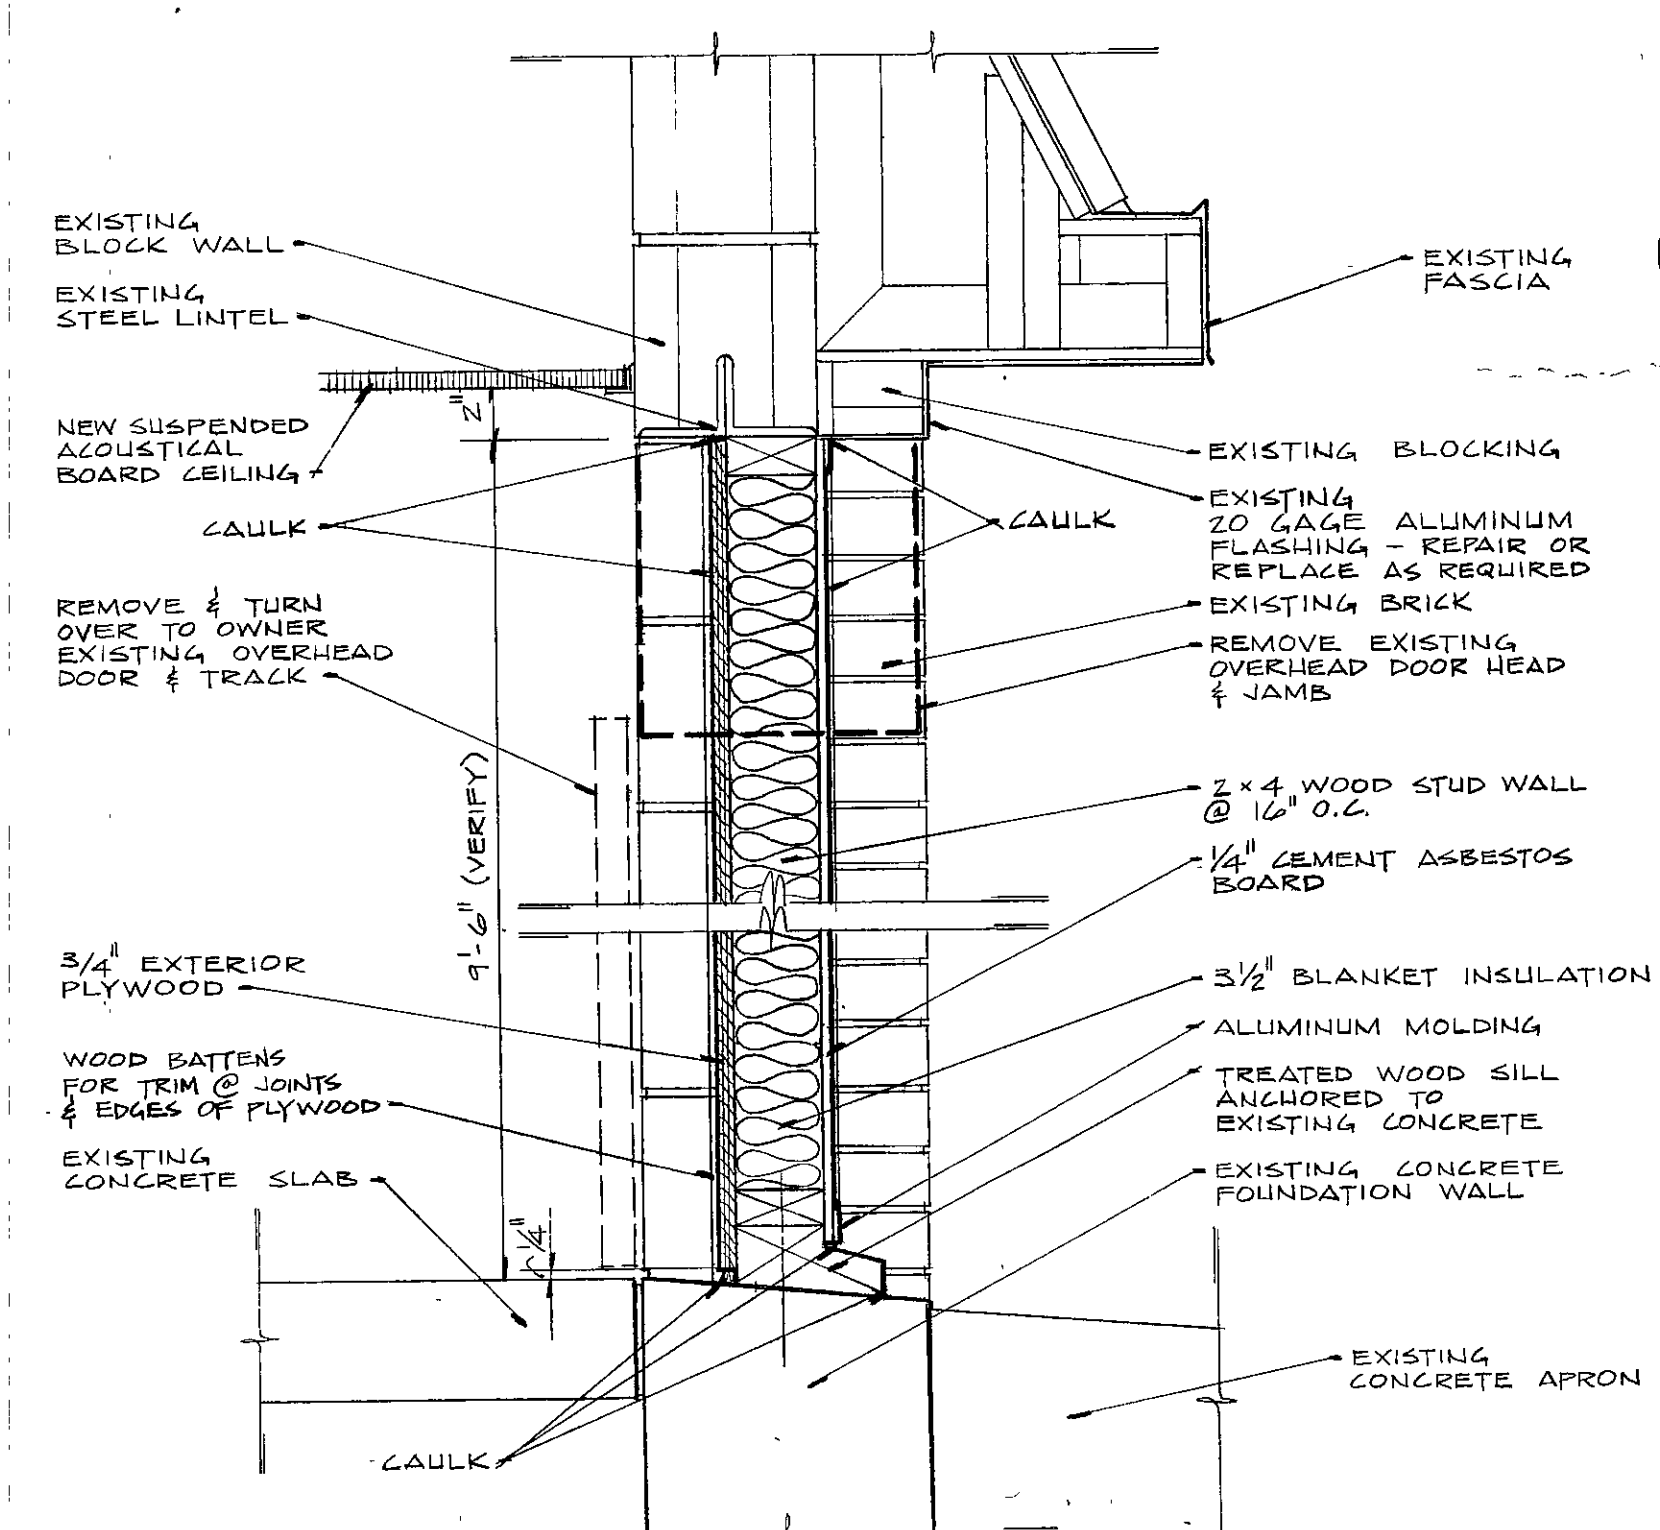

SECTION S1
SCALE: 1 1/2" = 1'-0"



ARCHITECTS
ENGINEERS
• INDIANAPOLIS, INDIANA • 46241

EVERETT I. BROWN COMPANY

5500 WEST BRADBURY AVENUE
• PARK FLETCHER •

PROJECT	2575
DATE	APRIL 12, 1976
REVISION	

NO. **5**
OF **20**

MISCELLANEOUS REMODELING TO THE EXISTING CHESTERTON SENIOR HIGH SCHOOL