


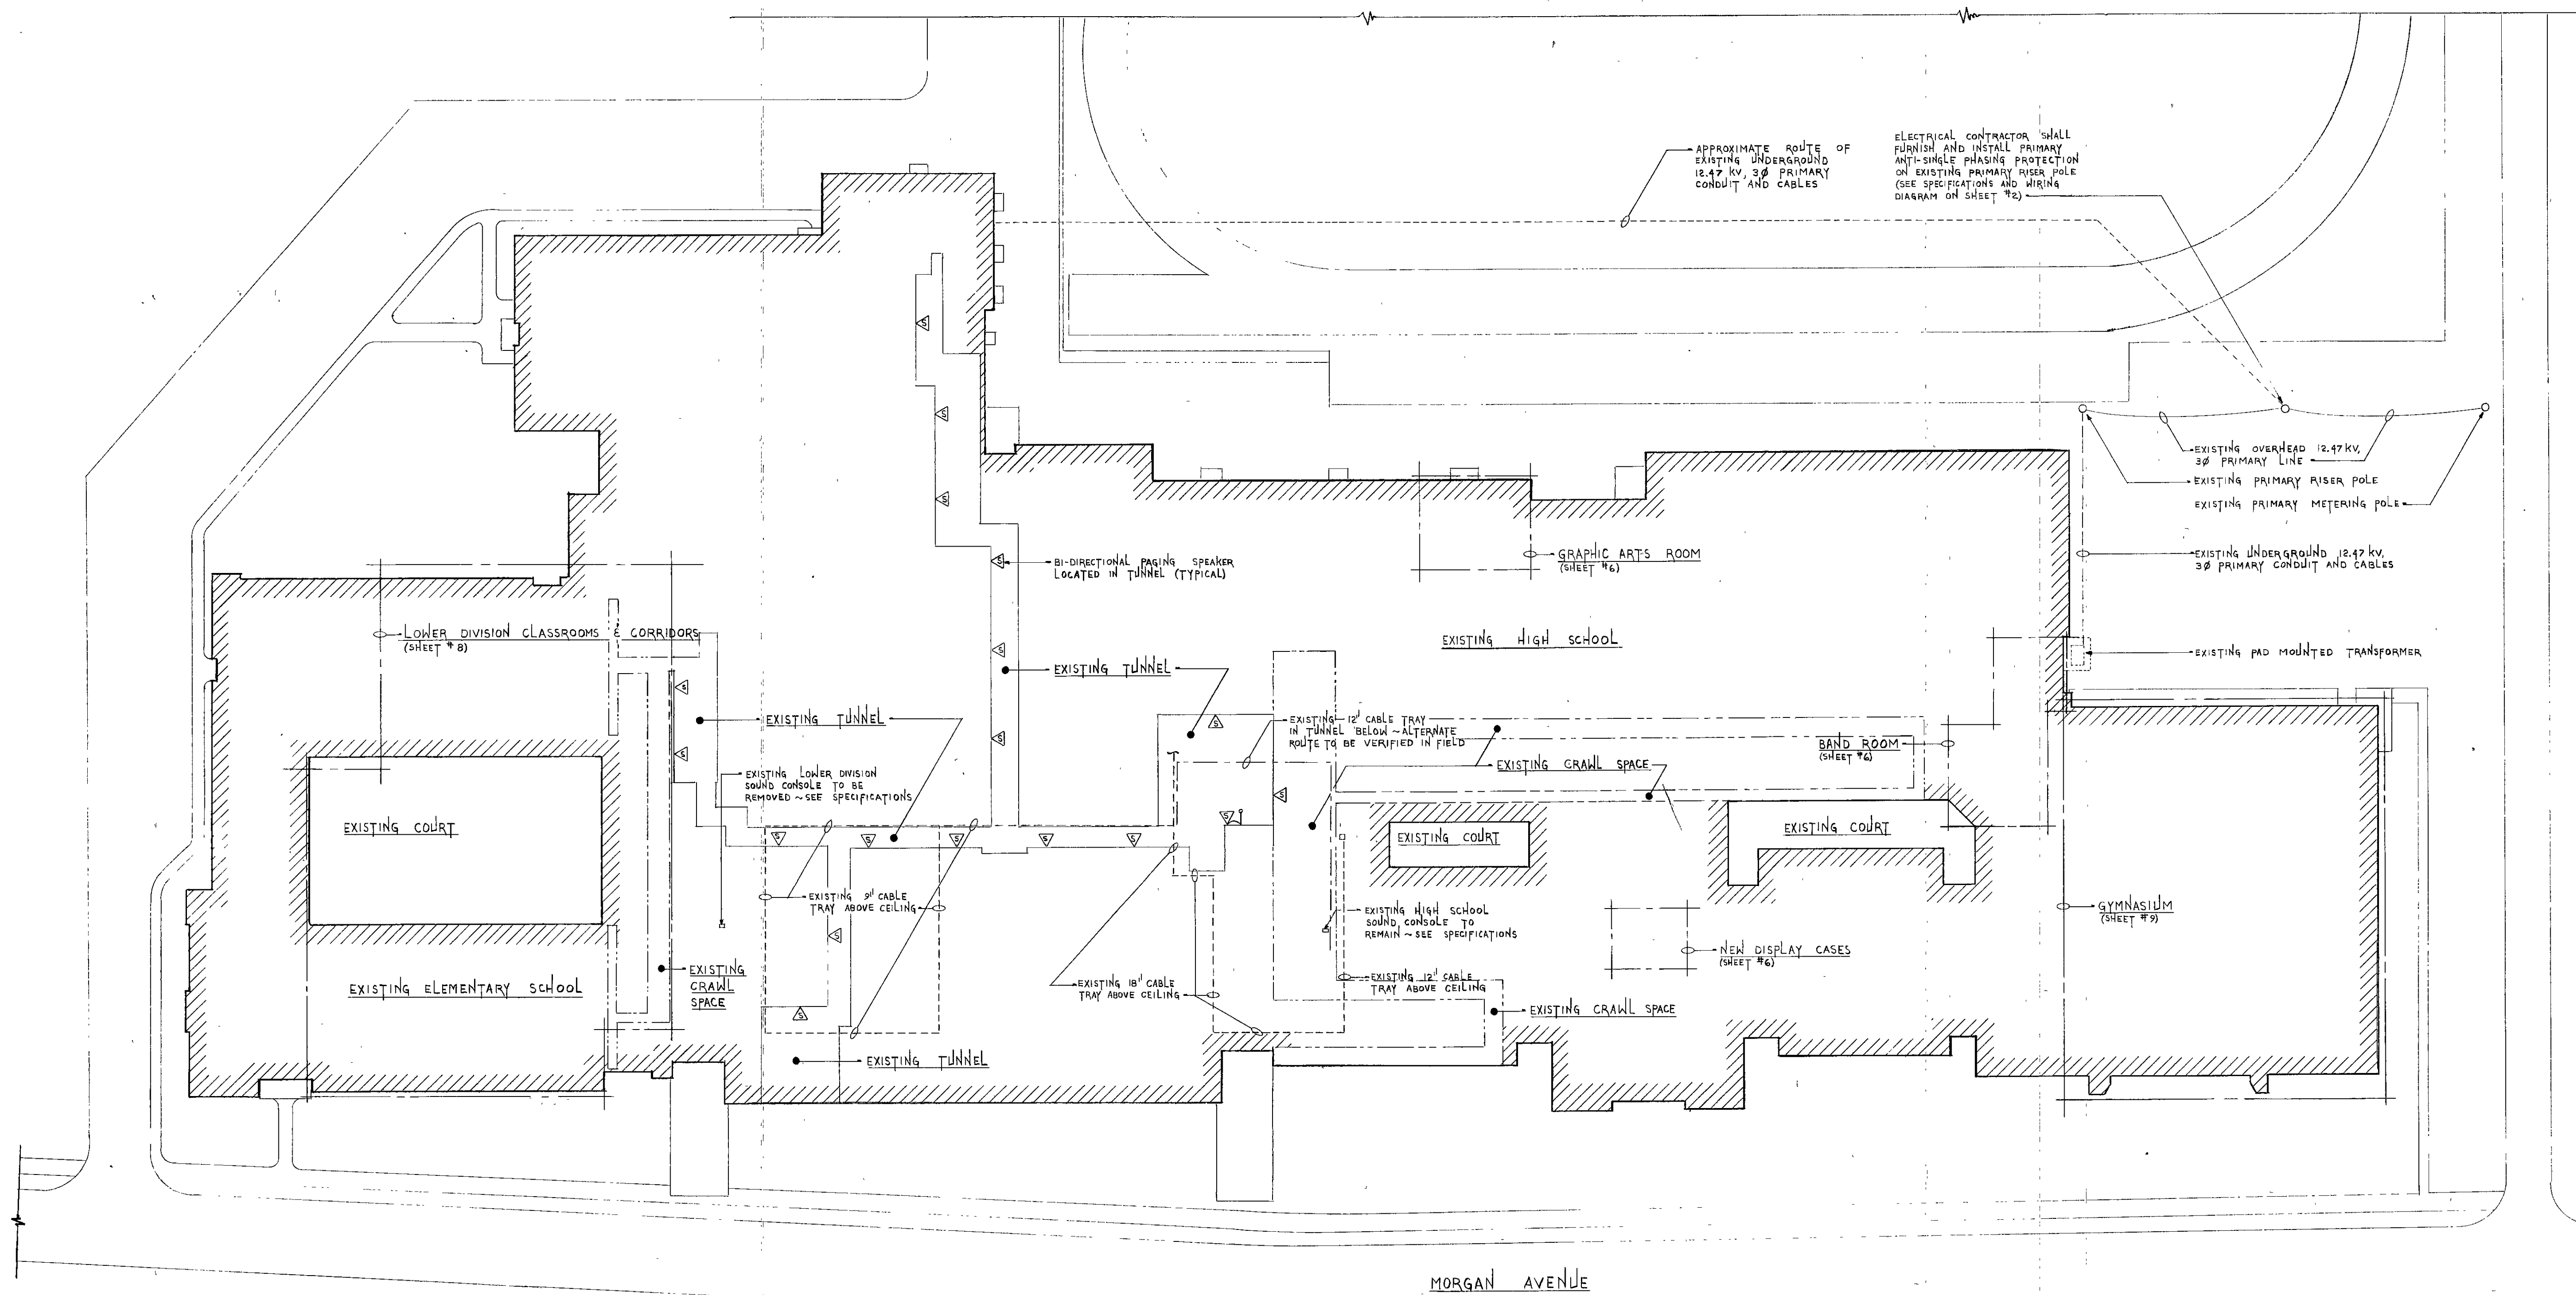

ELECTRICAL SITE PLAN


SCALE: 1"=40'-0"

NORTH



I. BROWN COMPANY ARCHITECTS
ENGINEERS
INDIANAPOLIS, INDIANA • 46241

NG TO THE EXISTING CHESTERTON SENIOR HIGH SCHOOL

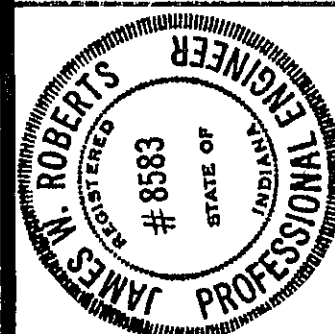

James M. Roberts