




James W. Roberts

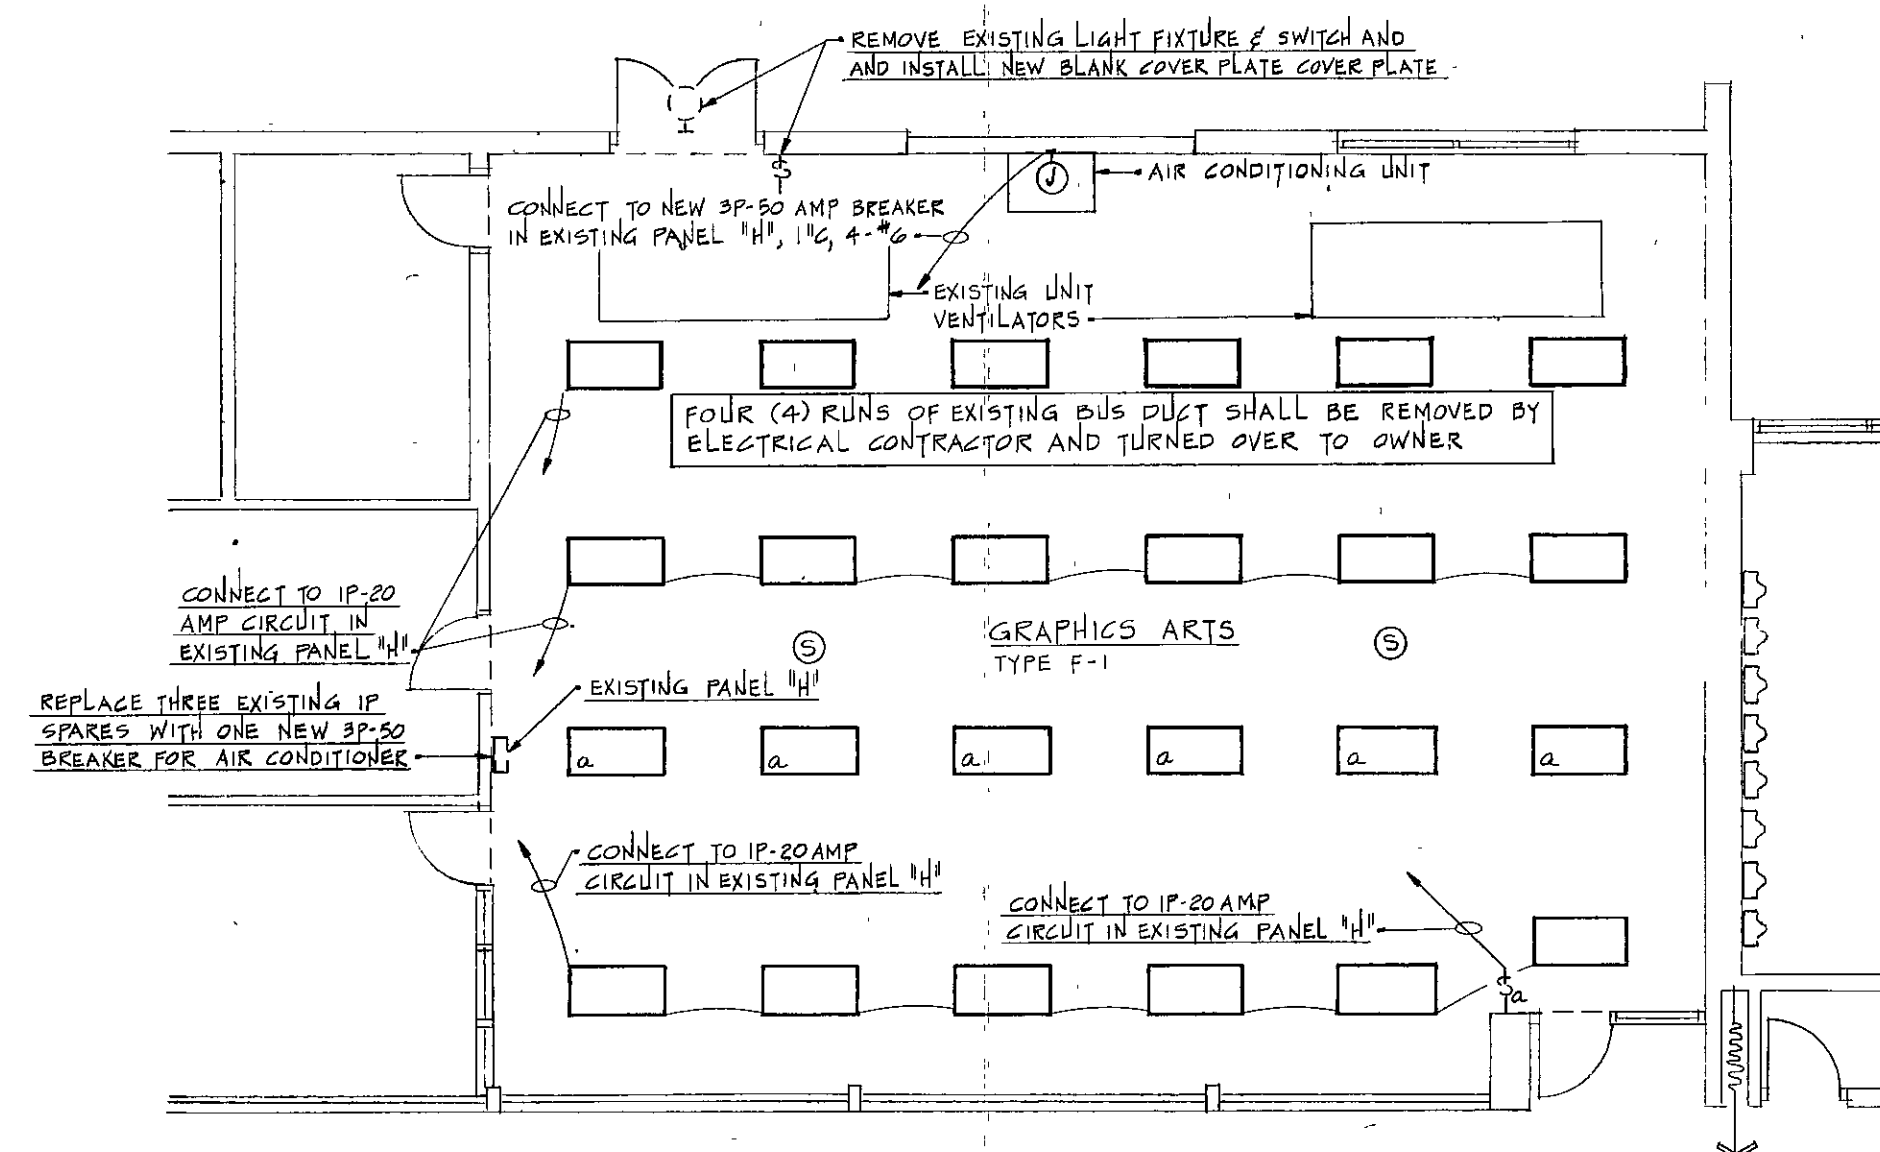



ELECTRICAL PLAN OF GRAPHIC ARTS ROOM

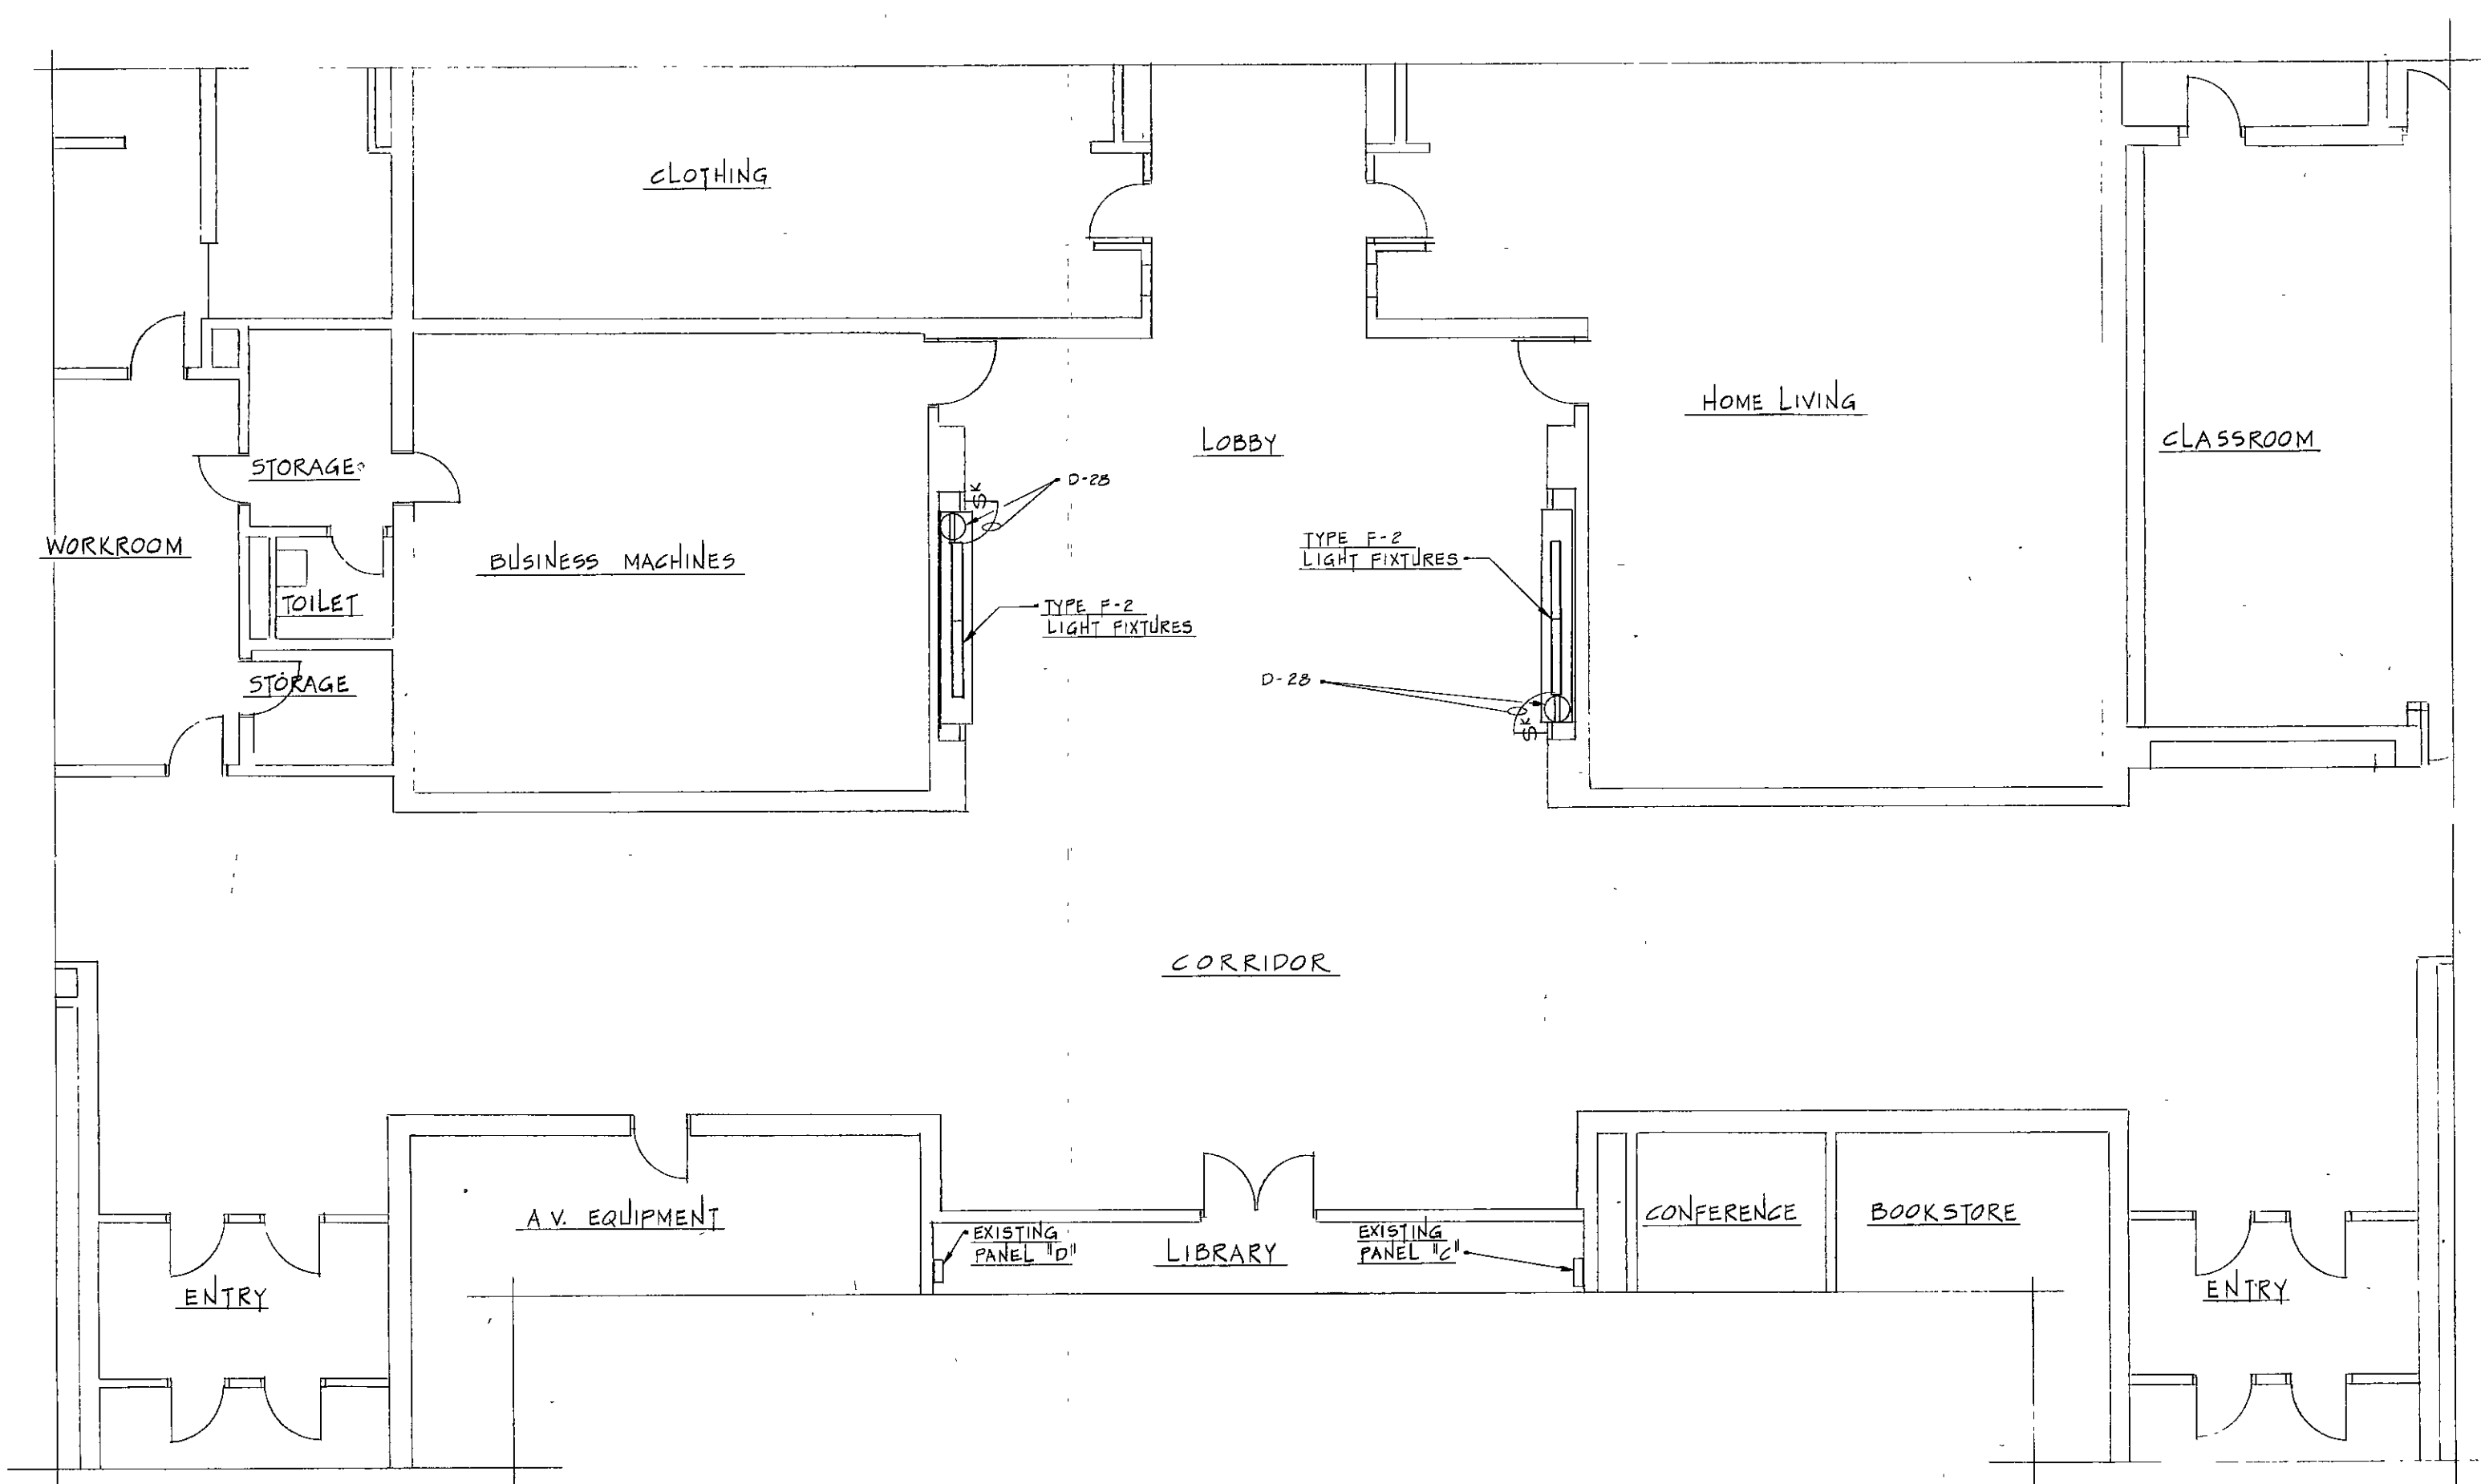

ELECTRICAL PLAN OF NEW DISPLAY CASES

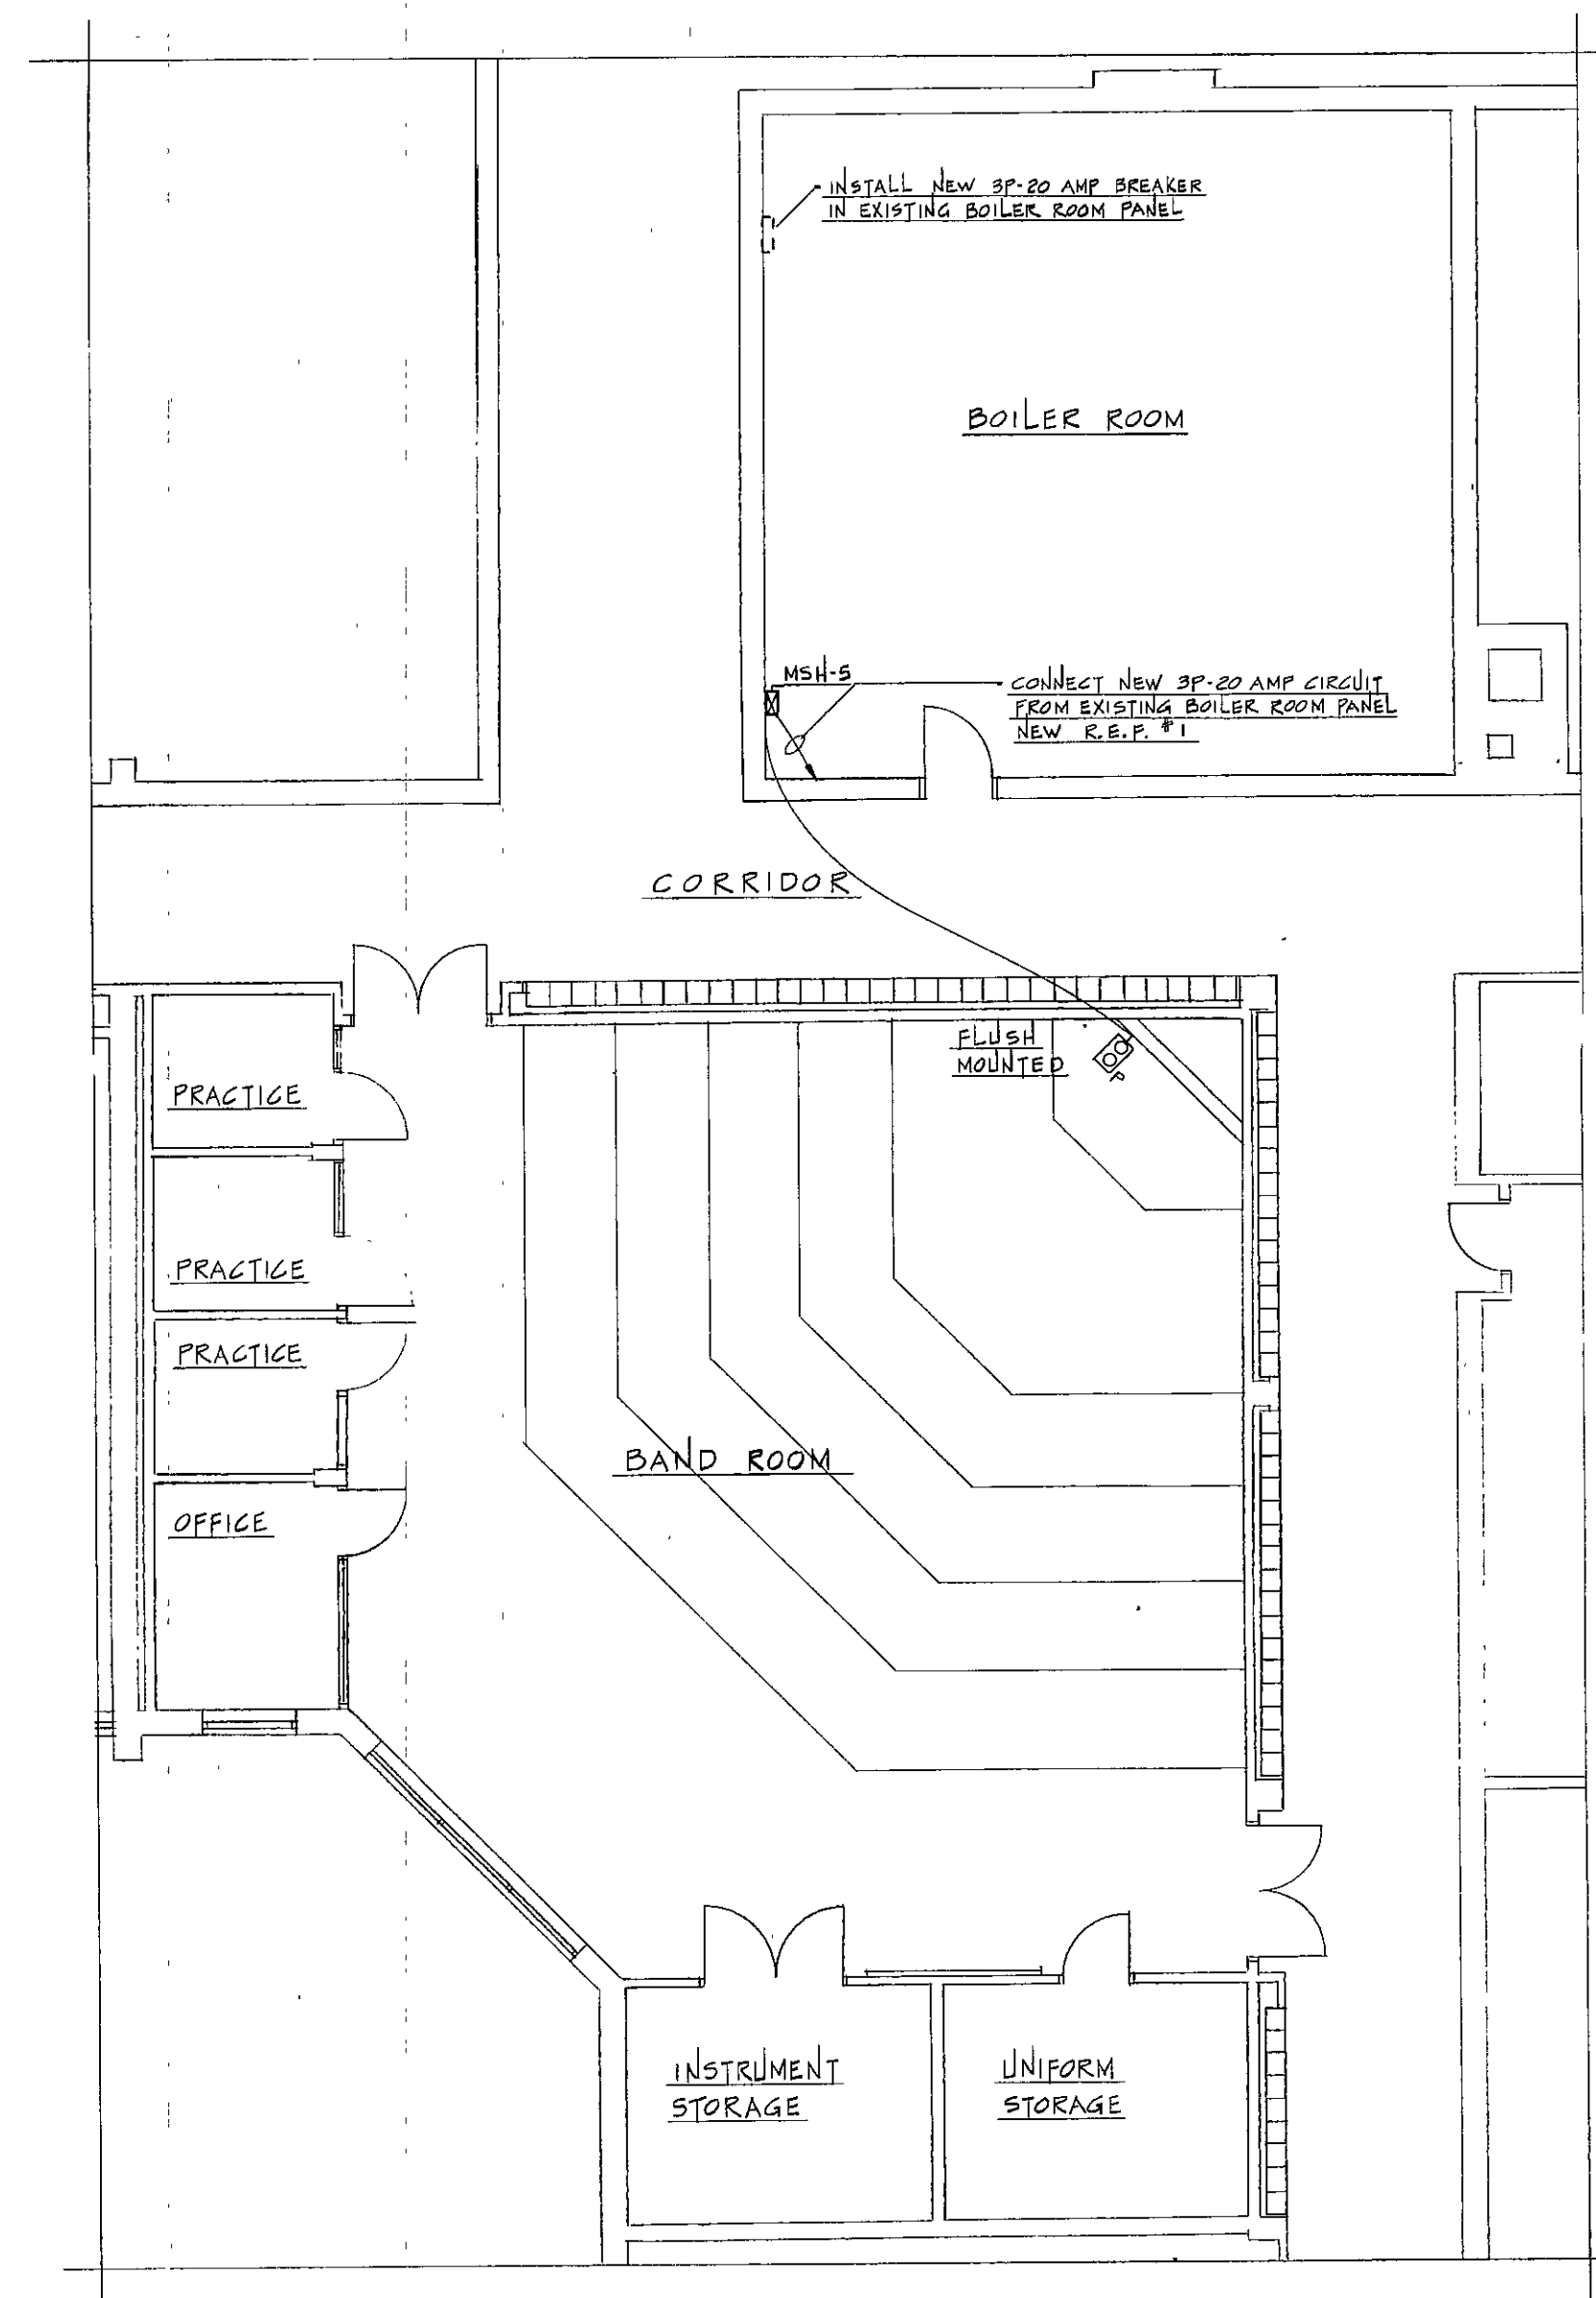

ELECTRICAL PLAN OF BAND ROOM
SCALE: 1/8" = 1' - 0"

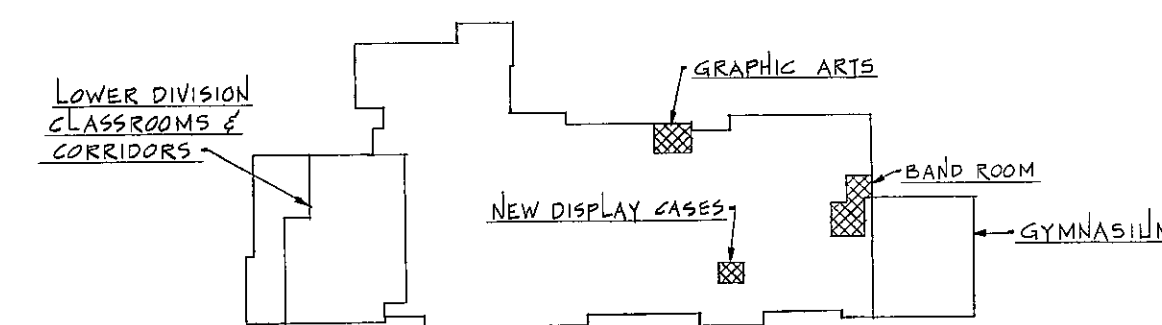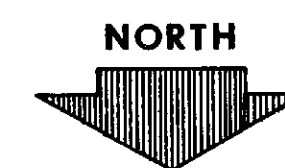

KEY PLAN
NO SCALE

EVERETT · I · BROWN COMPANY ARCHITECTS
ENGINEERS
5500 WEST BRADBURY AVENUE • PARK FLETCHER • INDIANAPOLIS, INDIANA • 46241

MISCELLANEOUS REMODELING TO THE EXISTING CHESTERTON SENIOR HIGH SCHOOL

PROJECT 2575	DATE APRIL 12, 1976	REVISED
------------------------	-------------------------------	---------

NO. 6
OF 20

76 E-03