



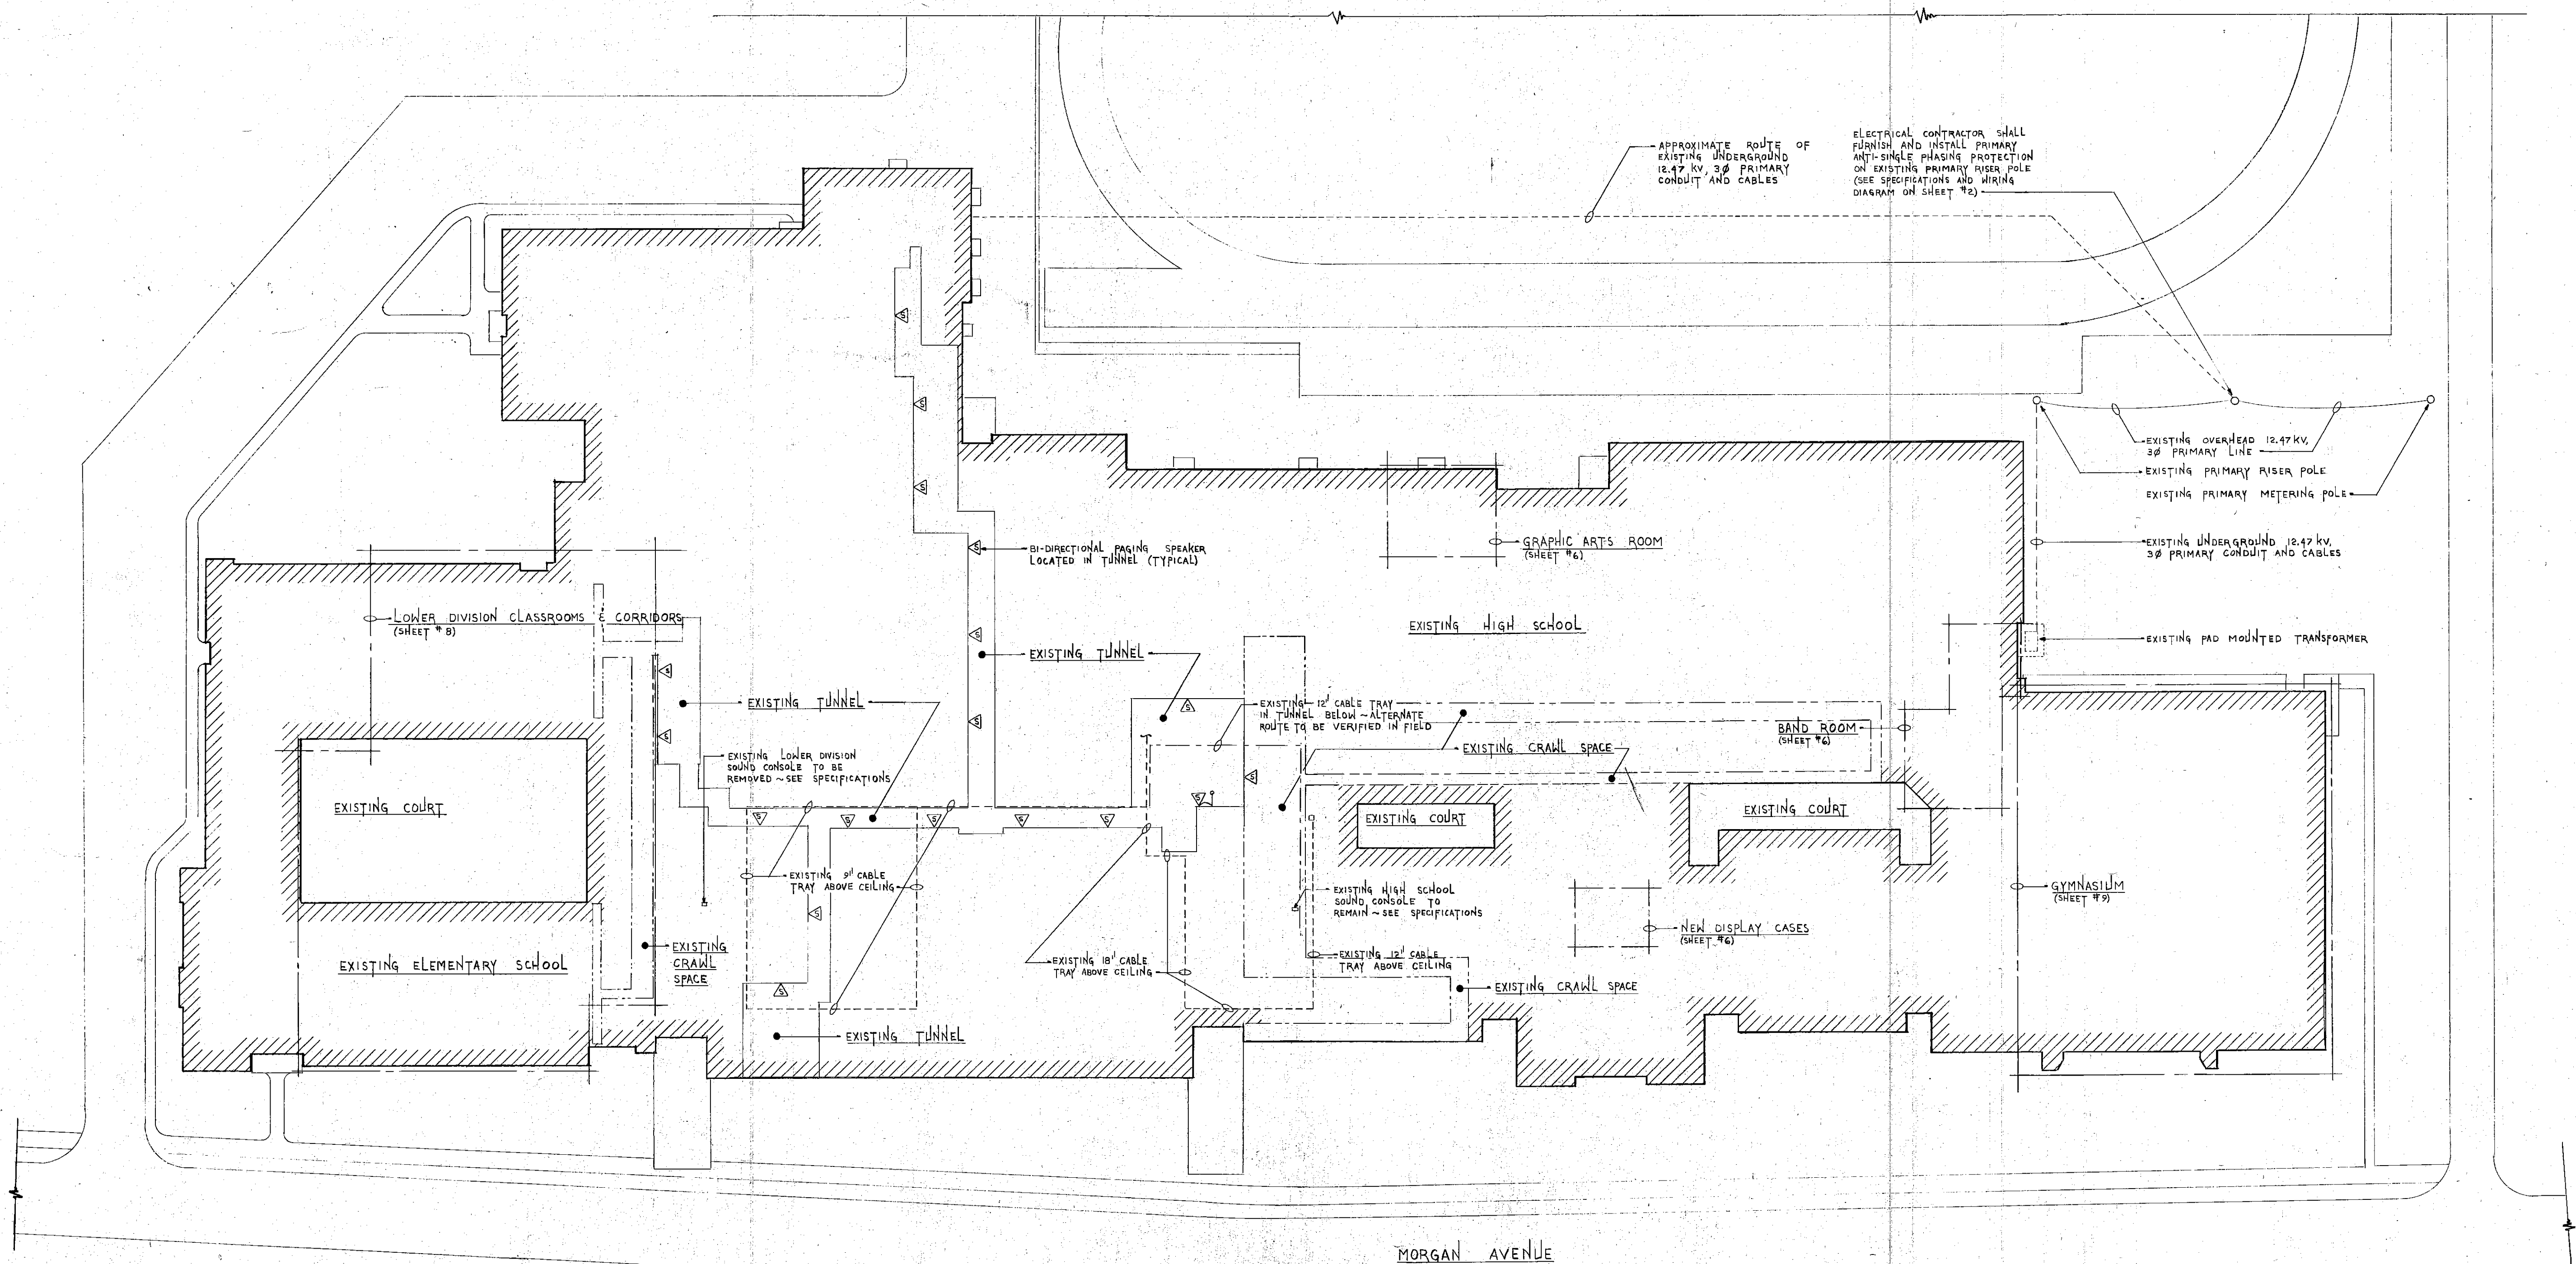


ELECTRICAL SITE PLAN

SCALE: 1" = 40'-0"

NORTH

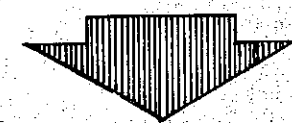

James W. Roberts

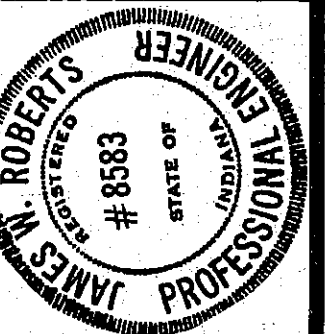

ARCHITECTS
ENGINEERS

EVERETT · I · BROWN COMPANY

• INDIANAPOLIS, INDIANA • 46241

• PARK FLETCHER •

5500 WEST BRADBURY AVENUE •

PROJECT 2575	DATE APRIL 12, 1976	REVISED
-----------------	------------------------	---------

NO. 3
OF 20

76-E-02

MISCELLANEOUS REMODELING TO THE EXISTING CHESTERTON SENIOR HIGH SCHOOL