

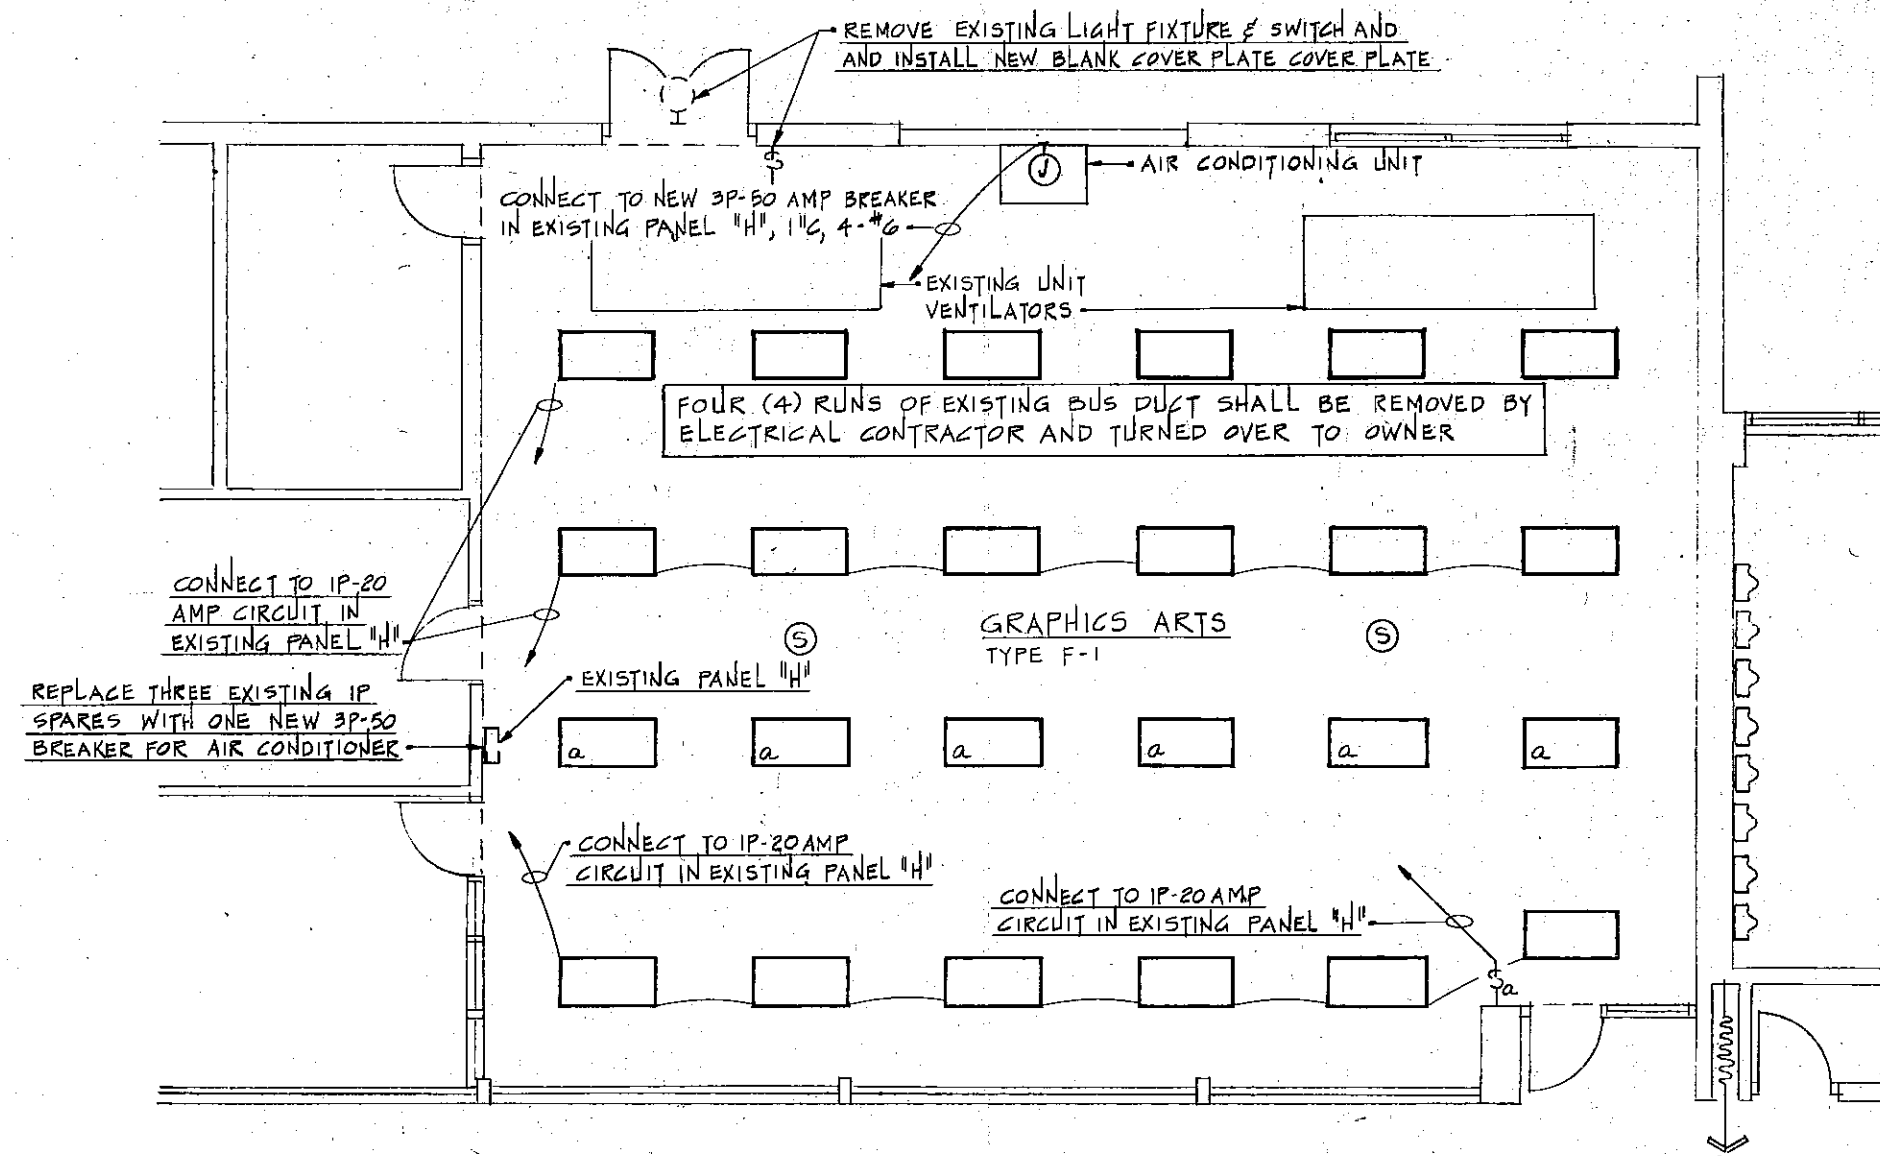


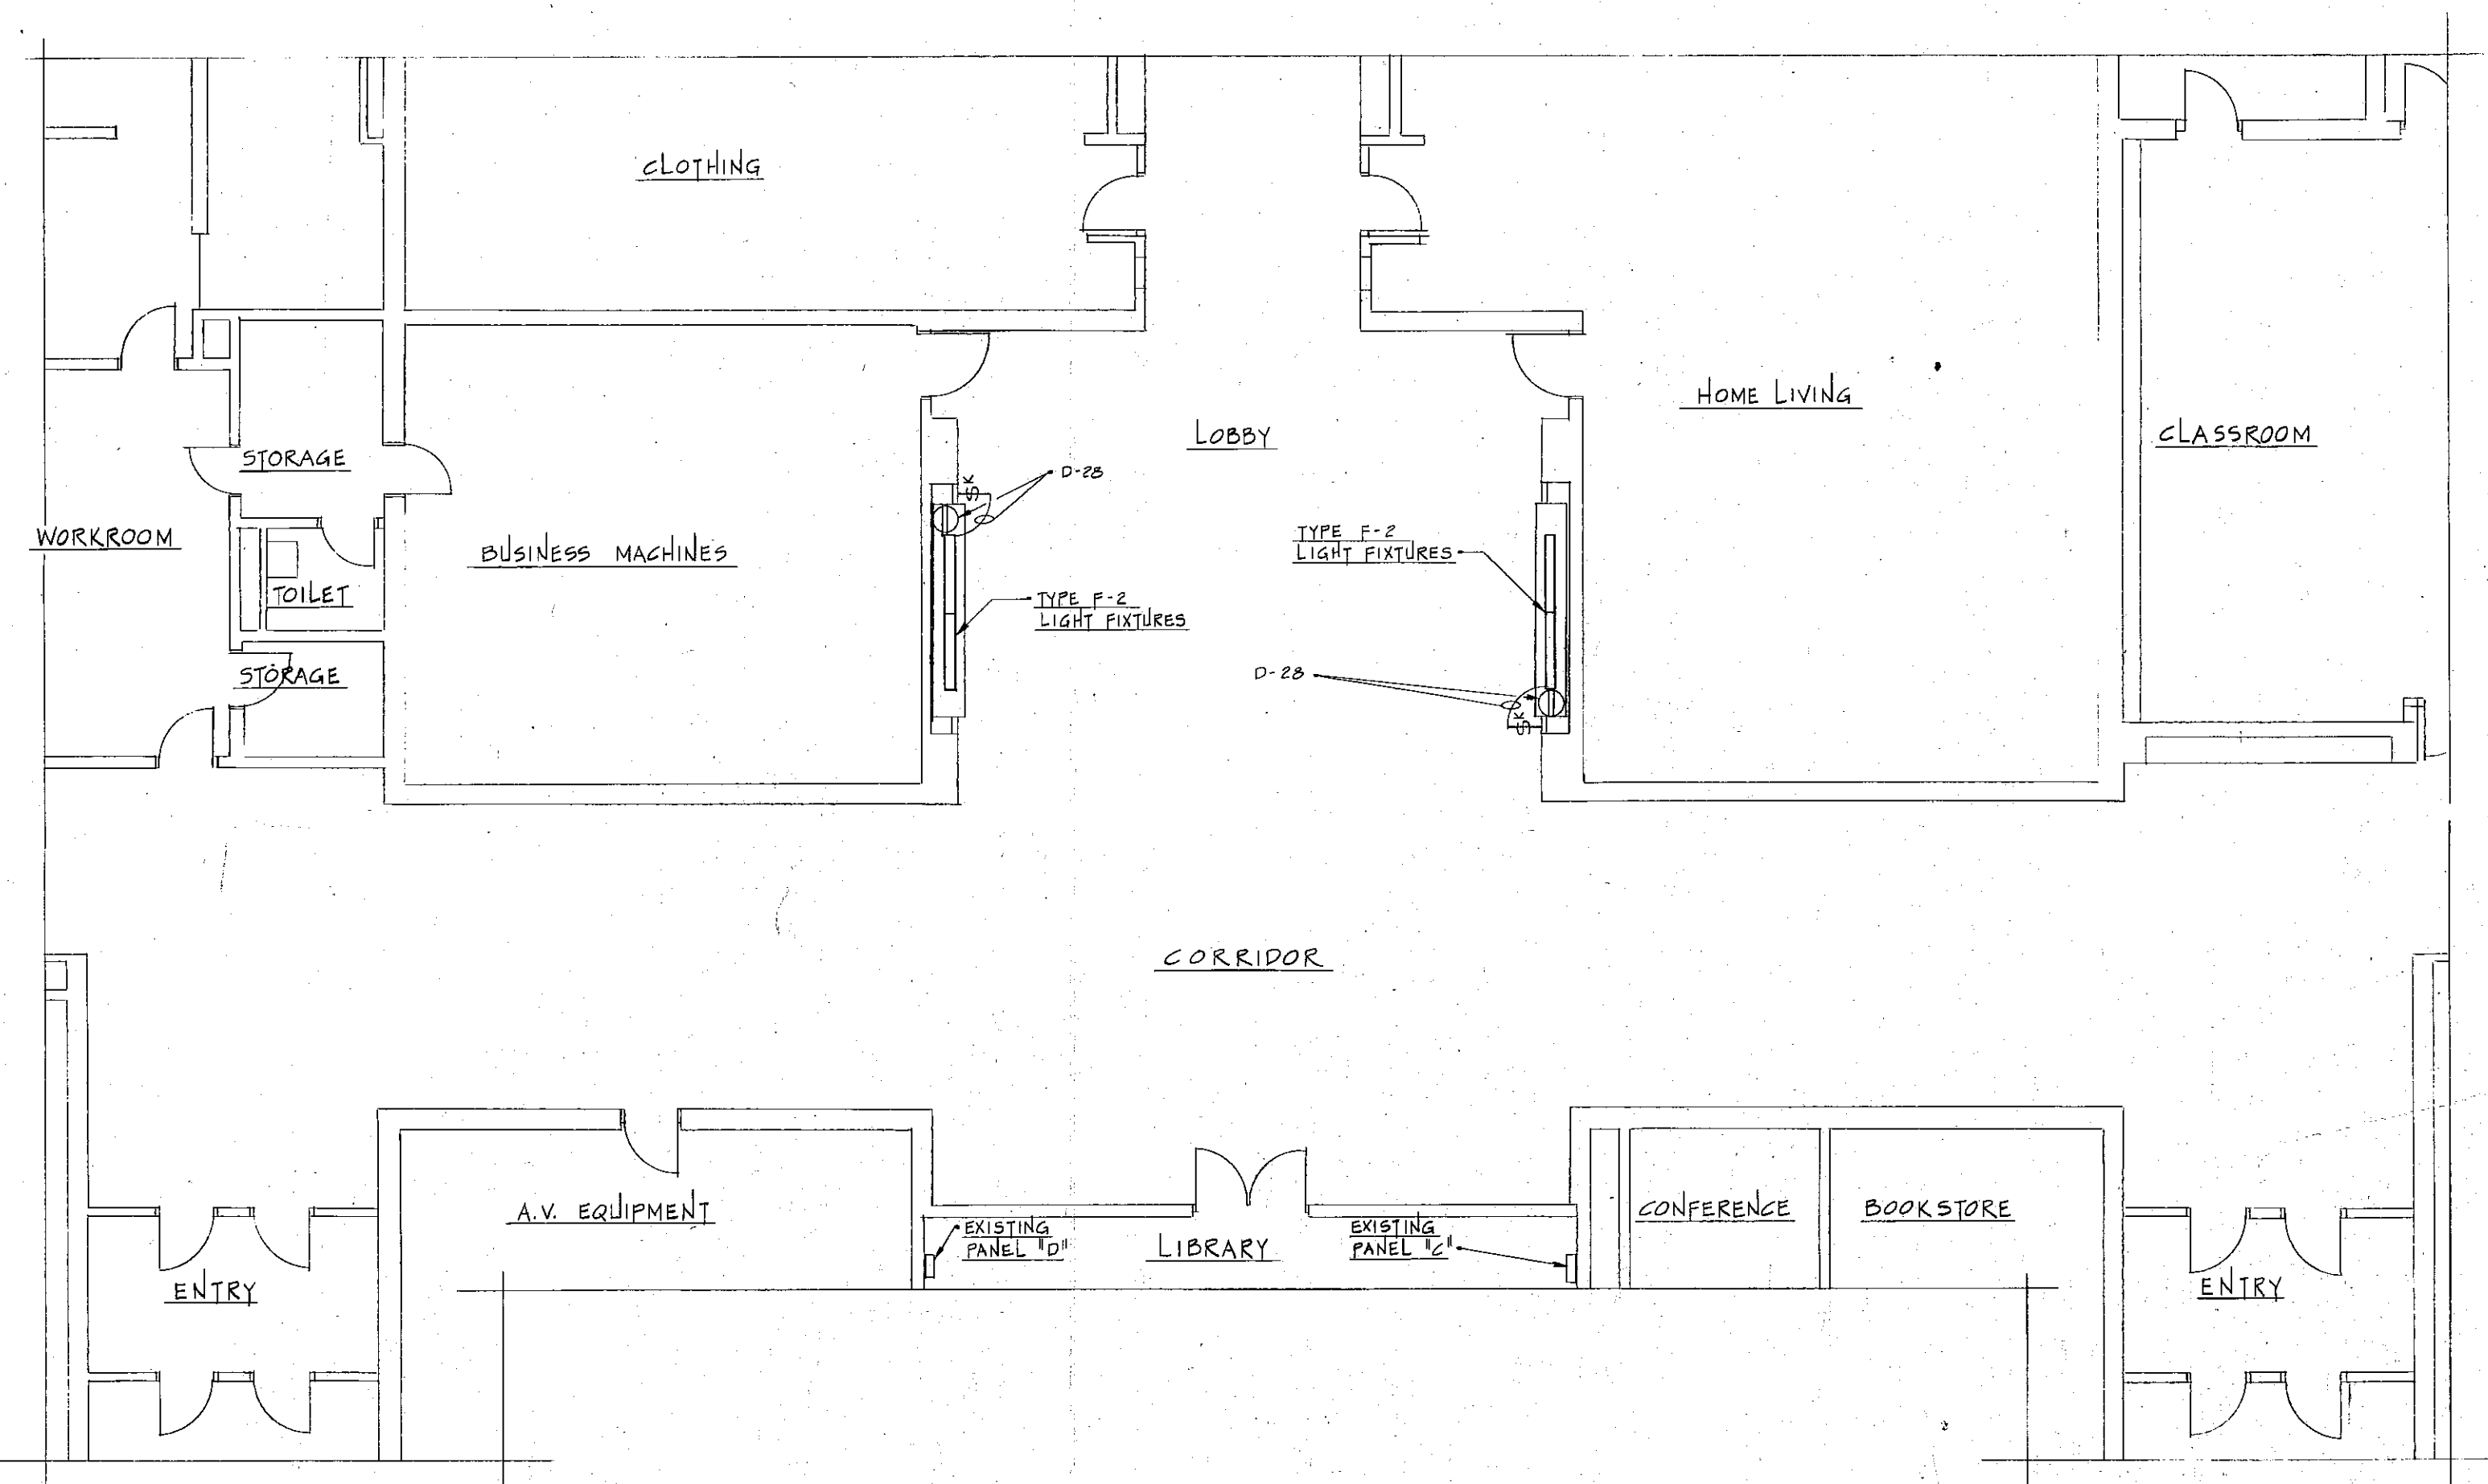

ELECTRICAL PLAN OF GRAPHIC ARTS ROOM

SCALE: 1/8" = 1'-0"



NORTH

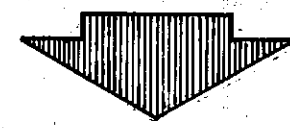

ELECTRICAL PLAN OF NEW DISPLAY CASES

SCALE: 1/8" = 1'-0"



NORTH

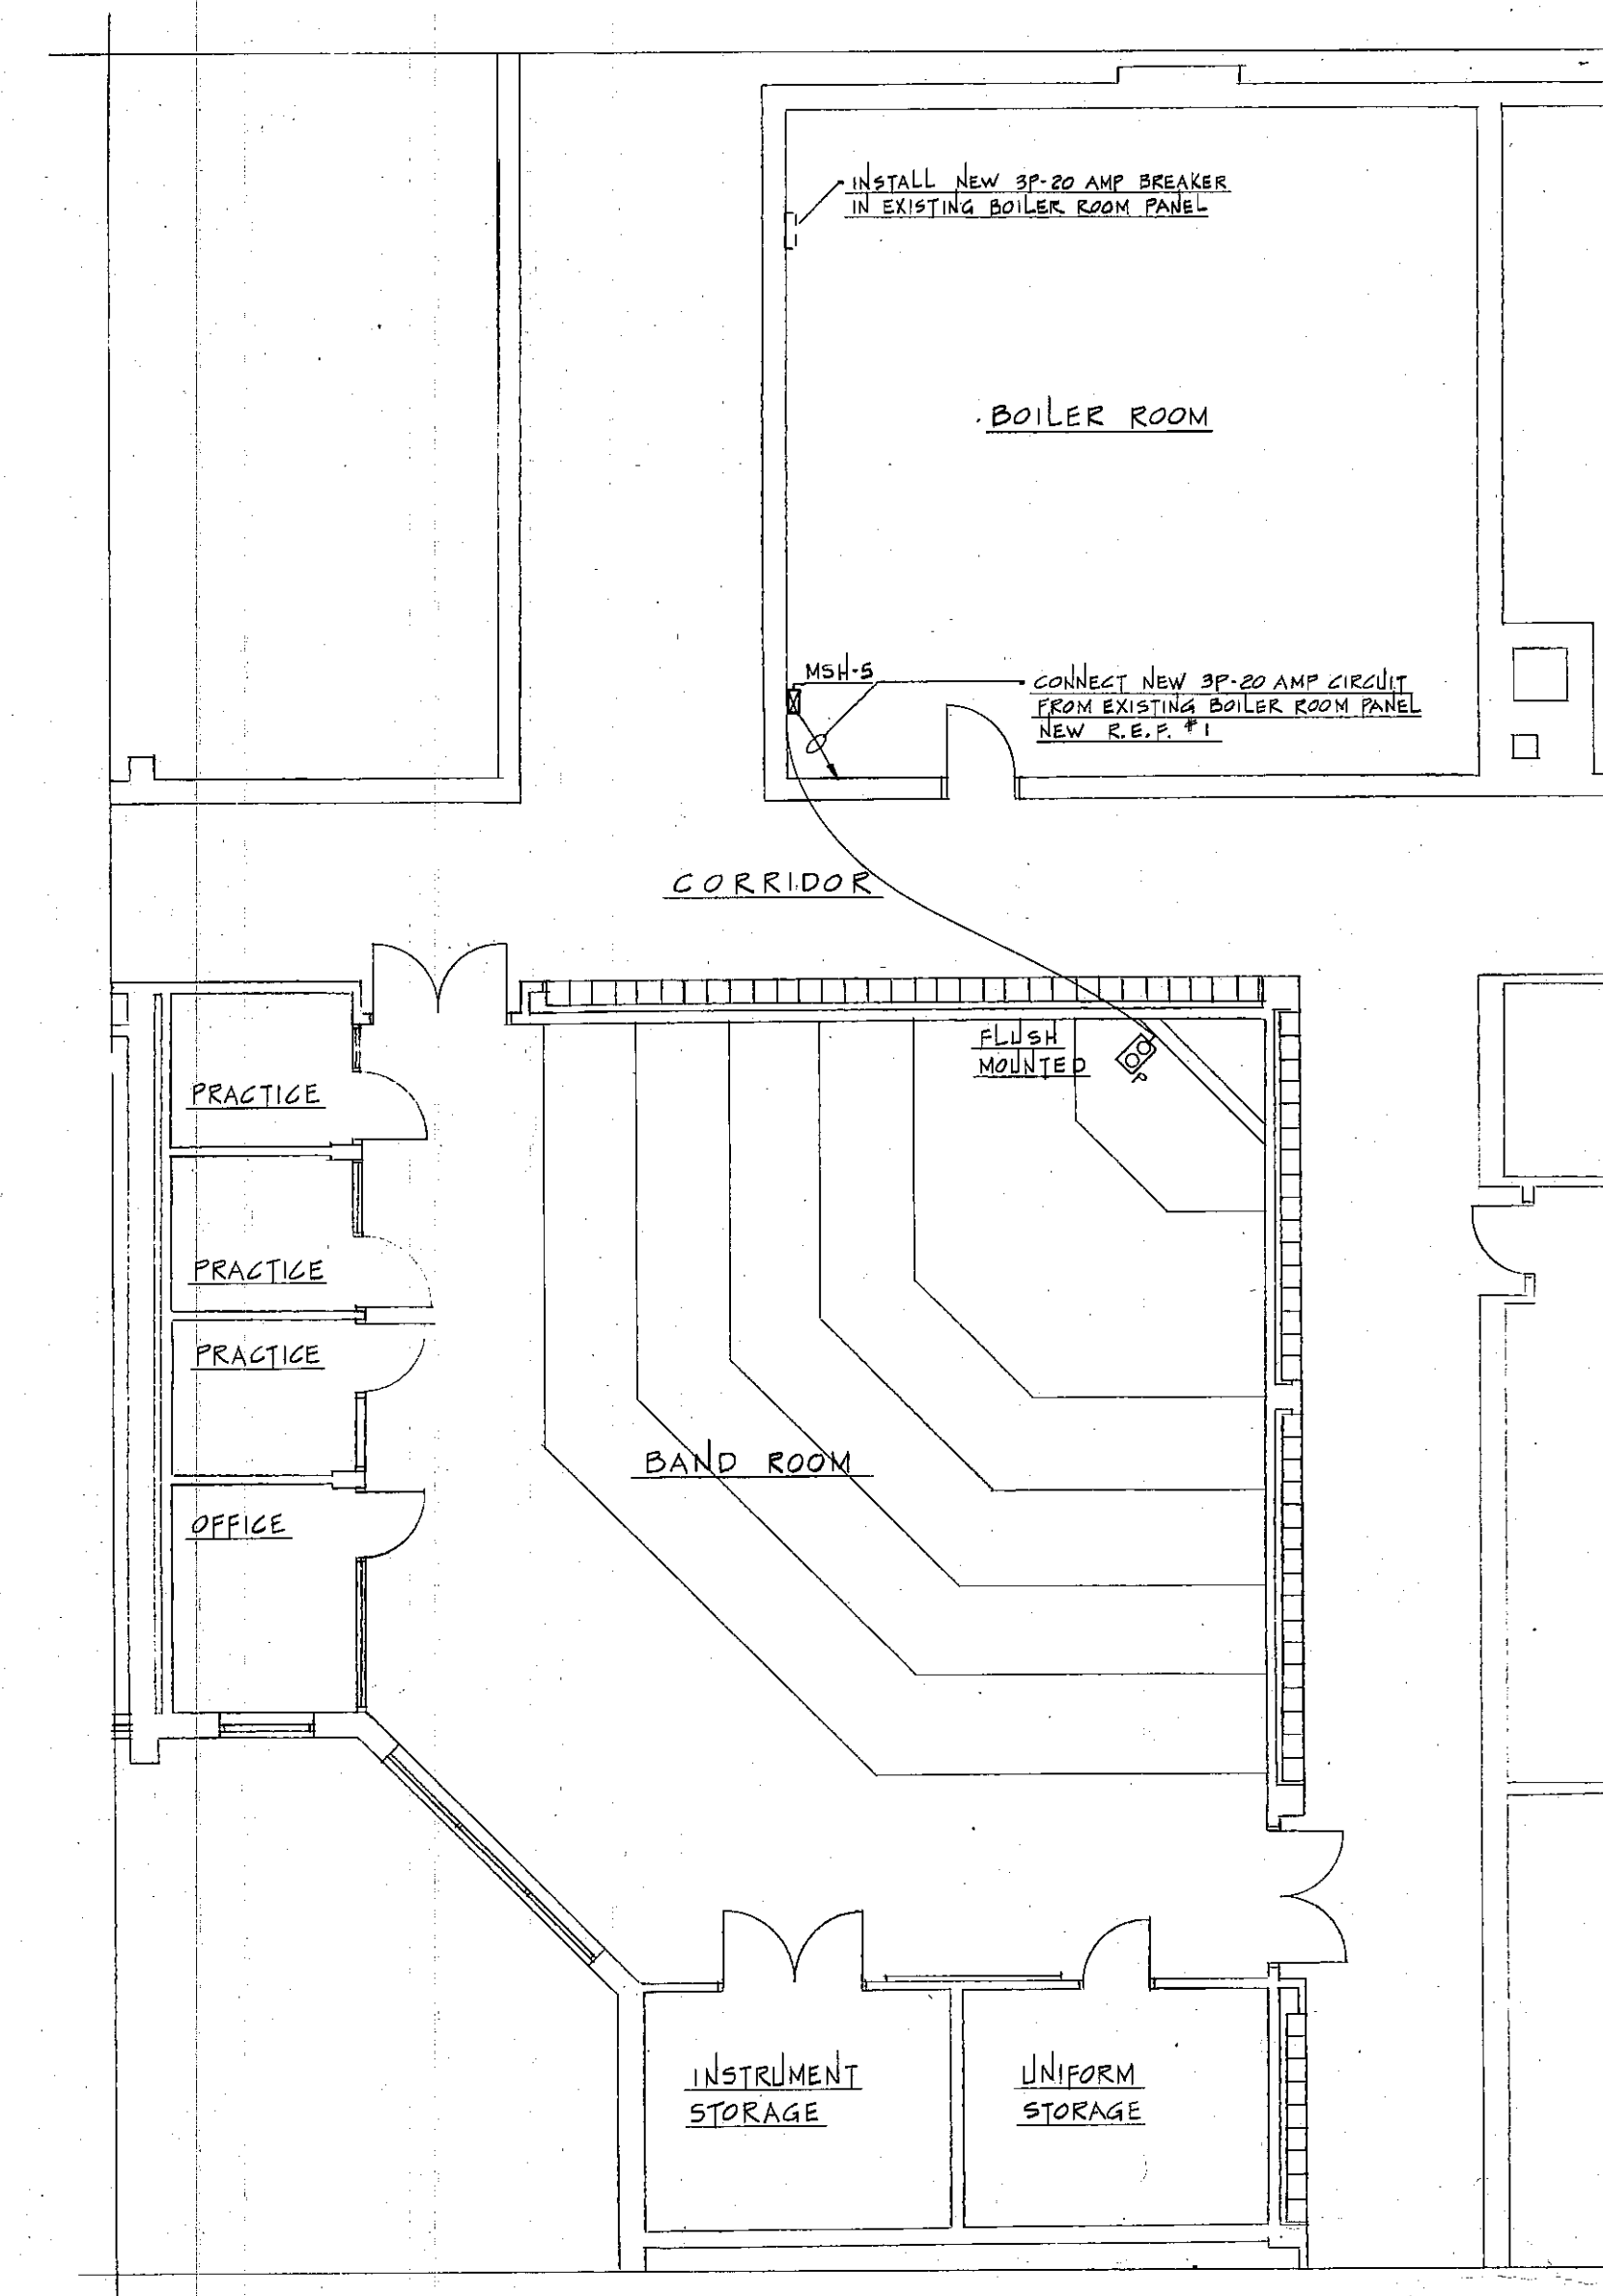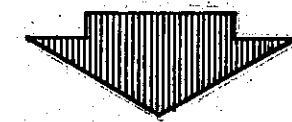

ELECTRICAL PLAN OF BAND ROOM

SCALE: 1/8" = 1'-0"

NORTH

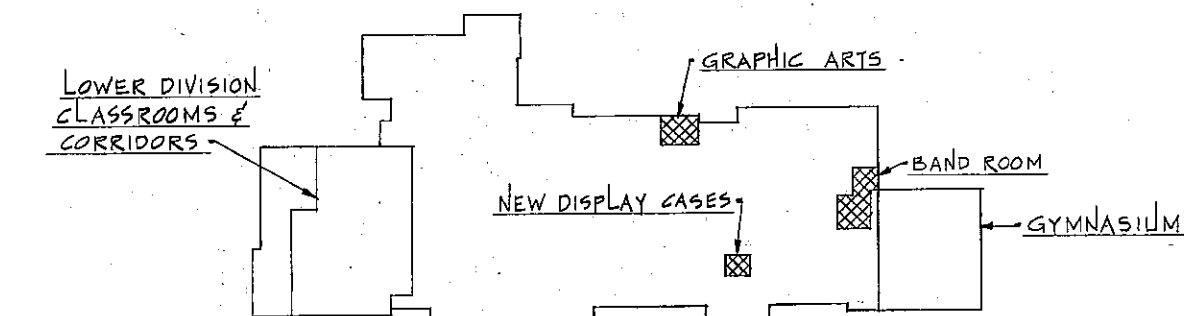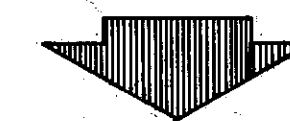

KEY PLAN

NO SCALE

1. See Sheet 2 for Electrical Symbols, Schedules, Details and Notes.

EVERETT · I · BROWN COMPANY ARCHITECTS
ENGINEERS
INDIANAPOLIS, INDIANA • 46241
PARK FLETCHER ·
5500 WEST BRADBURY AVENUE ·
MISCELLANEOUS REMODELING TO THE EXISTING CHESTERTON SENIOR HIGH SCHOOL

PROJECT
2575
DATE
APRIL 12, 1976
REVISED

NO. 6
OF 20

JAMES W. ROBERTS
REGISTERED PROFESSIONAL ENGINEER
STATE OF INDIANA
#8583

76-E-07