

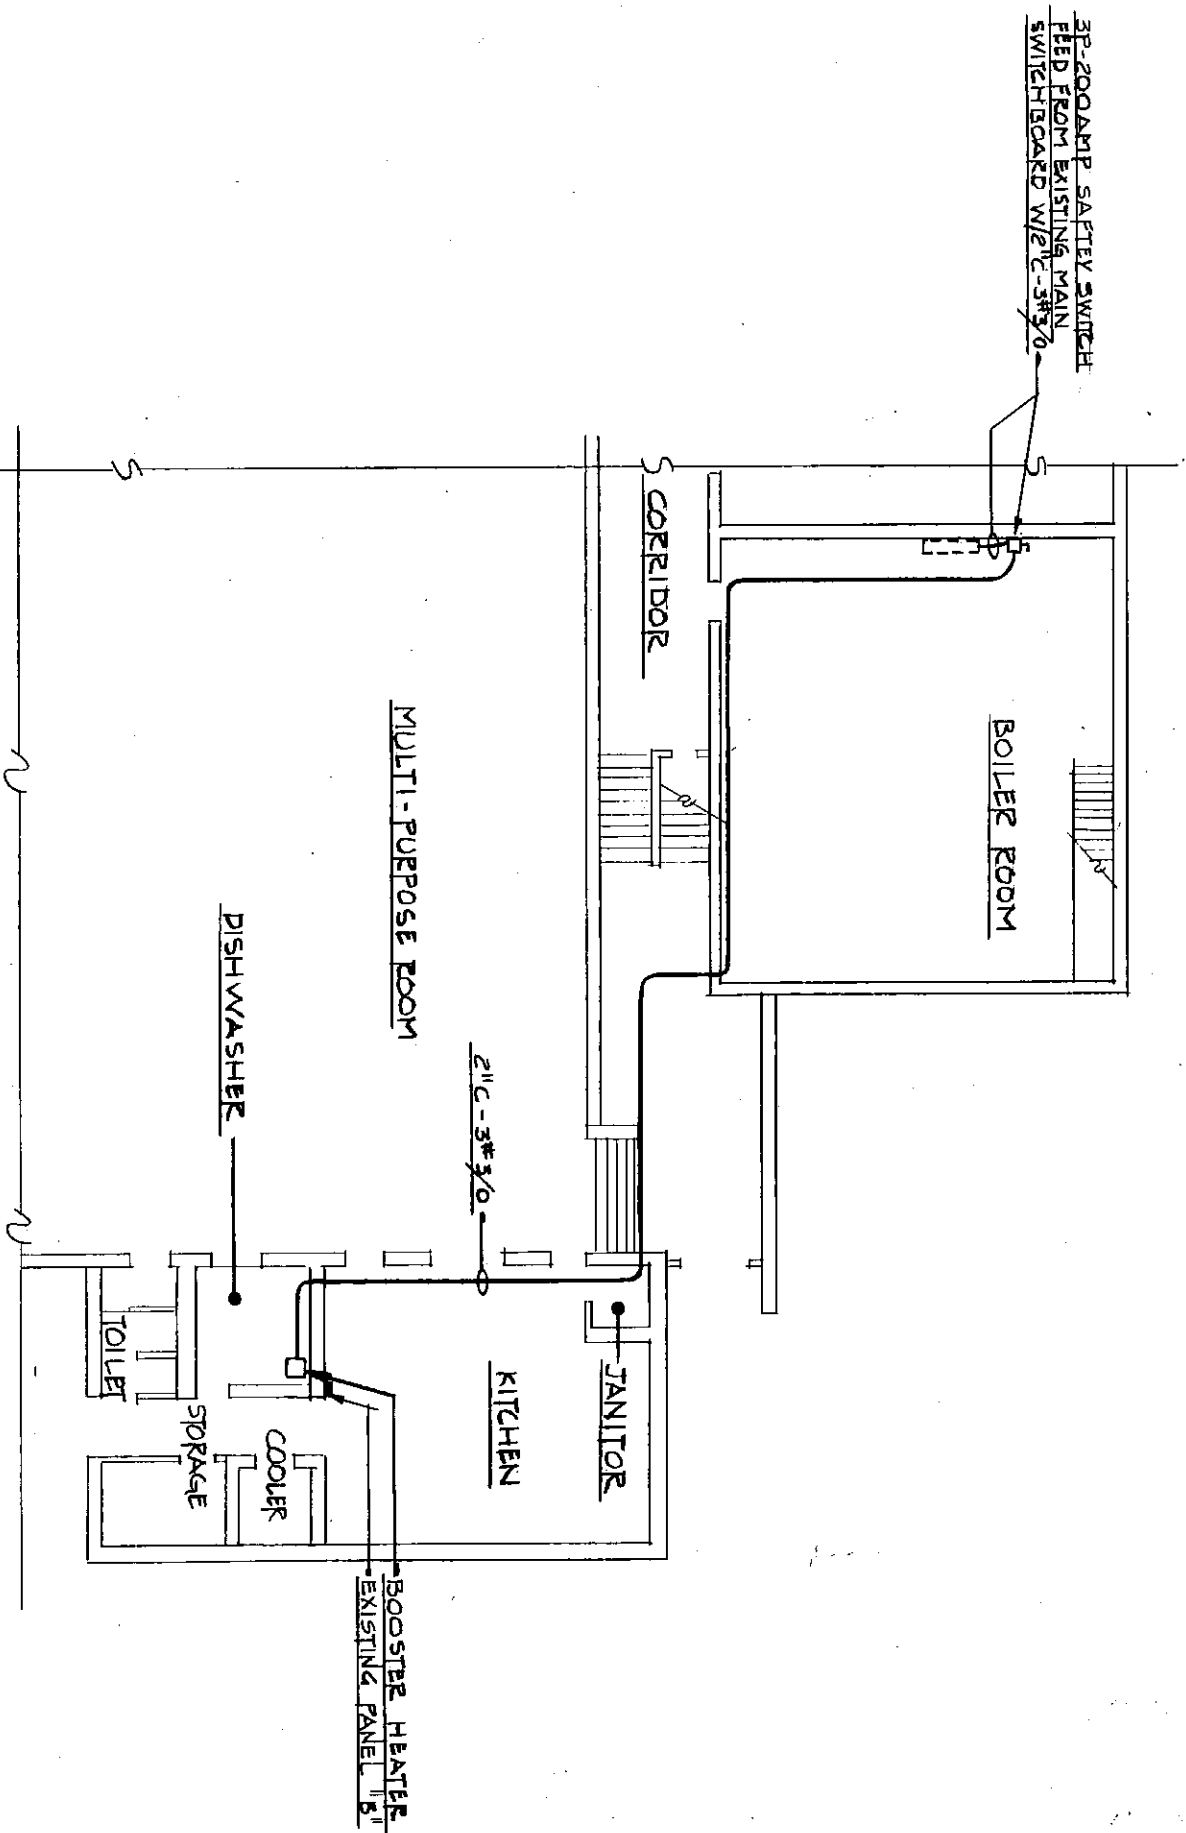



JACKSON ELEMENTARY				
FLUORESCENT		FIXTURE SCHEDULE		
TYPE	MANUFACTURER'S CATALOG NUMBER	MOUNT	LAMPS	REMARKS
F-1	INDY 612-48B-142	SERVICE	2/40	FLUORESCENT CHANGES
F-2	INDY 512-CP-48B-244	RECES	4/40	FLUORESCENT CHANGES

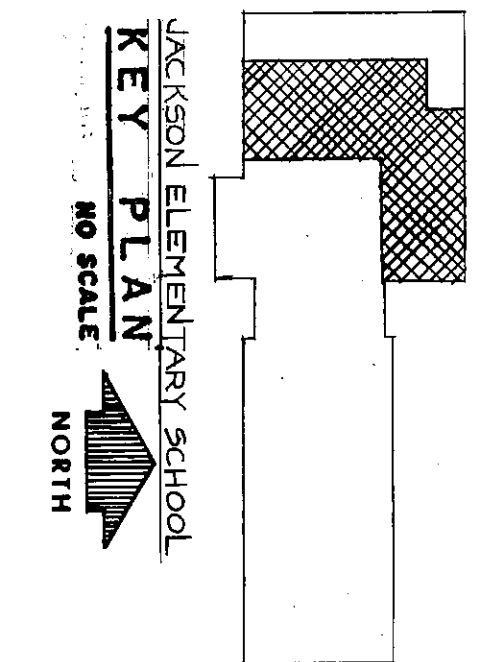

JACKSON ELEMENTARY				
PANEL		SCHEDULE		
MARK & TYPE	CIRCUITS	BREAKER OR SWITCH	FRAME	REMARKS
111	1-26	20-20	20-20	REPLACES EXISTING PANEL, 20-20
112	27-30	20-20	20-20	REPLACES EXISTING PANEL, 20-20
113	31-34	20-20	20-20	REPLACES EXISTING PANEL, 20-20
114	35-38	20-20	20-20	REPLACES EXISTING PANEL, 20-20
115	39-42	20-20	20-20	REPLACES EXISTING PANEL, 20-20


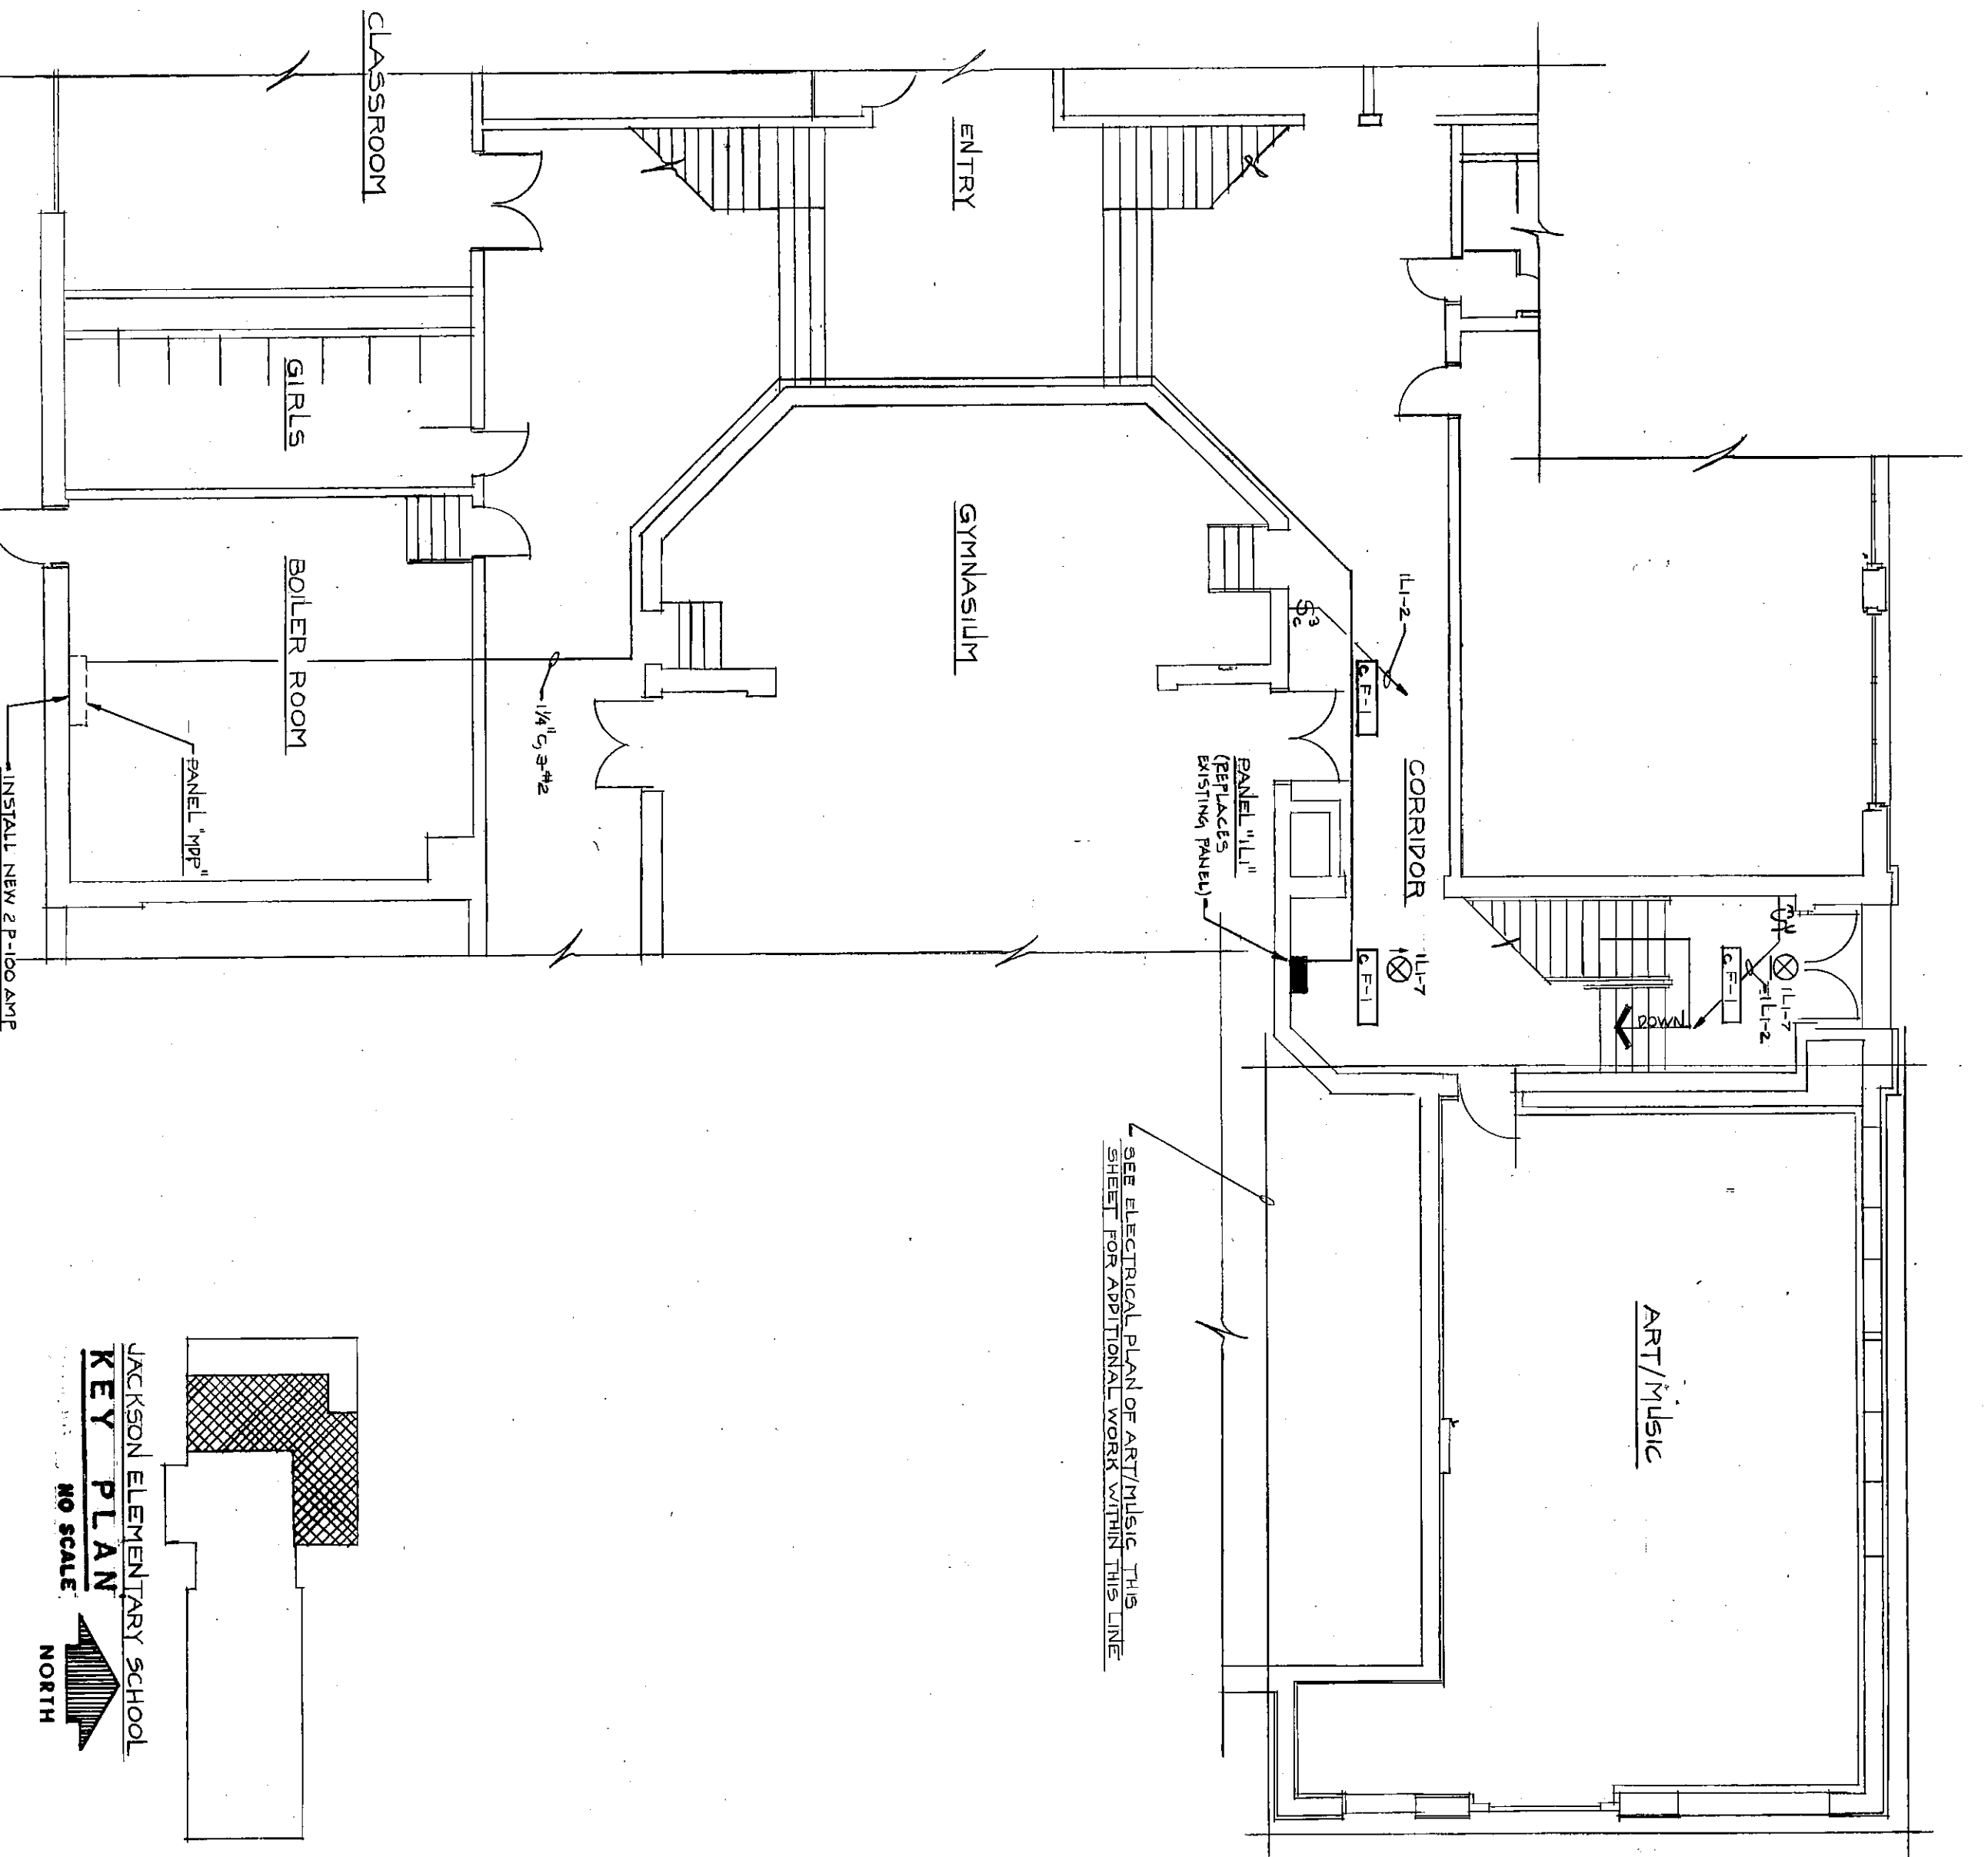


PARTIAL ELECTRICAL FIRST FLOOR PLAN
JACKSON ELEMENTARY SCHOOL
SCALE: 1/8" = 1'-0"

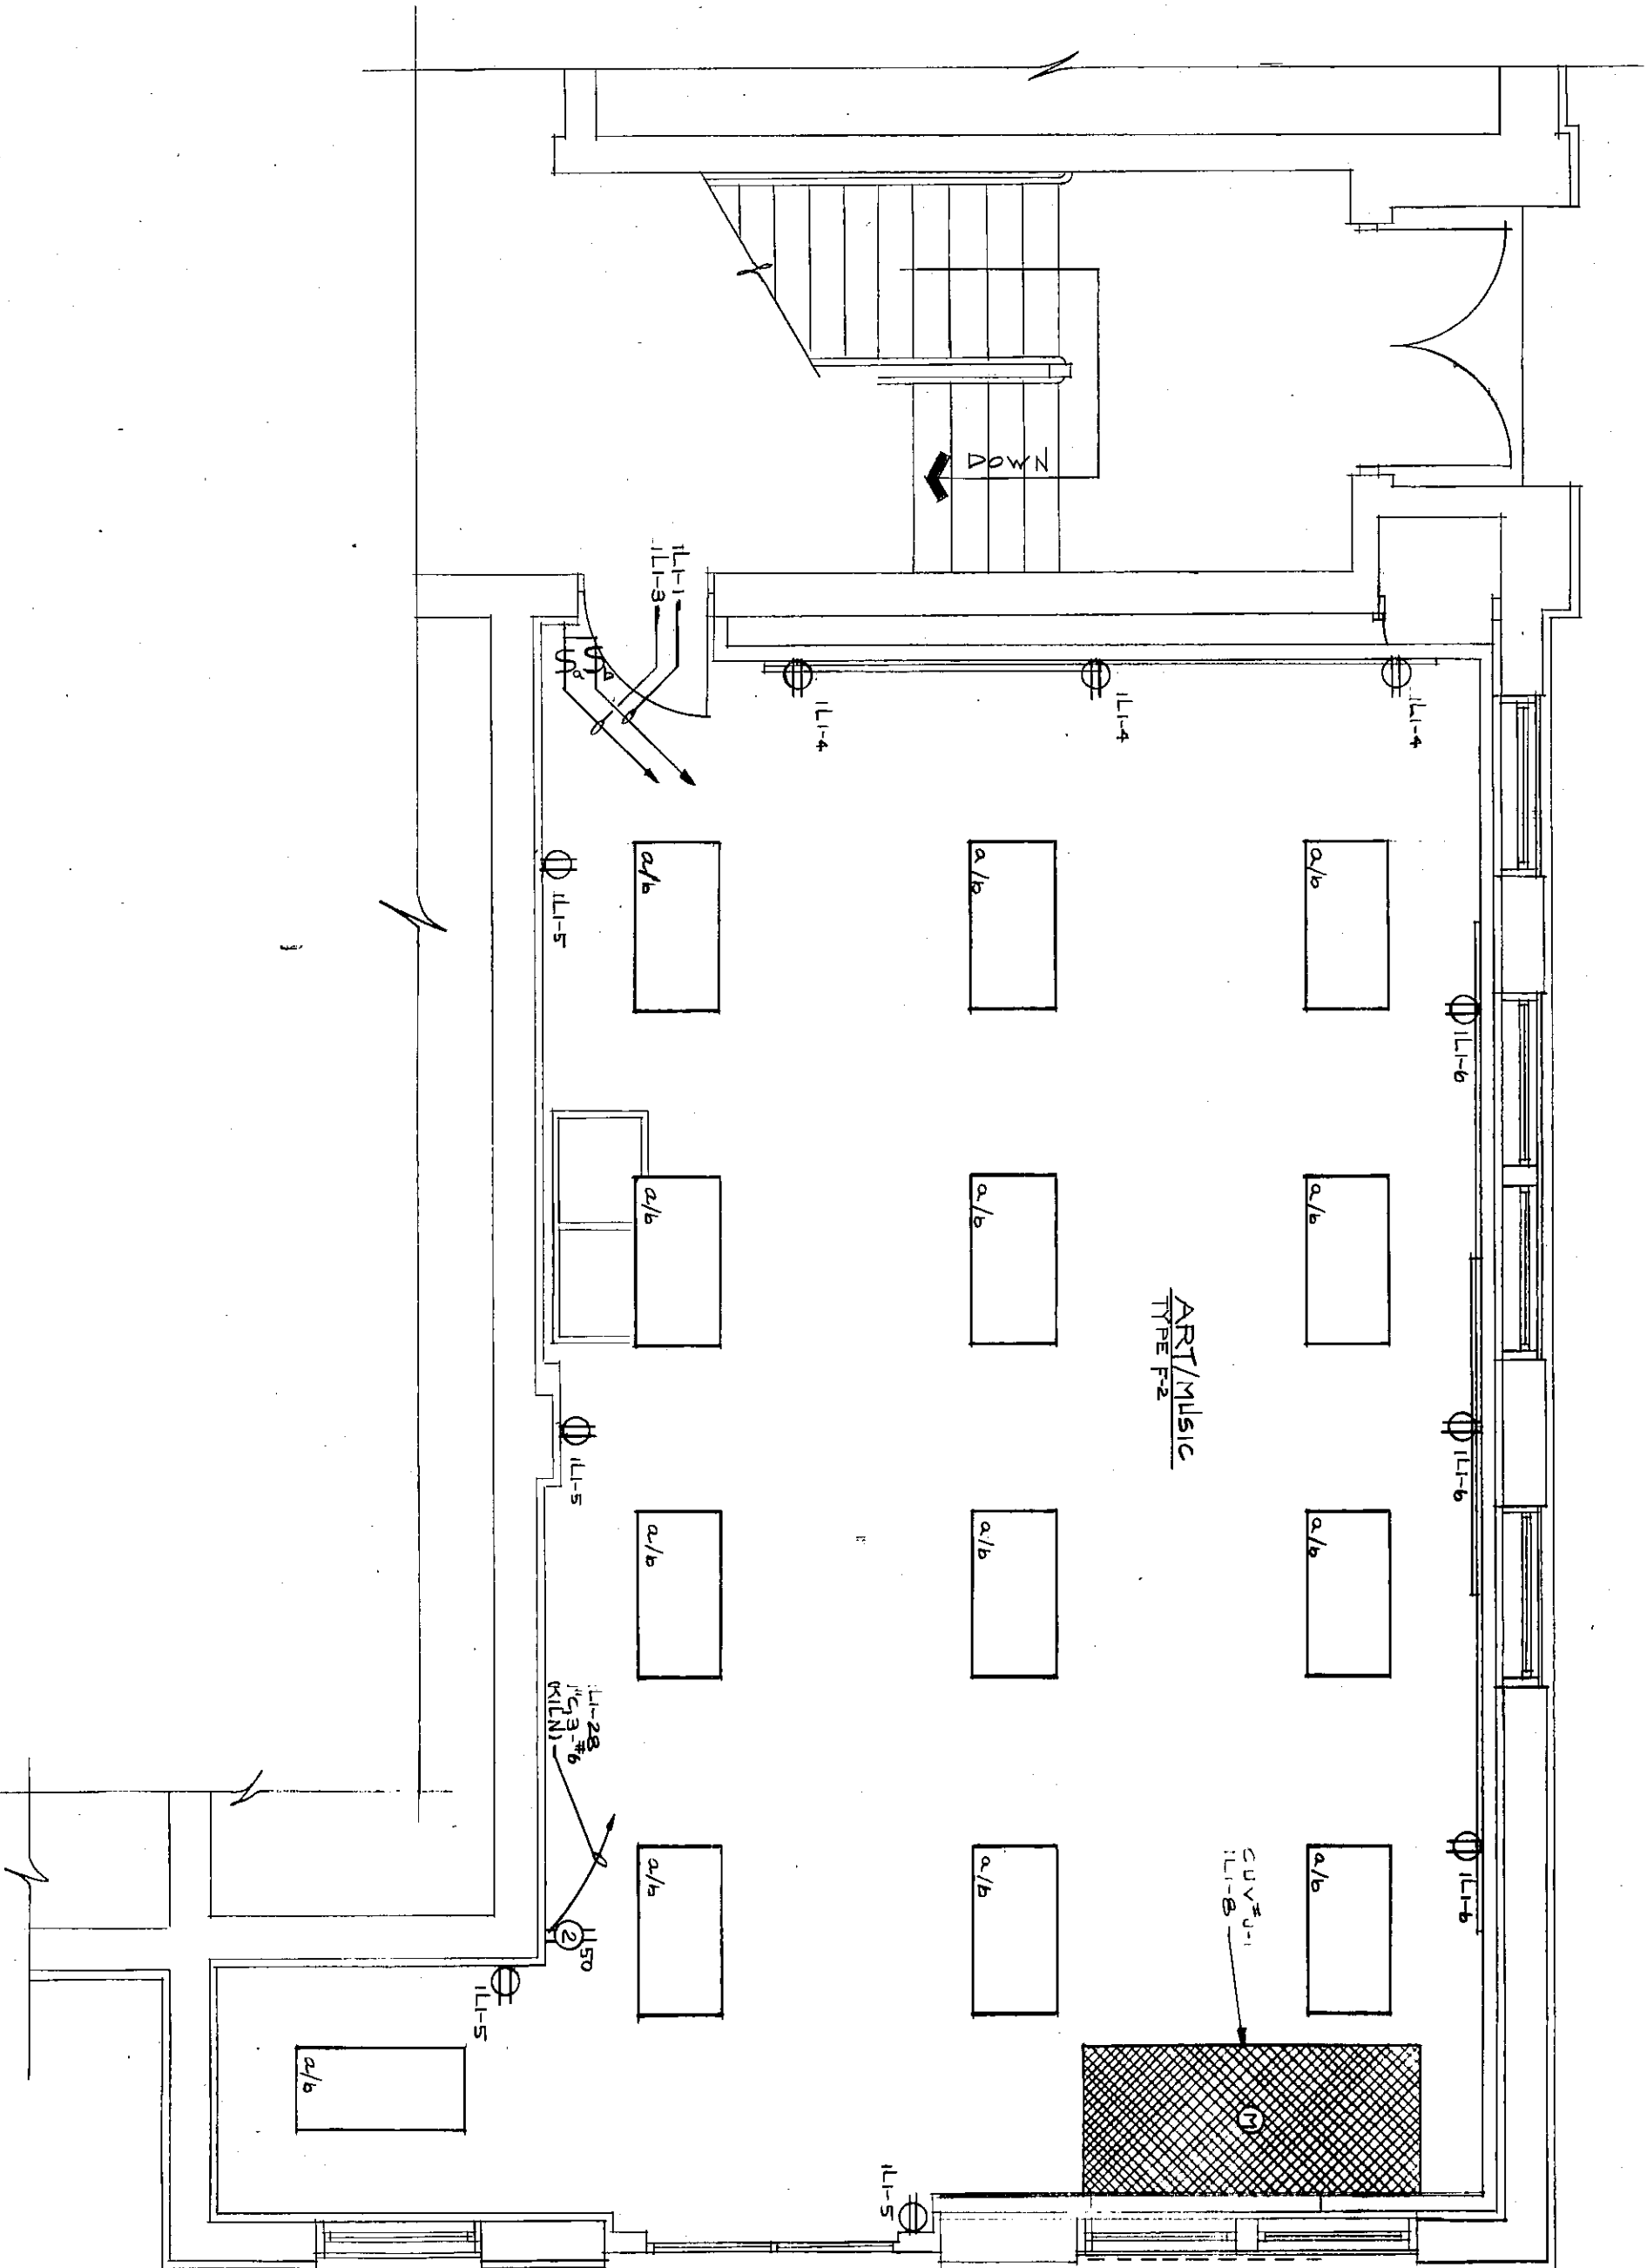

ELECTRICAL PLAN OF ART/MUSIC
JACKSON ELEMENTARY SCHOOL
SCALE: 1/8" = 1'-0"

PARTIAL ELECTRICAL PLAN OF EXISTING TRANSFORMER VAULT
JACKSON ELEMENTARY SCHOOL
SCALE: 1/8" = 1'-0"

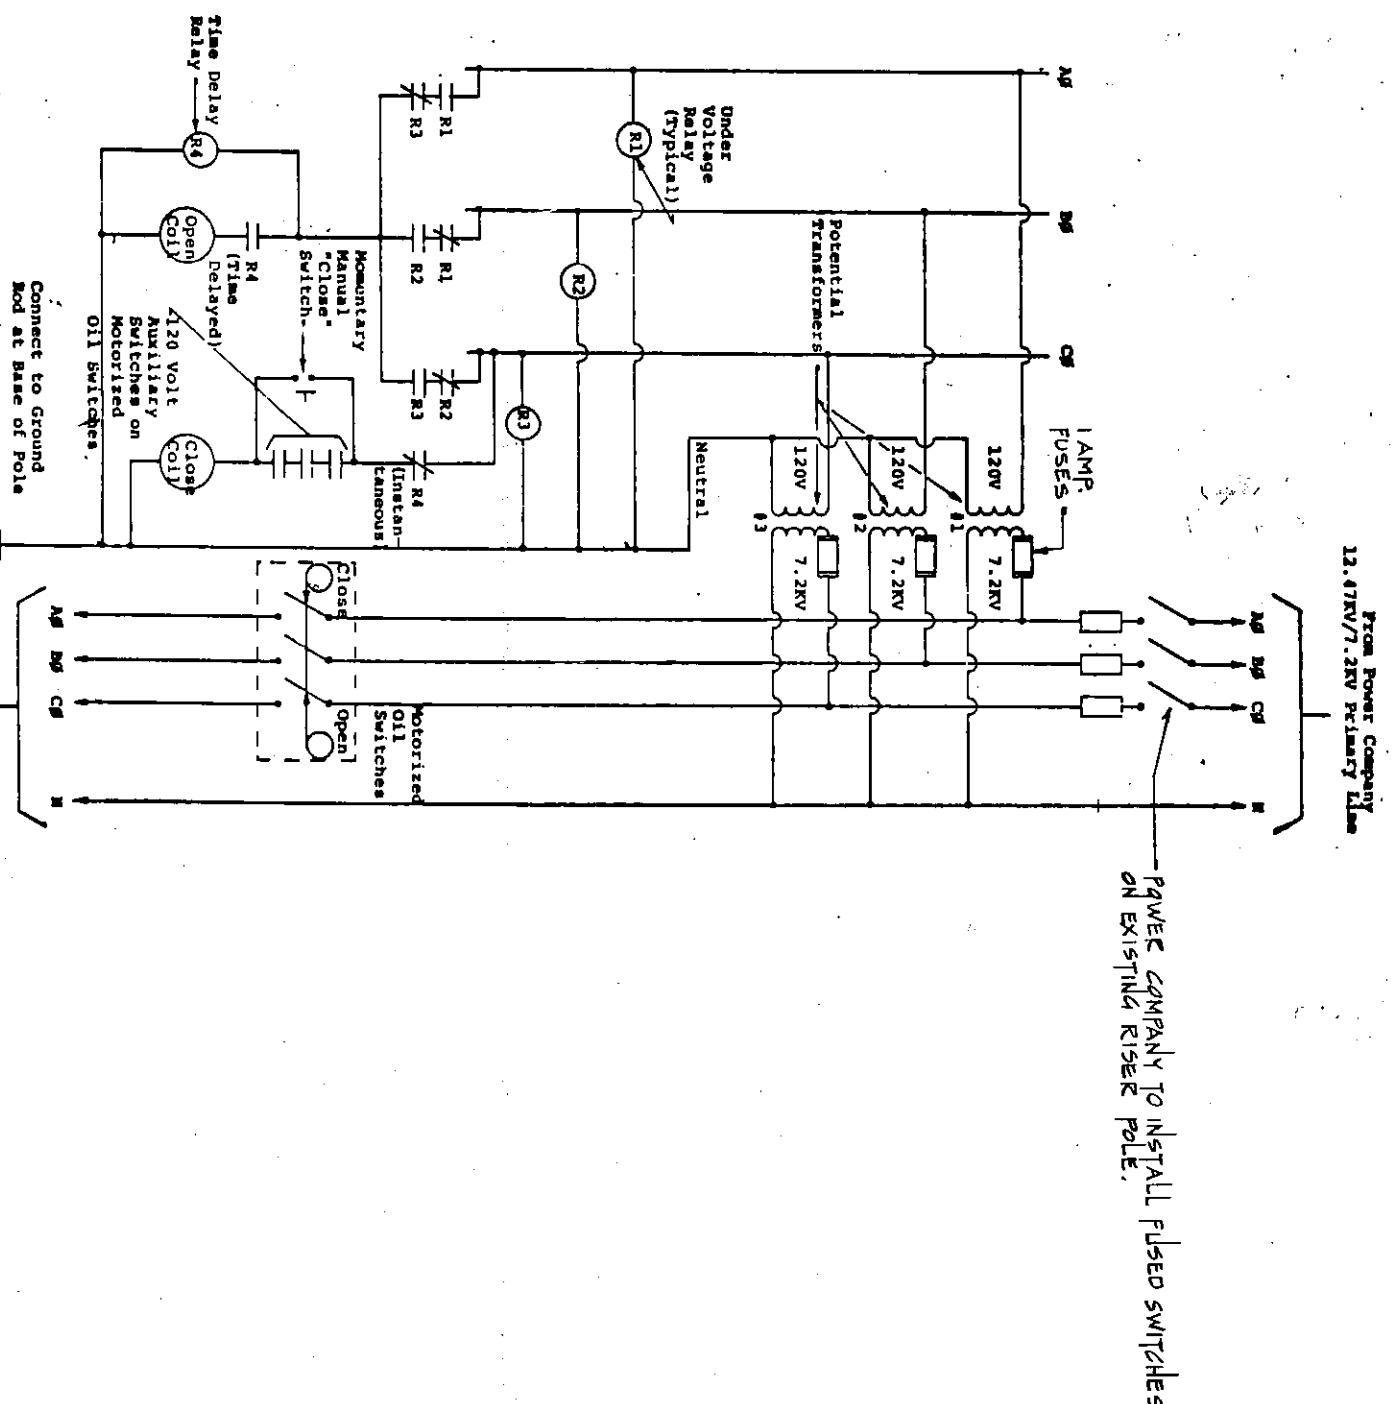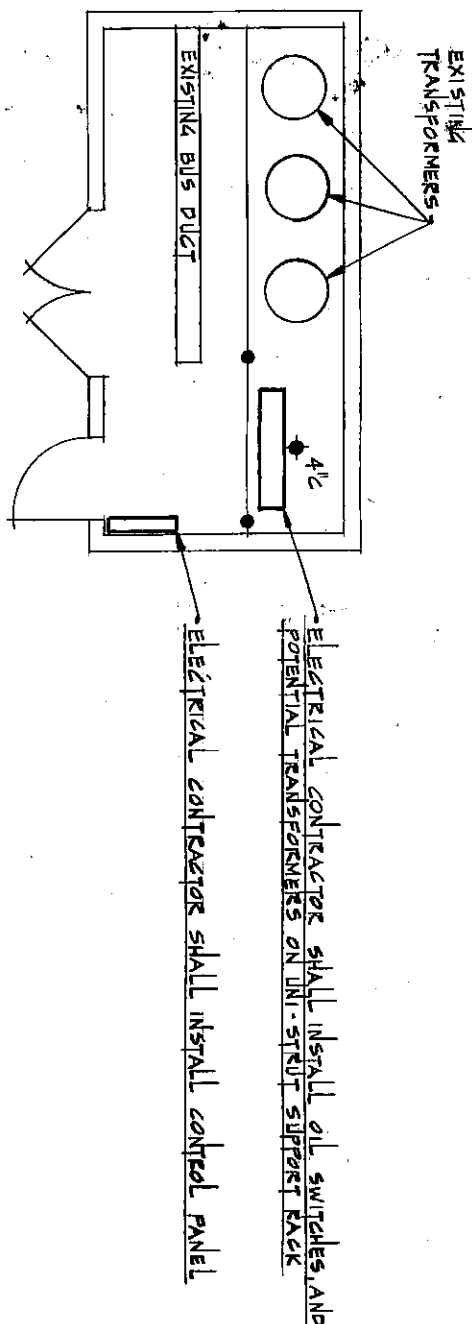

PRIMARY ANTI-SINGLE PHASE PROTECTOR WIRING DIAGRAM
JACKSON ELEMENTARY SCHOOL
SCALE: 1/8" = 1'-0"

1. See kitchen equipment schedule and notes for electrical work at room 111.

PLAN ROOM