




1. See Sheet E-1 for Electrical Symbols, Schedules, Details, and Notes.

PLAN NOTES

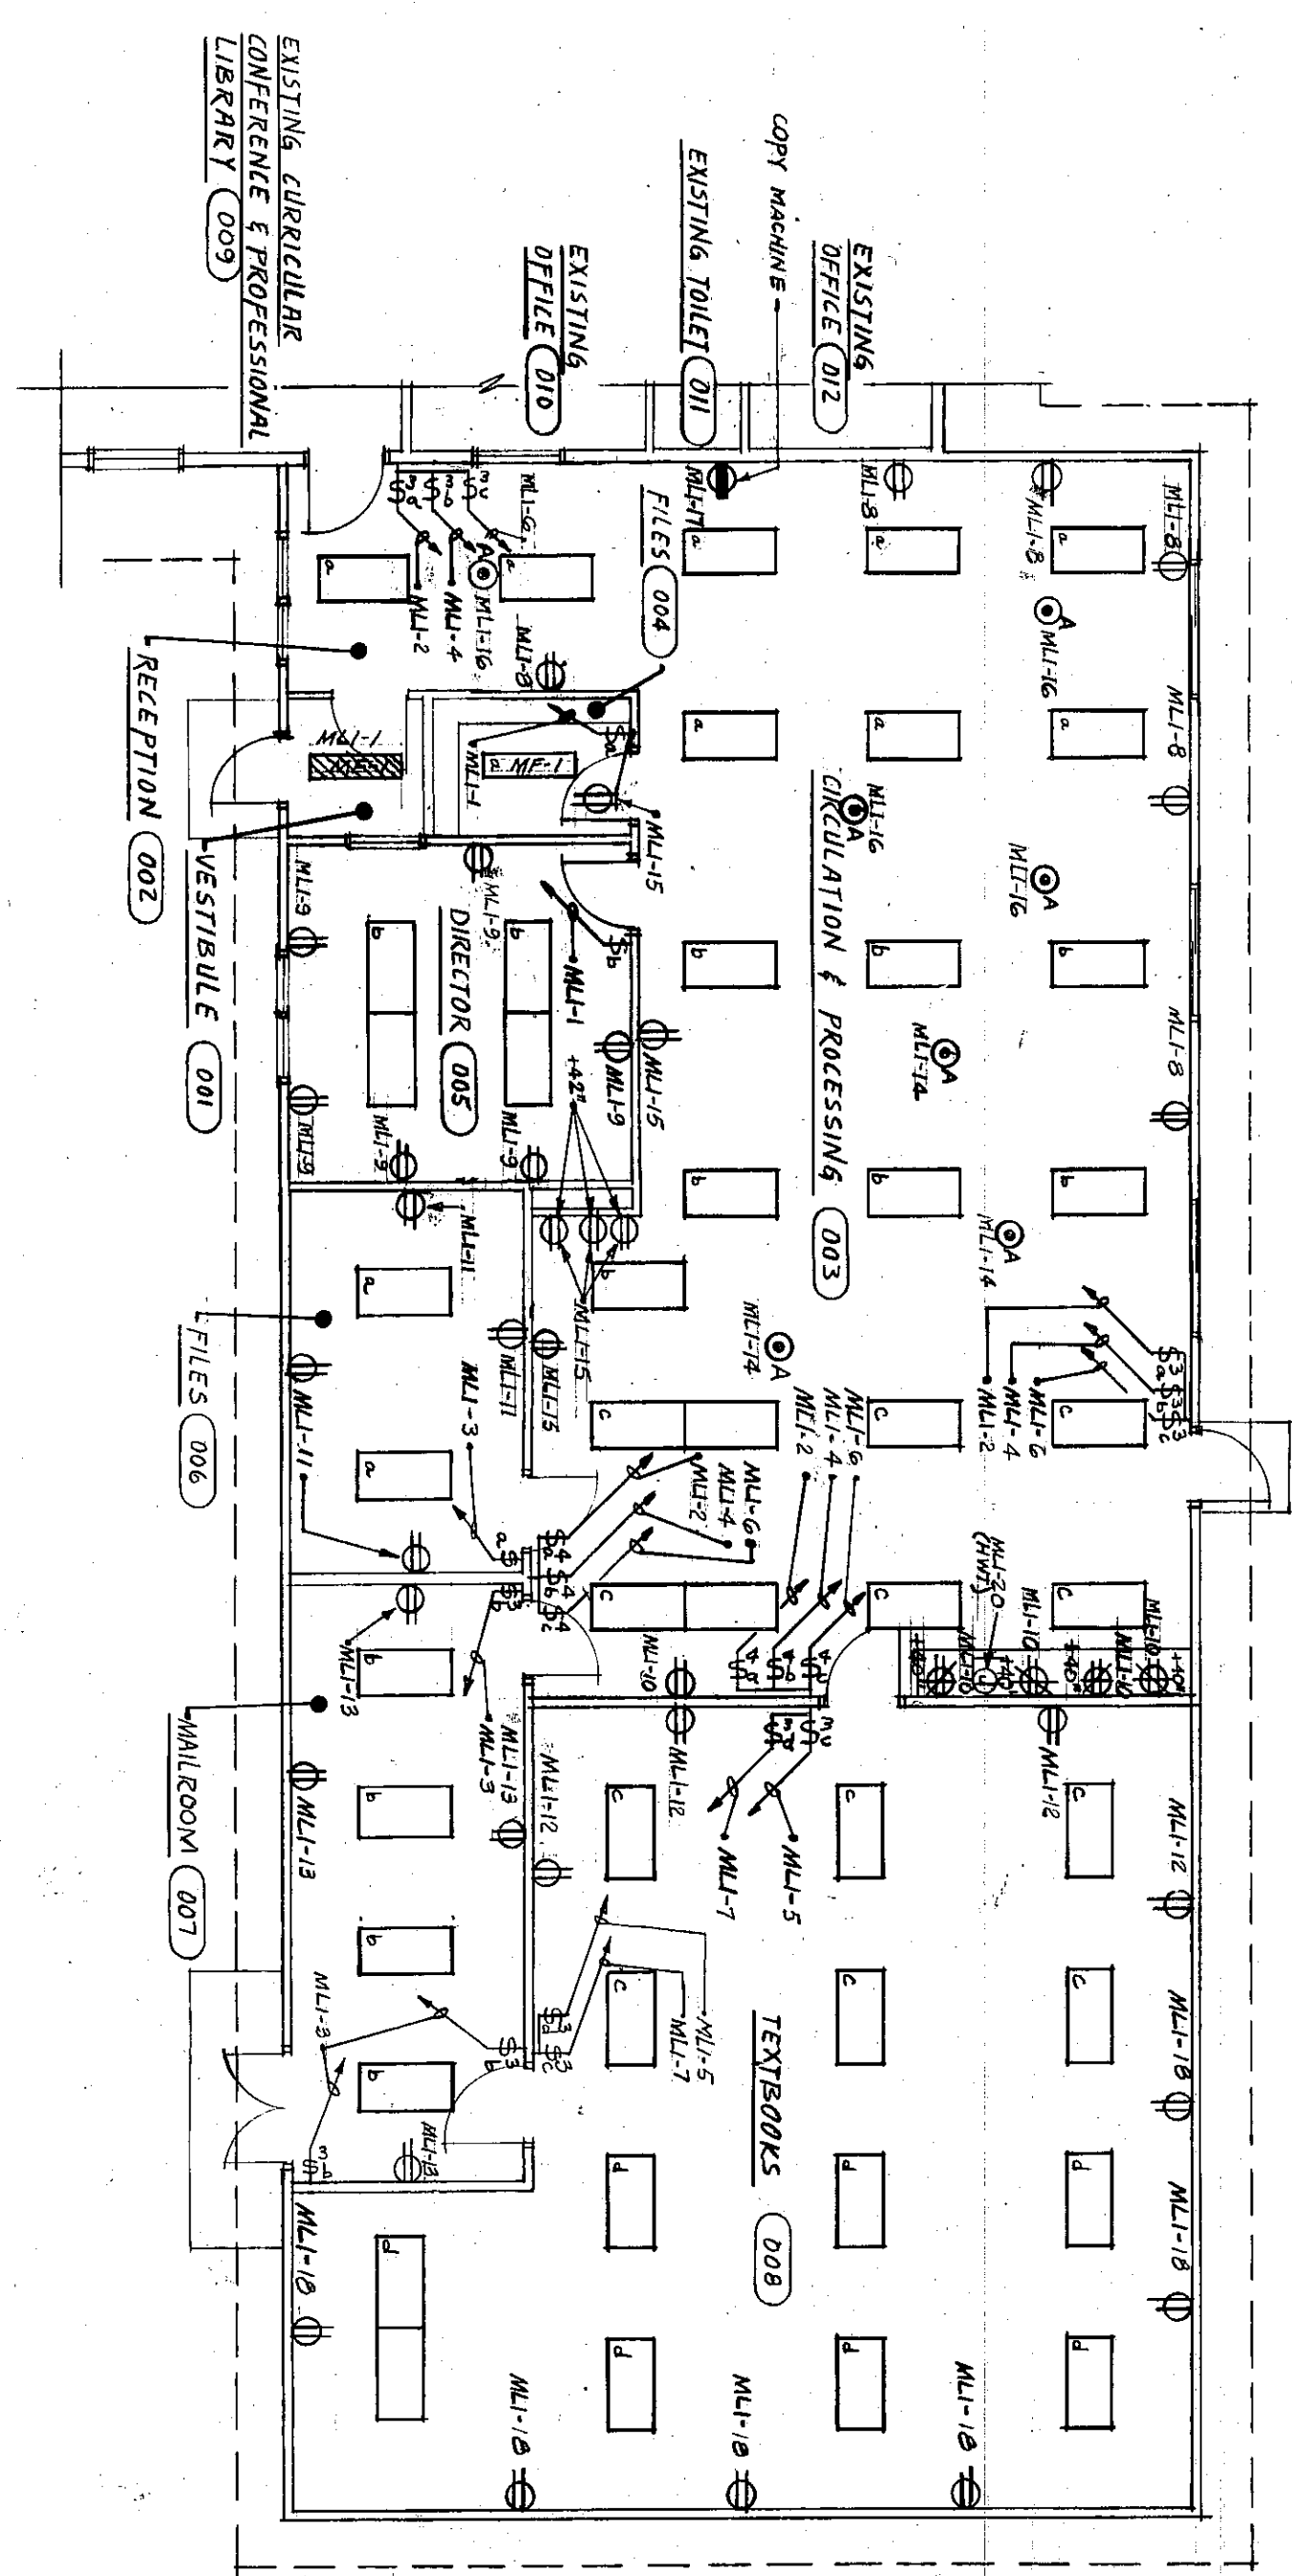



ELECTRICAL FIRST FLOOR PLAN

SCALE: 1/8"=1'-0"

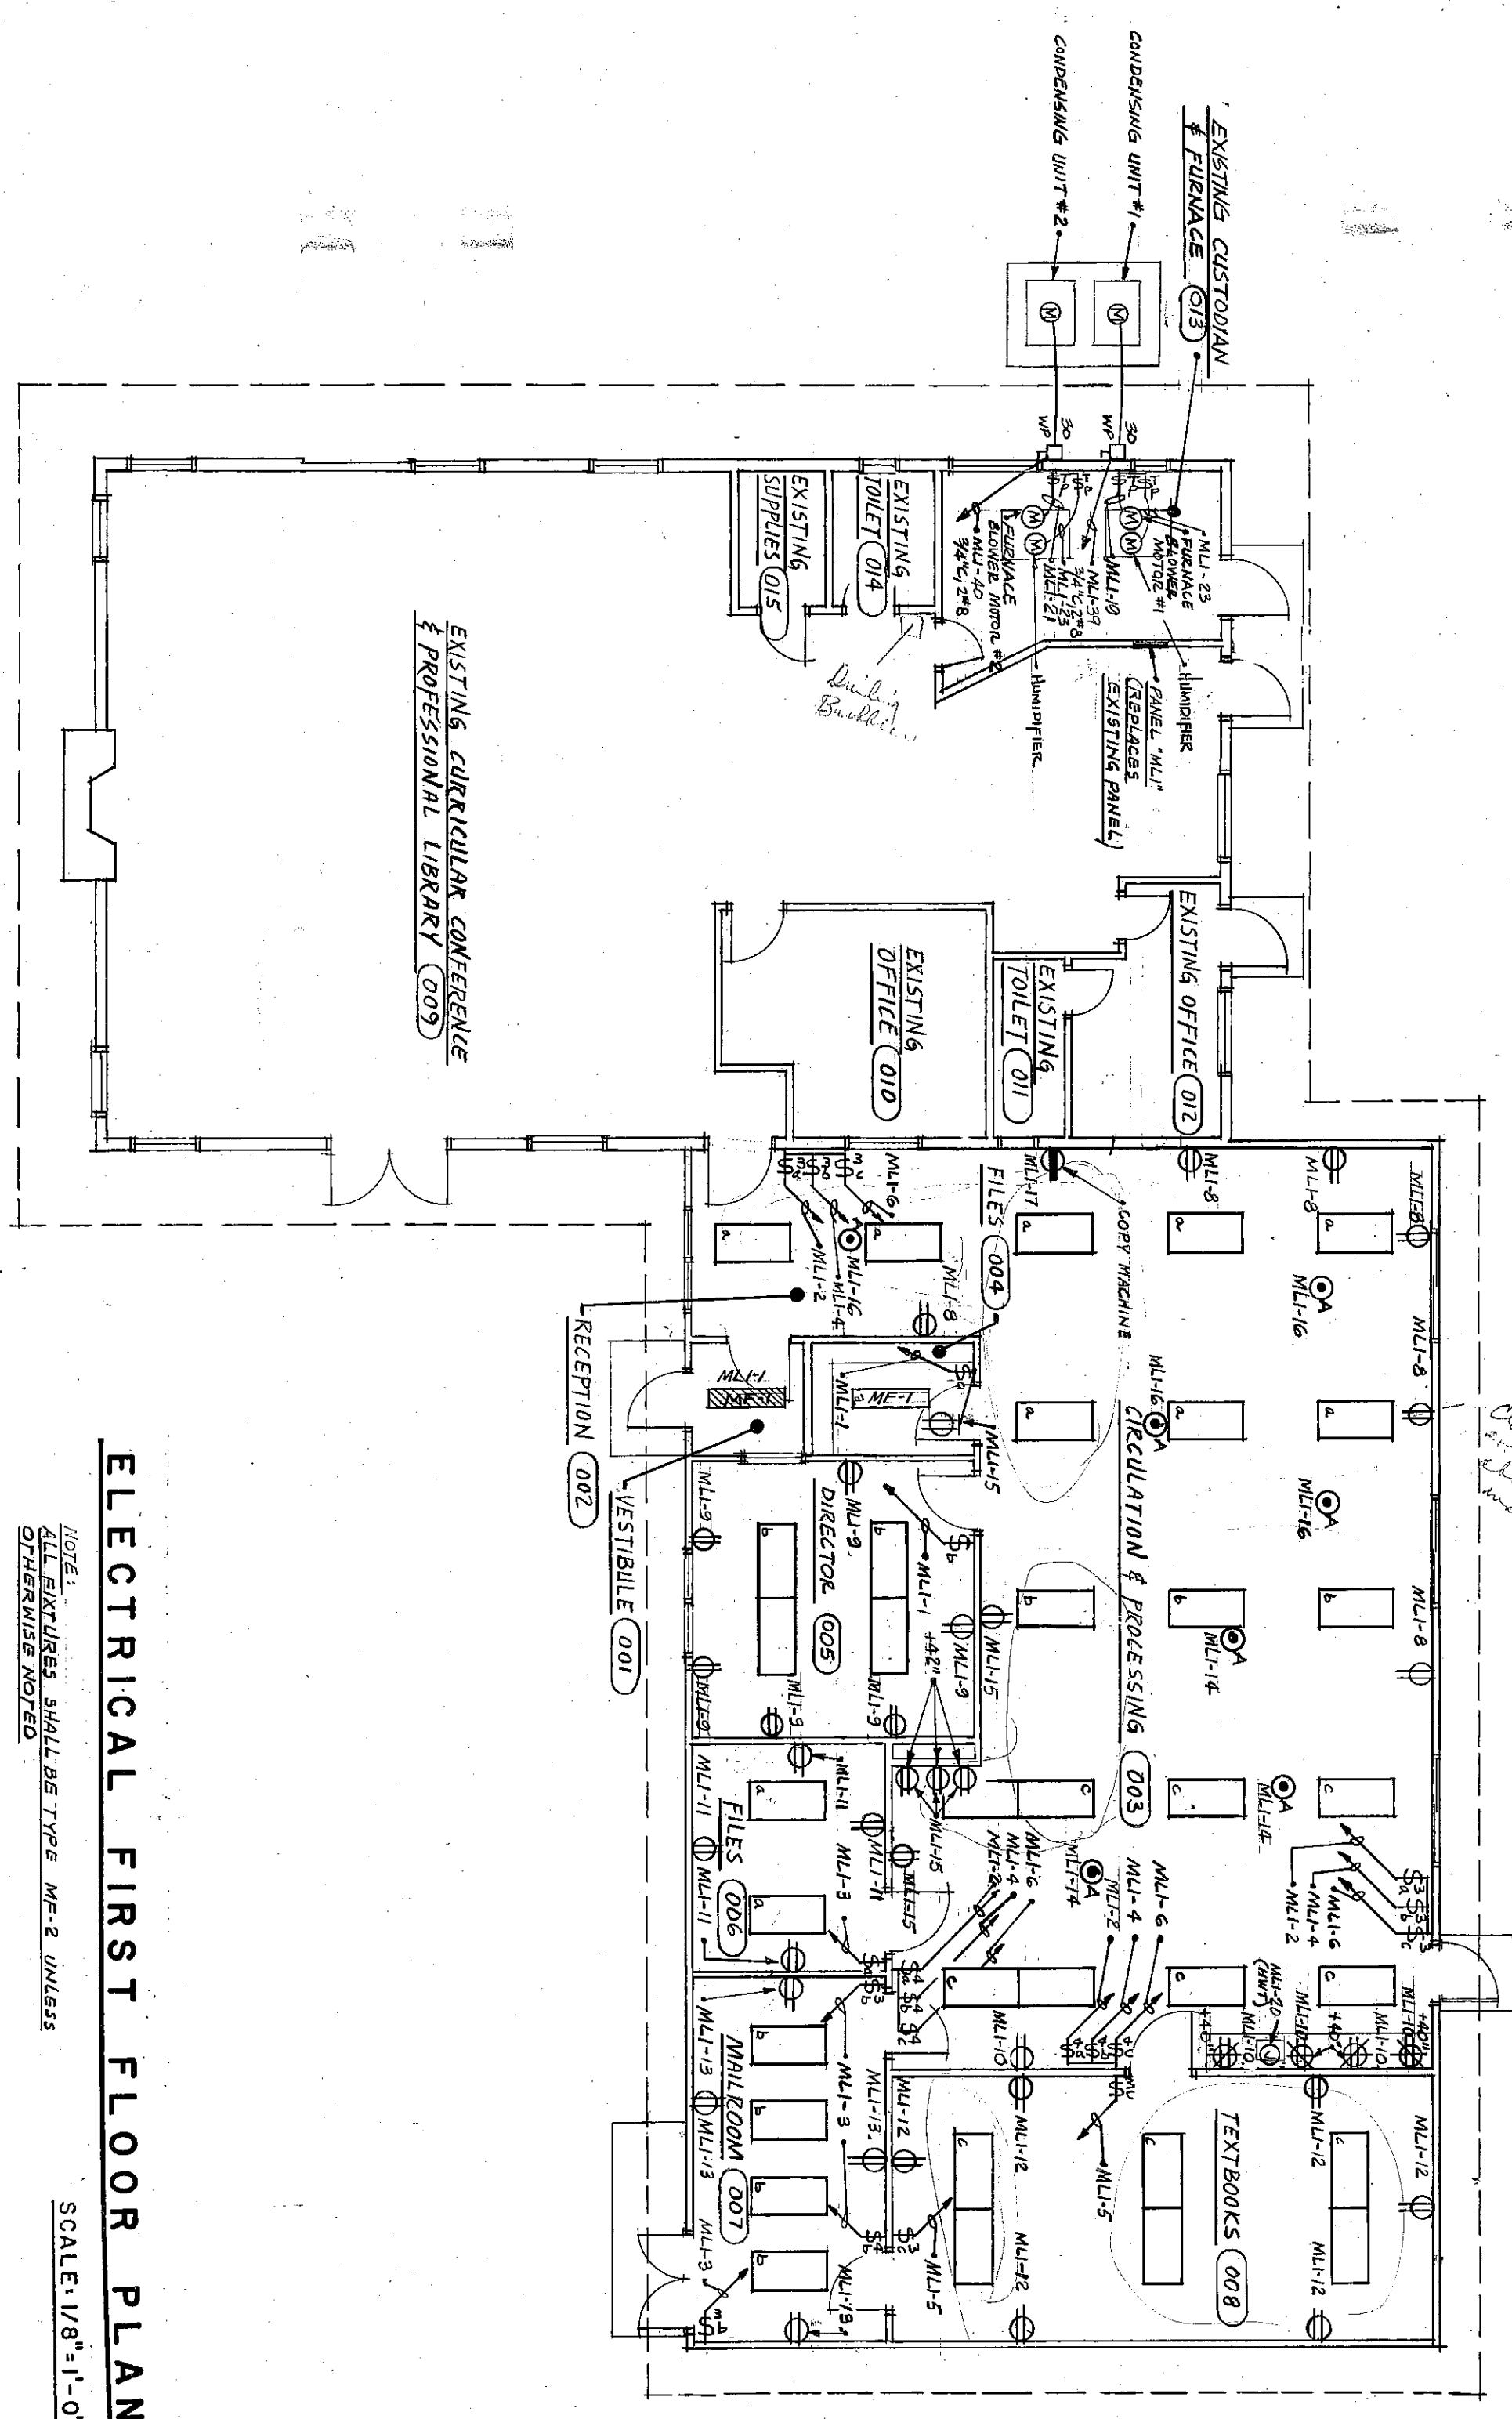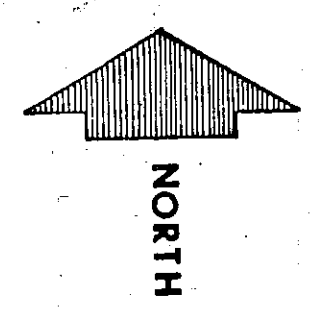

ELECTRICAL FIRST FLOOR PLAN


SCALE: 1/8"=1'-0"

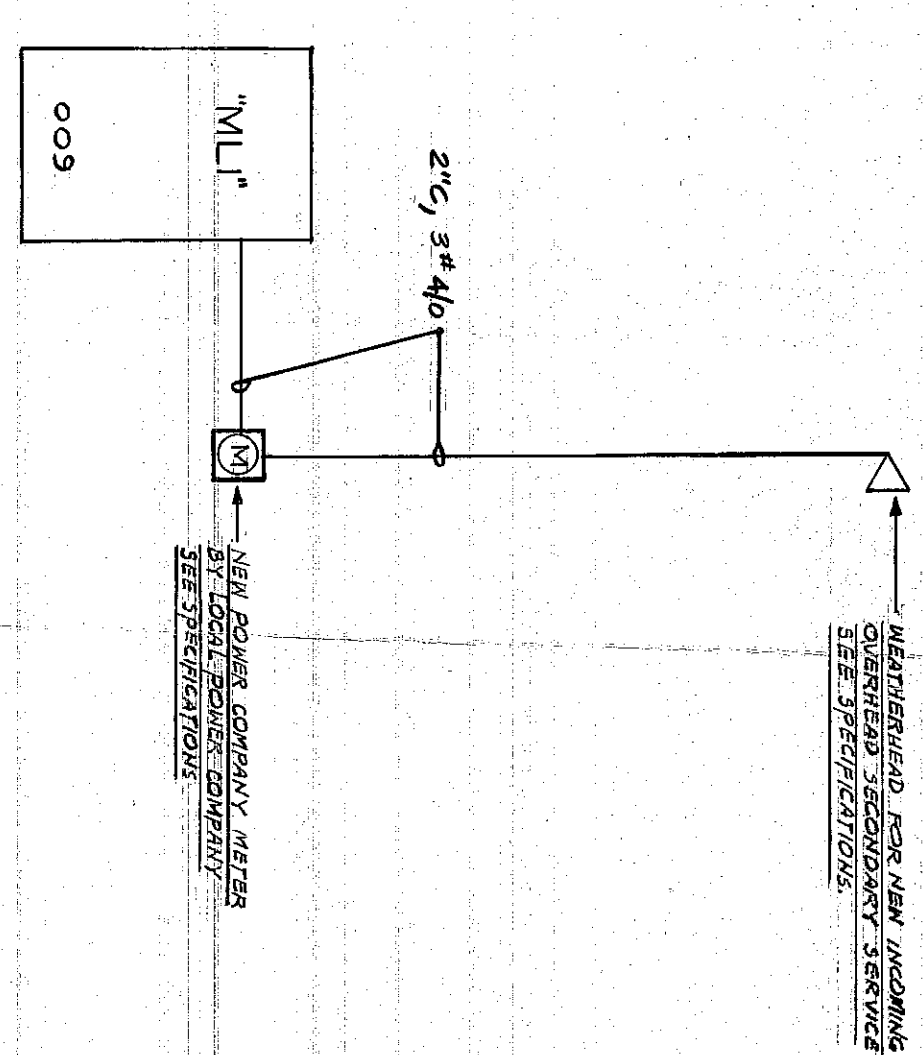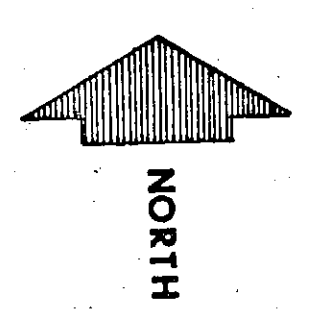

ELECTRICAL POWER DISTRIBUTION DIAGRAM

NO SCALE

PANEL SCHEDULE				REMARKS
NAME & TYPE	CIRCUITS	RECEIVED ON SWITCH	RECEIVED ON PANEL	
ML-1, 100 AMP, 120/208V, 3P, 4W, AN	1-30	21-40	100 AMP, 120/208V, 3P, 4W, AN	REPLACES EXISTING PANEL. NEW PANEL. EXISTING CIRCUITS TO BE REMOVED.

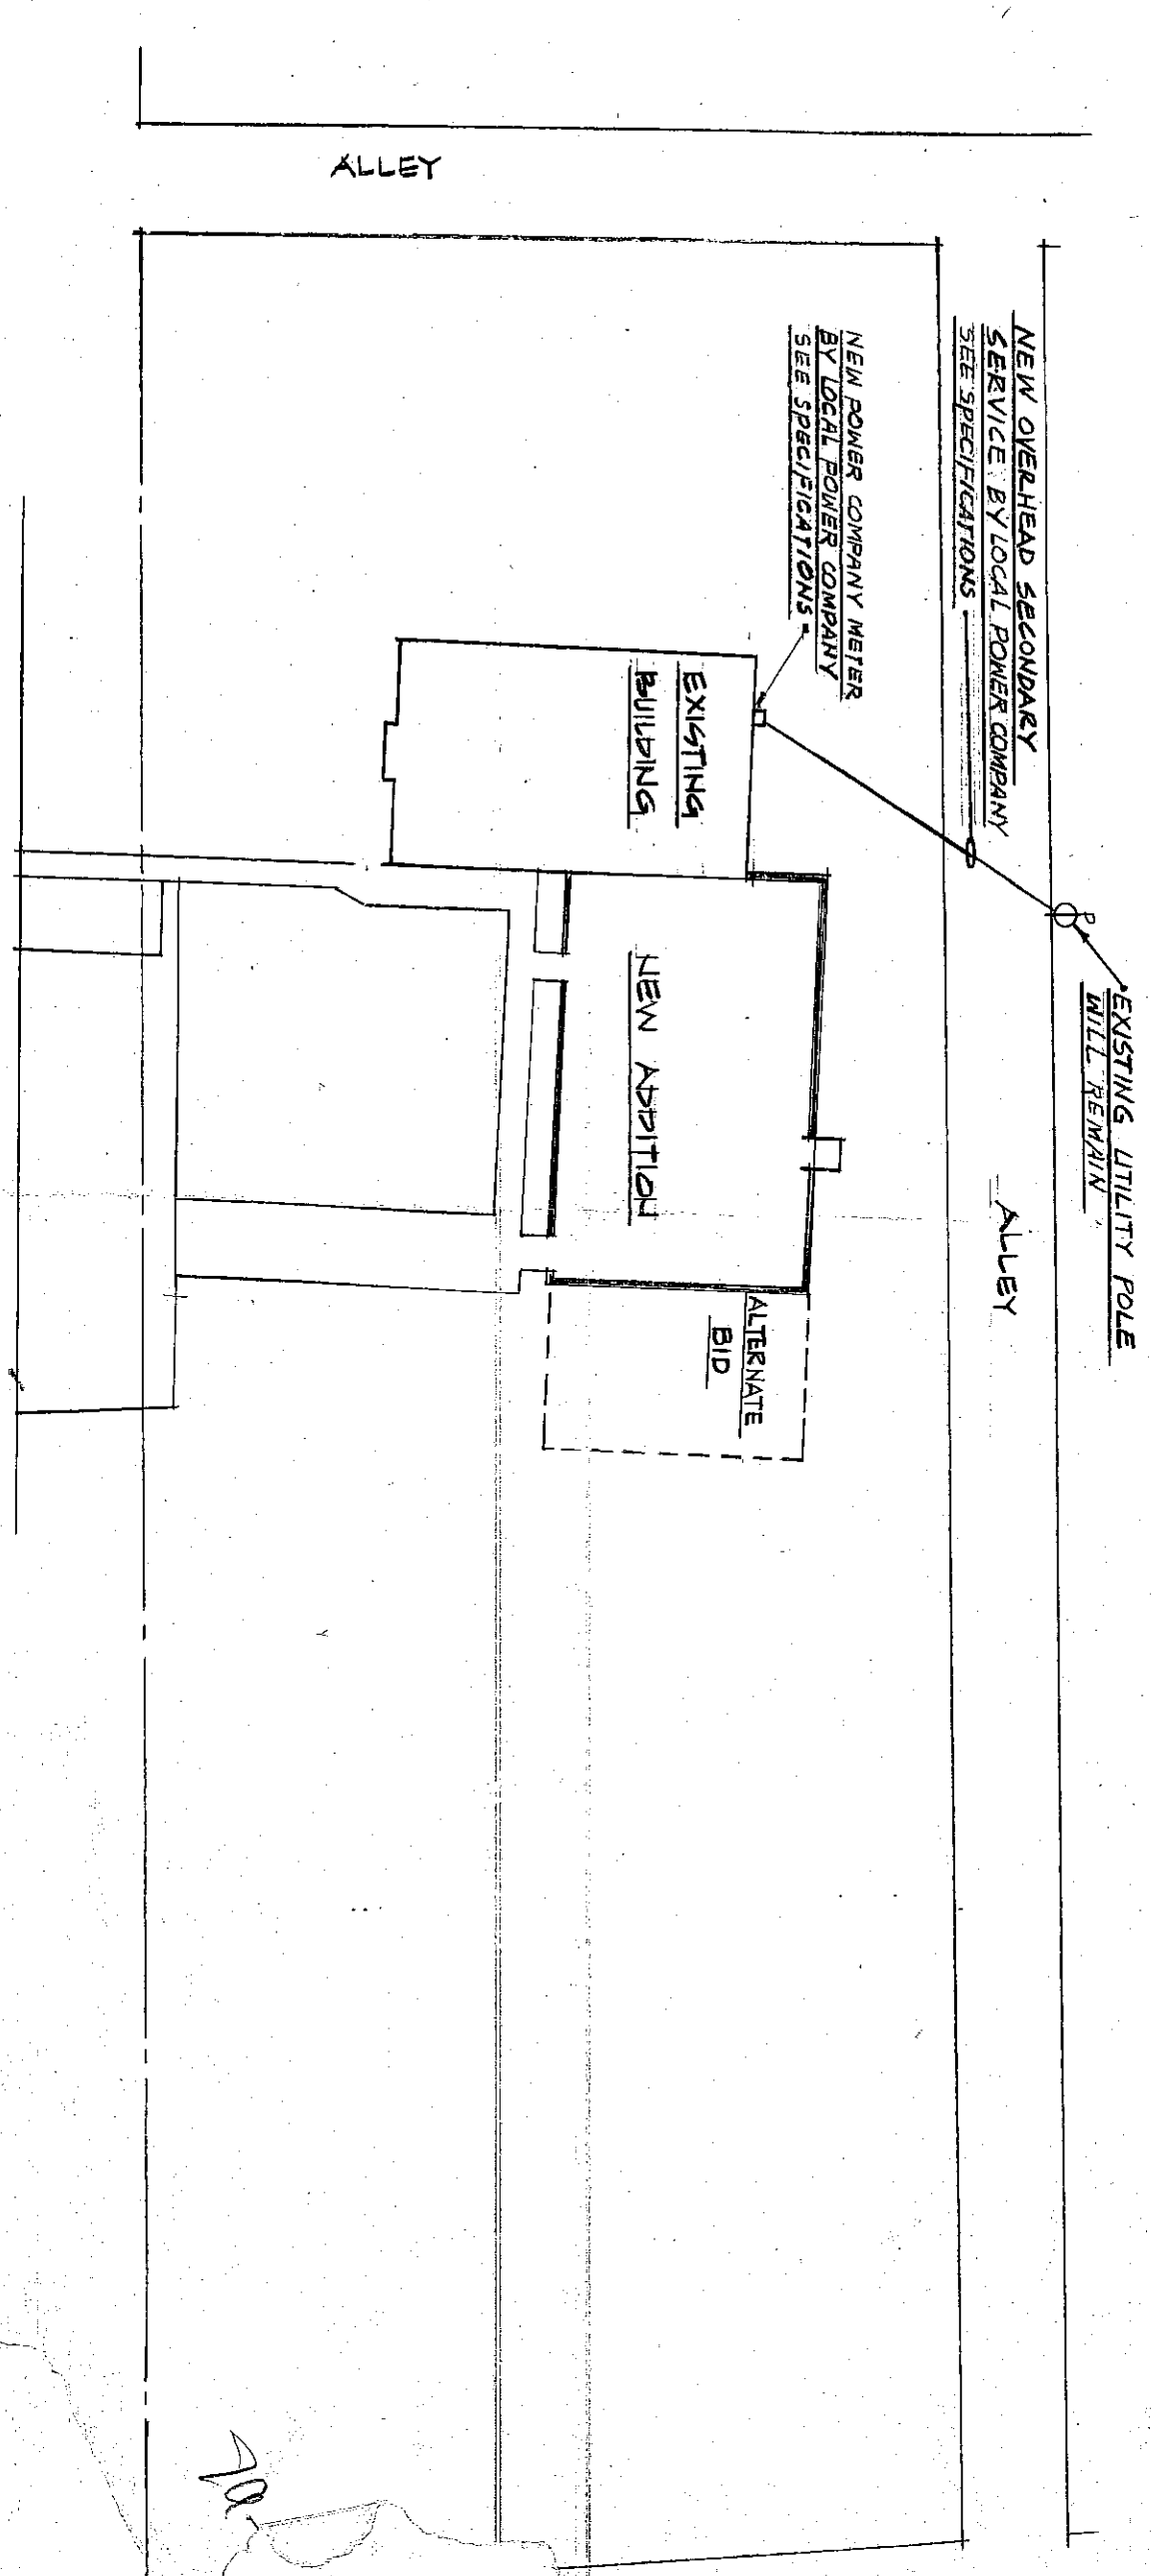

ELECTRICAL SITE PLAN

SCALE: 1/32"=1'-0"

