




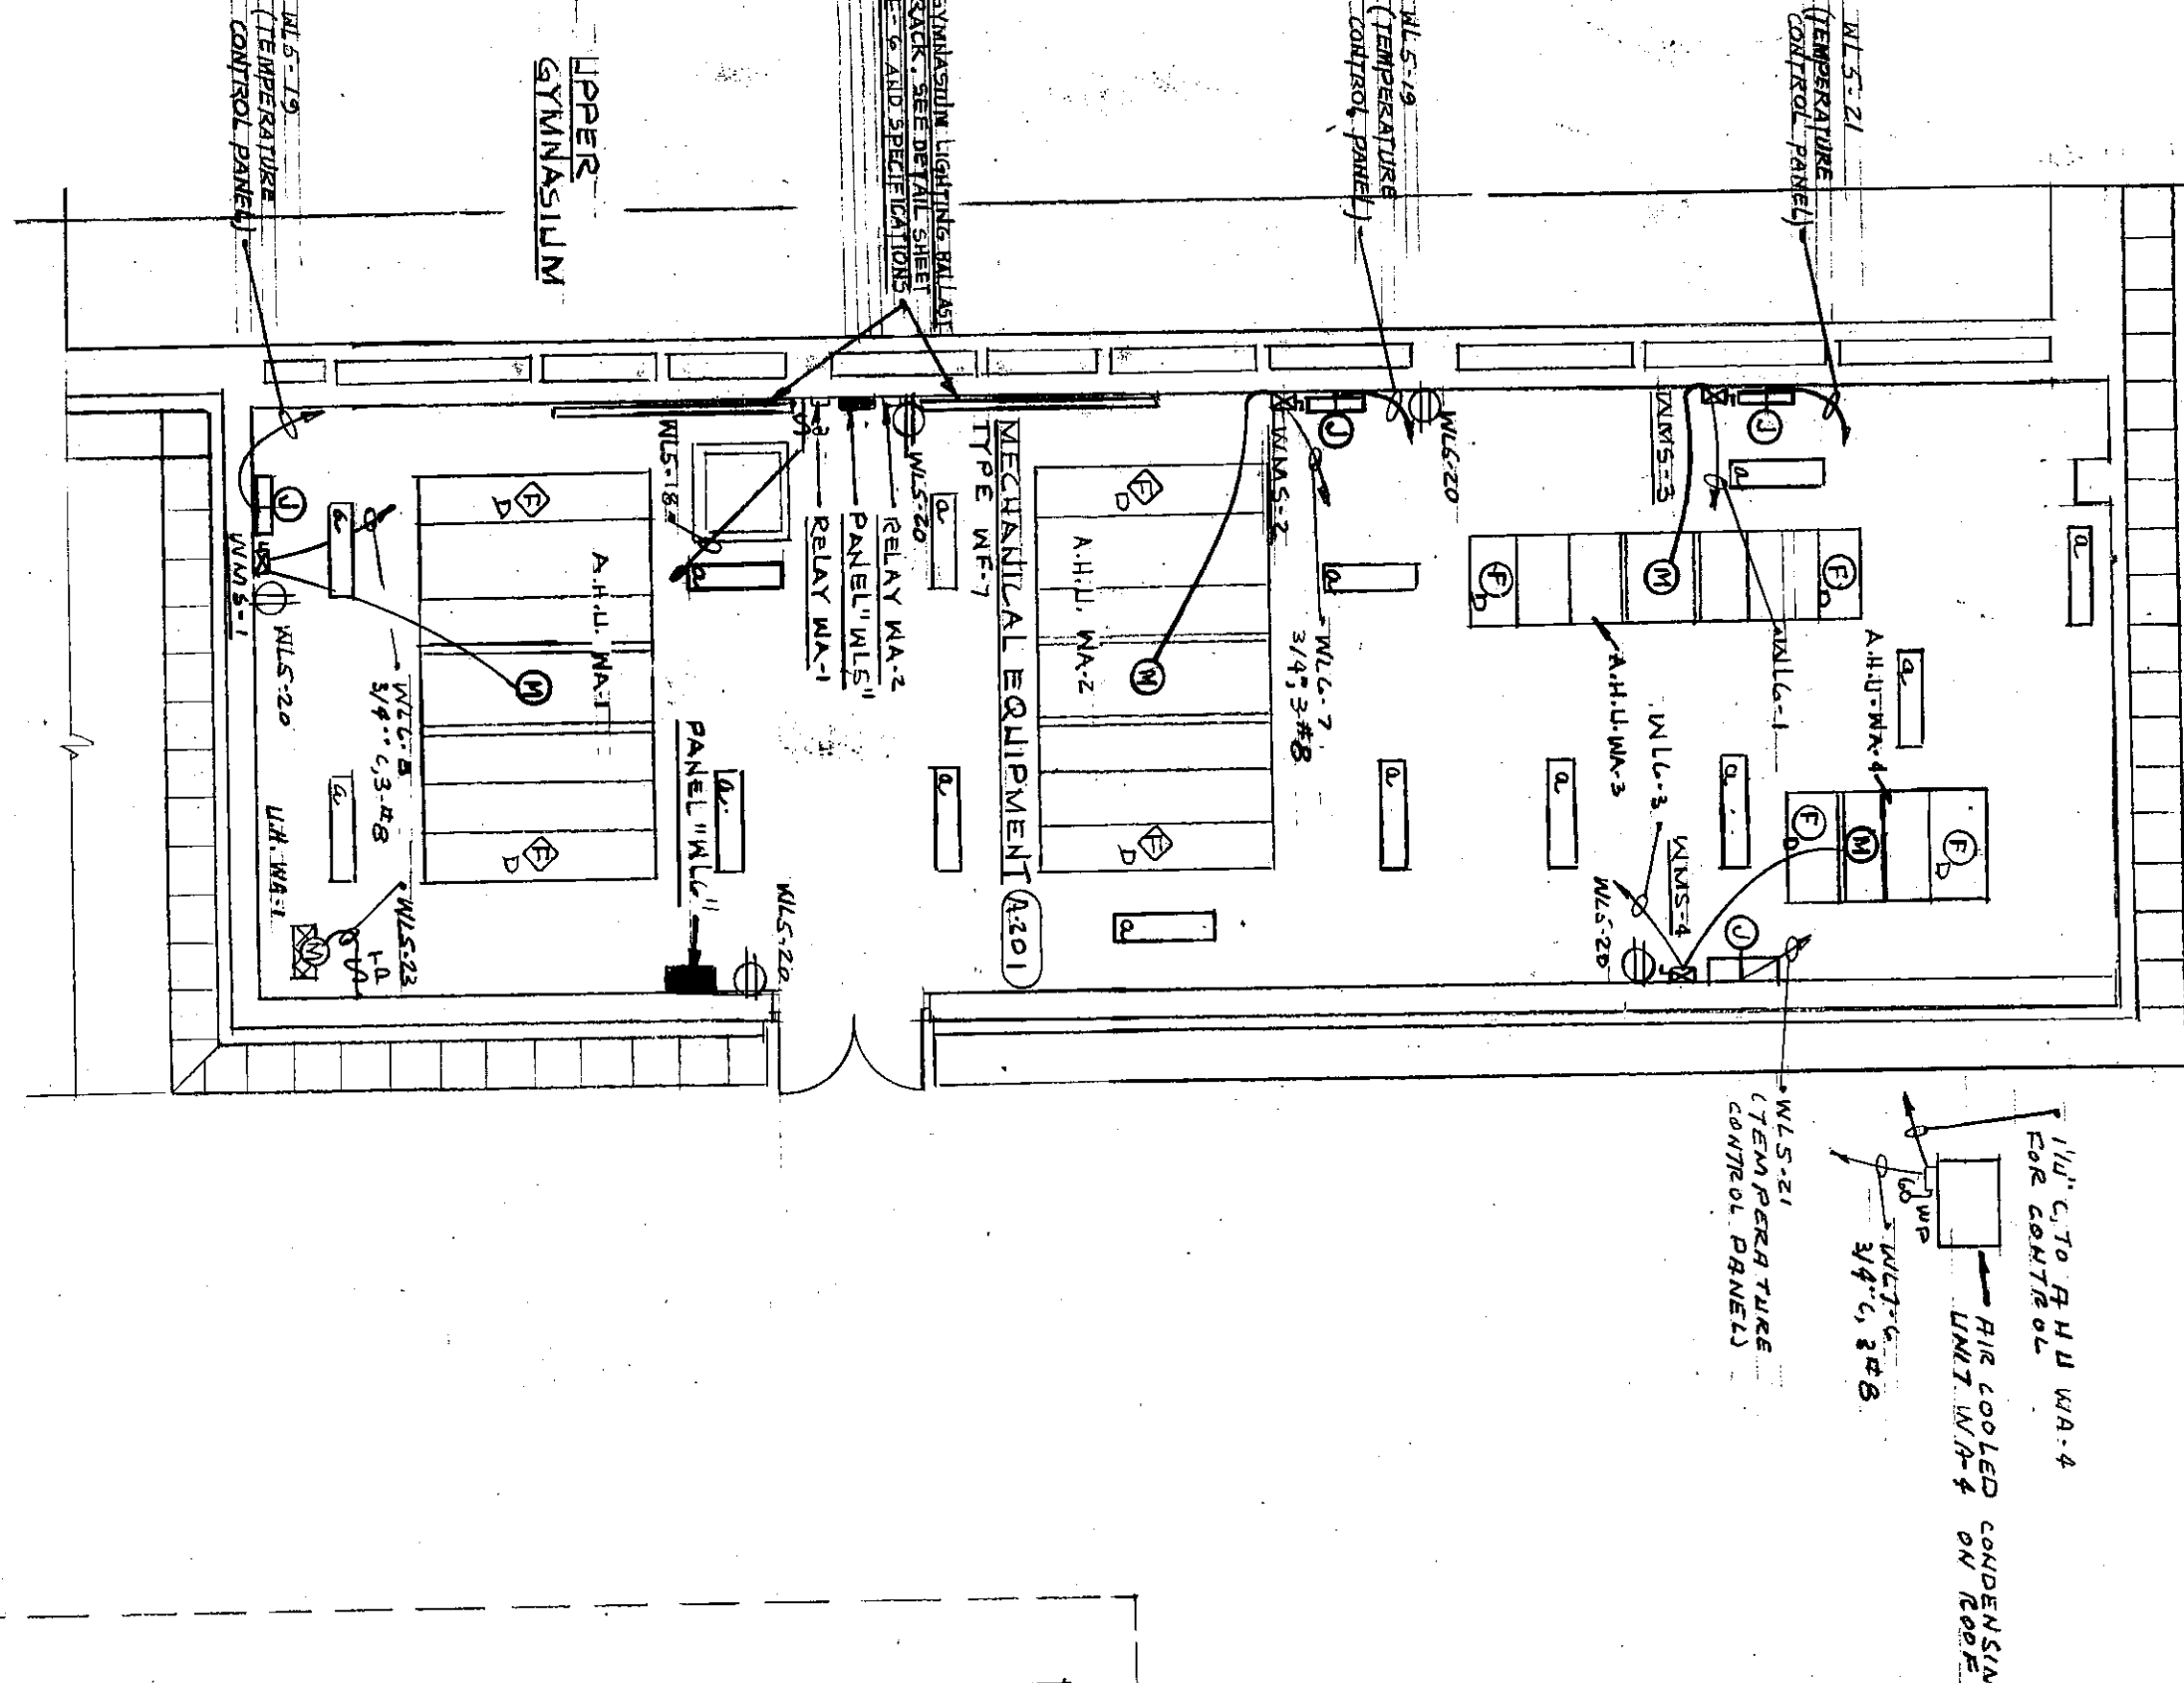


UNIT A ELECTRICAL SECOND FLOOR PLAN
SCALE 1/8"=1'-0"

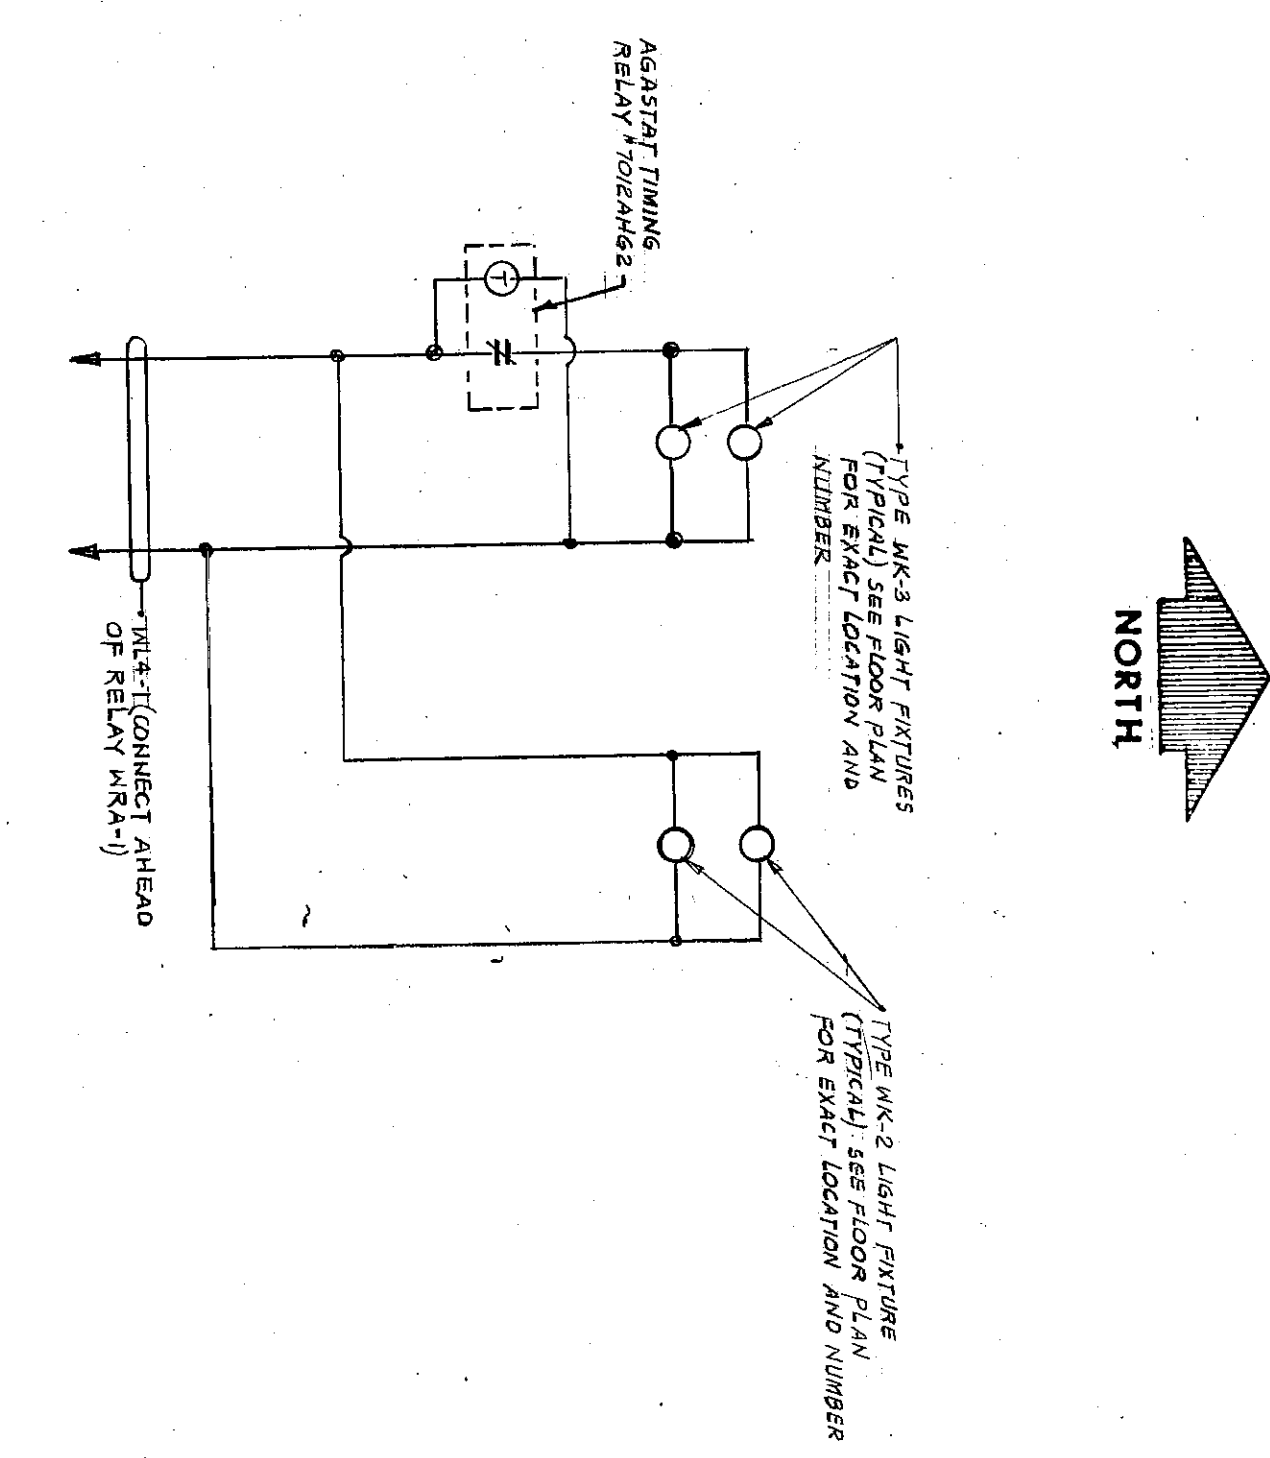



EMERGENCY LIGHTING CONTROL DIAGRAM
NO SCALE

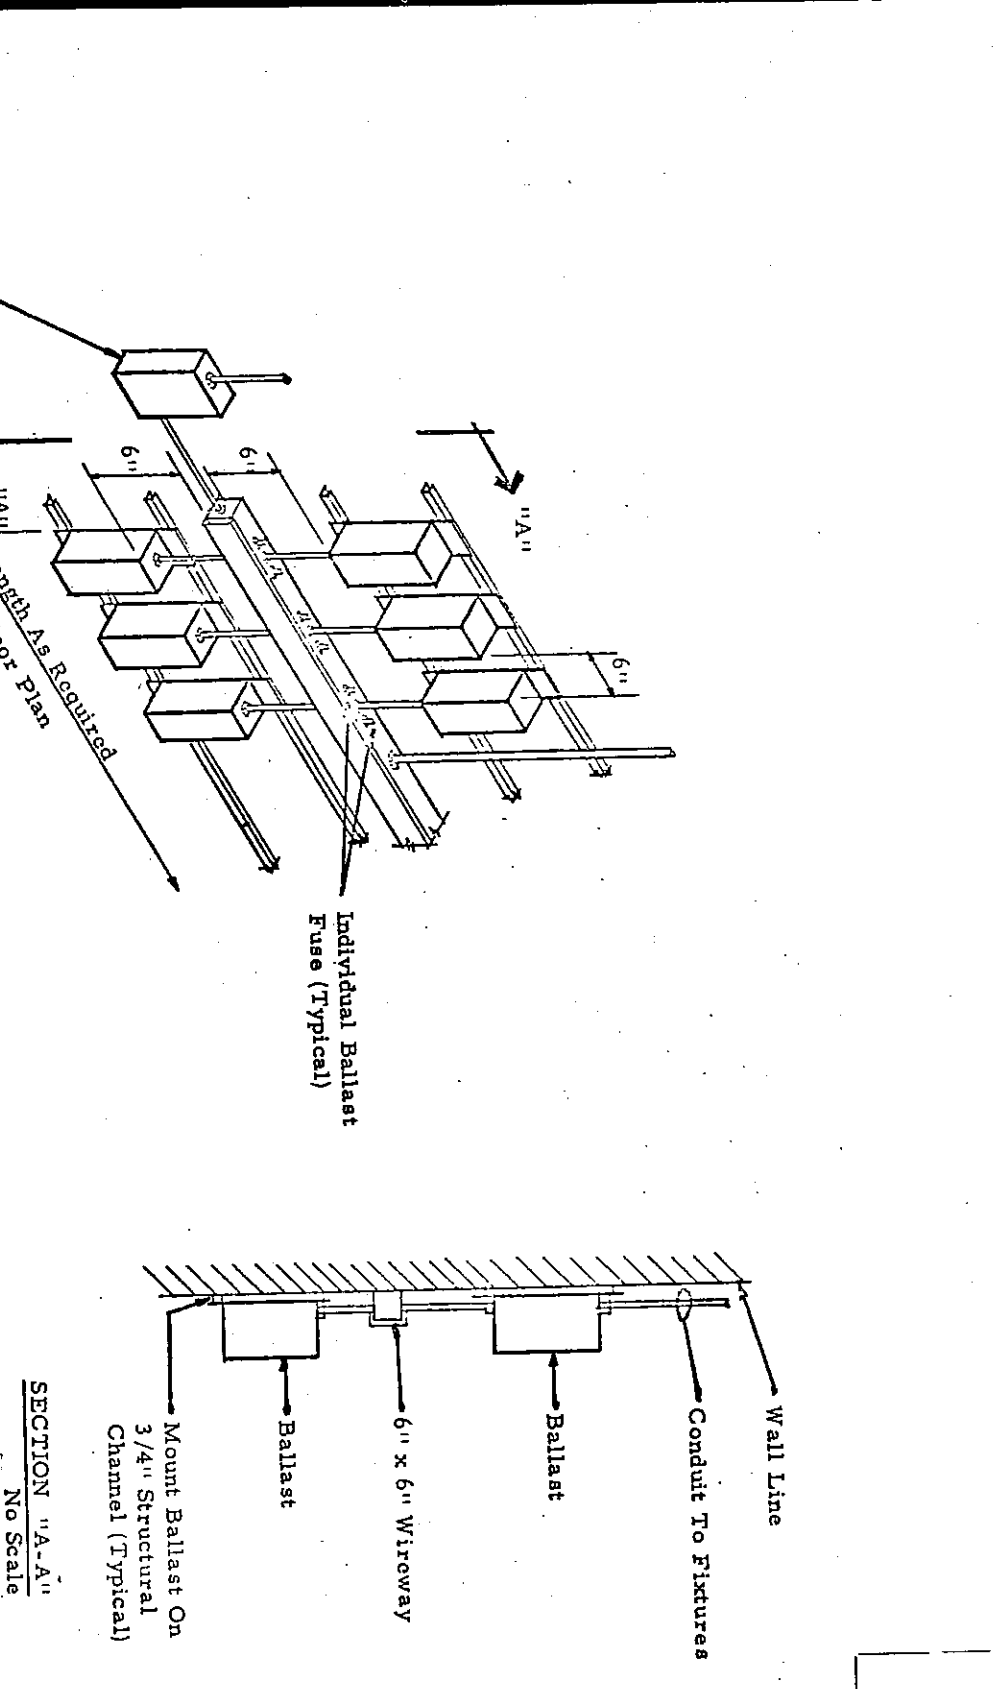

TYPICAL BALLAST BACK MOUNTING DETAIL
NO SCALE

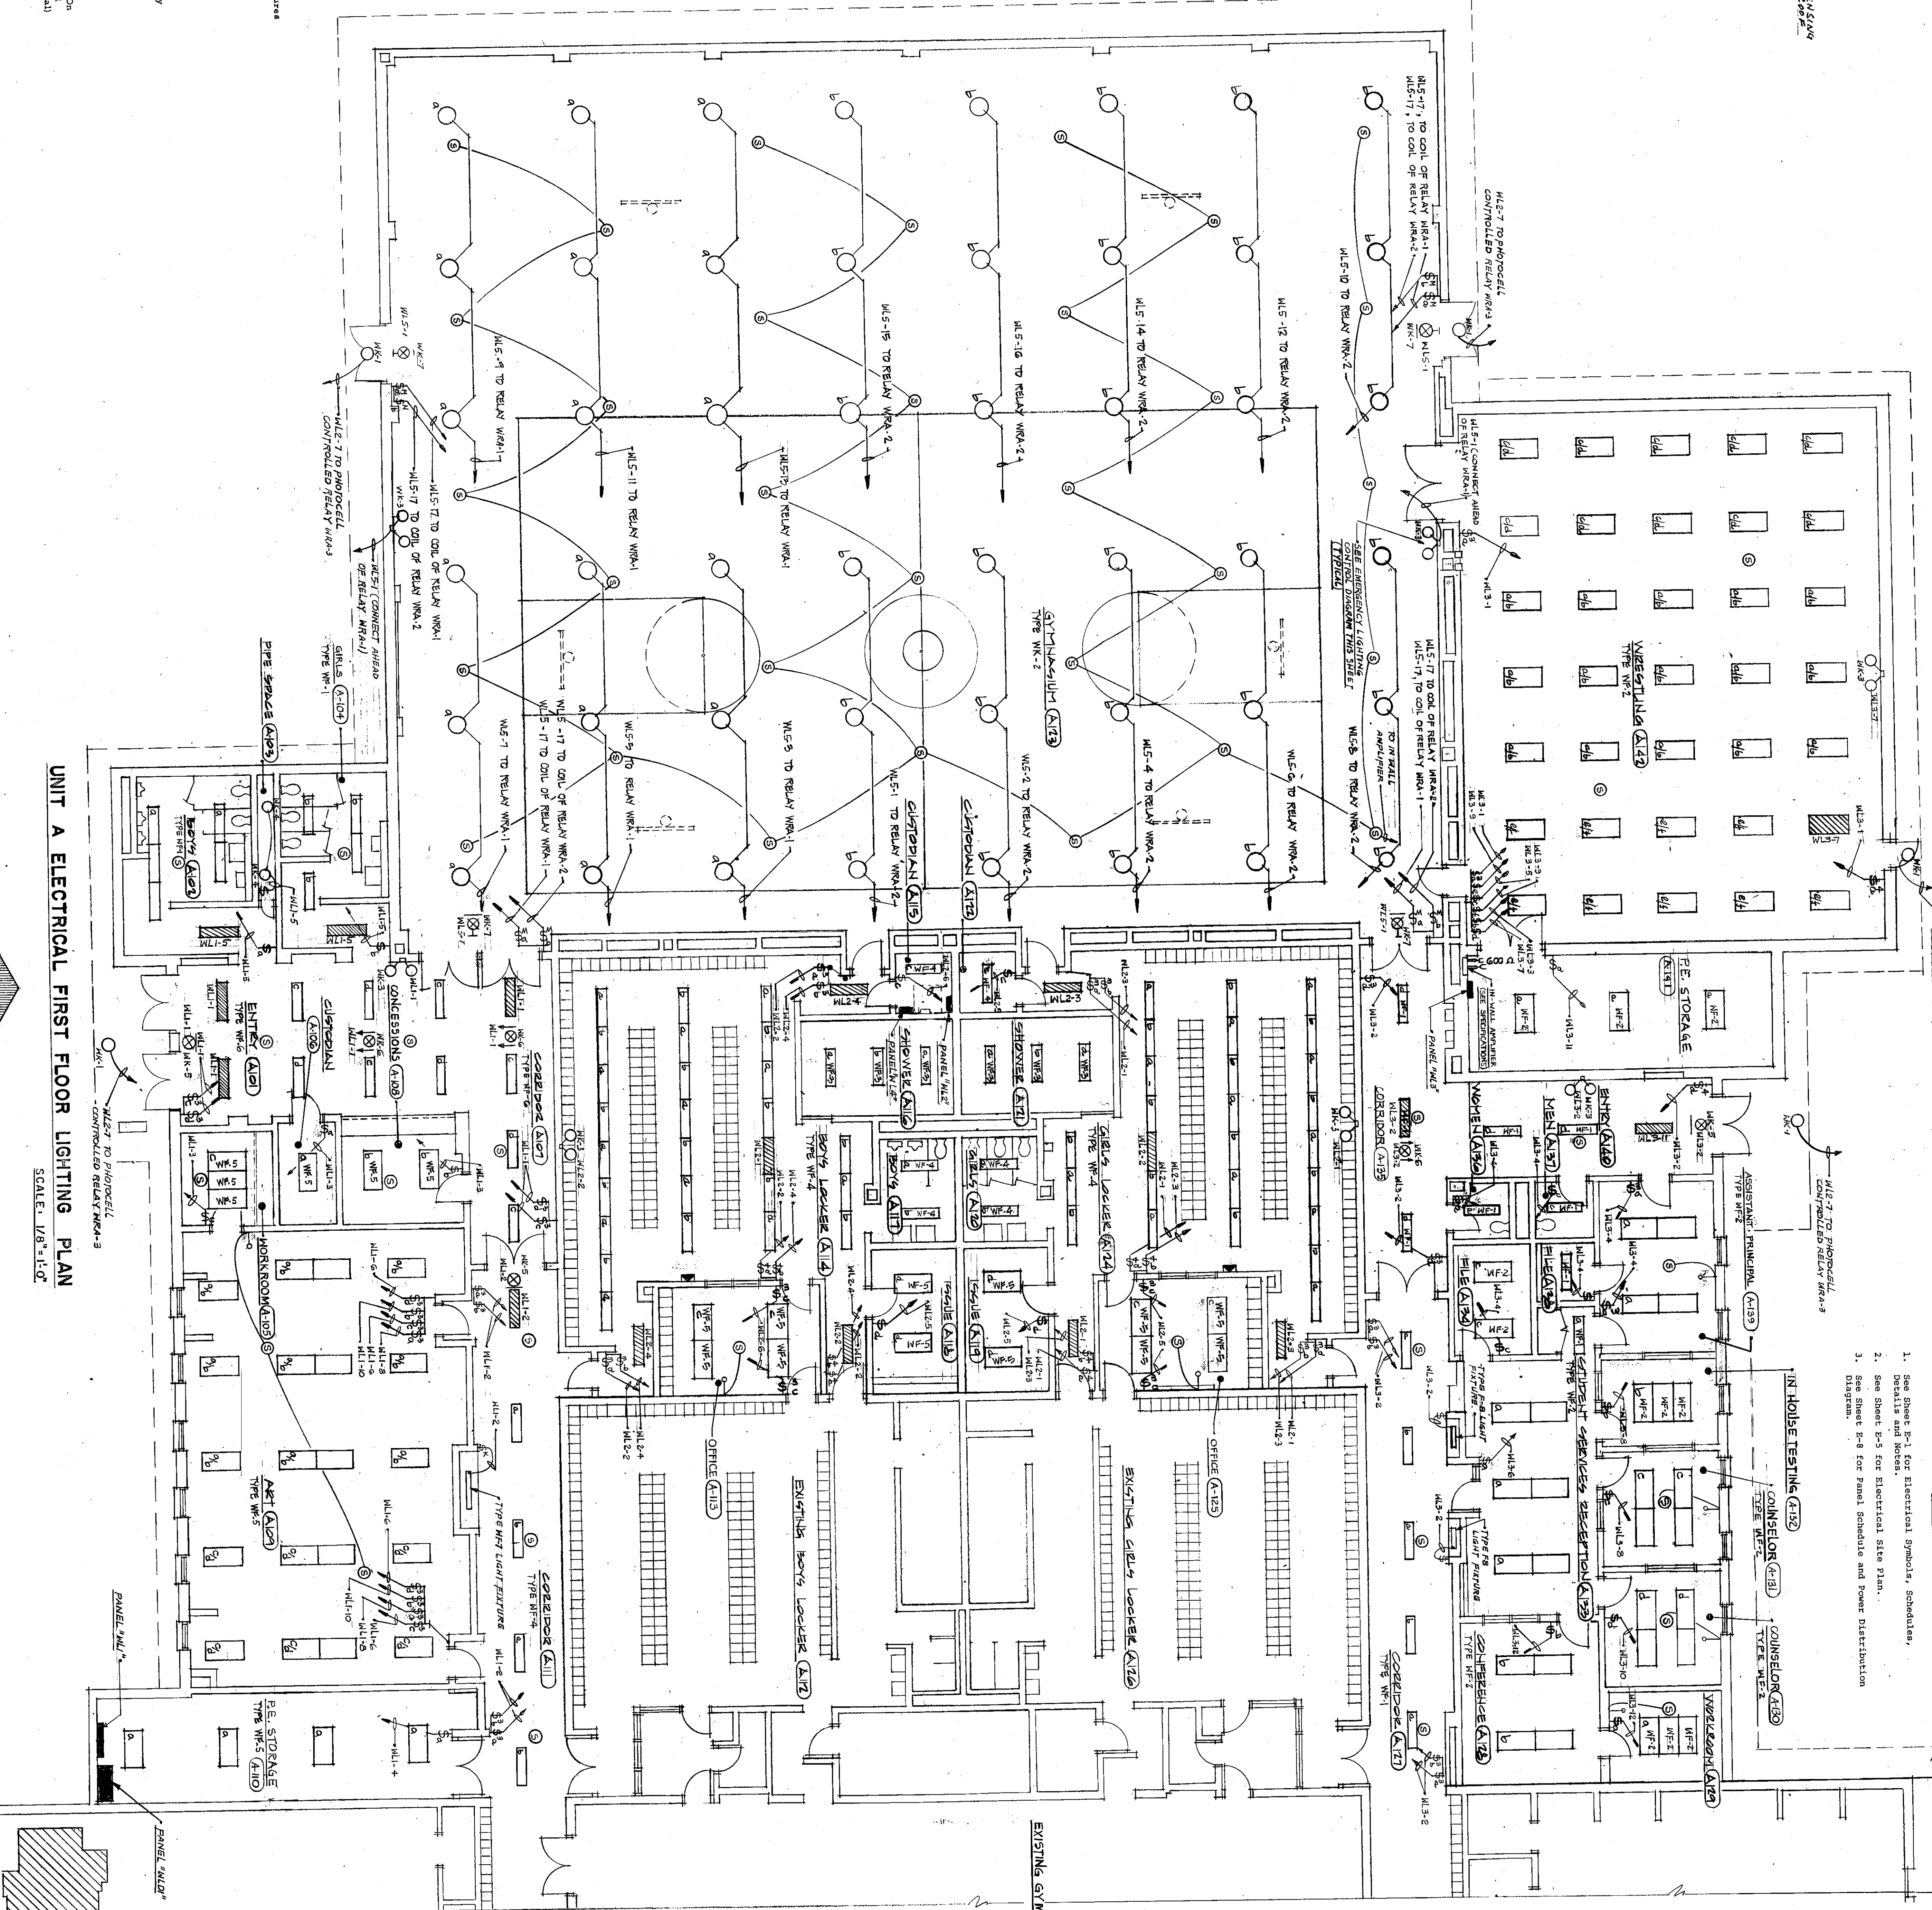

UNIT A ELECTRICAL FIRST FLOOR PLAN
SCALE 1/8"=1'-0"

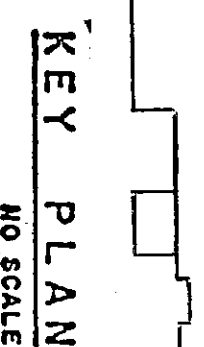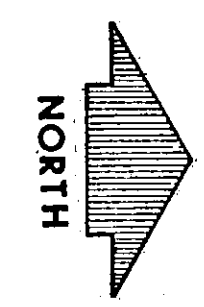

KEY PLAN
NO SCALE

1. See Sheet E-1 for Electrical Symbols, Schedule, and Notes.
2. See Sheet E-2 for Electrical Site Plan.
3. See Sheet E-3 for Panel Schedule and Power Distribution Diagram.

