




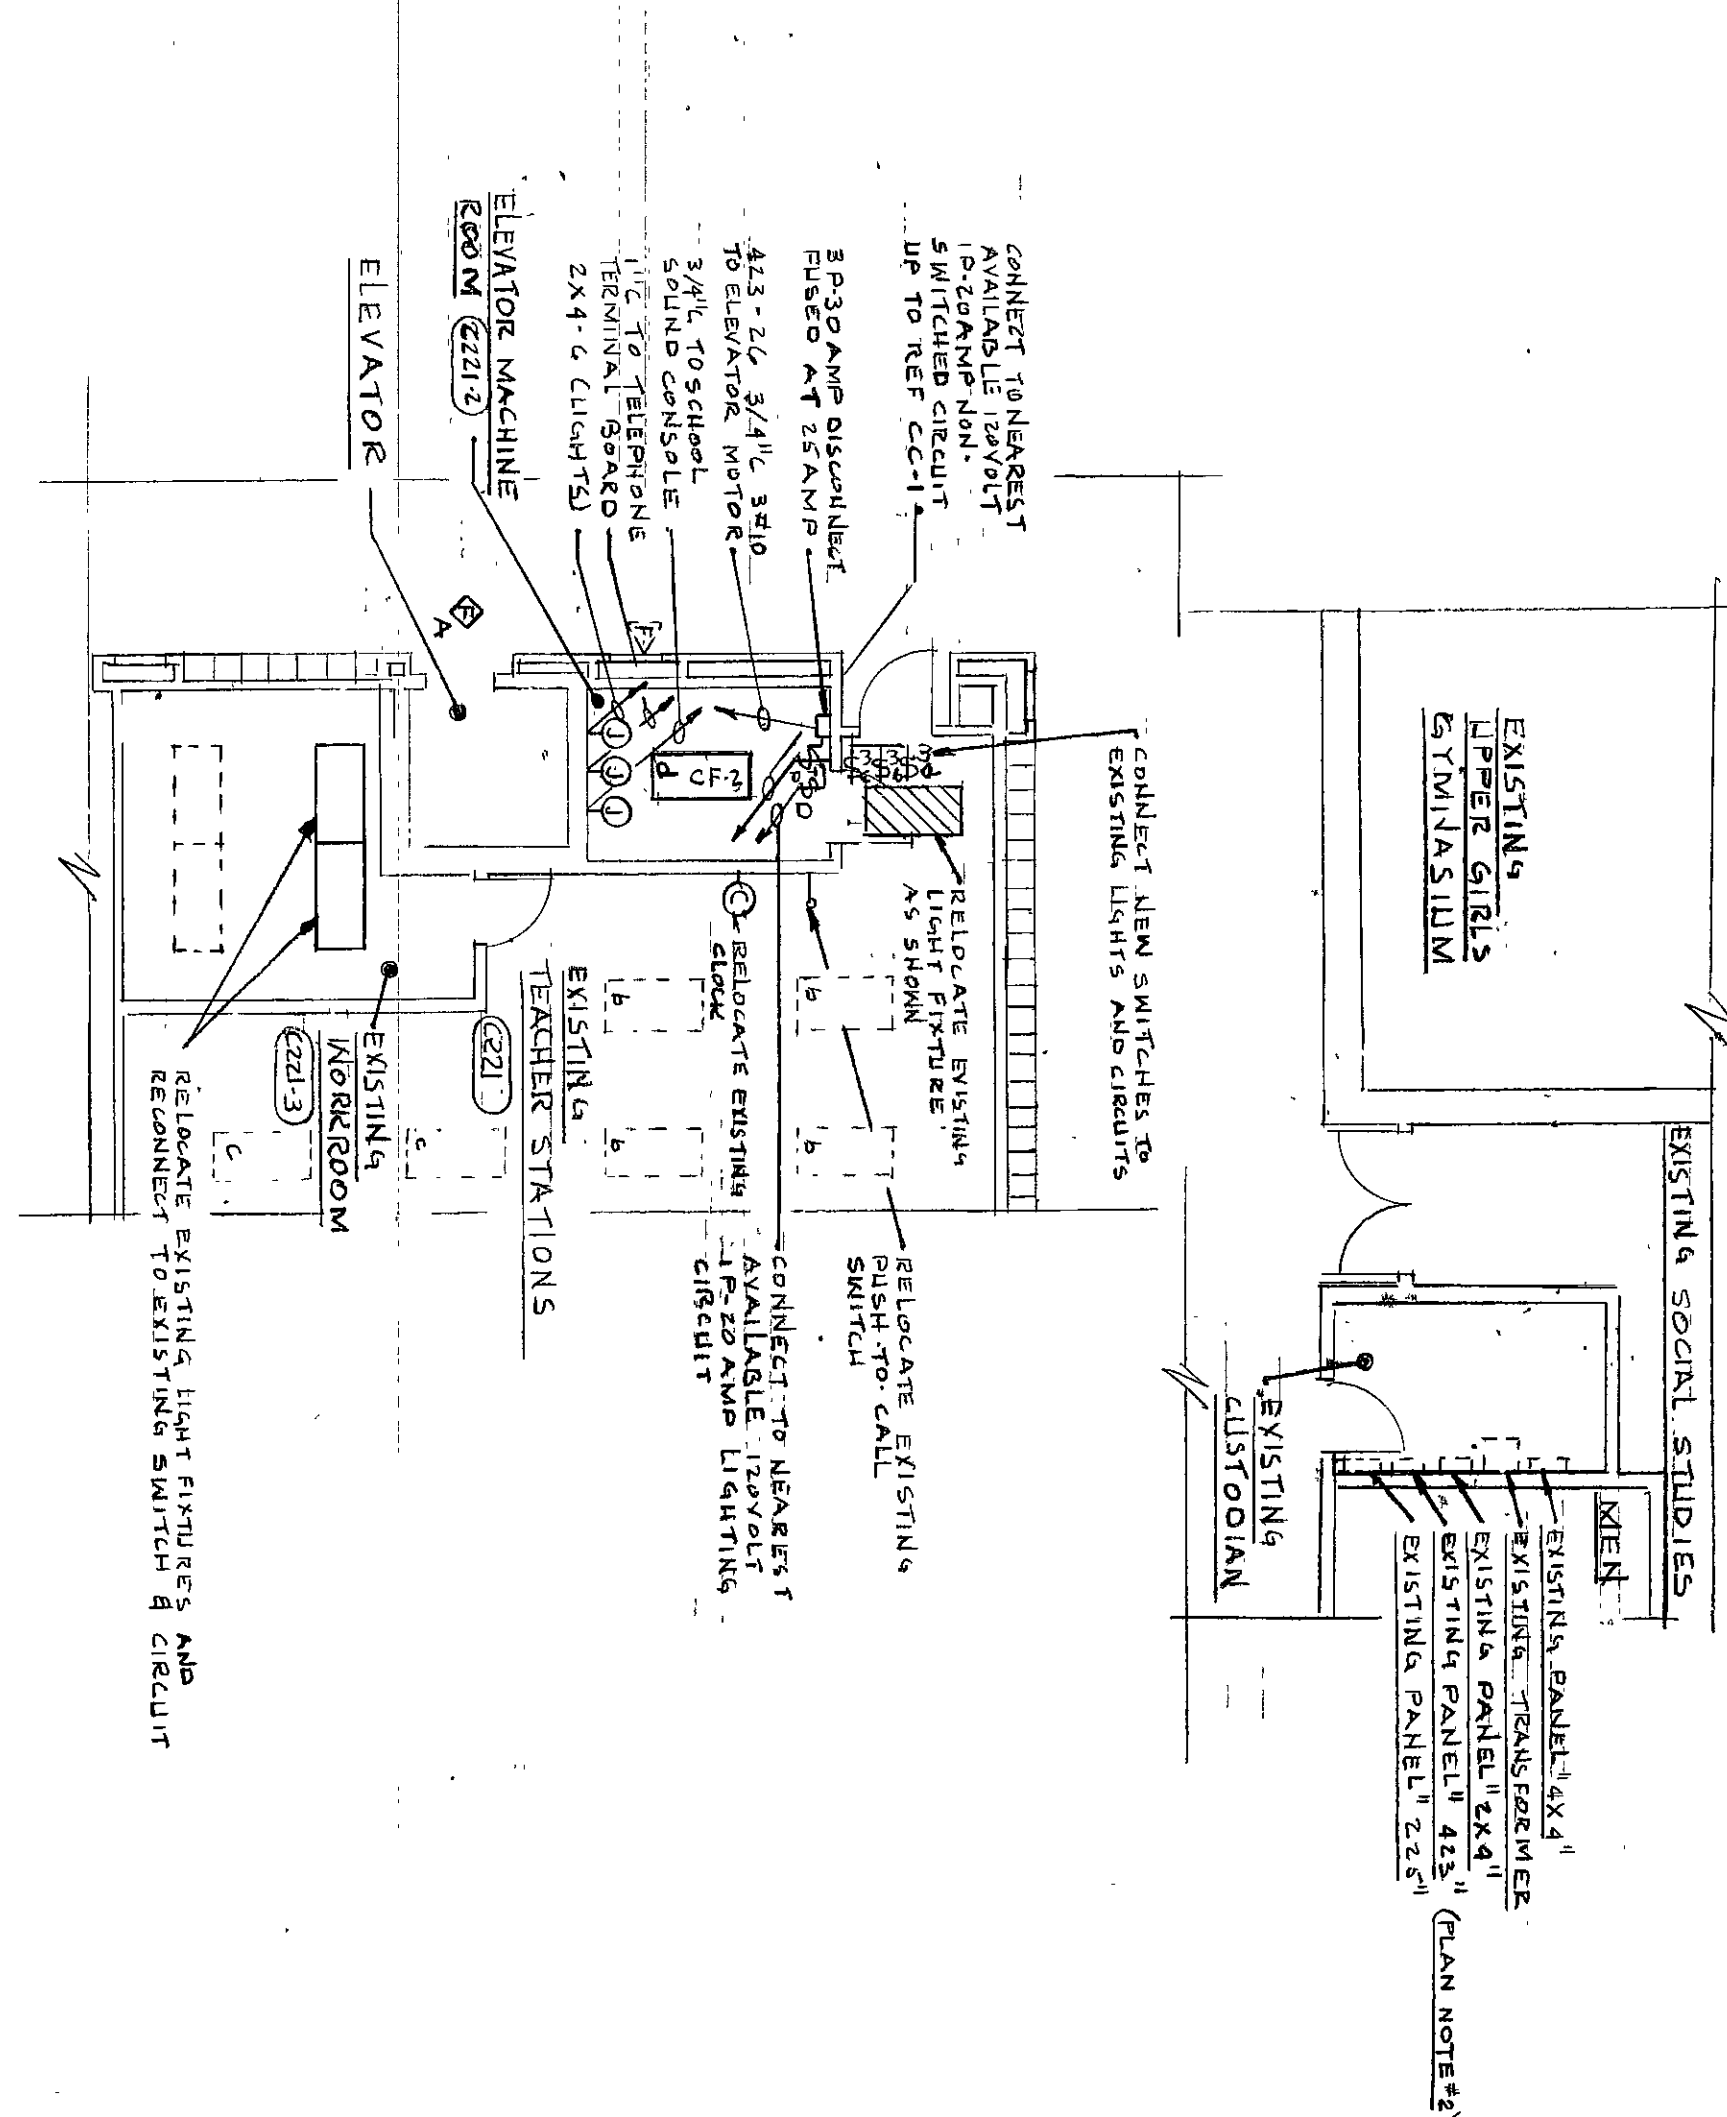


ELECTRICAL SECOND FLOOR ELEVATOR PLAN - AREA #1
SCALE: 1/8"=1'-0"

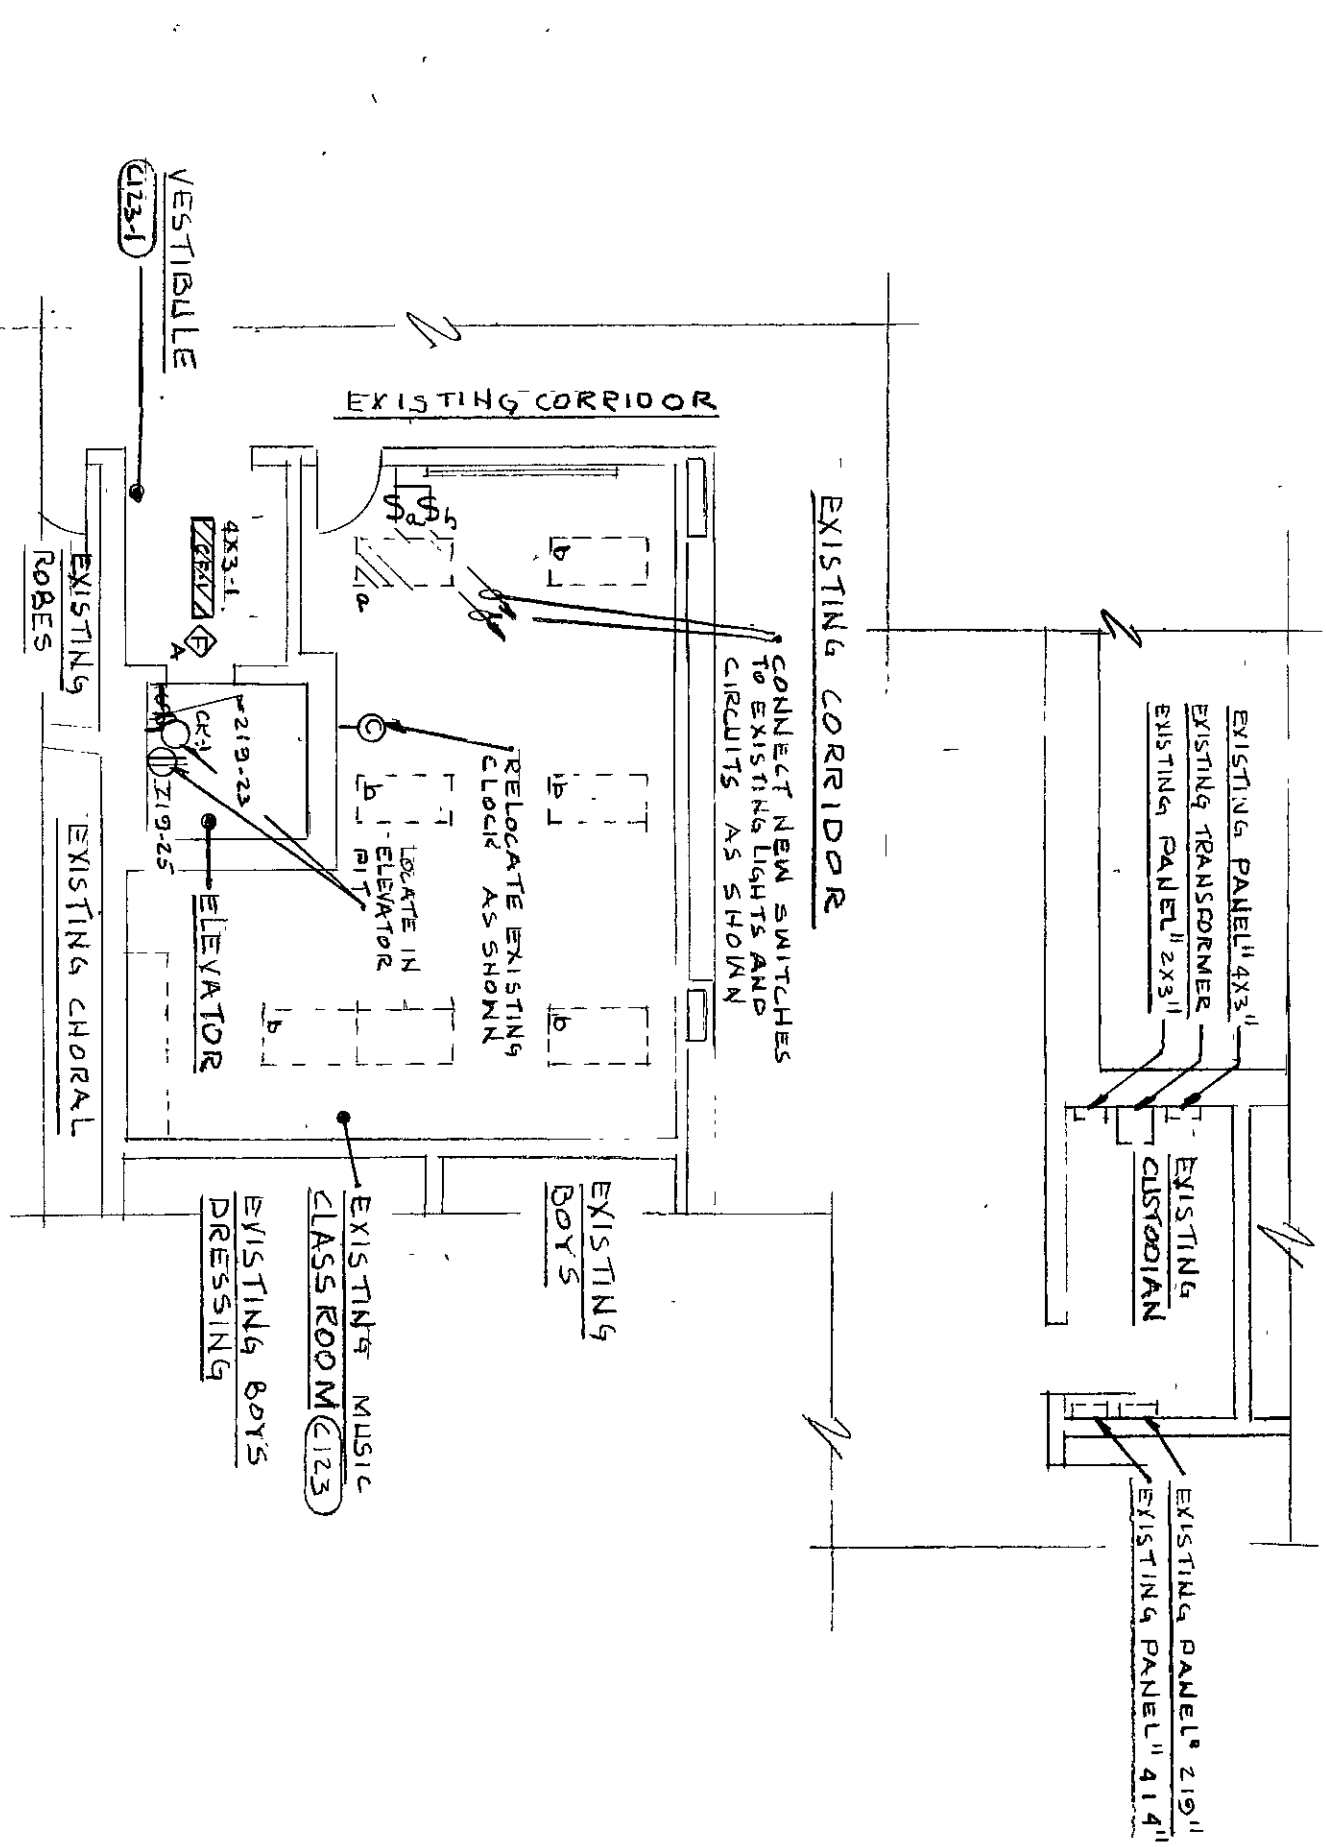


ELECTRICAL FIRST FLOOR ELEVATOR PLAN - AREA #1
SCALE: 1/8"=1'-0"

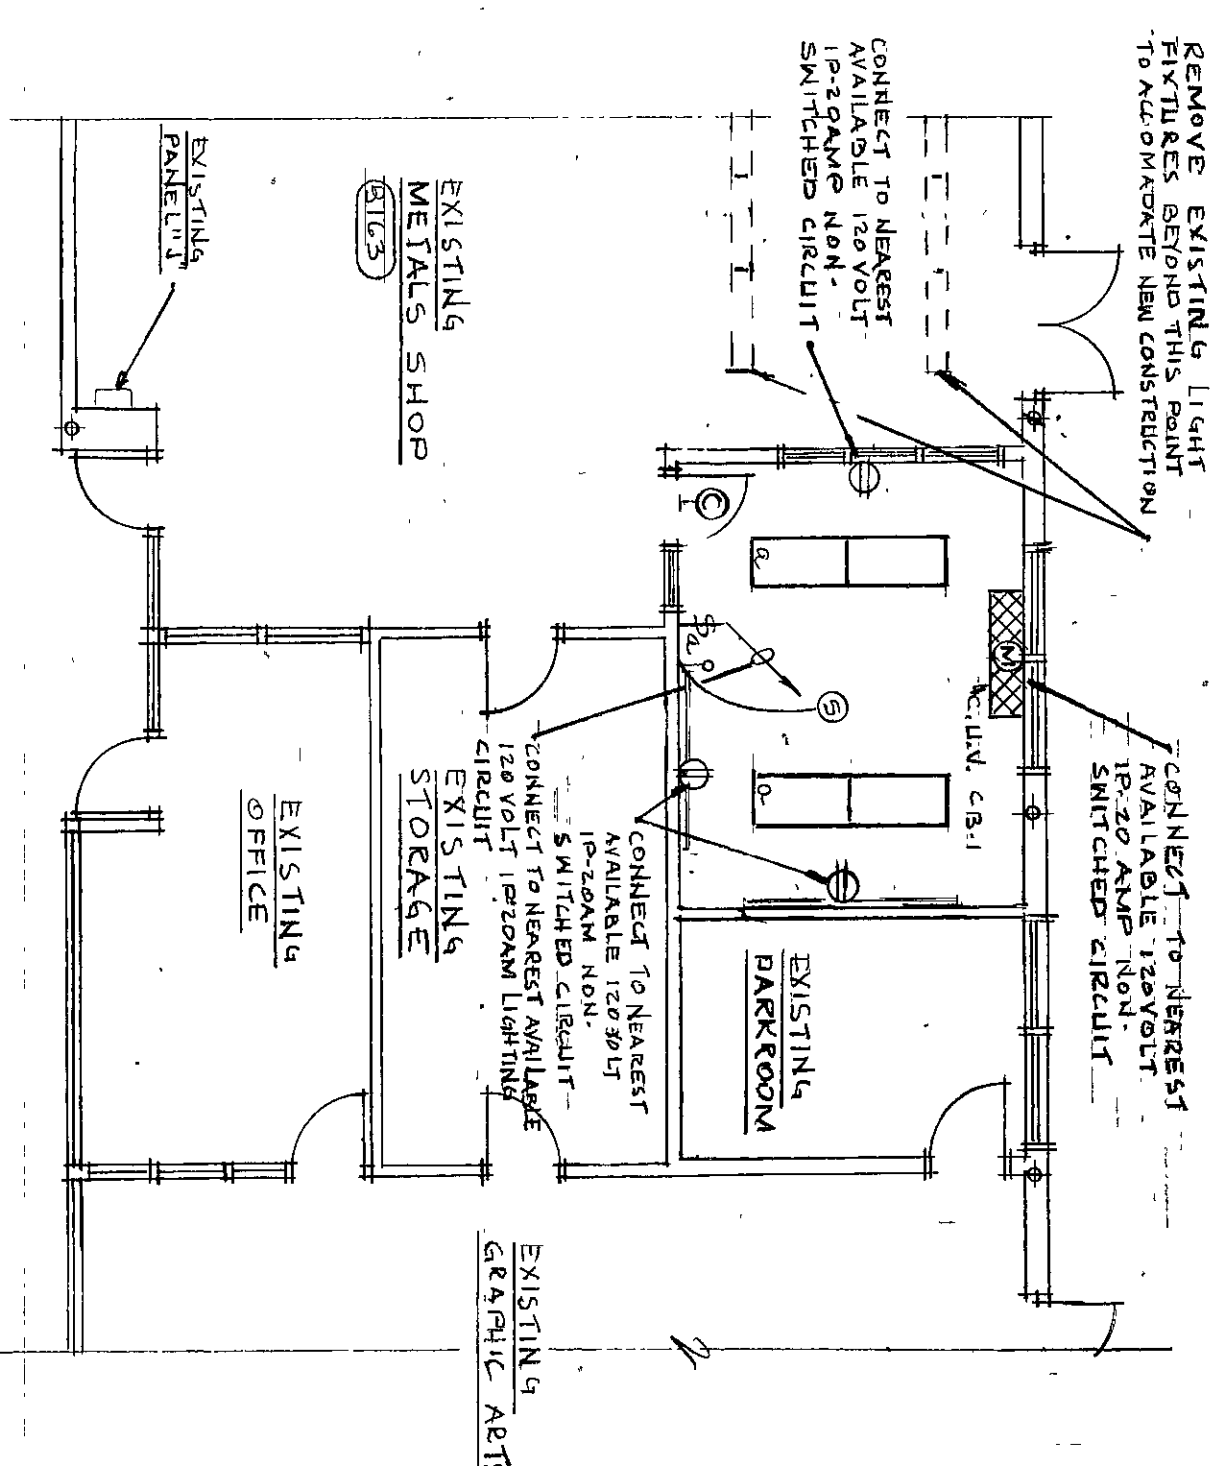


ELECTRICAL PLAN OF SEMINAR AREA #2
SCALE: 1/8"=1'-0"

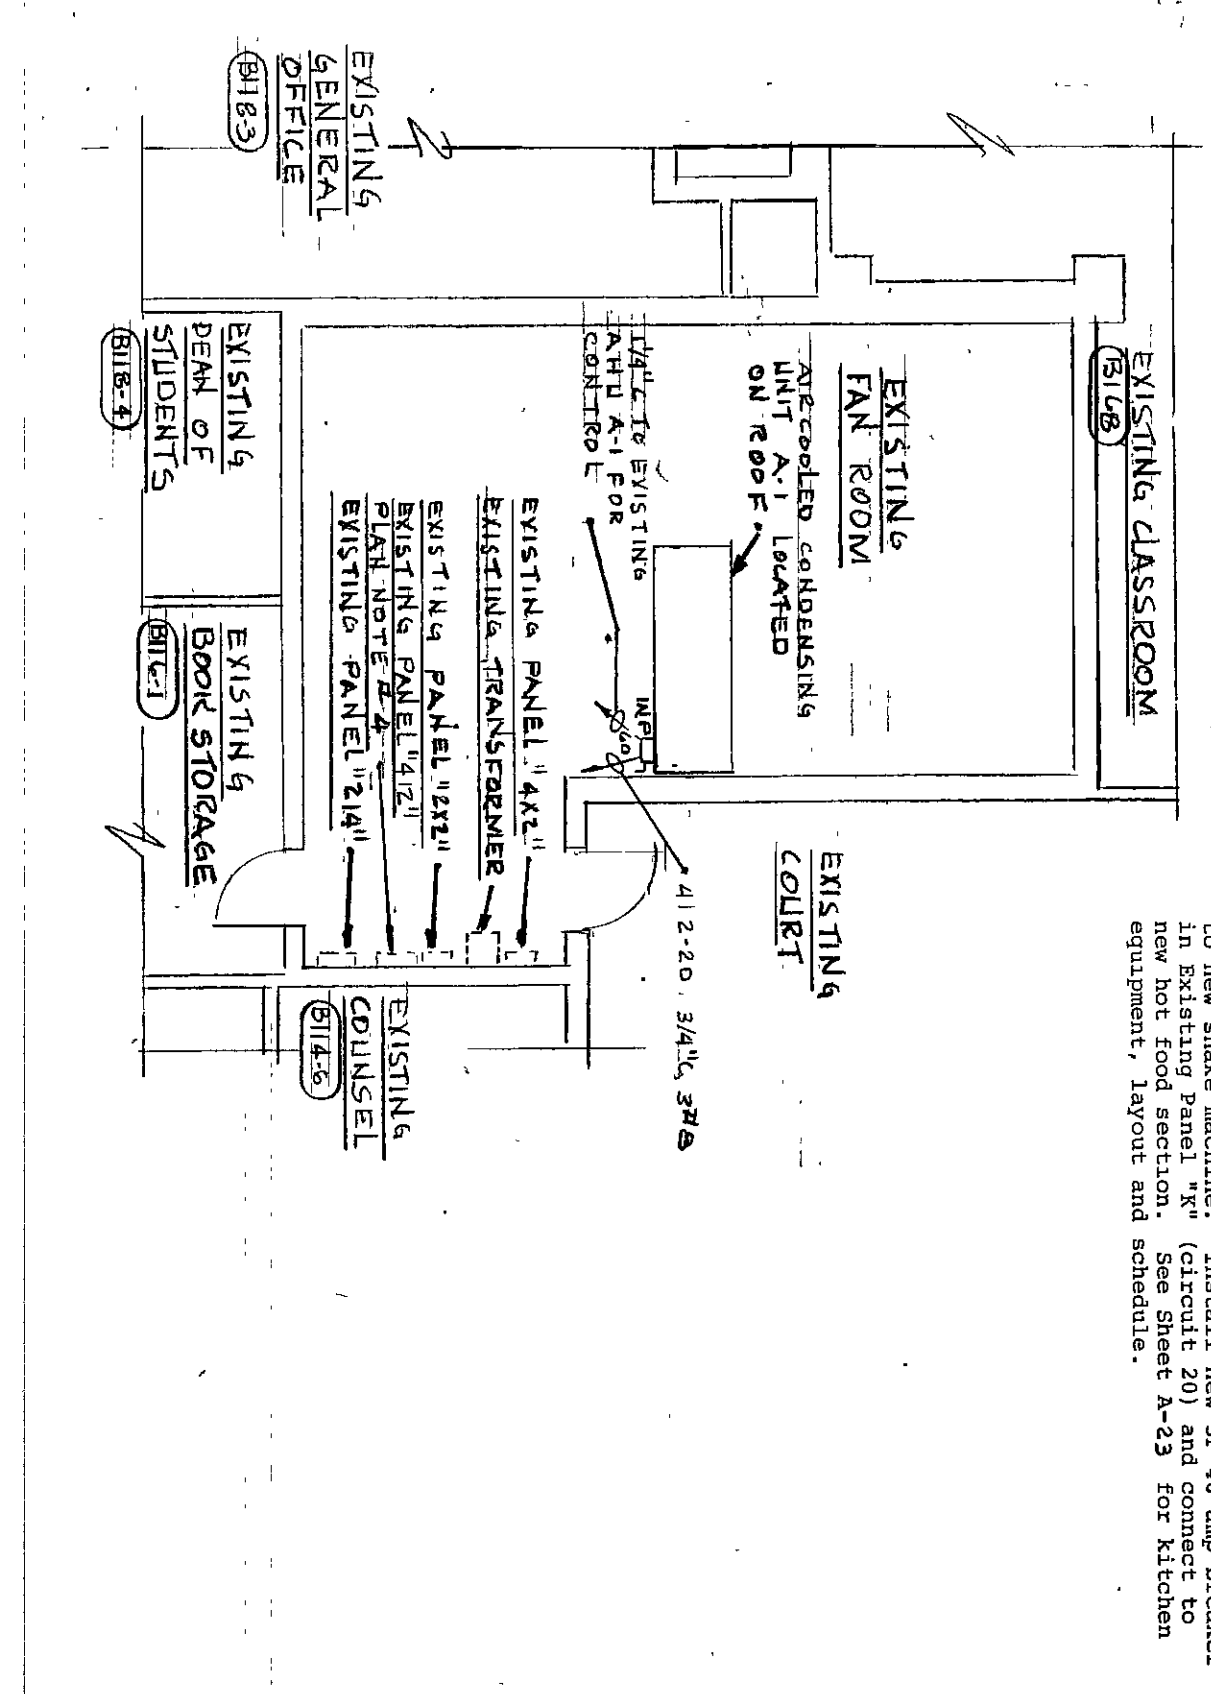


PARTIAL ELECTRICAL FIRST FLOOR PLAN AREA #5
SCALE: 1/8"=1'-0"

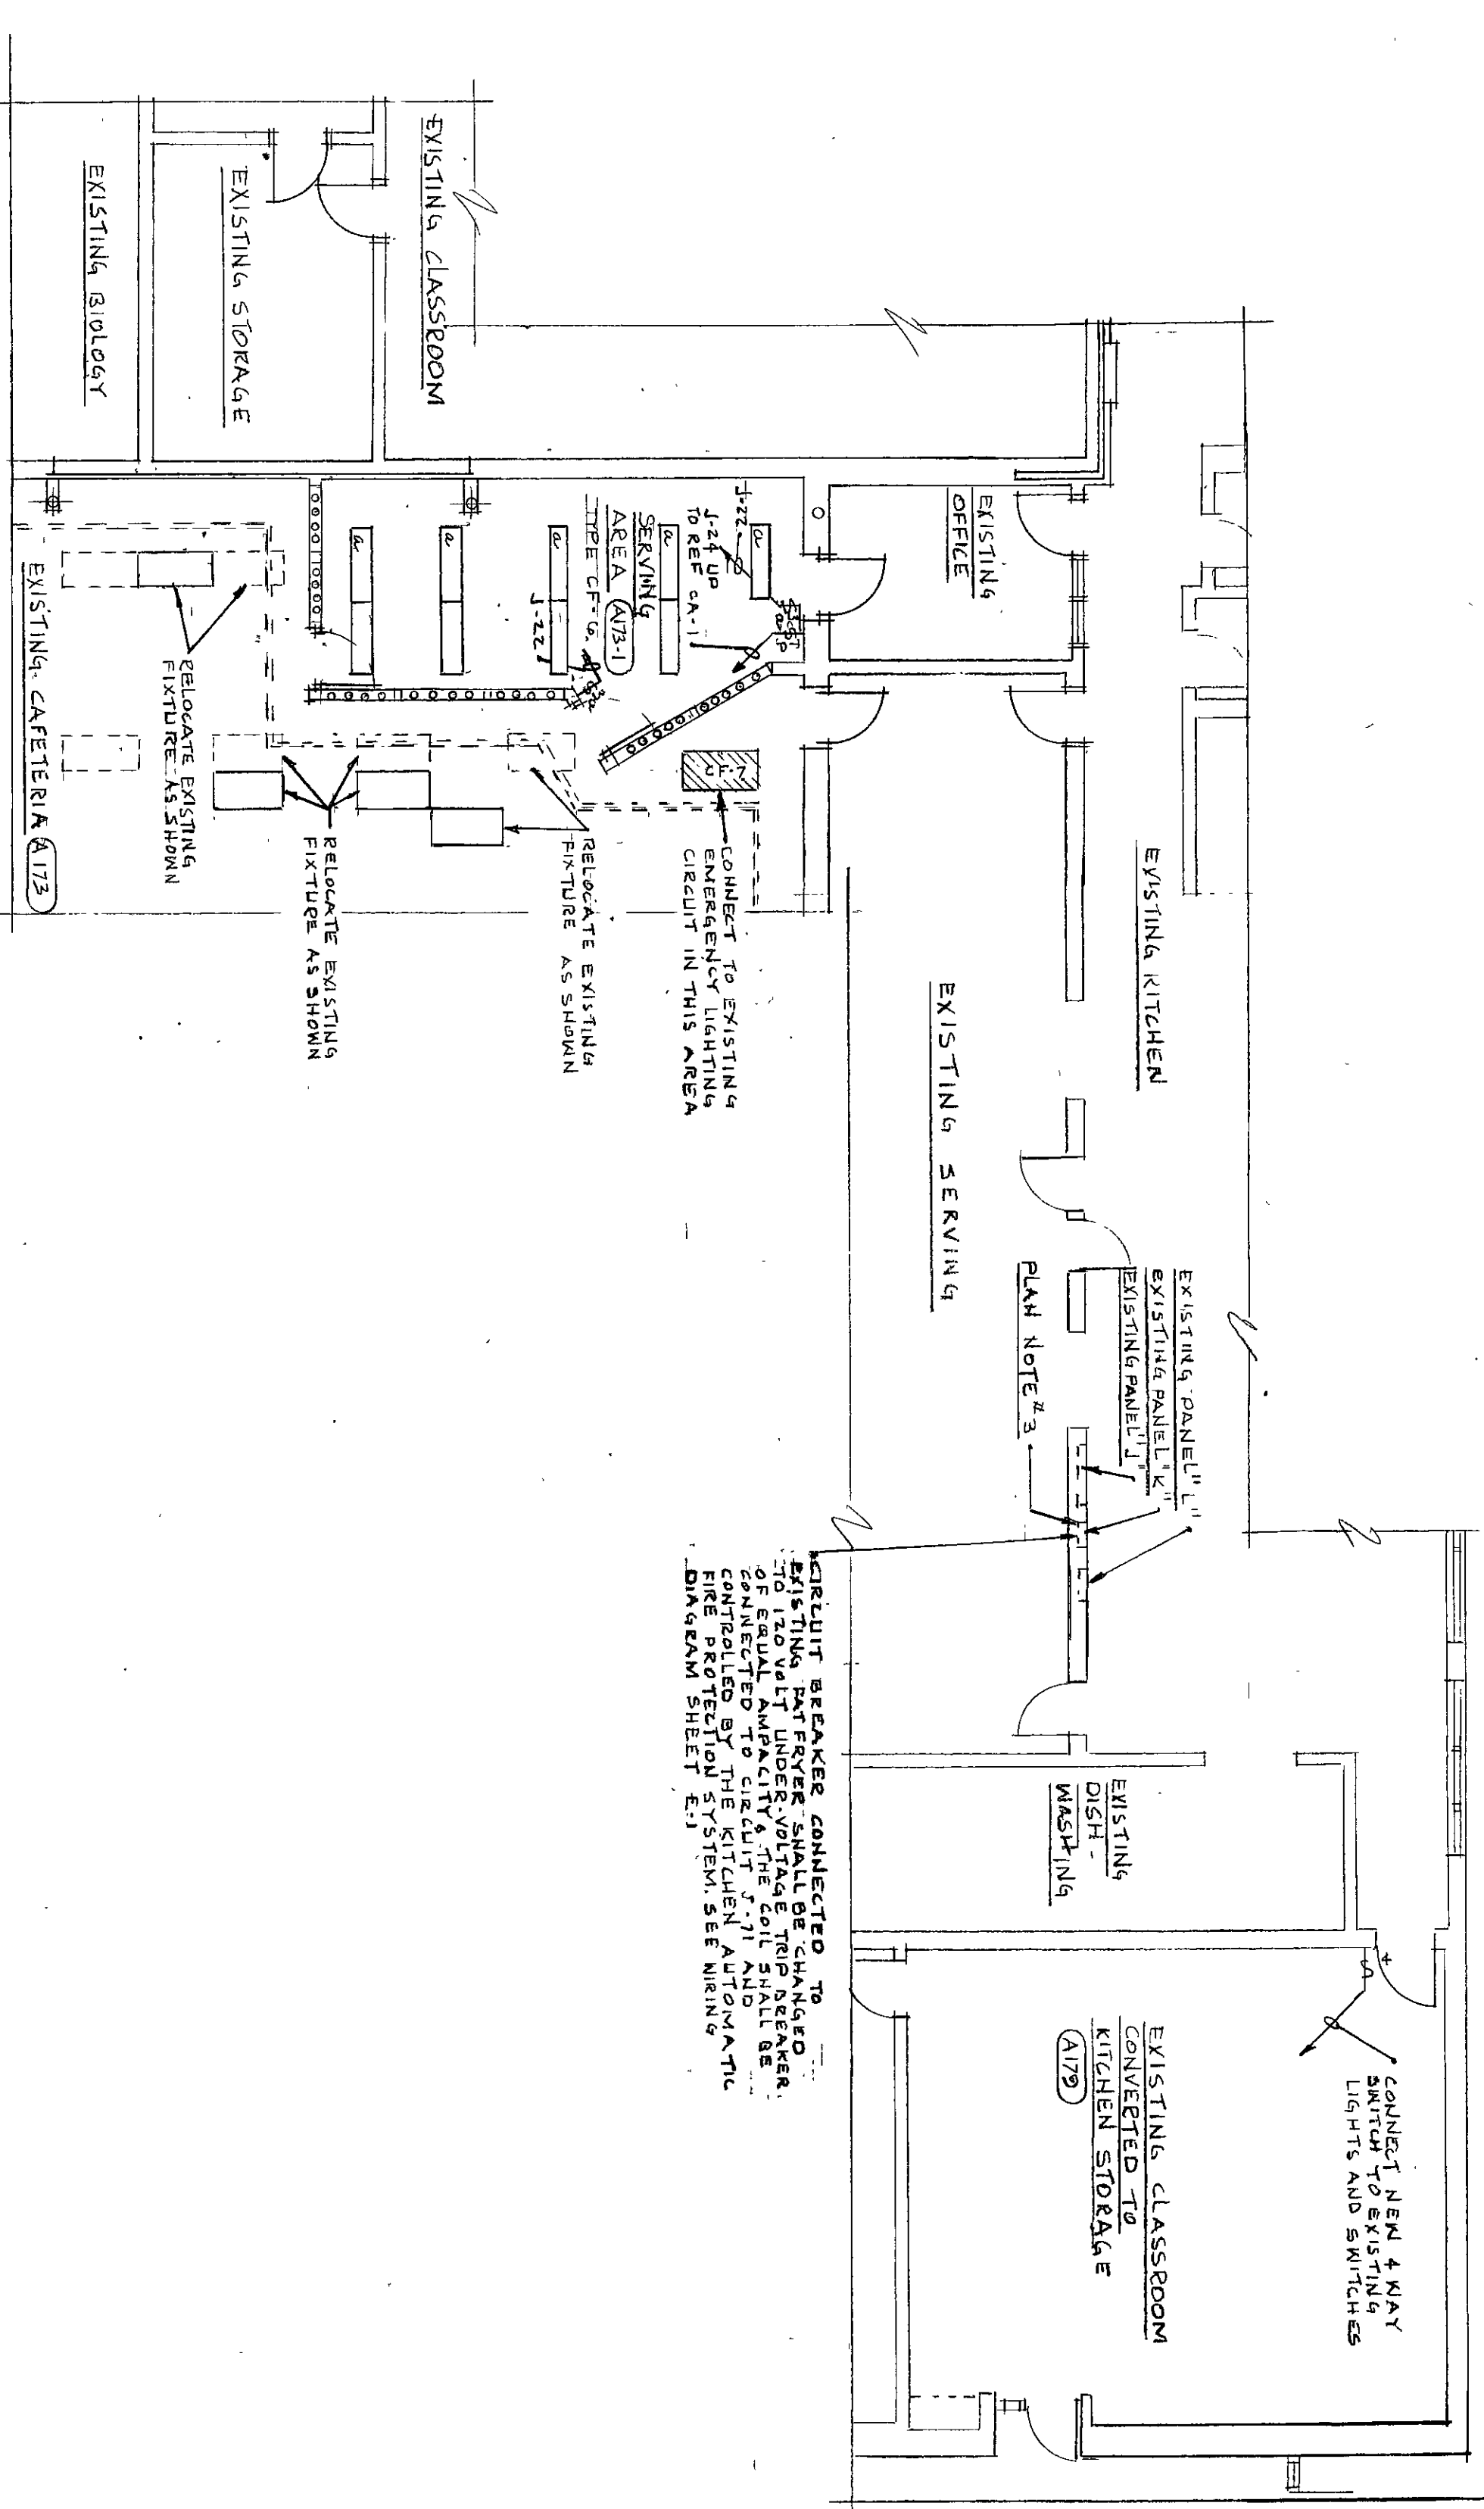

ELECTRICAL PLAN OF SERVING AREA #3
SCALE: 1/8"=1'-0"

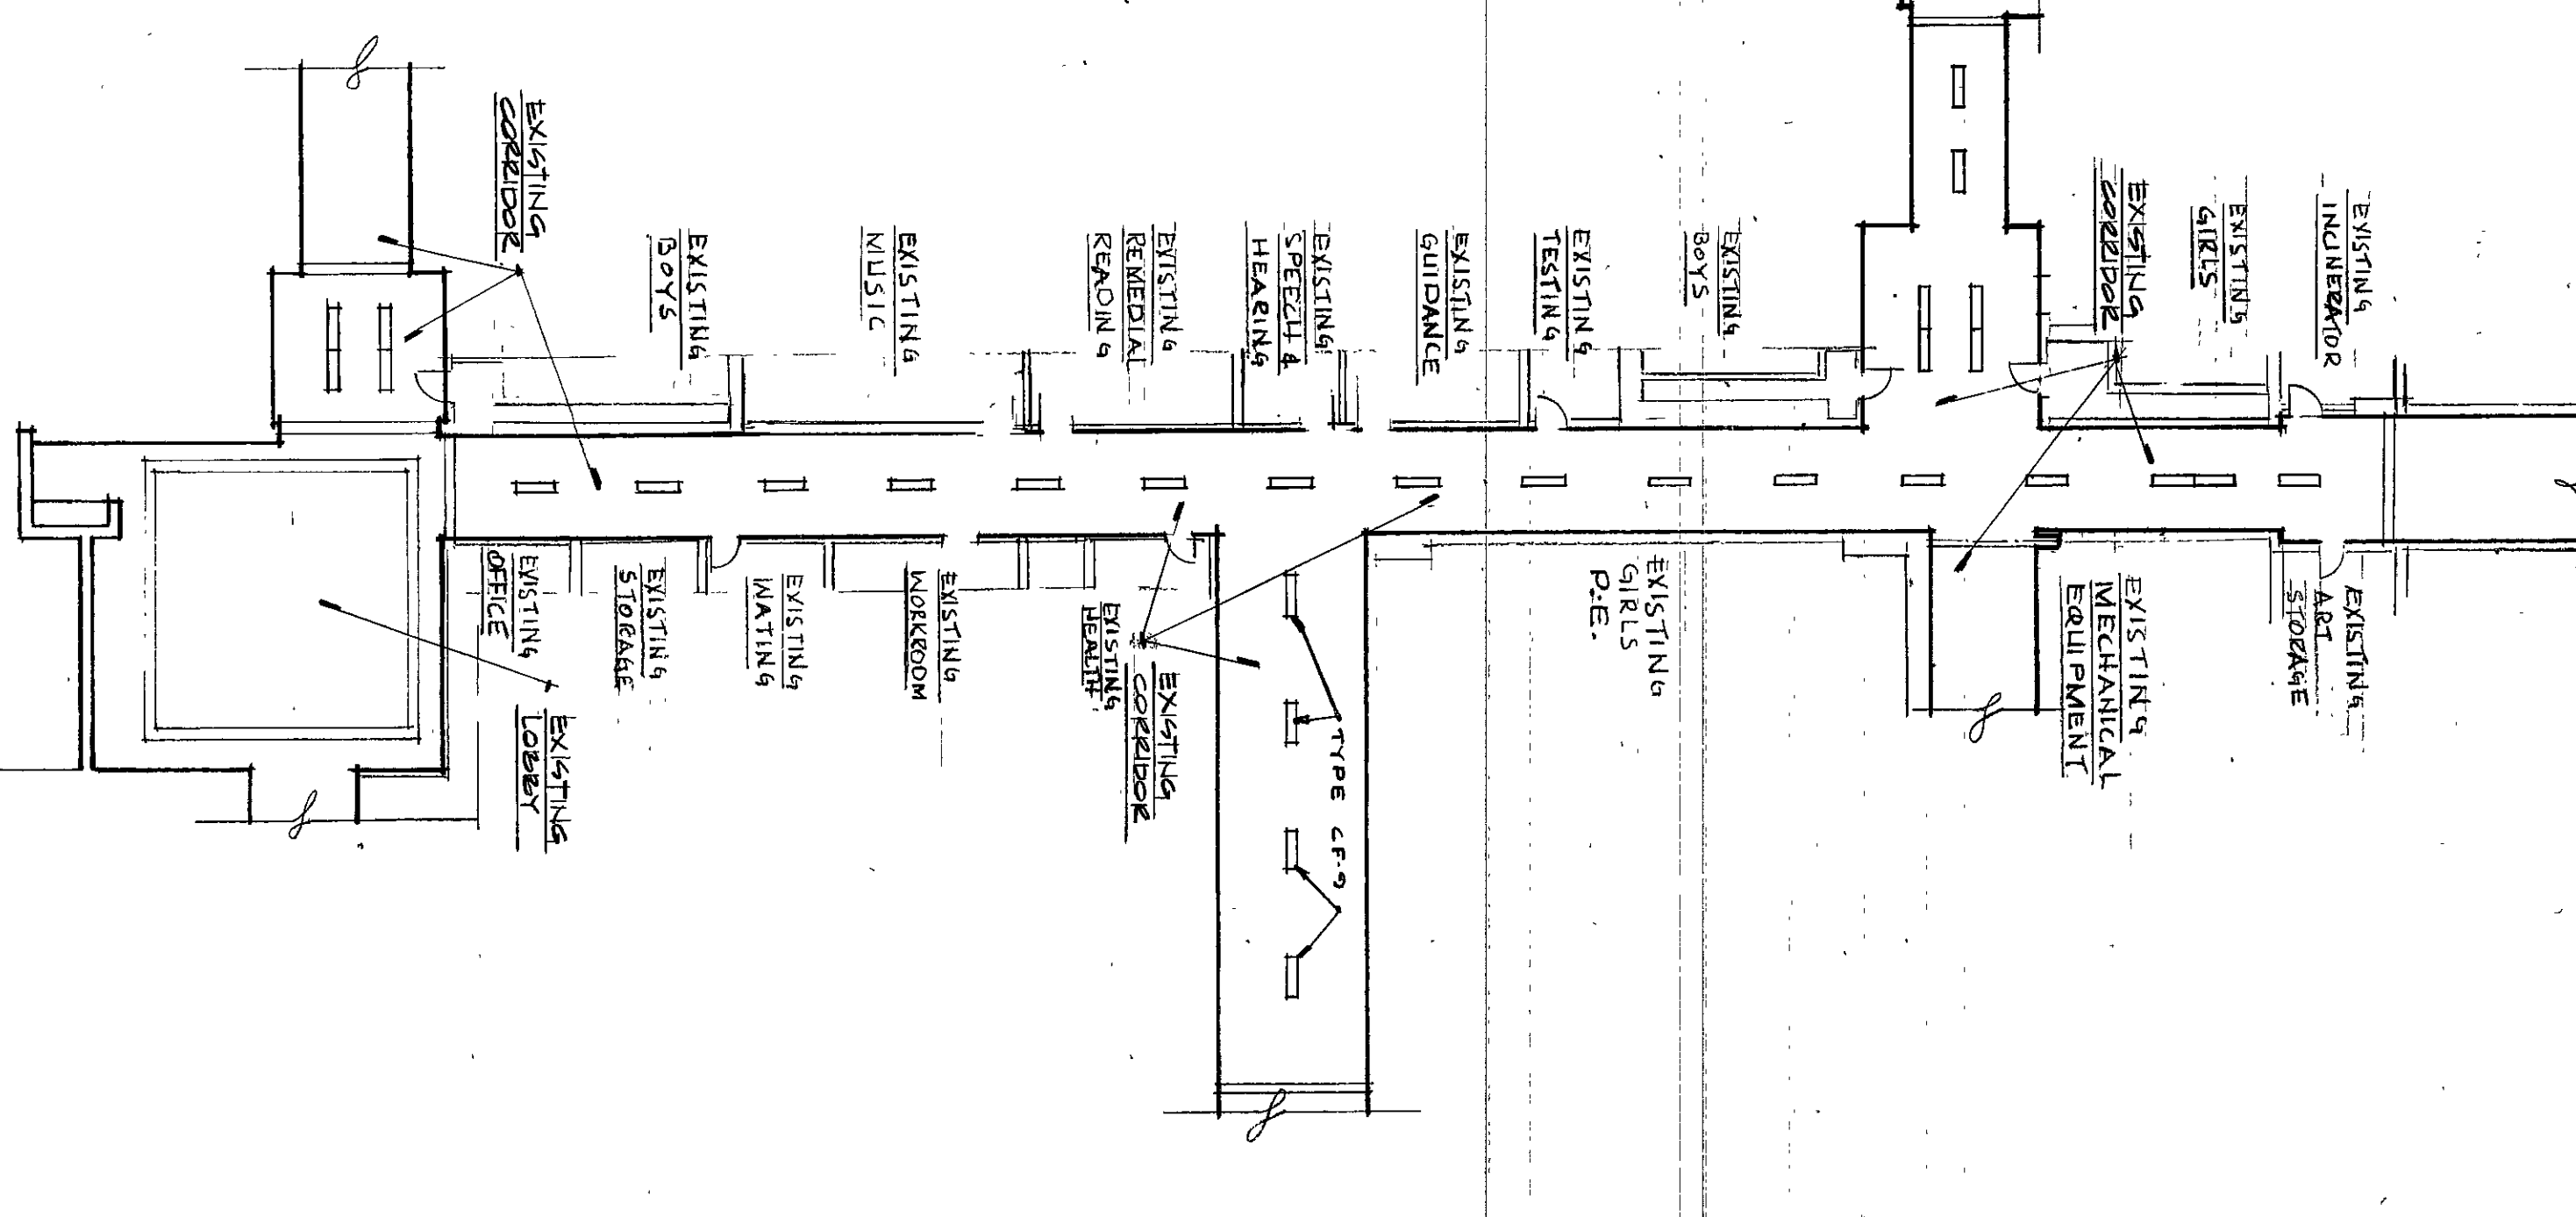

ELECTRICAL PLAN OF CORRIDOR - AREA #4
SCALE: 1/8"=1'-0"

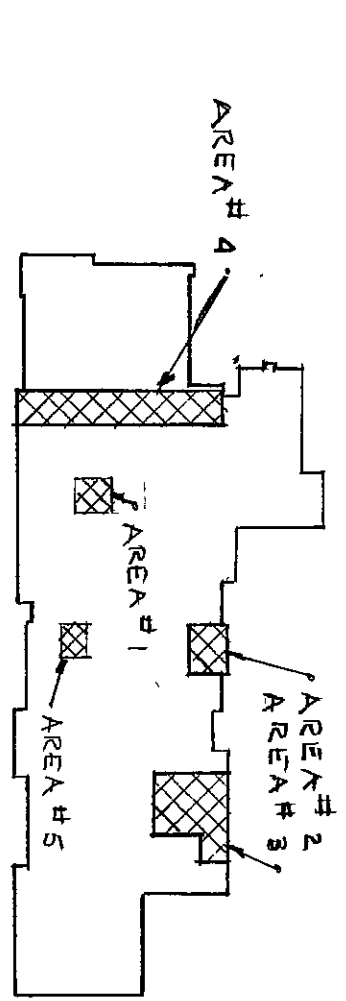

KEY PLAN
NO SCALE

- PLAN NOTES
- See sheet E-1 for Electrical Symbols, Schedules, Details and Notes.
 - Replace three (3) existing 30-amp breakers in one (1) new 30-amp breaker and connect to new elevator.
 - Replace existing 20-amp breaker in existing panel with new 20-amp breaker. Install new 30-amp breaker to new panel machine. Install new 30-amp breaker to new panel machine. See sheet E-2 for kitchen equipment, layout and schedule.

James W. Roberts

10-E-04