





SHEET M-1
SHEET M-2
SHEET M-3

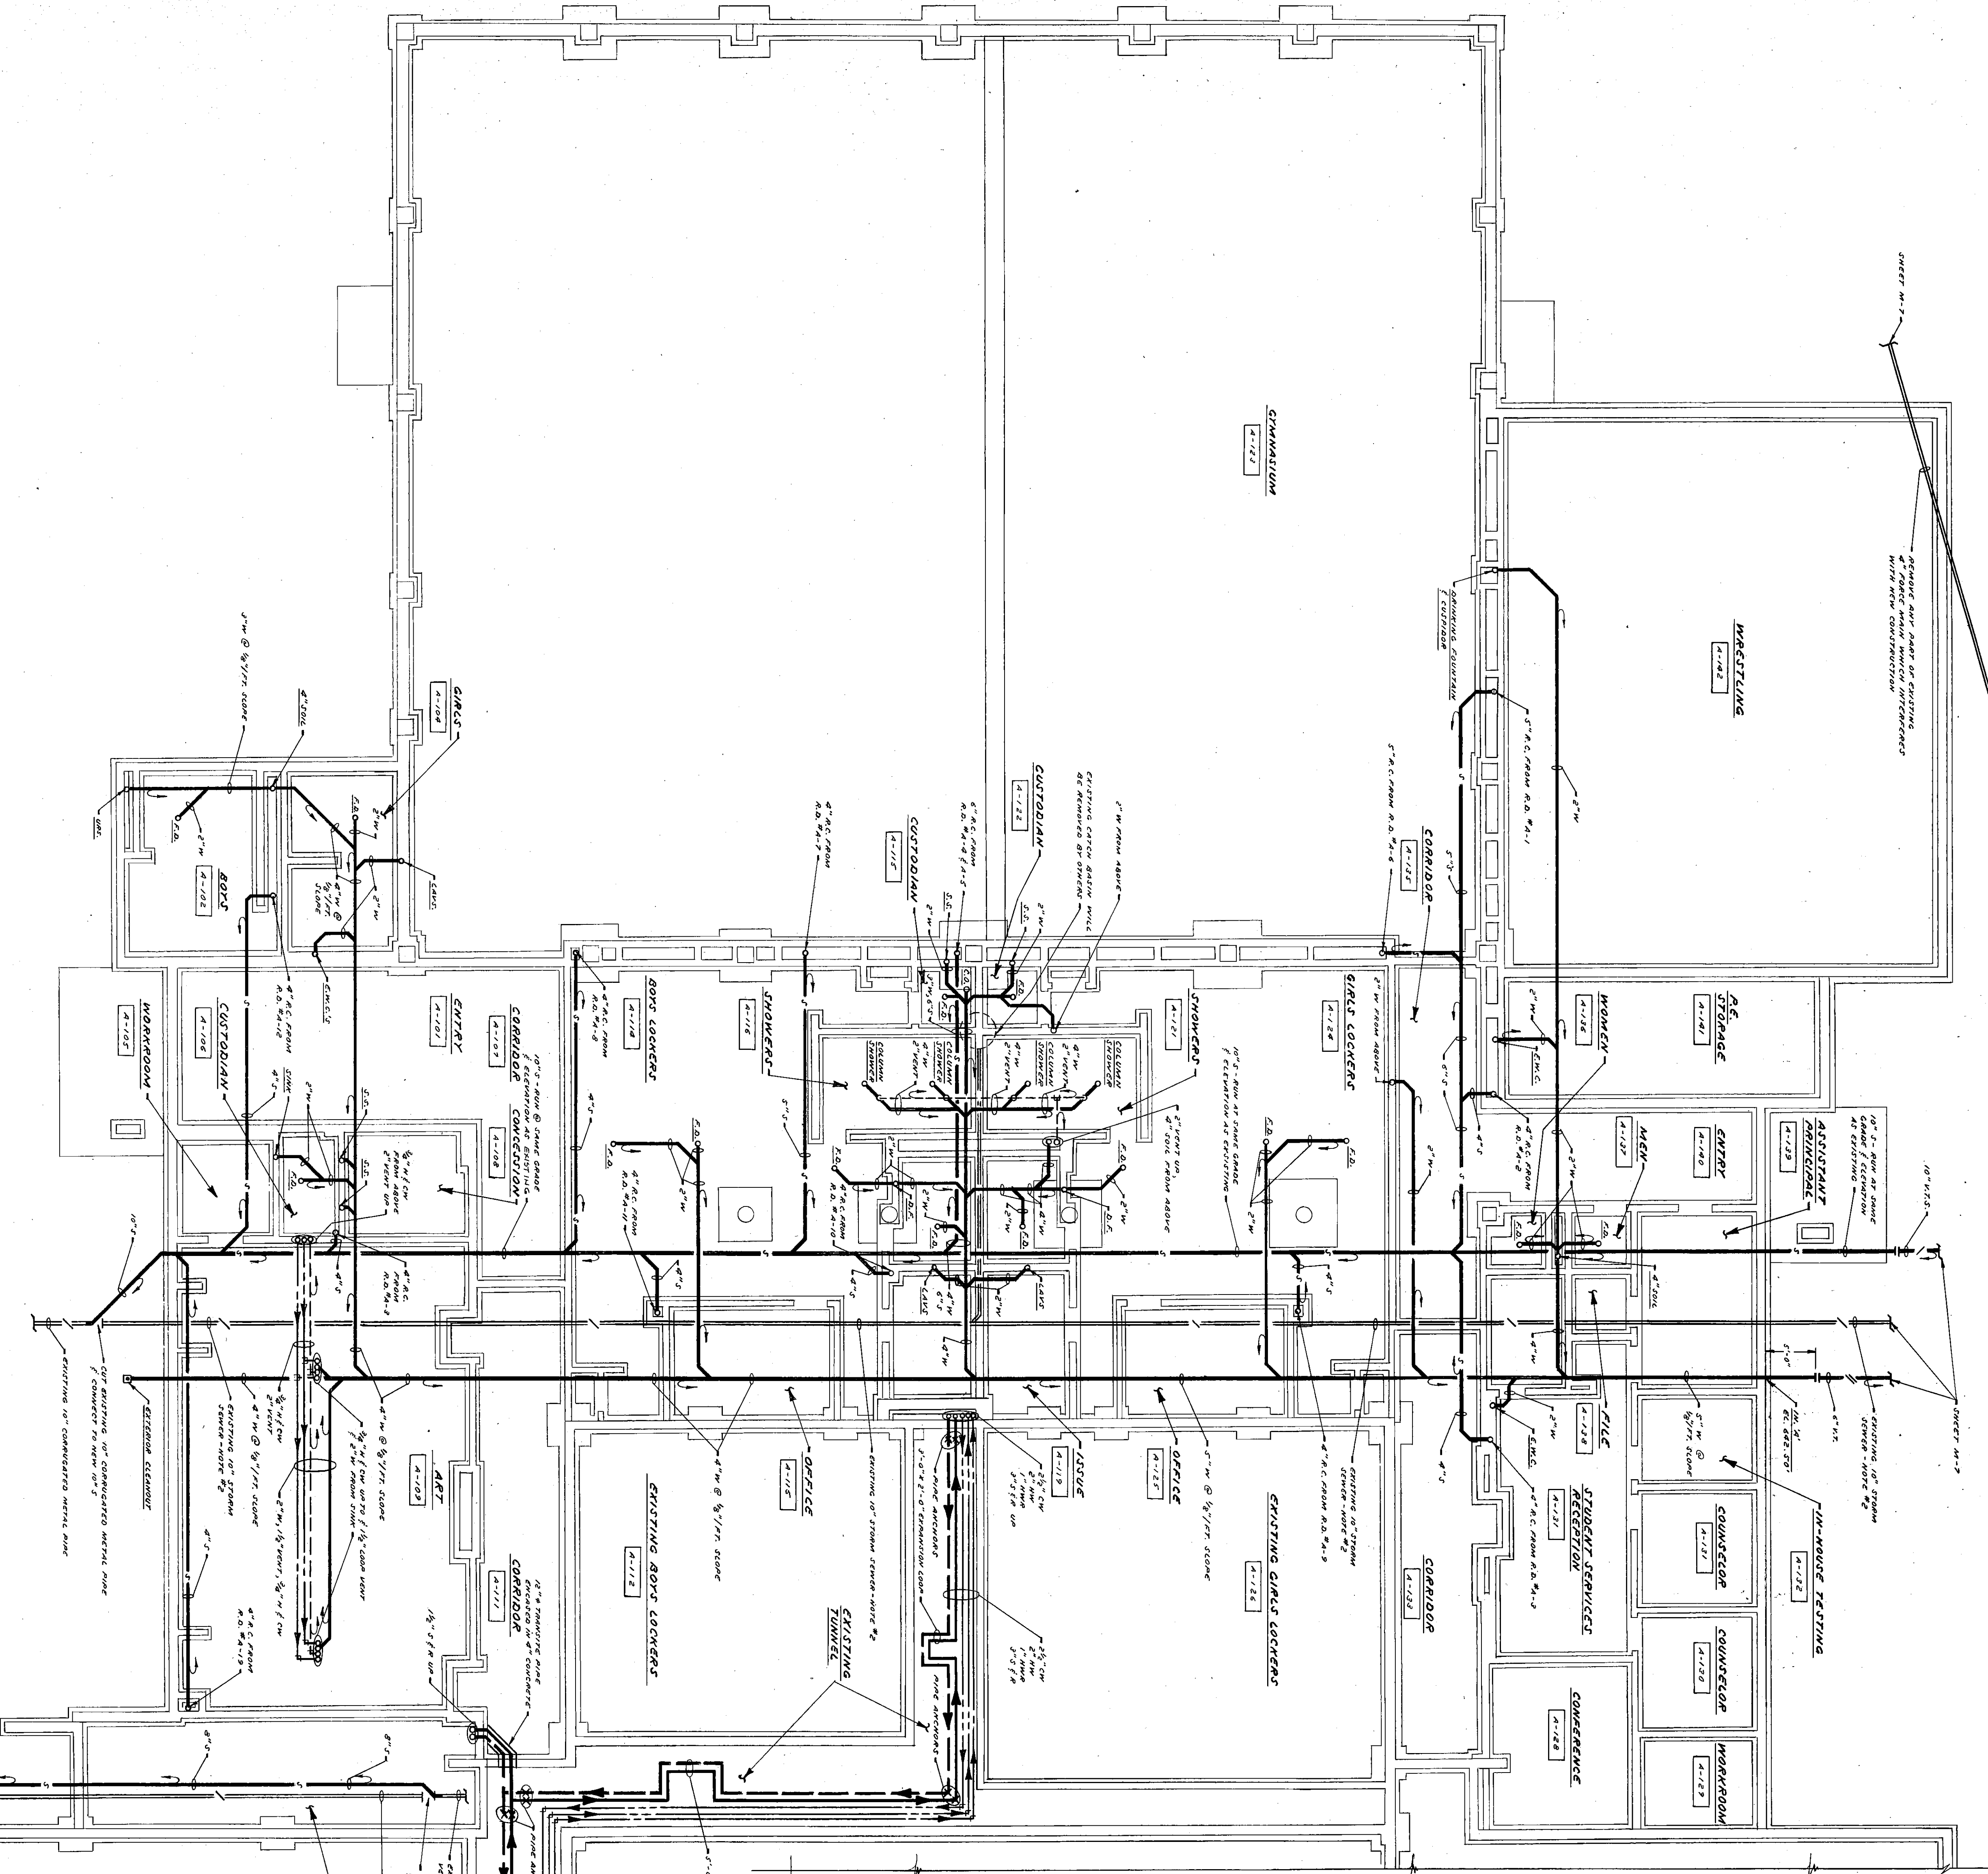


UNIT "A" HEATING, PLUMBING FOUNDATION PLAN
SCALE: 1/8" = 1'-0"

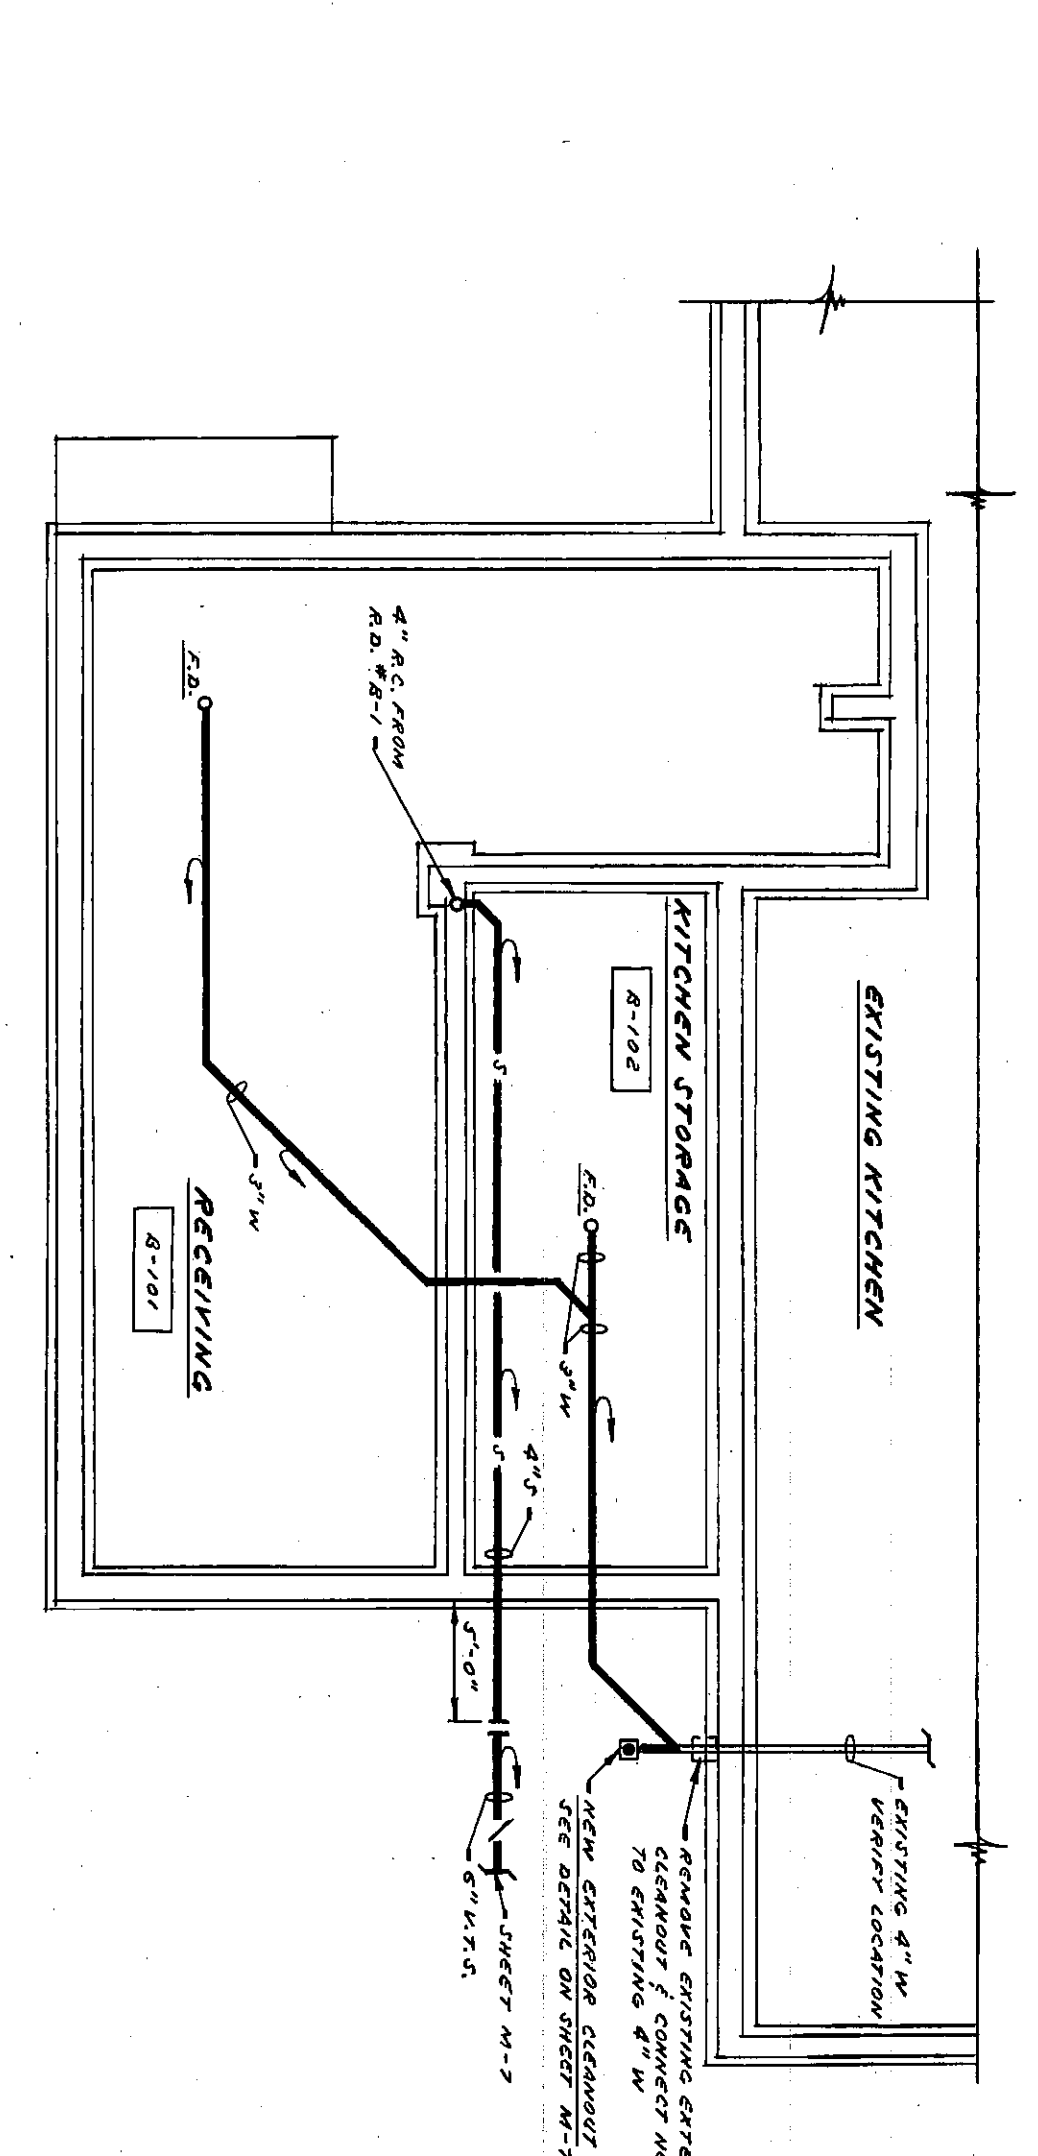


UNIT "B" PLUMBING FOUNDATION PLAN
SCALE: 1/8" = 1'-0"

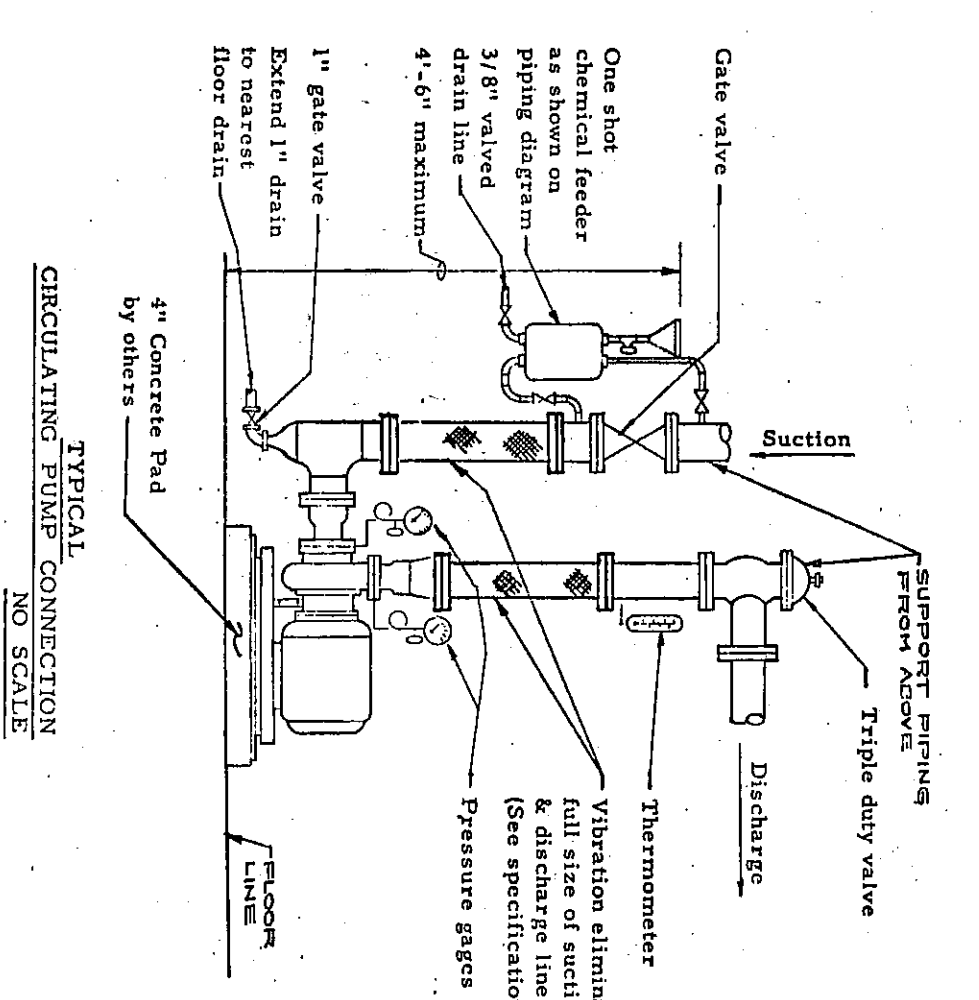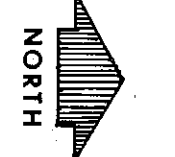

- PLAN NOTES
1. See Sheet M-1 for General Notes, Legend and Schedules.
 2. Existing storm sewer shall remain uninterrupted in service until new construction is completed then shall be cut, plugged and abandoned in place out of service.

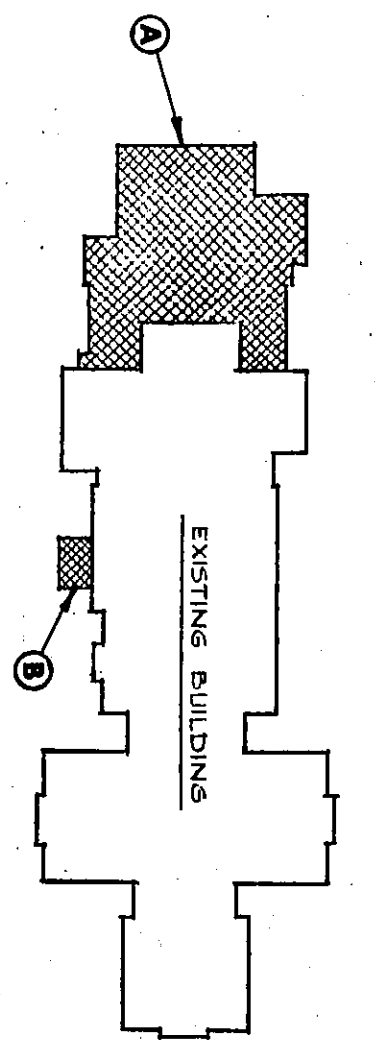

FOUNDATION KEY PLAN
NO SCALE

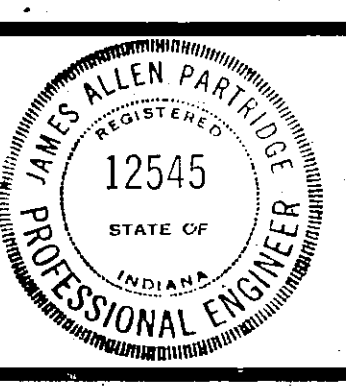

James A. Partidge

PROJECT 3178
DATE NOV 5, 1979
REVISED

79-M-02