

- PLAN NOTES
1. See Sheet M-1 for General Notes, Legend and Schedule.
 2. Wall recessed soap dispensing tank - see Detail Sheet M-16.
 3. 1-1/4" CW, 1-1/2" HW down to and 1-1/2" HW up from Thermostatic Controller. Thermostatic Controller shall be equal. "Hydroguard" Series 430, Model # 432 or an approved stainless steel cabinet - see specifications.
 4. 2-1/2" CW, 1-1/2" HW, 3/4" HW, 3/4" HW.
 5. 2-1/2" CW, 2" HW, 1" HW.
 6. Wall mounted soap dispensing tank - see Detail Sheet M-16.
 7. 2-1/2" CW, 1-1/2" HW, 1" HW.
 8. 4" R.C. from R.D. #A-10 and down.
 9. 2" HW, 2-1/4" CW down.
 10. 4" R.C. from R.D. #A-2.

WRESTLING
(A-142)

A.C. STORAGE
(A-141)

ENTRY
(A-140)

ASSISTANT
ADMINISTRATOR
(A-139)

MEAN
(A-138)

WOMEN
(A-137)

FILE
(A-136)

STUDENT SERVICES
RECEPTION
(A-135)

CONFERENCE
(A-134)

WORKROOM
(A-133)

SCOUTS
(A-132)

SCOUTS
(A-131)

SCOUTS
(A-130)

SCOUTS
(A-129)



SCOUTS
(A-128)

SCOUTS
(A-127)

SCOUTS
(A-126)



UNIT "B" PLUMBING FIRST FLOOR PLAN

SCALE: 1/8" = 1'-0"

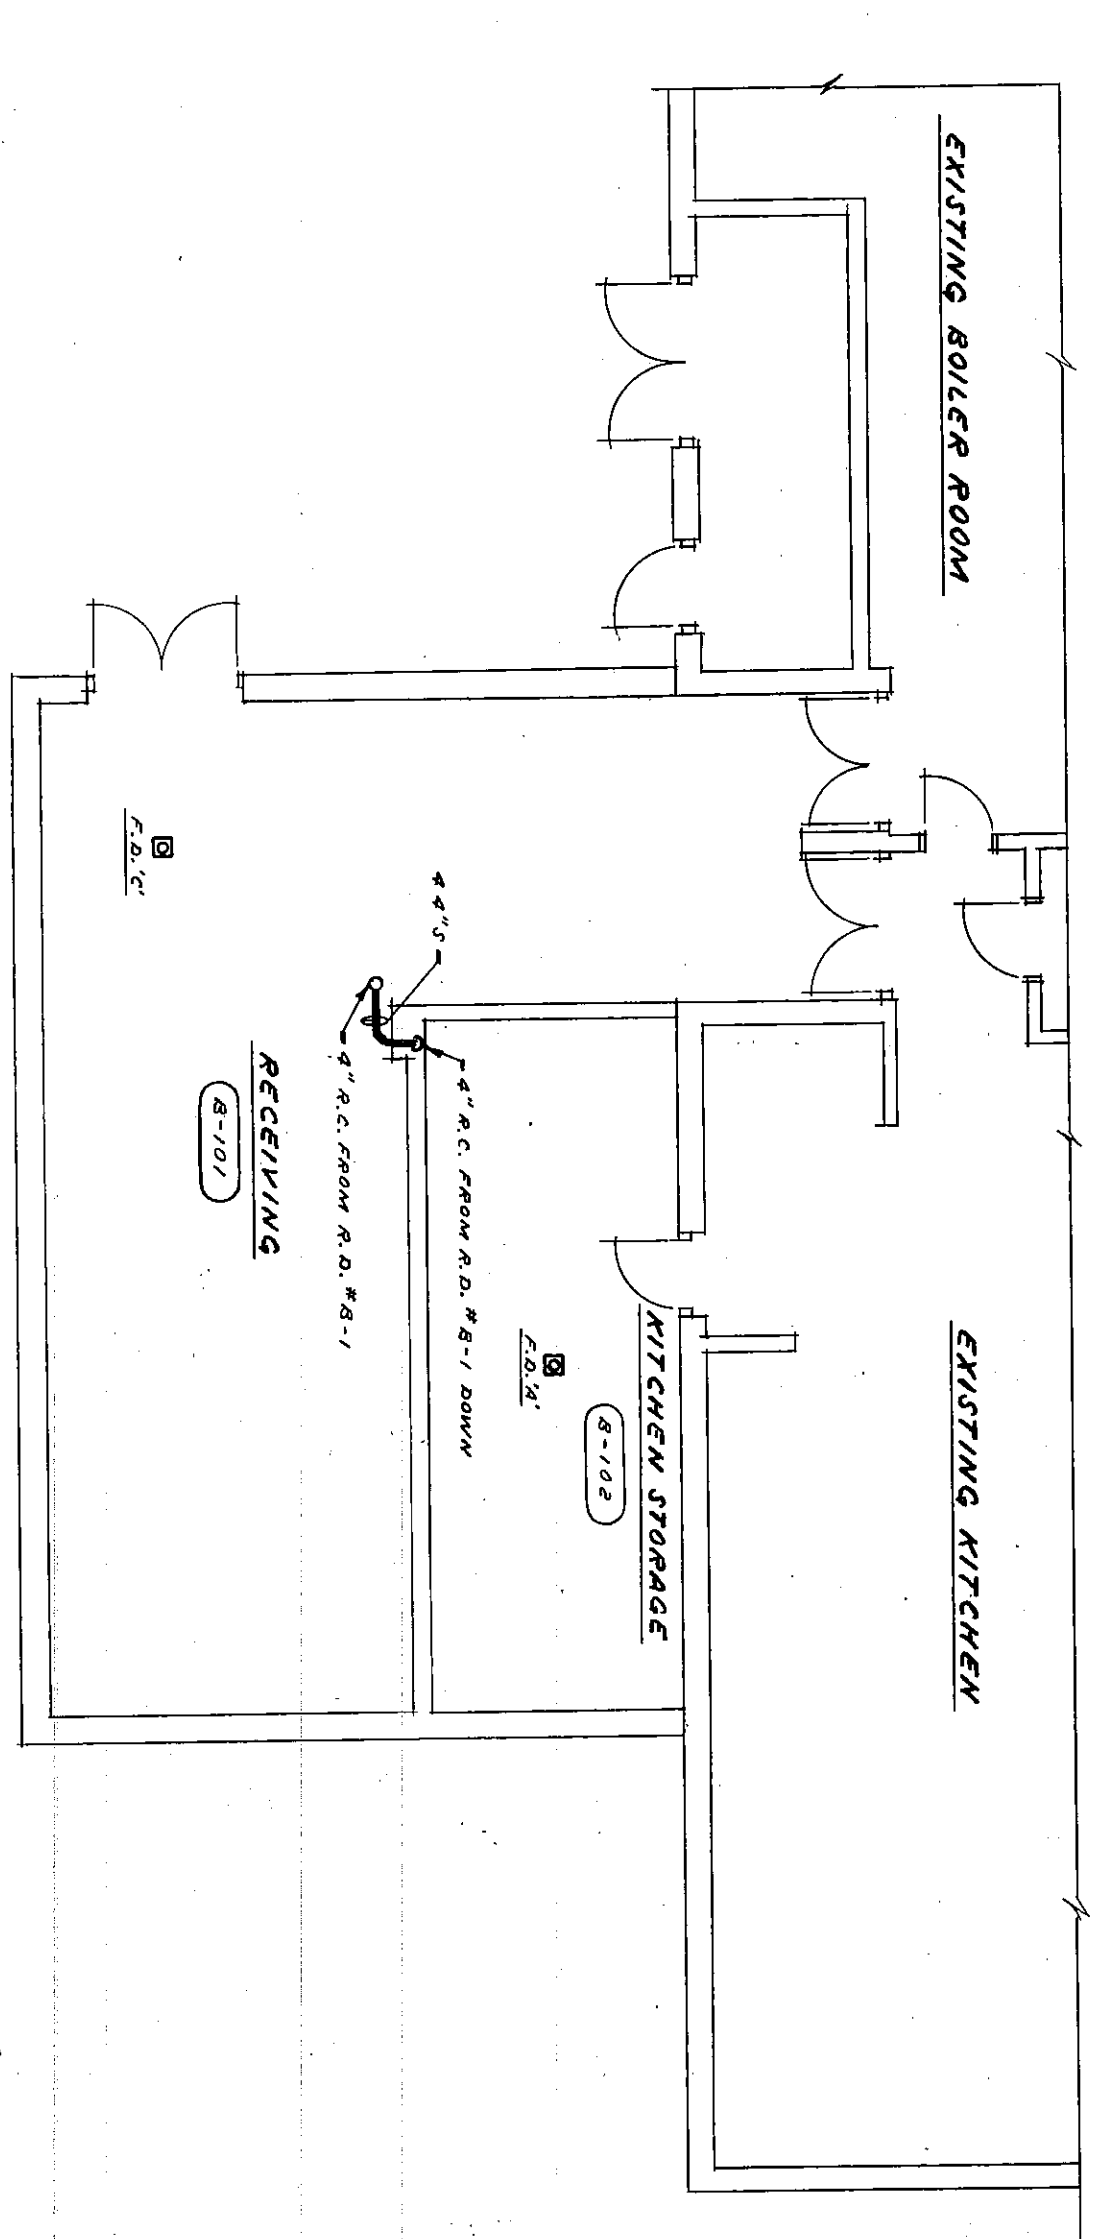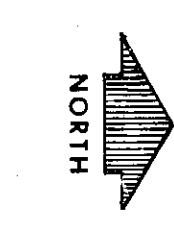


UNIT "A" PLUMBING FIRST FLOOR PLAN

SCALE: 1/8" = 1'-0"

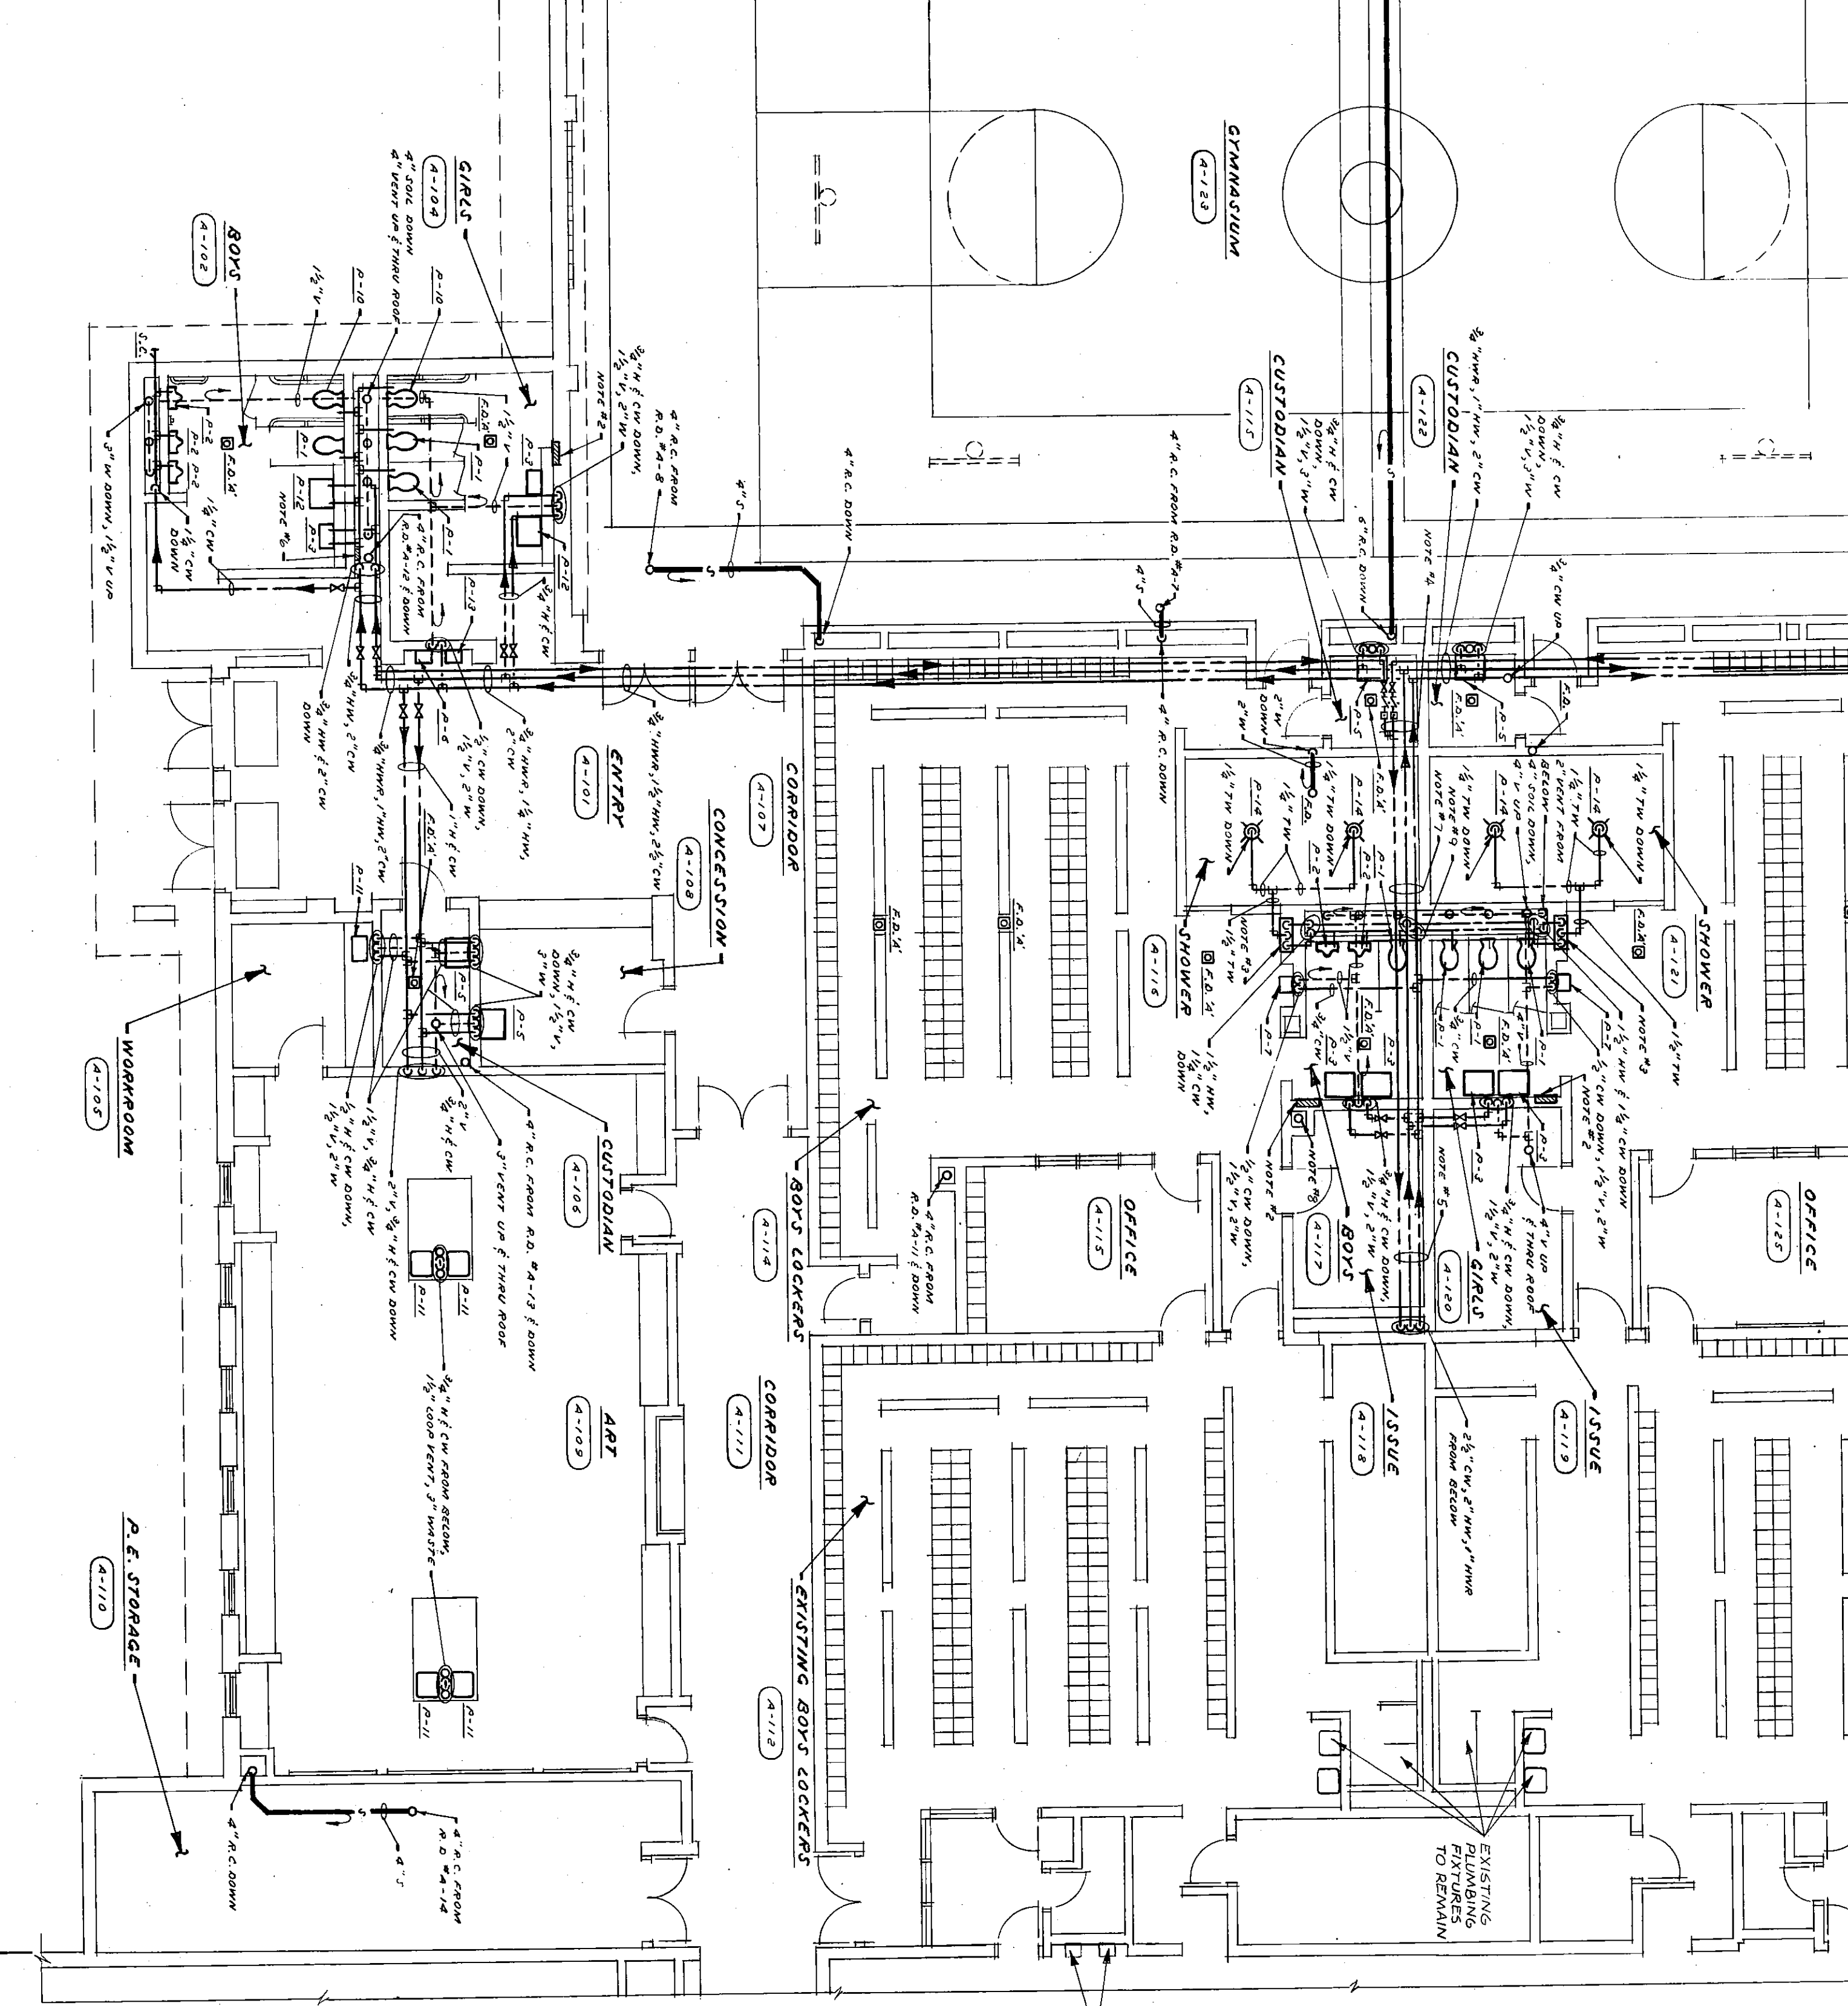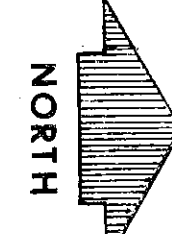


UNIT "A" PLUMBING SECOND FLOOR PLAN

SCALE: 1/8" = 1'-0"

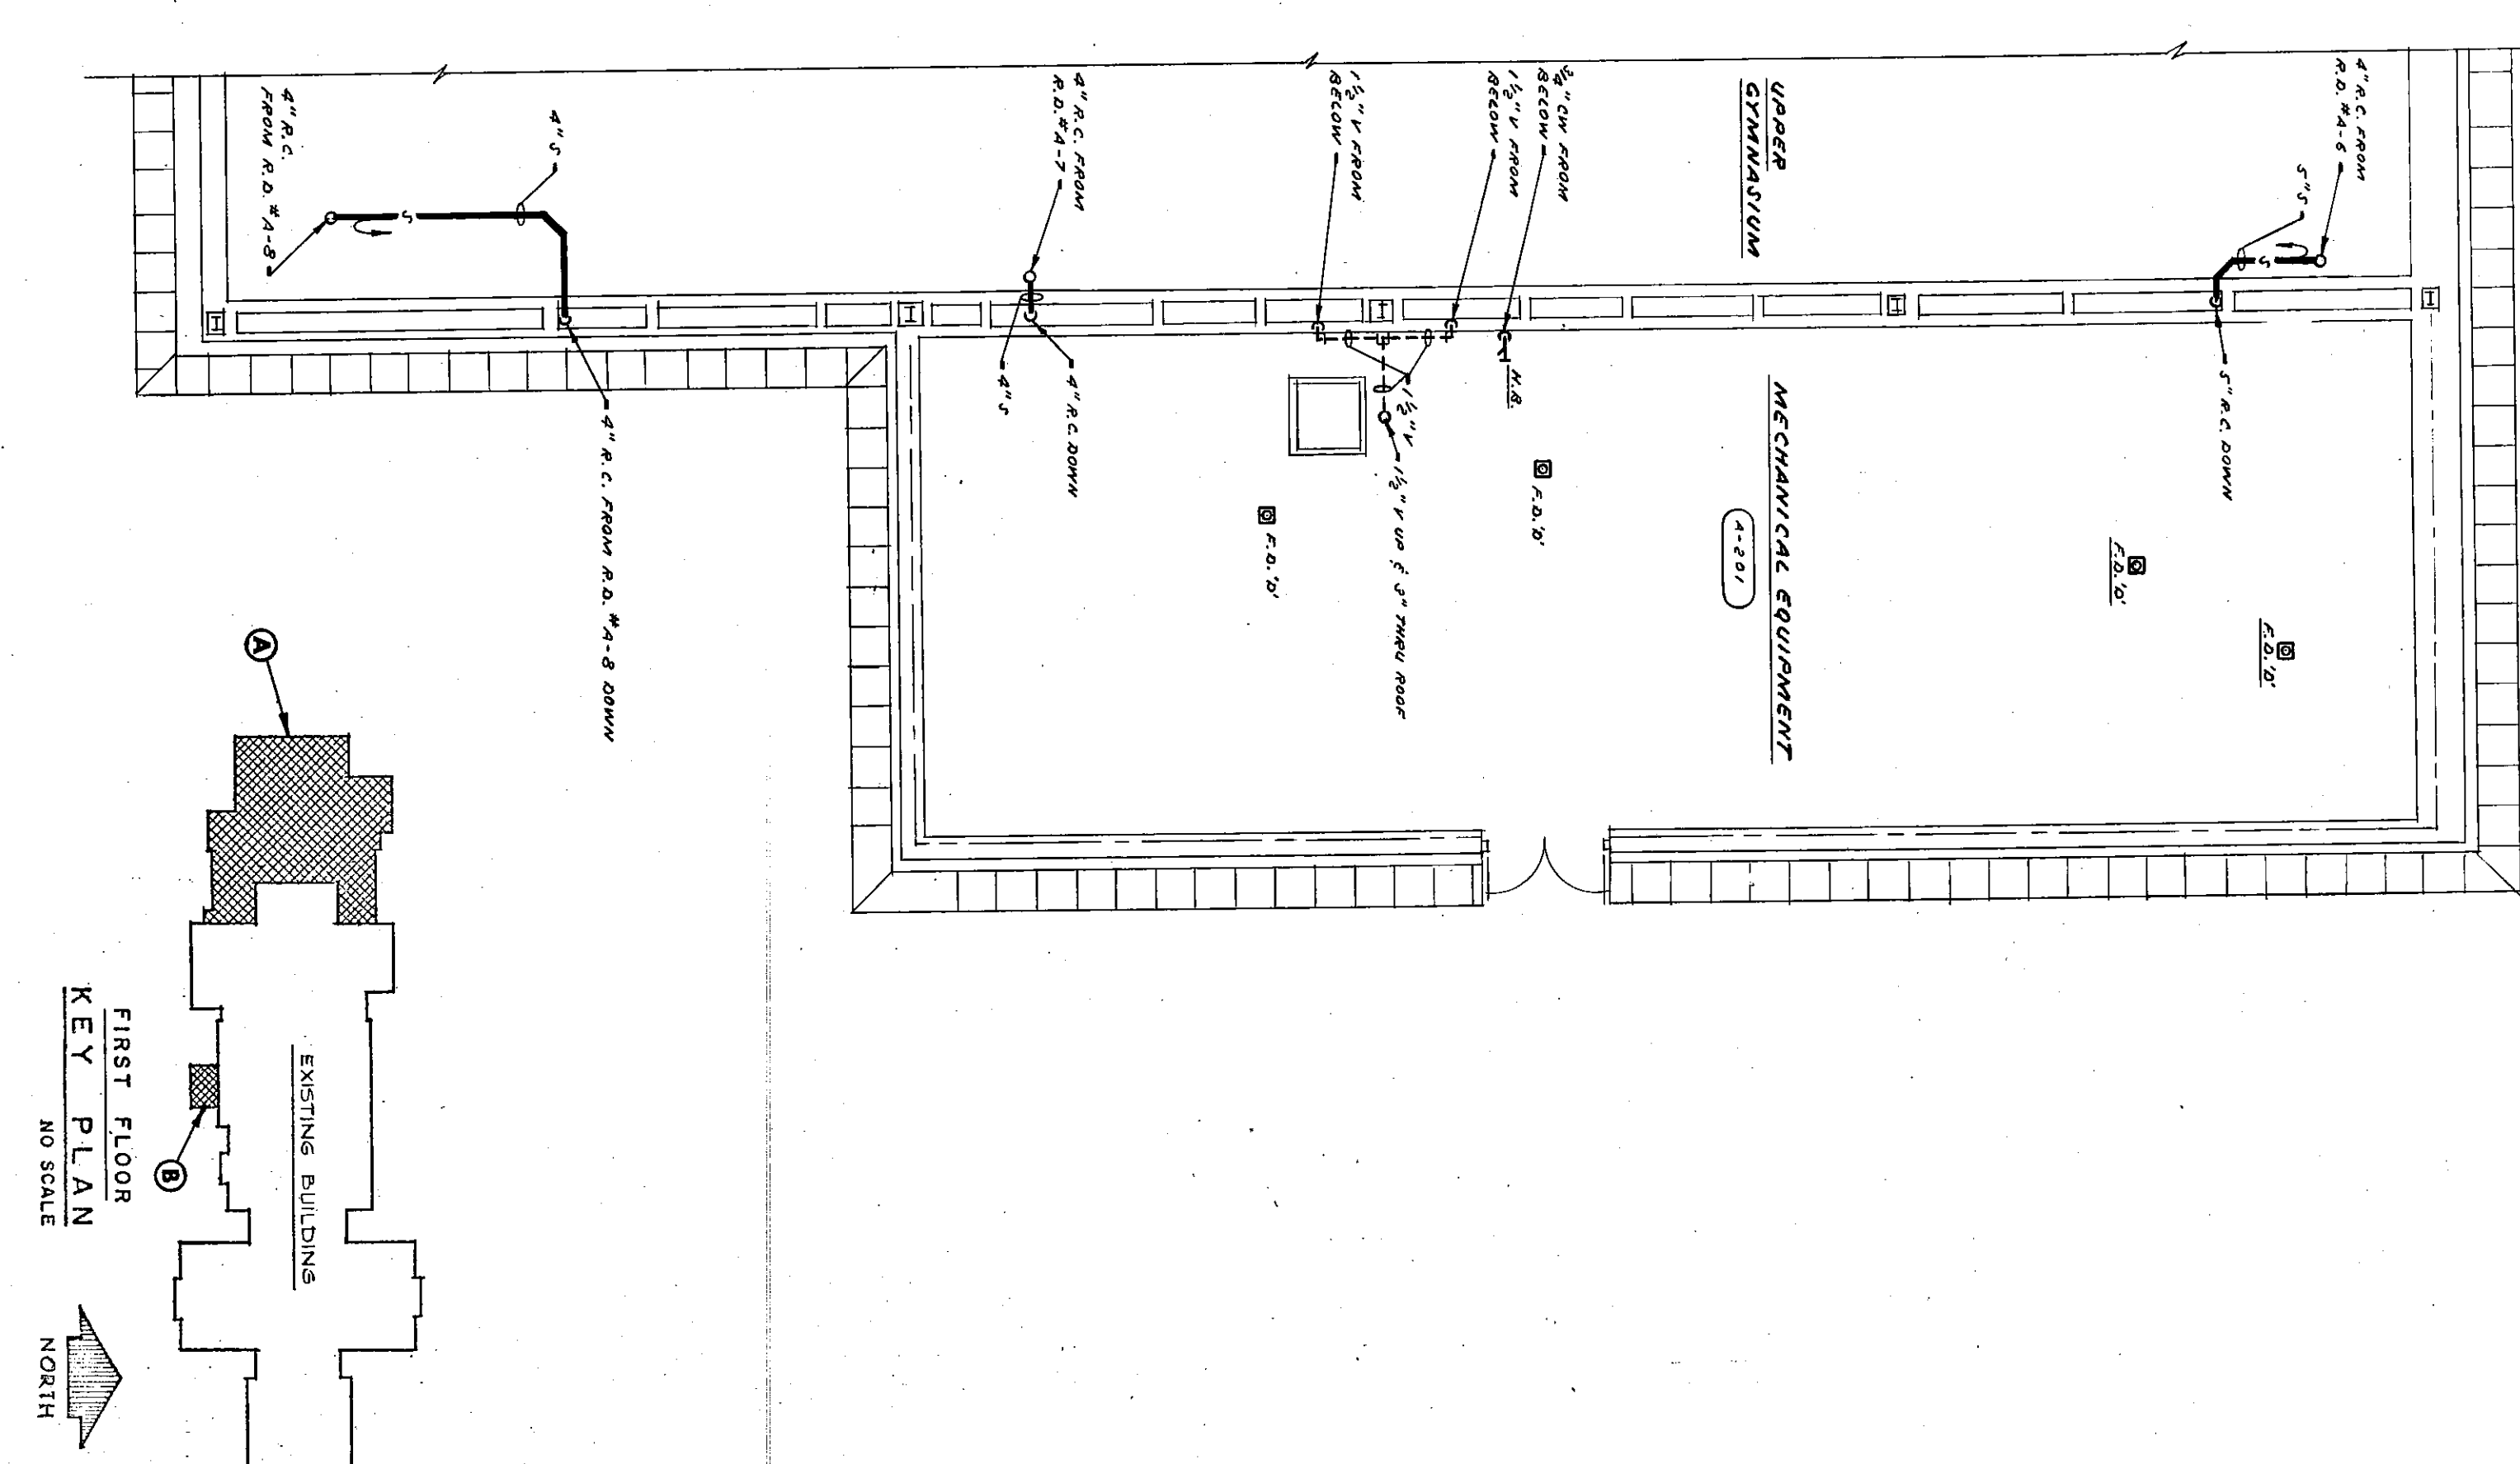

EXISTING BUILDING
KEY PLAN
NO SCALE

 

EVERETT · I · BROWN COMPANY

5500 WEST BRADBURY AVENUE ·

· PARK FLETCHER ·

ADDITION TO AND RENOVATION OF WESTCHESTER MIDDLE SCHOOL

ARCHITECTS
ENGINEERS

· INDIANAPOLIS, INDIANA · 46241

PROJECT
3178

DATE
NOV. 5, 1979

REVISED

NO. M-10
OF 18

JAMES A. PARTIDGE
REGISTERED PROFESSIONAL ENGINEER
STATE OF INDIANA
12545

James A. Partidge

79-M-88