

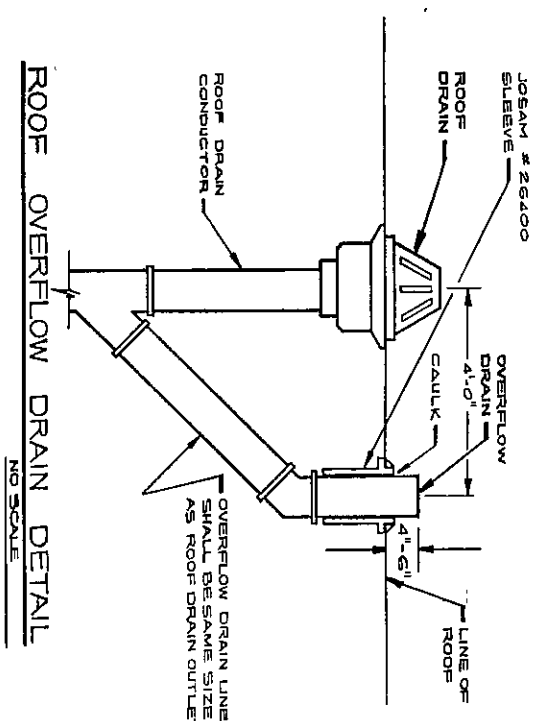


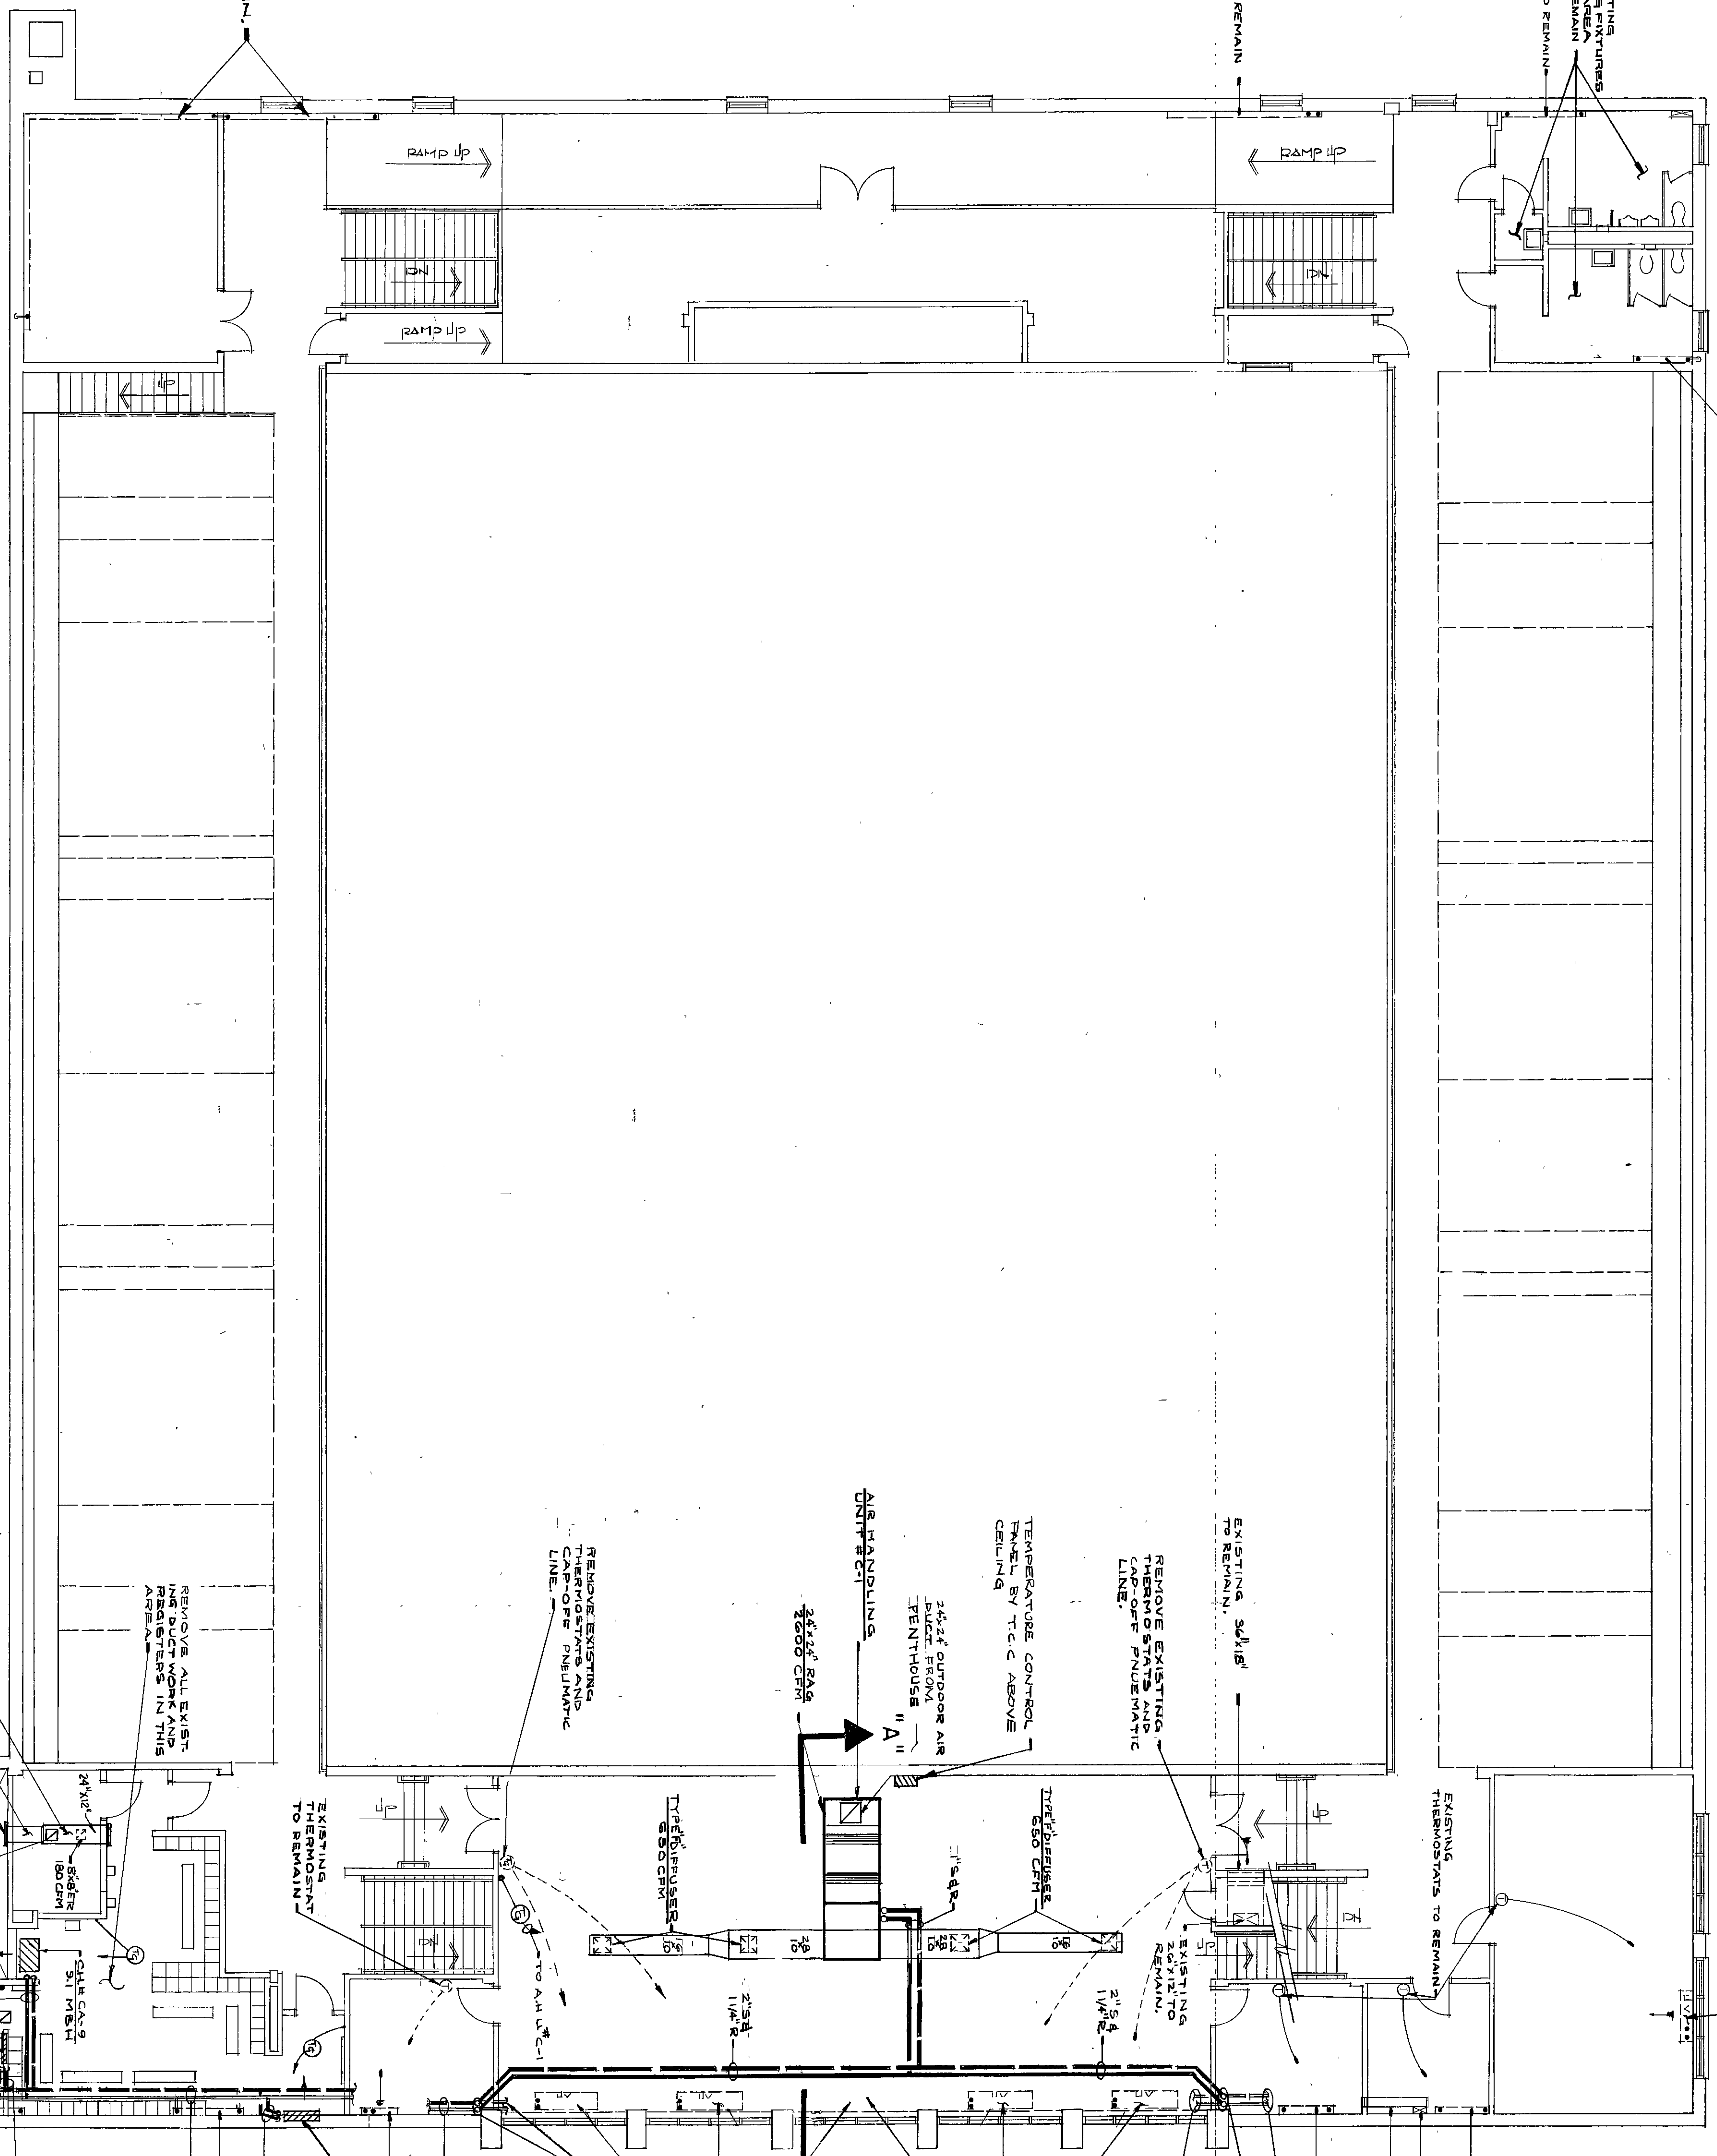


R O O F D R A I N S C H E D U L E				
ROOF DRAIN NUMBER	SIZE	J. R. SMITH	JCSAM	GRADE
A-1	3"	1010	21500	46'-1300

NOTE:

1. All roof drains shall be provided with overflows.

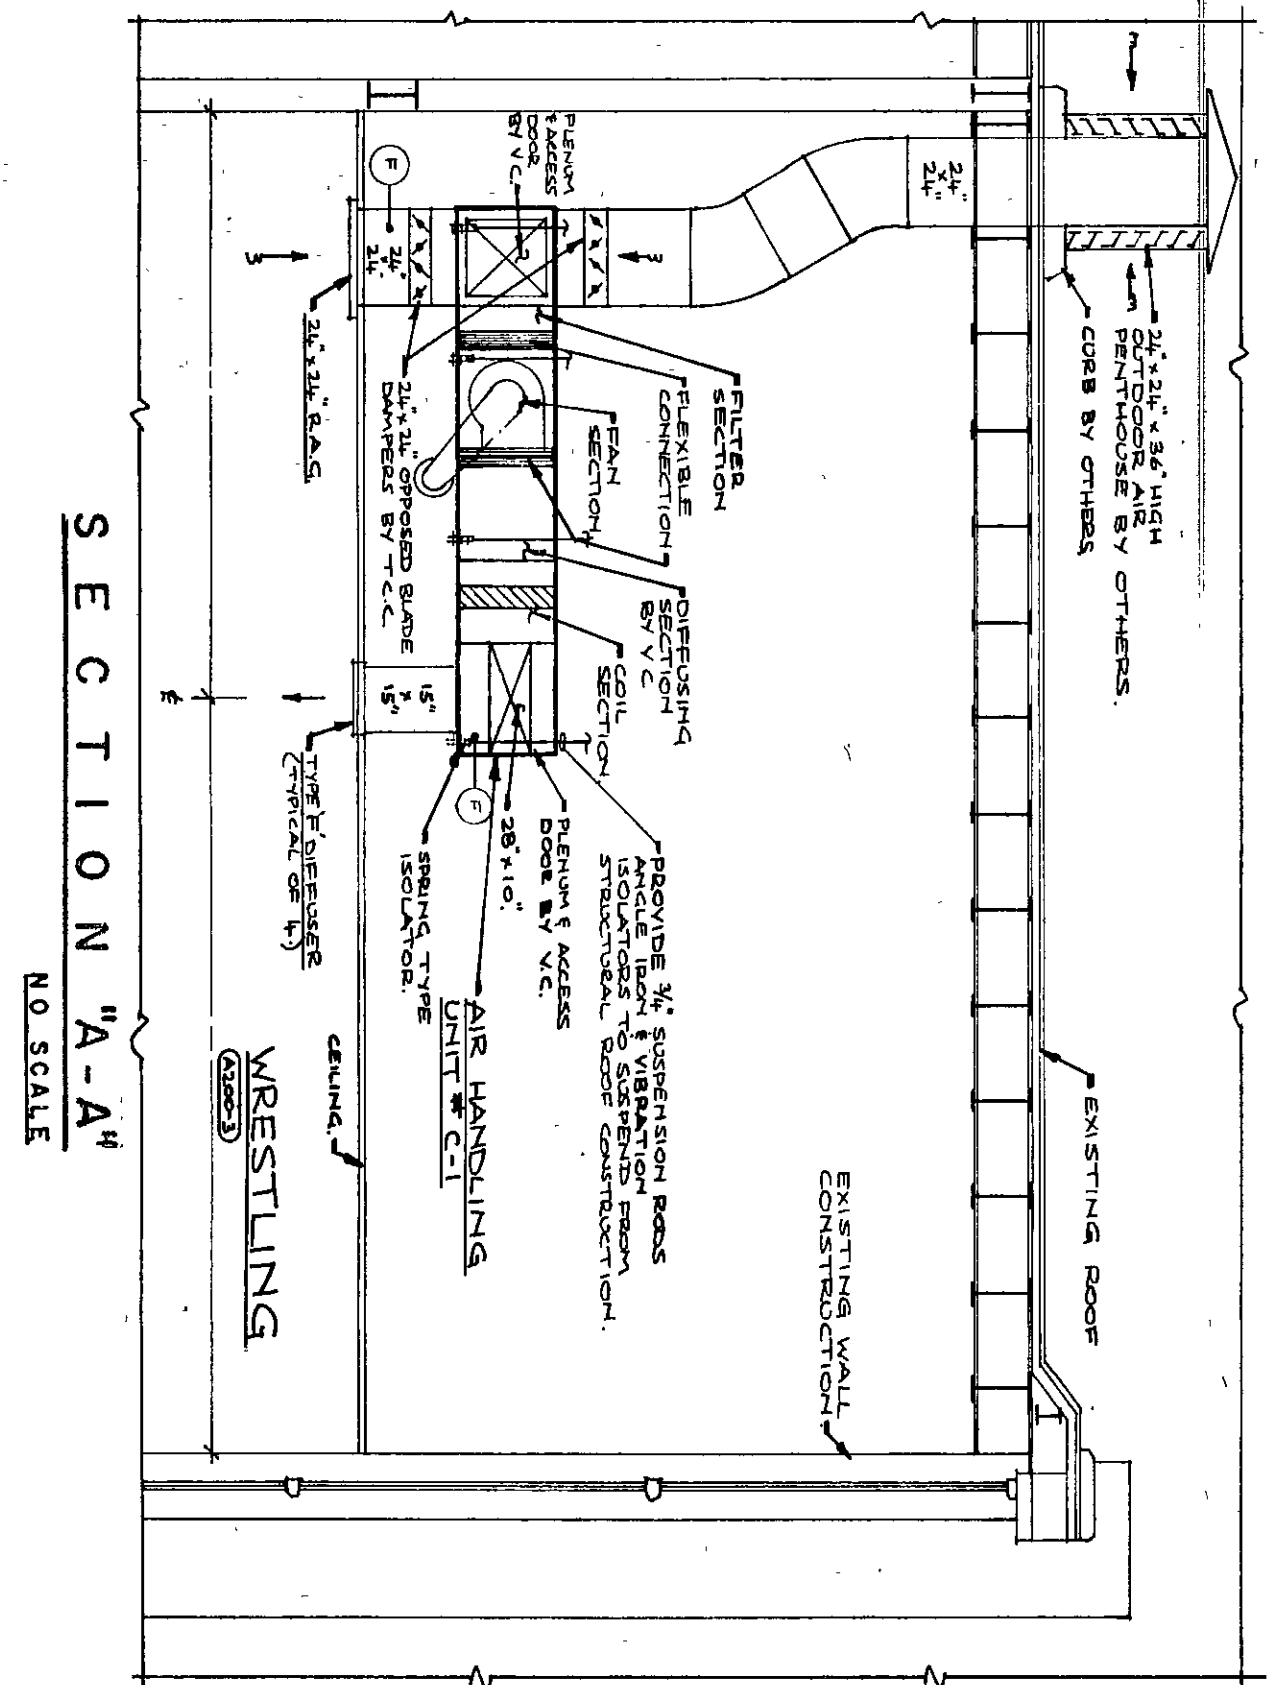


HEATING, VENTILATING & PLUMBING
SECOND FLOOR PLAN
SCALE: 1/8" = 1'-0"

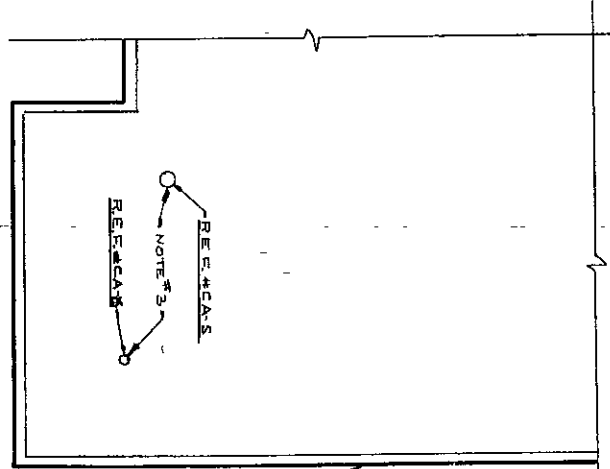


PARTIAL ROOF PLAN AREA #2

SCALE 1/8" = 1'-0"

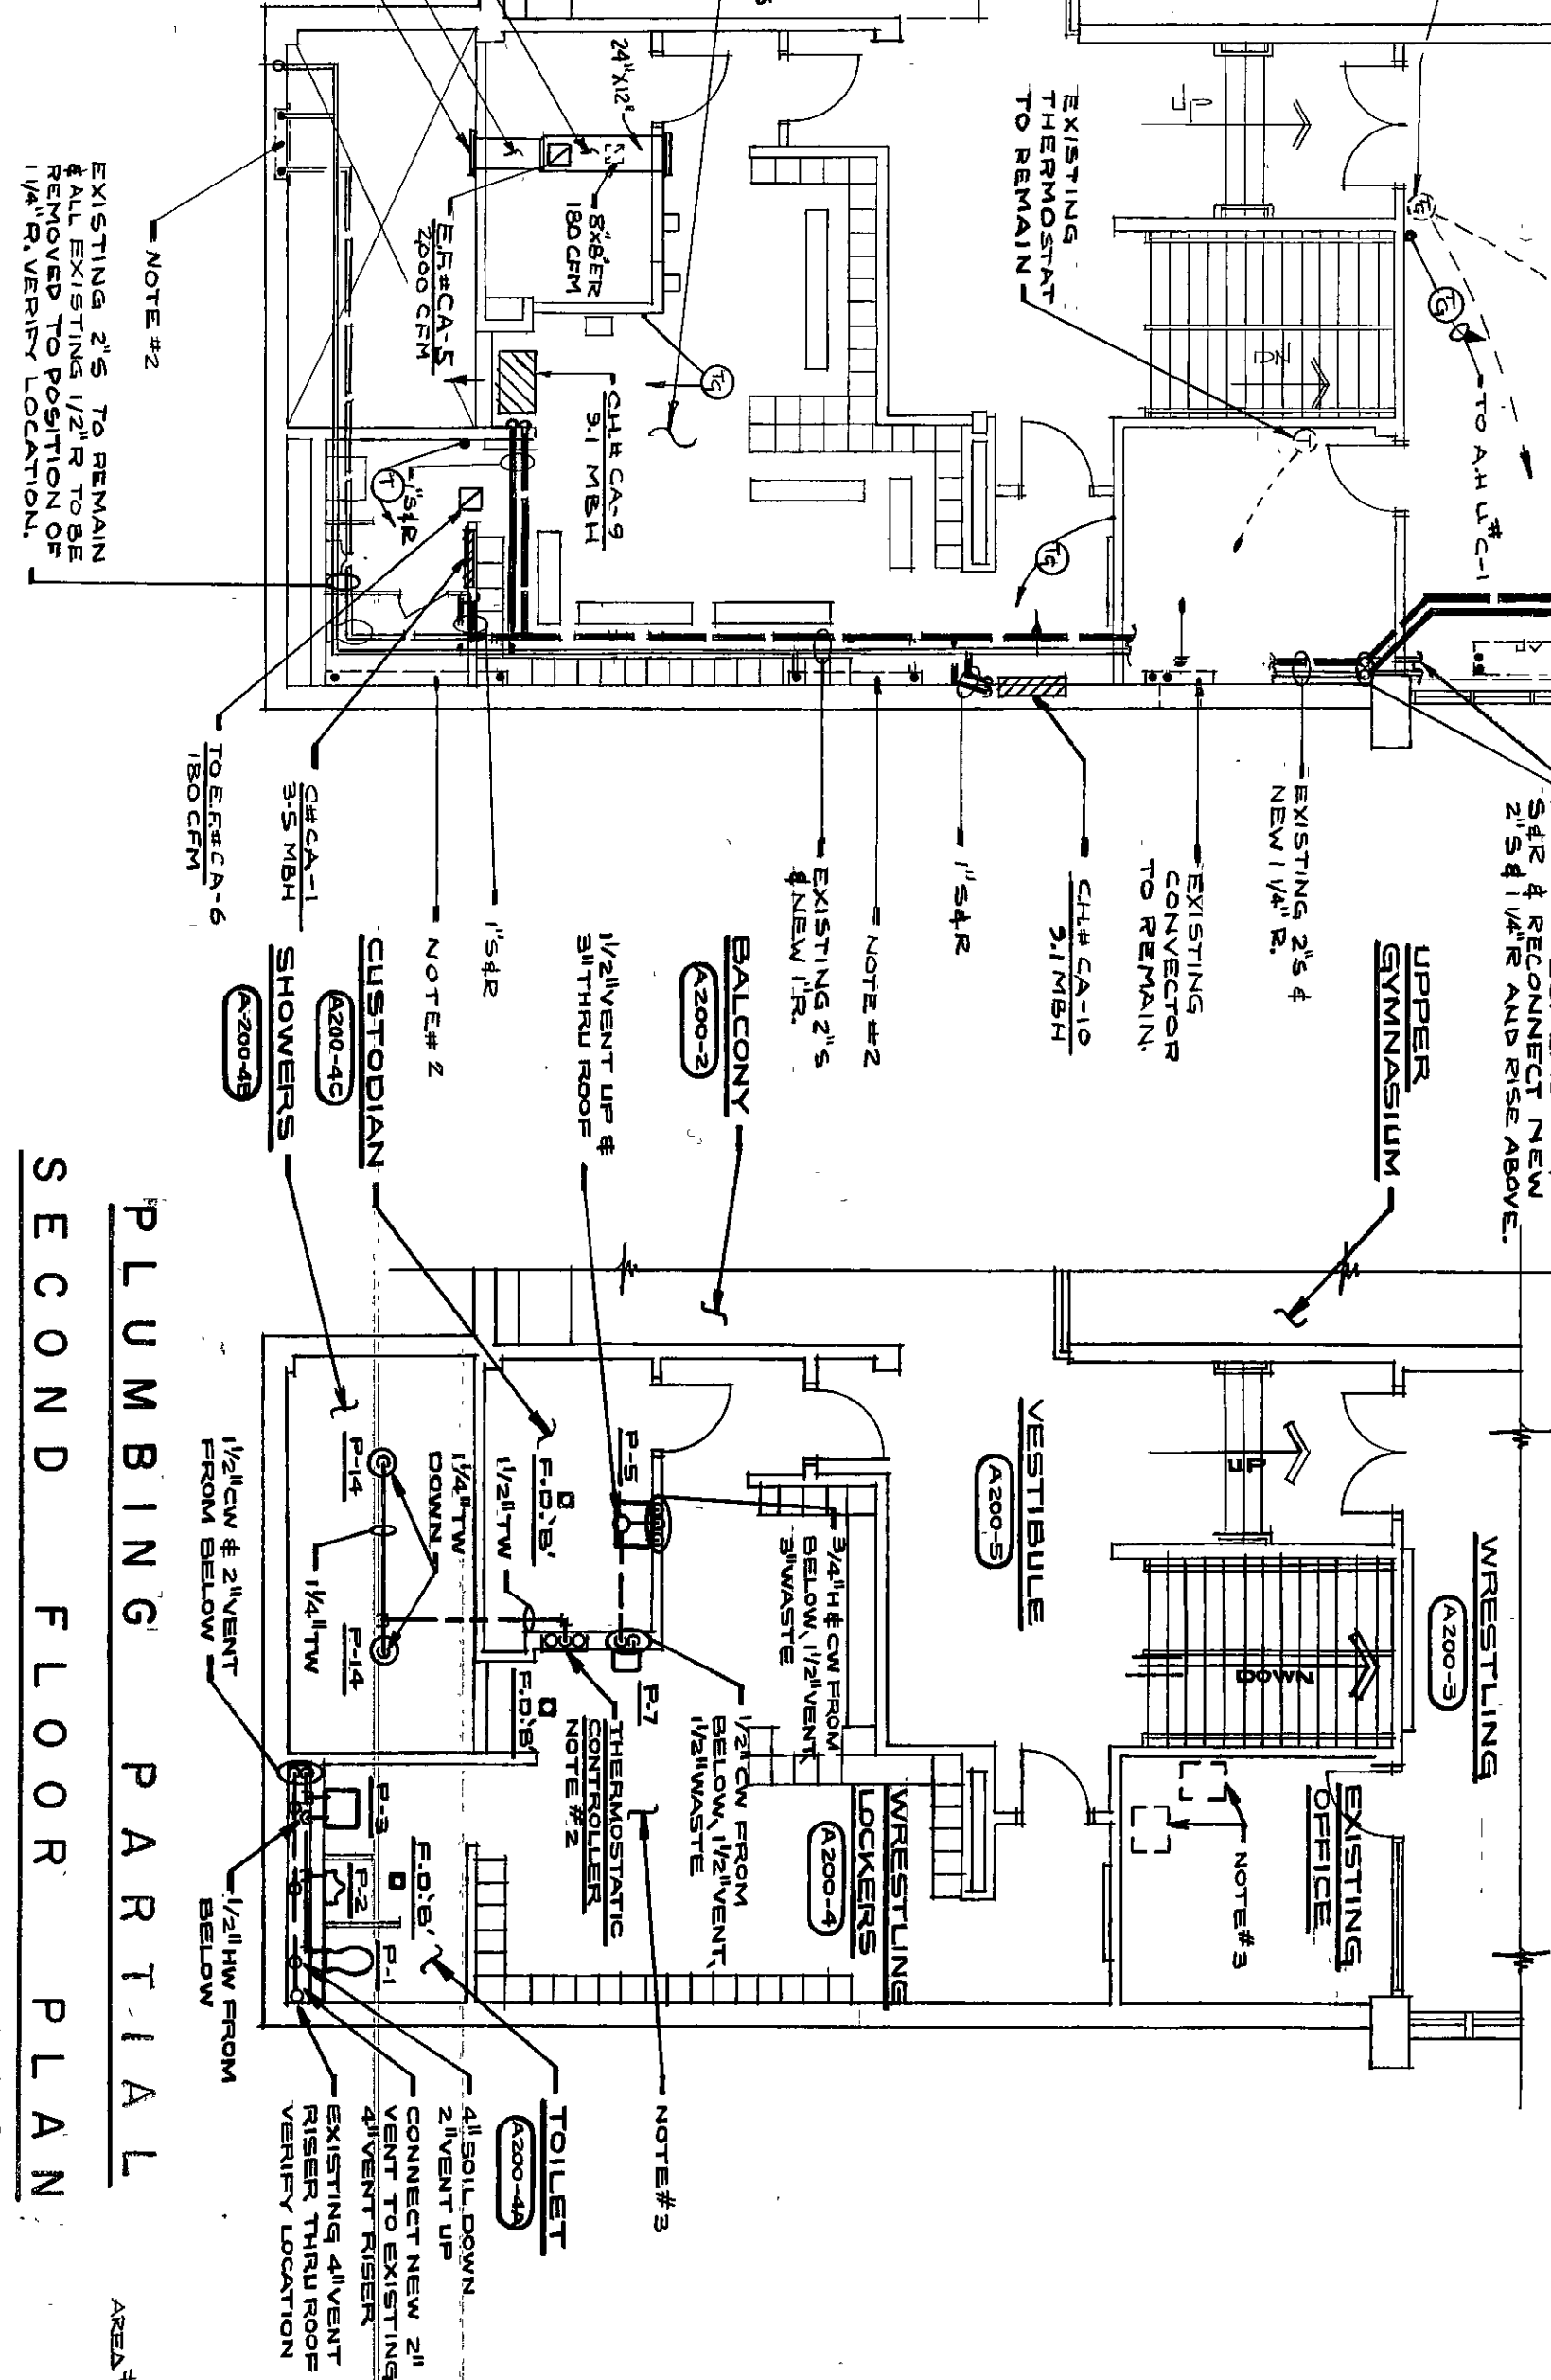

PLUMBING PARTIAL
SECOND FLOOR PLAN
SCALE: 1/8"=1'-0"

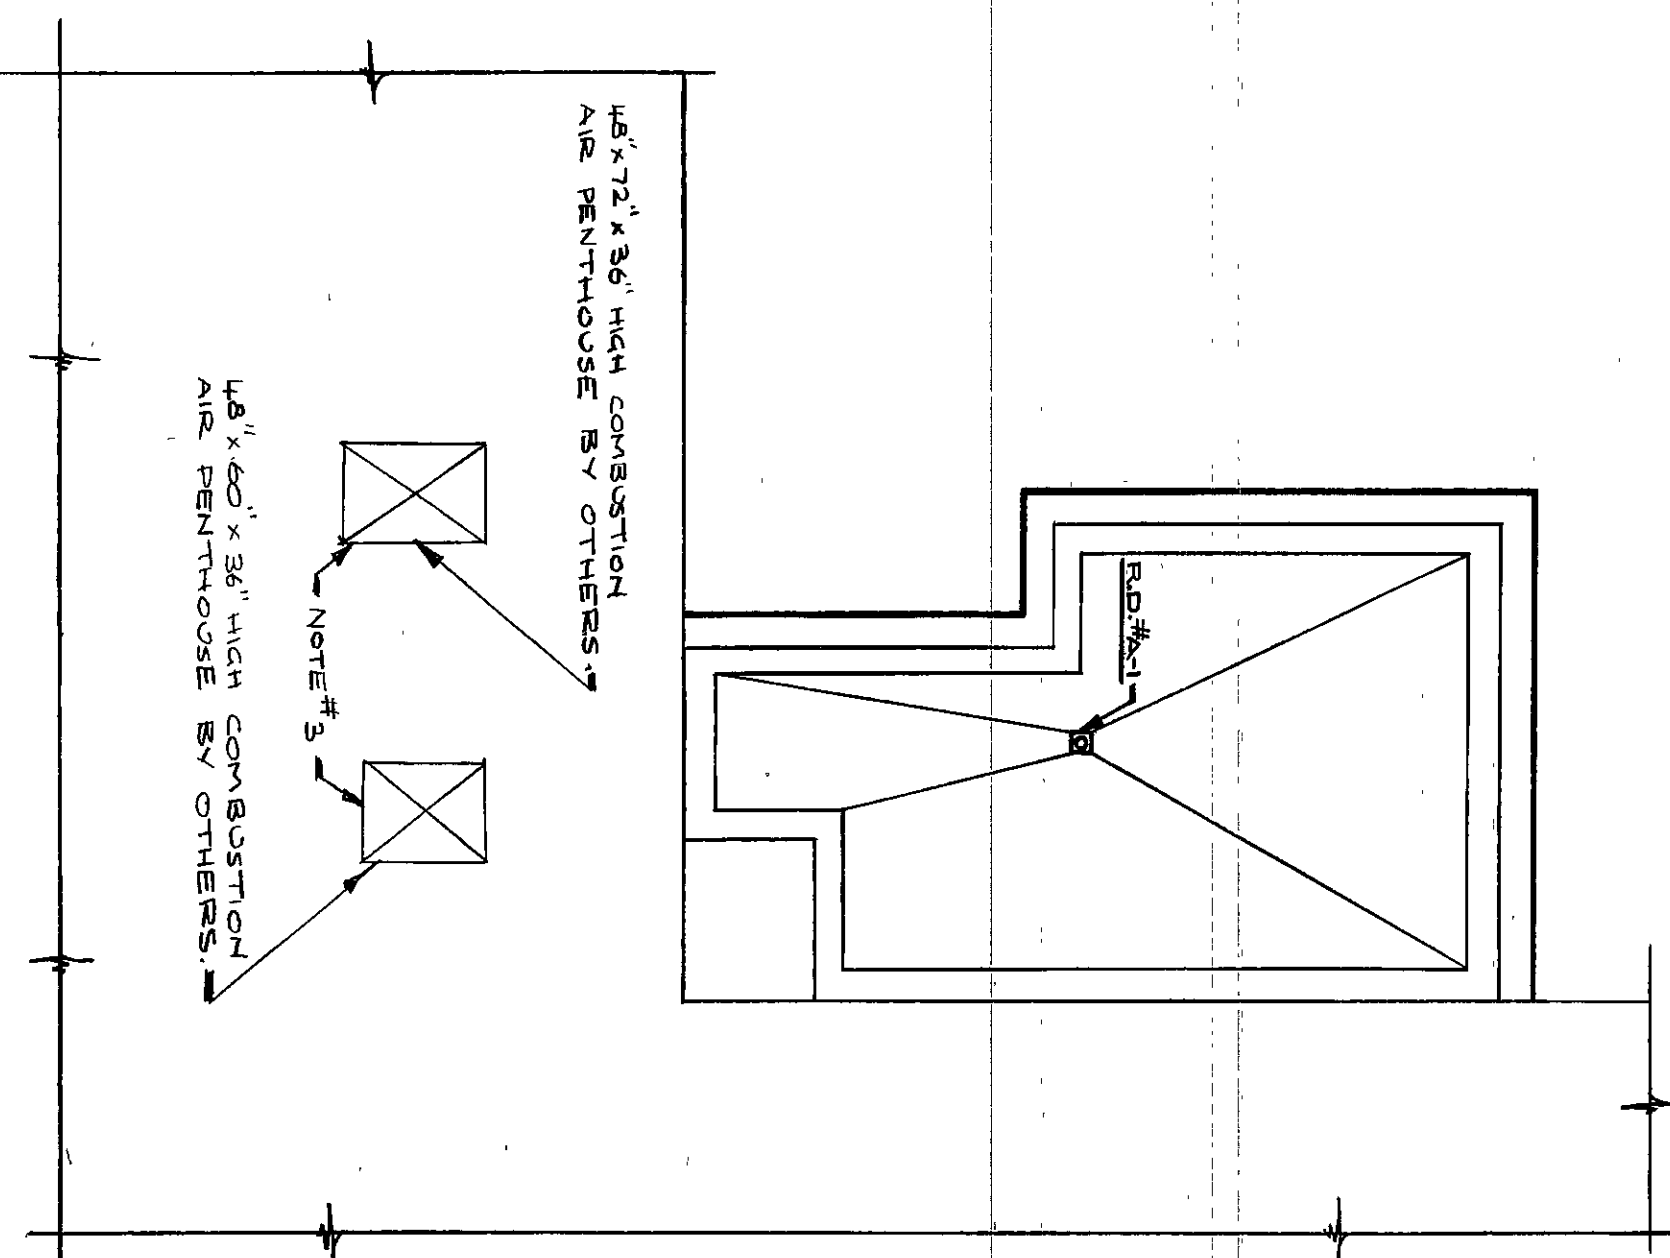

PARTIAL ROOF PLAN AREA #1

1. See Sheet M-1 for General Notes, Legend and Schedules
2. Remove all existing classroom unit ventilator in radiator and plpym as necessary.
3. Curbs and repatching of roof by others.

PLAN NOTES

EVERETT · I · BROWN COMPANY

5500 WEST BRADBURY AVENUE •

• PARK FLETCHER •

• INDIANAPOLIS, INDIANA • 46241

MISCELLANEOUS RENOVATION OF CHESTERTON HIGH SCHOOL

© EVERETT I BROWN COMPANY