




- PLAN NOTES
1. See Sheet M-1 for General Notes, Legends and Schedules.
 2. Provide pipe portals where refrigeration piping passes through roof. See specifications.
 3. Cuts and re-patching of roof by others.

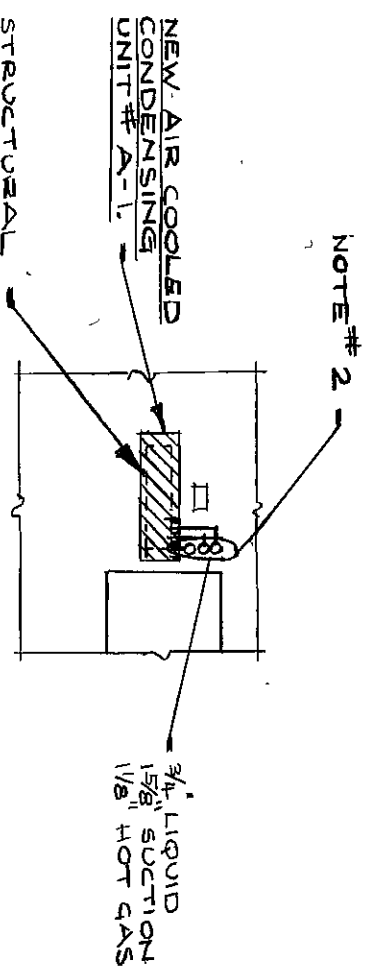


ROOF PLAN AREA #2
SCALE: 1/8" = 1'-0"

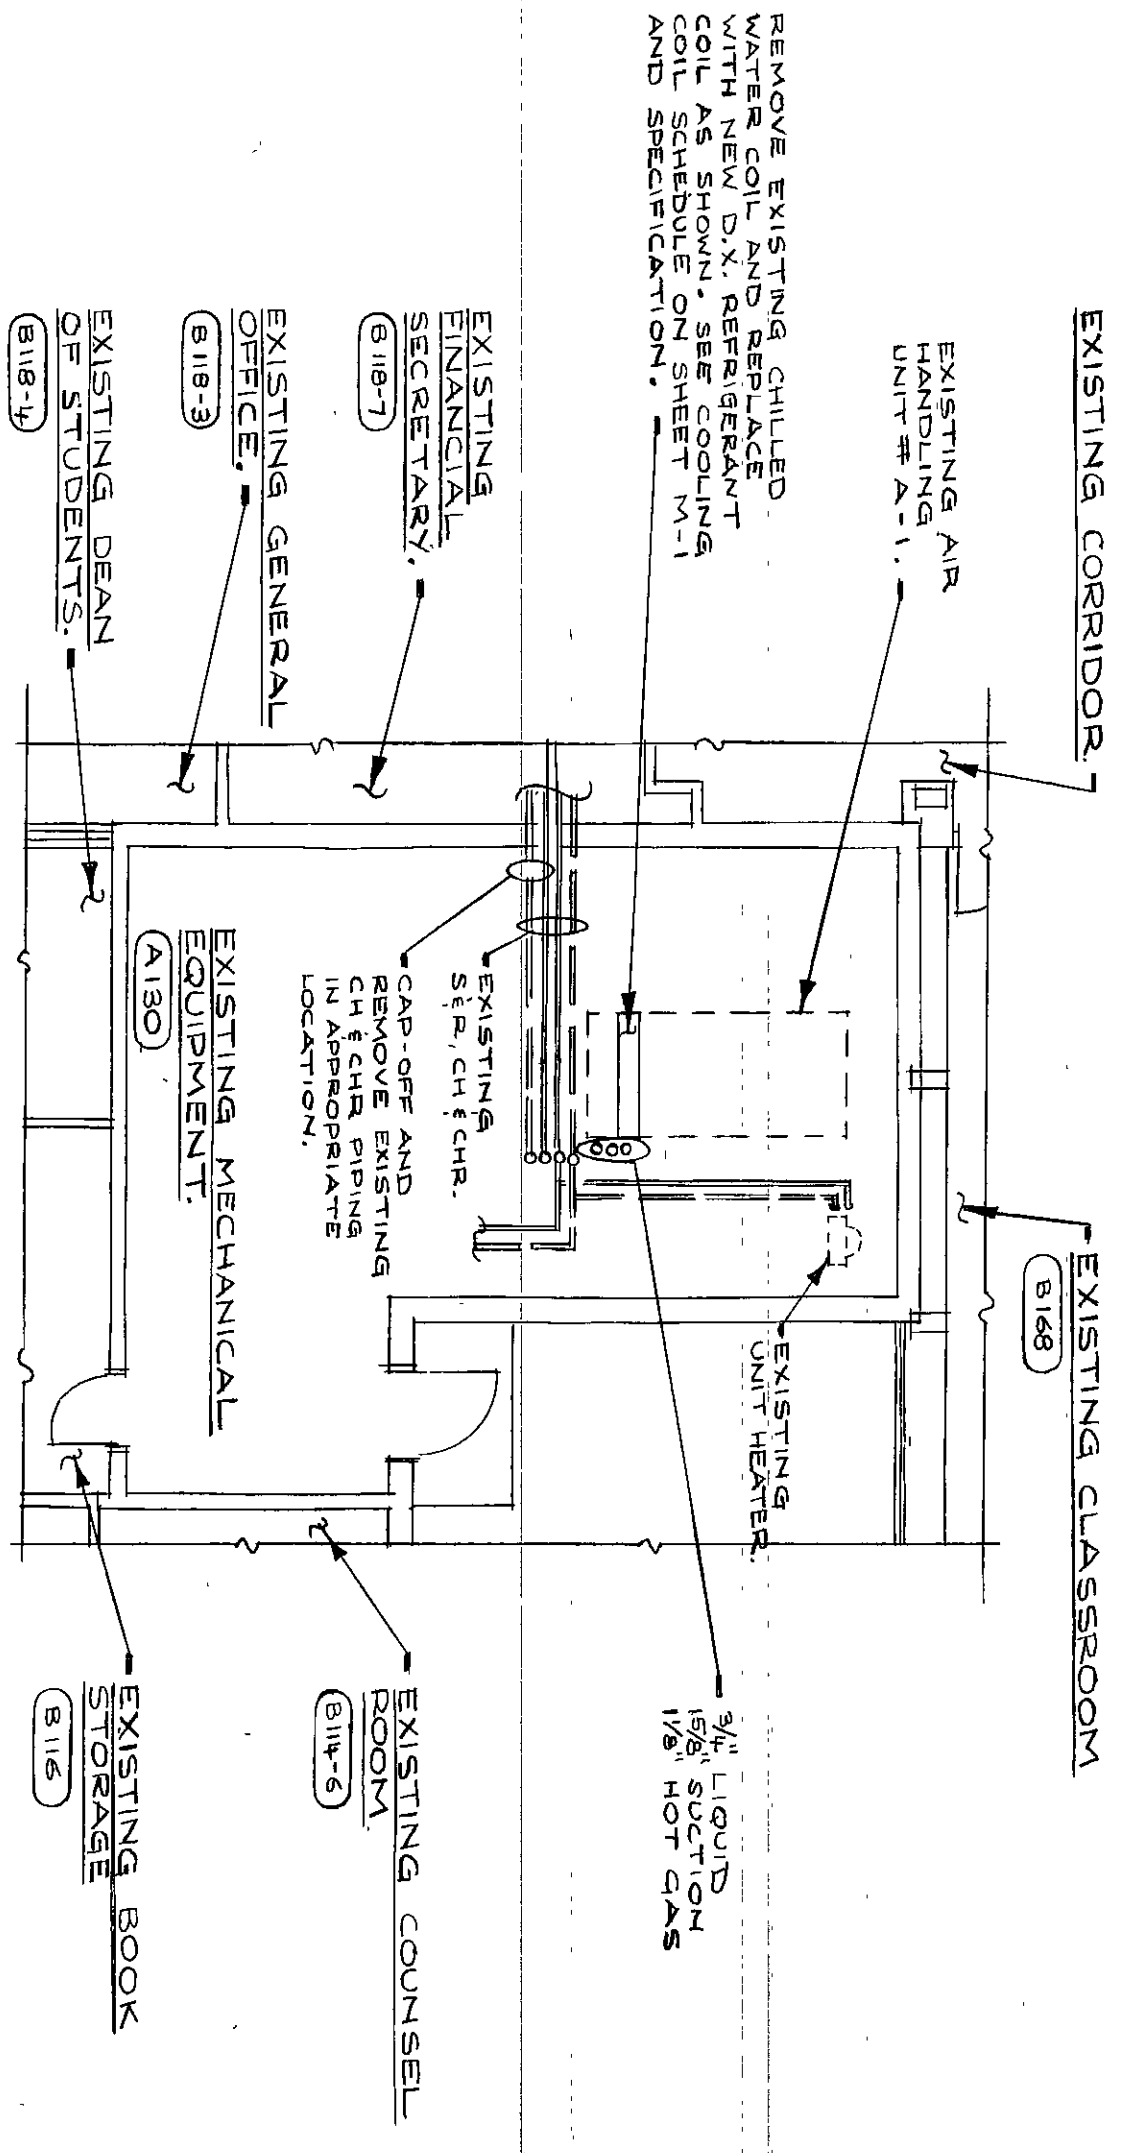


FIRST FLOOR PLAN AREA #2
SCALE: 1/8" = 1'-0"

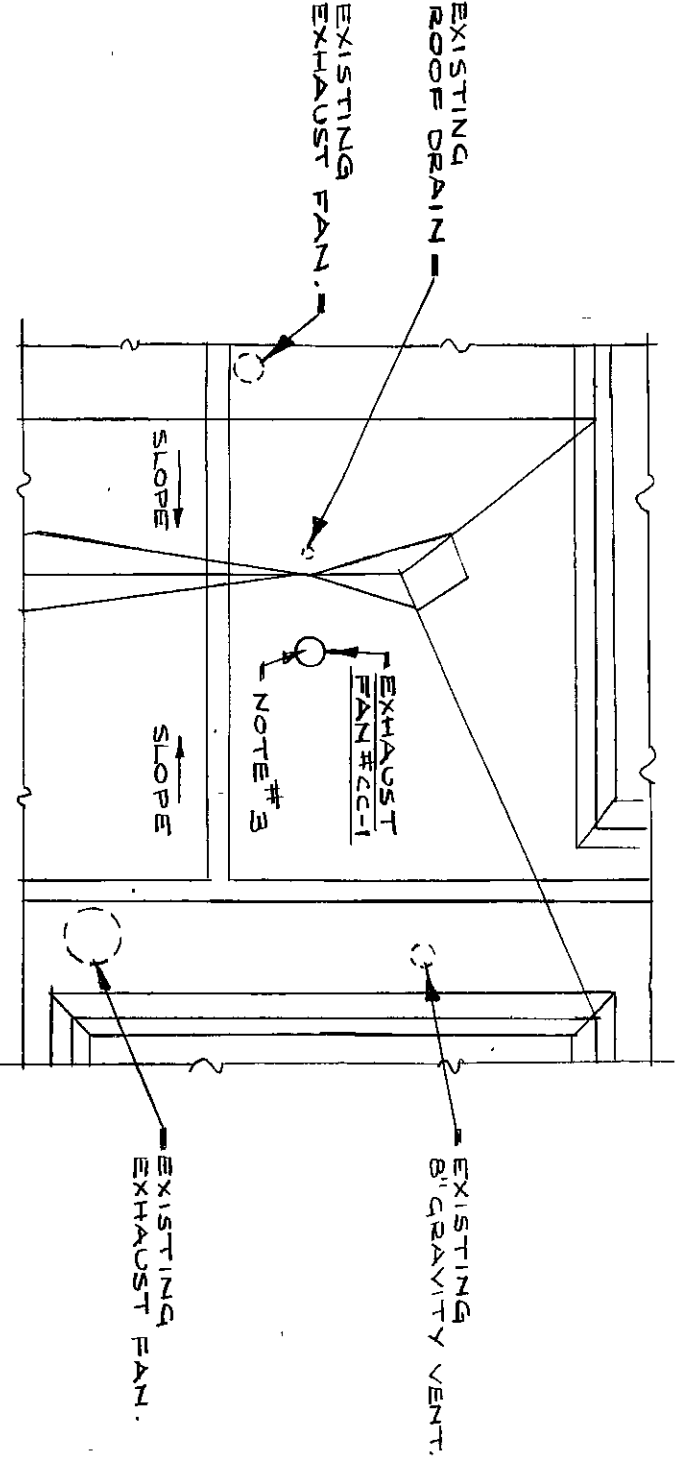


ROOF PLAN AREA #1
SCALE: 1/8" = 1'-0"

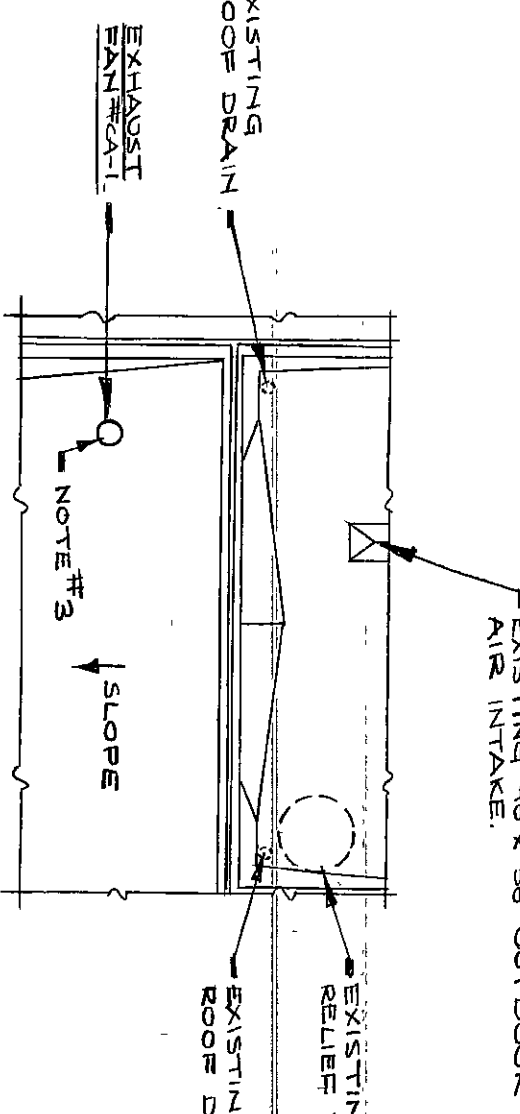


ROOF PLAN AREA #4
SCALE: 1/8" = 1'-0"

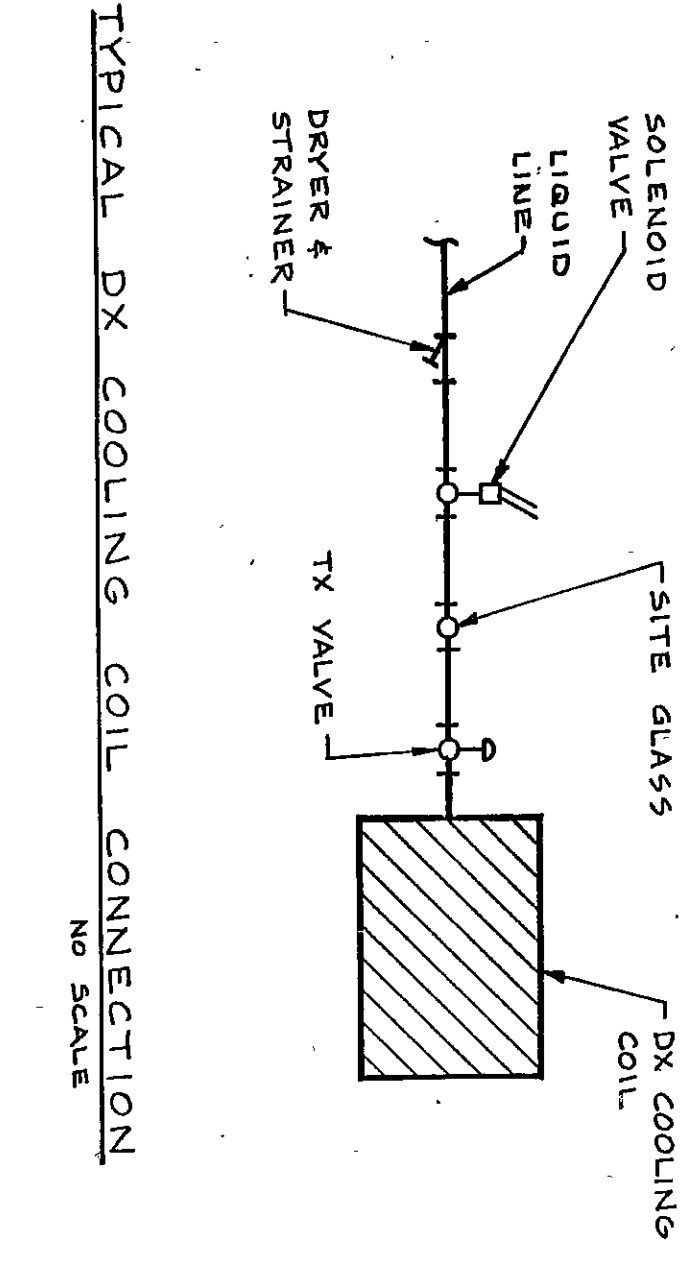


TYPICAL DX COOLING COIL CONNECTION
NO SCALE

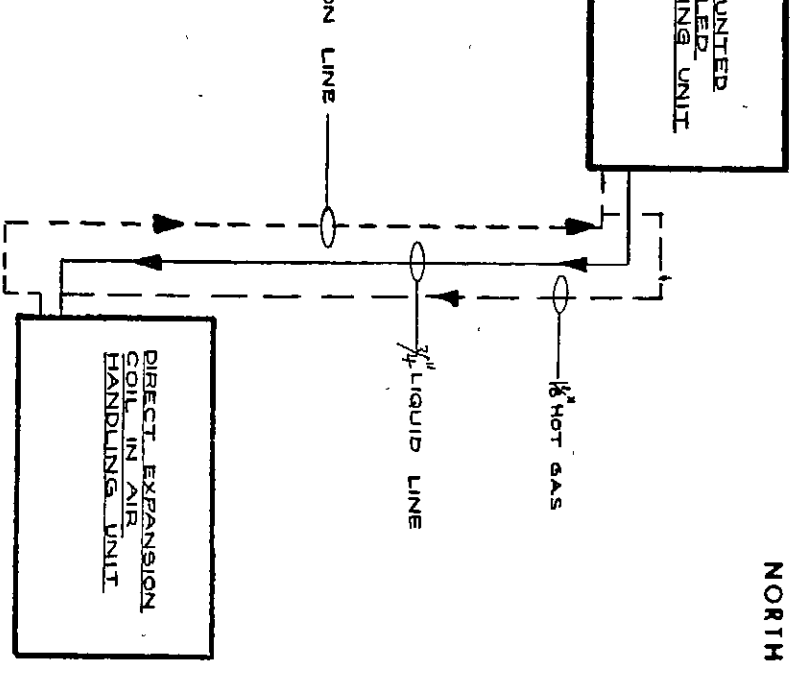


EXISTING AIR HANDLING UNIT #A-1
REFRIGERANT PIPING DIAGRAM
NO SCALE

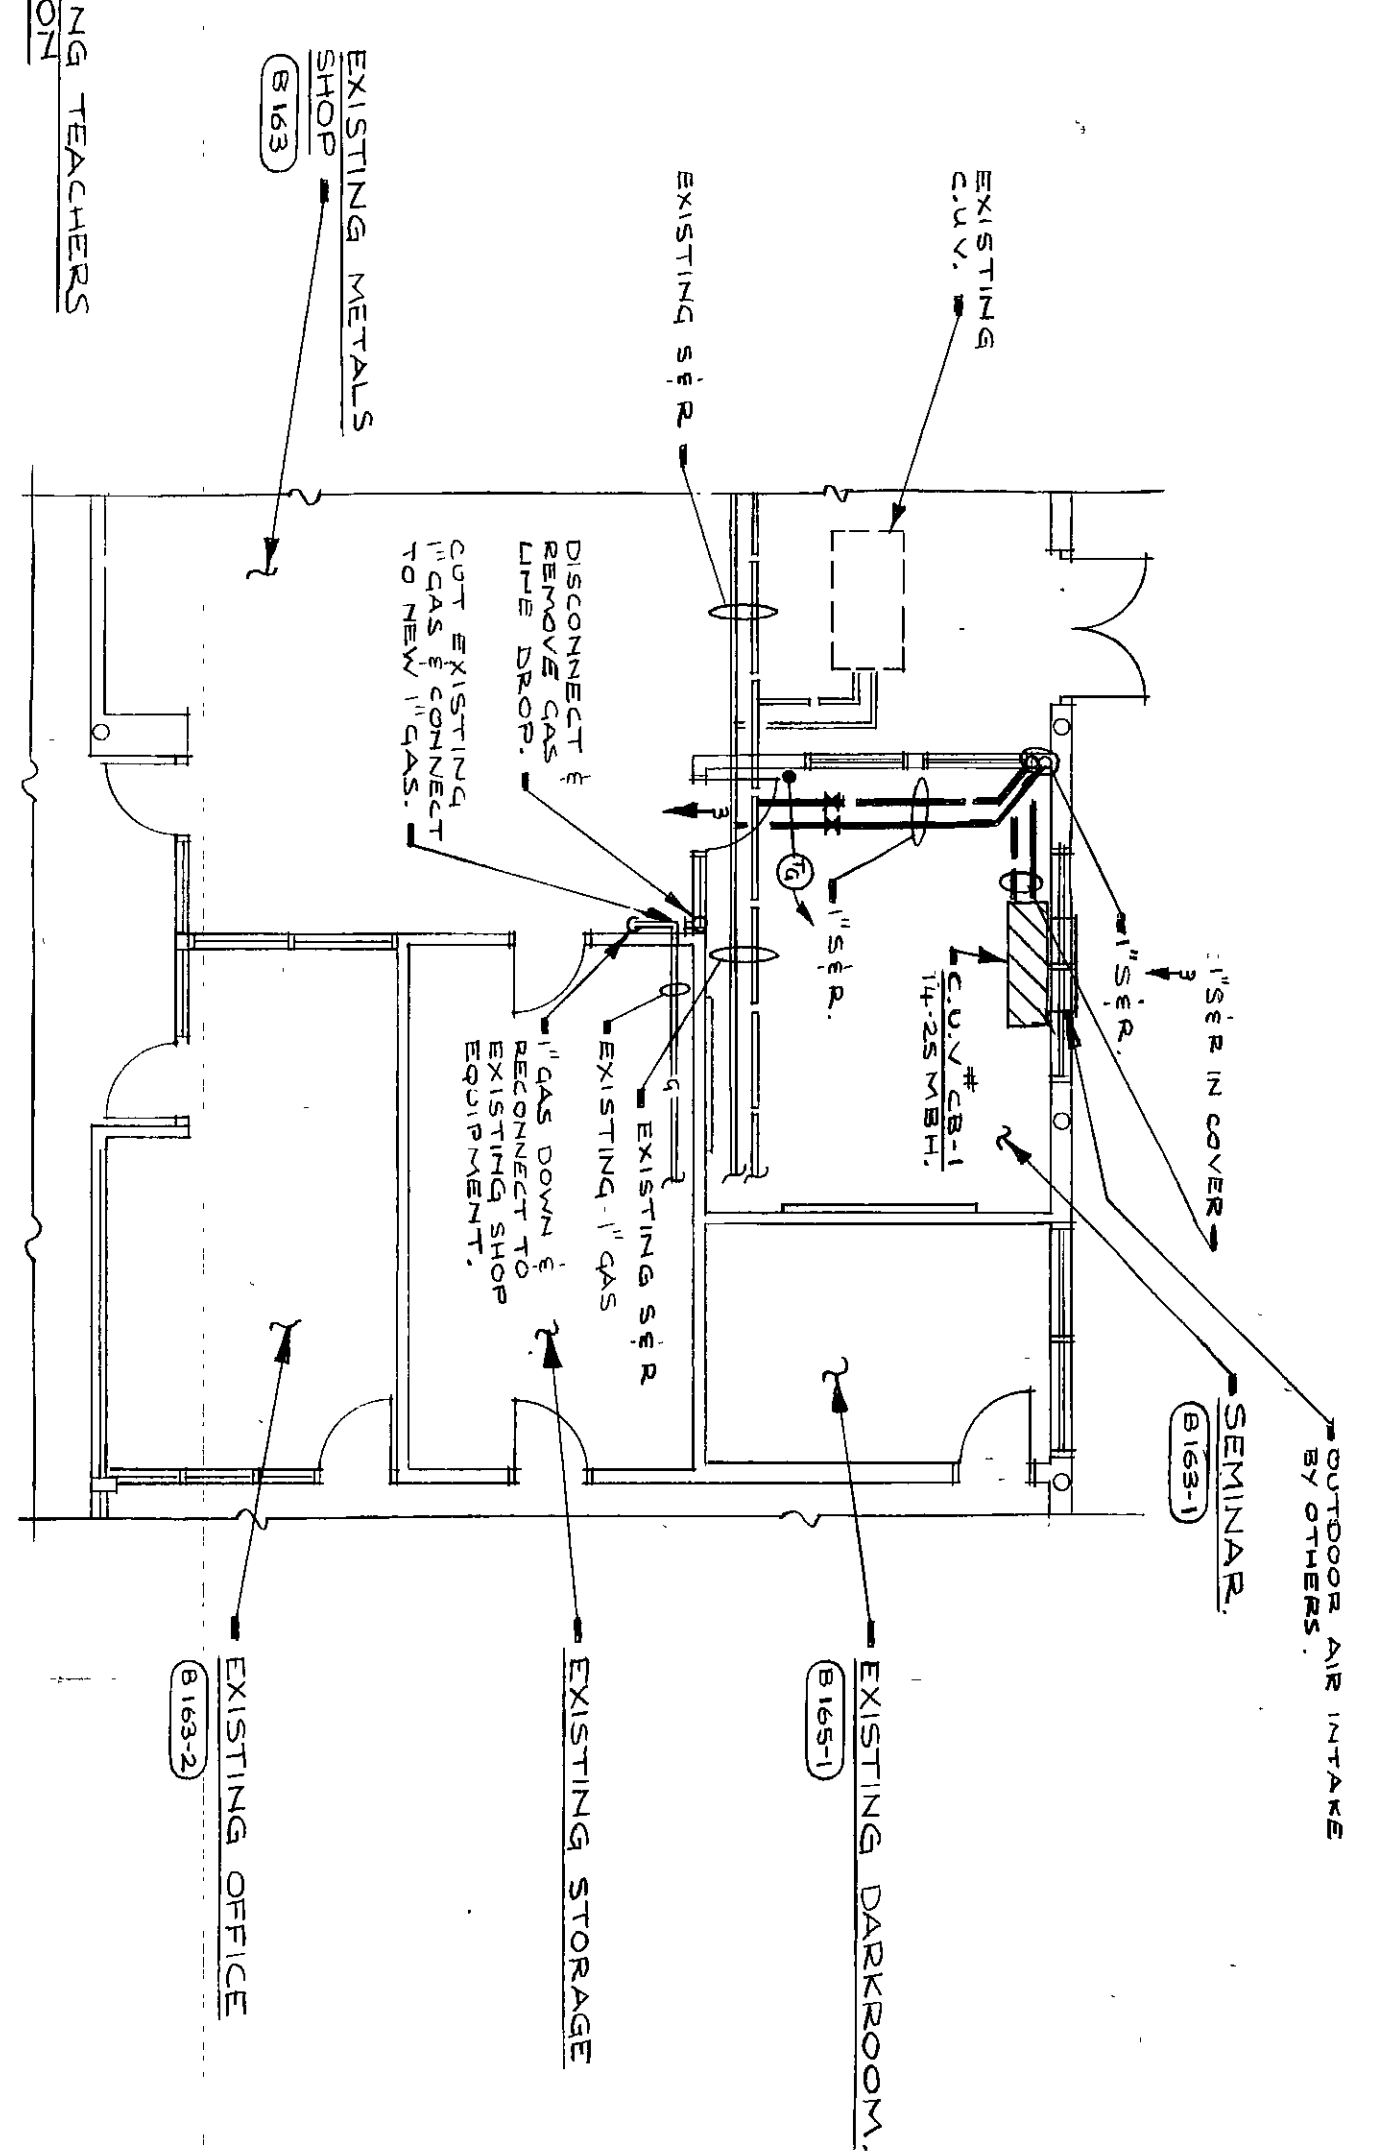


FIRST FLOOR PLAN AREA #3
SCALE: 1/8" = 1'-0"

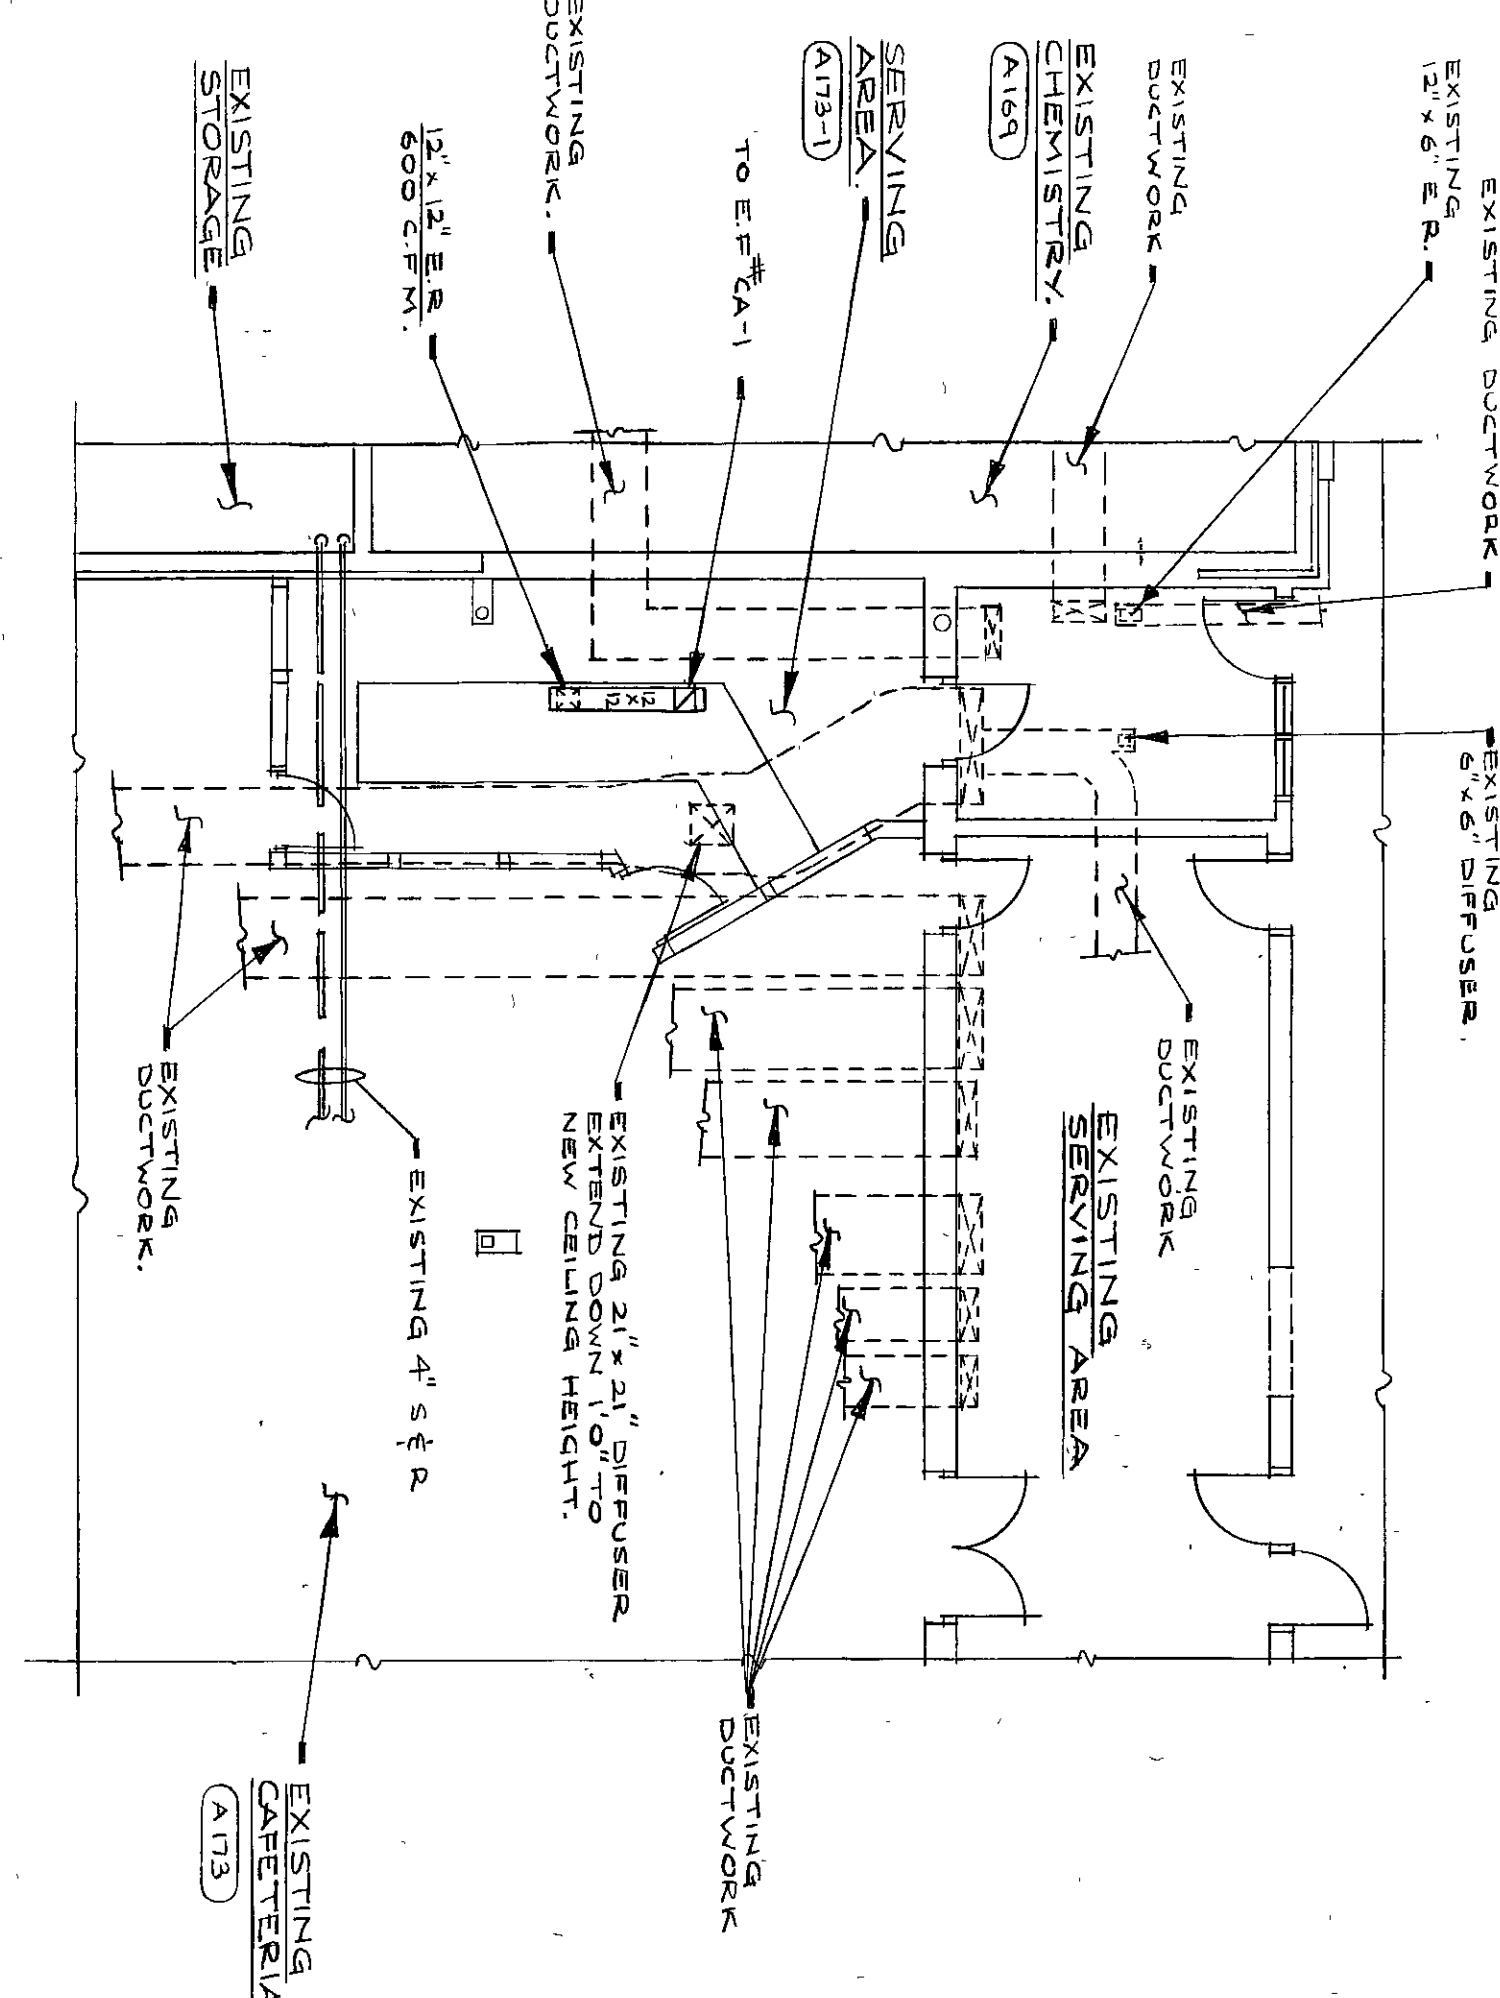

FIRST FLOOR PLAN AREA #4
SCALE: 1/8" = 1'-0"

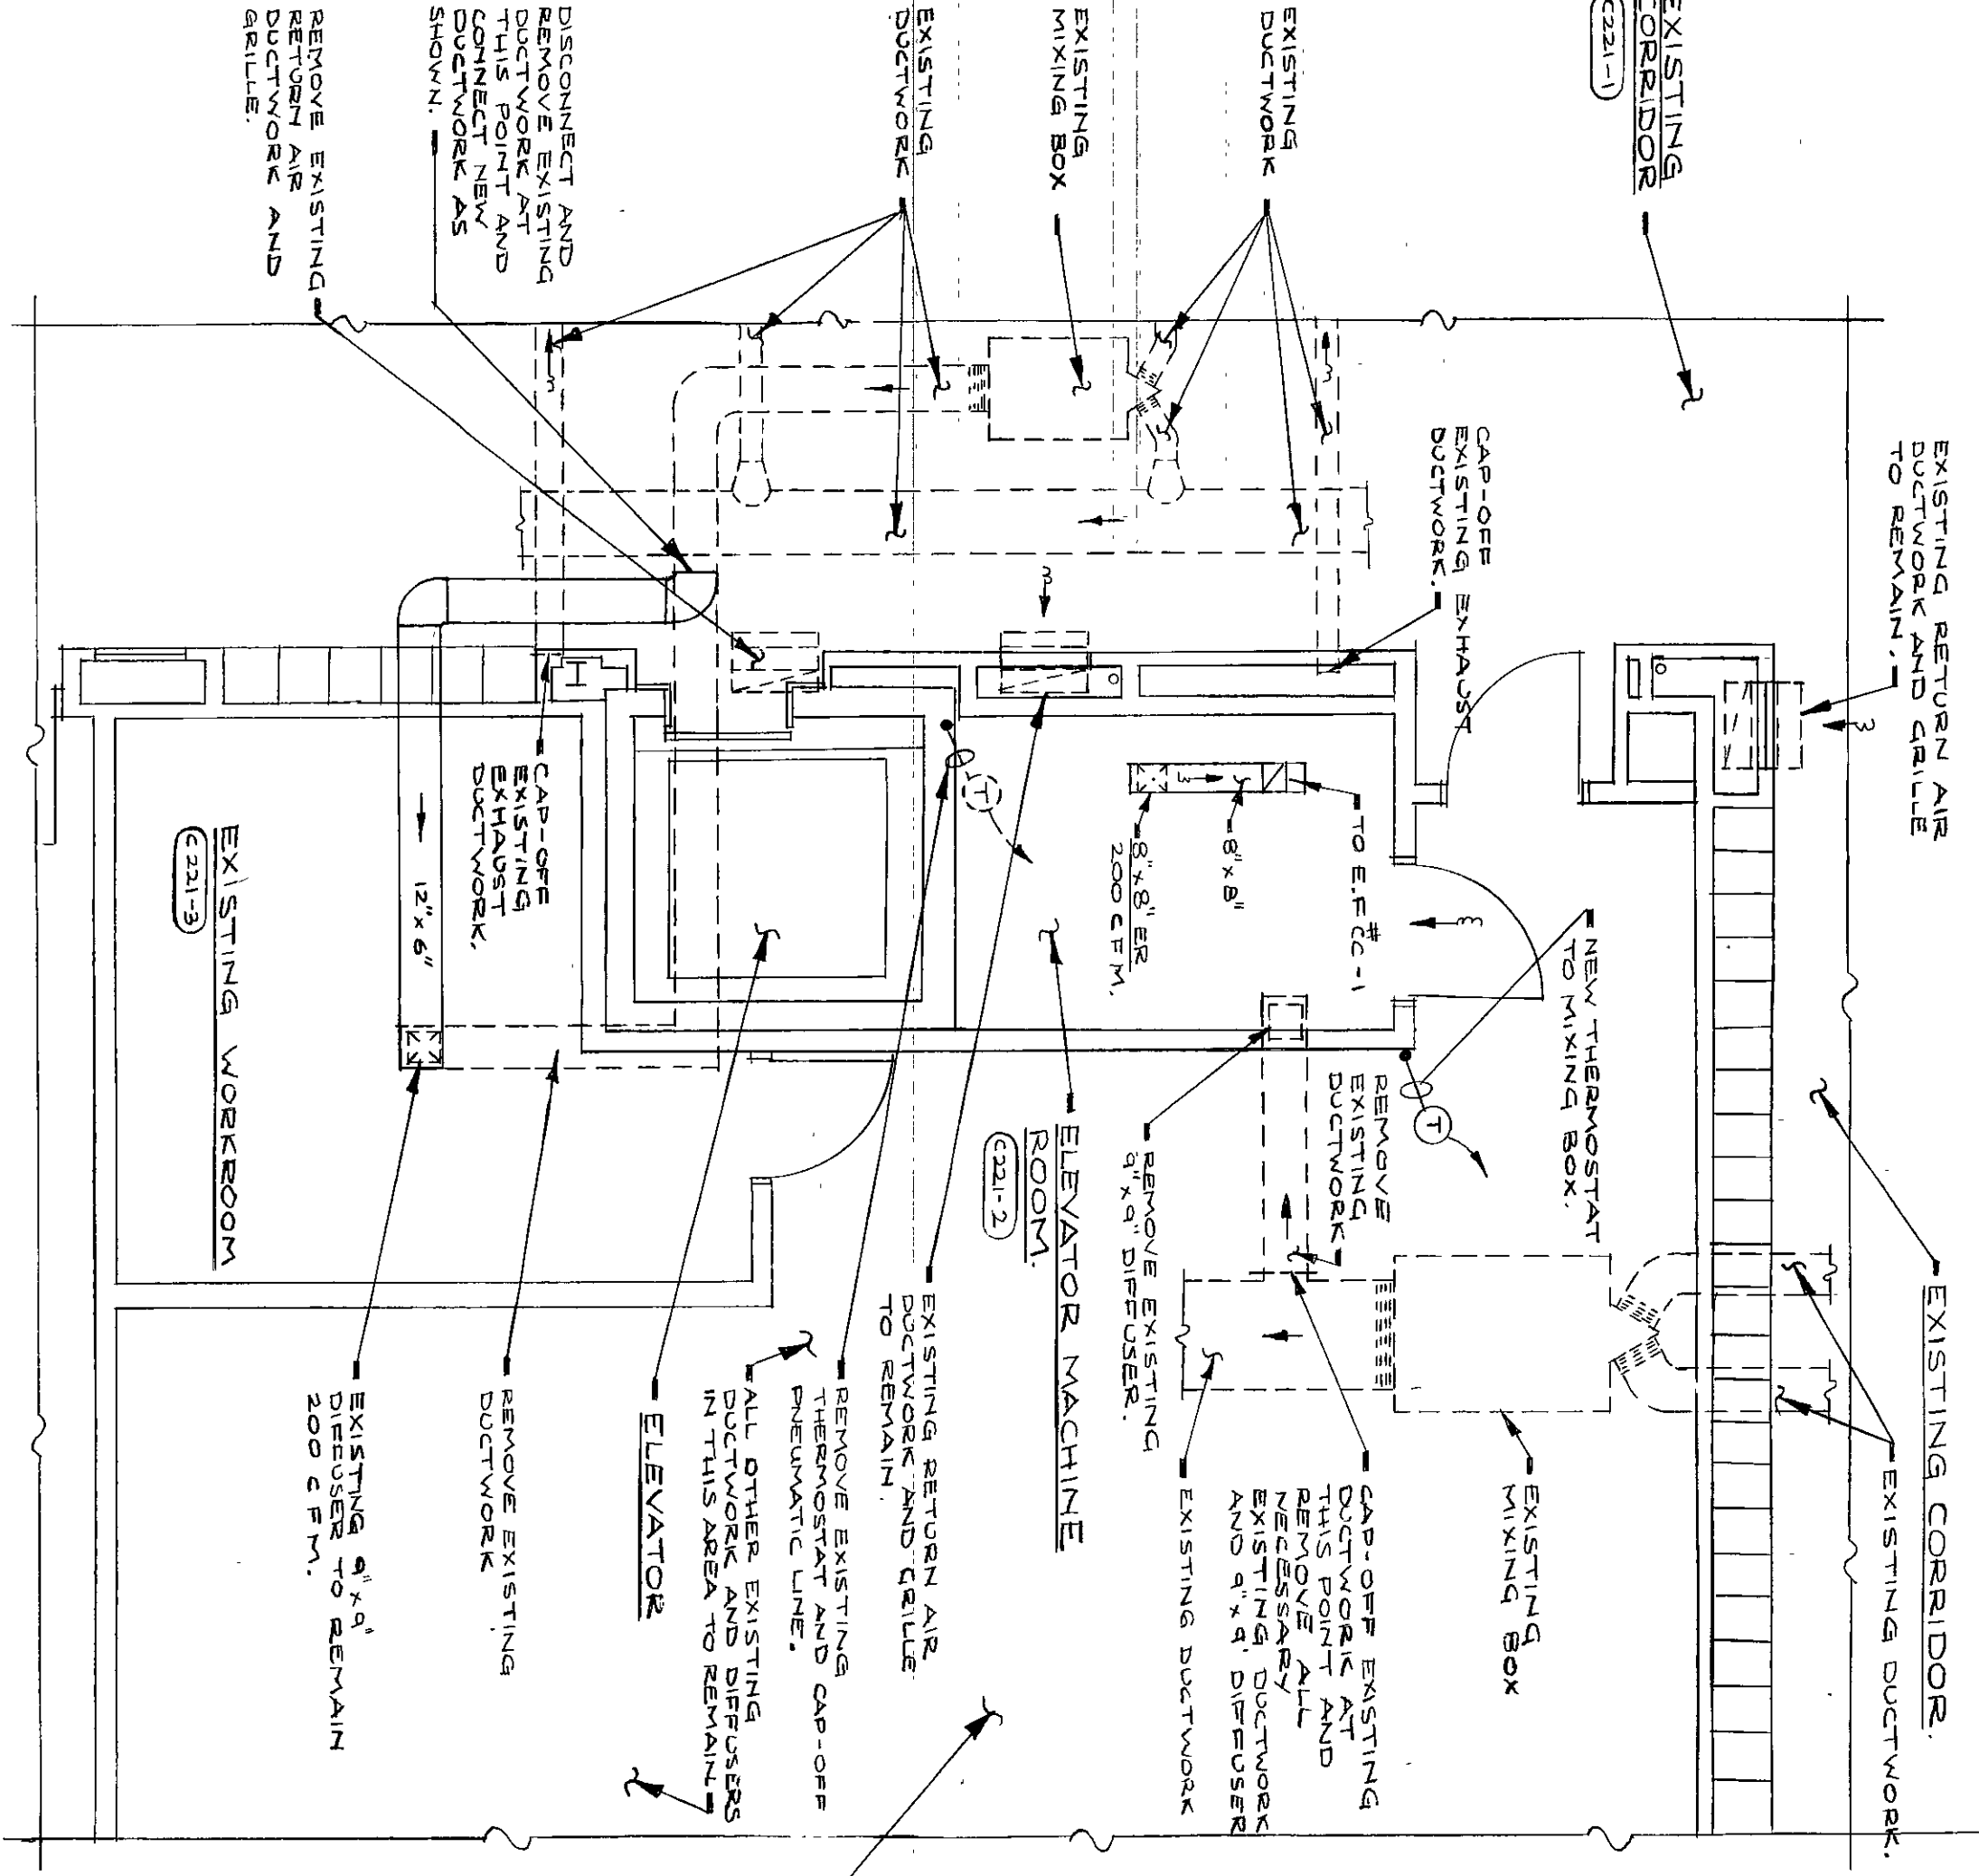

SECOND FLOOR ELEVATOR PLAN AREA #1
SCALE: 1/8" = 1'-0"

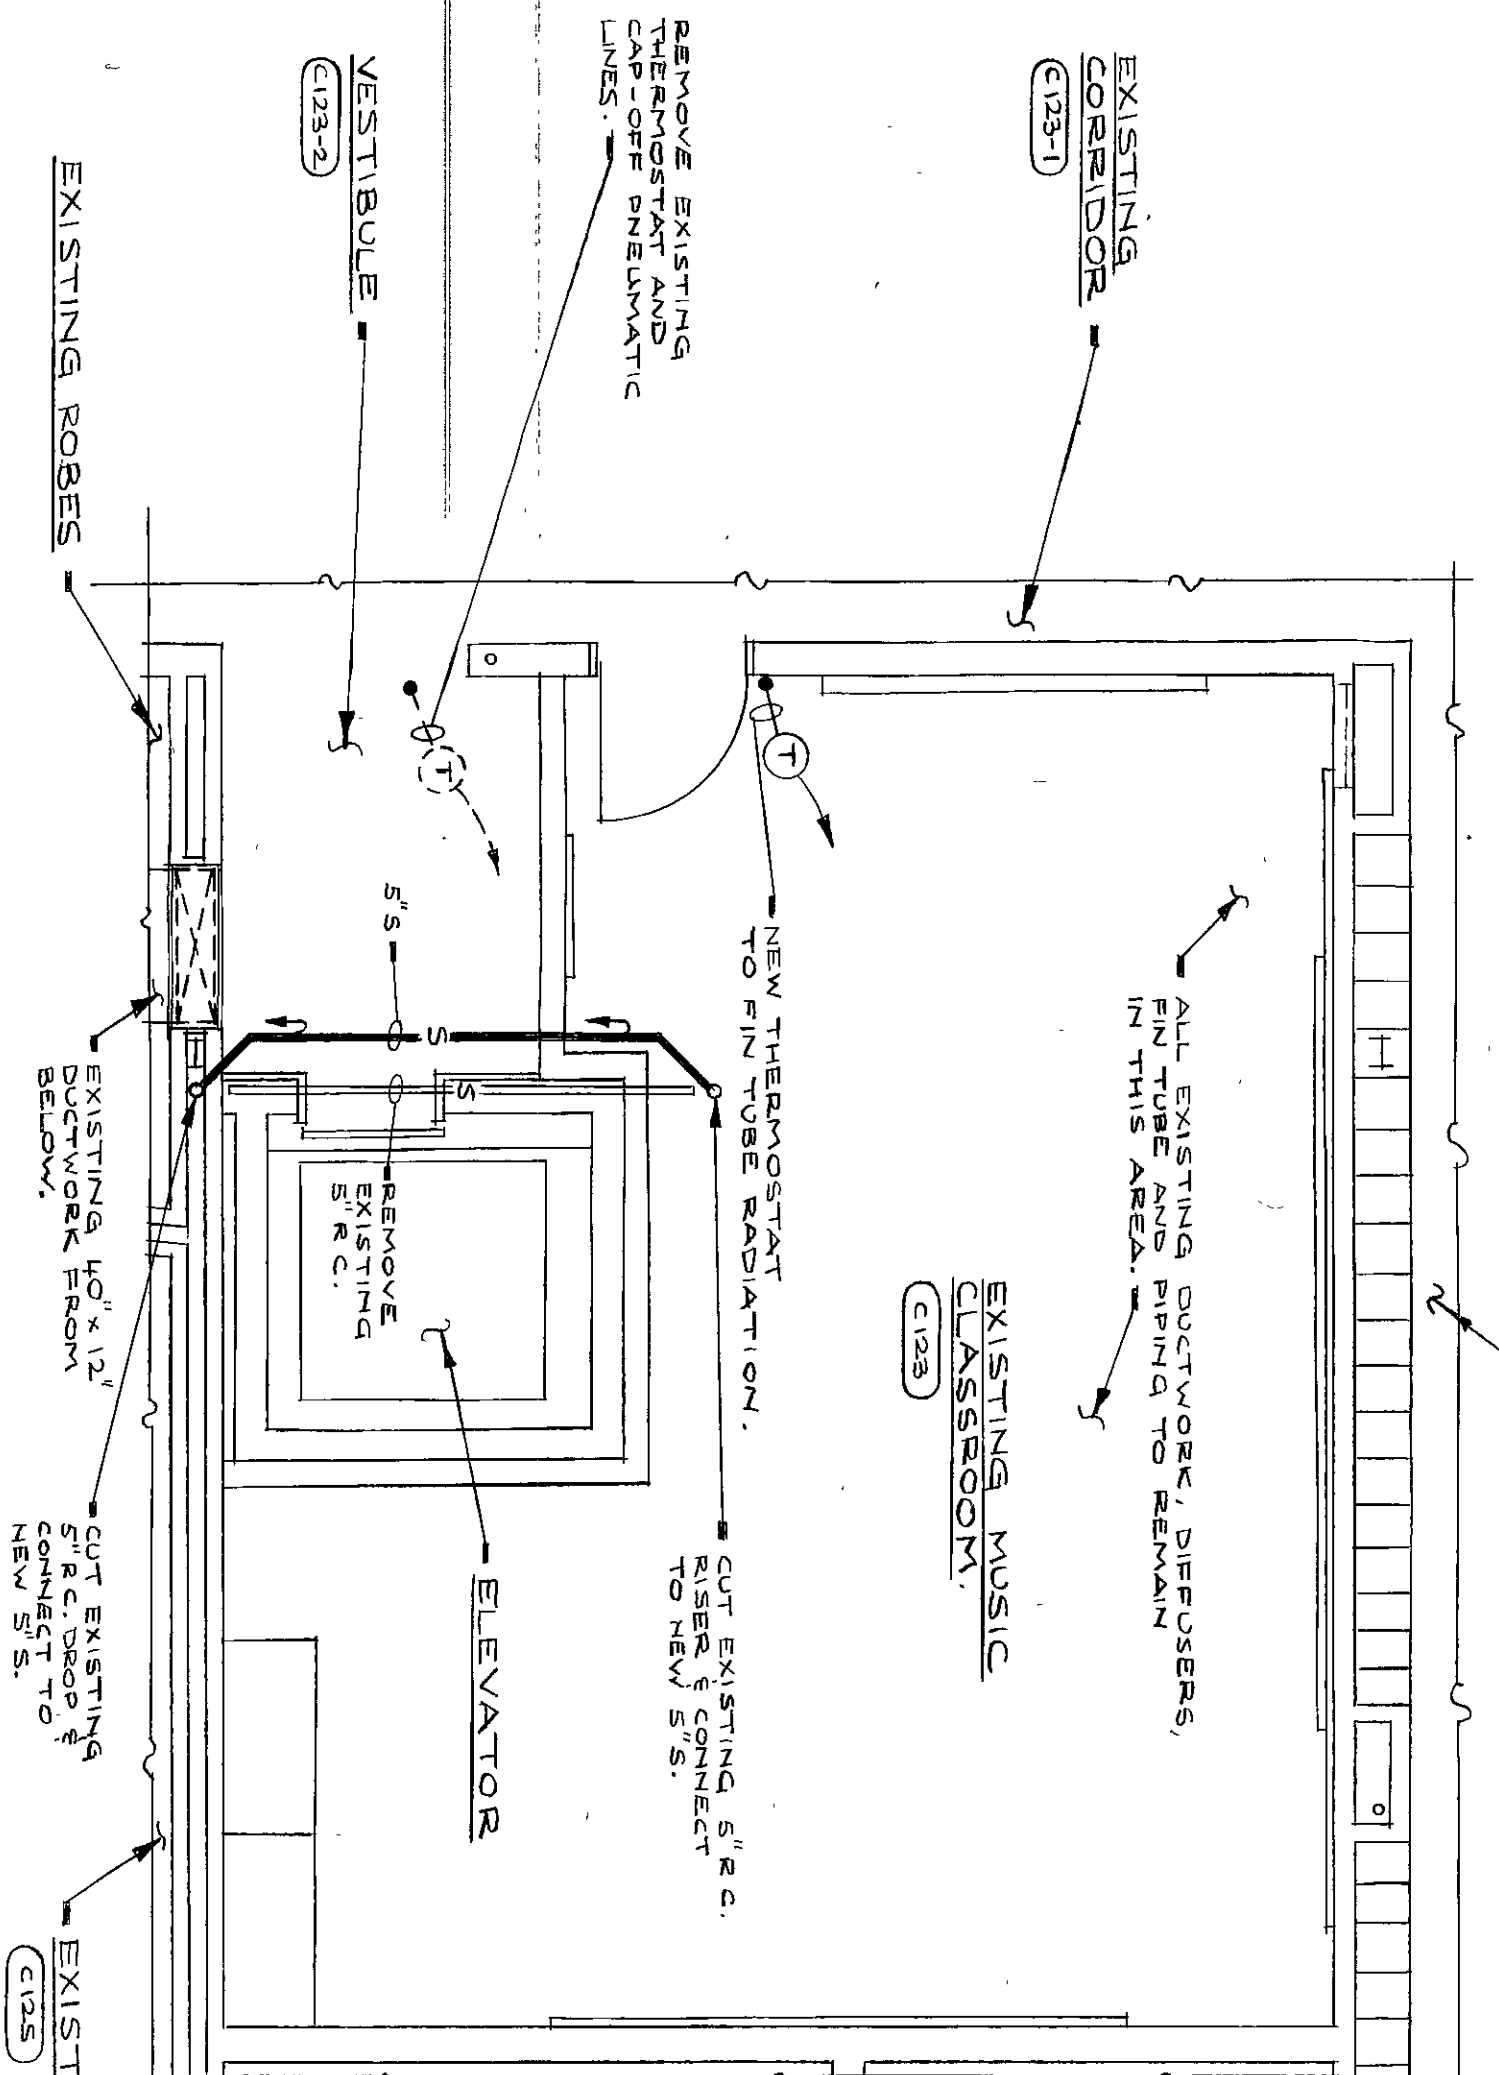

FIRST FLOOR ELEVATOR PLAN AREA #1
SCALE: 1/8" = 1'-0"