



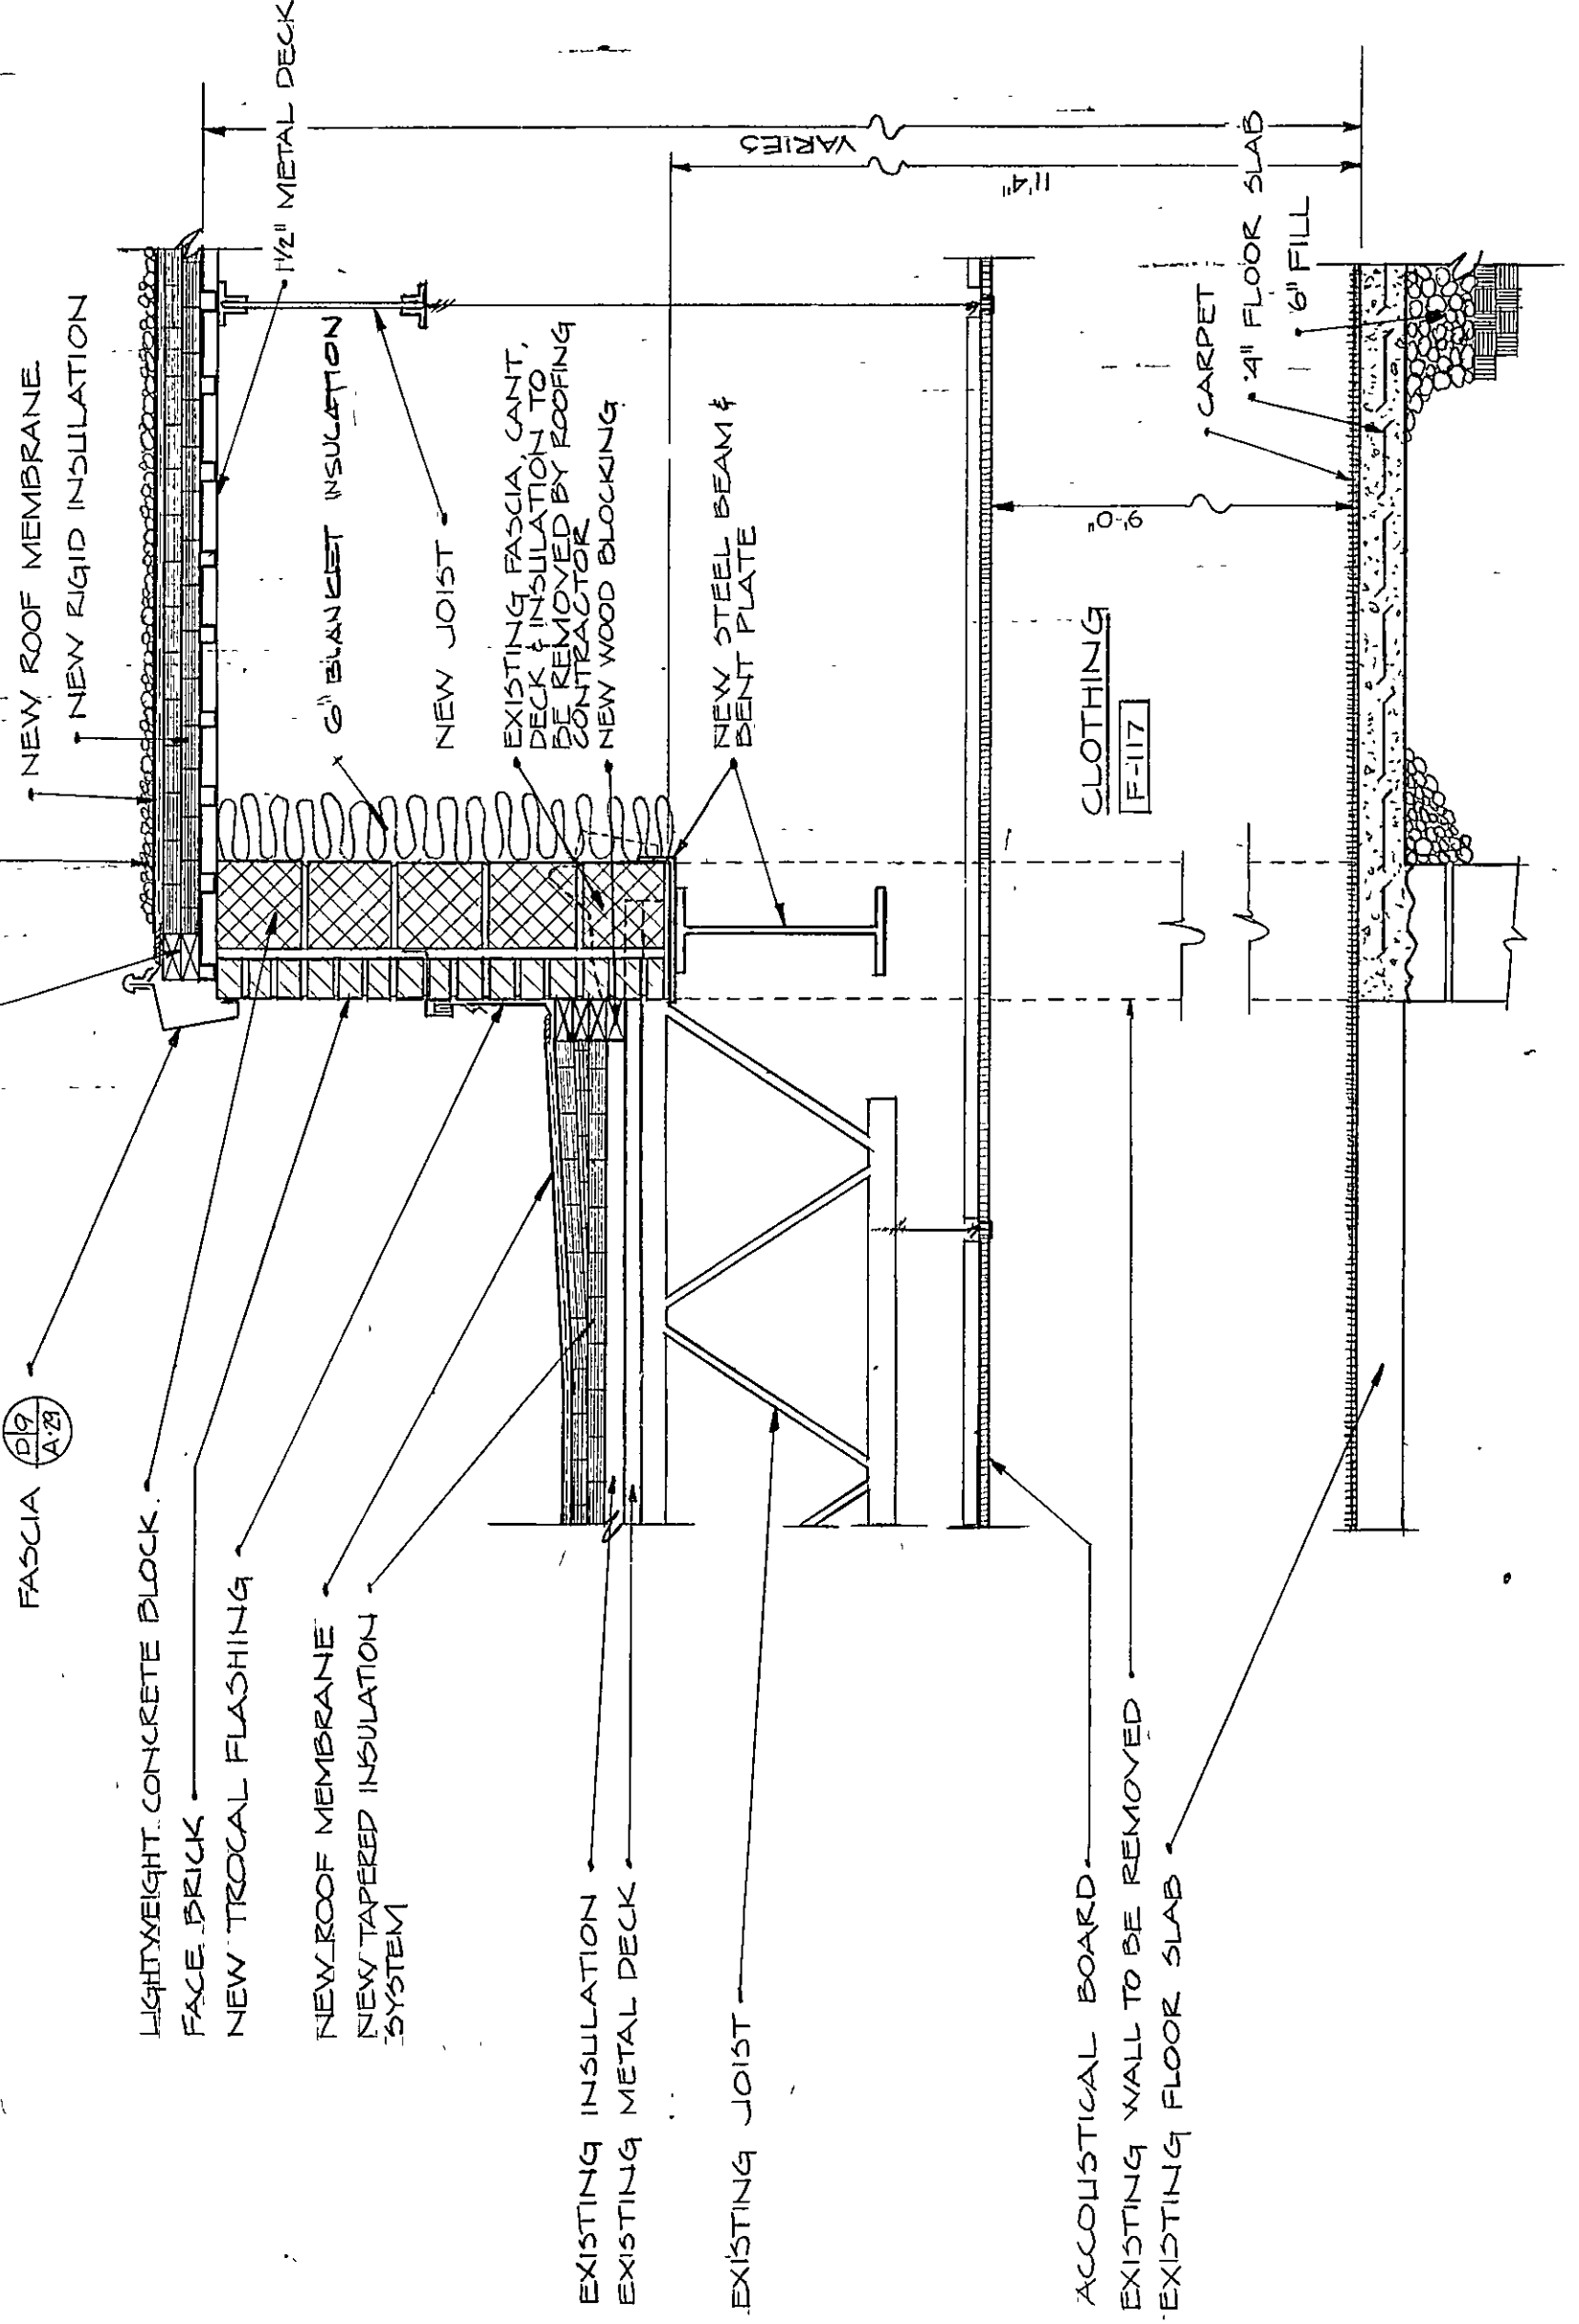


SECTION 32
SCALE: 3/4" = 1'-0"

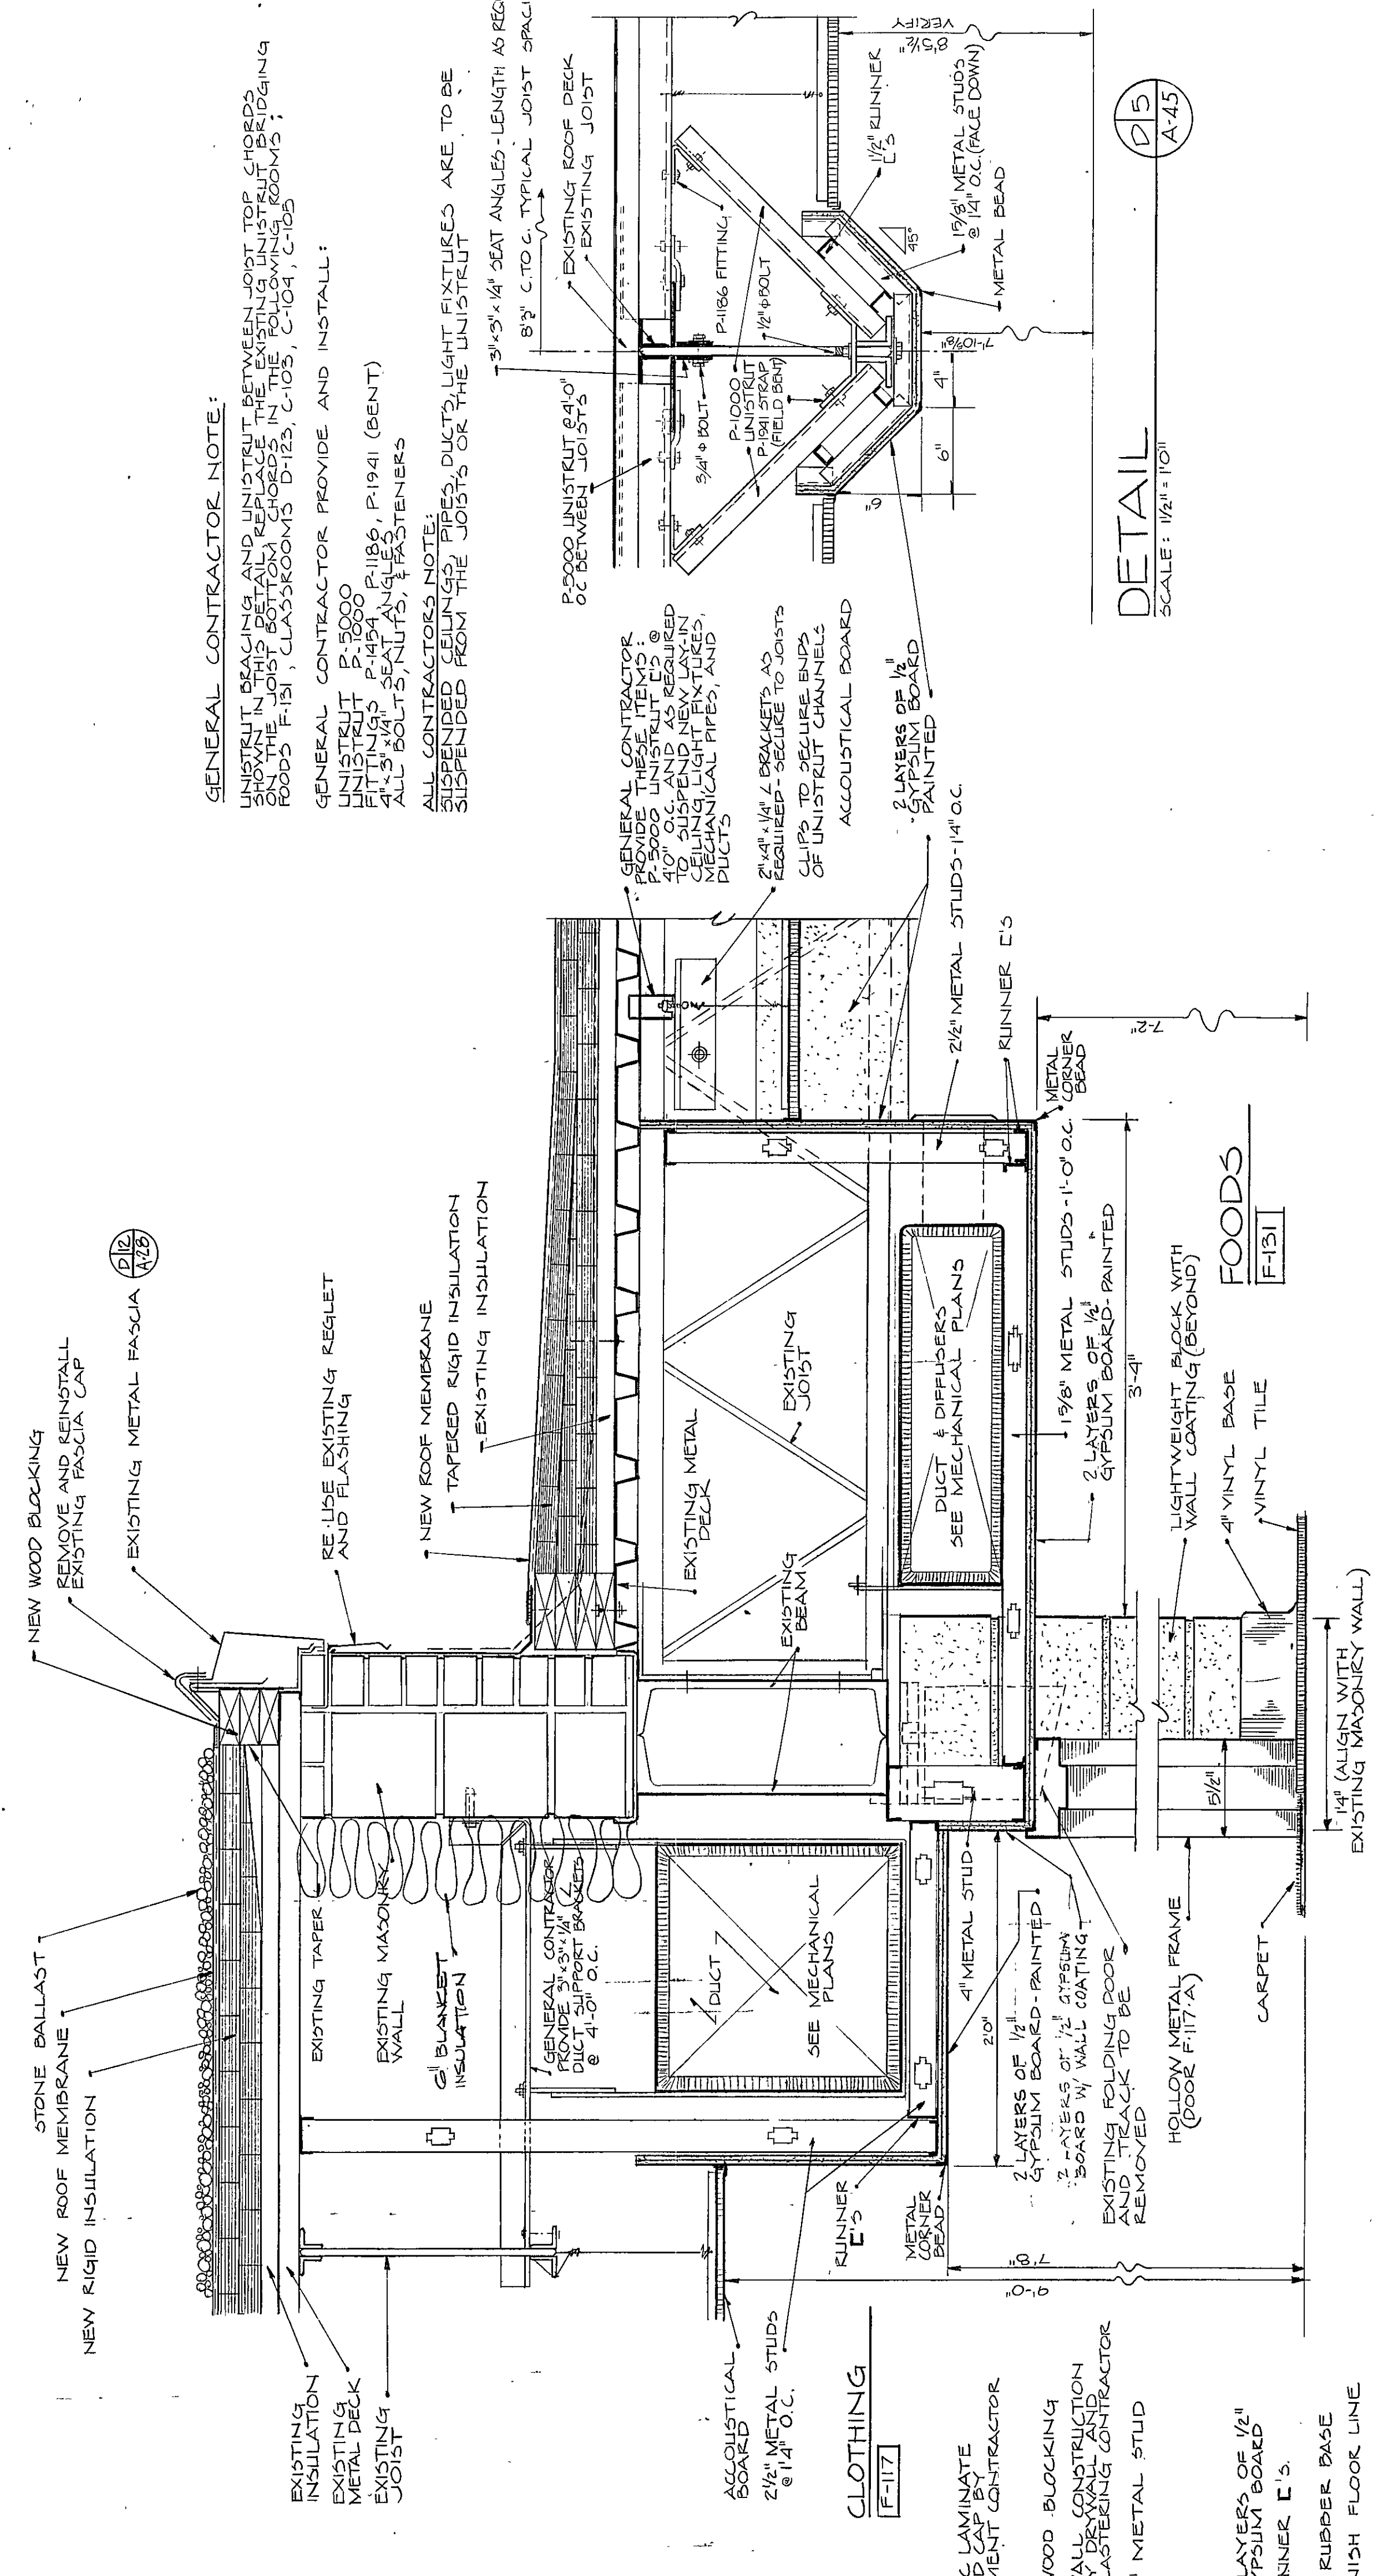


SECTION 31
SCALE: 1/2" = 1'-0"



DETAIL D16
SCALE: 1" = 1'-0"

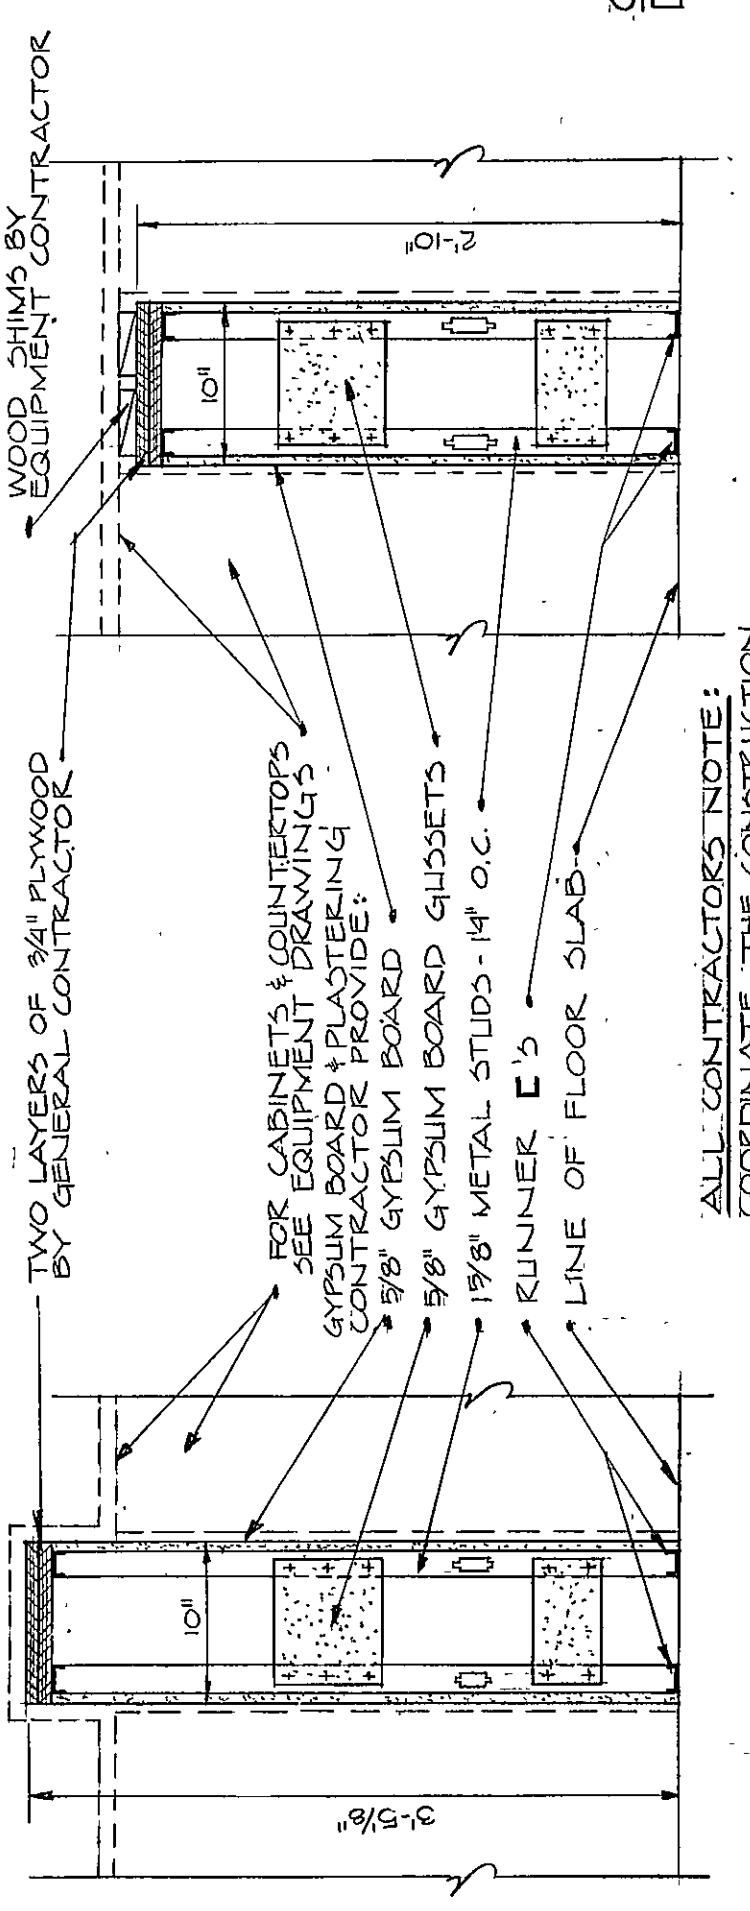


DETAIL D17
SCALE: 1" = 1'-0"

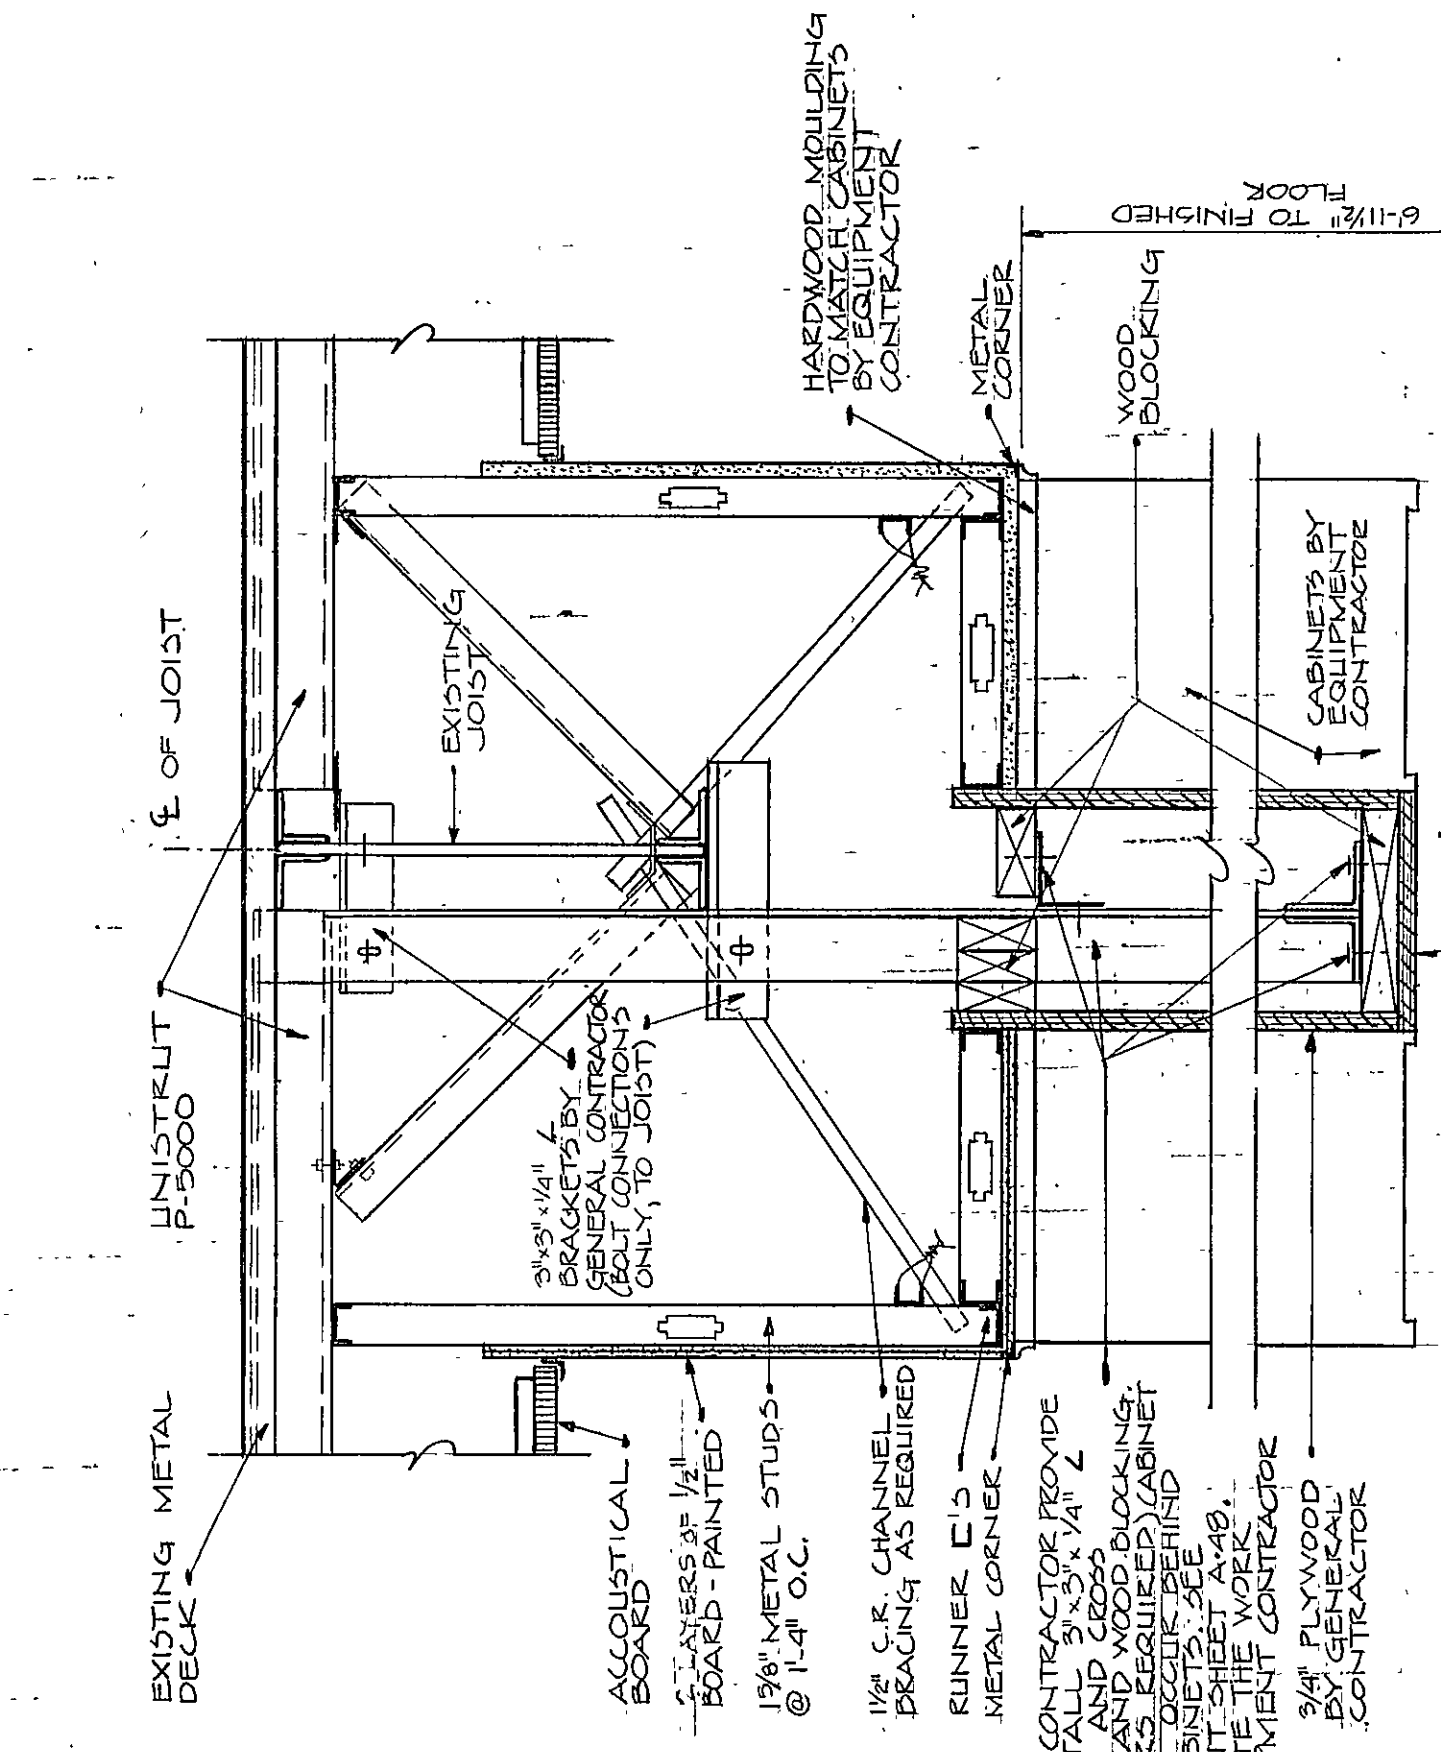

DETAIL D19
SCALE: 1/2" = 1'-0"

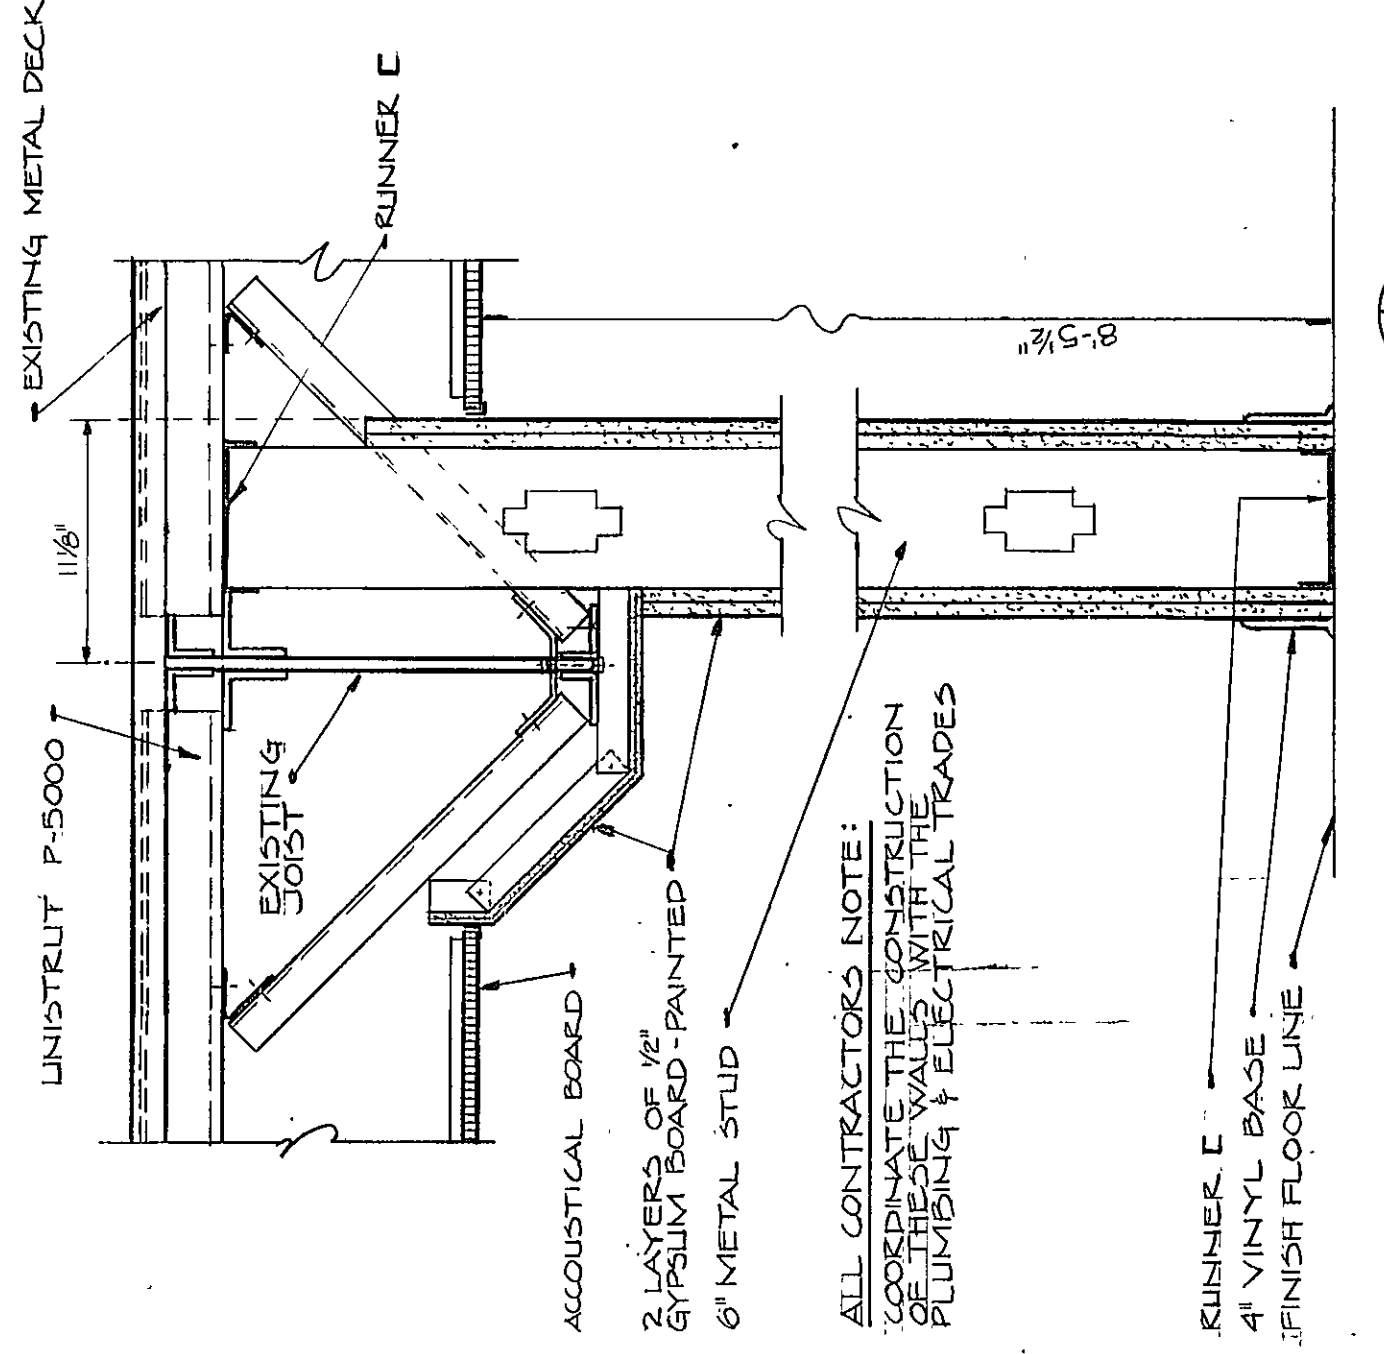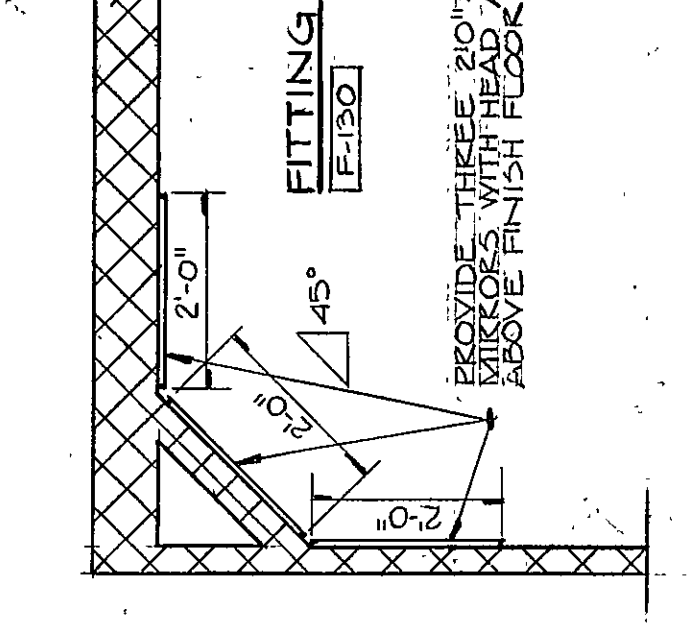

DETAIL D12
SCALE: 1/2" = 1'-0"

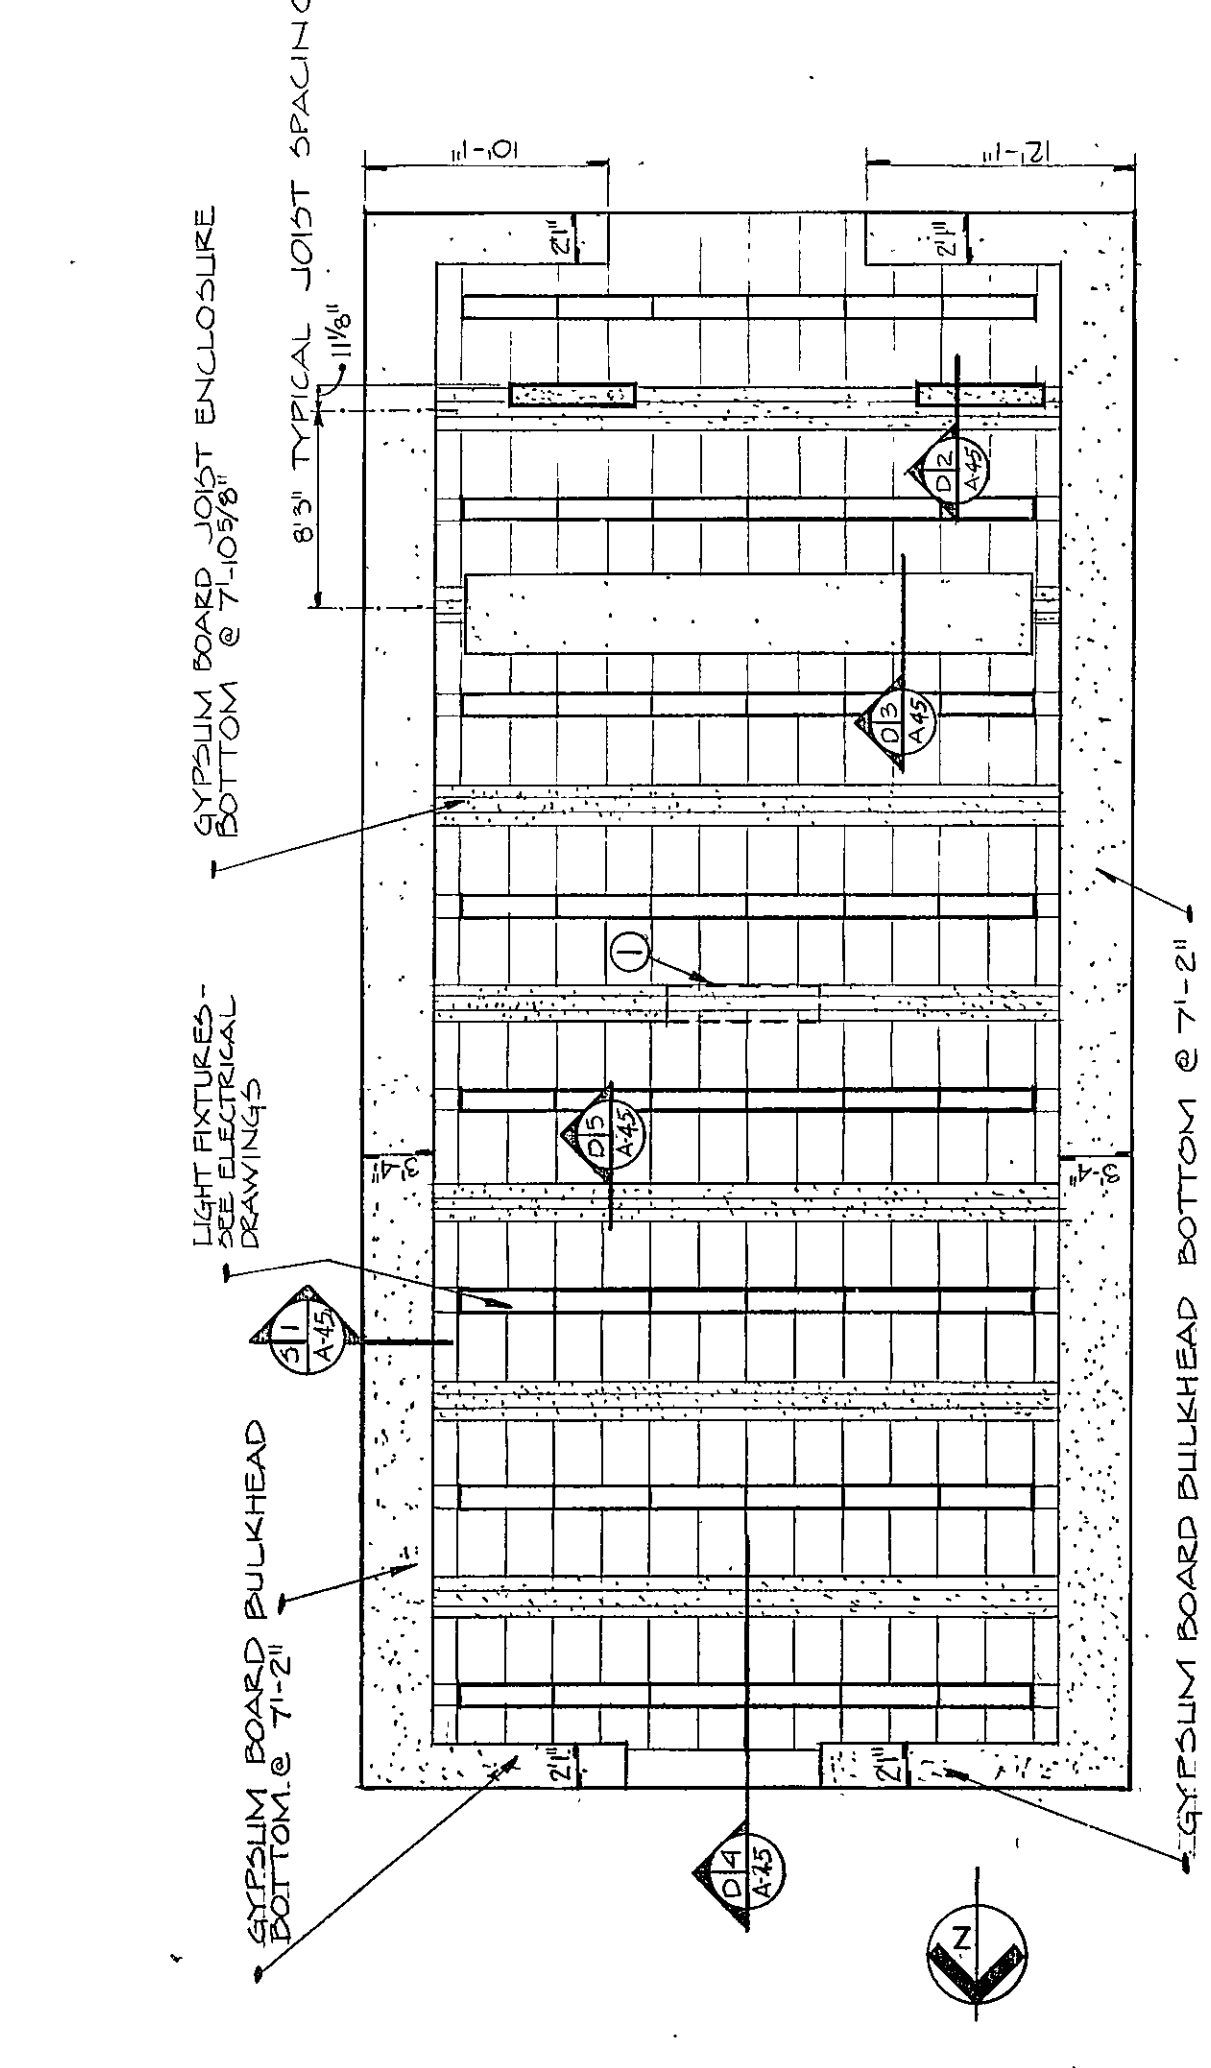

REFLECTED CEILING PLAN
SCALE: 1/8" = 1'-0"

GENERAL CONTRACTOR NOTE:
UNISTRUT BRACING AND UNISTRUT BETWEEN JOIST TOP CHORDS
SHOW THE JOIST DETAILS EXPOSED IN THE EXISTING UNISTRUT BRACING
ROOMS F-131, CLASSROOMS D-183, C-105, C-104, C-106

GENERAL CONTRACTOR PROVIDE AND INSTALL:
UNISTRUT P-5000
HANGERS P-4900 P-1886 P-1941 (BENT)
4" X 3" METAL STUDS 14" O.C.
ALL CONTRACTORS NOTE:
SUSPENDED CEILING LIGHT FIXTURES ARE TO BE
SUSPENDED FROM THE JOISTS OR THE UNISTRUT

GENERAL CONTRACTOR PROVIDE AND INSTALL:
UNISTRUT P-5000
HANGERS P-4900 P-1886 P-1941 (BENT)
4" X 3" METAL STUDS 14" O.C.
ALL CONTRACTORS NOTE:
SUSPENDED CEILING LIGHT FIXTURES ARE TO BE
SUSPENDED FROM THE JOISTS OR THE UNISTRUT

GENERAL CONTRACTOR PROVIDE AND INSTALL:
UNISTRUT P-5000
HANGERS P-4900 P-1886 P-1941 (BENT)
4" X 3" METAL STUDS 14" O.C.
ALL CONTRACTORS NOTE:
SUSPENDED CEILING LIGHT FIXTURES ARE TO BE
SUSPENDED FROM THE JOISTS OR THE UNISTRUT

GENERAL CONTRACTOR PROVIDE AND INSTALL:
UNISTRUT P-5000
HANGERS P-4900 P-1886 P-1941 (BENT)
4" X 3" METAL STUDS 14" O.C.
ALL CONTRACTORS NOTE:
SUSPENDED CEILING LIGHT FIXTURES ARE TO BE
SUSPENDED FROM THE JOISTS OR THE UNISTRUT

GENERAL CONTRACTOR PROVIDE AND INSTALL:
UNISTRUT P-5000
HANGERS P-4900 P-1886 P-1941 (BENT)
4" X 3" METAL STUDS 14" O.C.
ALL CONTRACTORS NOTE:
SUSPENDED CEILING LIGHT FIXTURES ARE TO BE
SUSPENDED FROM THE JOISTS OR THE UNISTRUT

GENERAL CONTRACTOR PROVIDE AND INSTALL:
UNISTRUT P-5000
HANGERS P-4900 P-1886 P-1941 (BENT)
4" X 3" METAL STUDS 14" O.C.
ALL CONTRACTORS NOTE:
SUSPENDED CEILING LIGHT FIXTURES ARE TO BE
SUSPENDED FROM THE JOISTS OR THE UNISTRUT

GENERAL CONTRACTOR PROVIDE AND INSTALL:
UNISTRUT P-5000
HANGERS P-4900 P-1886 P-1941 (BENT)
4" X 3" METAL STUDS 14" O.C.
ALL CONTRACTORS NOTE:
SUSPENDED CEILING LIGHT FIXTURES ARE TO BE
SUSPENDED FROM THE JOISTS OR THE UNISTRUT

GENERAL CONTRACTOR PROVIDE AND INSTALL:
UNISTRUT P-5000
HANGERS P-4900 P-1886 P-1941 (BENT)
4" X 3" METAL STUDS 14" O.C.
ALL CONTRACTORS NOTE:
SUSPENDED CEILING LIGHT FIXTURES ARE TO BE
SUSPENDED FROM THE JOISTS OR THE UNISTRUT

GENERAL CONTRACTOR PROVIDE AND INSTALL:
UNISTRUT P-5000
HANGERS P-4900 P-1886 P-1941 (BENT)
4" X 3" METAL STUDS 14" O.C.
ALL CONTRACTORS NOTE:
SUSPENDED CEILING LIGHT FIXTURES ARE TO BE
SUSPENDED FROM THE JOISTS OR THE UNISTRUT

GENERAL CONTRACTOR PROVIDE AND INSTALL:
UNISTRUT P-5000
HANGERS P-4900 P-1886 P-1941 (BENT)
4" X 3" METAL STUDS 14" O.C.
ALL CONTRACTORS NOTE:
SUSPENDED CEILING LIGHT FIXTURES ARE TO BE
SUSPENDED FROM THE JOISTS OR THE UNISTRUT

GENERAL CONTRACTOR PROVIDE AND INSTALL:
UNISTRUT P-5000
HANGERS P-4900 P-1886 P-1941 (BENT)
4" X 3" METAL STUDS 14" O.C.
ALL CONTRACTORS NOTE:
SUSPENDED CEILING LIGHT FIXTURES ARE TO BE
SUSPENDED FROM THE JOISTS OR THE UNISTRUT

GENERAL CONTRACTOR PROVIDE AND INSTALL:
UNISTRUT P-5000
HANGERS P-4900 P-1886 P-1941 (BENT)
4" X 3" METAL STUDS 14" O.C.
ALL CONTRACTORS NOTE:
SUSPENDED CEILING LIGHT FIXTURES ARE TO BE
SUSPENDED FROM THE JOISTS OR THE UNISTRUT

GENERAL CONTRACTOR PROVIDE AND INSTALL:
UNISTRUT P-5000
HANGERS P-4900 P-1886 P-1941 (BENT)
4" X 3" METAL STUDS 14" O.C.
ALL CONTRACTORS NOTE:
SUSPENDED CEILING LIGHT FIXTURES ARE TO BE
SUSPENDED FROM THE JOISTS OR THE UNISTRUT