


SITE PLAN NOTES

1. ELECTRICAL CONTRACTOR SHALL RELOCATE OR REMOVE ANY OR ALL EXISTING SERVICES, POLES, ETC., AS MAY BE REQUIRED TO ACCOMMODATE ANY NEW CONSTRUCTION, UNLESS OTHERWISE NOTED.
2. ELECTRICAL CONTRACTOR SHALL BACKFILL THE EXCAVATION FOR ALL CONDUIT RUNS UNDER SIDEWALKS AND PAVED AREAS WITH BANK RUN GRAVEL OR SAND.
3. ALL WORK SHOWN ON THIS SHEET IS NEW AND BY THE ELECTRICAL TRADES, UNLESS OTHERWISE NOTED.
4. ELECTRICAL CONTRACTOR SHALL PAY ALL FEES AND OTHER COSTS NOT BORNE BY THE LOCAL POWER COMPANY TO PROVIDE COMPLETE NEW ELECTRICAL SERVICE.
5. ELECTRICAL CONTRACTOR SHALL PAY ALL FEES AND OTHER COSTS NOT BORNE BY THE LOCAL TELEPHONE COMPANY TO PROVIDE COMPLETE NEW TELEPHONE SERVICE.

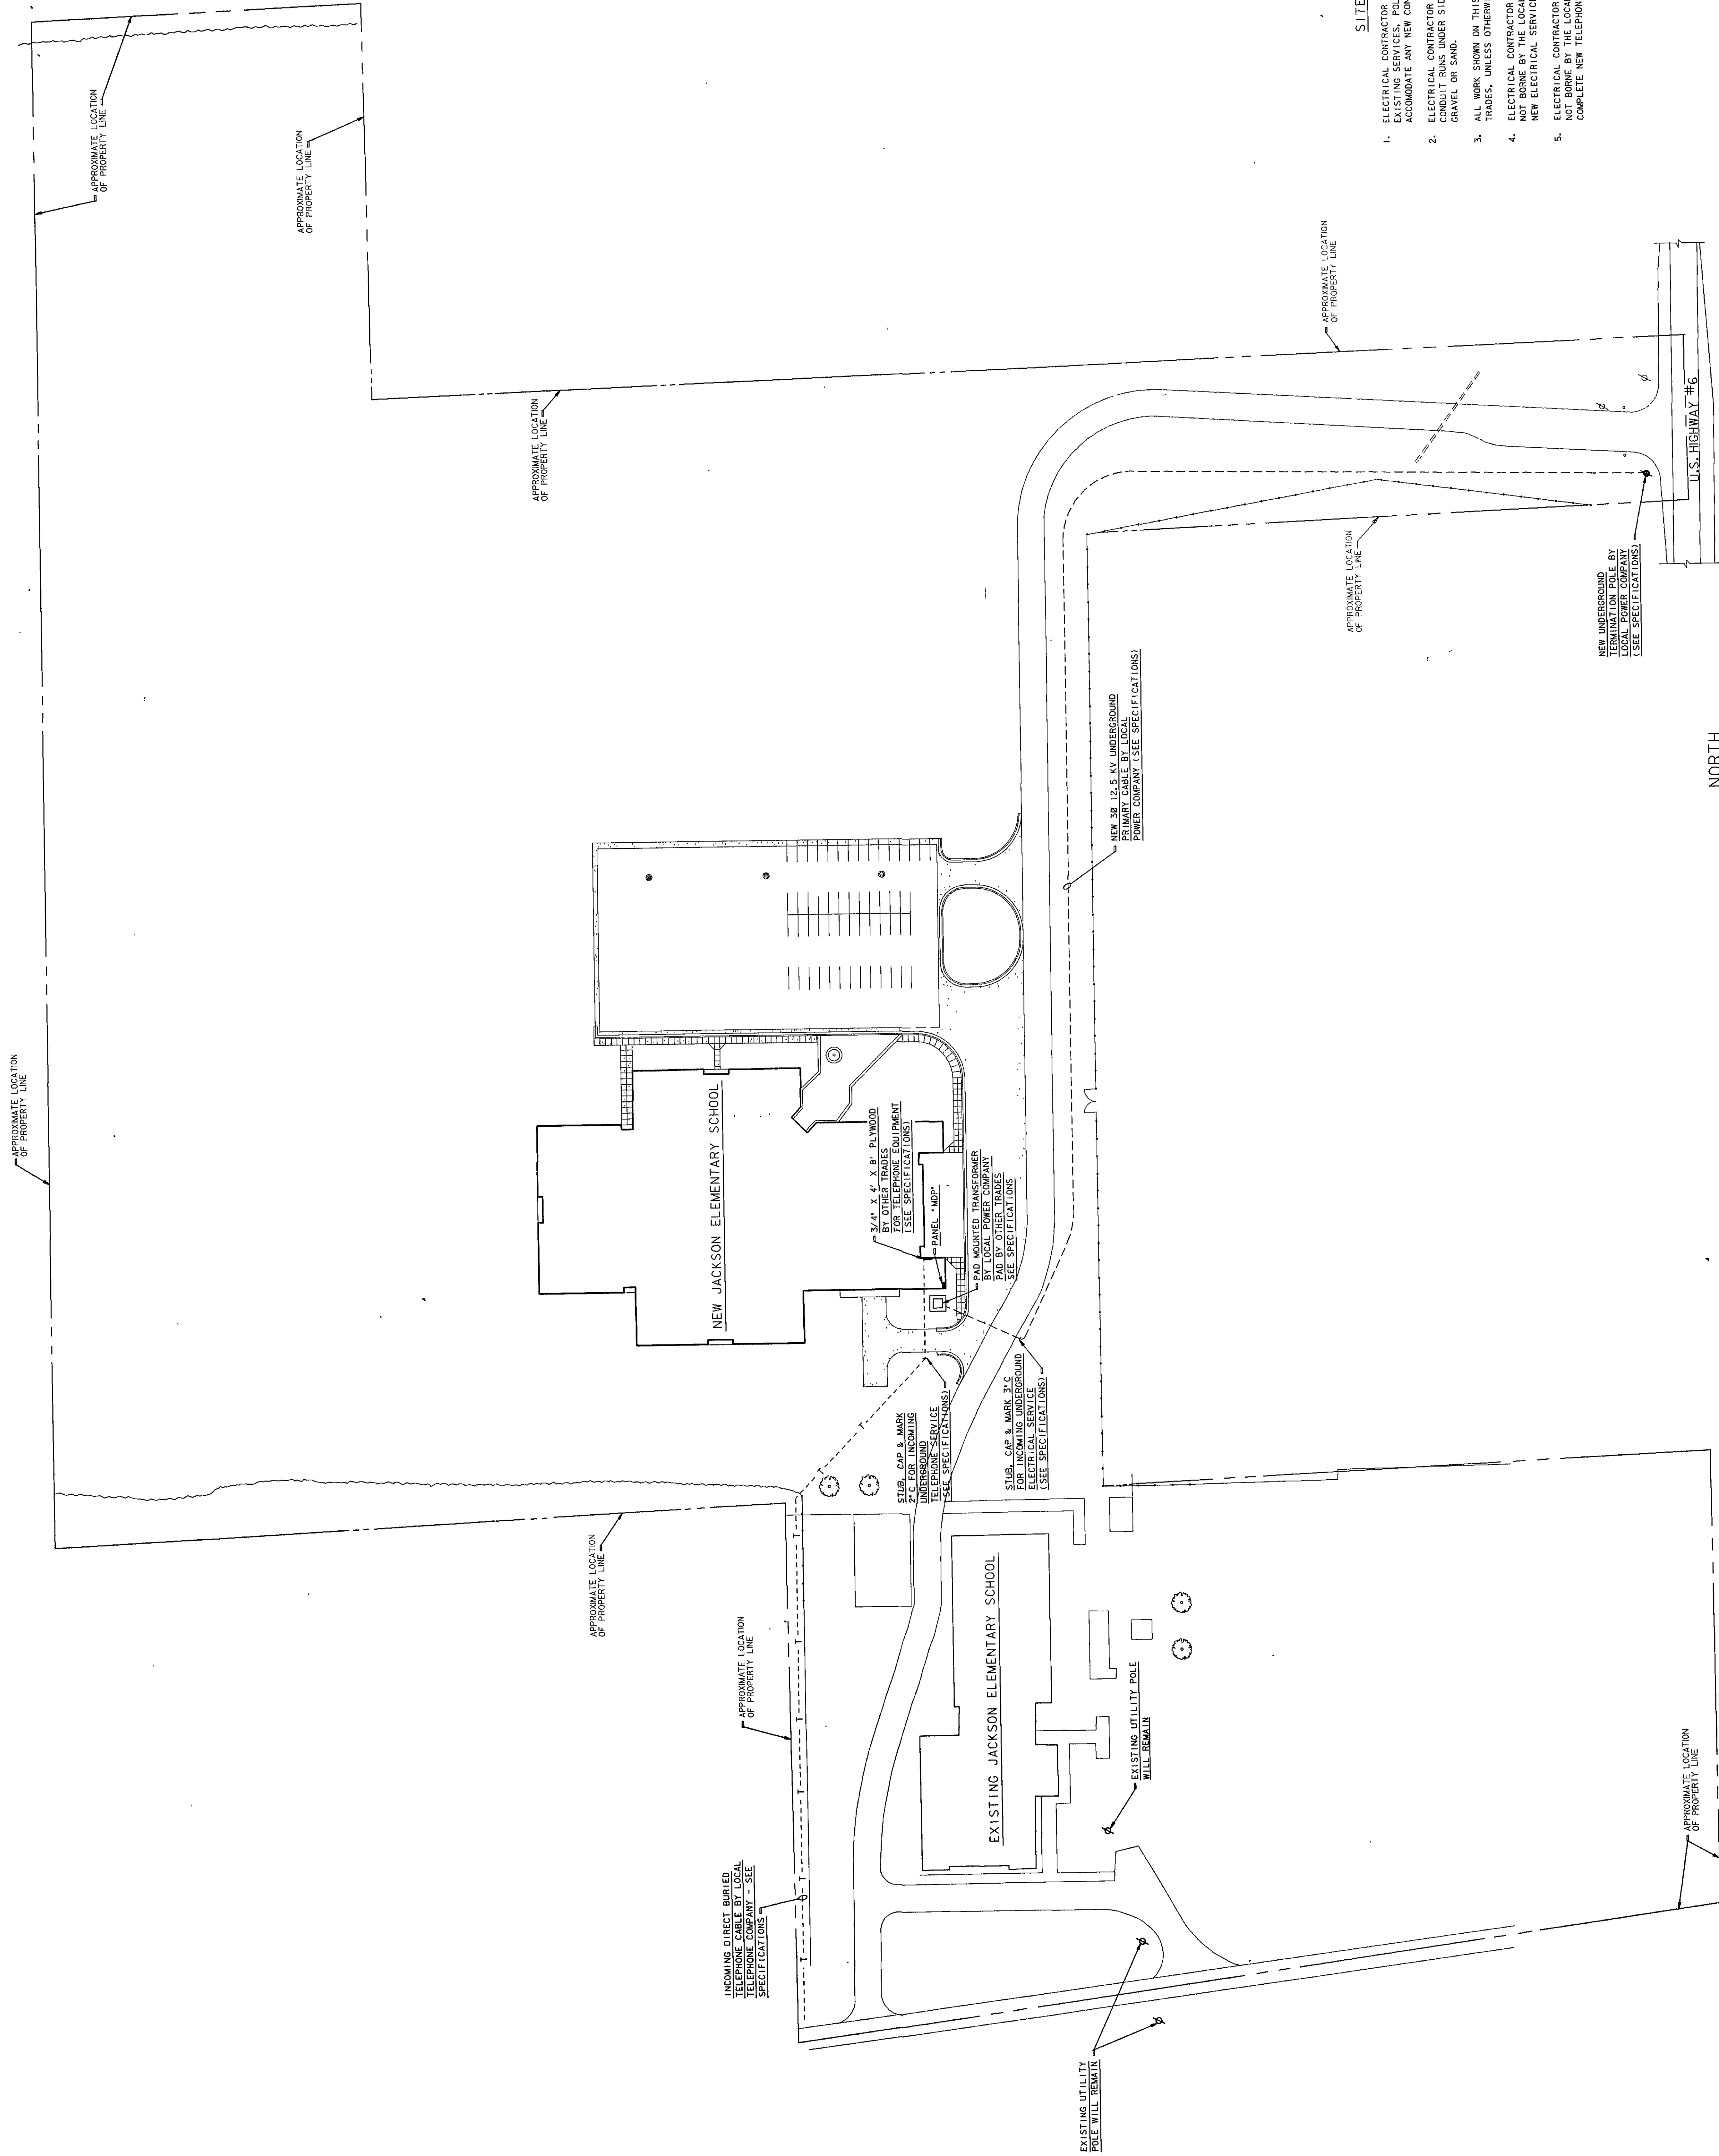

ELECTRICAL SITE PLAN
SCALE: 1"=60'-0"