



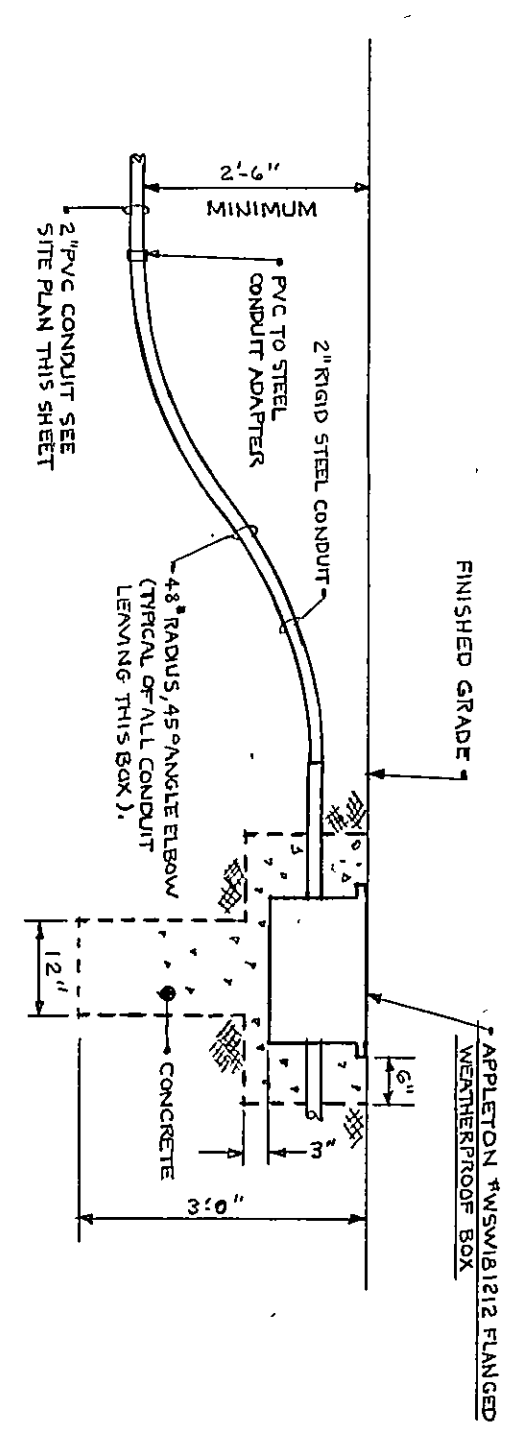


HANDHOLE MOUNTING DETAIL
NO SCALE

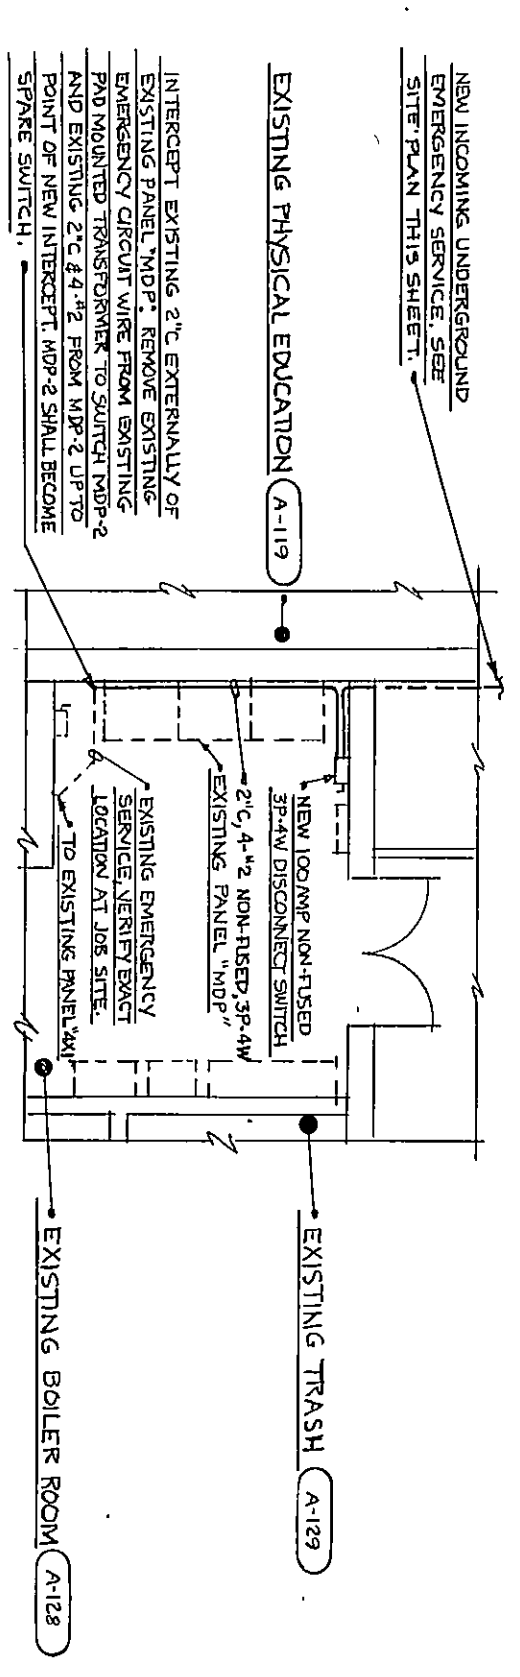

AUXILIARY PLAN A
SCALE: 1/8"=1'-0"

- SEE PLAN NOTES
1. ELECTRICAL CONTRACTOR SHALL RELOCATE OR REMOVE ANY OR ALL EXISTING SERVICES, ROUTES, ETC., AS MAY BE REQUIRED TO ACCOMMODATE THE NEW SERVICES AND EQUIPMENT.
 2. EXISTING SERVICES, ROUTES, ETC., AS MAY BE REQUIRED TO ACCOMMODATE THE NEW SERVICES AND EQUIPMENT, SHALL BE RELOCATED TO THE EXISTING SERVICE CONDUIT AND/OR UNDER EGRESS AND PAVED AREAS WITH BARR AND GRAVEL OR SAND.
 3. ALL WORK SHOWN ON THIS SHEET IS TO BE DONE BY THE ELECTRICAL CONTRACTOR, UNLESS OTHERWISE NOTED.

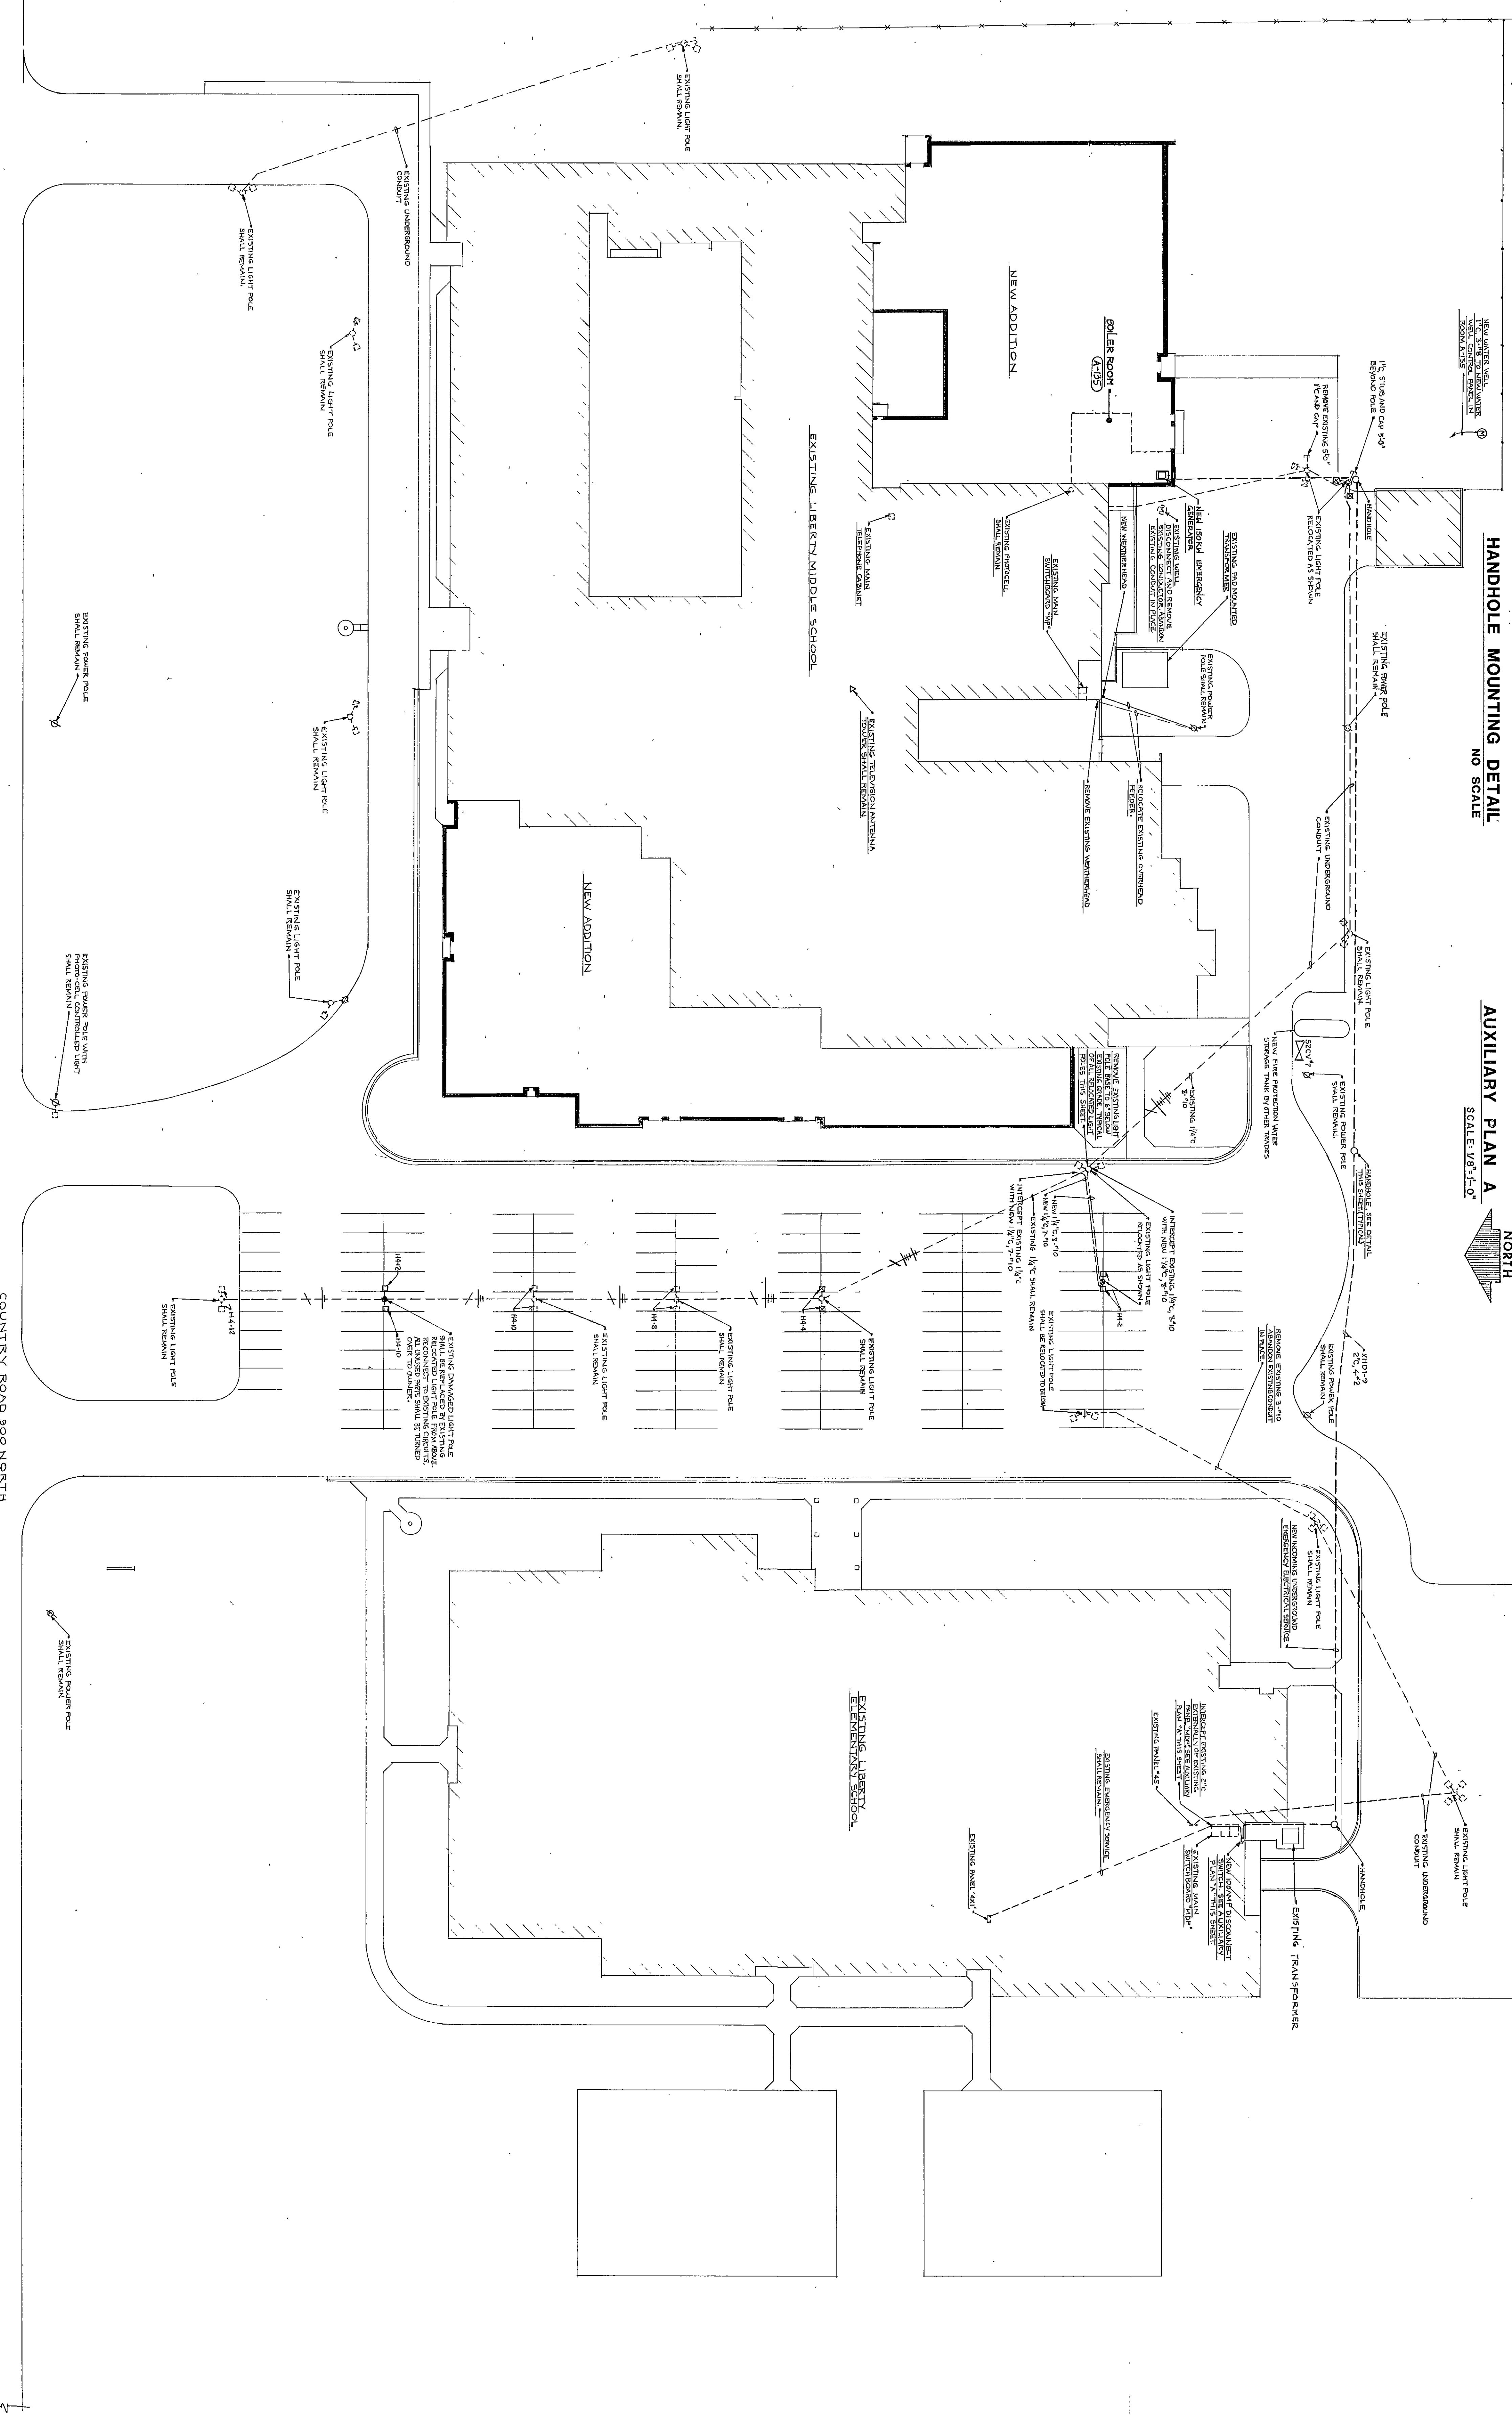

ELECTRICAL SITE PLAN
SCALE: 1\"/>

EVERETT · I · BROWN COMPANY

5500 WEST BRADBURY AVENUE · PARK FLETCHER ·

ADDITION TO AND RENOVATION OF LIBERTY MIDDLE SCHOOL

ARCHITECTS
ENGINEERS
INDIANAPOLIS, INDIANA · 46241

James W. Roberts

JAMES W. ROBERTS
REGISTERED
#8583
STATE OF INDIANA
PROFESSIONAL ENGINEER

PROJECT
12579.00

DATE
MAY 3, 1982

REVISED

NO. E-10
OF 22

PROJECT
12579.00

DATE
MAY 3, 1982

REVISED