



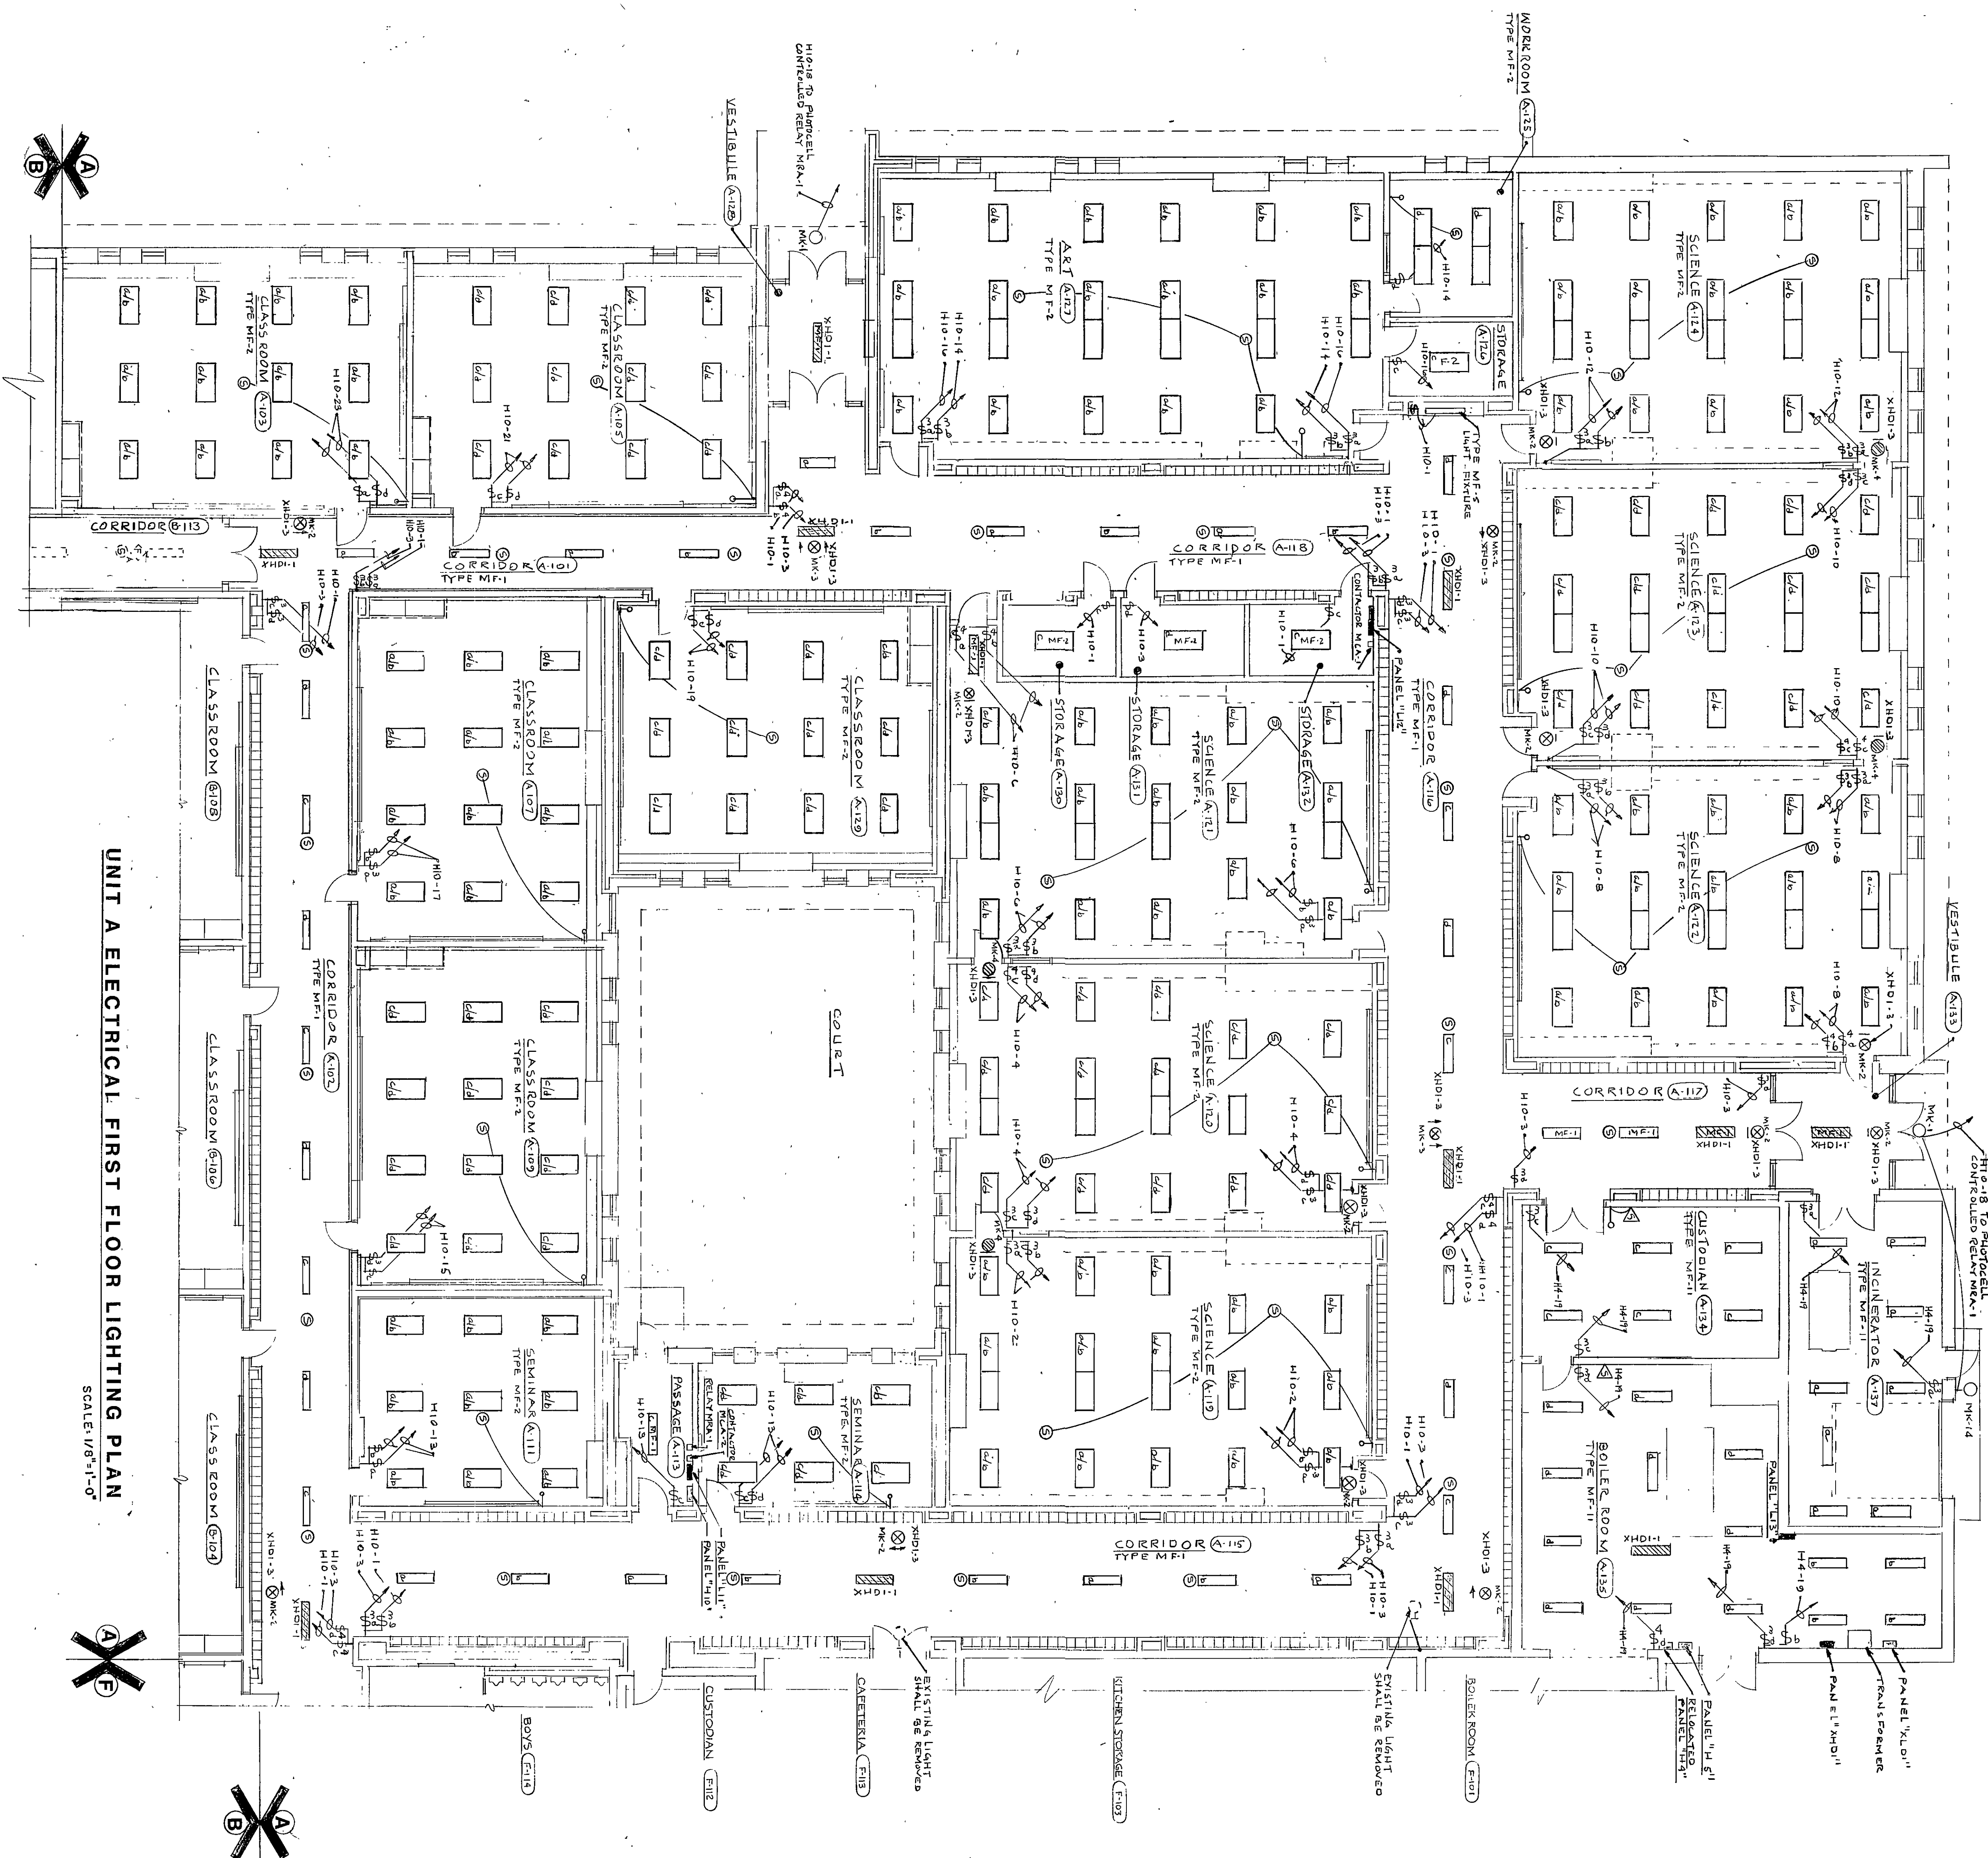

UNIT A ELECTRICAL FIRST FLOOR LIGHTING PLAN
SCALE: 1/8"=1'-0"


- PLAN NOTES
1. SEE SHEET E-10 FOR ELECTRICAL SITE PLAN.
 2. SEE SHEET E-11 FOR ELECTRICAL SYMBOLS, SCHEDULES, DETAILS AND NOTES.
 3. SEE SHEET E-20 FOR ELECTRICAL FIRE ALARM DISTRIBUTION DIAGRAM AND TELEPHONE DISTRIBUTION DIAGRAM.
 4. SEE SHEET E-21 FOR ELECTRICAL TELEVISION DISTRIBUTION DIAGRAM.
 5. SEE SHEET E-22 FOR ELECTRICAL POWER DISTRIBUTION DIAGRAM.
 6. PULSED SWITCHED LIGHT FIXTURES SHALL HAVE THE SINGLE COIL OPERATING AND BE OUTSIDE LAMP(S) CONTROLLED BY THE OTHER SWITCH(ES).

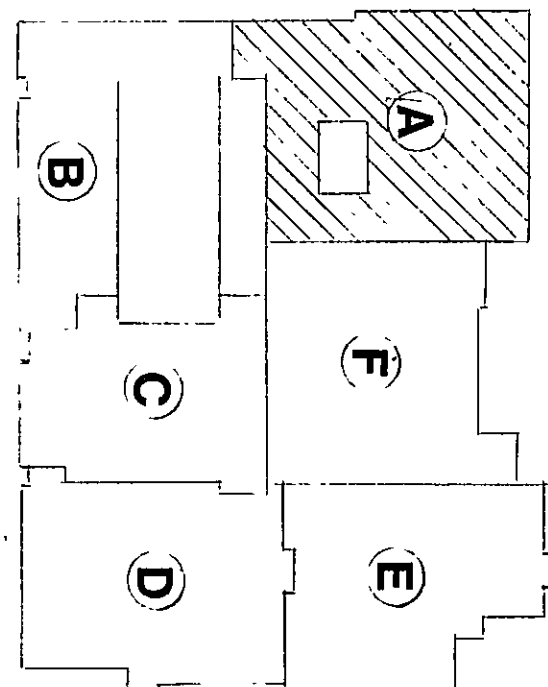

KEY PLAN
NO SCALE

EVERETT · I · BROWN COMPANY
5500 WEST BRADBURY AVENUE · PARK FLETCHER ·
ADDITION TO AND RENOVATION OF LIBERTY MIDDLE SCHOOL

ARCHITECTS
ENGINEERS
INDIANAPOLIS, INDIANA · 46241

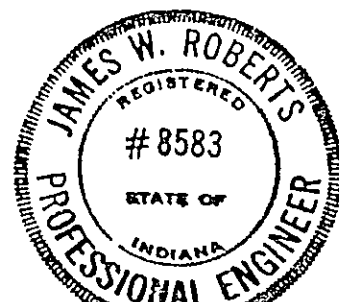

James W. Roberts

PROJECT
12579.0G
DATE
MAY 3, 1982
REVISED

NO. E-12
OF 22

62-6-03