



PLAN NOTES

1. SEE SHEETS E-1 AND E-2 FOR ELECTRICAL SITE PLANS.
2. SEE SHEET E-3 FOR ELECTRICAL SYMBOLS, SCHEDULES, DETAILS AND NOTES.
3. SEE SHEET E-8 FOR ELECTRICAL FIRE ALARM DISTRIBUTION DIAGRAM, TELEPHONE DISTRIBUTION DIAGRAM, AND TELEVISION DISTRIBUTION DIAGRAM.
4. SEE SHEET E-9 FOR ELECTRICAL POWER DISTRIBUTION DIAGRAM AND PANEL SCHEDULES.
5. CONDUIT SHALL BE 1/2" OR 3/4" RIGID PVC OR EMT, UNLESS OTHERWISE NOTED. ALL CONDUIT SHALL BE INSTALLED IN ACCORDANCE WITH THE NATIONAL ELECTRICAL CODE (NEC).

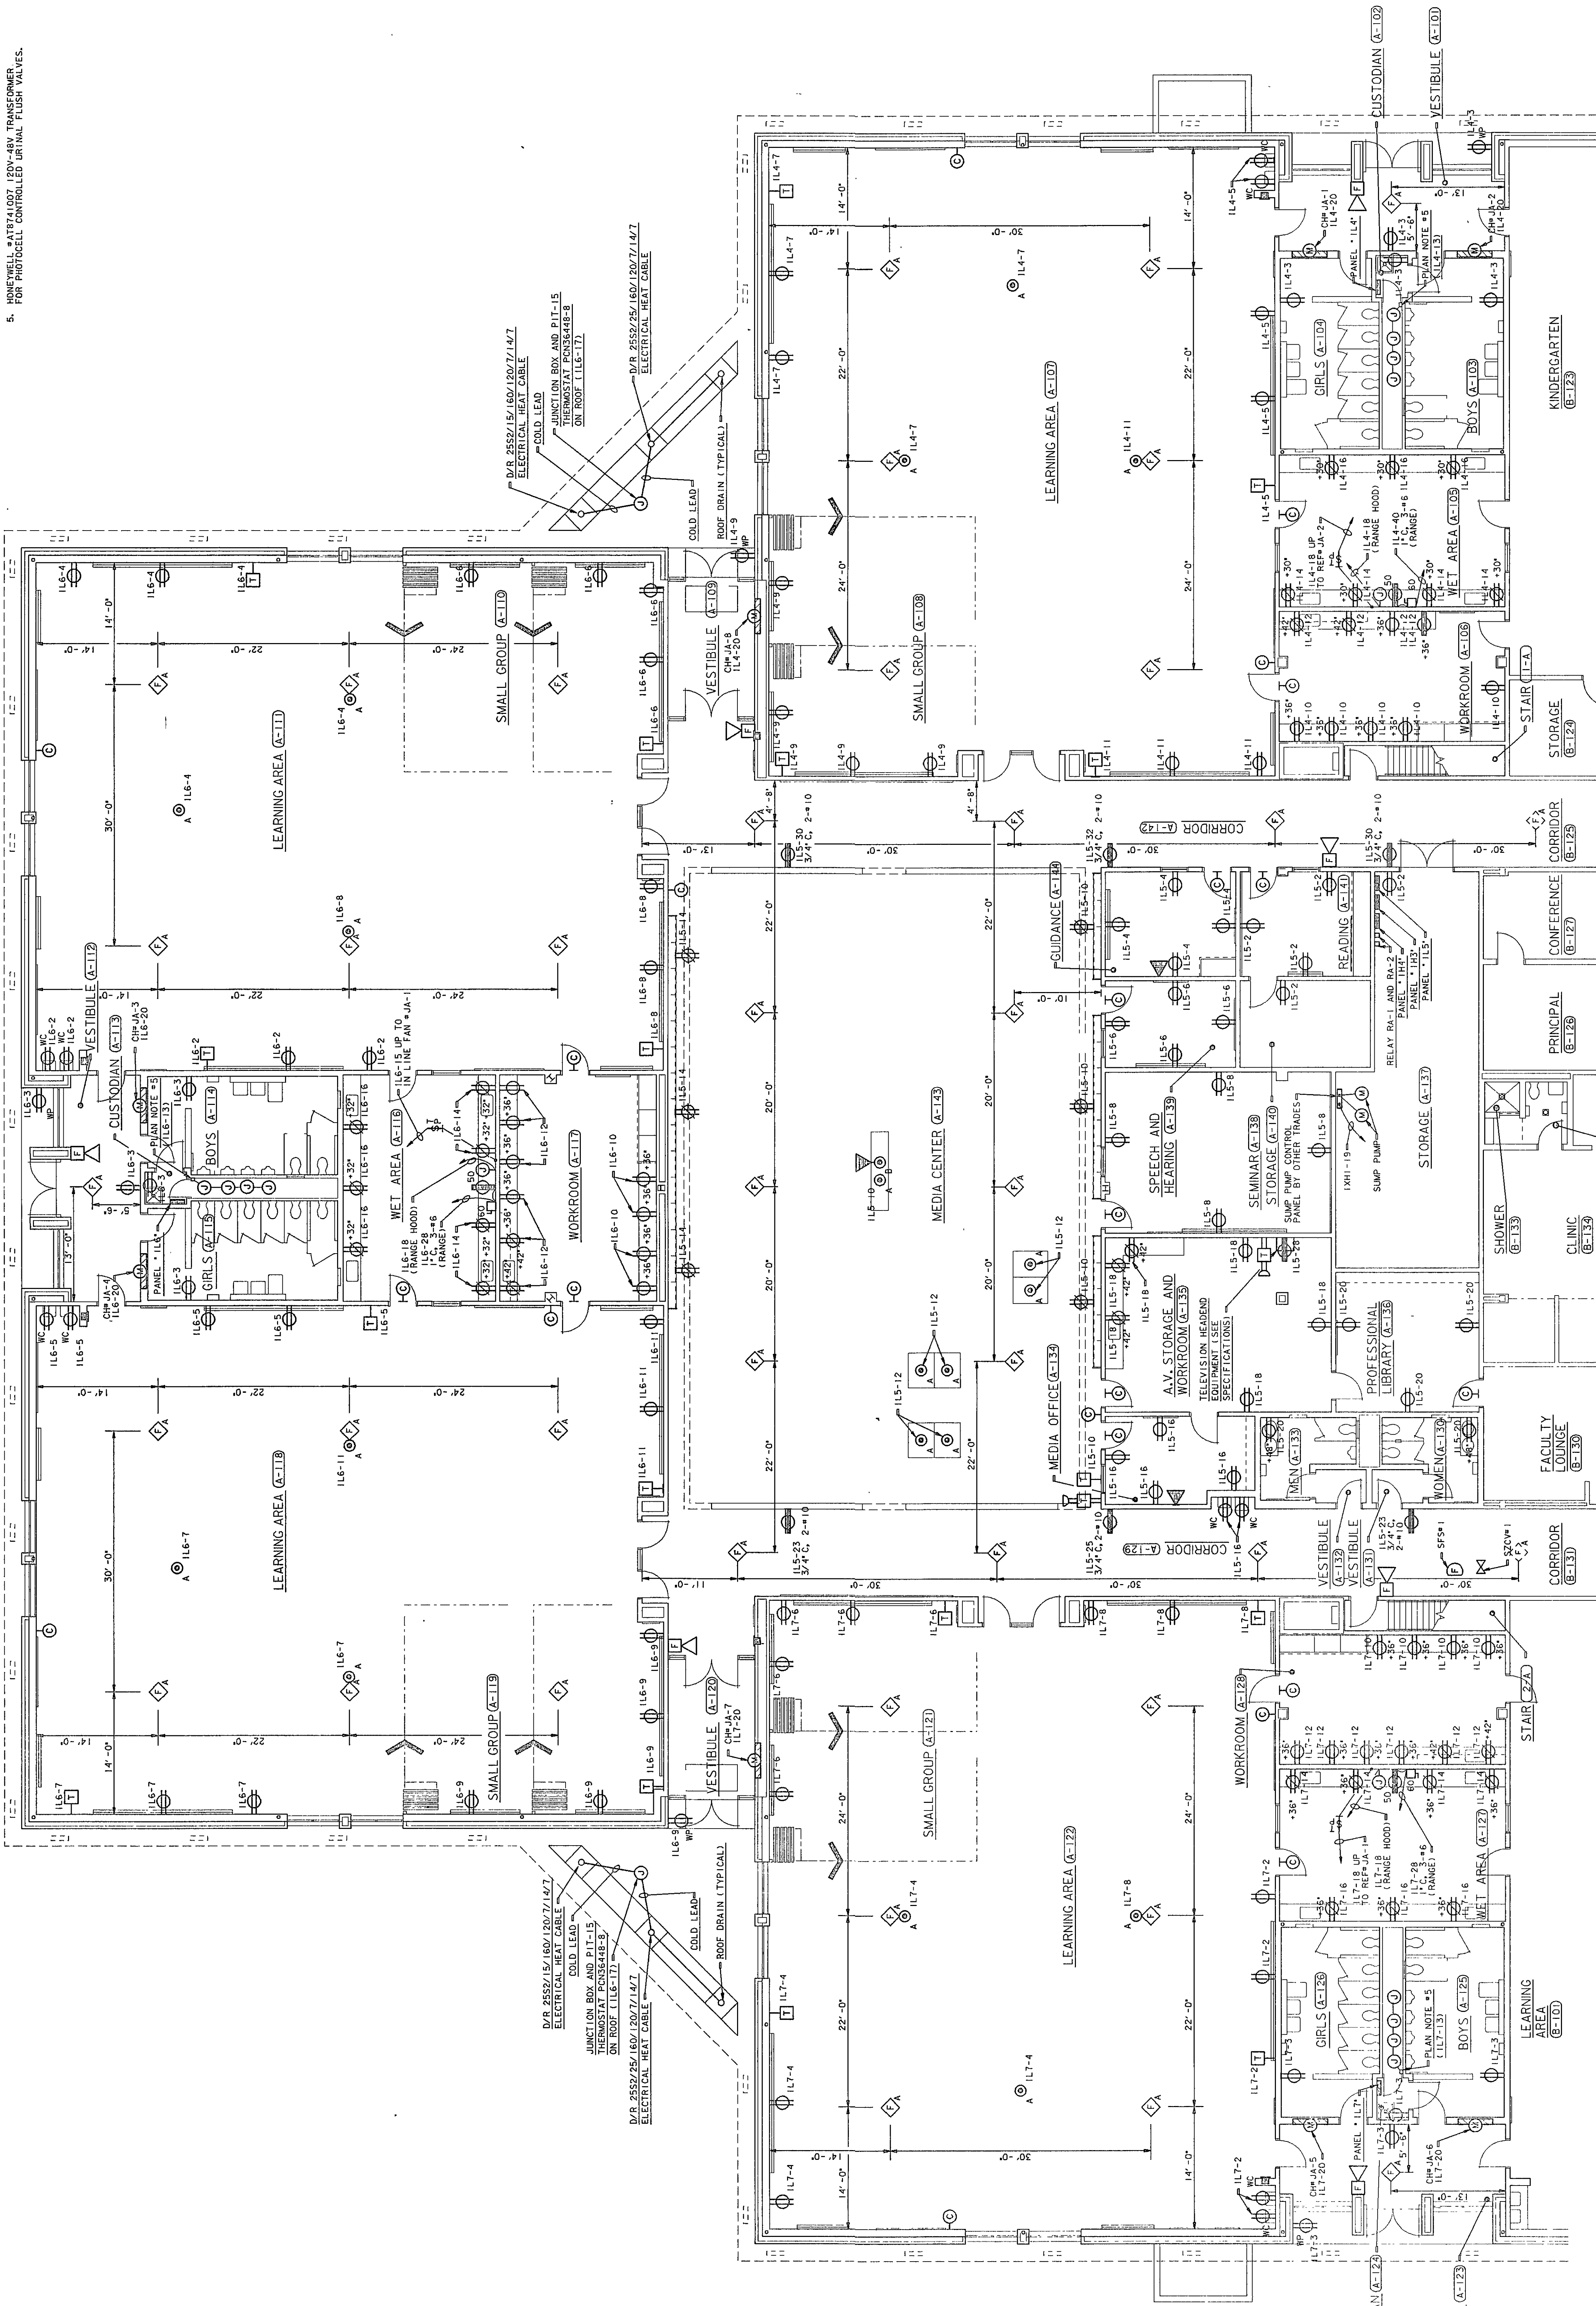

UNIT "A" ELECTRICAL FIRST FLOOR POWER PLAN
SCALE: 1/8"=1'-0"

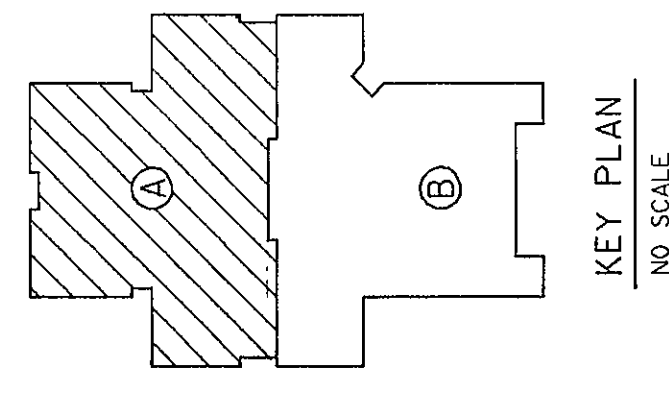

KEY PLAN
NO SCALE