



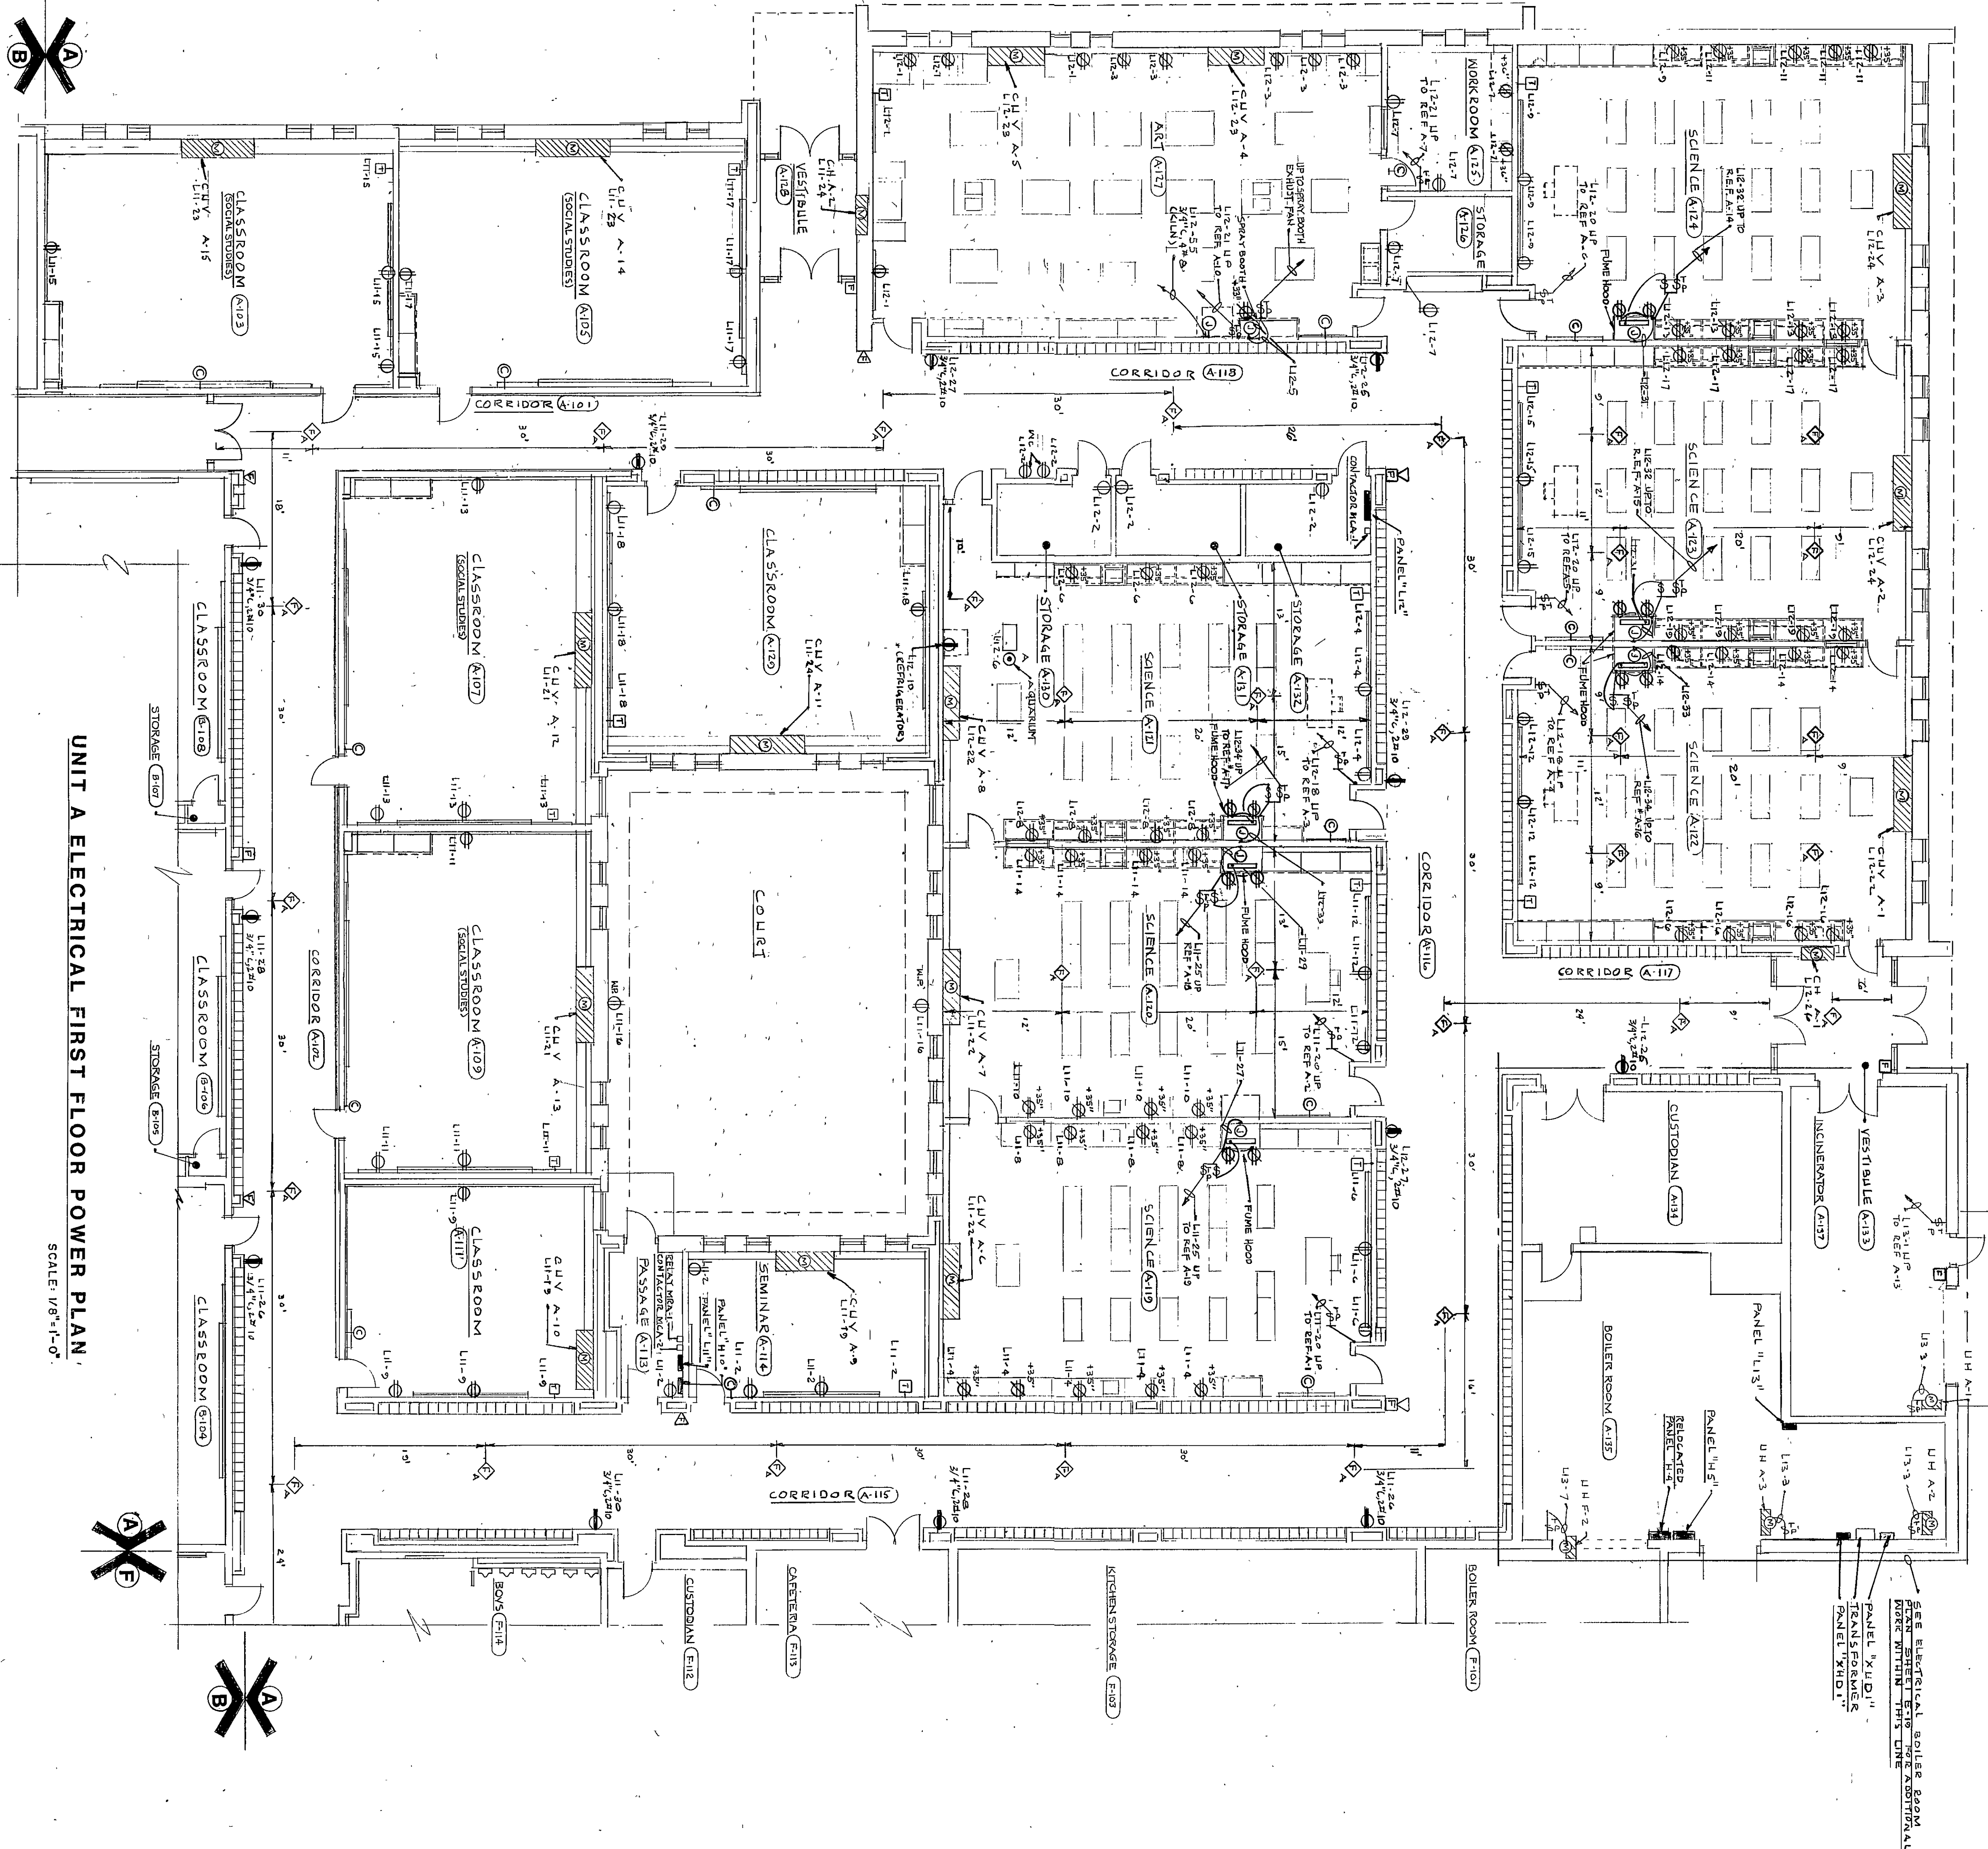

UNIT A ELECTRICAL FIRST FLOOR POWER PLAN
SCALE: 1/8"=1'-0"

- PLAN NOTE:
- SEE SHEET P-10 FOR ELECTRICAL SITE PLAN.
 - SEE SHEET P-11 FOR ELECTRICAL SYMBOLS, SCHEDULES, DETAILS AND NOTES.
 - SEE SHEET P-12 FOR ELECTRICAL FIRE ALARM DISTRIBUTION DIAGRAM AND TELEPHONE DISTRIBUTION DIAGRAM.
 - SEE SHEET P-13 FOR ELECTRICAL TELEVISION DISTRIBUTION DIAGRAM AND PANEL SCHEDULES.
 - SEE SHEET P-14 FOR ELECTRICAL POWER DISTRIBUTION DIAGRAM.

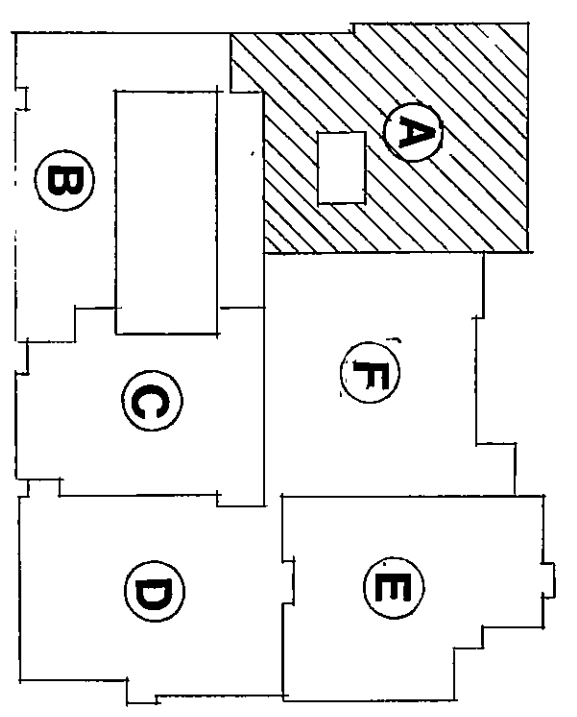

KEY PLAN
NO SCALE



James W. Roberts

EVERETT · I · BROWN COMPANY ARCHITECTS
ENGINEERS
5500 WEST BRADBURY AVENUE · PARK FLETCHER · INDIANAPOLIS, INDIANA · 46241

ADDITION TO AND RENOVATION OF LIBERTY MIDDLE SCHOOL

PROJECT 12579.0G
DATE MAY 3, 1982
REVISED
NO. E-13
OF 22
82-6-24