

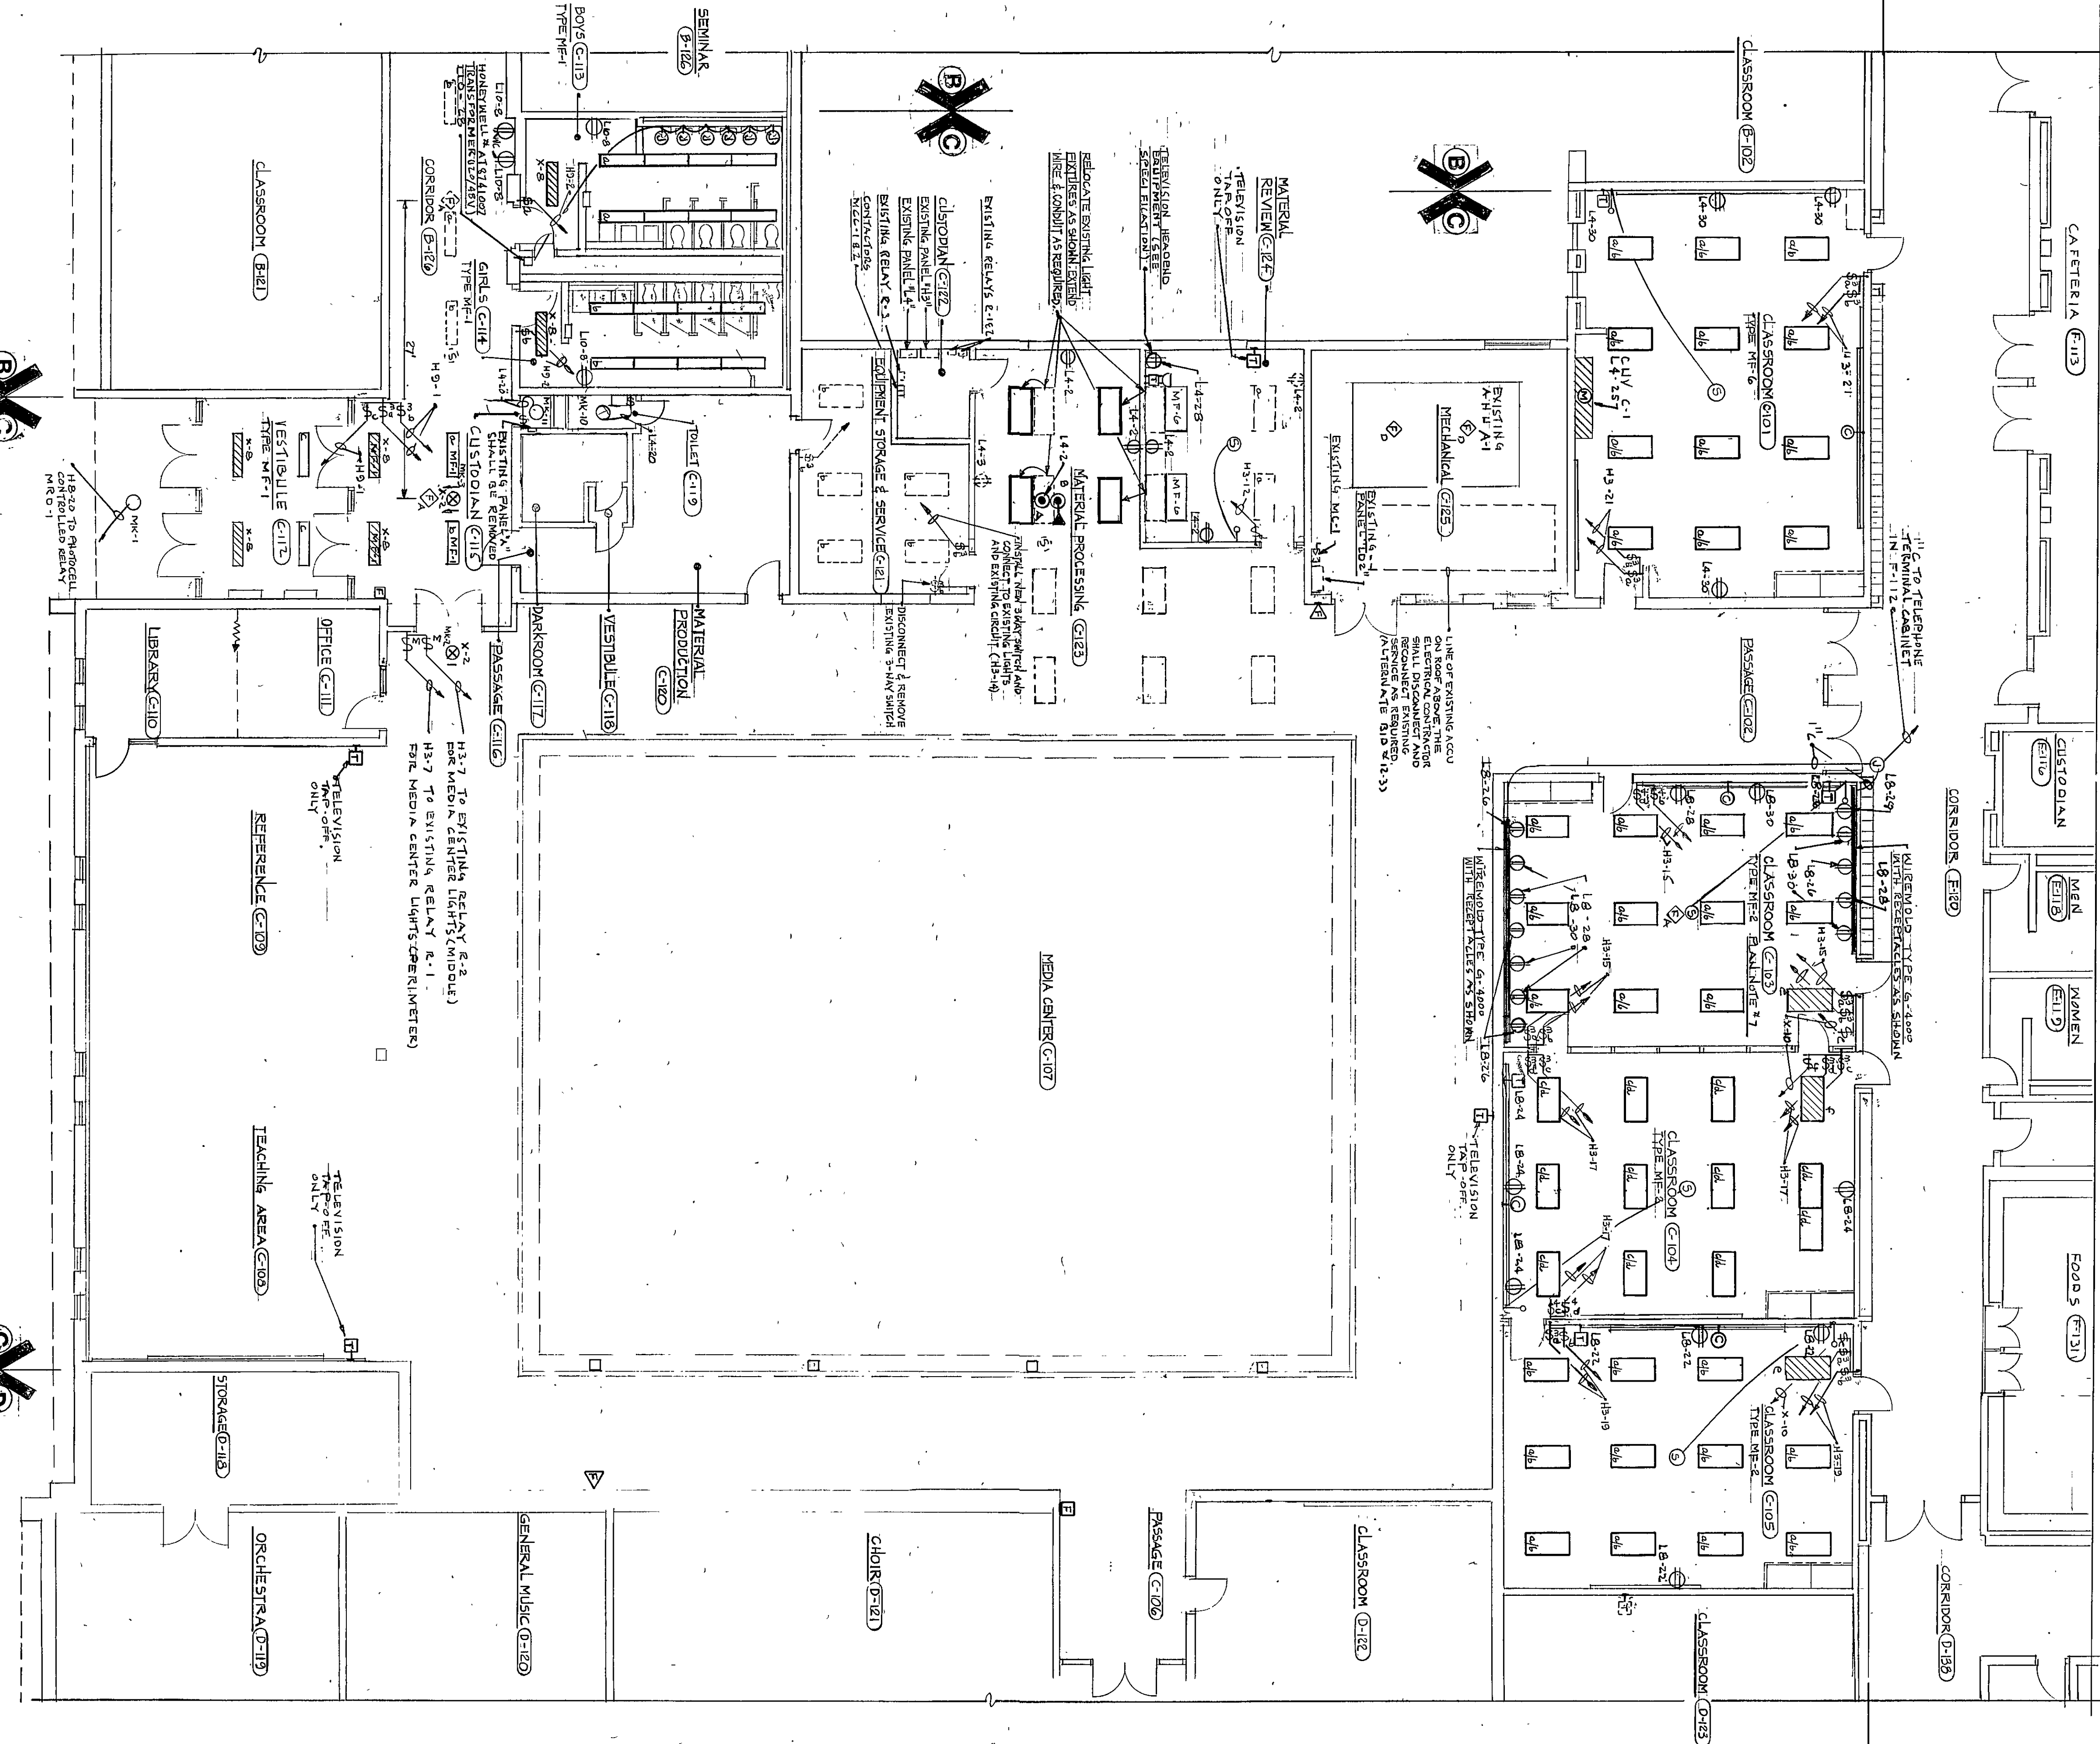
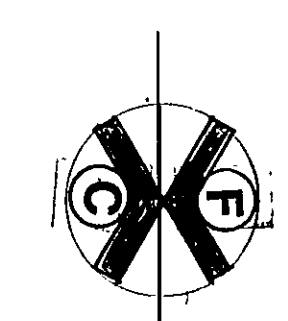


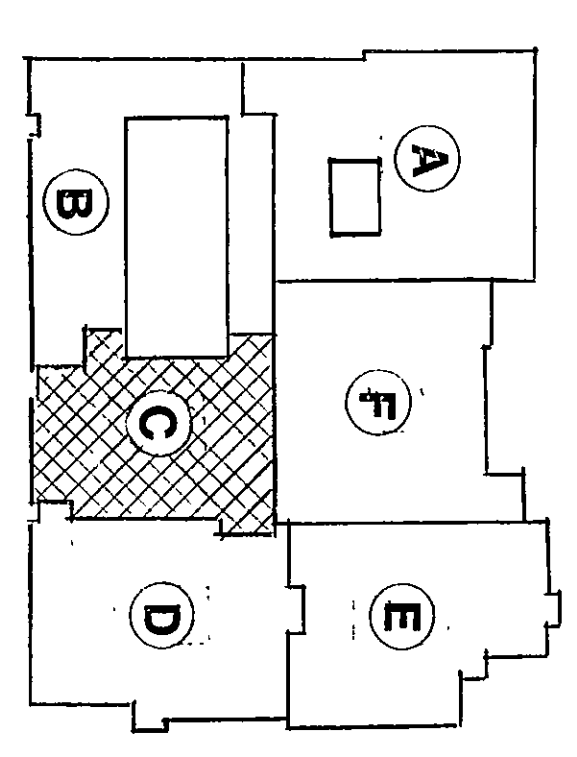

UNIT C ELECTRICAL FIRST FLOOR PLAN
SCALE: 1/8" = 1'-0"

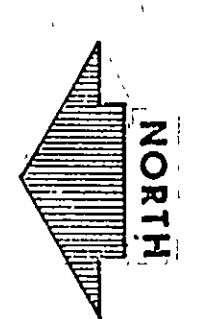

KEY PLAN
NO SCALE

- PLAN NOTE
1. SEE SHEET P-10 FOR ELECTRICAL SITE PLAN.
 2. SEE SHEET P-11 FOR ELECTRICAL SYMBOLS, SCHEDULES, DETAILS AND NOTES.
 3. SEE SHEET P-12 FOR ELECTRICAL FIRE ALARM DISTRIBUTION DIAGRAM AND TELEPHONE DISTRIBUTION DIAGRAM.
 4. SEE SHEET P-13 FOR ELECTRICAL TELEVISION DISTRIBUTION DIAGRAM.
 5. SEE SHEET P-14 FOR ELECTRICAL POWER DISTRIBUTION DIAGRAM.
 6. MULTI SWITCHED LIGHT FIXTURES SHALL HAVE THE MINIMUM NUMBER OF SWITCHES CONTROLLED BY THE SWITCHES CLOSEST TO THE OTHER SWITCHES. SWITCHES SHALL BE CONTROLLED BY THE OTHER SWITCHES.
 7. ALL RECEPTACLES IN THIS ROOM TO BE LOCATED WITHIN 5 FEET OF THE WALLS.