




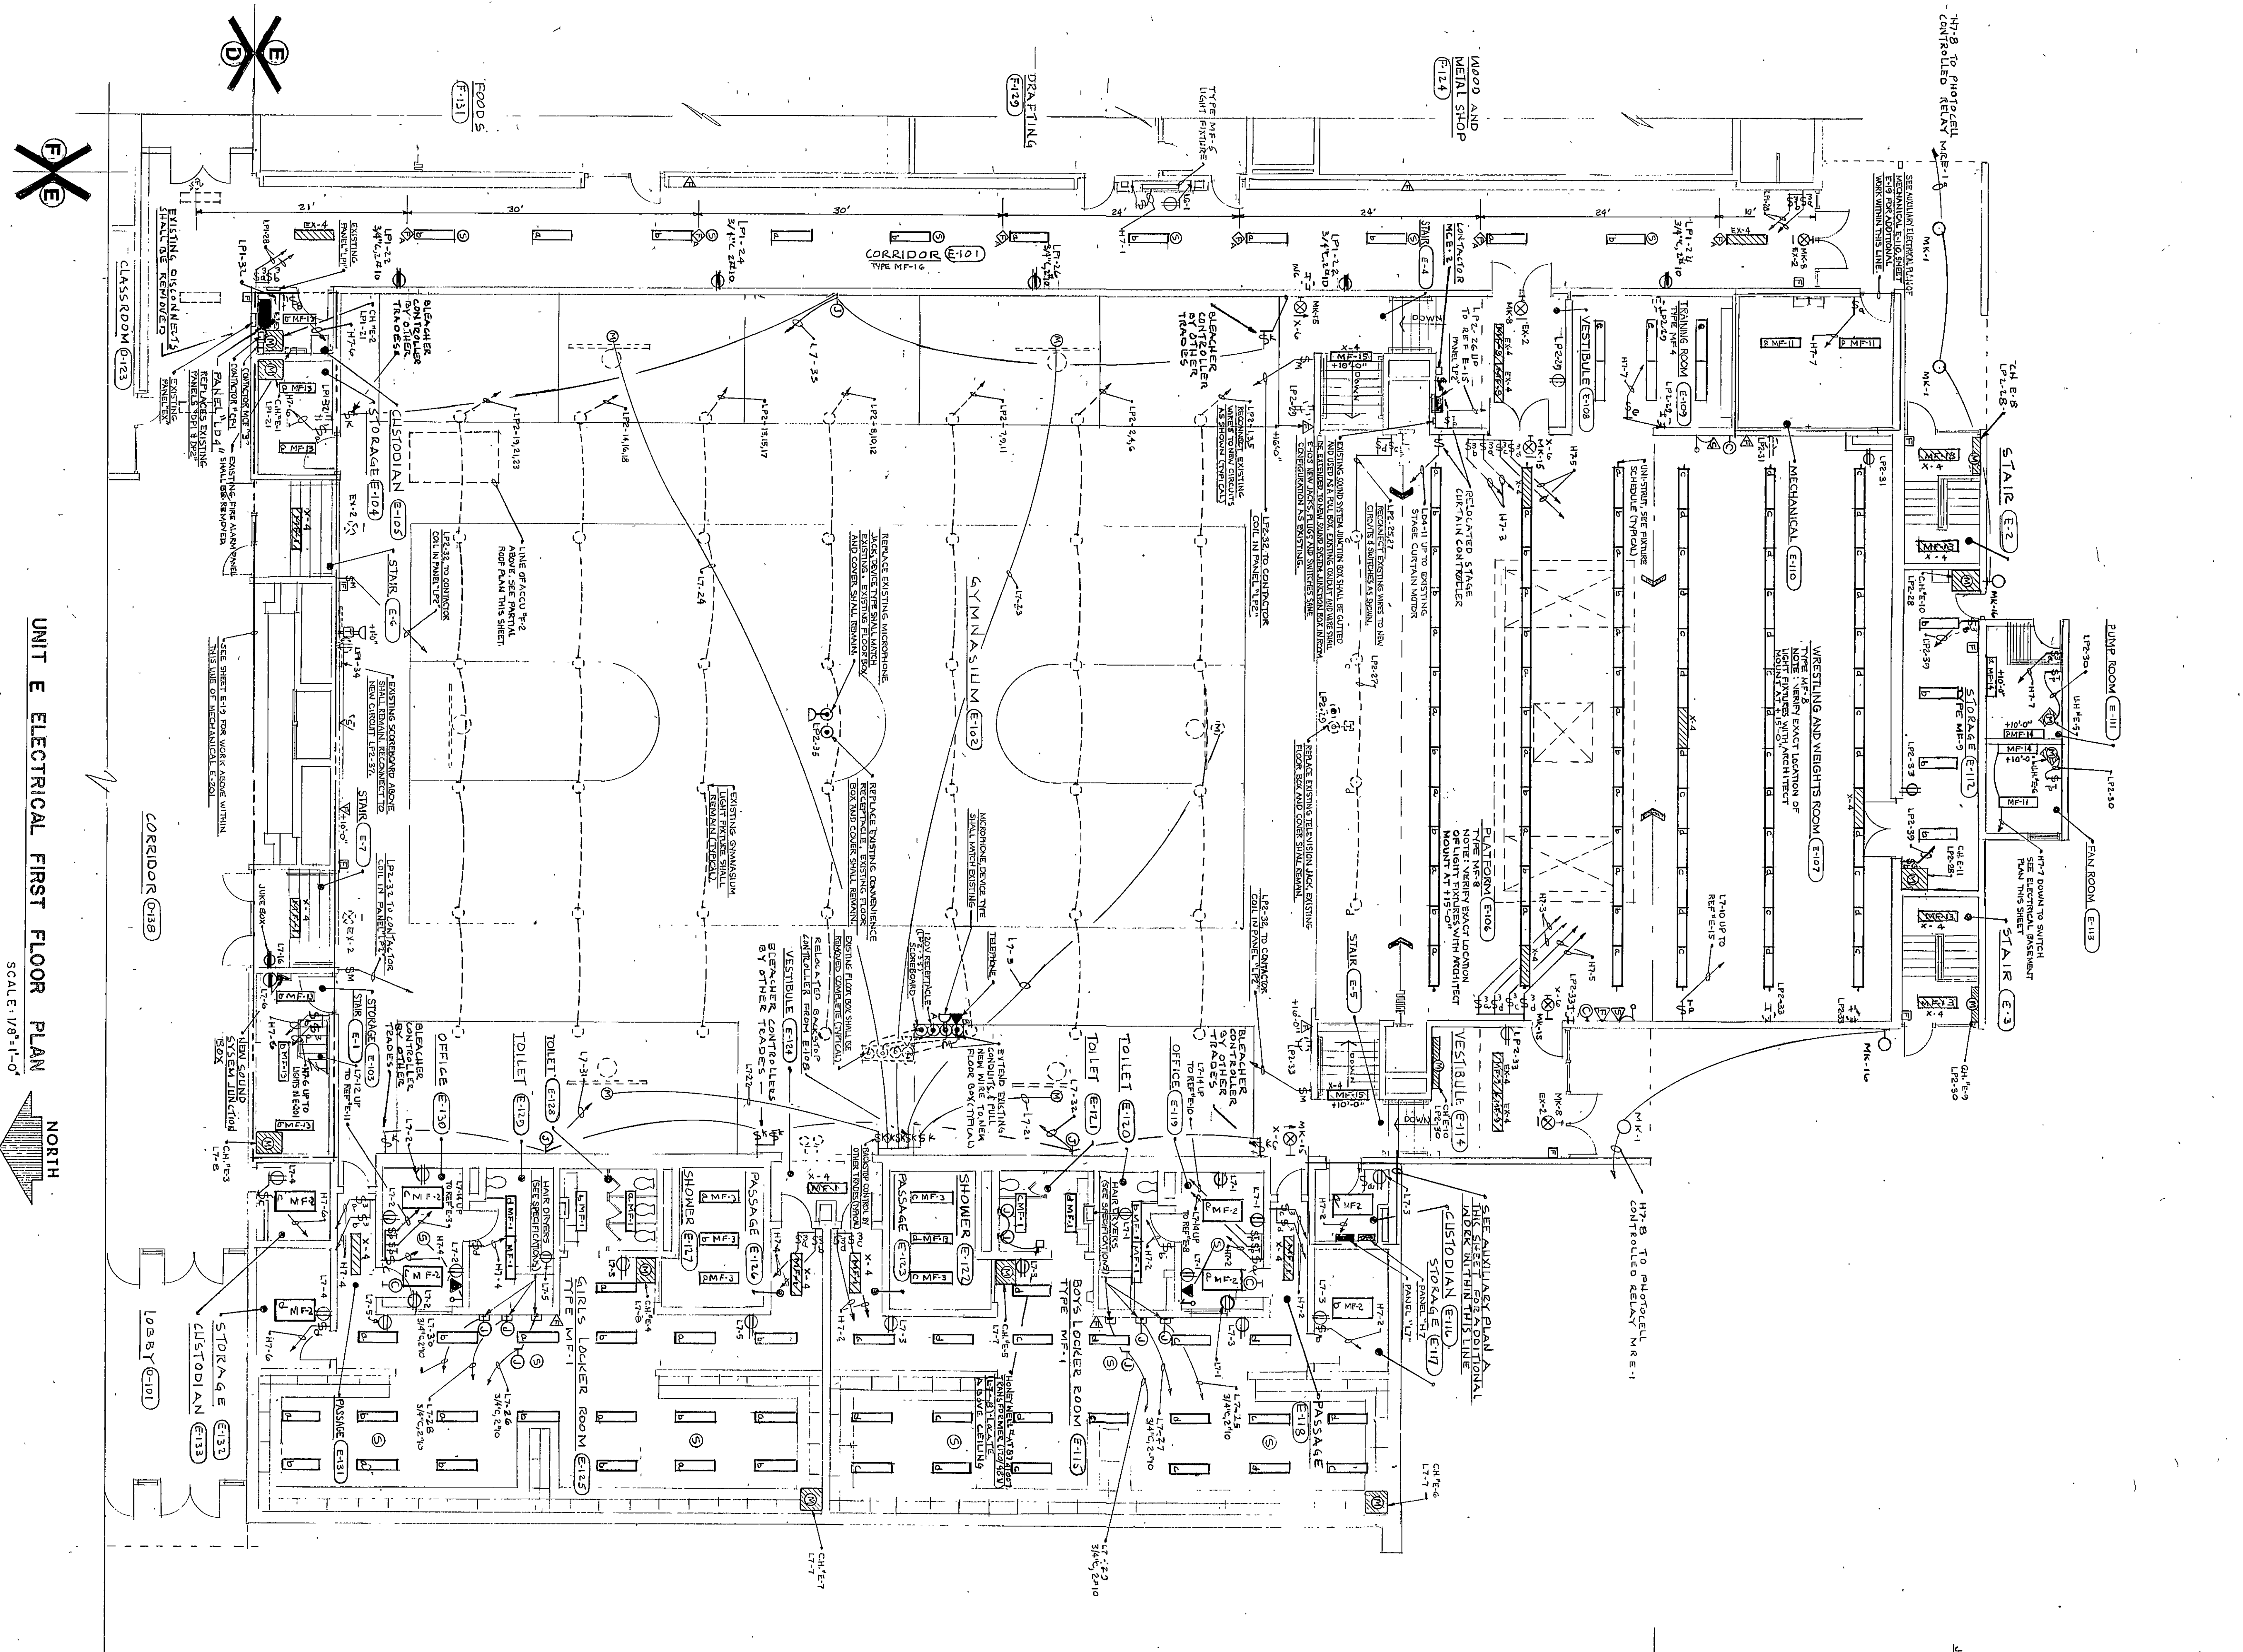


UNIT E ELECTRICAL FIRST FLOOR PLAN  
SCALE: 1/8"=1'-0"

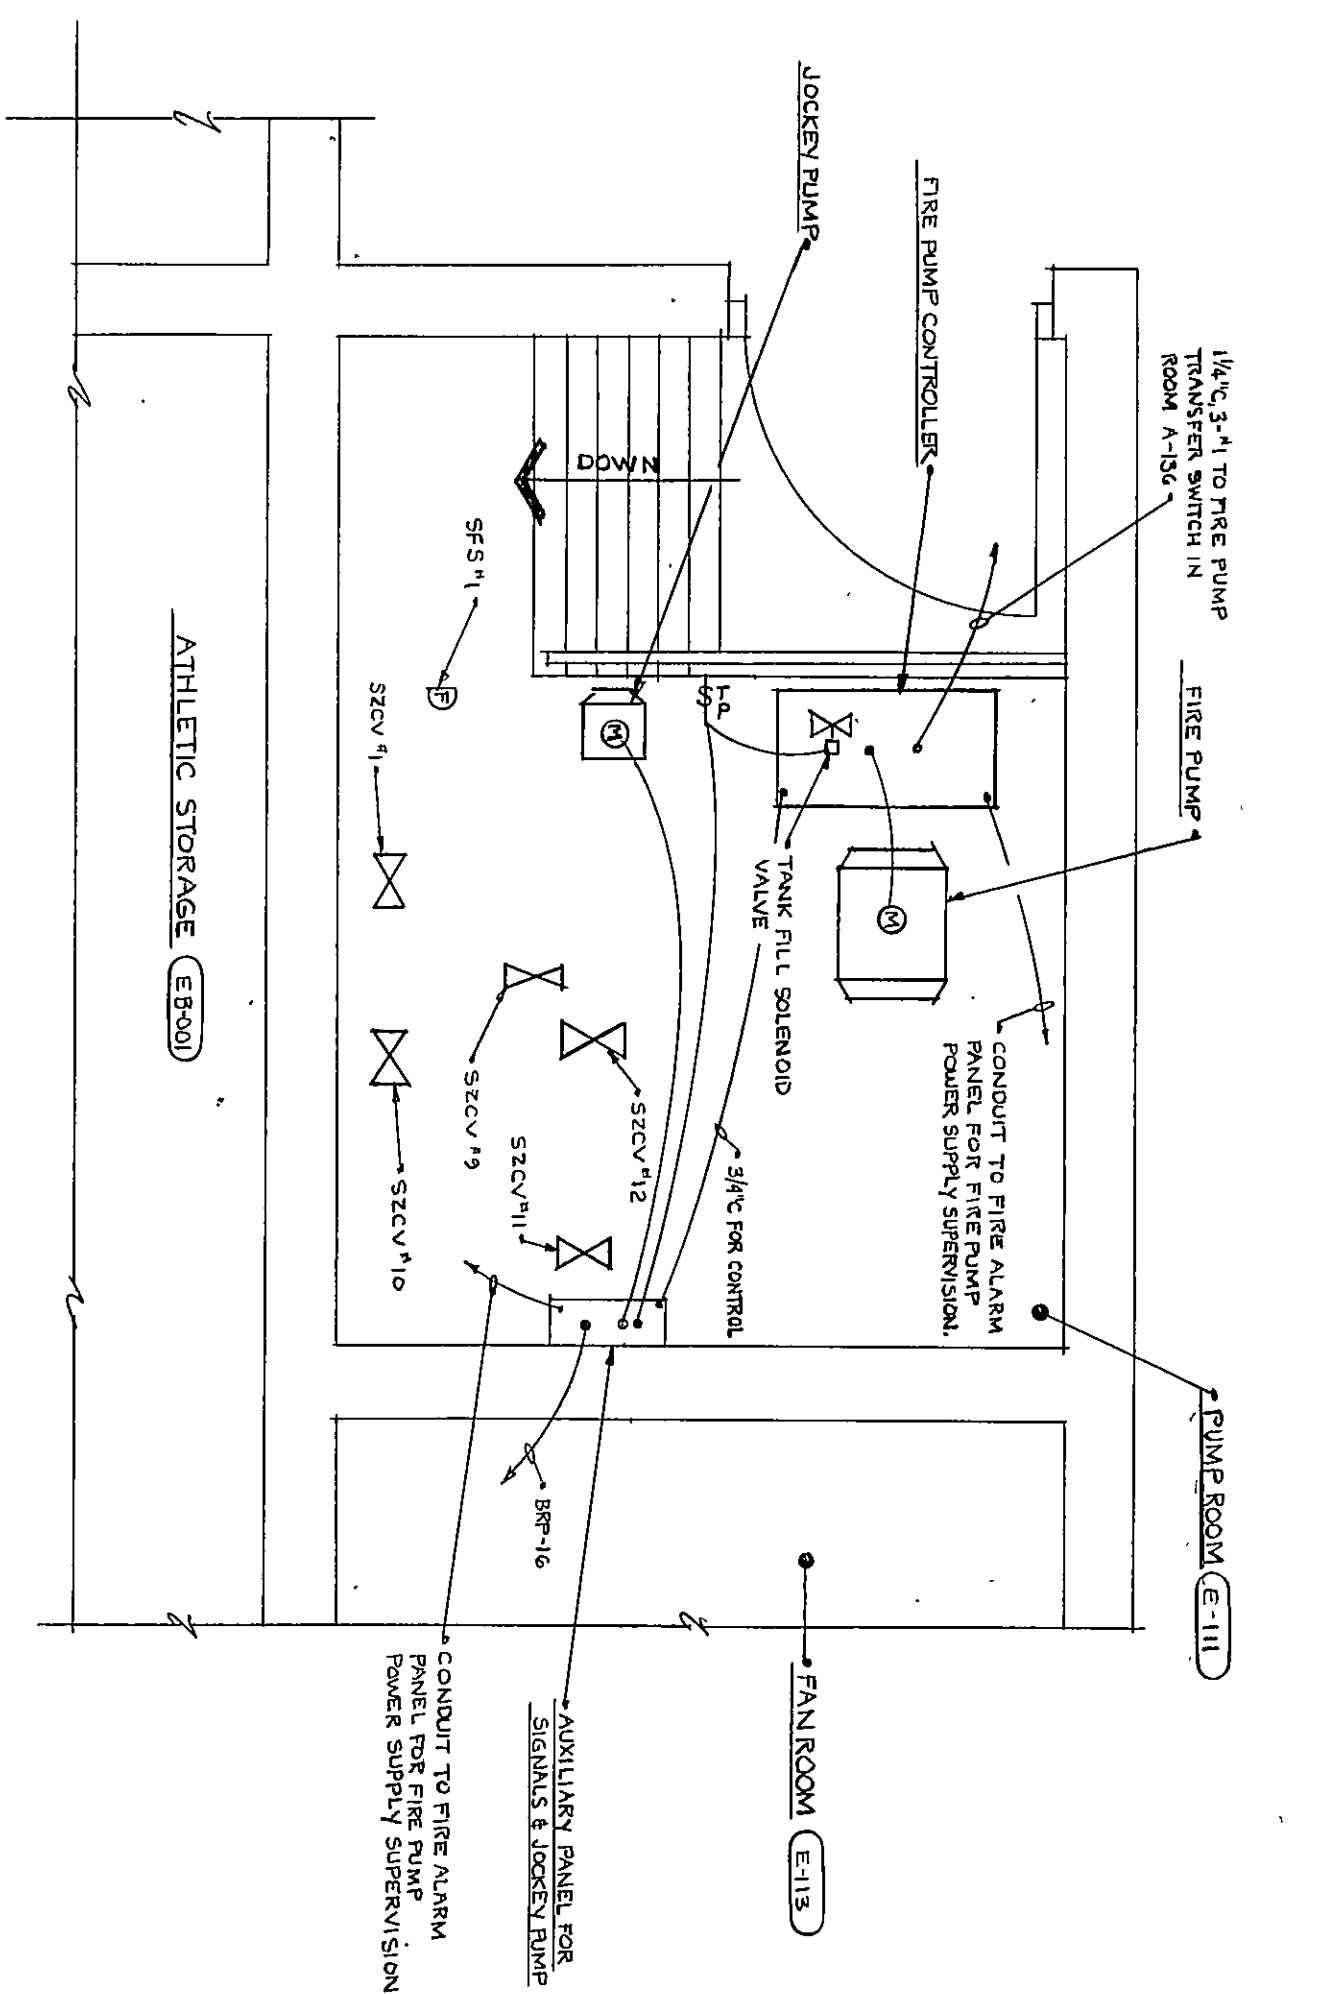


AUXILIARY PLAN B  
SCALE: 1/2"=1'-0"

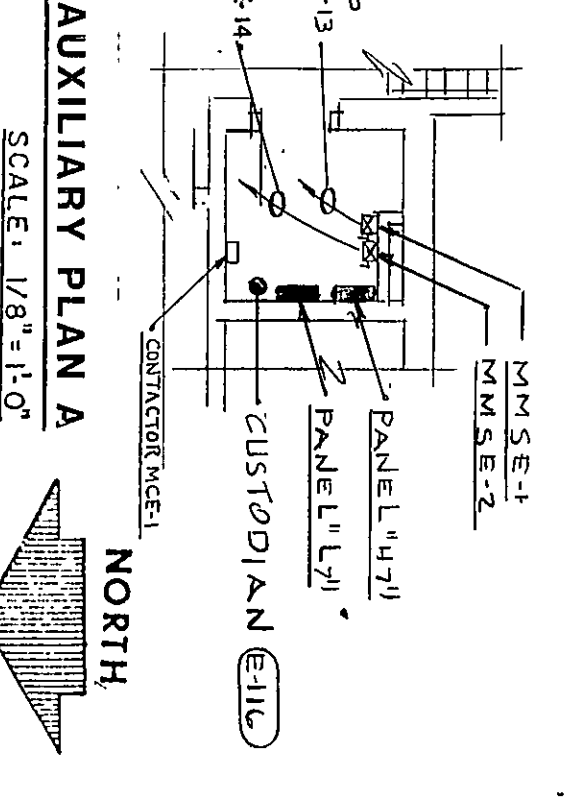


AUXILIARY PLAN A  
SCALE: 1/8"=1'-0"

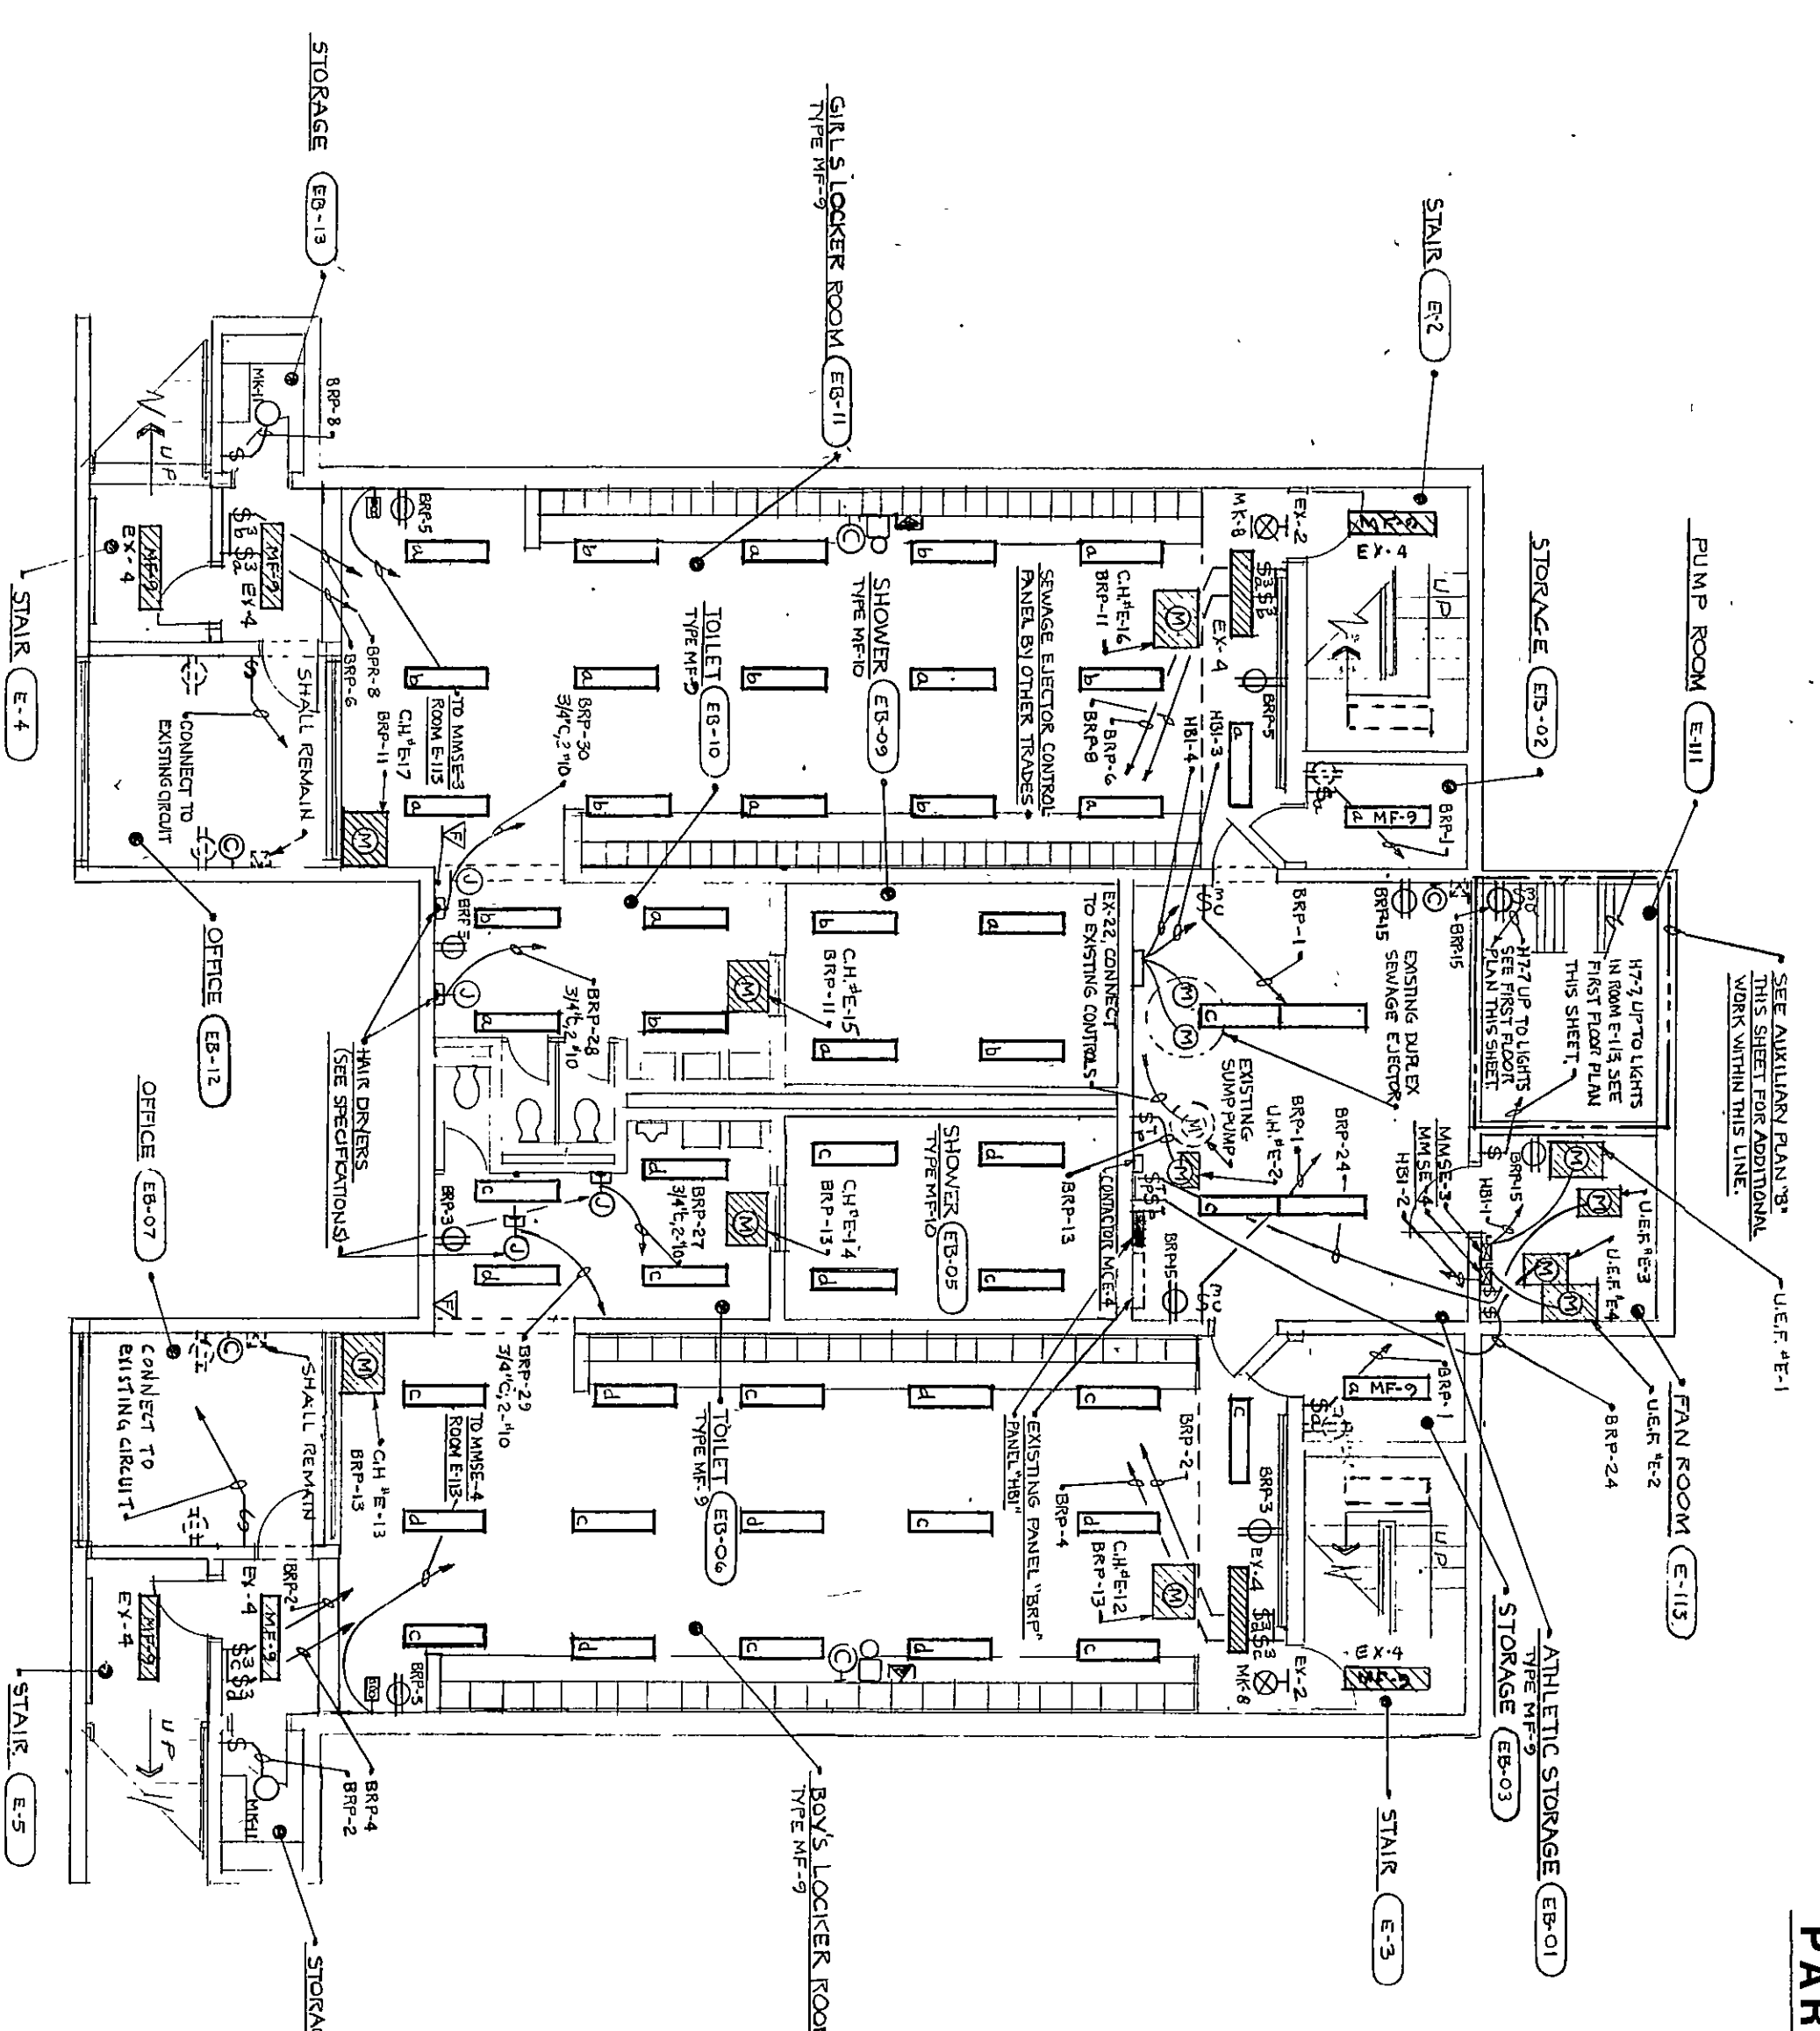


UNIT E ELECTRICAL BASEMENT FLOOR PLAN  
SCALE: 1/8"=1'-0"

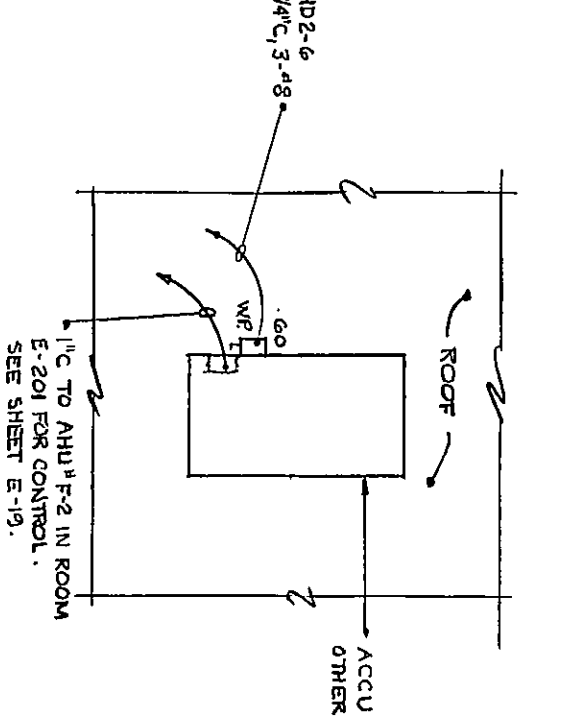


PARTIAL ROOF PLAN  
SCALE: 1/8"=1'-0"

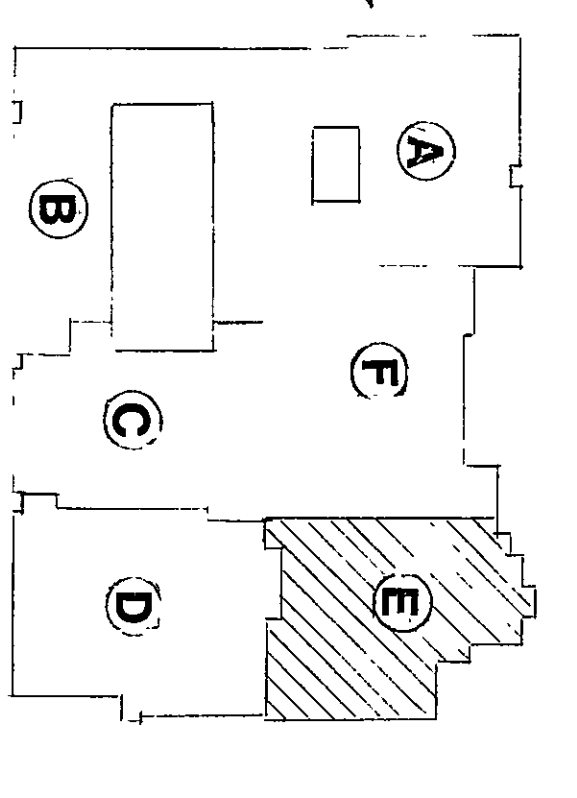

KEY PLAN  
NO SCALE

 

- PLAN NOTES
- SEE SHEET E-10 FOR ELECTRICAL SITE PLAN.
  - SEE SHEET E-11 FOR ELECTRICAL SYMBOLS, SCHEDULES, DIMENSIONS AND NOTES.
  - SEE SHEET E-12 FOR ELECTRICAL, FIRE ALARM, TELEVISION, DISBURSEMENT AND TELEPHONE DISTRIBUTION DIVISION.
  - SEE SHEET E-21 FOR ELECTRICAL, TELEVISION DISTRIBUTION DIVISION.
  - SEE SHEET E-22 FOR ELECTRICAL POWER DISTRIBUTION DIVISION.

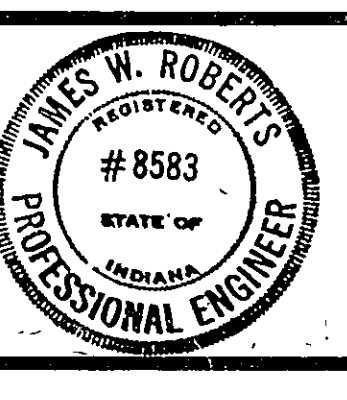

James W. Roberts

**EVERETT · I · BROWN COMPANY** ARCHITECTS  
ENGINEERS  
5500 WEST BRADBURY AVENUE · PARK FLETCHER · INDIANAPOLIS, INDIANA · 46241

PROJECT  
12579.00  
DATE  
MAY 3, 1982  
REVISED

NO. E-17  
OF  
22