




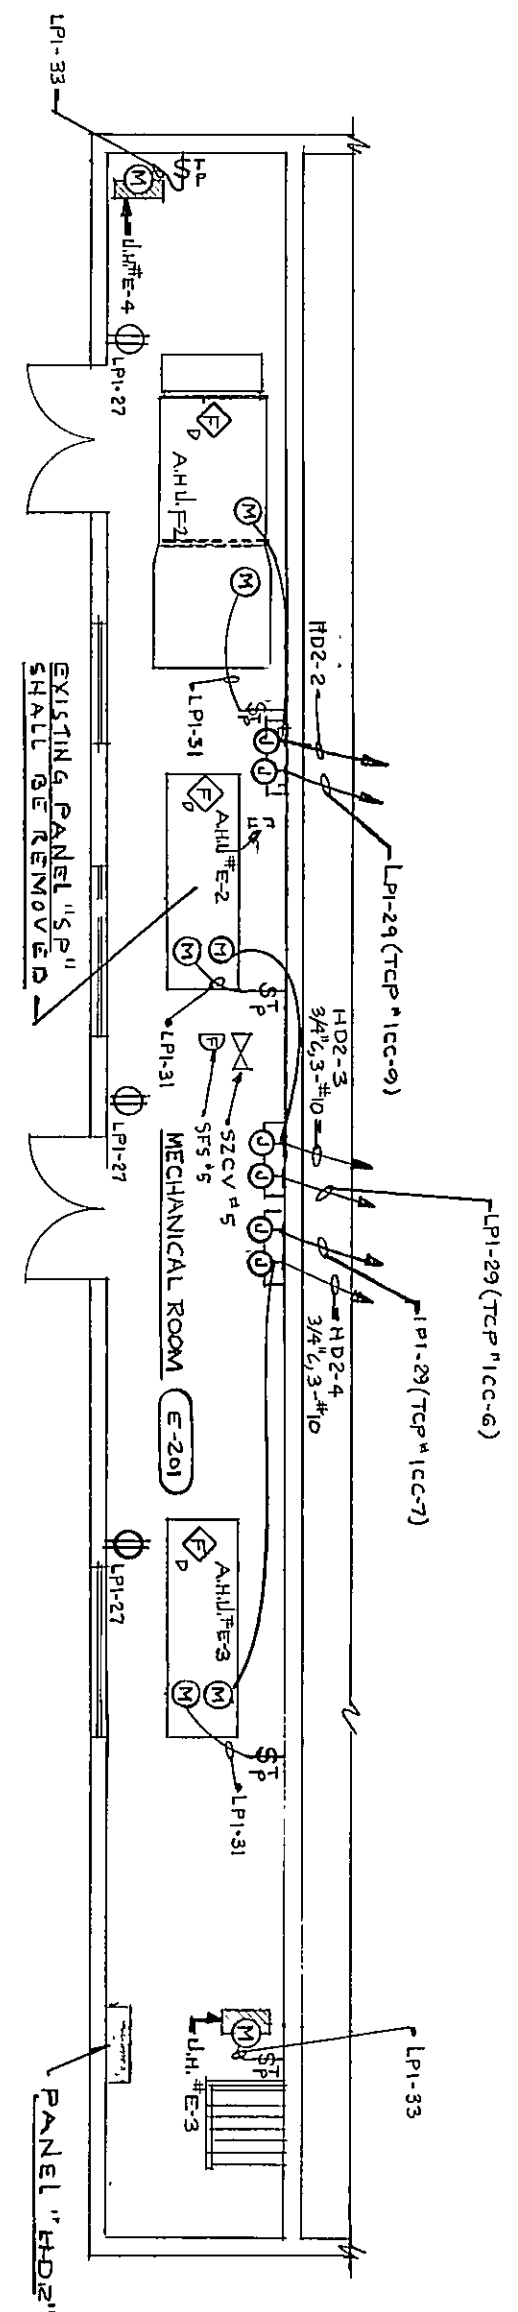


ELECTRICAL POWER PLAN OF MECHANICAL ROOM E-201
SCALE: 1/8"=1'-0"

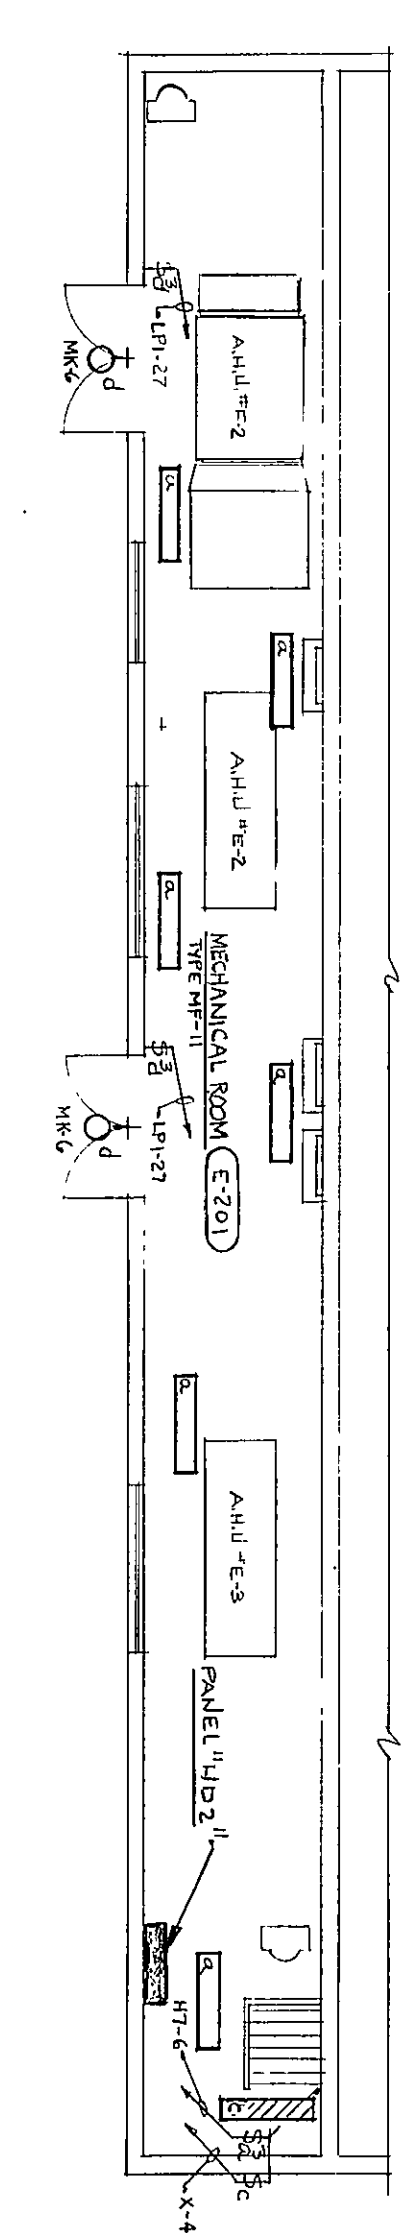


ELECTRICAL LIGHTING PLAN OF MECHANICAL ROOM E-201
SCALE: 1/8"=1'-0"

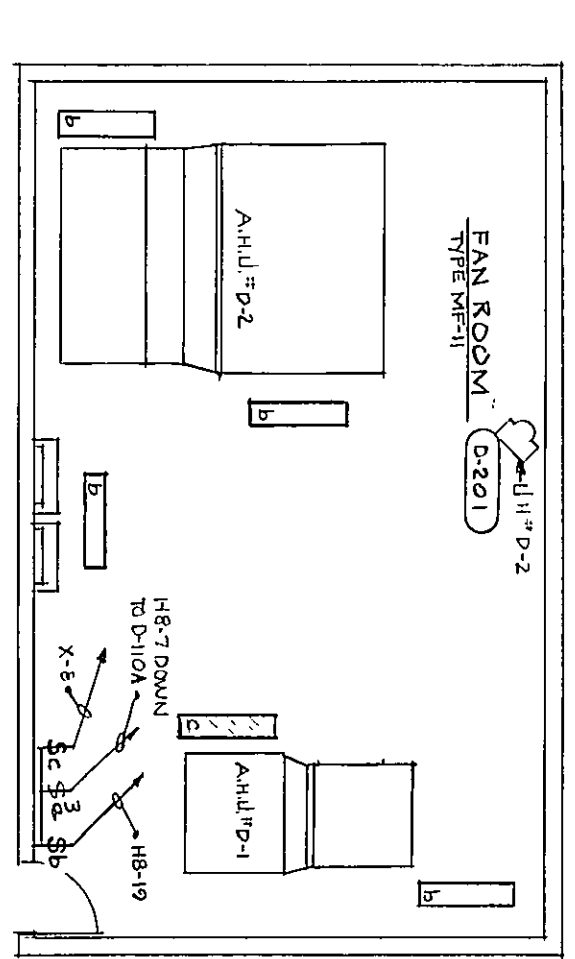


ELECTRICAL POWER PLAN OF FAN ROOM D-201
SCALE: 1/8"=1'-0"

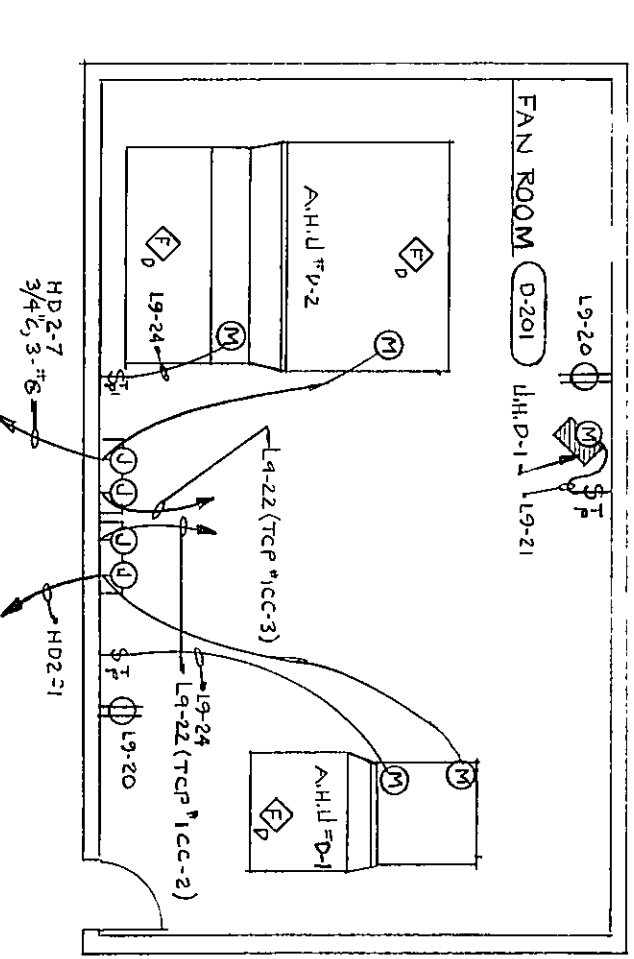

ELECTRICAL LIGHTING PLAN OF FAN ROOM D-201
SCALE: 1/8"=1'-0"

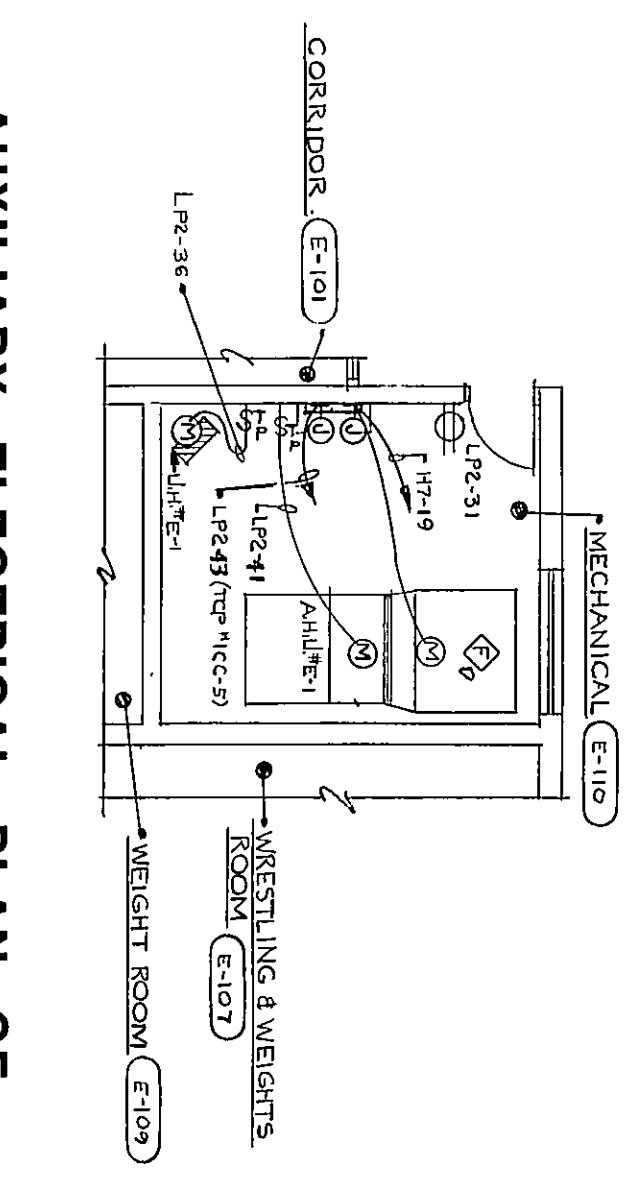

AUXILIARY ELECTRICAL PLAN OF MECHANICAL ROOM E-110
SCALE: 1/8"=1'-0"

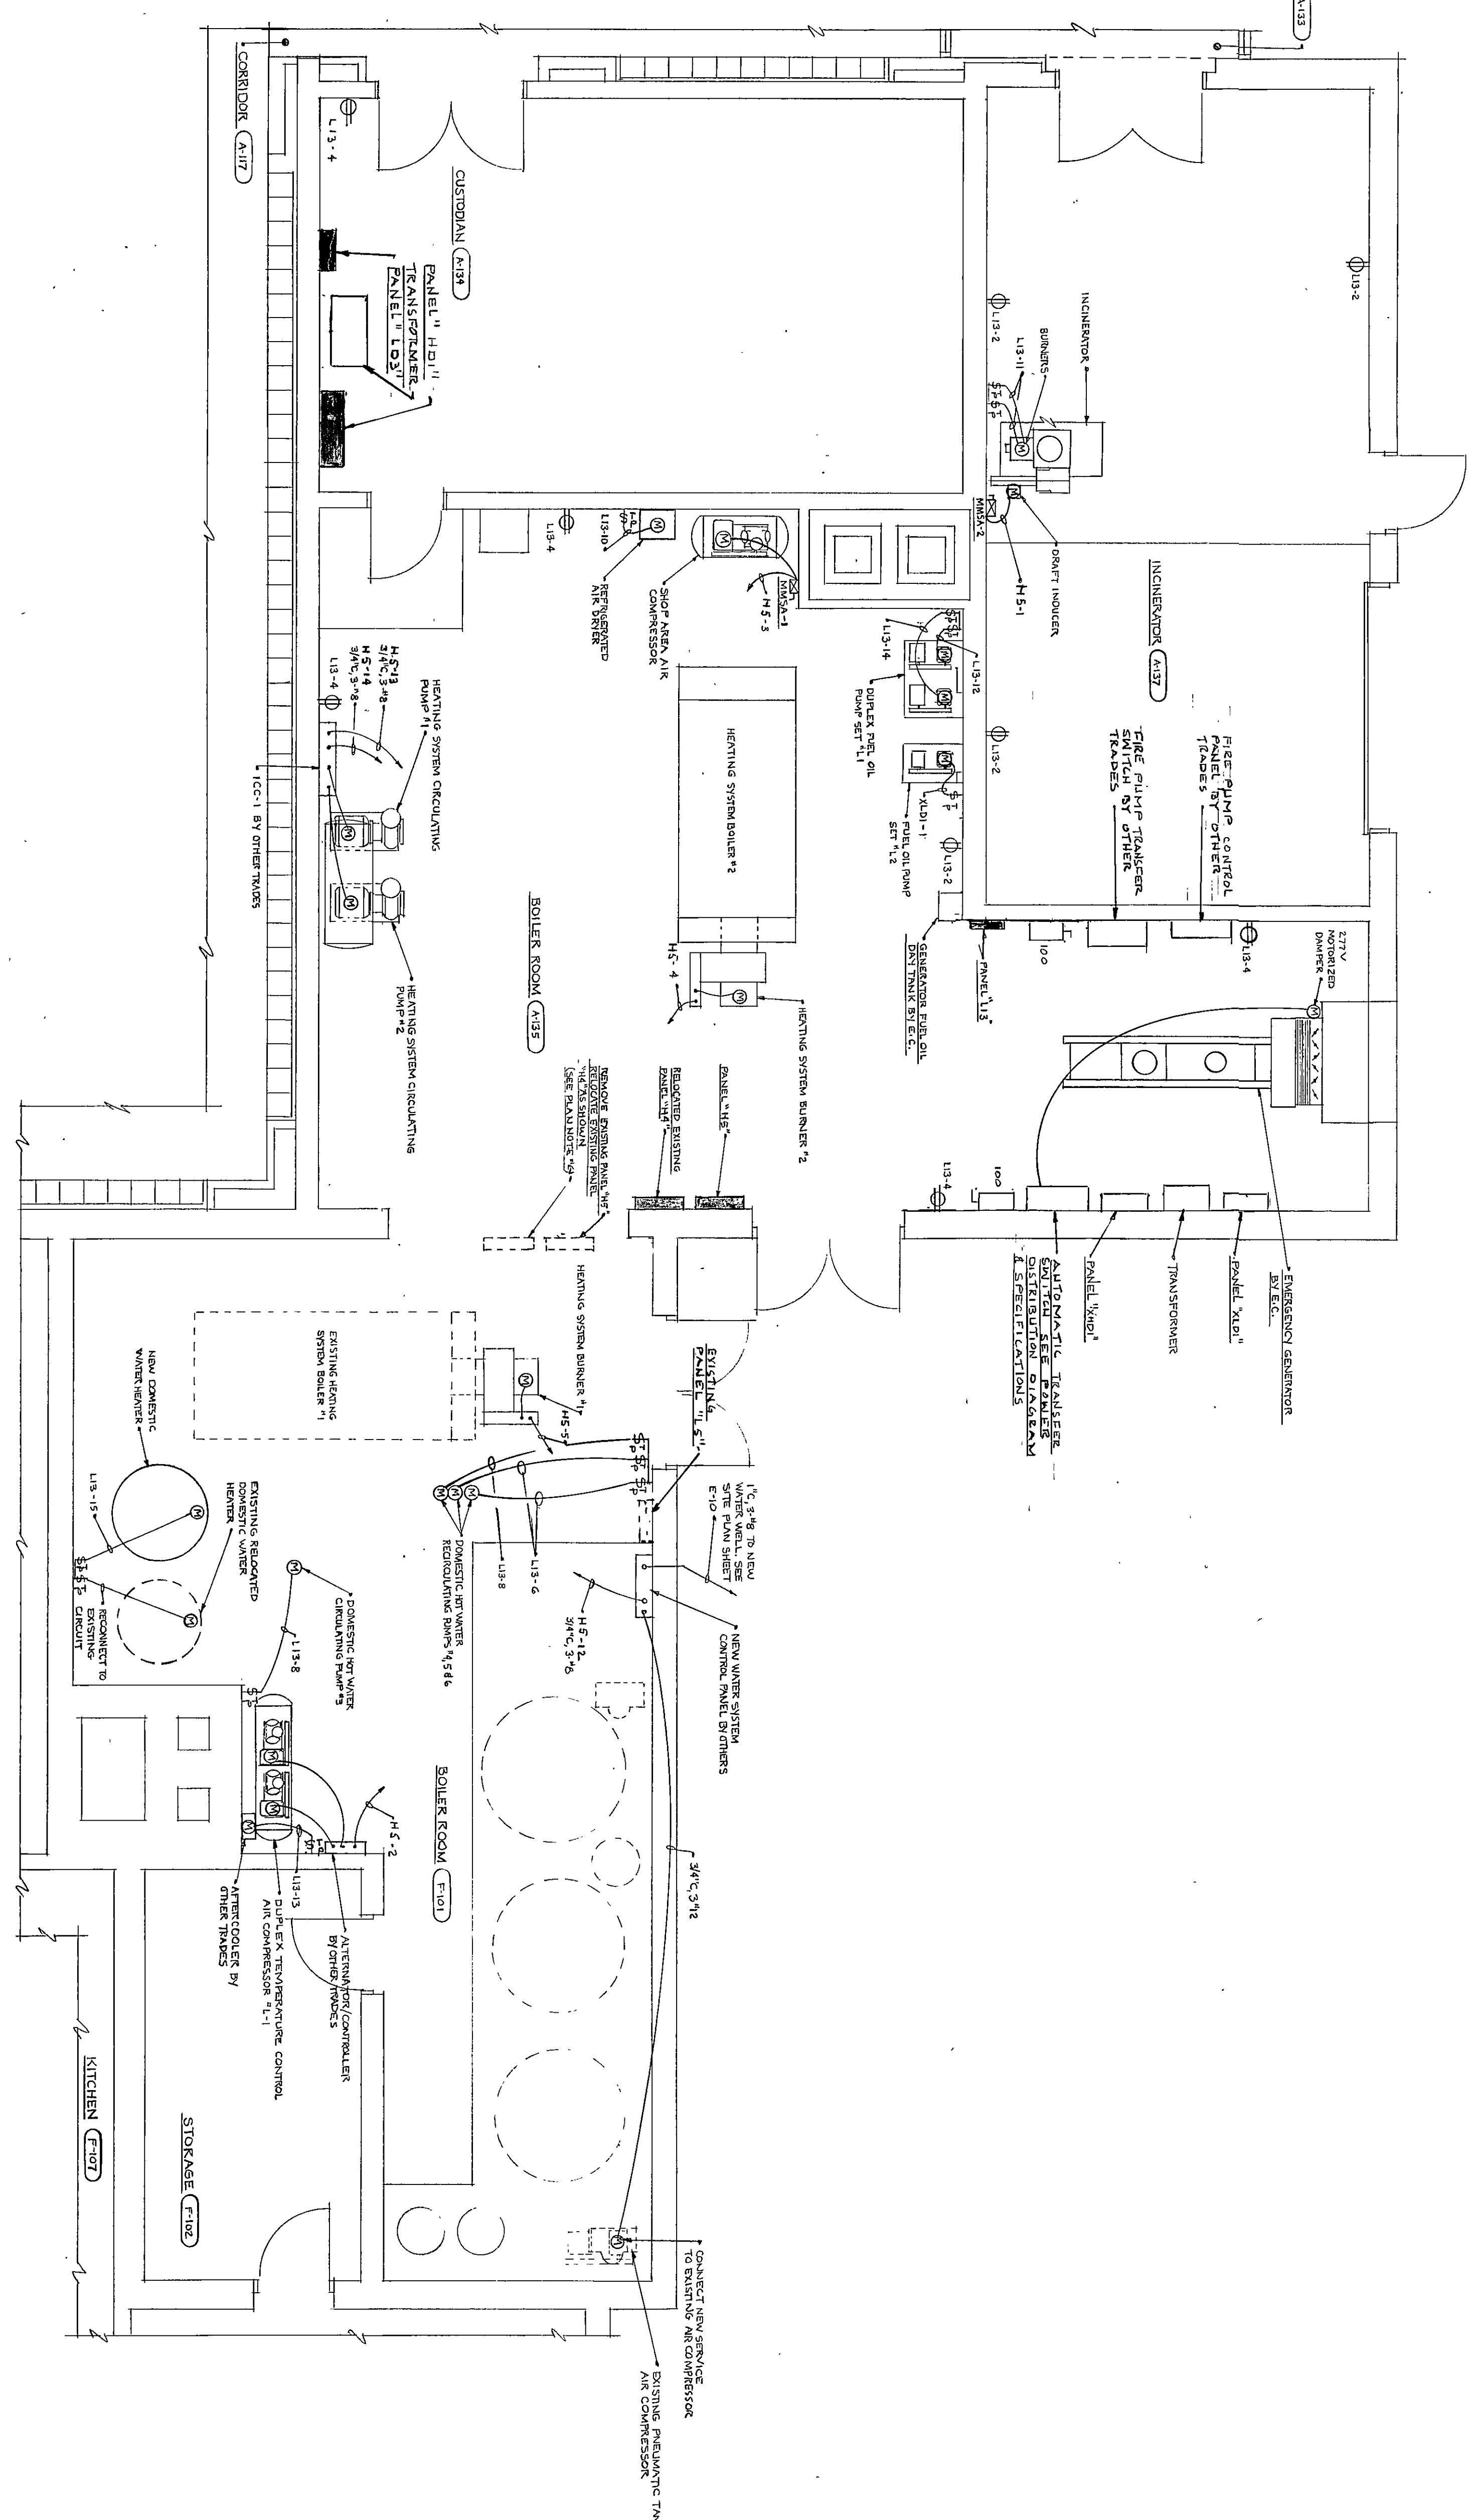

ELECTRICAL POWER PLAN OF BOILER ROOM
SCALE: 1/8"=1'-0"

- PLAN NOTES
1. SEE SHEET E-10 FOR ELECTRICAL SITE PLAN.
 2. SEE SHEET E-11 FOR ELECTRICAL SYMBOLS, SCHEDULES.
 3. SEE SHEET E-20 FOR ELECTRICAL FIRE ALARM DISTRIBUTION DIAGRAM AND TELEPHONE DISTRIBUTION DIAGRAM.
 4. SEE SHEET E-21 FOR ELECTRICAL TELEVISION DISTRIBUTION DIAGRAM AND PANEL SCHEDULES.
 5. SEE SHEET E-22 FOR ELECTRICAL POWER DISTRIBUTION DIAGRAM.
 6. AVOID EXISTING CIRCUITS TO NEW PANEL LOCATION.