


TEST PUMP CONNECTION

SHEET FP-2

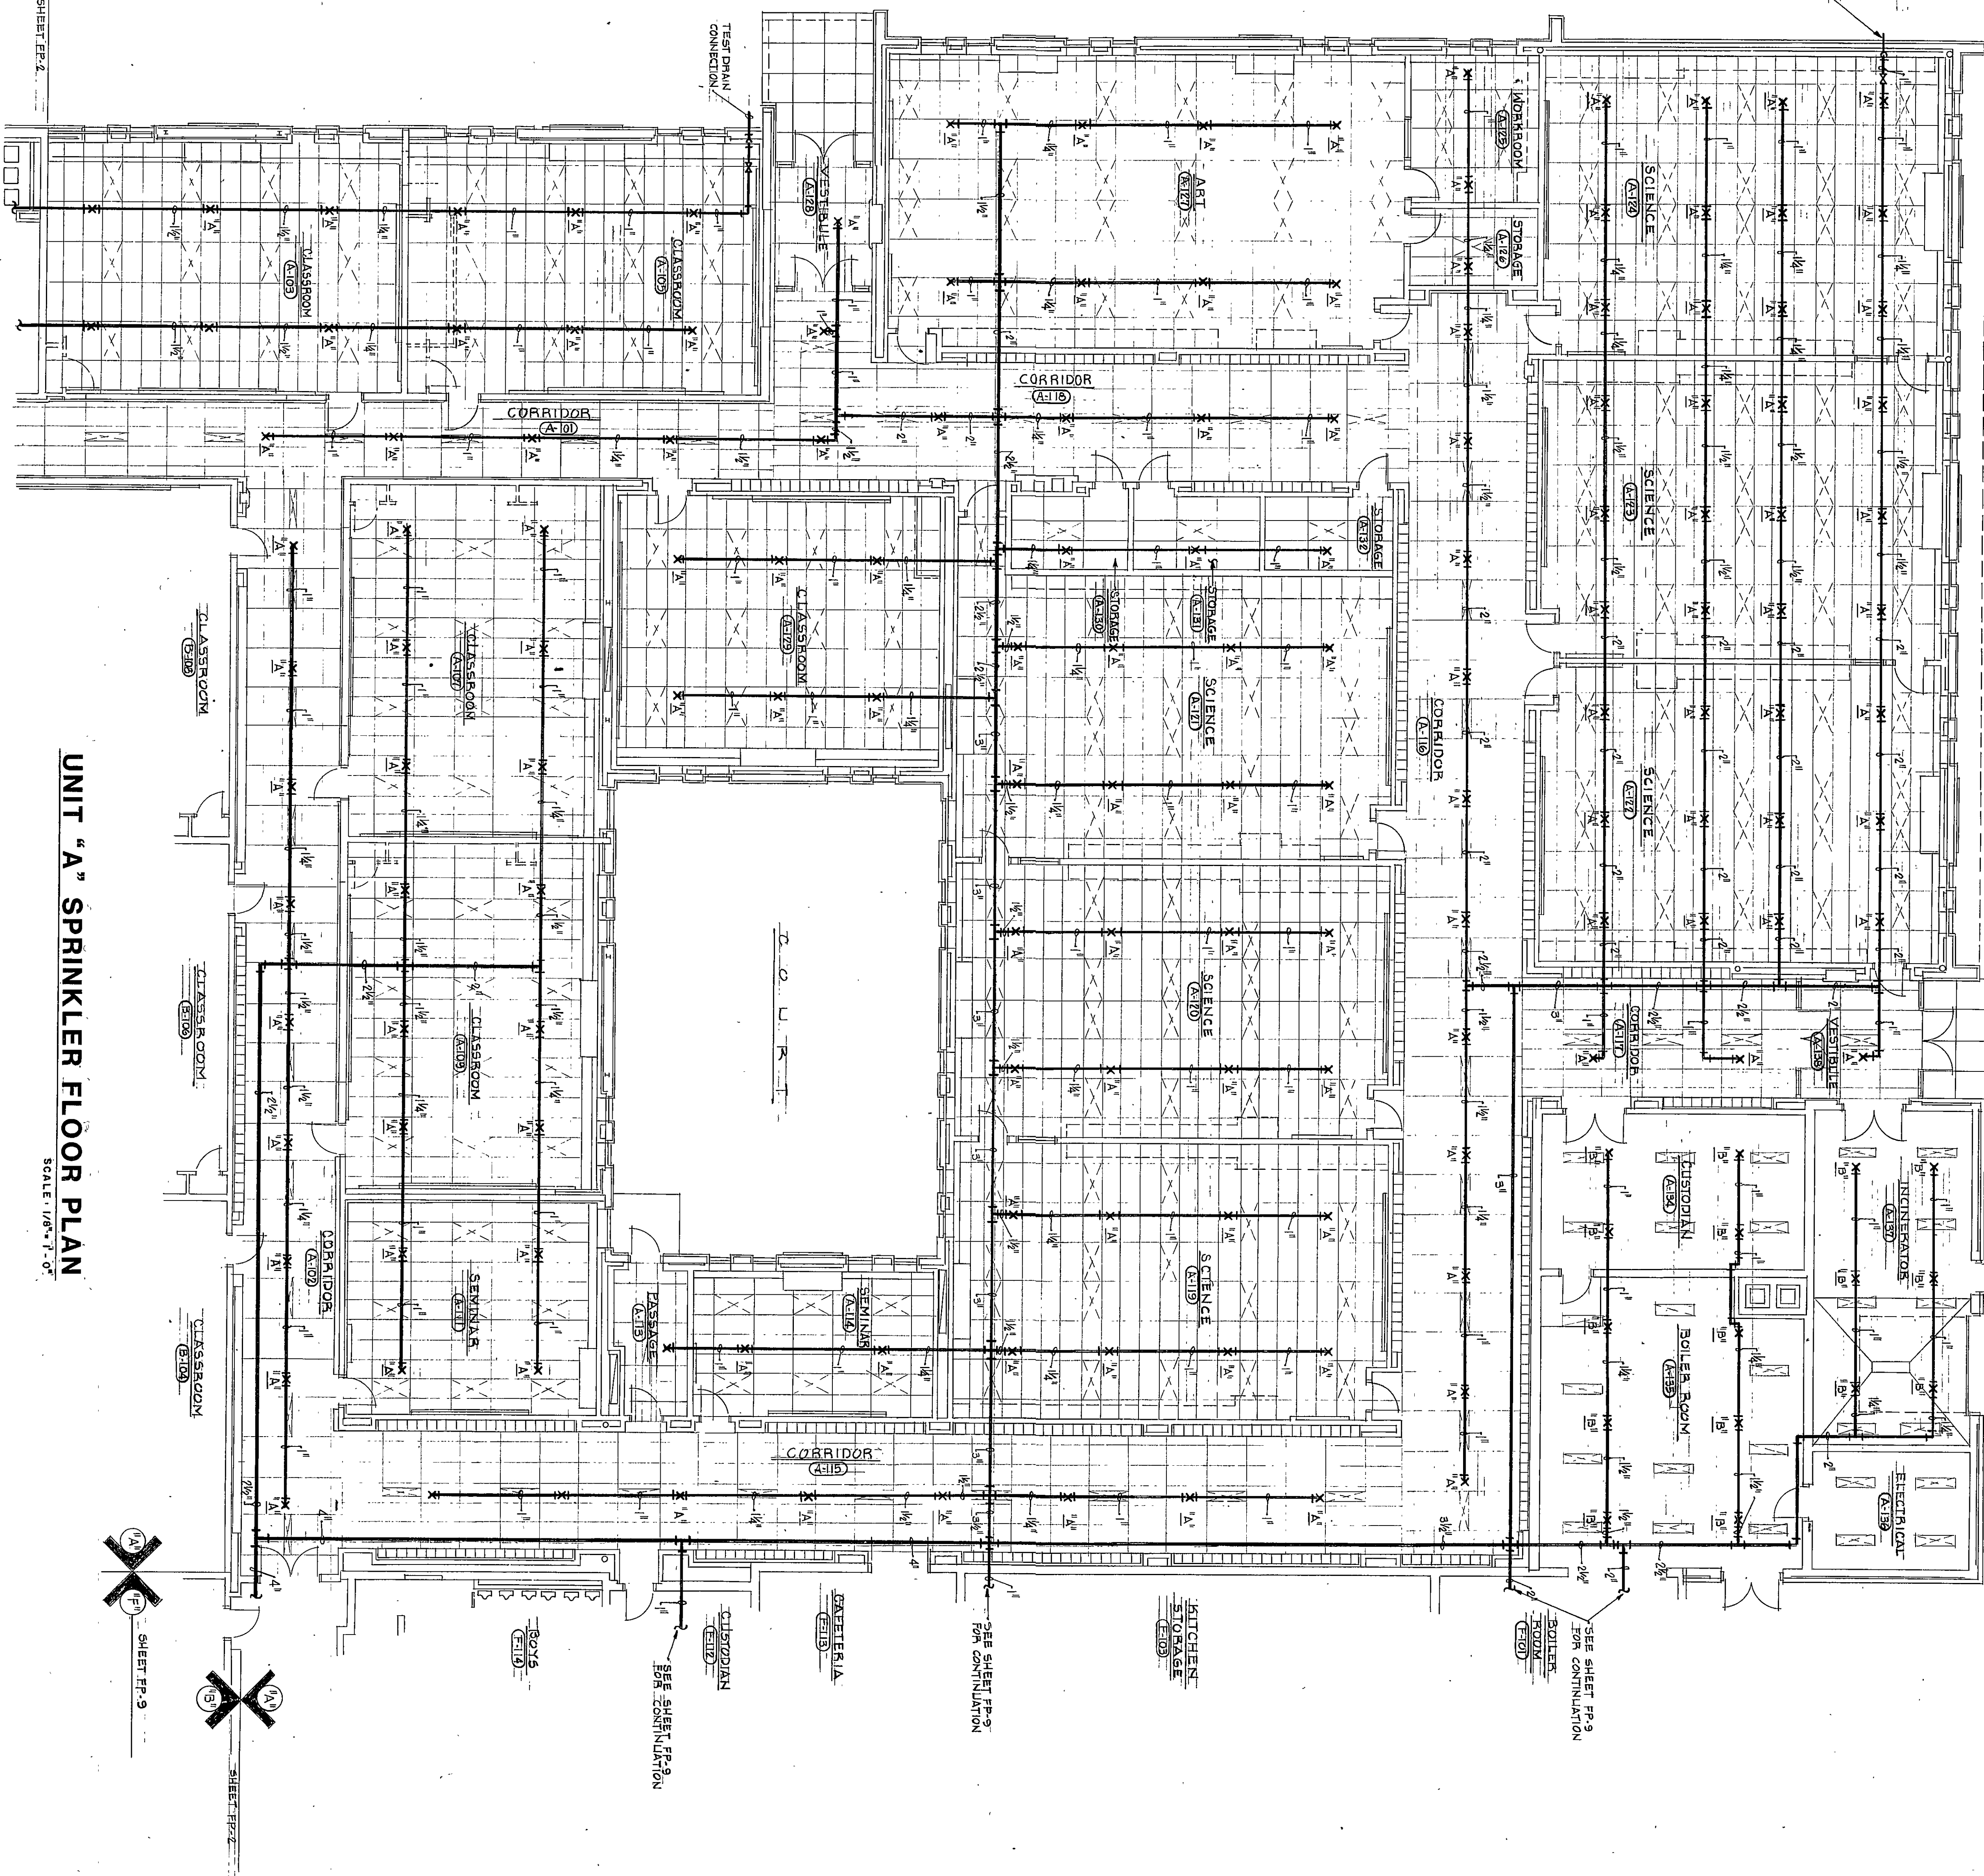

UNIT 'A' SPRINKLER FLOOR PLAN


SCALE: 1/8" = 1'-0"

SHEET FP-3


SHEET FP-3

SHEET FP-2

- PLAN NOTES
1. SEE SHEET M-3 FOR GENERAL NOTES, LEGEND AND SCHEDULES. SEE SHEET FP-3 FOR SPRINKLER SCHEDULE.
 2. THE SPRINKLER CONTRACTOR SHALL COORDINATE HIS WORK WITH THE VENTILATING CONTRACTOR AND THE ARCHITECTS REPRESENTATIVE BEFORE INSTALLING ANY SPRINKLER PIPING.
 3. SPRINKLER HEADS SHALL BE LOCATED AT CENTER OR QUARTER POINTS OF CEILING TILE. RANDOM LOCATIONS WILL NOT BE PERMITTED.
 4. THE SPRINKLER CONTRACTOR SHALL VERIFY THE CEILING GRID LOCATION WITH THE ARCHITECTS REPRESENTATIVE BEFORE INSTALLING ANY SPRINKLER PIPING.

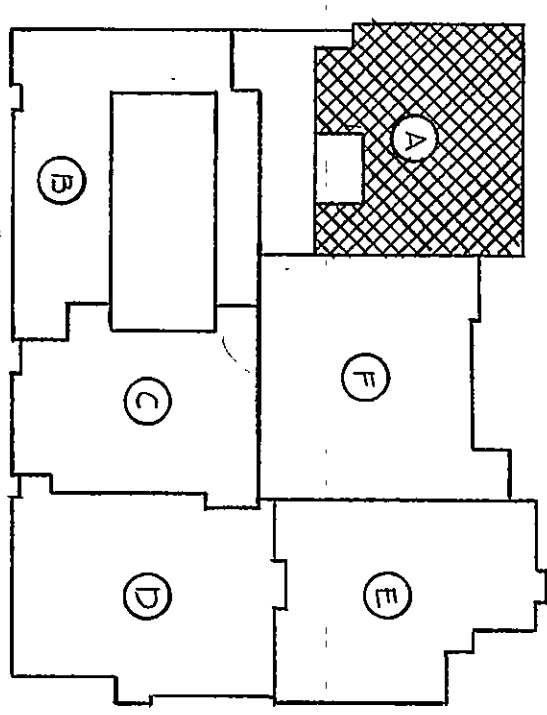

KEY PLAN
NO SCALE

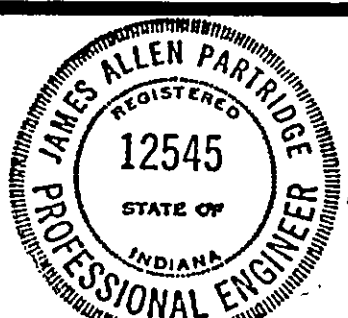

James A. Partridge

EVERETT · I · BROWN COMPANY
5500 WEST BRADBURY AVENUE · PARK FLETCHER ·
ADDITION TO AND RENOVATION OF LIBERTY MIDDLE SCHOOL

ARCHITECTS
ENGINEERS
• INDIANAPOLIS, INDIANA • 46241

PROJECT 12579.00
DATE MAY 3, 1982
REVISED

NO.FP-4
OF 10

87-P-01