



- PLAN NOTES
1. SEE SHEET M-3 FOR GENERAL NOTES, LEGEND AND SCHEDULES. SEE SHEET FP-3 FOR SPRINKLER SCHEDULE.
 2. THE SPRINKLER CONTRACTOR SHALL COORDINATE HIS WORK WITH THE VENTILATING CONTRACTOR, THE MECHANICAL CONTRACTOR AND THE ARCHITECTS REPRESENTATIVE BEFORE INSTALLING ANY SPRINKLER PIPING.
 3. SPRINKLER HEADS SHALL BE LOCATED AT CENTER OR 1/4" FROM CENTER OF CEILING TILE. RANDOM LOCATIONS WILL NOT BE TOLERATED.
 4. THE SPRINKLER CONTRACTOR SHALL VERIFY THE REPRESENTATIVE LOCATION WITH THE ARCHITECTS REPRESENTATIVE BEFORE INSTALLING ANY SPRINKLER PIPING.
 5. SPRINKLER HEADS SHALL BE LOCATED AS REQUIRED TO MISS MECHANICAL EQUIPMENT. ADDITIONAL HEADS SHALL BE PROVIDED IF REQUIRED TO GIVE COVERAGE.

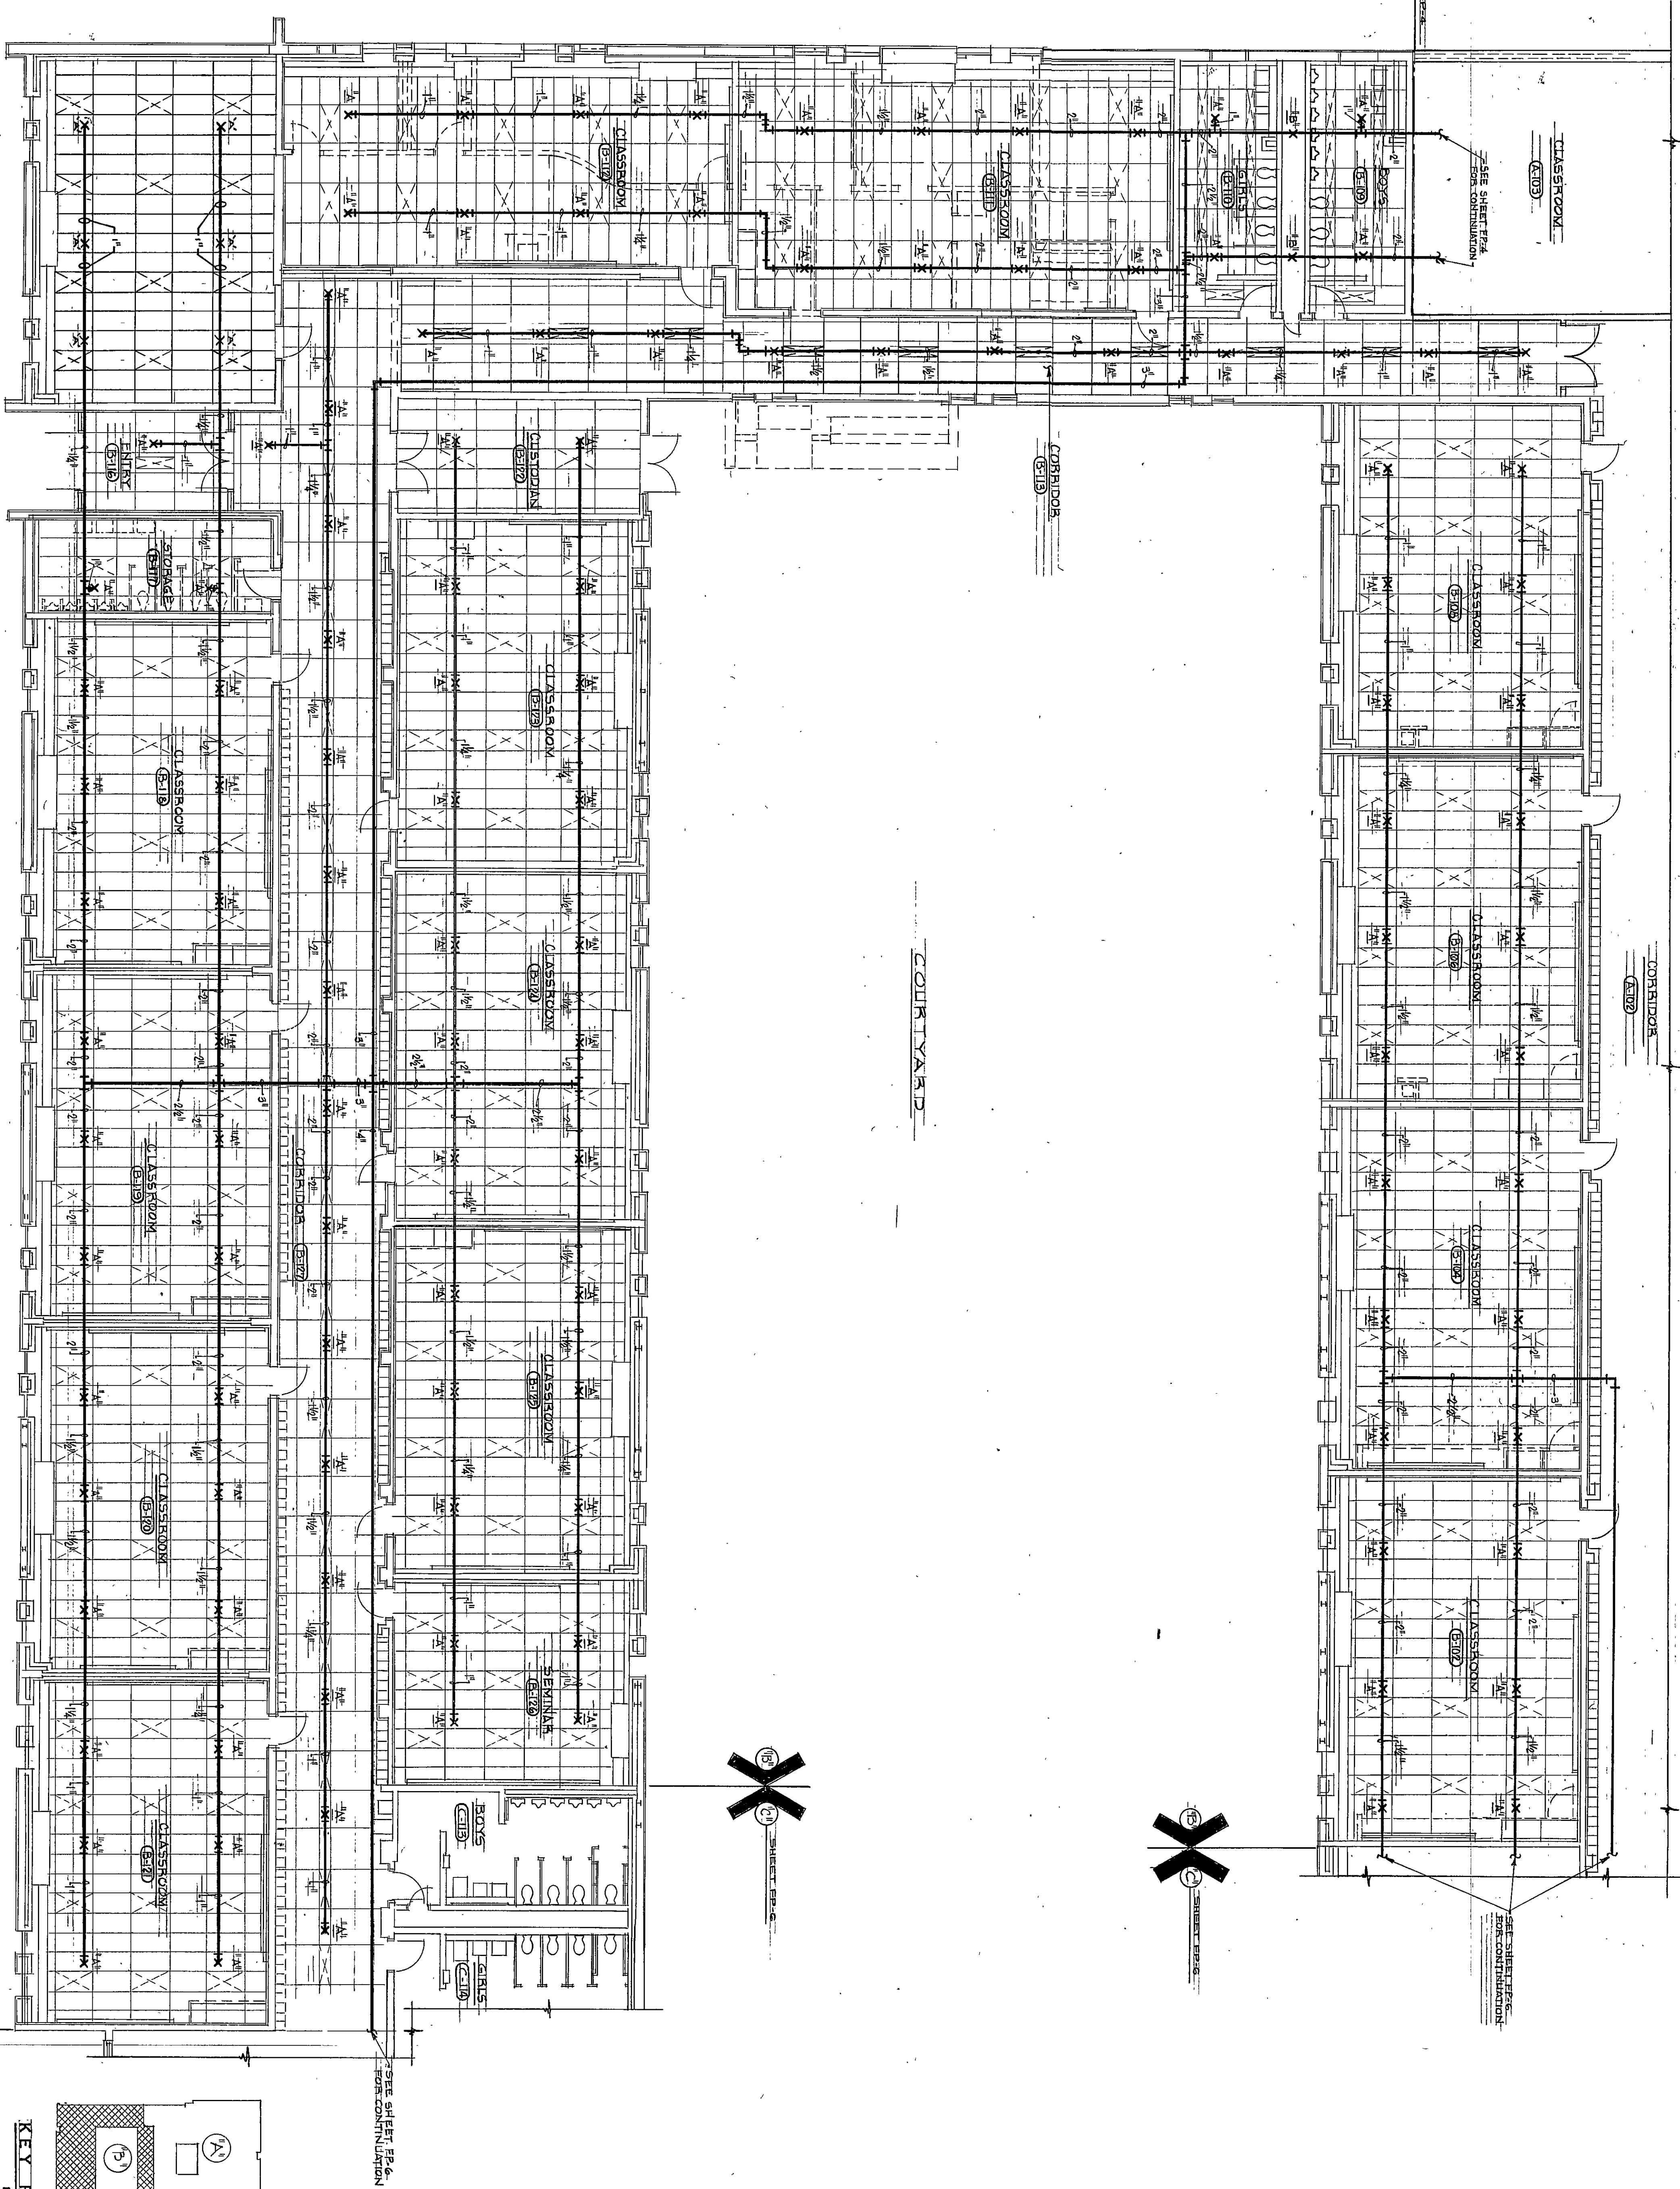

UNIT "B" SPRINKLER FLOOR PLAN

SCALE: 1/8" = 1'-0"

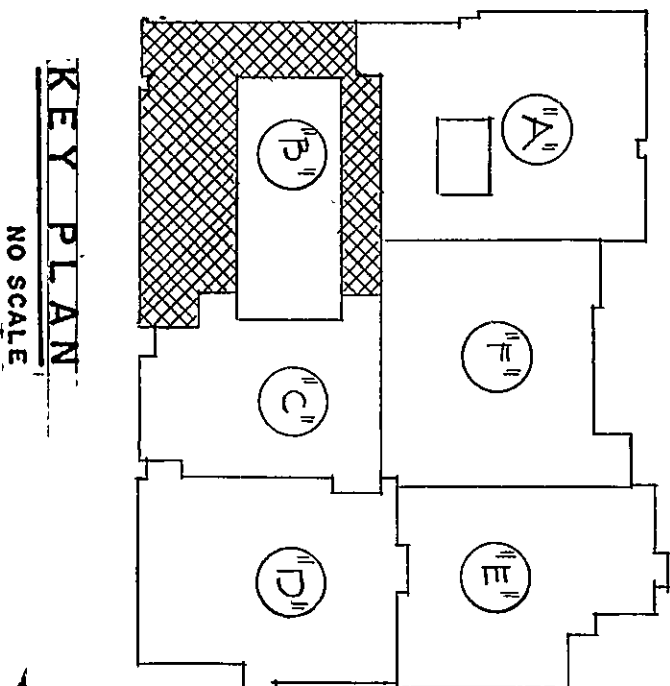

NORTH

EVERETT · I · BROWN COMPANY ARCHITECTS
5500 WEST BRADBURY AVENUE • PARK FLETCHER •
INDIANAPOLIS, INDIANA • 46241

ADDITION TO AND RENOVATION OF LIBERTY MIDDLE SCHOOL



James A. Partridge

PROJECT
12579.00
DATE
MAY 3, 1982
REVISED

NO. FP-5
OF 10

82-PP-02