


PLAN NOTES



1. SEE SHEET M-3 FOR GENERAL NOTES, LEGEND & SCHEDULES. SEE SHEET FP-3 FOR SPRINKLER SCHEDULE.
2. SPRINKLER HEADS SHALL BE 1" K-CLASS, 1/2" K-CLASS, OR 3/4" K-CLASS, DEPENDENT ON QUARTER POINTS OF CEILING TILE.
3. THE SPRINKLER CONTRACTOR SHALL COORDINATE HIS WORK WITH THE VENTILATING CONTRACTOR, THE MECHANICAL CONTRACTOR AND THE ARCHITECT'S REPRESENTATIVE BEFORE INSTALLING ANY SPRINKLER PIPING.
4. THE SPRINKLER CONTRACTOR SHALL VERIFY THE CEILING GRID LOCATION WITH THE ARCHITECT'S REPRESENTATIVE BEFORE INSTALLING ANY SPRINKLER PIPING.

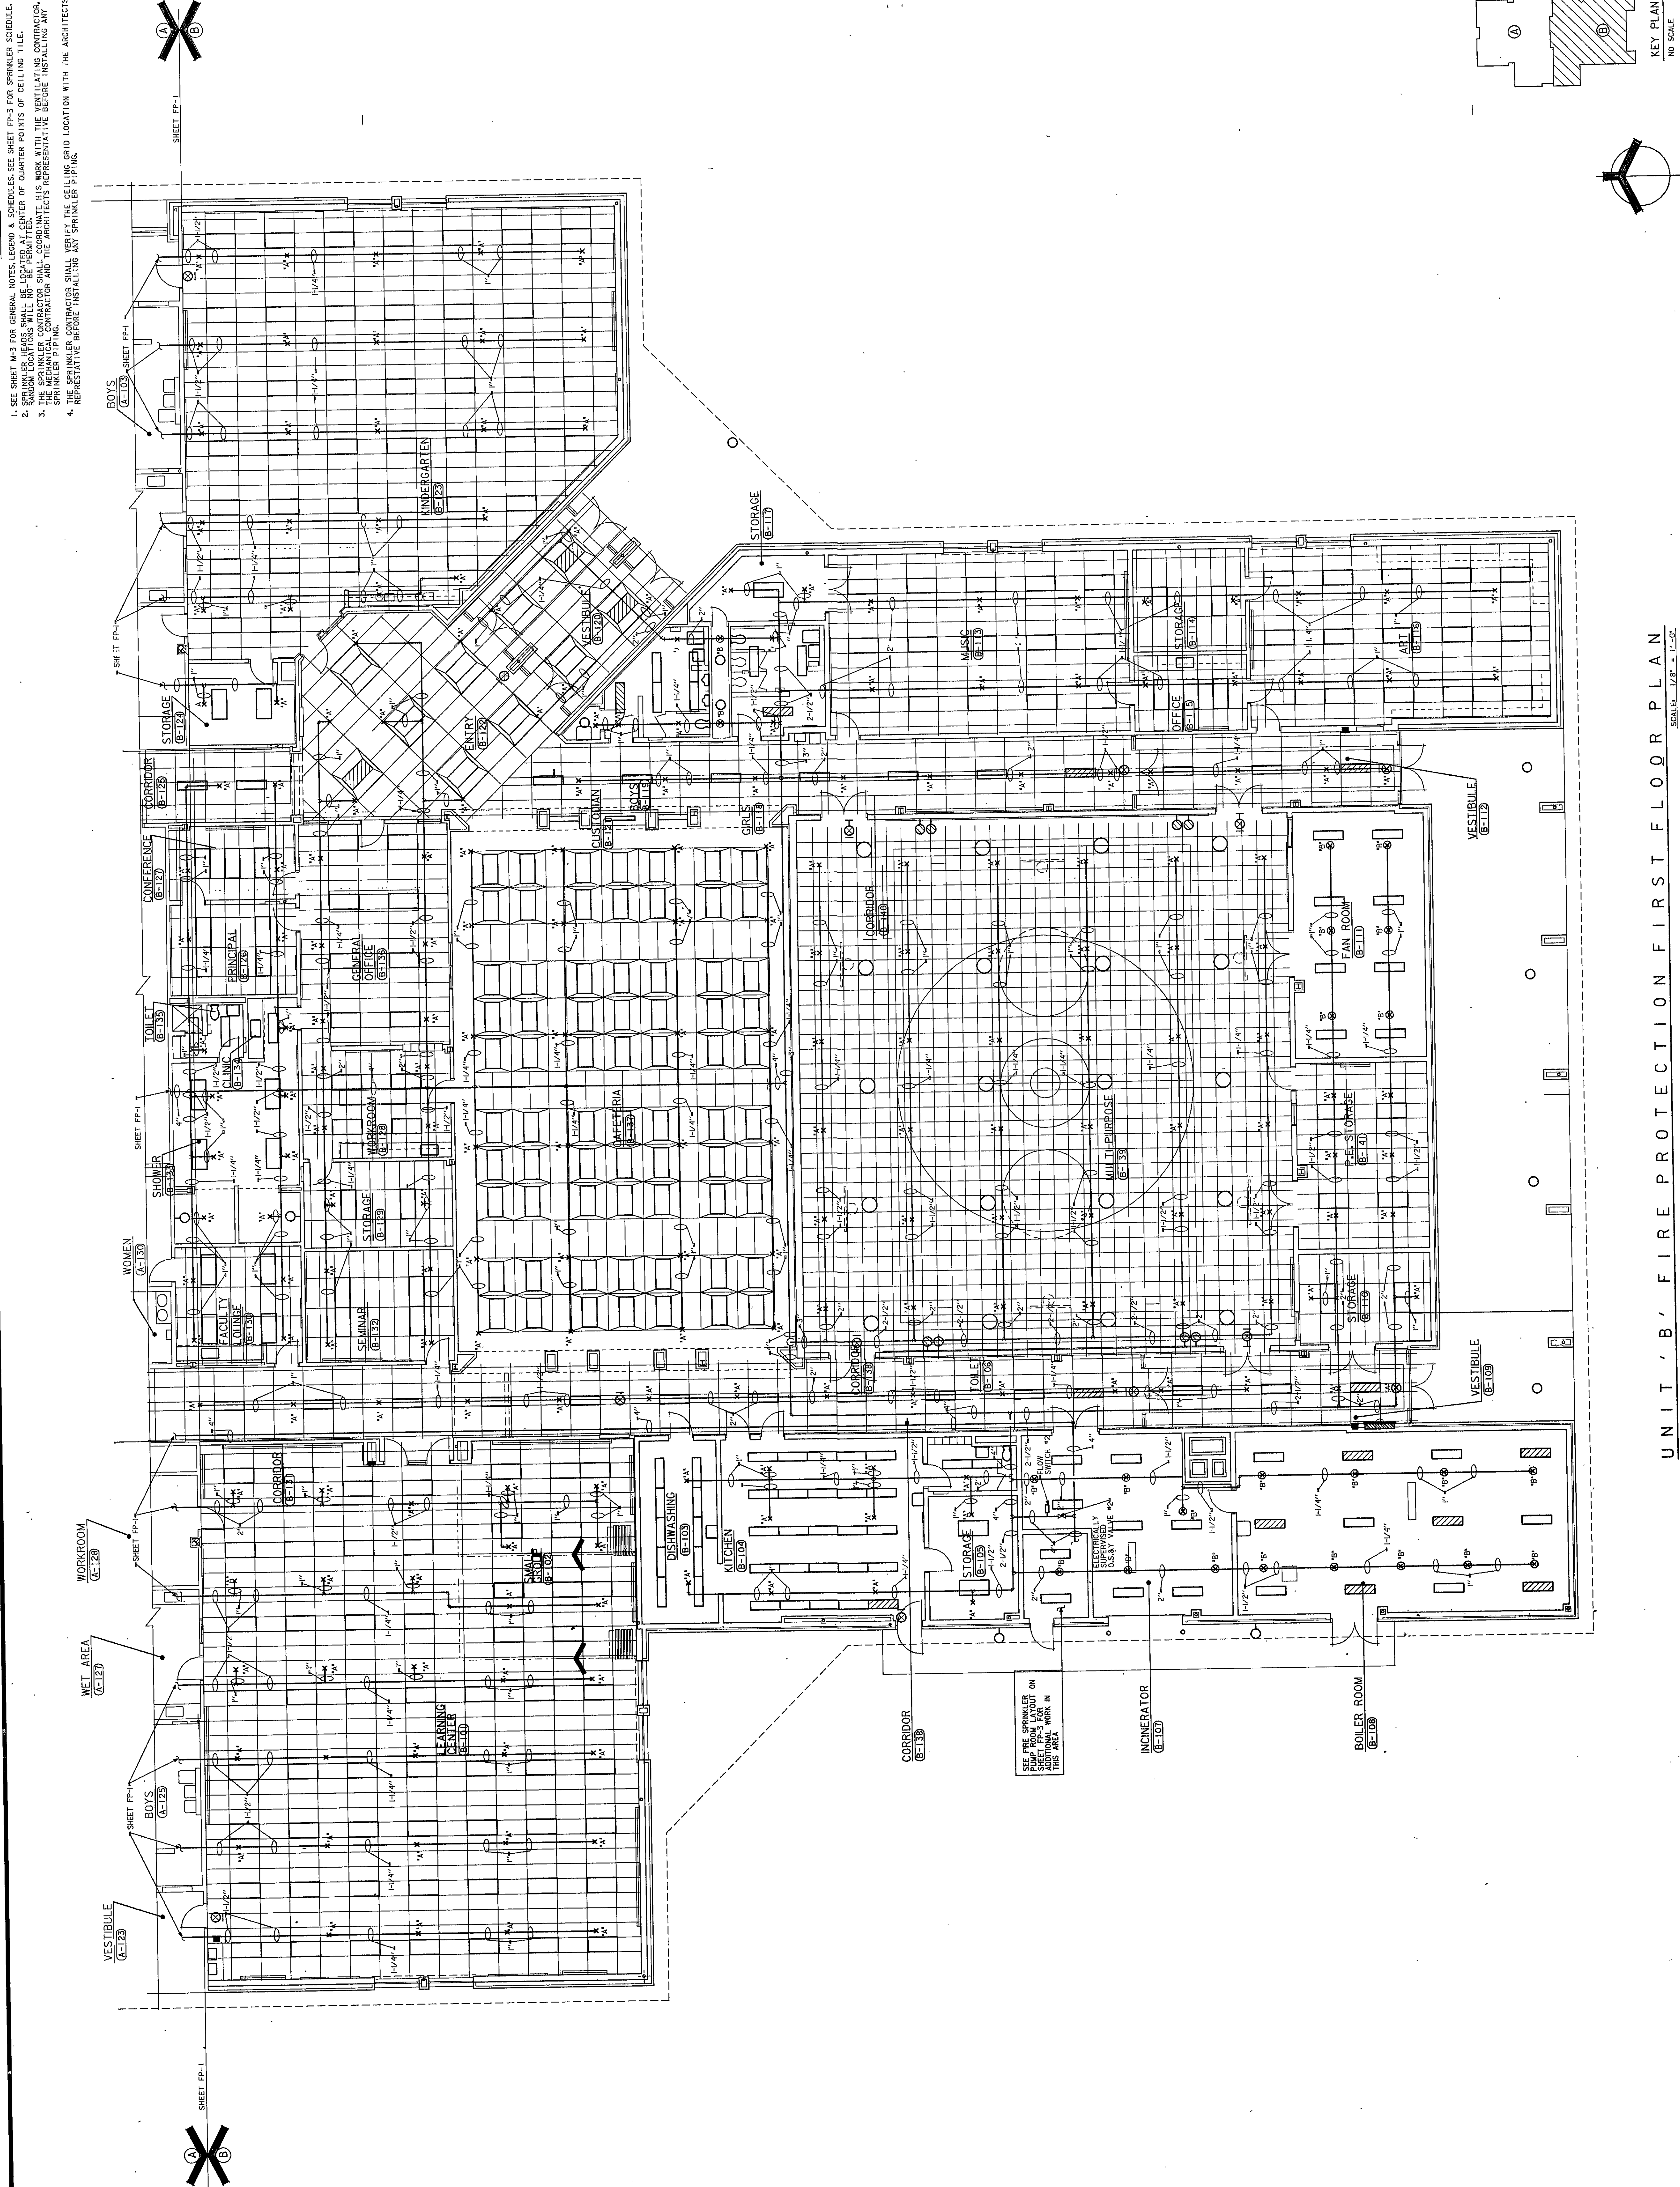


UNIT 'B', FIRE PROTECTION FIRST FLOOR PLAN

SCALE: 1/8" = 1'-0"

KEY PLAN
NO SCALE

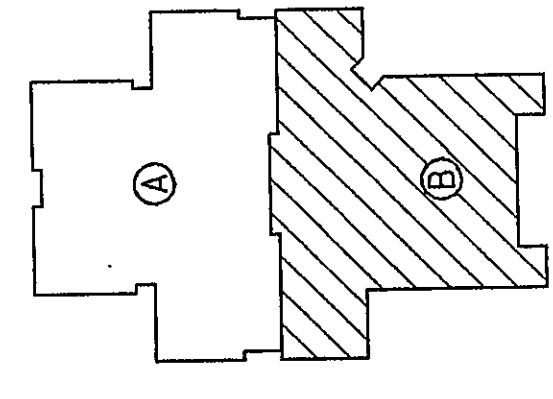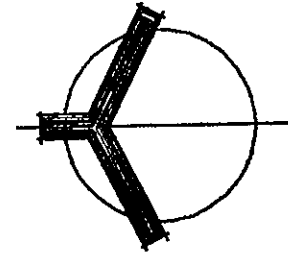

PROJECT	12579.00
DATE	MAY 3, 1982
REVISED	
NO. FP-2	OF 10

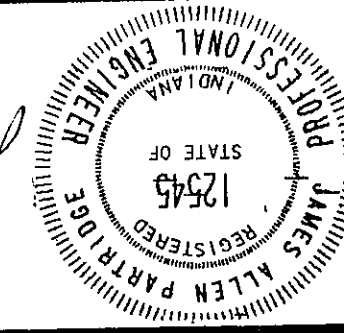

James A. Rindge