



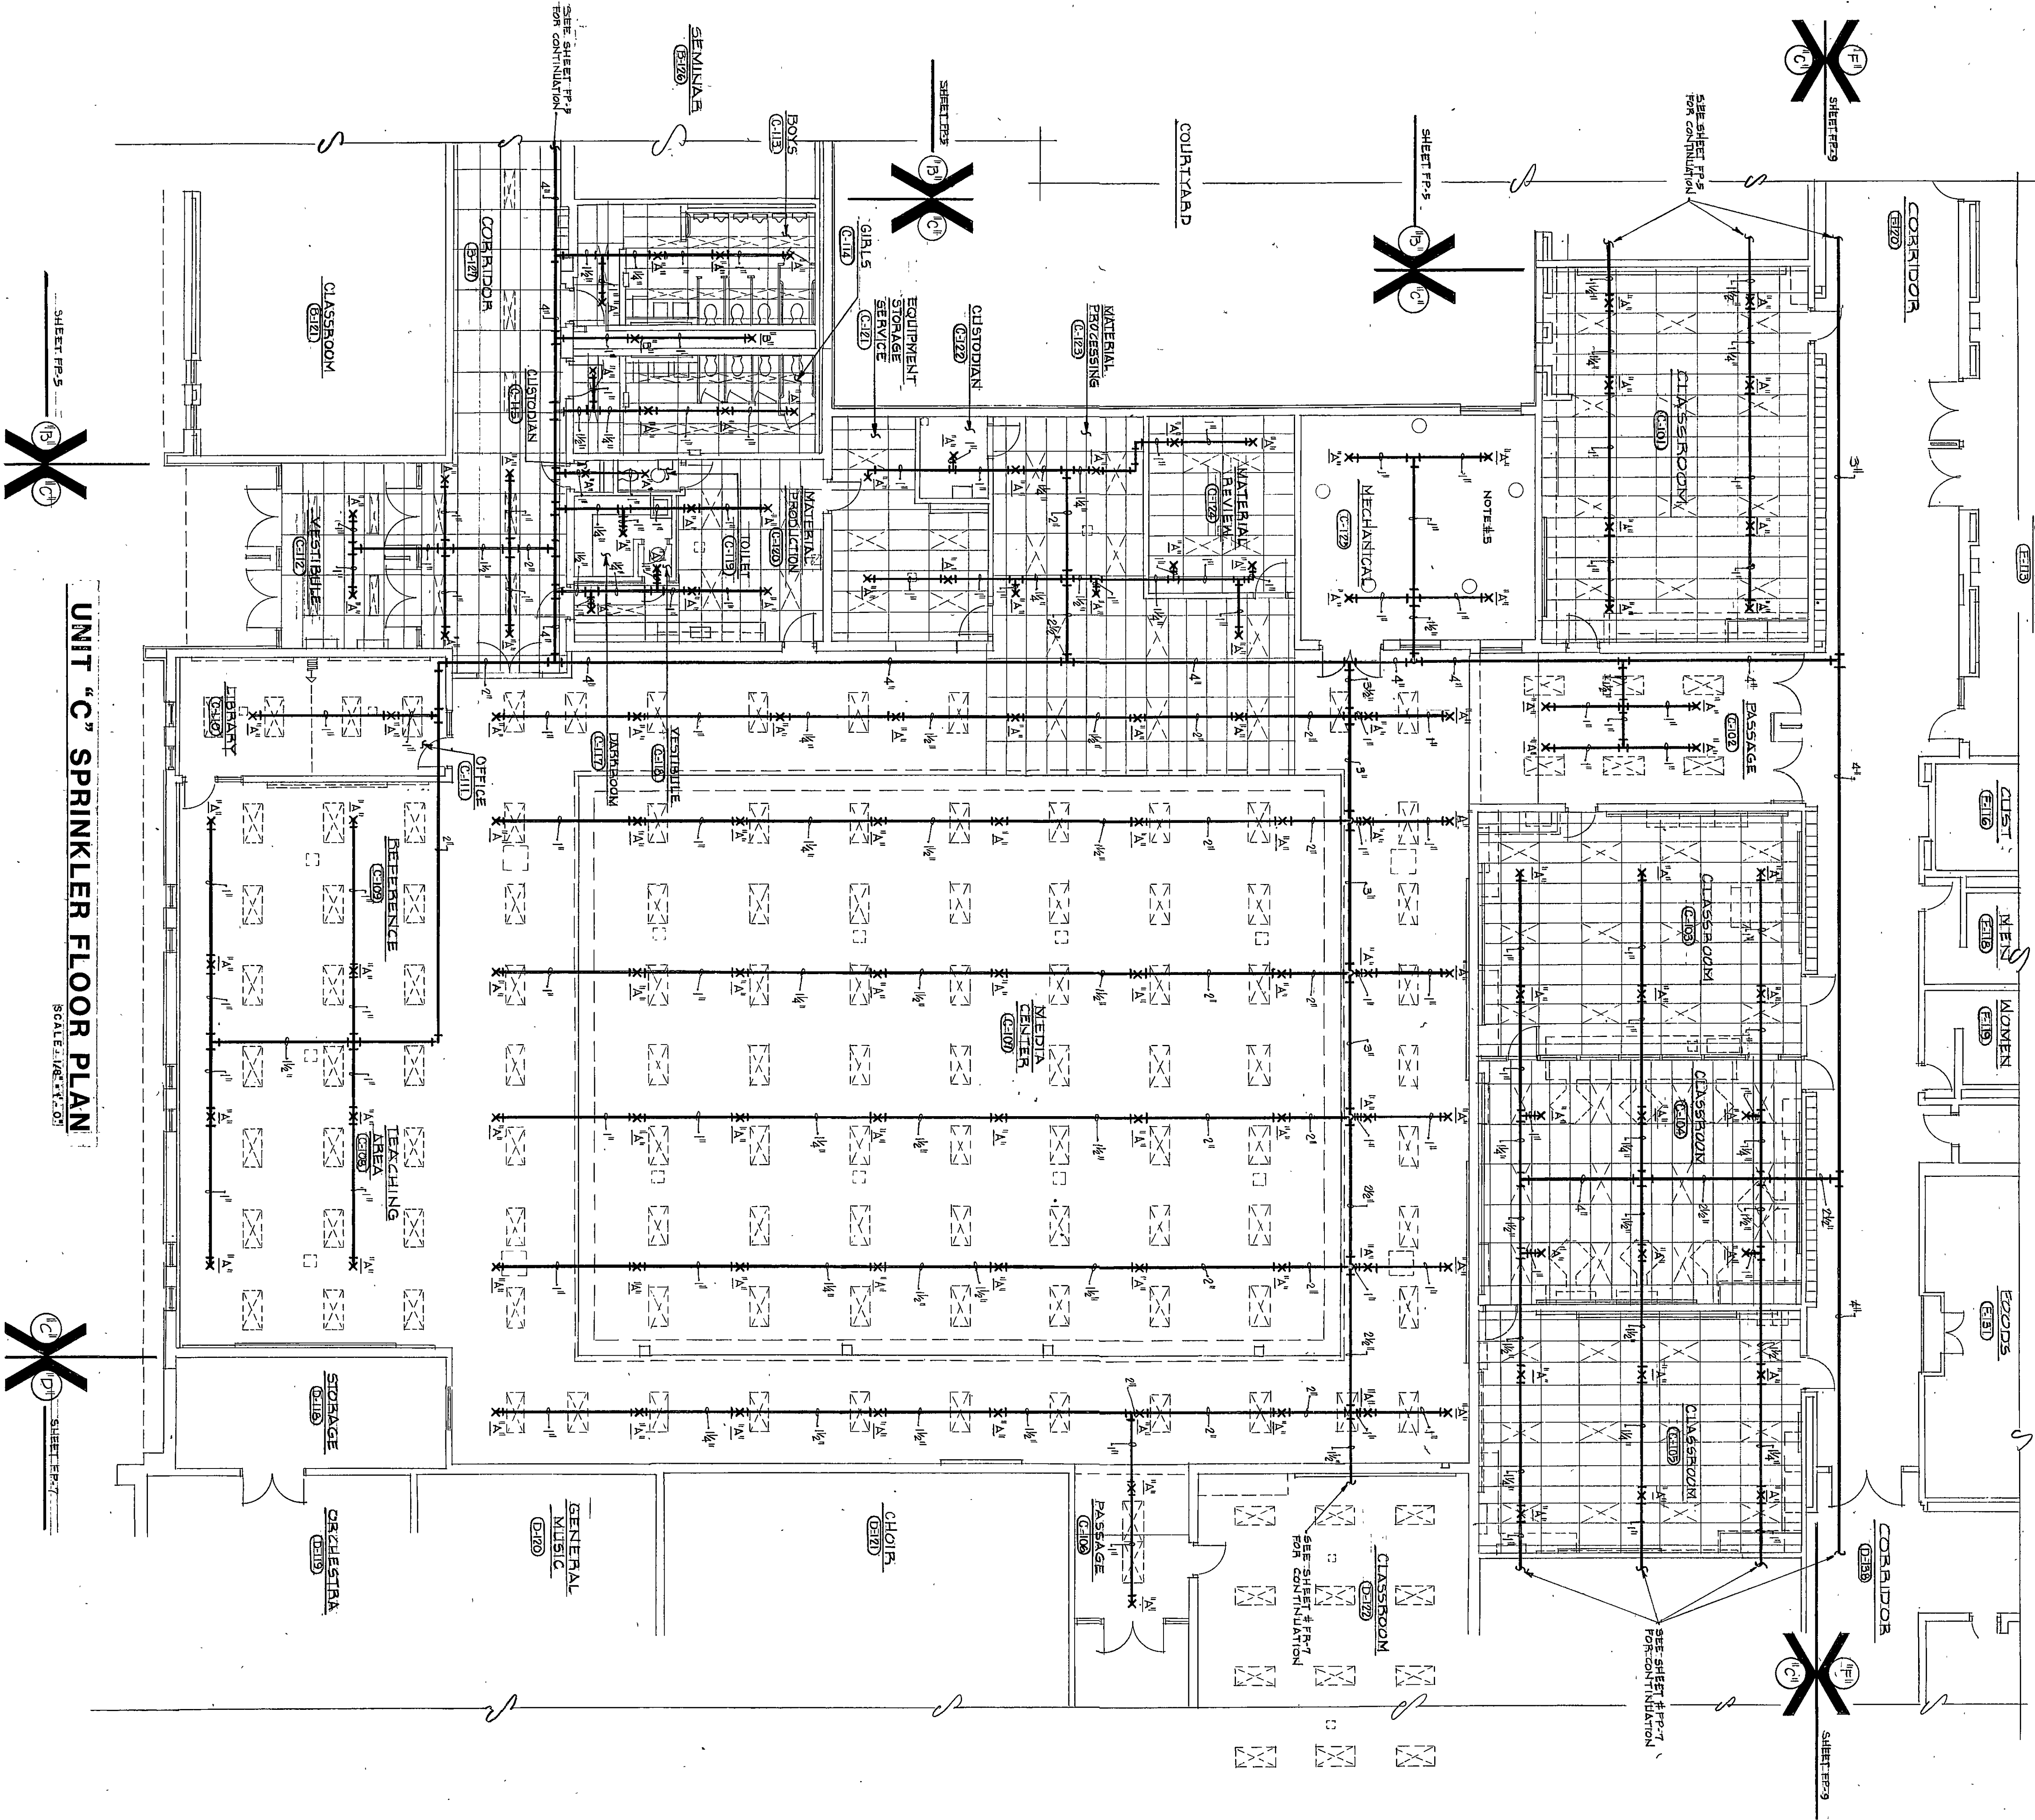

UNIT "C" SPRINKLER FLOOR PLAN

SCALE: 1/8" = 1'-0"


- PLAN NOTES
1. SEE SHEET W-3 FOR GENERAL NOTES, LEGEND AND SCHEDULES. SEE SHEET FP-3 FOR SPRINKLER SCHEDULES.
 2. THE SPRINKLER CONTRACTOR SHALL COORDINATE HIS WORK WITH THE MECHANICAL CONTRACTOR, THE ELECTRICAL CONTRACTOR, AND THE ARCHITECT'S REPRESENTATIVE BEFORE INSTALLING ANY SPRINKLER PIPING.
 3. SPRINKLER HEADS SHALL BE LOCATED AT CENTER OF QUARTER POINTS OF CEILING TILES. RANDOM LOCATIONS WILL NOT BE PERMITTED.
 4. THE SPRINKLER CONTRACTOR SHALL VERIFY THE REPRESENTATIVE BEFORE INSTALLING ANY SPRINKLER PIPING.
 5. SPRINKLER HEADS SHALL BE LOCATED AS REQUIRED BY THE SPRINKLER CONTRACTOR. ADDITIONAL HEADS SHALL BE PROVIDED IF REQUIRED TO GIVE COVERAGE.

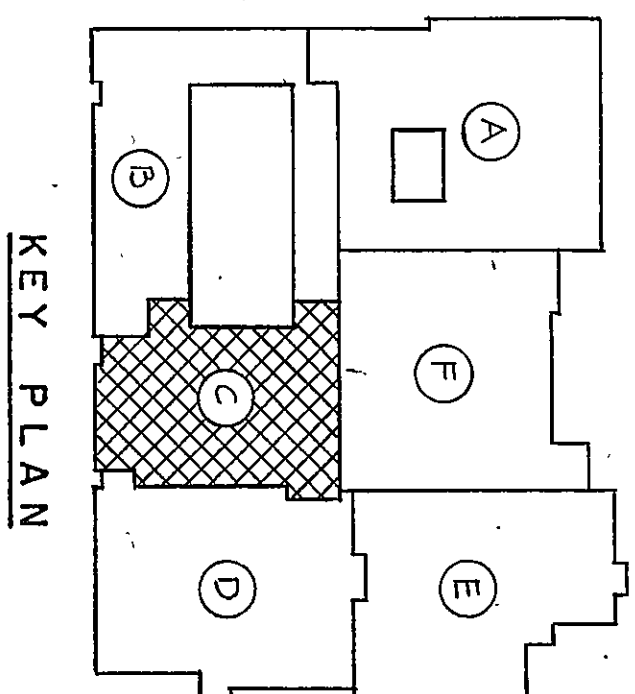

KEY PLAN

NO SCALE

PROJECT
12579.00
DATE
MAY 3, 1982
REVISED

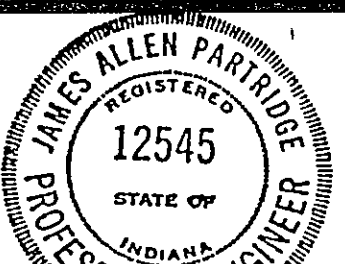

James A. Rutledge

EVERETT · I · BROWN COMPANY
5500 WEST BRADBURY AVENUE · PARK FLETCHER · INDIANAPOLIS, INDIANA · 46241

ADDITION TO AND RENOVATION OF LIBERTY MIDDLE SCHOOL

ARCHITECTS
ENGINEERS