



11
X
E

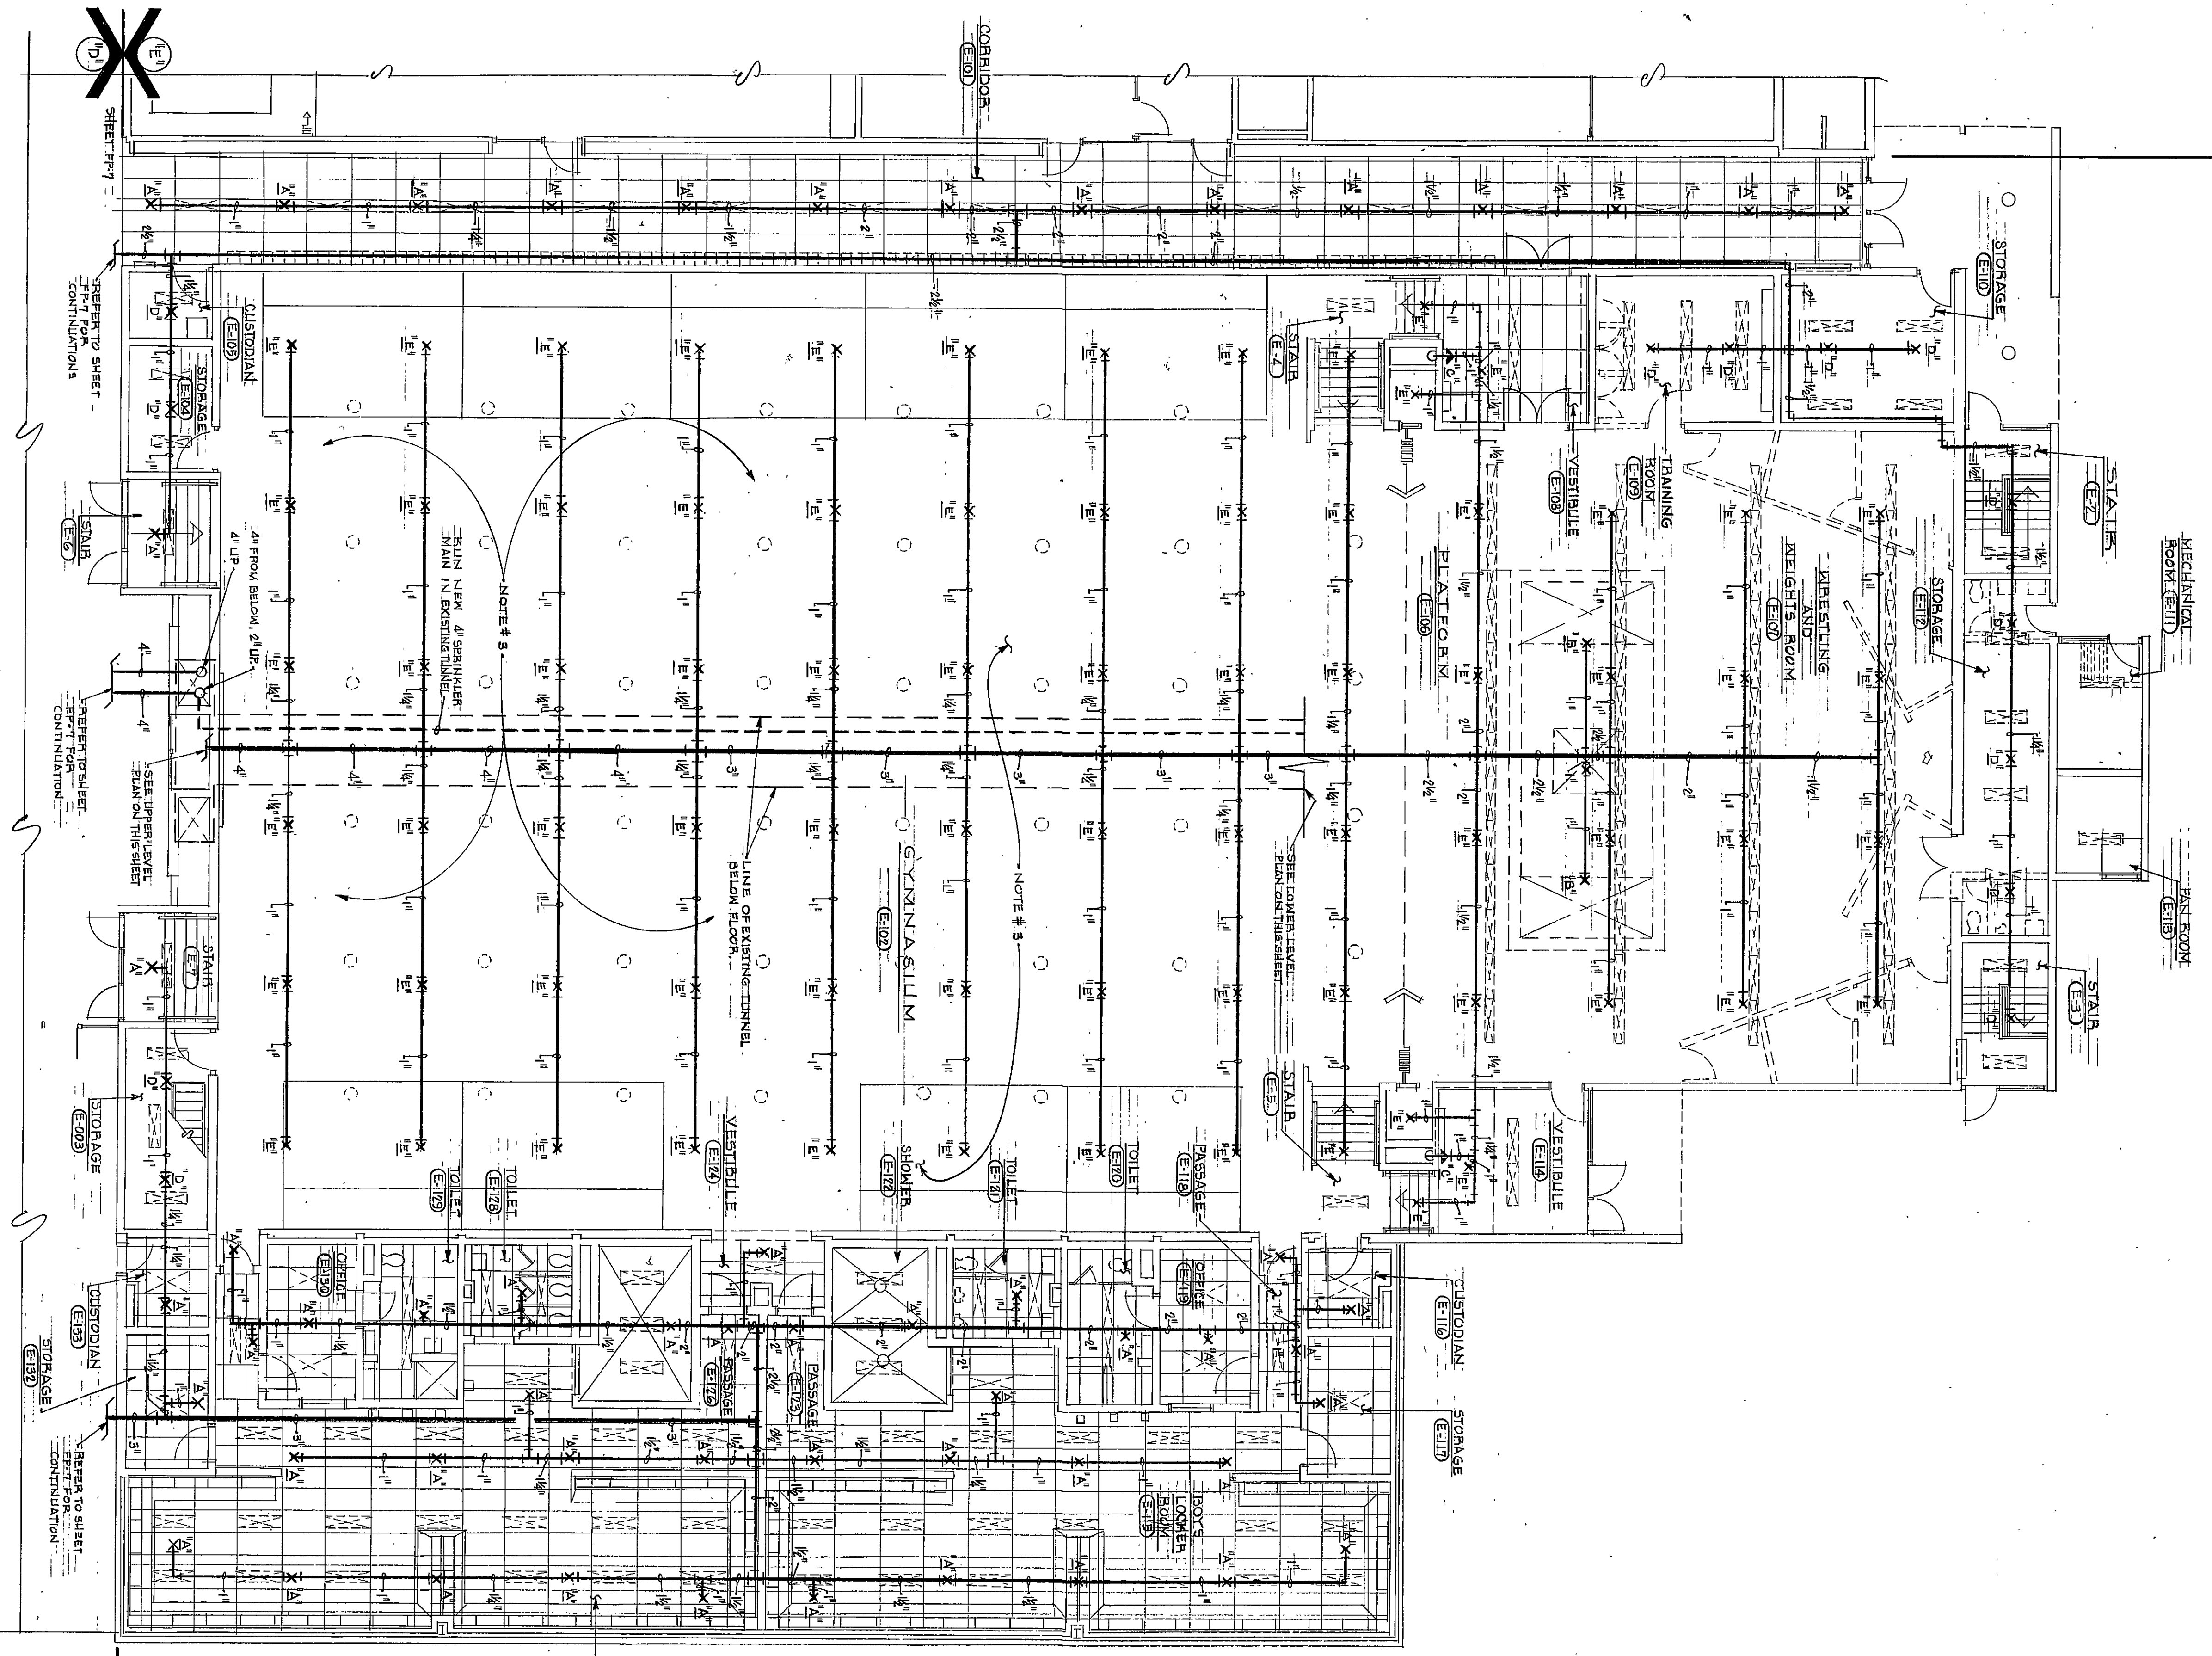

UNIT "E" SPRINKLER FLOOR PLAN
SCALE 1/8" = 1'-0"

11
X
E

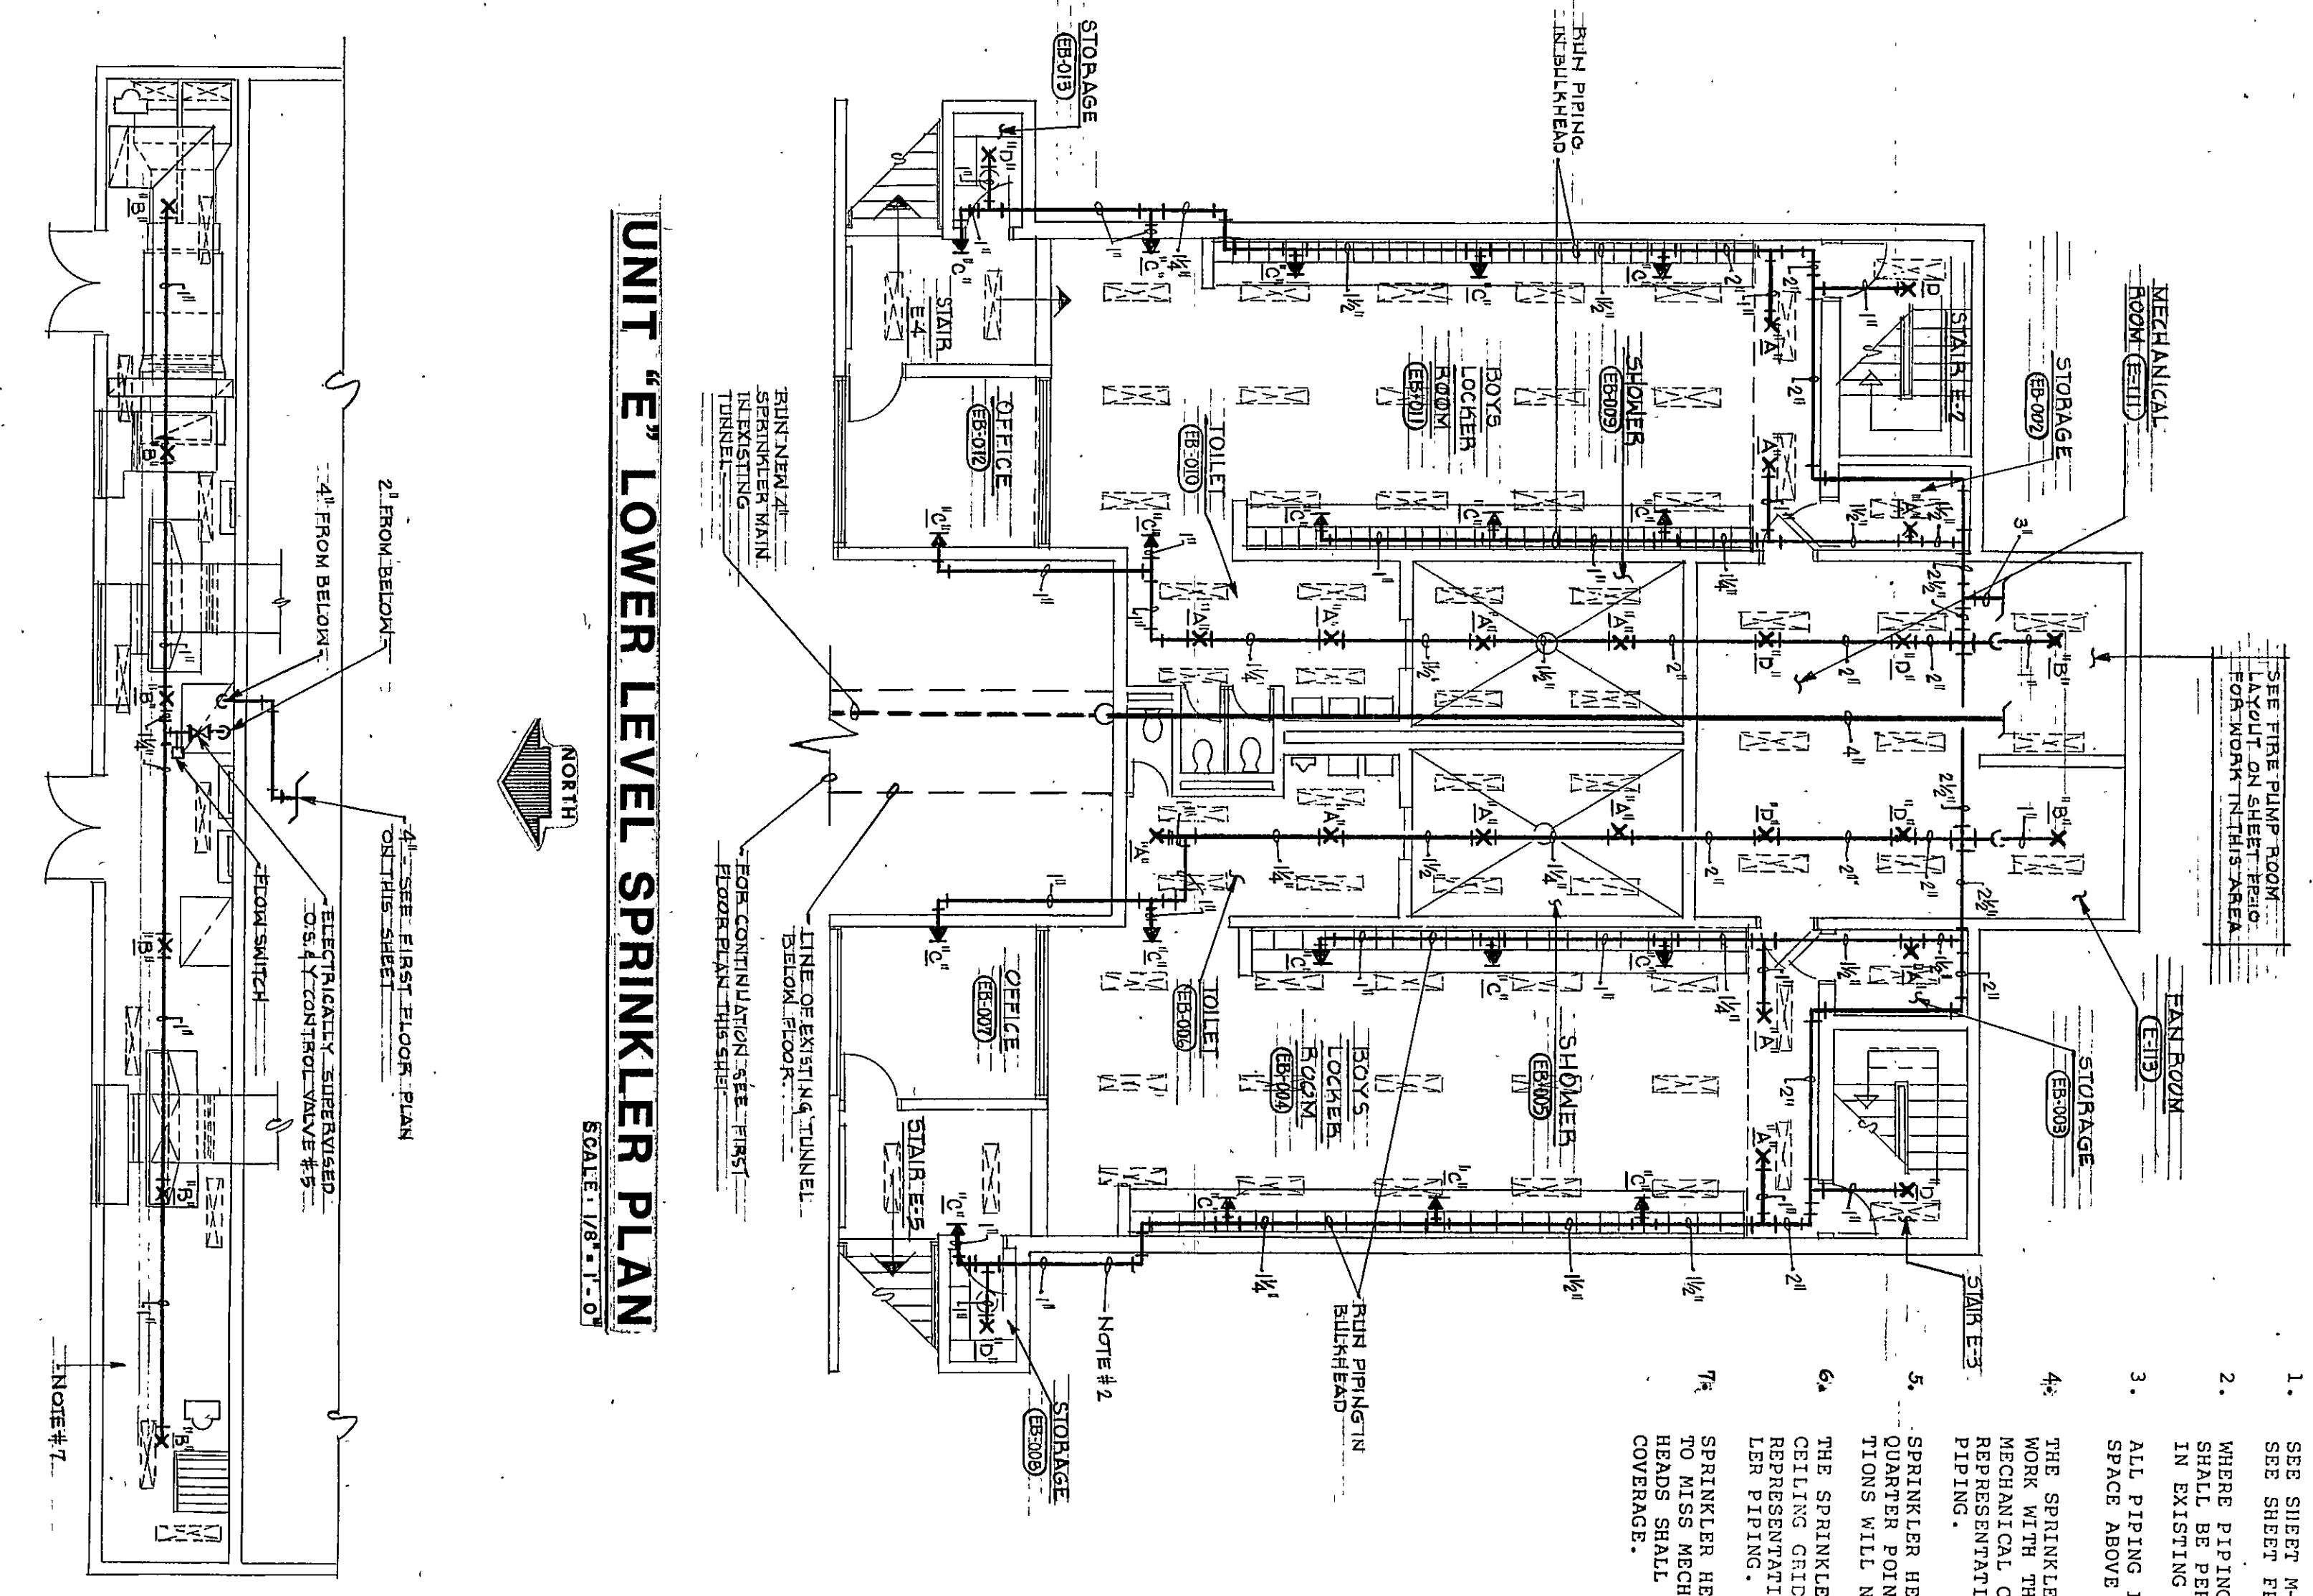

UNIT "E" LOWER LEVEL SPRINKLER PLAN
SCALE 1/8" = 1'-0"


UNIT "E" UPPER LEVEL SPRINKLER PLAN
SCALE 1/8" = 1'-0"

- PLAN NOTES
- SEE SHEET N-3 FOR GENERAL NOTES, LEGEND AND SCHEDULES.
 - SEE SHEET P-3 FOR SPRINKLER SCHEDULE.
 - WHERE PIPING IS RUN BELOW EXISTING FLOOR SLAB, WORK SHALL BE PERFORMED AS SHOWN IN "DETAIL SHOWING CUTS IN EXISTING FINISHED SURFACES" ON SHEET N-28.
 - ALL PIPING IN THIS AREA SHALL BE RUN IN CONCEALED SPACE ABOVE EXISTING METAL DECK CEILING.
 - THE SPRINKLER CONTRACTOR SHALL COORDINATE HIS WORK WITH THE VENTILATION CONTRACTOR AND THE ARCHITECTS REPRESENTATIVE BEFORE INSTALLING ANY SPRINKLER PIPING.
 - SPRINKLER HEADS SHALL BE LOCATED AT CENTER OR TIONS WILL NOT BE PERMITTED.
 - THE SPRINKLER CONTRACTOR SHALL VERIFY THE REPRESENTATIVE'S BEFORE INSTALLING ANY SPRINKLER PIPING.
 - SPRINKLER HEADS SHALL BE LOCATED AS REQUIRED TO THIS MECHANICAL EQUIPMENT. HEADS SHALL BE PROVIDED TO GIVE COVERAGE.


NORTH

NORTH

NORTH

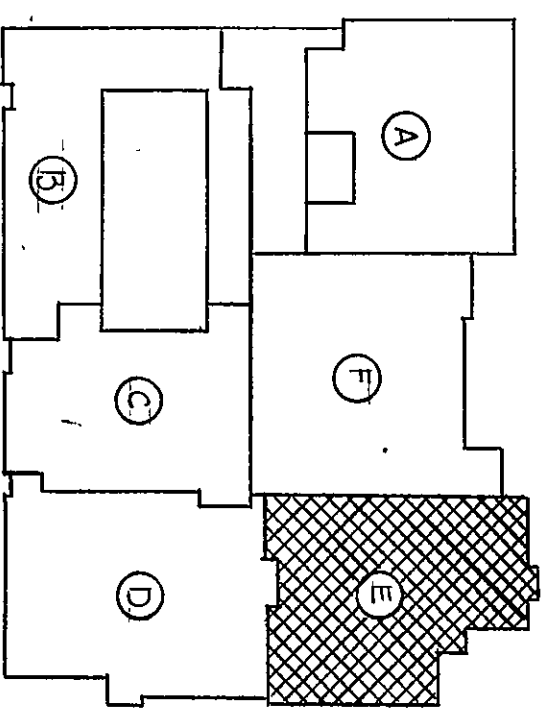

KEY PLAN
NO SCALE

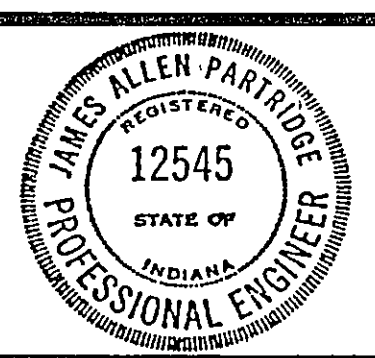

James A. Partidge

PROJECT
12579.00
DATE
MAY 3, 1982
REVISED

NO FP-8
OF 10

82-FP-05