



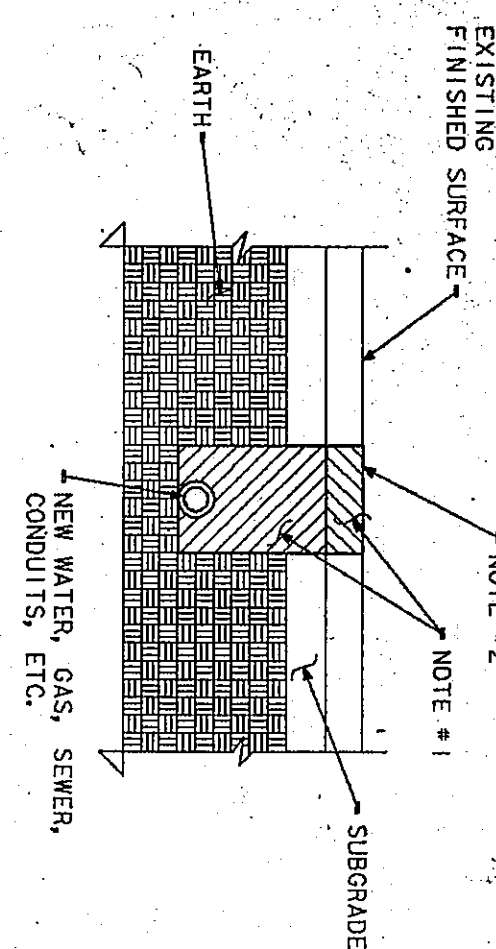

DETAIL SHOWING CUTS IN EXISTING FINISHED SURFACES


NOTES:

1. THE CONTRACTOR SHALL MAKE THE CUT, EXCAVATE, INSTALL NEW SERVICE, INSTALL AN ADAPTER, BACKFILL, BACKFILL TO TOP OF SUBGRADE, AND FINISH SURFACE.
2. WHERE SHOWN ON THE ARCHITECTURAL OR STRUCTURAL DRAWINGS, FINAL FINISHED SURFACES FOR CUTS NOT NOTED ON THE ARCHITECTURAL DRAWINGS SHALL BE THE RESPONSIBILITY OF THE CONTRACTOR MAKING THE CUTS.

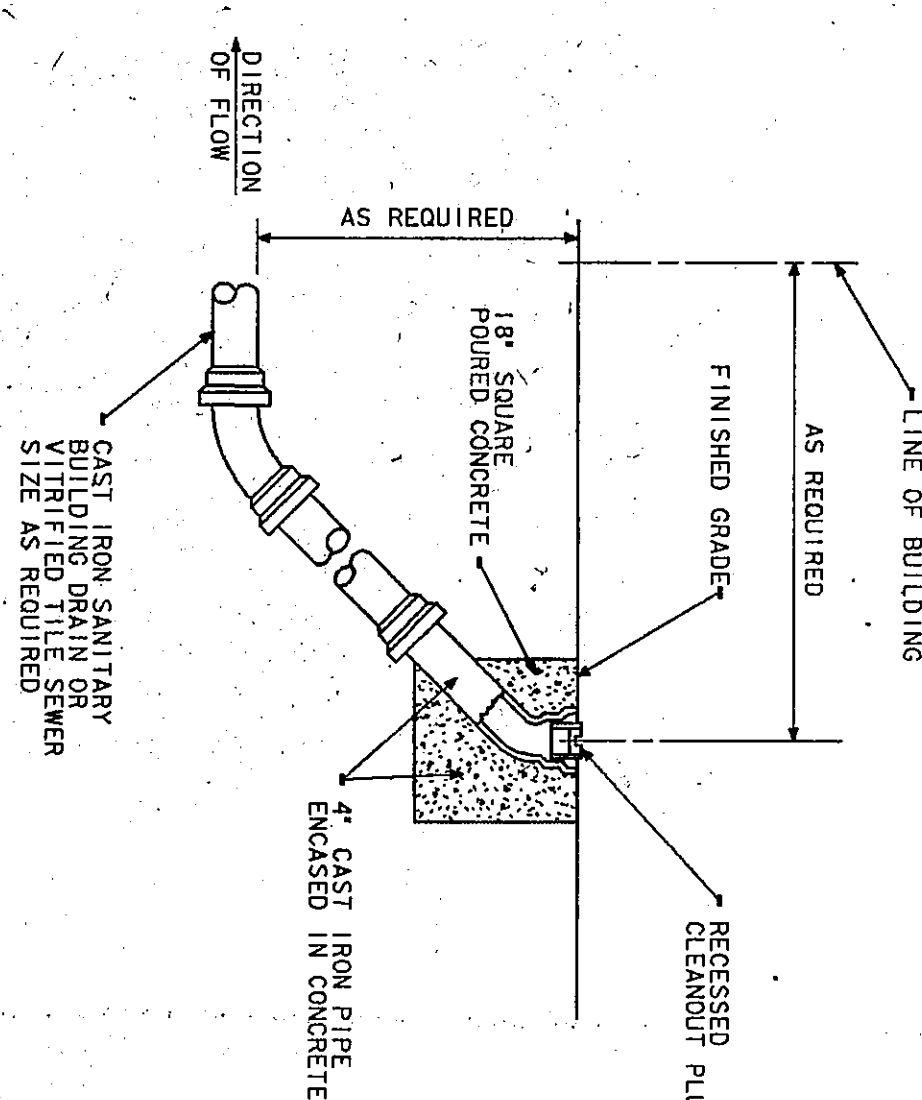


DETAIL OF TYPICAL OUTSIDE CLEANOUT

NO SCALE

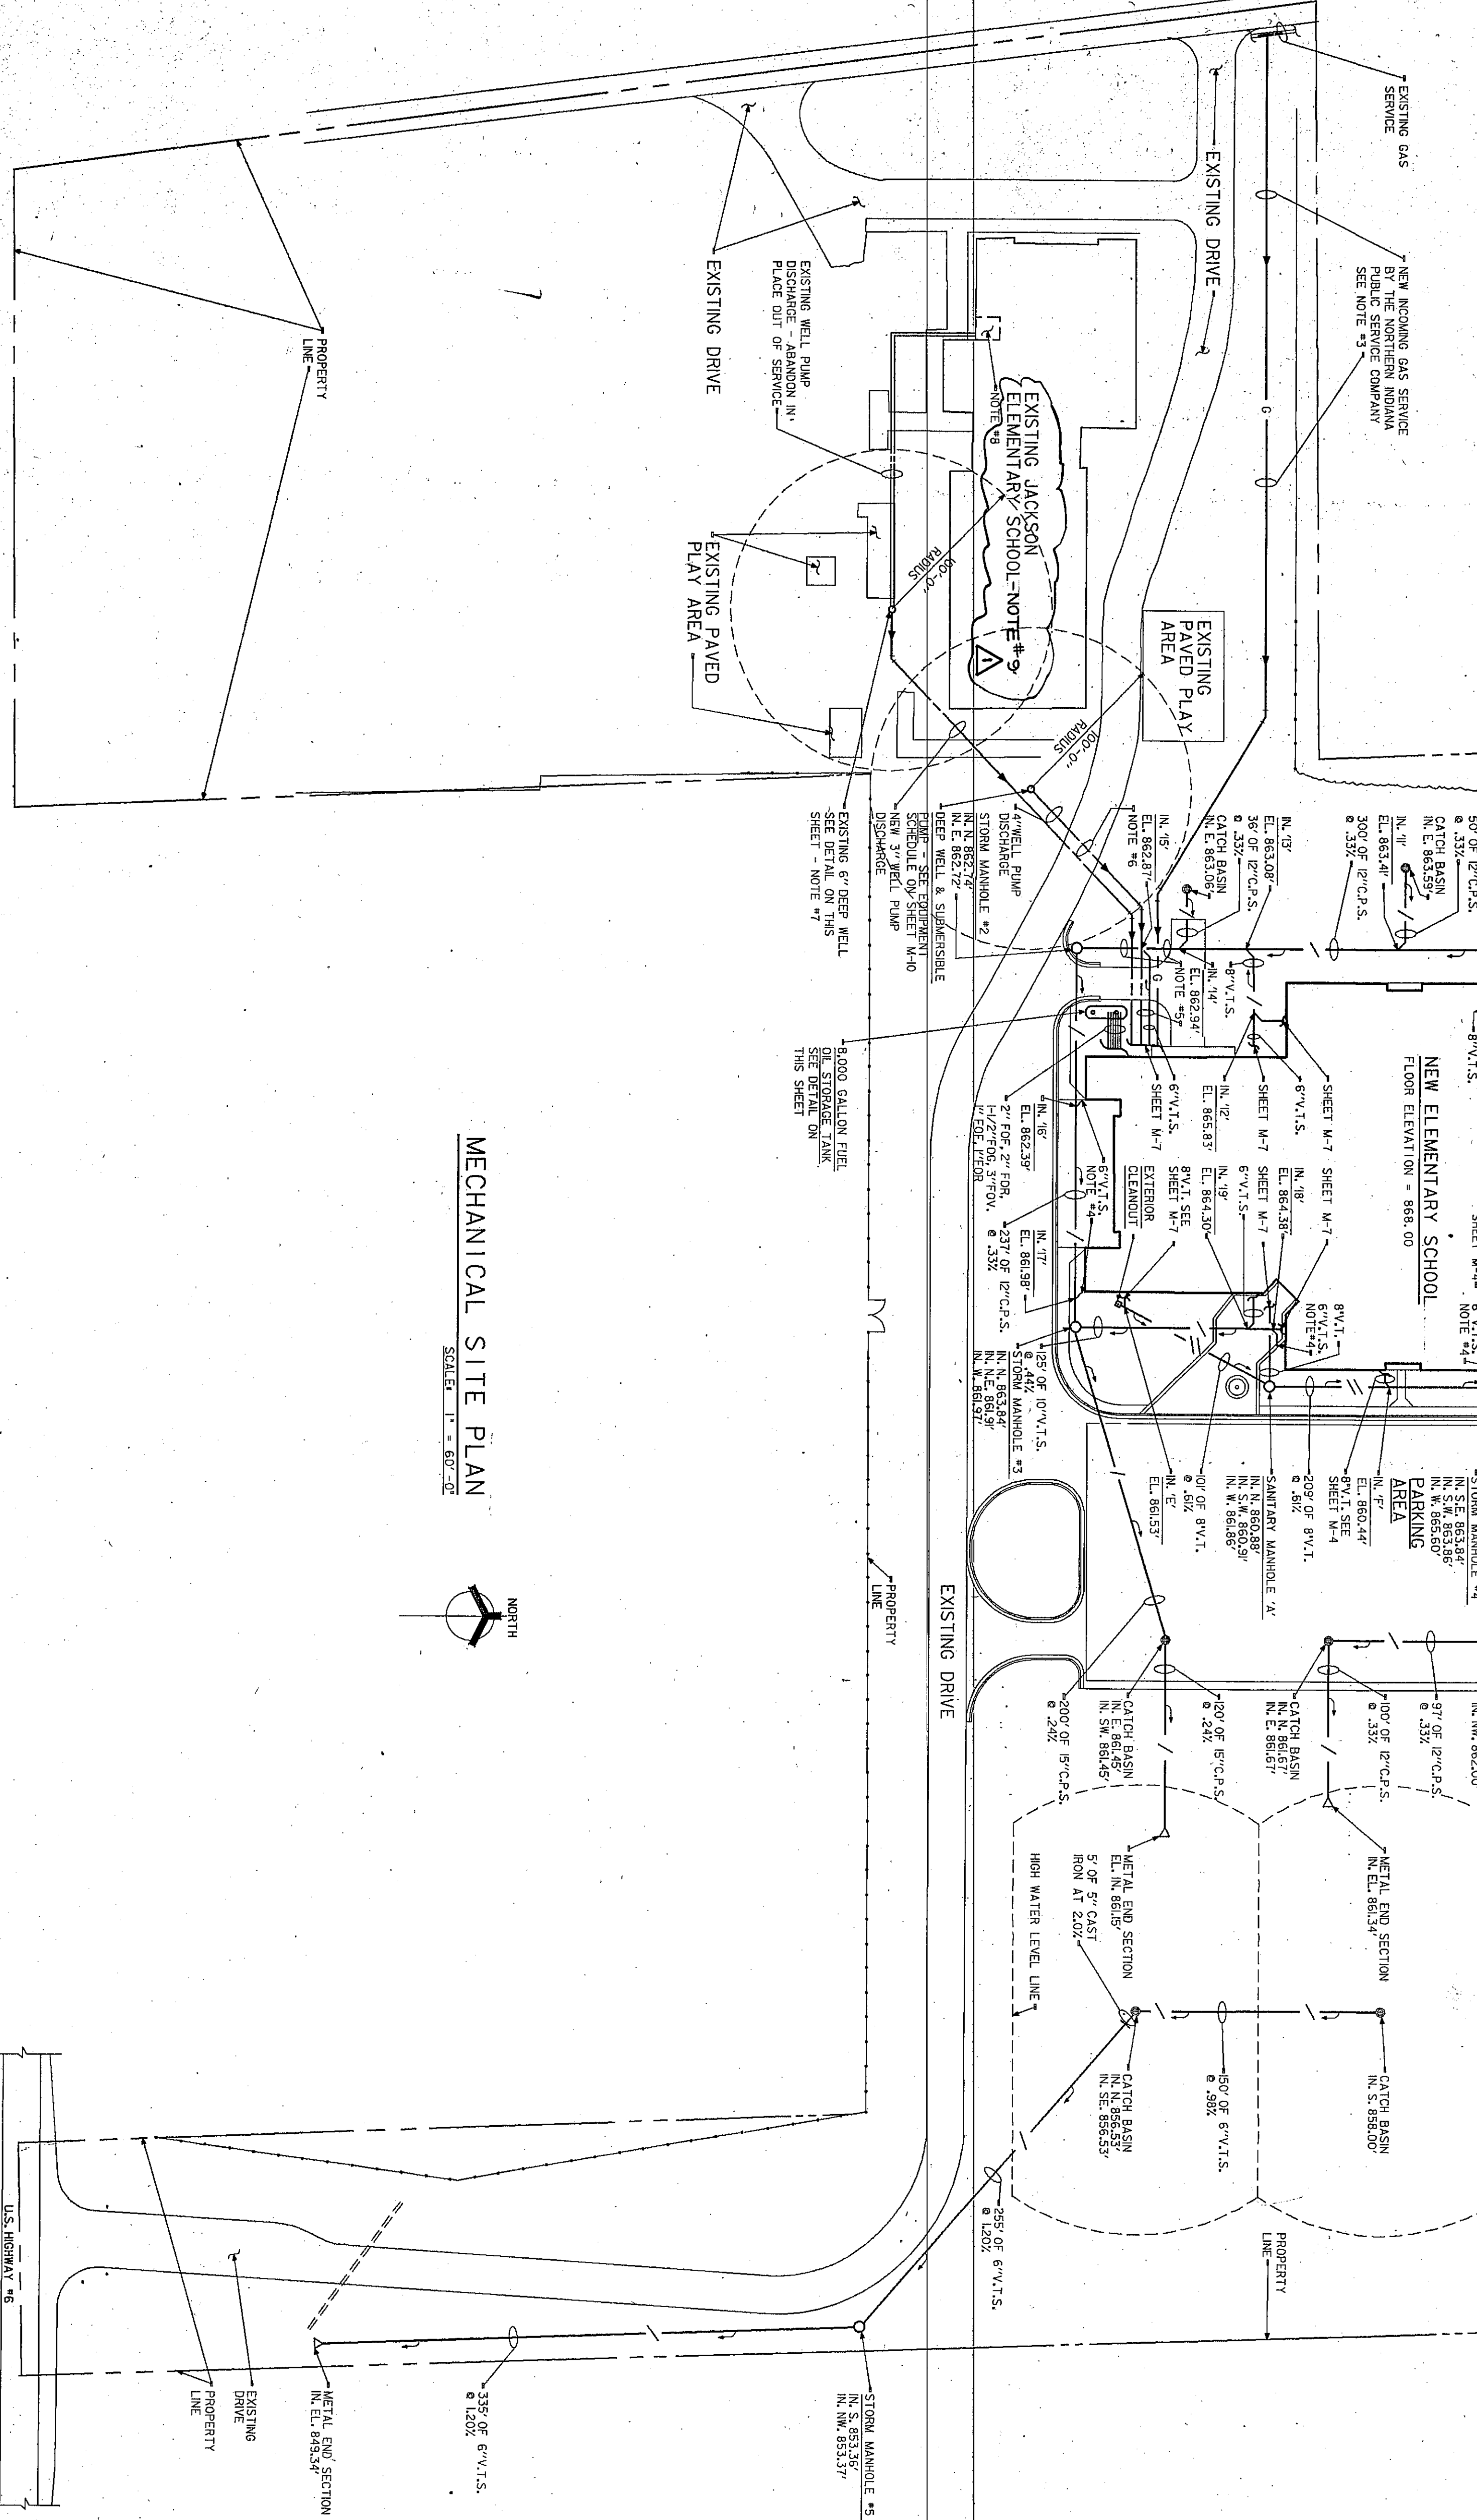


MECHANICAL SITE PLAN

SCALE: 1" = 50'-0"

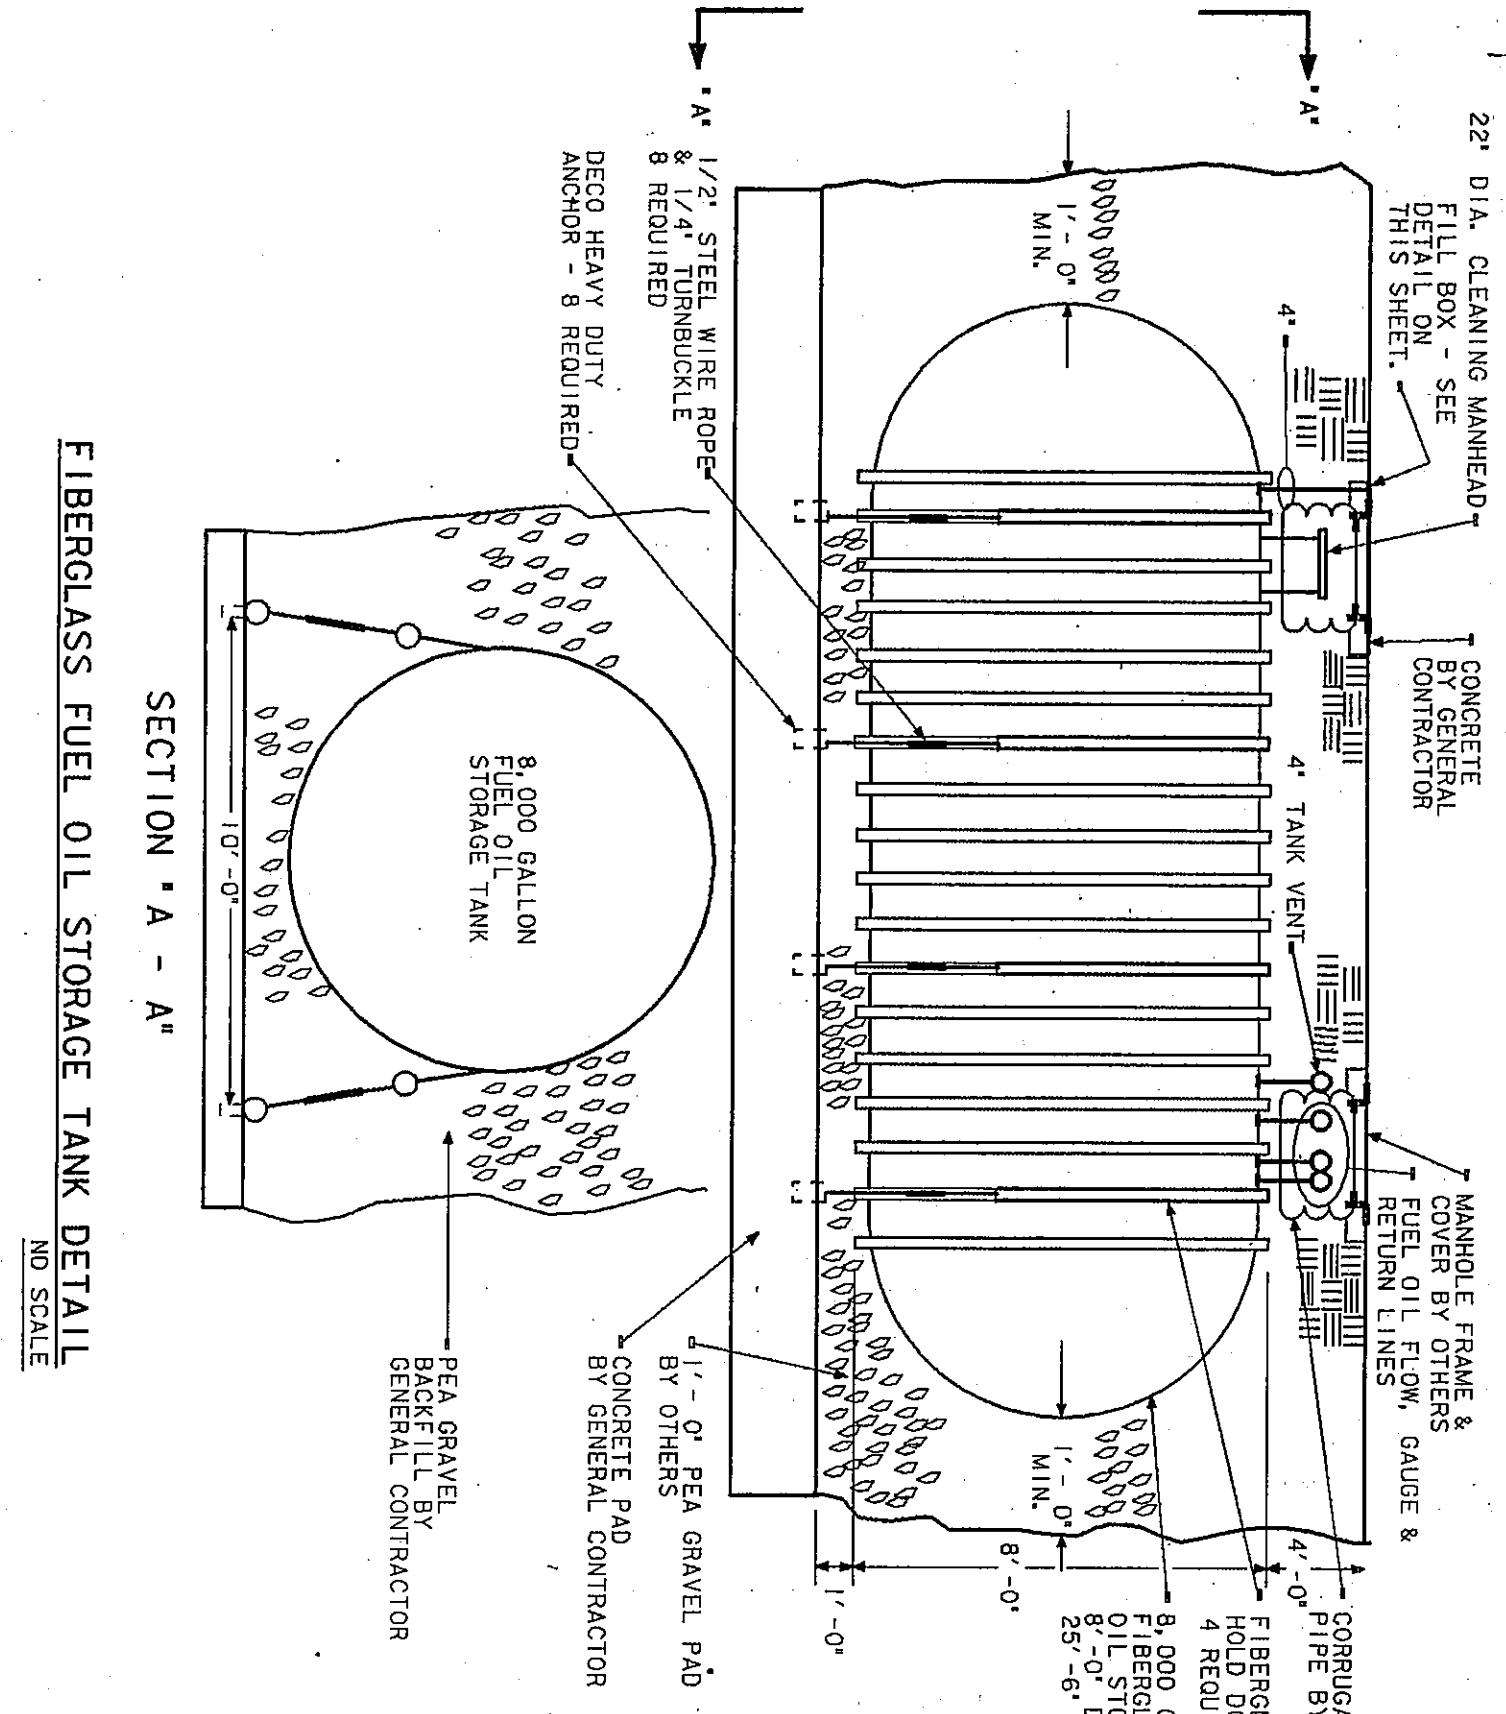


SECTION A-A - FIBERGLASS FUEL OIL STORAGE TANK DETAIL

NO SCALE

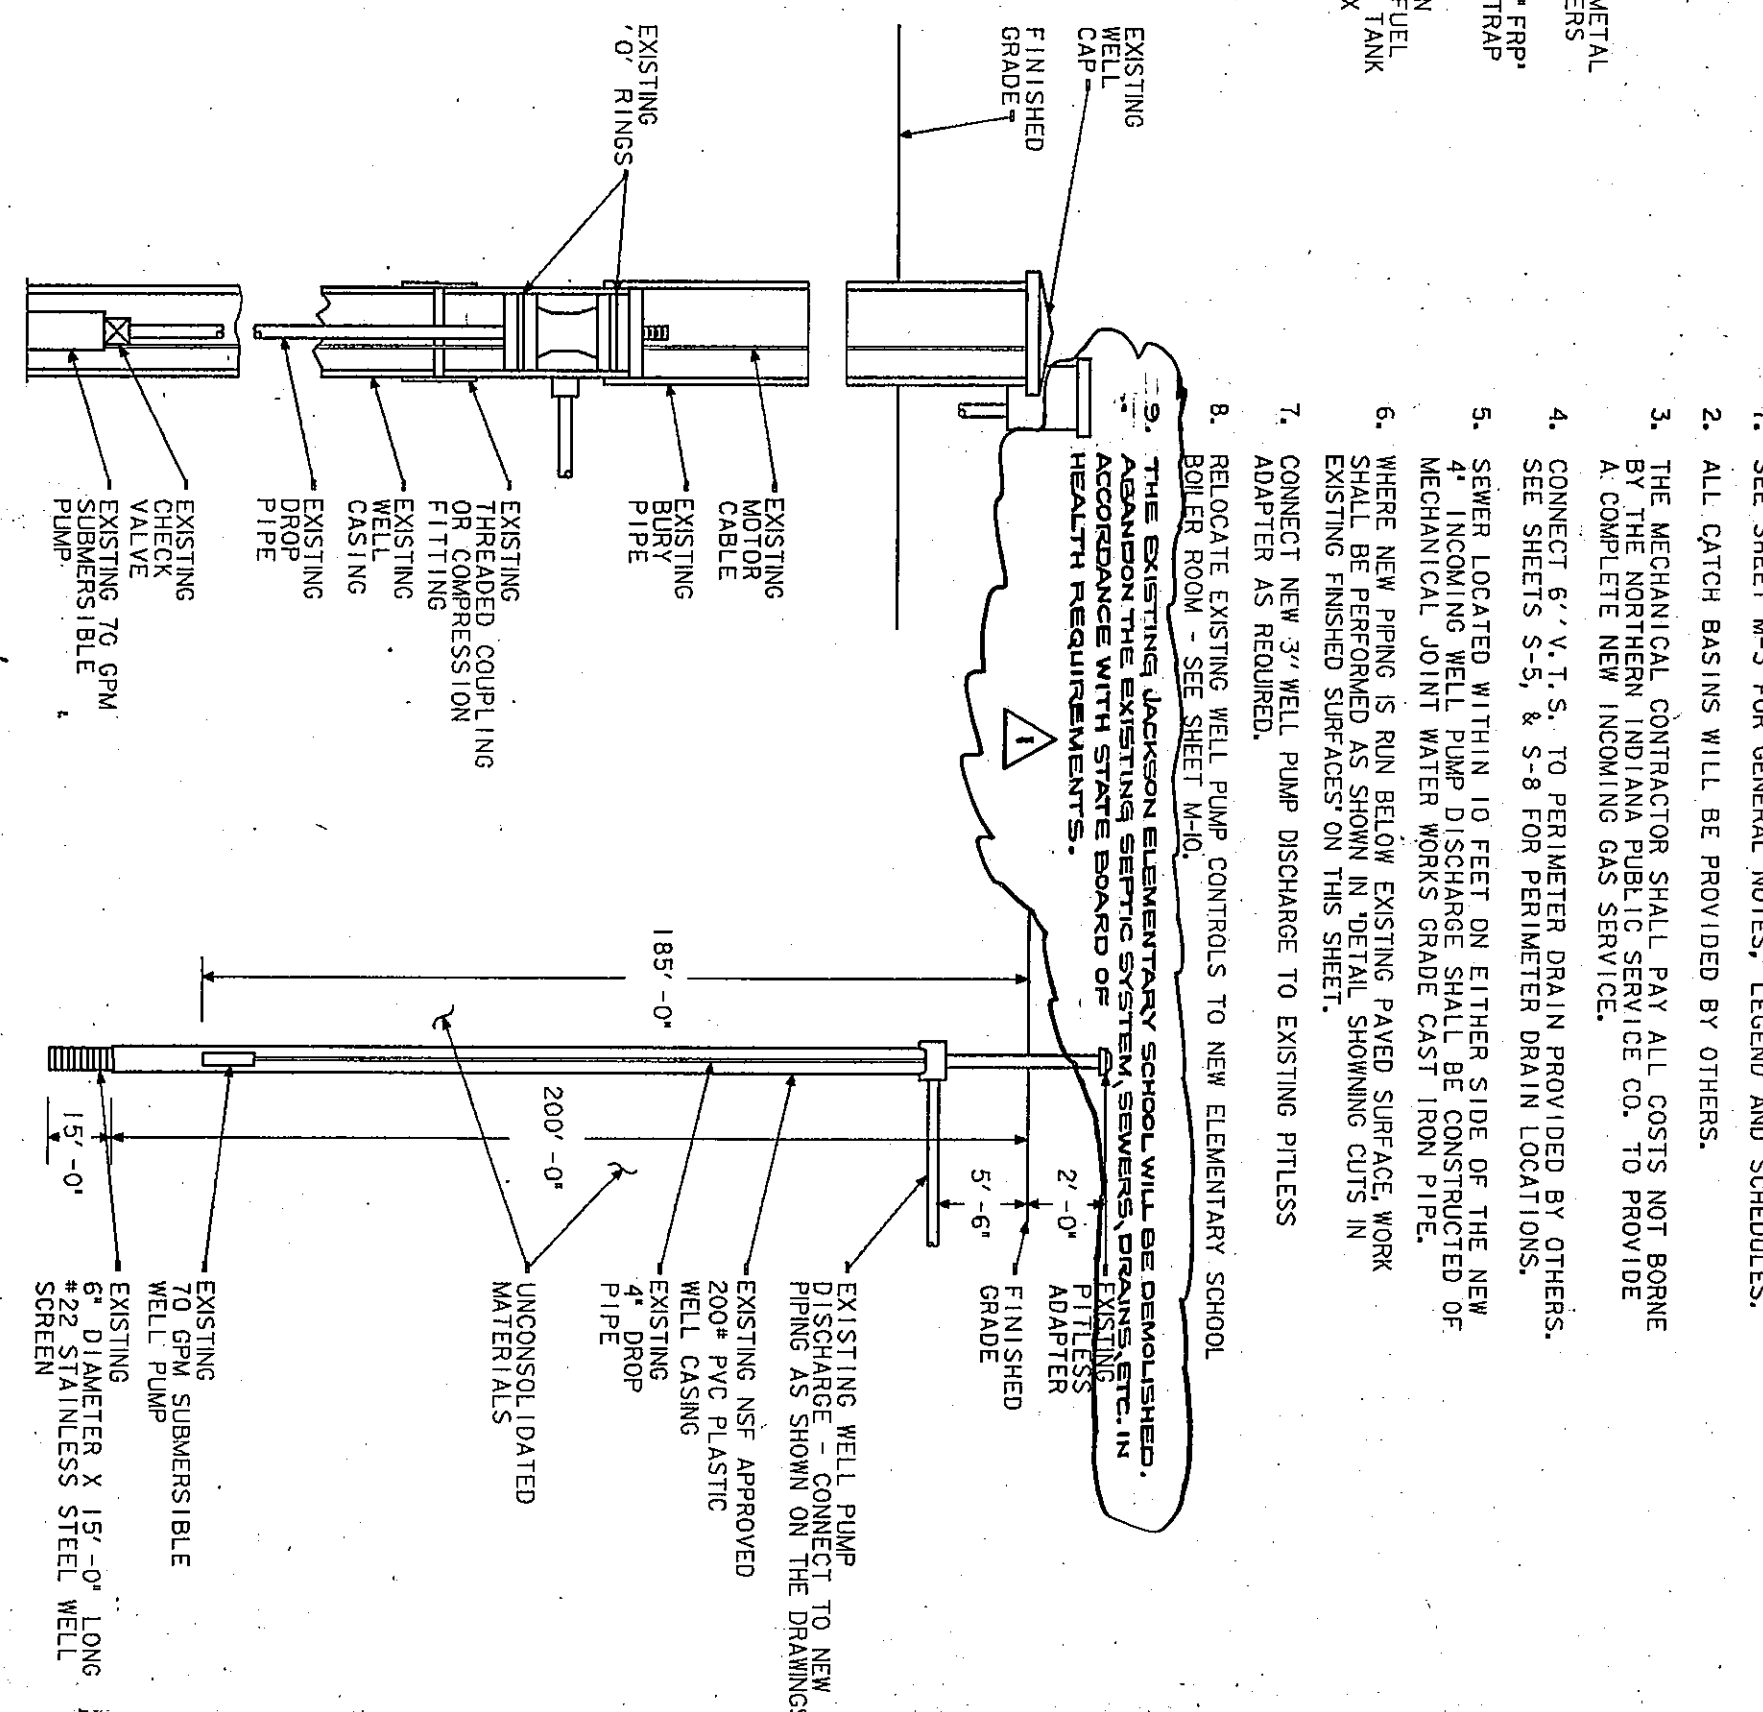


SECTION THRU EXISTING PITLESS ADAPTER AND EXISTING WATER WELL

NO SCALE

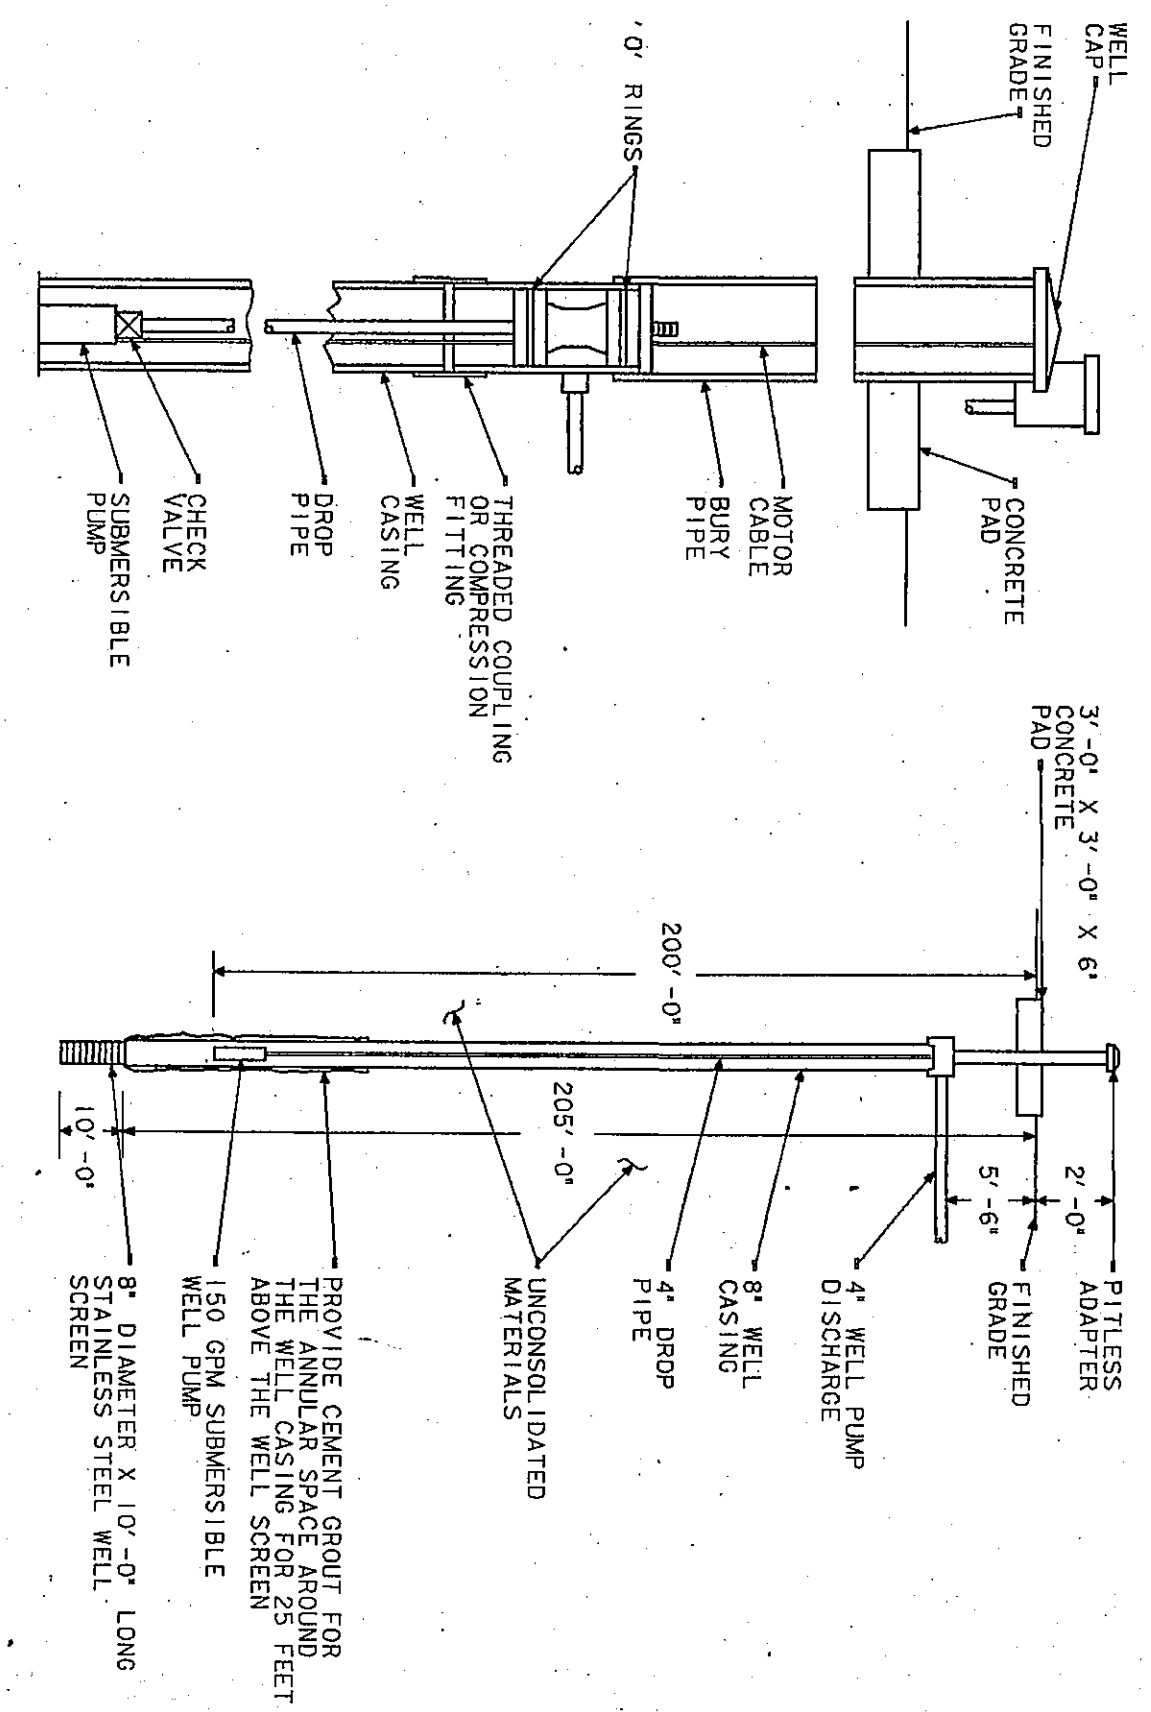

SECTION THRU PITLESS ADAPTER AND WATER WELL

NO SCALE

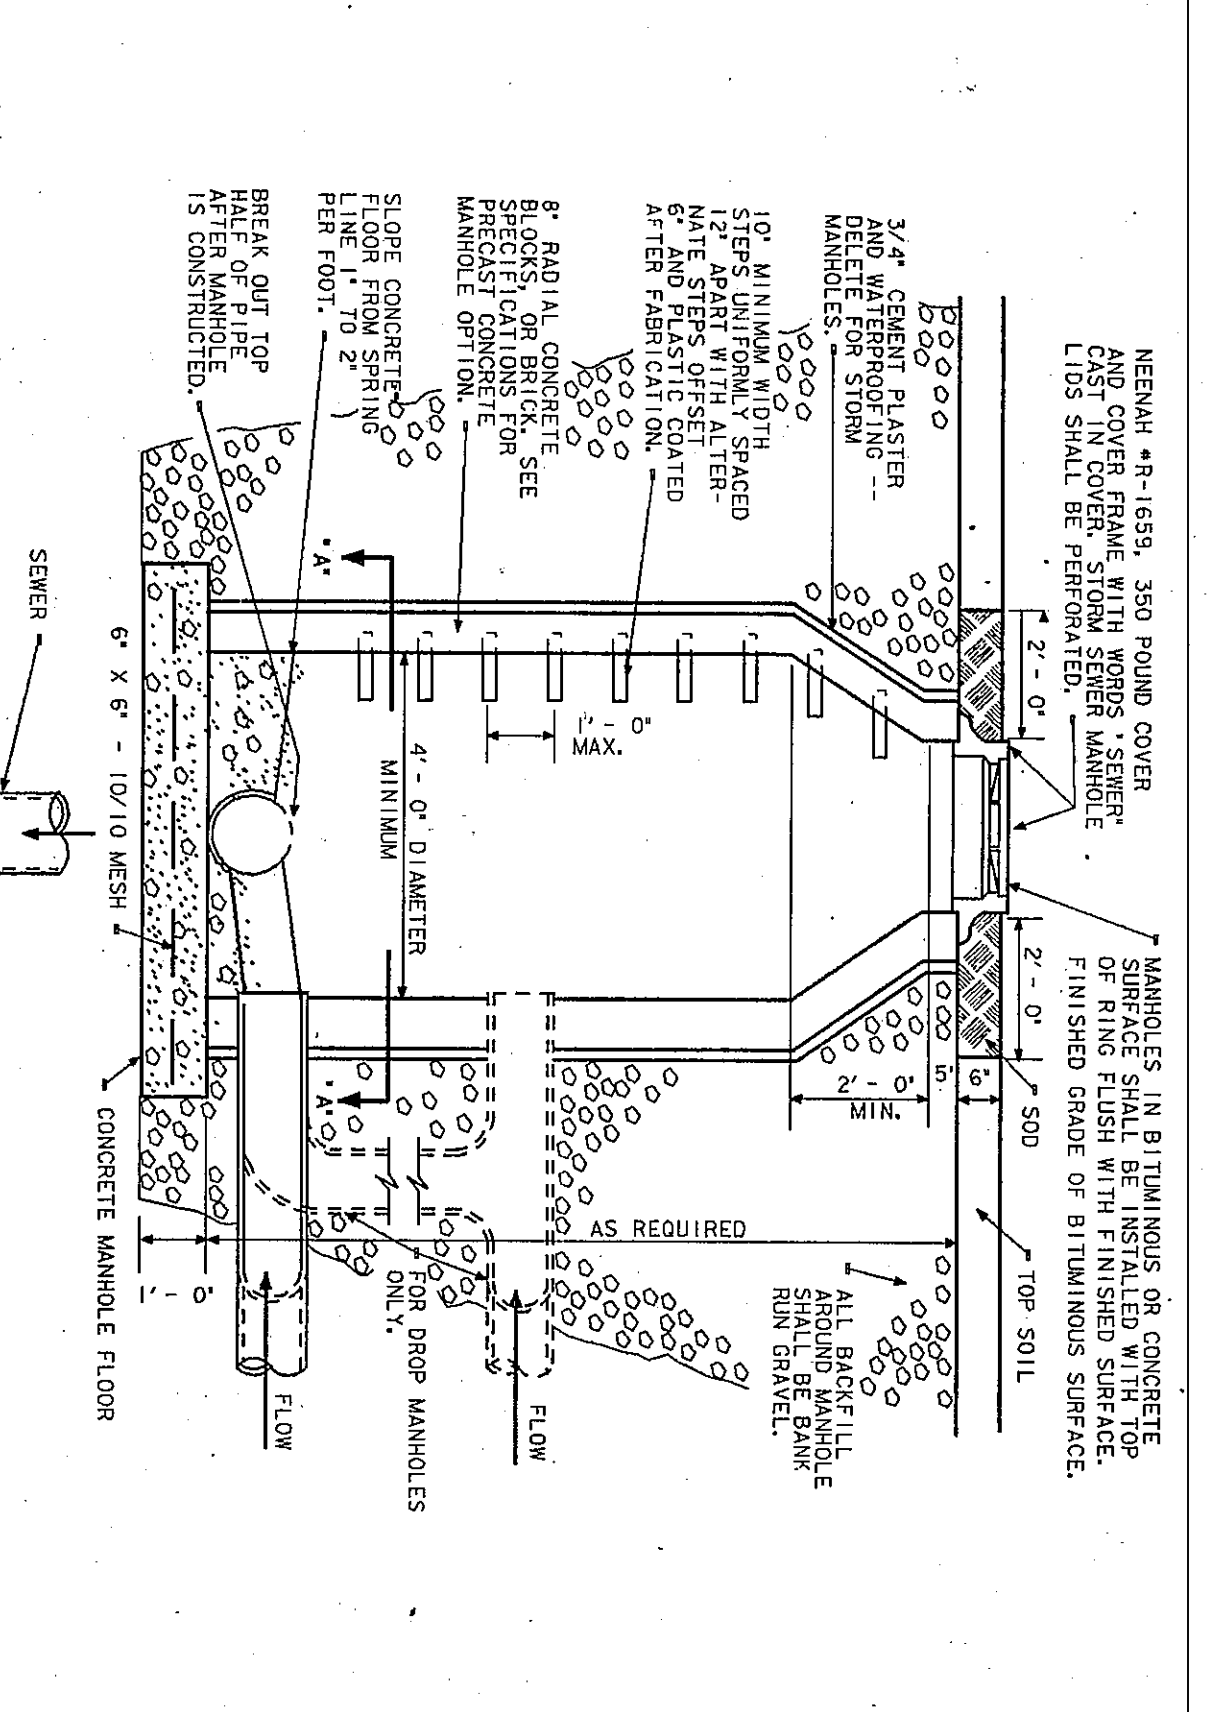

TYPICAL MANHOLE DETAIL

NO SCALE

PLAN NOTES

1. SEE SHEET M-3 FOR GENERAL NOTES, LEGEND AND SCHEDULES.
2. ALL CATCH BASINS WILL BE PROVIDED BY OTHERS.
3. THE MECHANICAL CONTRACTOR SHALL PAY ALL COSTS NOT BORNE BY THE SCHOOL DISTRICT.
4. CONNECT 6" V.I.S. TO PERIMETER DRAIN PROVIDED BY OTHERS.
5. SEWER LOCATED WITHIN 10 FEET OF EITHER SIDE OF THE NEW MECHANICAL JOINT WATER WORKS GRADE CAST FROM PIPE OF 6" V.I.S. SHALL BE REMOVED AS SHOWN IN SPECIAL SHOWING CUTS IN SECTION A-A.
6. WHERE NEW PIPING IS RUN BELOW EXISTING PAVED SURFACE WORK SHALL BE DONE AS SHOWN IN SPECIAL SHOWING CUTS IN SECTION A-A.
7. ADAPTER AS REQUIRED.
8. RELOCATE EXISTING WELL PUMP CONTROLS TO NEW ELEMENTARY SCHOOL.
9. ADAPTER AS REQUIRED.
10. ADAPTER AS REQUIRED.

AS-BUILT
25 SEPT. 1984

NO. M-1
OF 36

PROJECT
12579.00
DATE
MAY 3, 1982
REVISED
JULY 23, 1982

James A. Partridge
ARCHITECTS
ENGINEERS

EVERETT · I · BROWN COMPANY
5500 WEST BRADBURY AVENUE · PARK FLETCHER · INDIANAPOLIS, INDIANA · 46241

ARCHITECTS
ENGINEERS

© EVERETT · I · BROWN COMPANY