


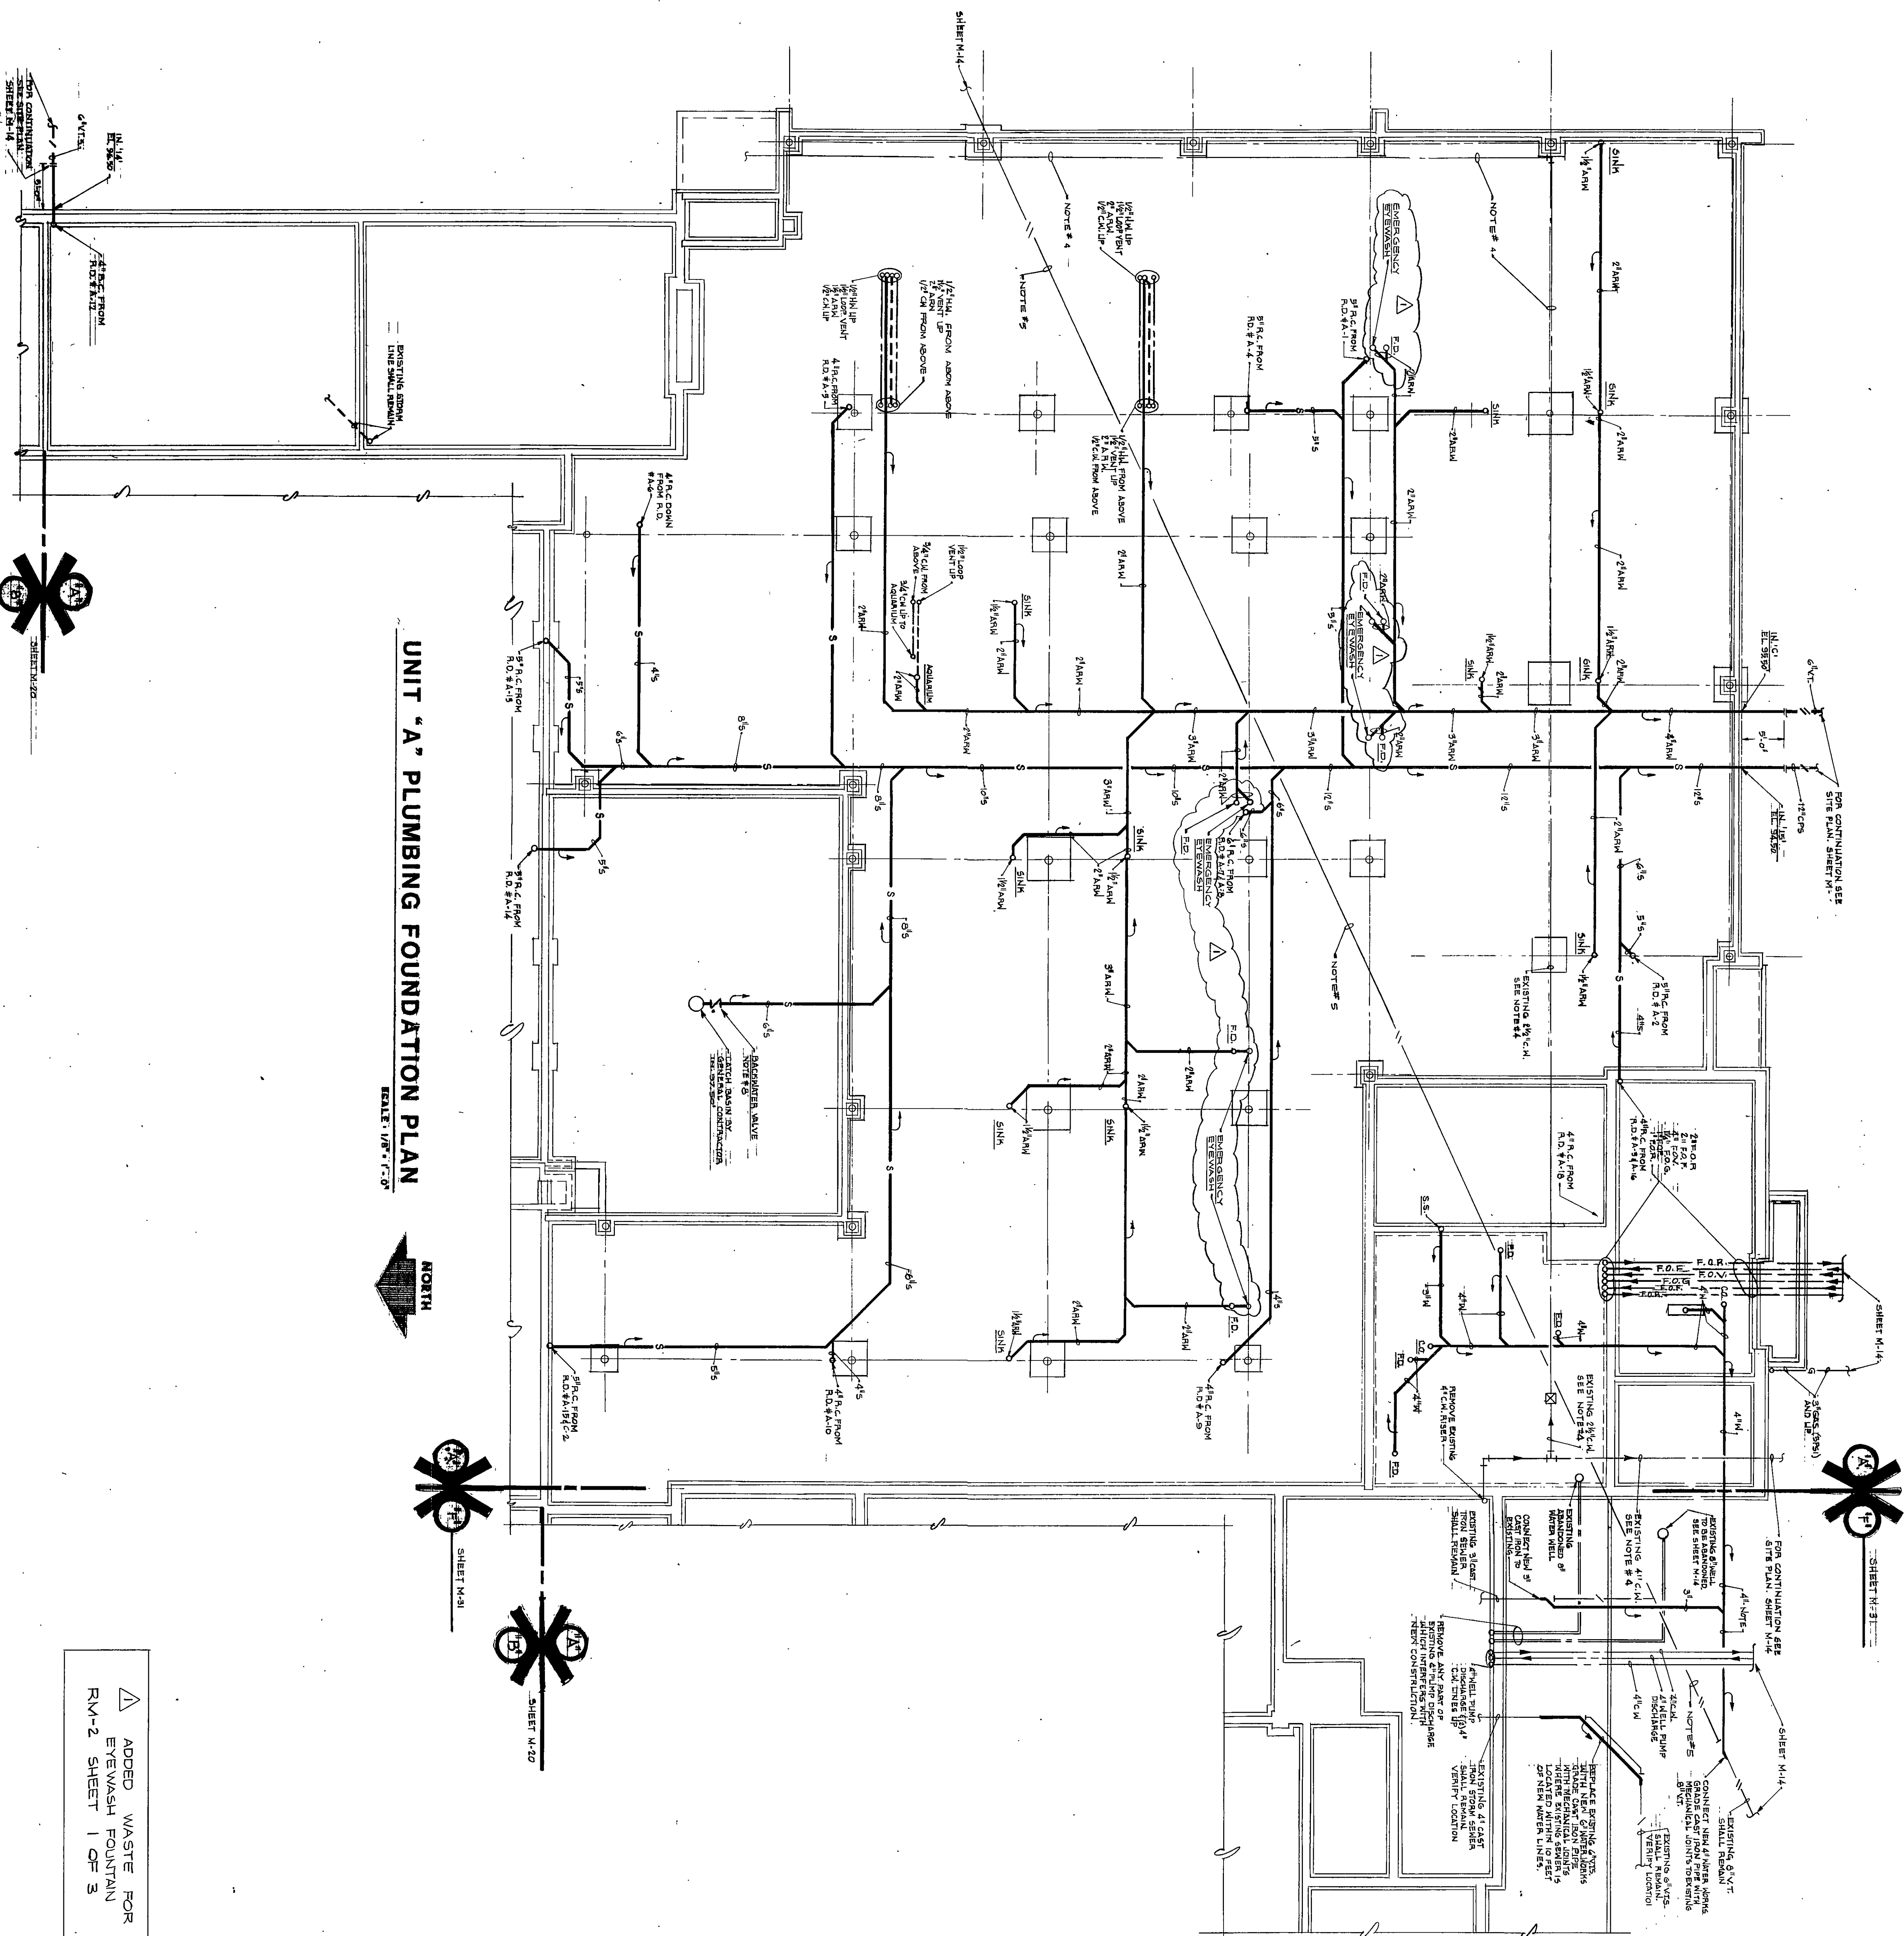


UNIT "A" PLUMBING FOUNDATION PLAN

SCALE: 1/8" = 1'-0"

NORTH

△ ADDED WASTE FOR
EYEWASH FOUNTAIN
RM-2 SHEET 1 OF 3

- PLAN NOTES
1. SEE SHEET M-16 FOR GENERAL MECHANICAL NOTES, LEGEND AND SCHEDULES.
 2. SEE SHEET M-14 FOR MECHANICAL SITE PLAN.
 3. ALL WASTE AND VENT PIPING IN SCIENCE AND ART AREAS SHALL BE ACID RESISTANT.
 4. EXISTING COLD WATER LINE SHALL REMAIN IN SERVICE UNTIL NEW CONSTRUCTION IS COMPLETED. THEN SHALL BE CUT, CAPPED AND ABANDONED IN PLACE OUT OF SERVICE UNLESS REMOVAL IS NECESSARY FOR CONSTRUCTION.
 5. EXISTING SANITARY LINE SHALL REMAIN IN SERVICE UNTIL NEW CONSTRUCTION IS COMPLETED. THEN SHALL BE CUT, CAPPED AND ABANDONED IN PLACE OUT OF SERVICE UNLESS REMOVAL IS NECESSARY FOR CONSTRUCTION.
 6. WHERE NEW PIPING IS RUN BELOW FINISHED FLOOR SURFACES, WORK SHALL BE PERFORMED AS SHOWN IN DETAIL.
 7. ALL SEWERS WITHIN 10 FEET OF NEW WATER MAINS SHALL BE CONSTRUCTED OF WATER WORKS GRADE CAST IRON PIPE WITH MECHANICAL JOINTS.
 8. BACKWATER VALVE SHALL BE J.R. SMITH MODEL #7022, SIZE 6" OR AN APPROVED EQUAL.

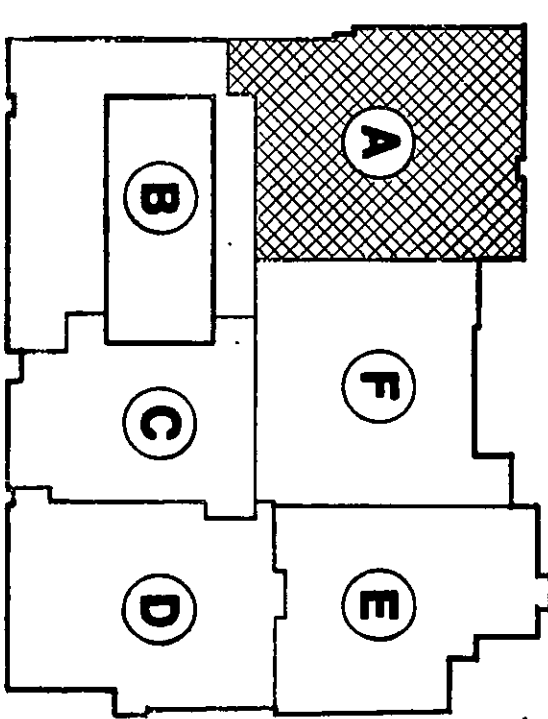

EVERETT · I · BROWN COMPANY ARCHITECTS
ENGINEERS
5500 WEST BRADBURY AVENUE · PARK FLETCHER · INDIANAPOLIS, INDIANA · 46241
ADDITION TO AND RENOVATION OF LIBERTY MIDDLE SCHOOL



James A. Partridge

PROJECT
12579.00
DATE
MAY 3, 1982
REVISED
JAN. 14, 1983

AS-BUILT

25 SEPT 1984

KEY PLAN
NO SCALE

NORTH

NO. M-17
OF 36

82-M-04