
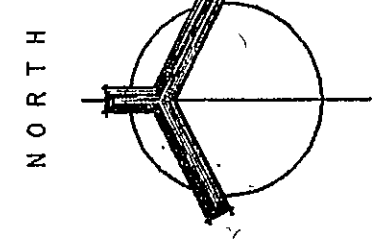



James A. Feltz

AS-BUILT
12545
REVISED
MAY 3, 1982
DATE
12529.00
PROJECT



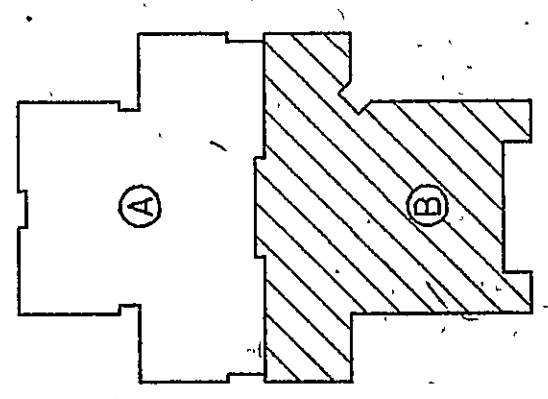


UNIT 'B' HEATING, VENTILATING, AIR-CONDITIONING FIRST FLOOR PLAN

SCALE: 1/8" = 1'-0"

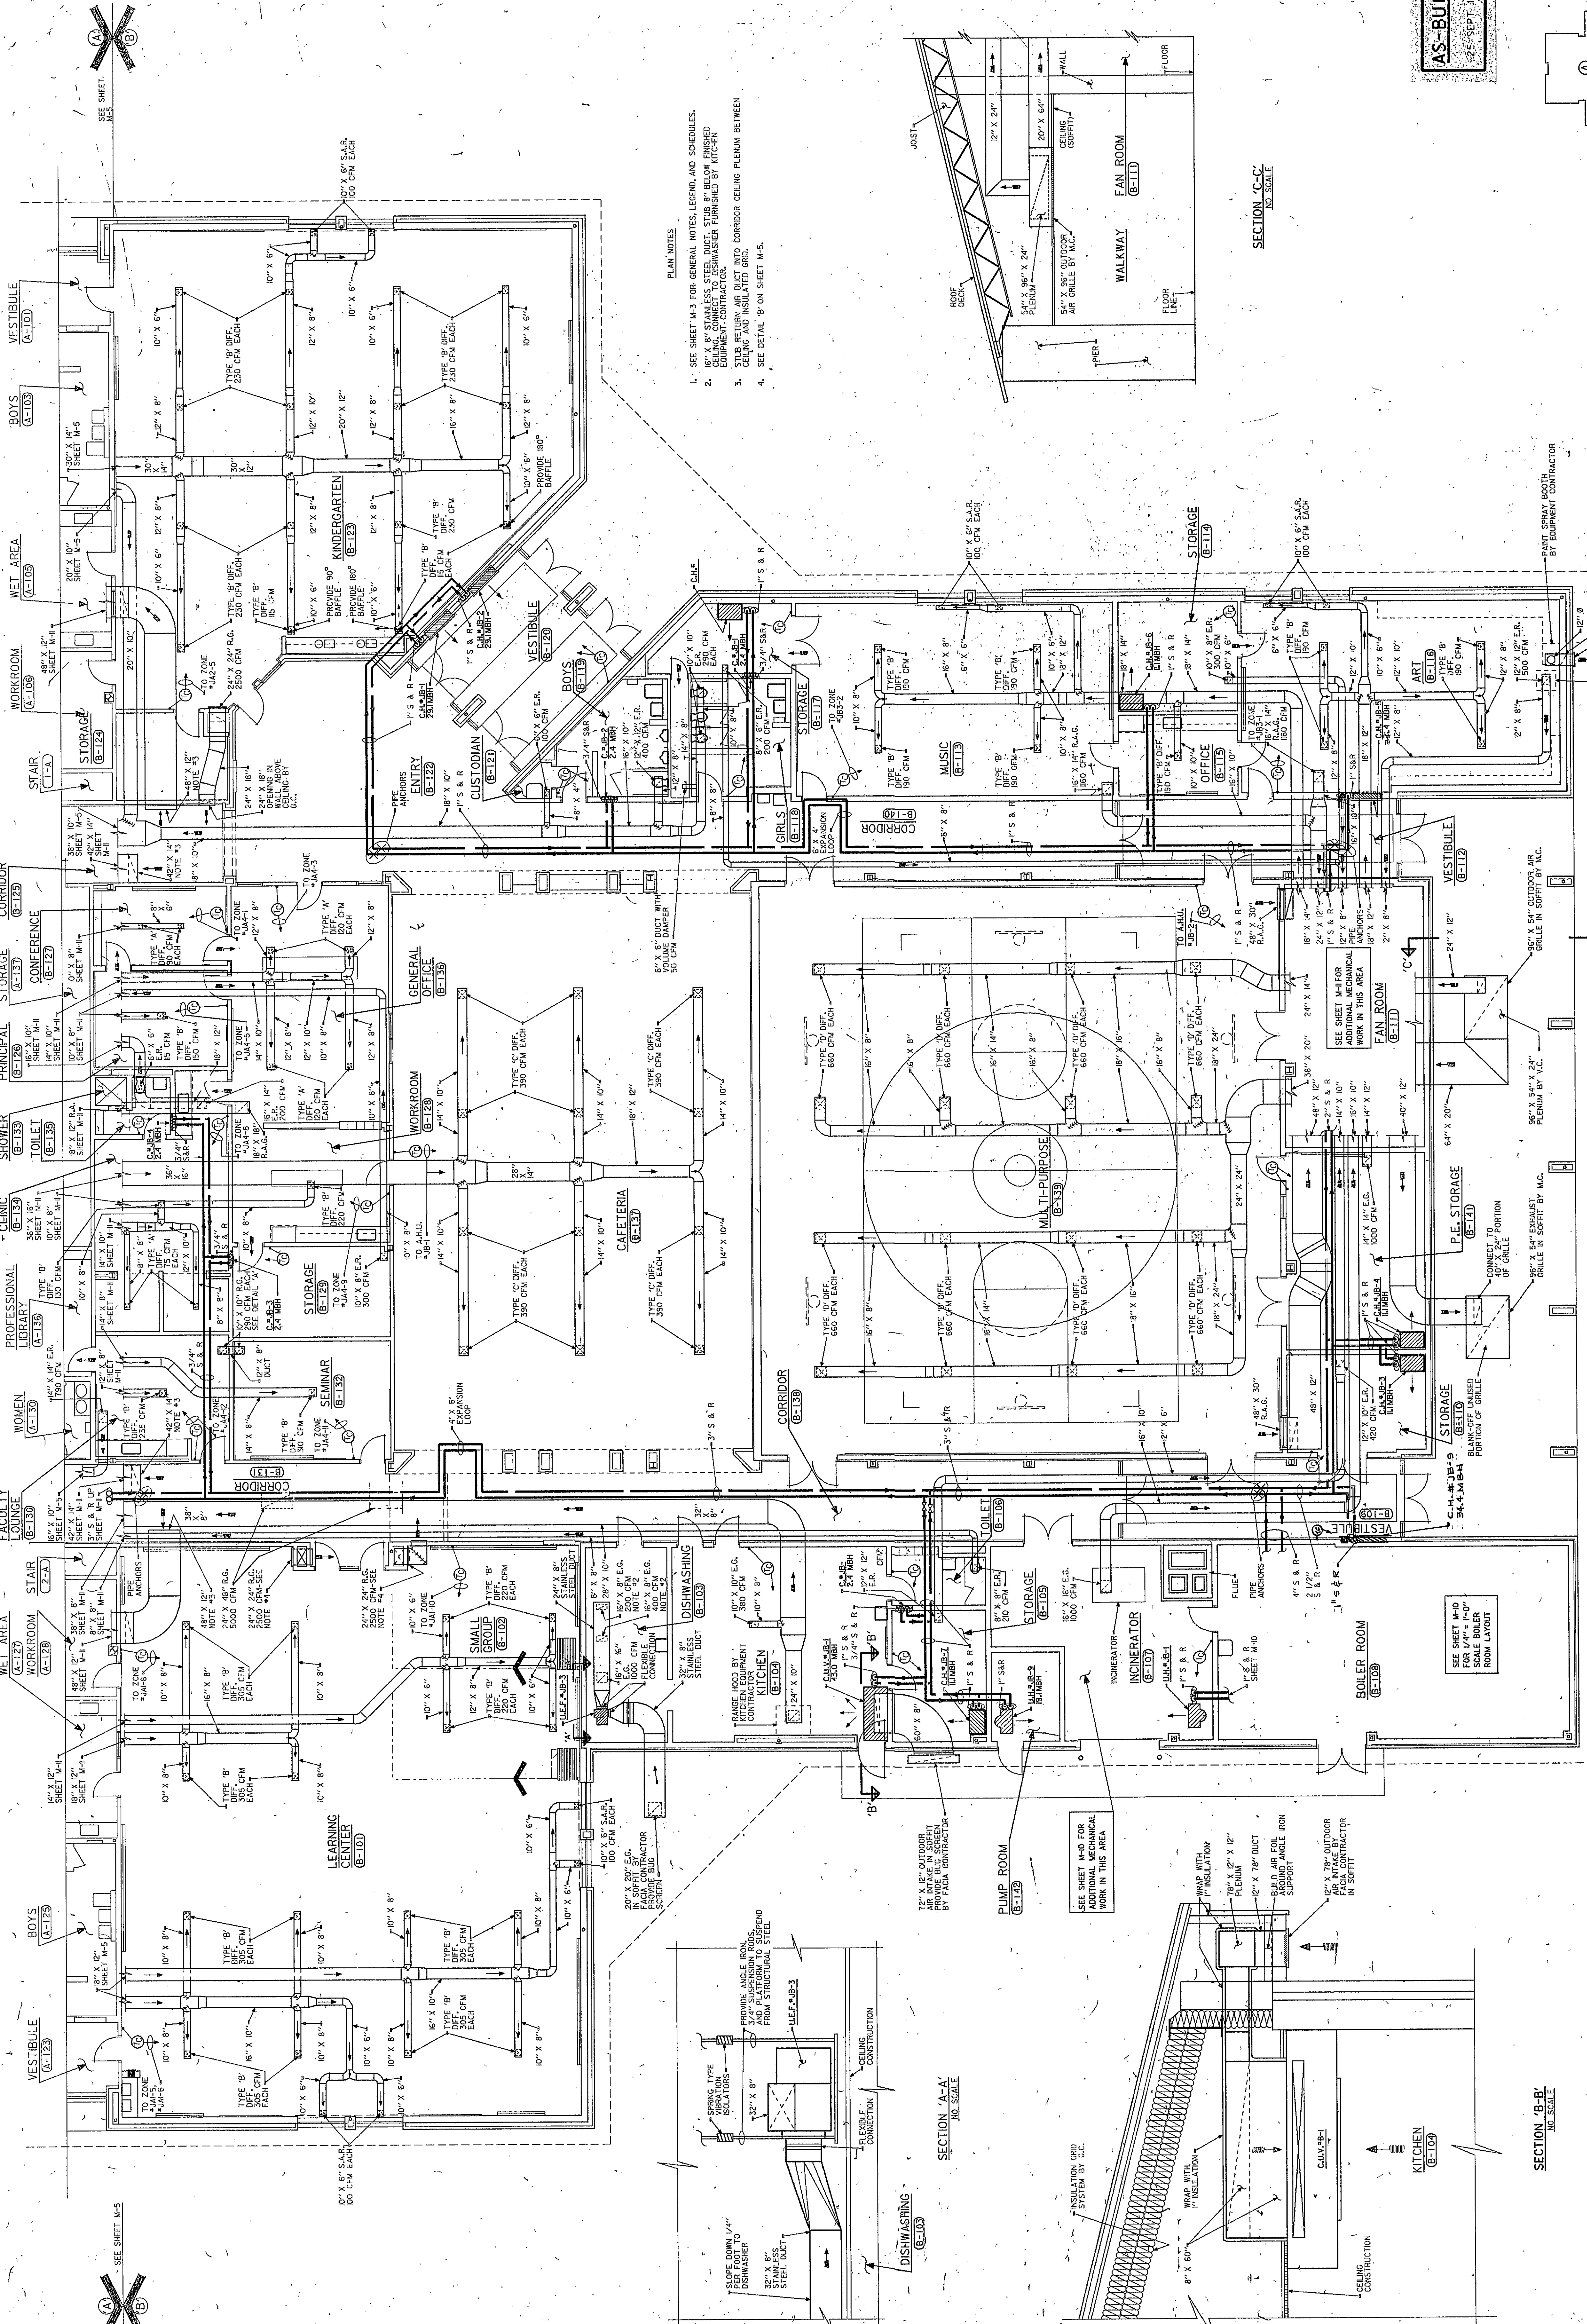

- PLAN NOTES
1. SEE SHEET M-3 FOR GENERAL NOTES, LEGEND, AND SCHEDULES.
 2. 18" X 8" STAINLESS STEEL DUCT, STUB 8" BELOW FINISHED EQUIPMENT CONTRACTOR.
 3. STUB RETURN AIR DUCT INTO CORRIDOR CEILING PLenum BETWEEN
 4. SEE DETAIL 'B' ON SHEET M-5.

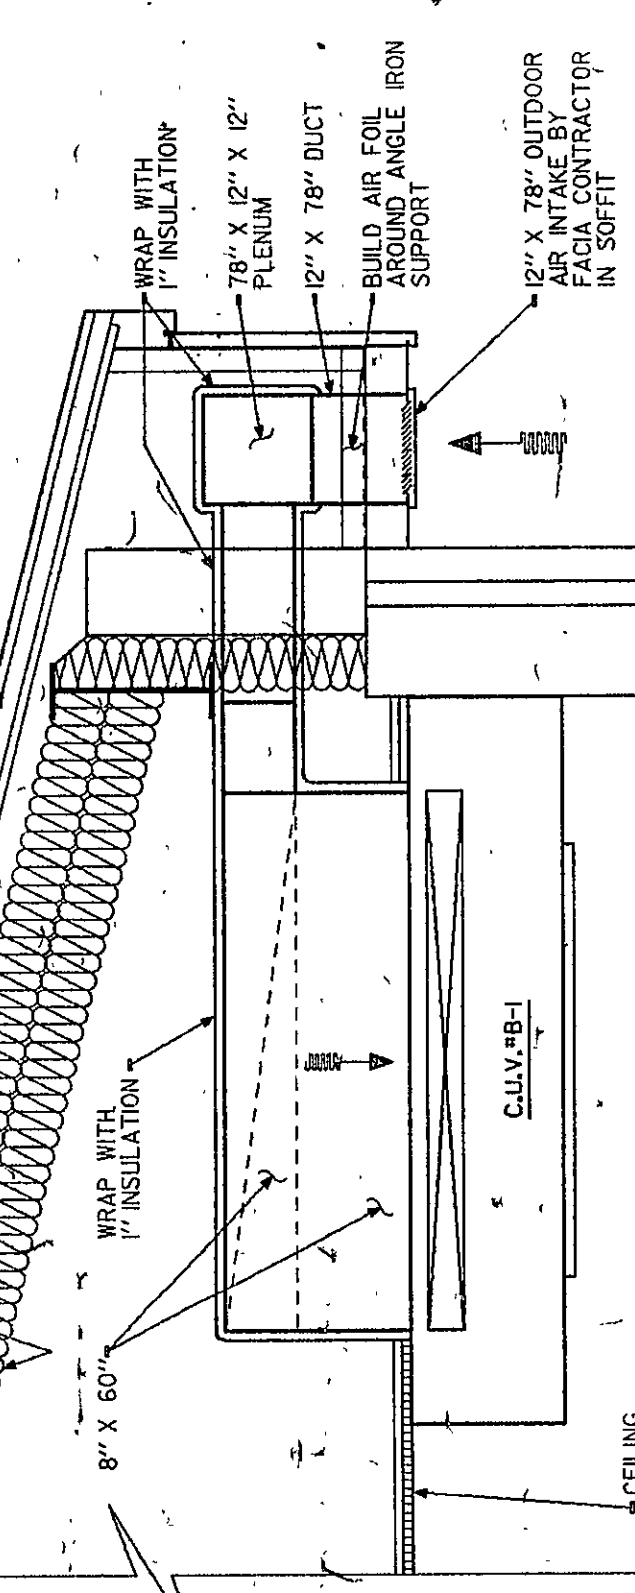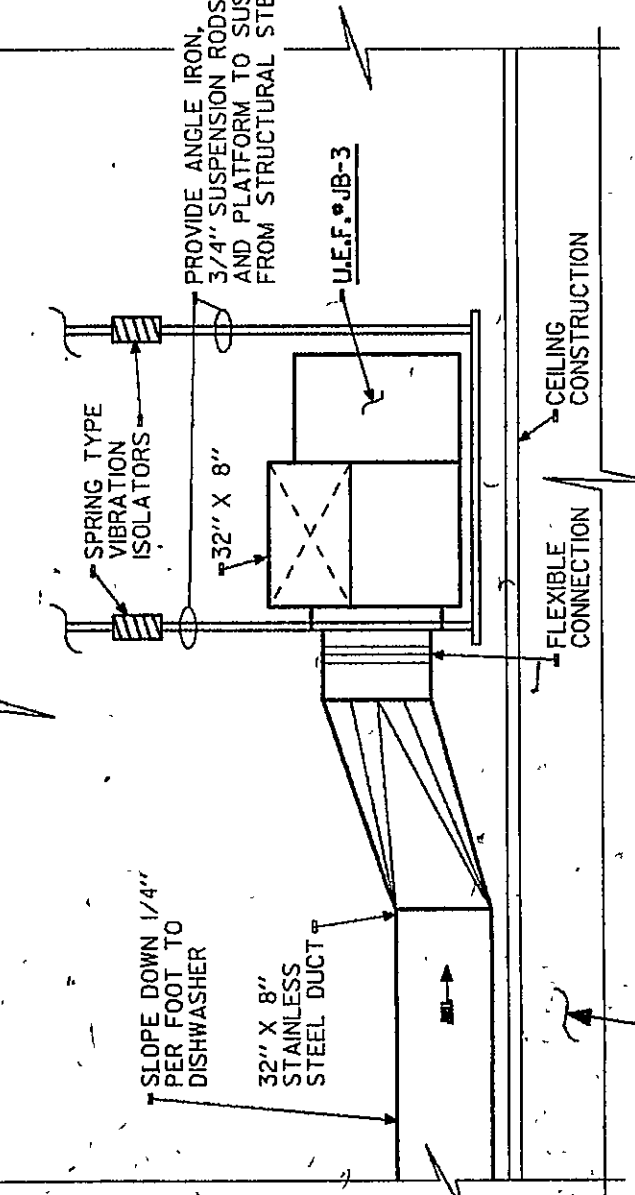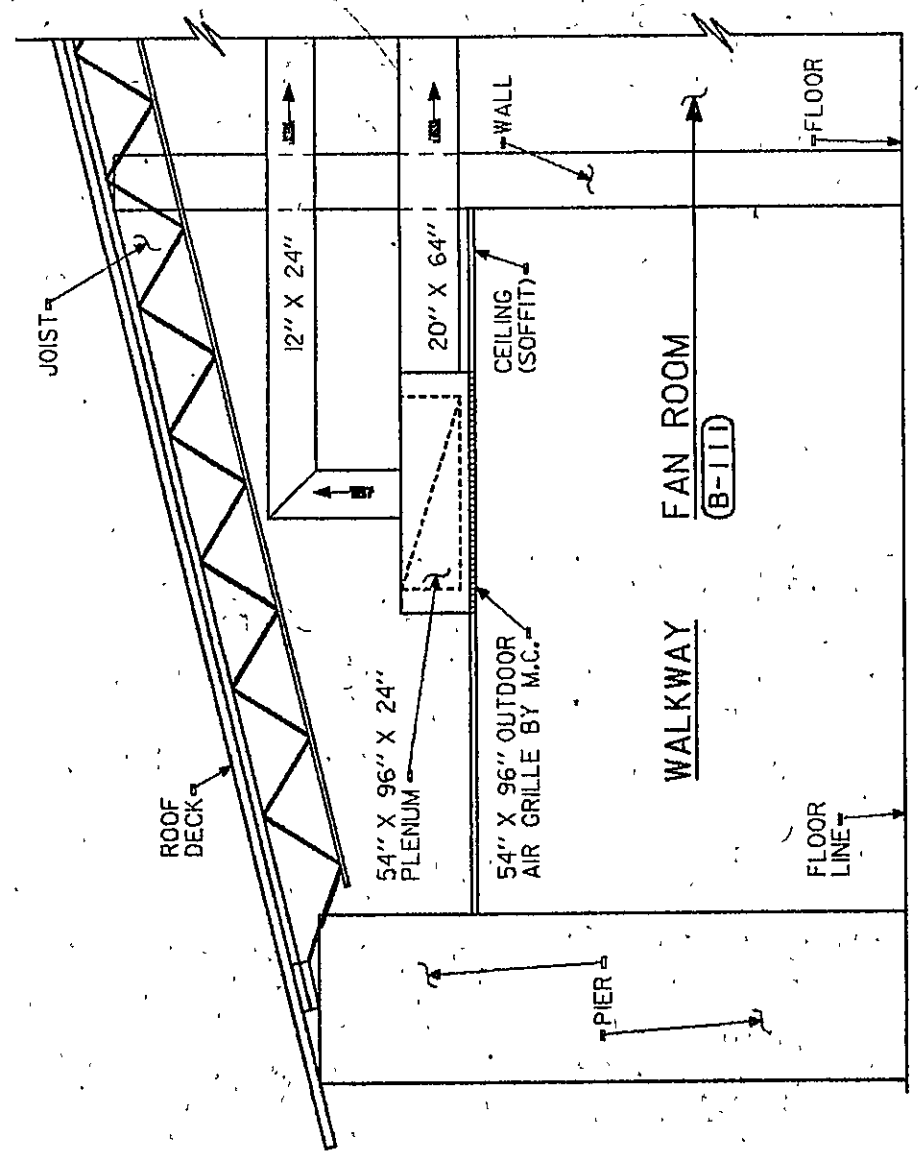

SEE SHEET M-5

SEE SHEET M-5

12-27