


R-27


UNIT D - HEATING, VENTILATING AND AIR CONDITIONING FLOOR PLAN

SCALE 1/8" = 1'-0"

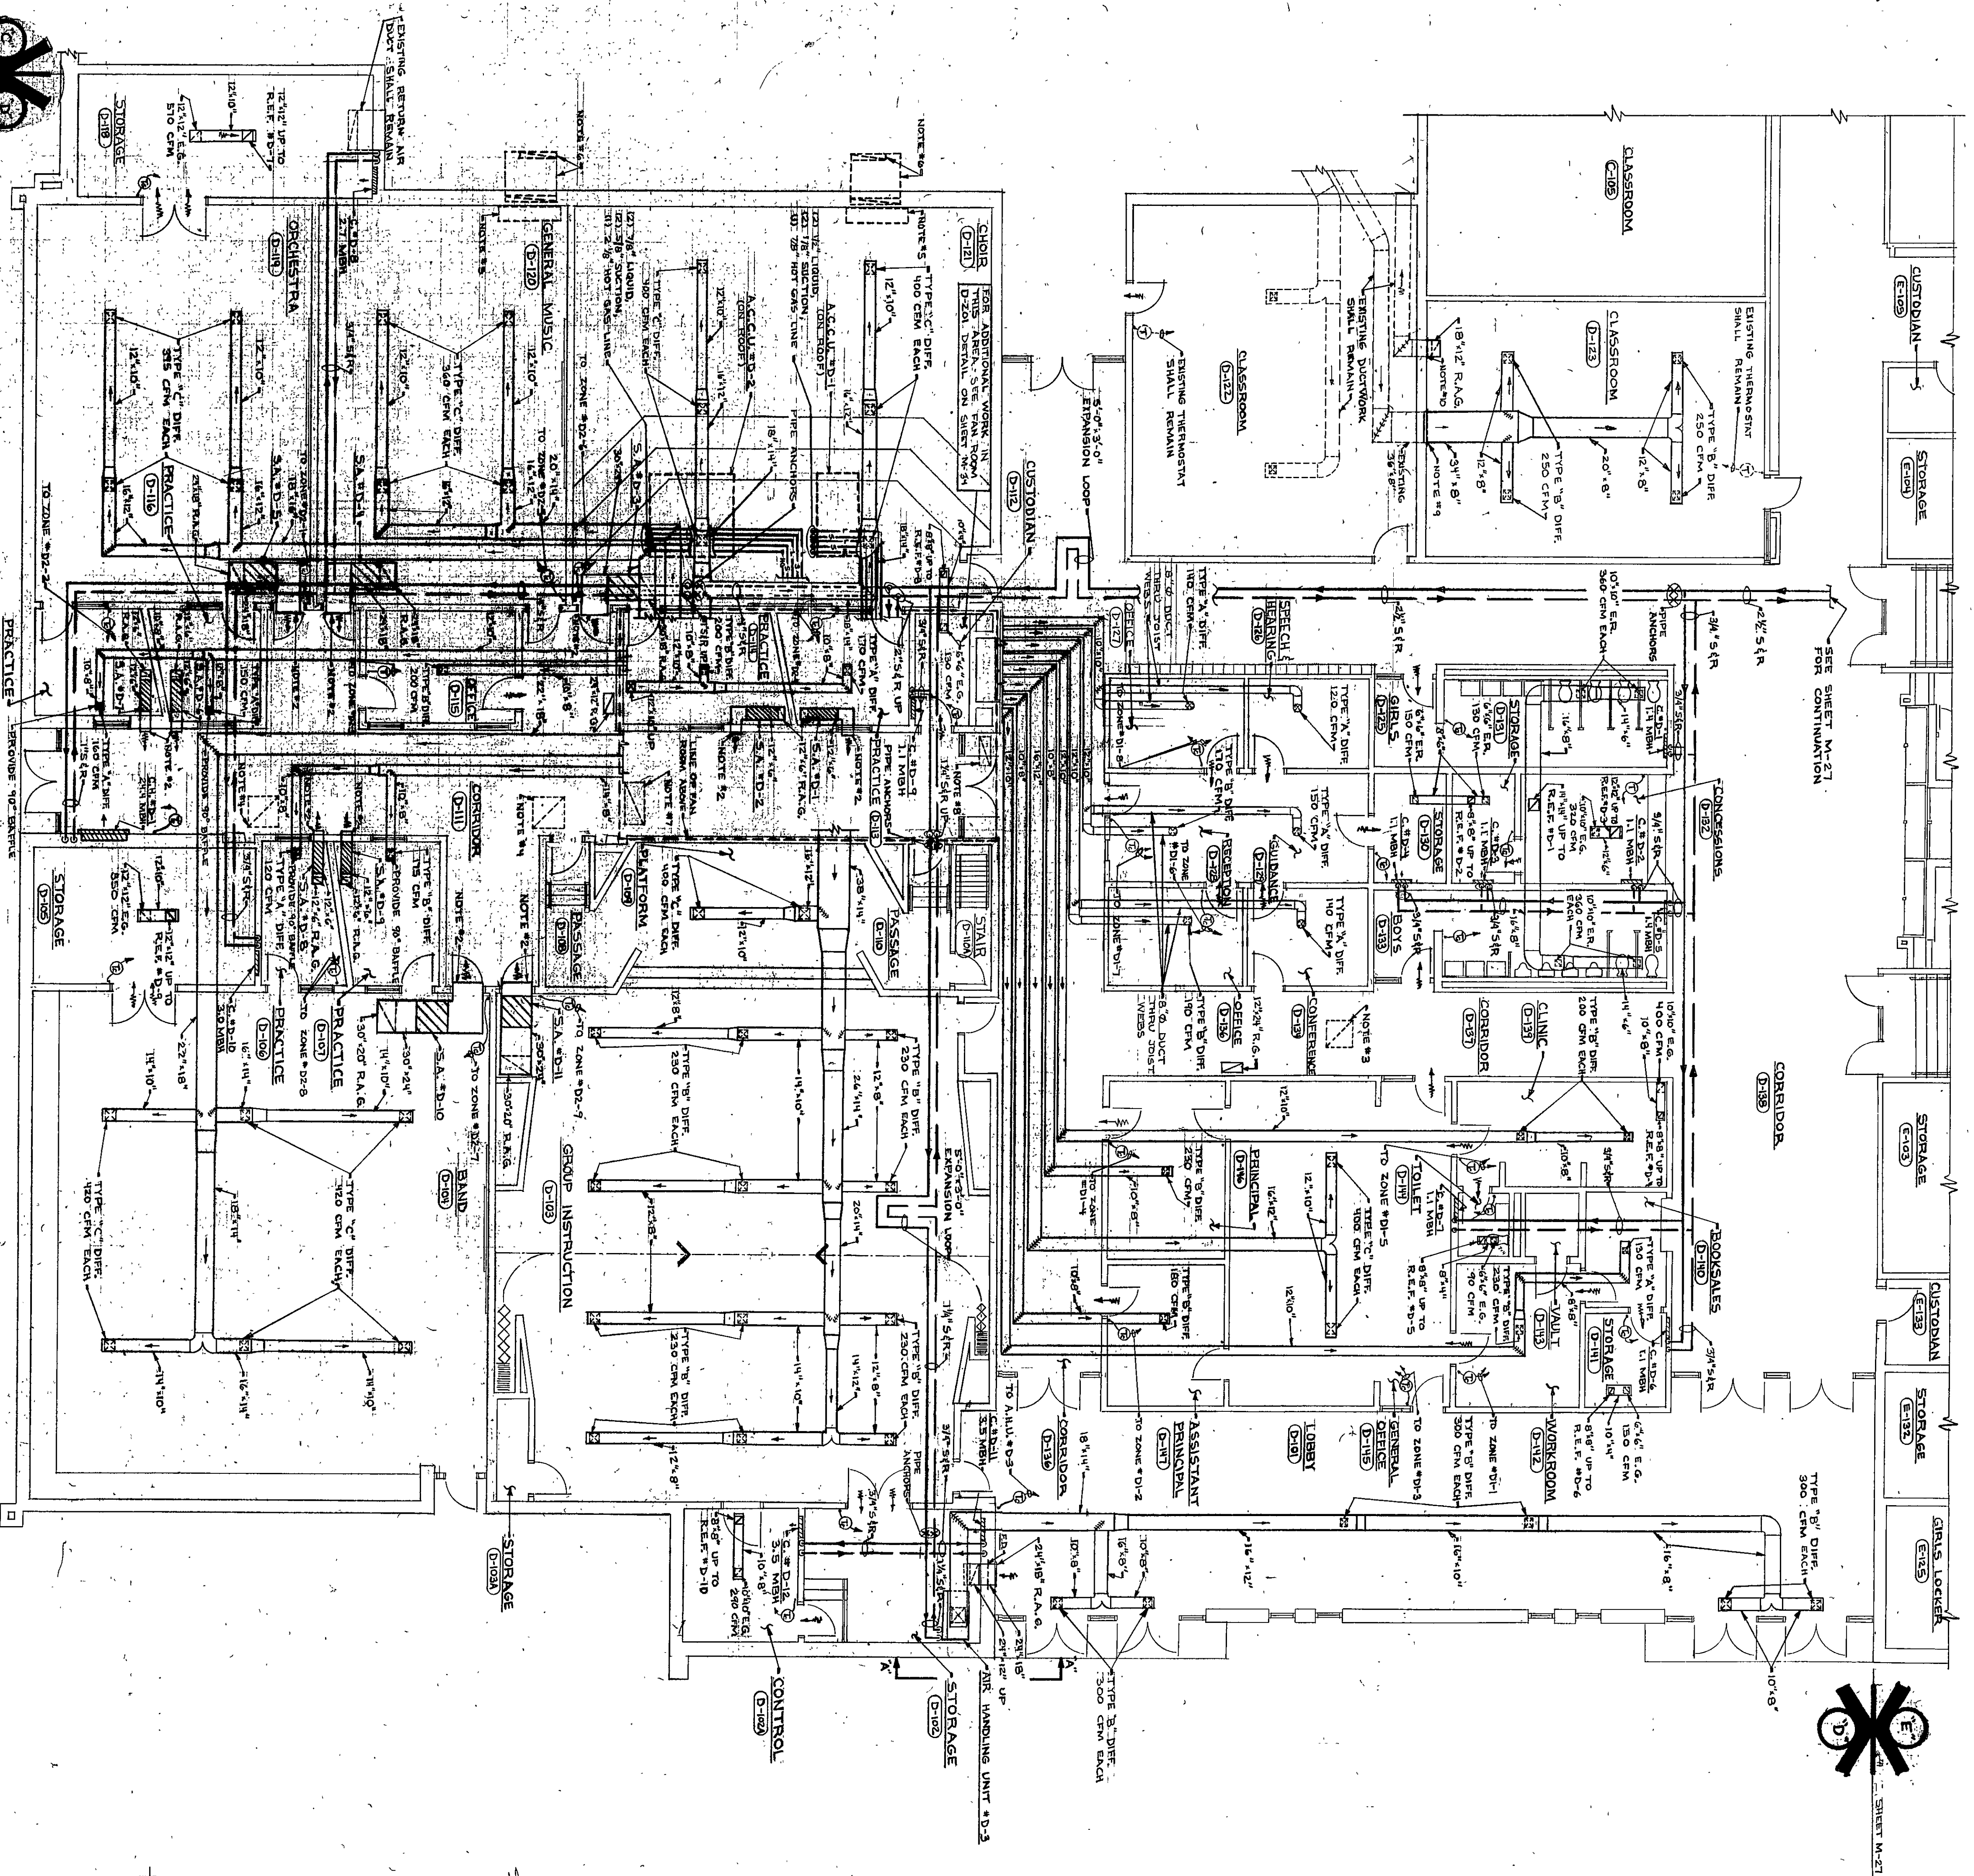


UNIT D - PARTIAL DEMOLITION PLAN

NO SCALE

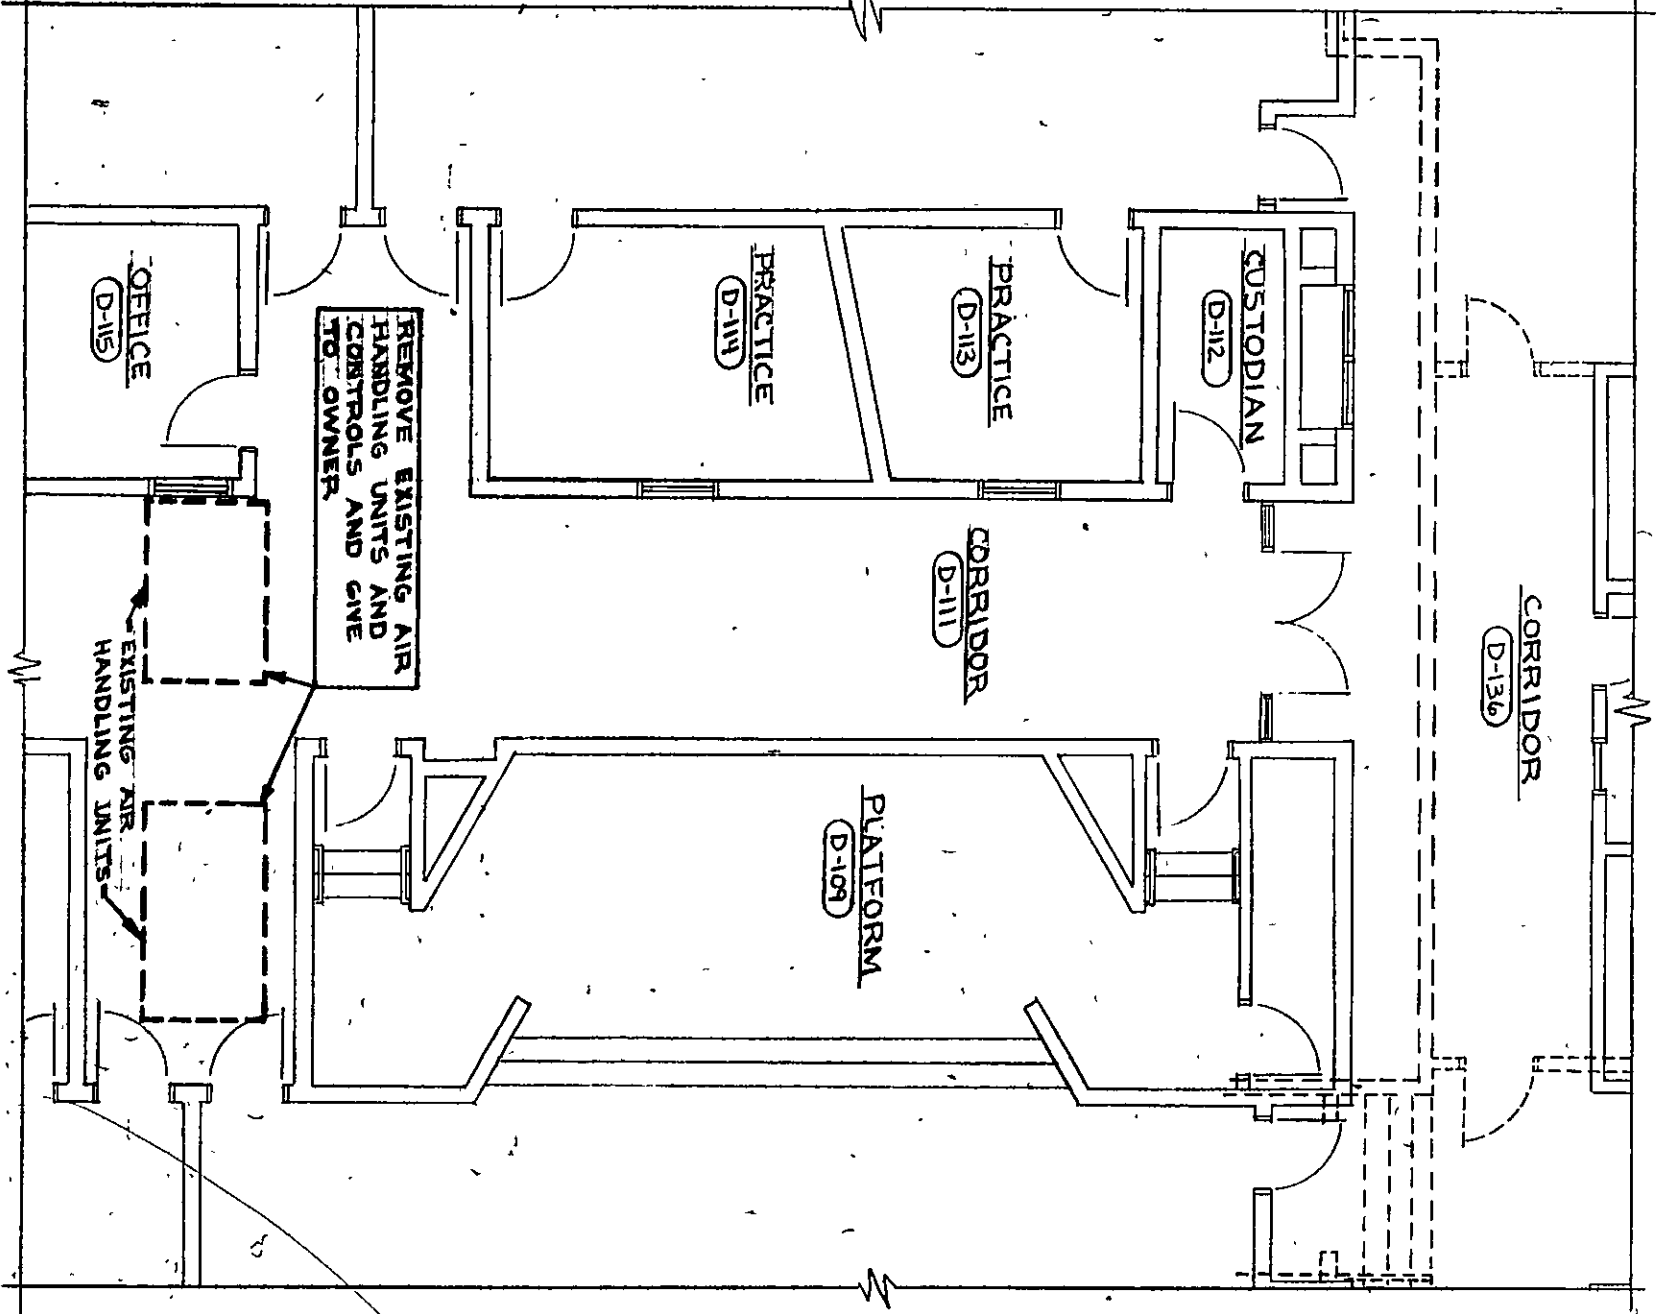



SECTION 'A-A'

1/8" SCALE

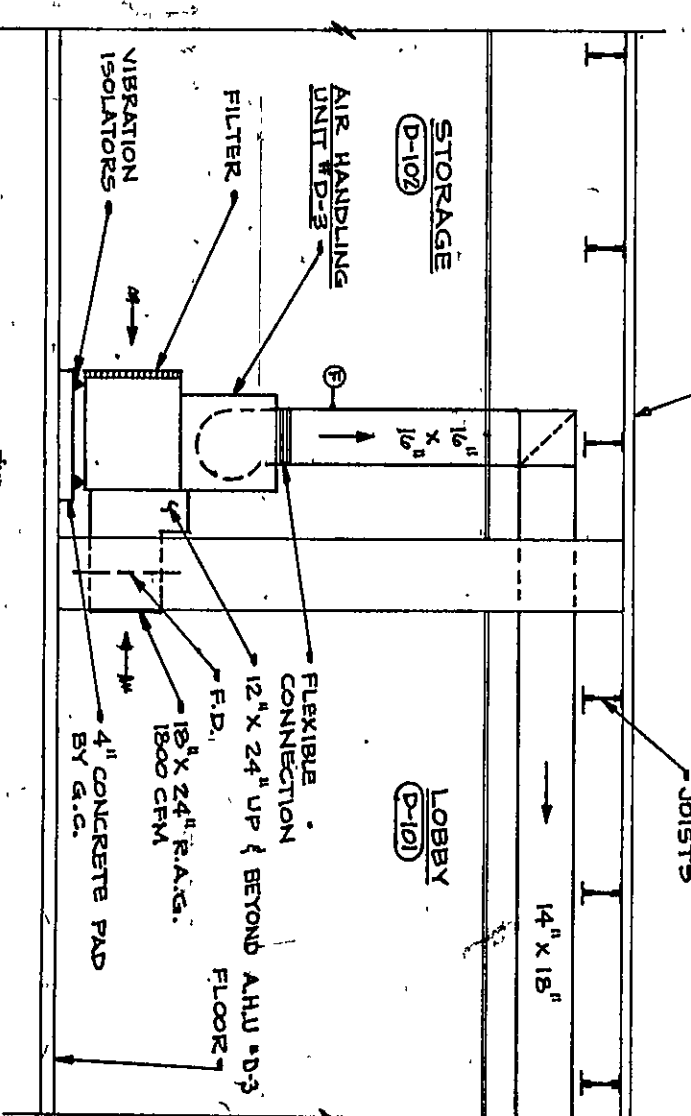

- PLAN NOTES
1. SEE SHEET M-16 FOR GENERAL NOTES, LEGEND, AND SCHEDULES.
 2. STUB RETURN AIR DUCT INTO CORRIDOR CEILING SPACE.
 3. 10" X 30" OPENING IN ROOF CONSTRUCTION BY GENERAL CONTRACTOR. PROVIDE 30" RELIEF SEE DETAIL "C" ON SHEET M-21.
 4. 36" X 36" OPENING IN ROOF CONSTRUCTION BY GENERAL CONTRACTOR. PROVIDE 30" RELIEF SEE DETAIL "C" ON SHEET M-21.
 5. REMOVE EXISTING CLASSROOM UNIT VENTILATOR. WALL OPENING TO BE PATCHED BY GENERAL CONTRACTOR.
 6. REMOVE EXISTING OUTDOOR AIR INTAKE ON ROOF. ROOF TO BE WEATHERPROOFED BY OTHERS. ABANDON EXISTING OUTDOOR AIR INTAKE DUCT IN PLACE.
 7. STUB 48" X 24" RETURN AIR DUCT INTO CORRIDOR CEILING SPACE.
 8. STUB 32" X 12" RETURN AIR DUCT INTO CORRIDOR CEILING SPACE.
 9. REMOVE EXISTING 48" X 88" SUPPLY AIR REGISTER. CONNECT NEW 34" X 8" DUCT TO EXISTING 36" X 8" DUCT AS SHOWN.
 10. REMOVE EXISTING 18" X 12" RETURN AIR GRILLE. STUB RETURN AIR DUCT FROM EXISTING WALL. OPENING DOWN THROUGH BURHEAD TO NEW 18" X 12" RETURN AIR GRILLE AS SHOWN.

AS-BUILT
23 SEPT 1984

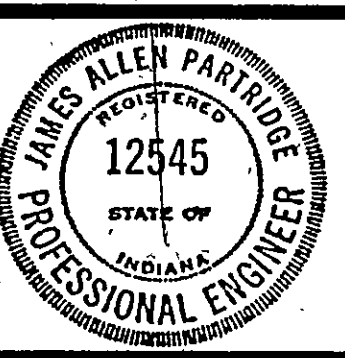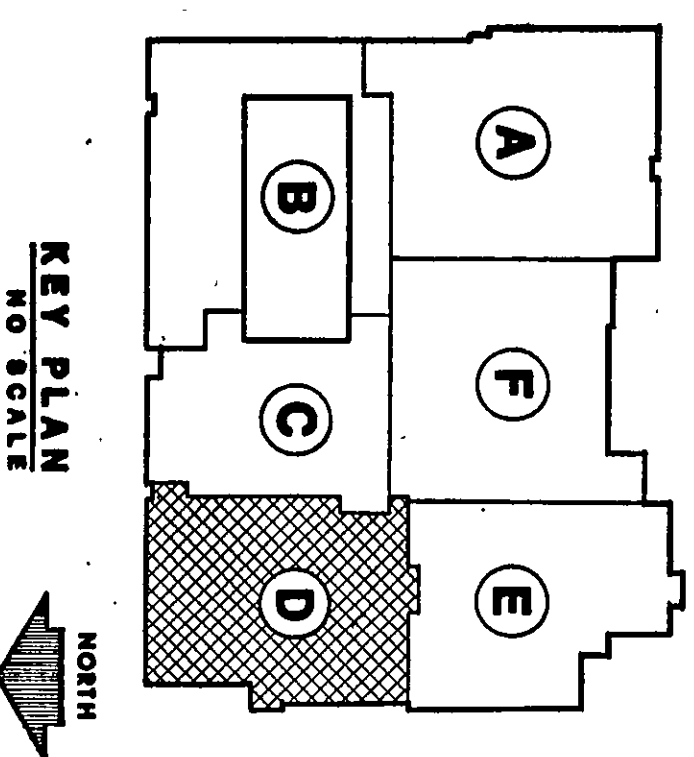

James A. Partridge

EVERETT · I · BROWN COMPANY

5500 WEST BRADBURY AVENUE ·

· PARK FLETCHER ·

· INDIANAPOLIS, INDIANA · 46241

ADDITION TO AND RENOVATION OF LIBERTY MIDDLE SCHOOL

ARCHITECTS
ENGINEERS

© EVERETT · I · BROWN COMPANY

PROJECT
12579.00
DATE
MAY 3, 1982
REVISED

NO-M-25
OF 36

82-M-12